


HIGHLAND CENTRAL SCHOOL DISTRICT
HIGHLAND ELEMENTARY SCHOOL
2022 CAPITAL IMPROVEMENT PROJECT - PHASE 1

Project Title

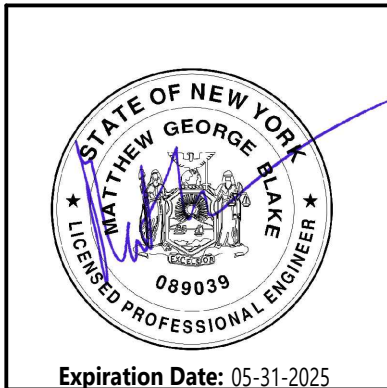

Expiration Date: 05-31-2025

DATE	DESCRIPTION

Drawn By: BJK
Checked By: BJK
Proj. #: 62-08-03-04-0-010-014
CSArch Proj. #: 197-2201.01
Issued for Bid: 8/18/23


Sheet Title
AREA A
GROUND FLOOR
LIGHTING PLAN

Sheet No.
HES
E201

CONSTRUCTION DOCUMENTS

General Notes:

1. IN ALL AREAS WITH EXISTING CEILINGS TO REMAIN, ELECTRICAL CONTRACTOR IS RESPONSIBLE TO REMOVE AND REINSTALL CEILING TILES AND GRID AS NECESSARY TO COMPLETE REMOVAL AND INSTALLATION OF LIGHTING, WIRING, CONDUIT, JUNCTION BOXES, ETC.
2. WALL MOUNTED EXIT LIGHTING IN CORRIDORS IS EXISTING TO REMAIN WHERE SHOWN ON THE PLANS. CONTRACTOR SHALL ADJUST PLACEMENT OF EXISTING FIXTURES IF NEEDED TO ACCOMMODATE CEILING REPLACEMENT.

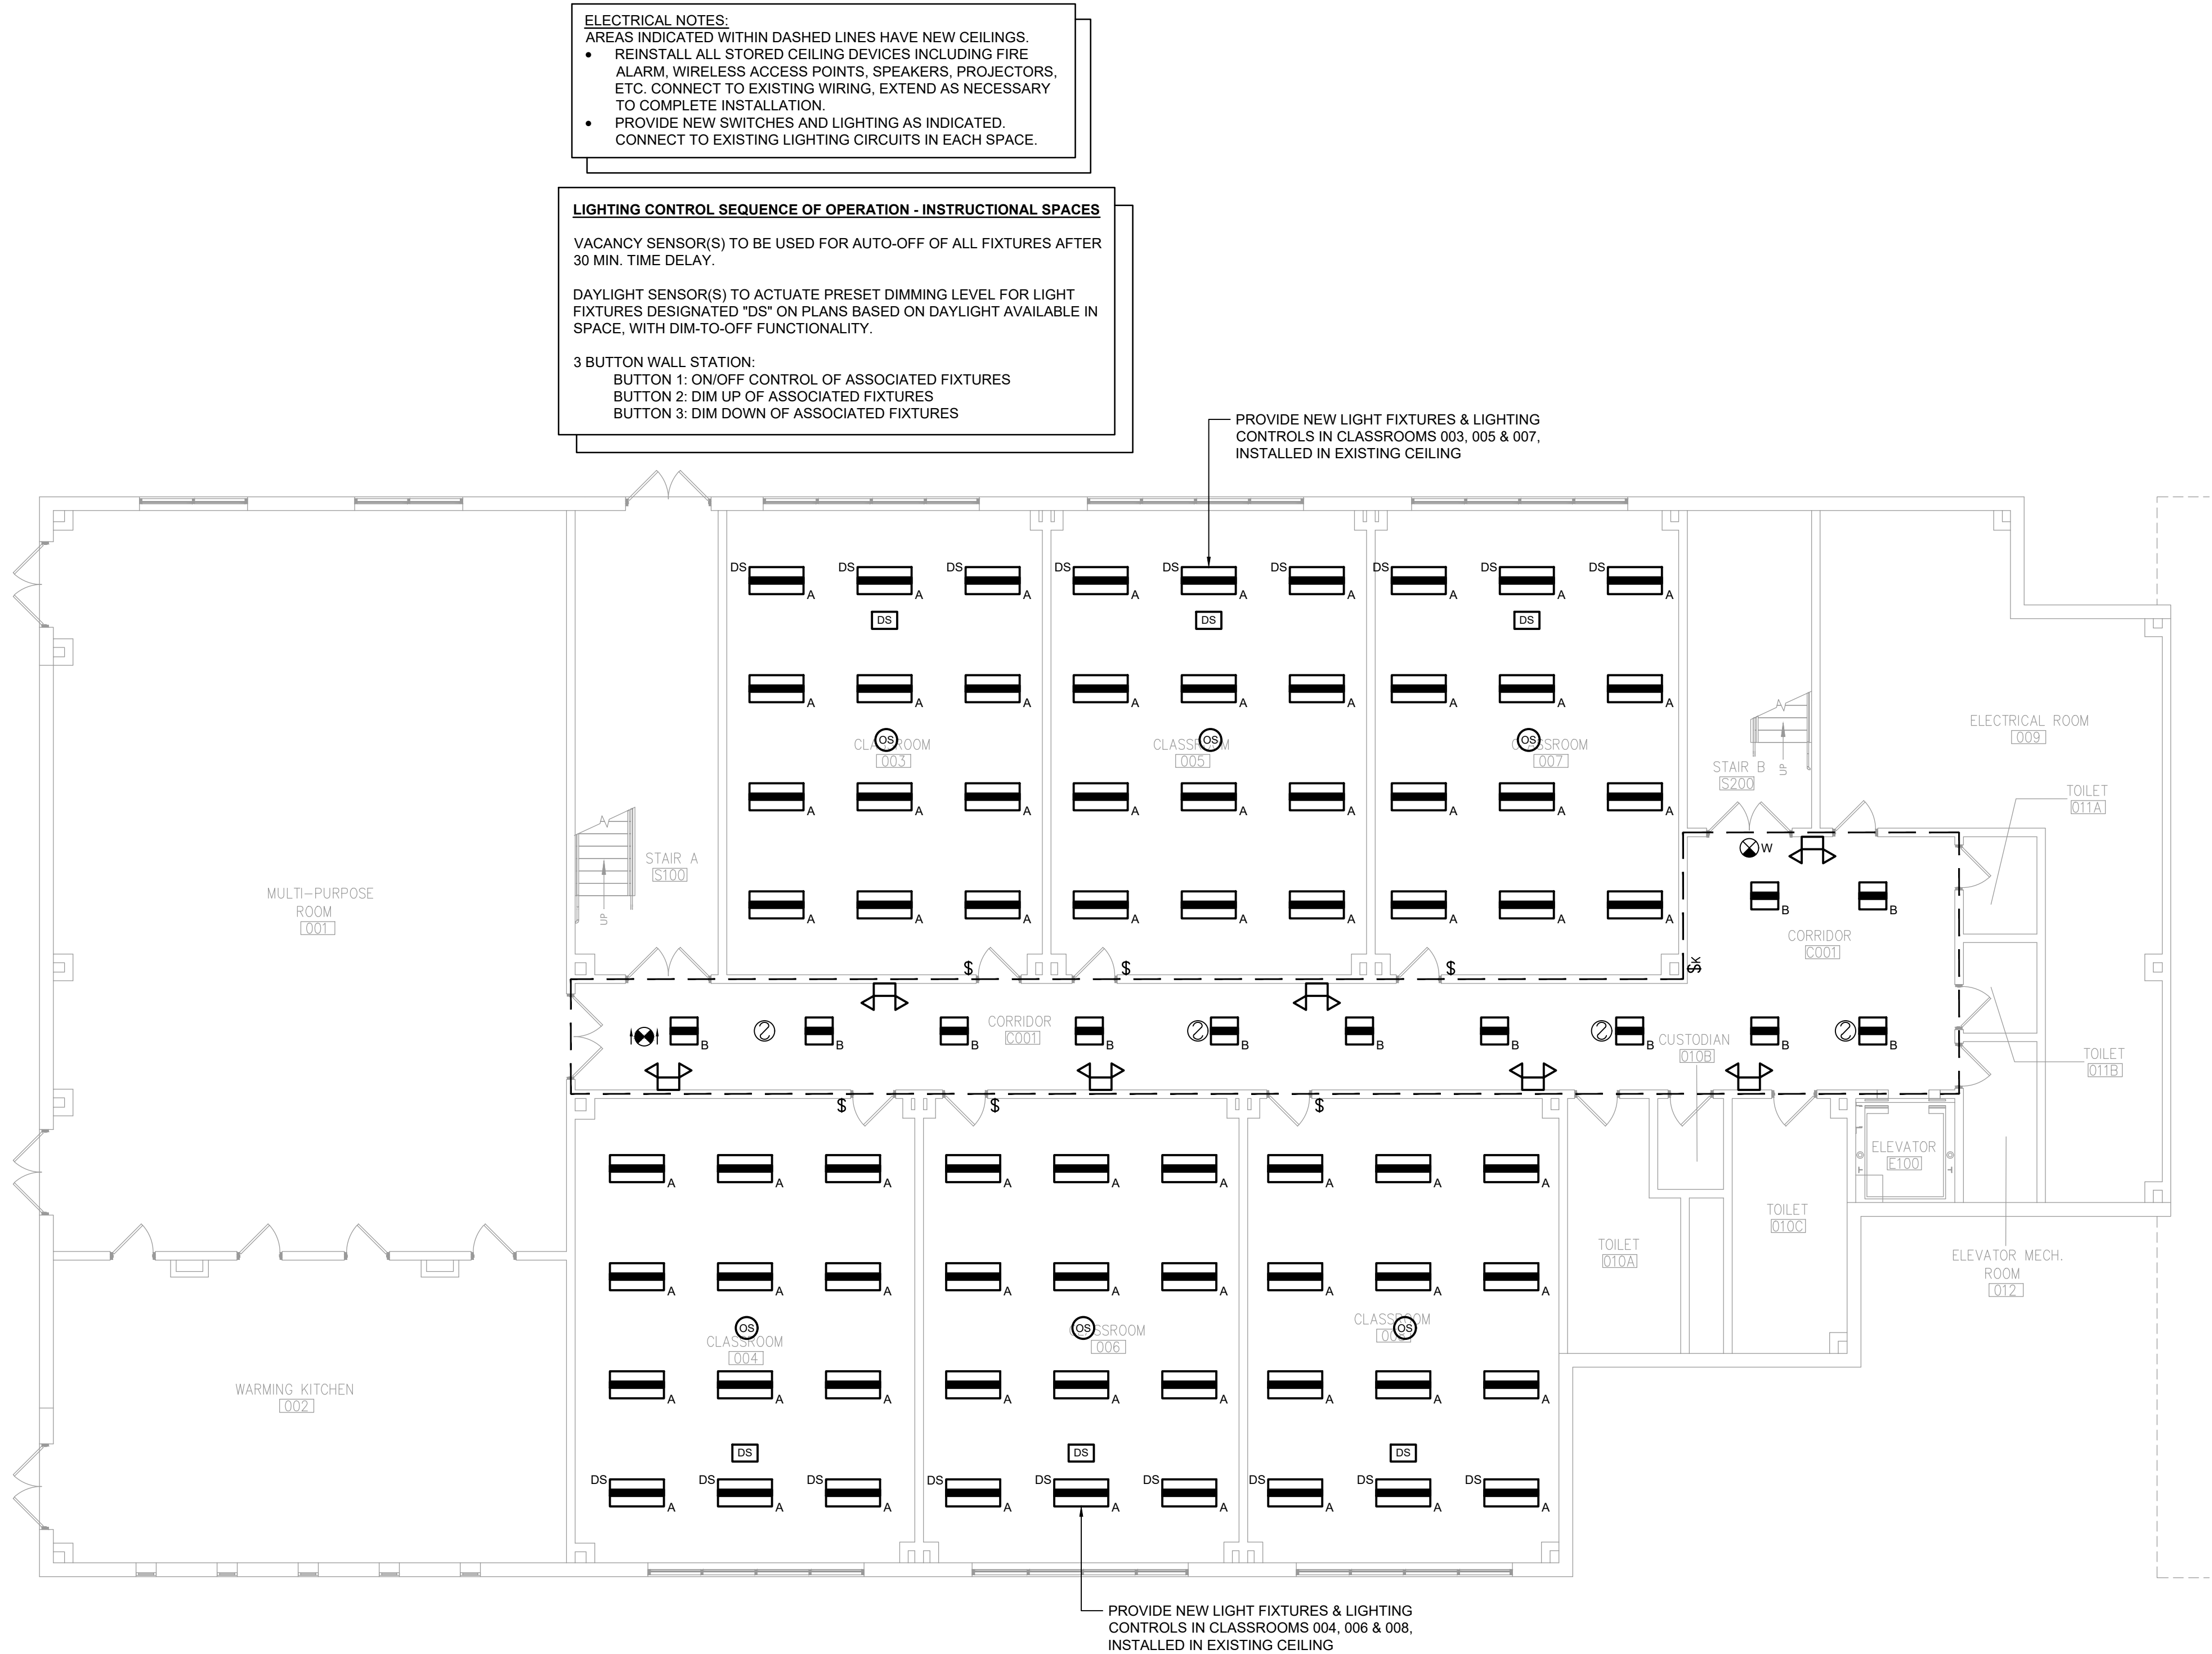

1 Area A Ground Floor Lighting Plan
E201 Scale: 1/8" = 1'-0"

KEY PLAN

