
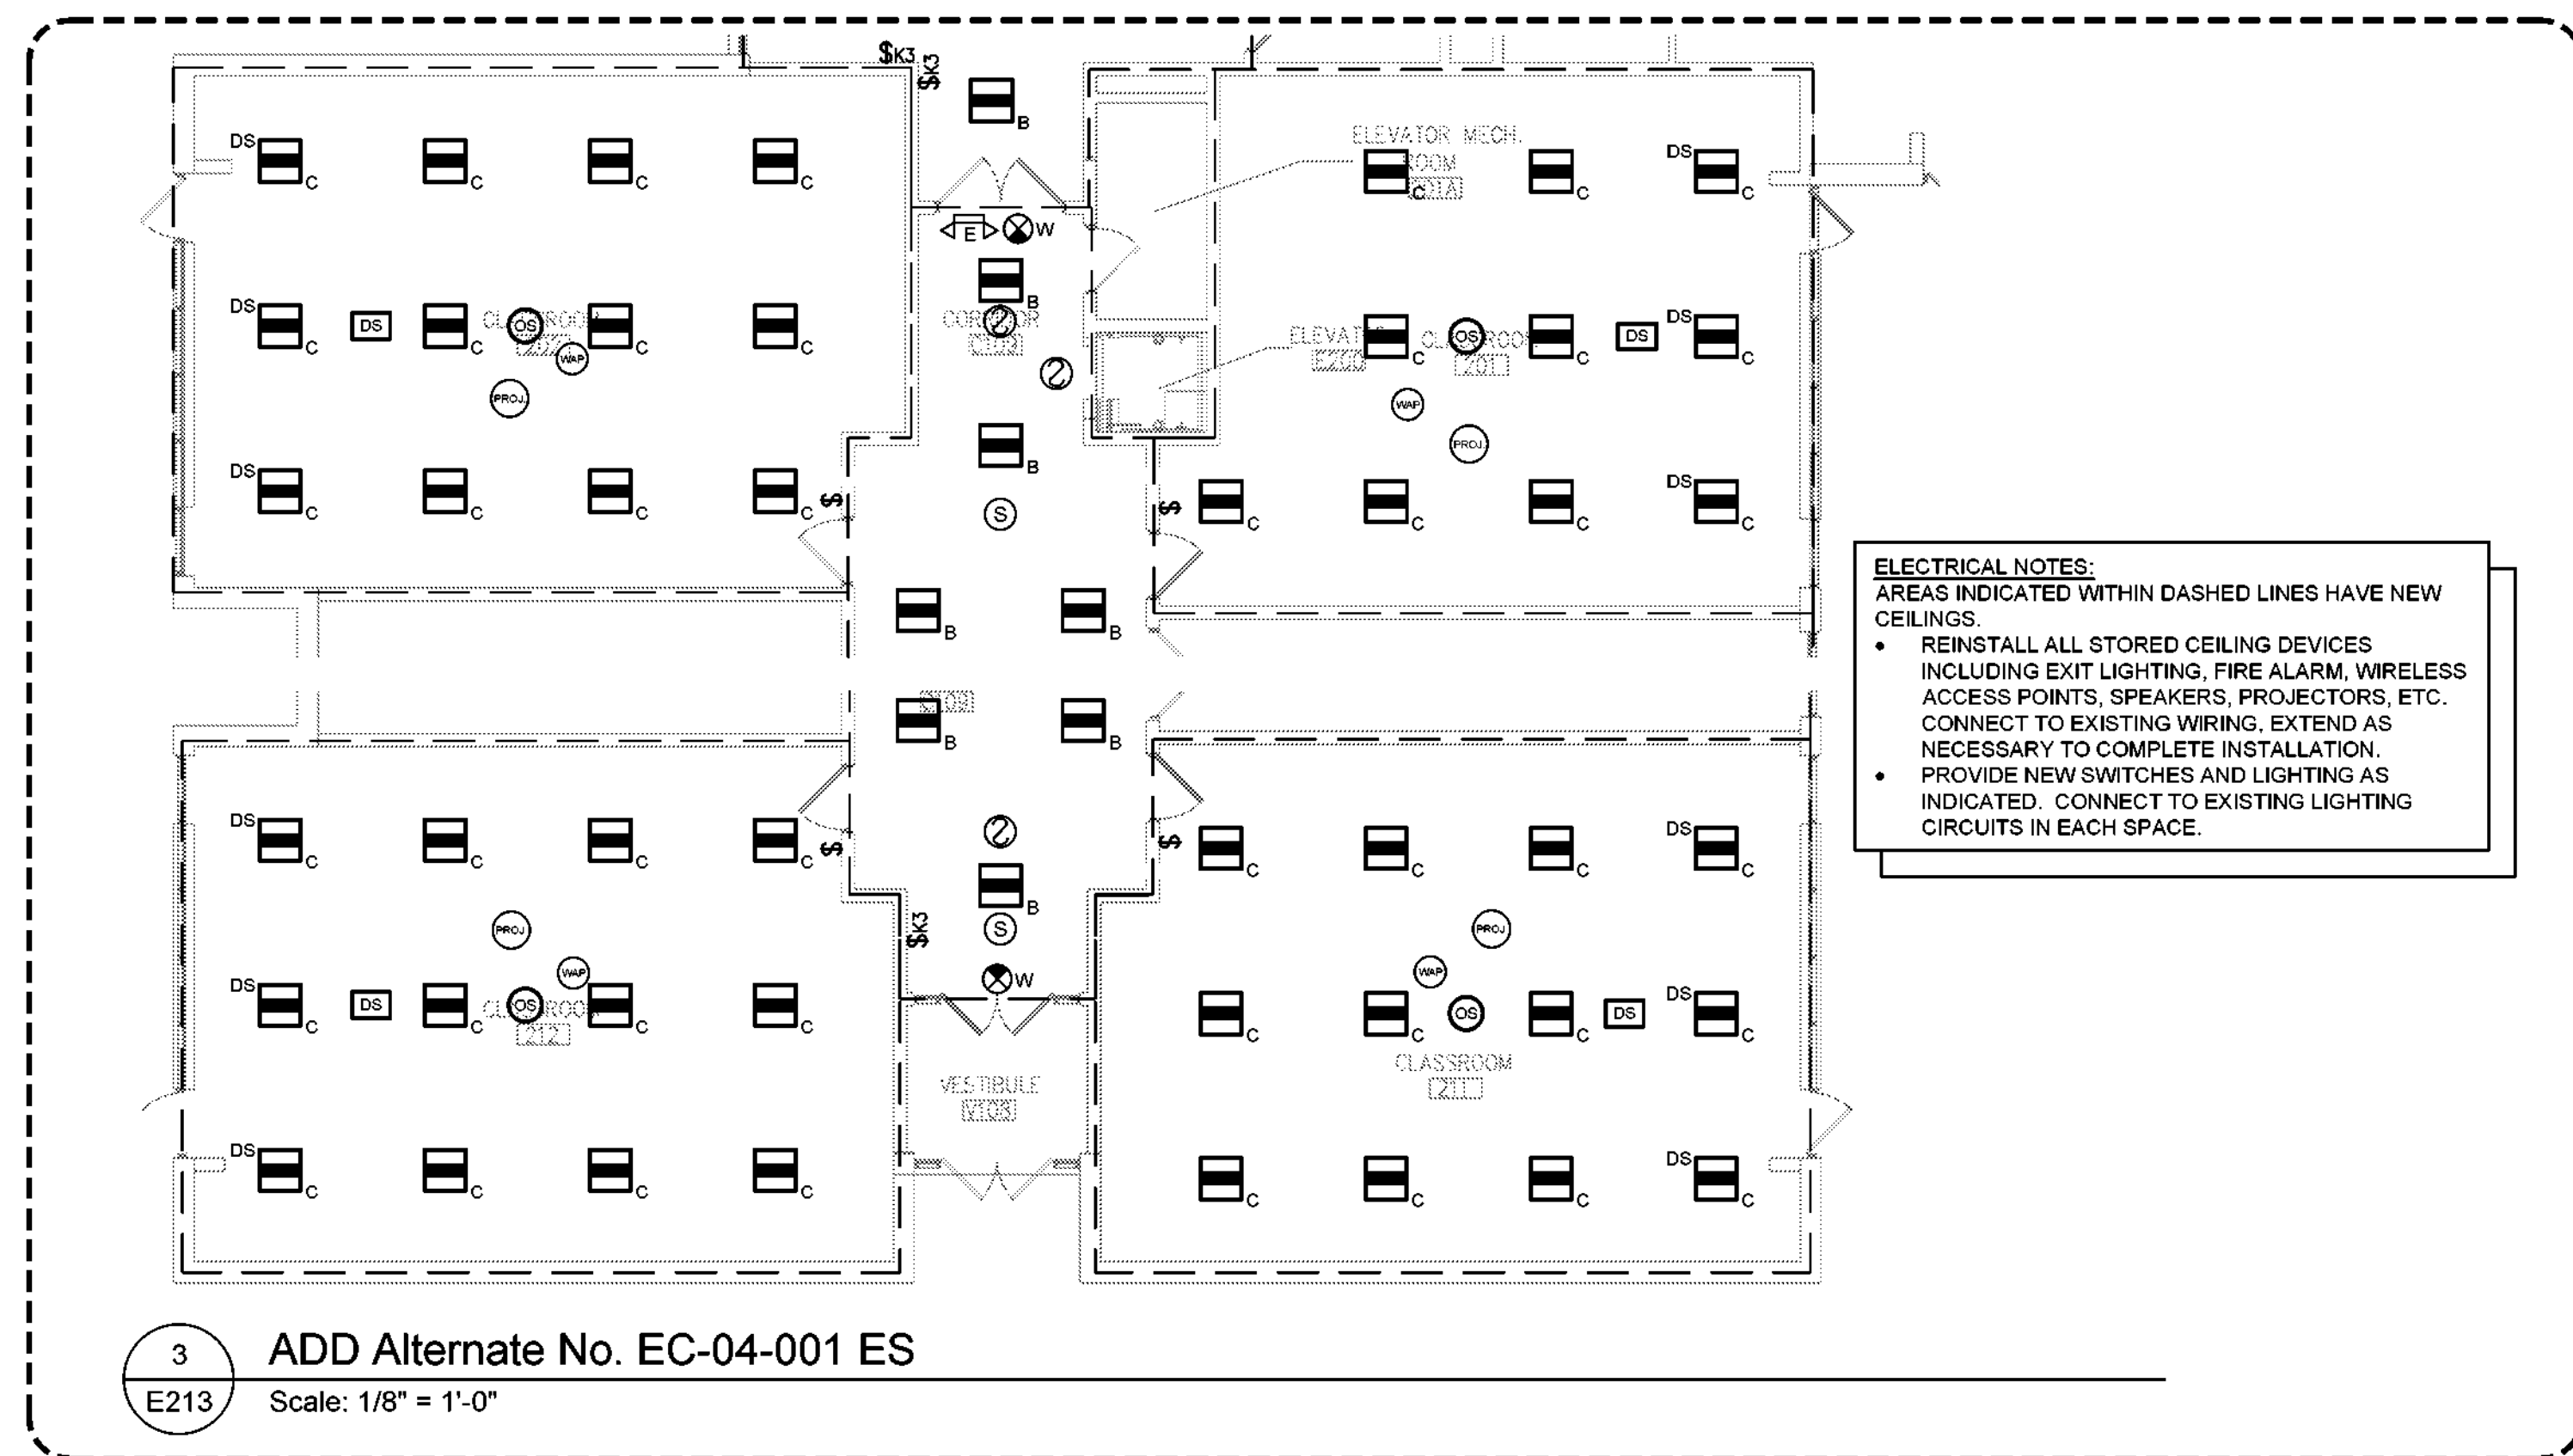


**LIGHTING CONTROL SEQUENCE OF OPERATION - INSTRUCTIONAL SPACES**

VACANCY SENSOR(S) TO BE USED FOR AUTO-OFF OF ALL FIXTURES AFTER 30 MIN. TIME DELAY.

DAYLIGHT SENSOR(S) TO ACTUATE PRESET DIMMING LEVEL FOR LIGHT FIXTURES DESIGNATED "DS" ON PLANS BASED ON DAYLIGHT AVAILABLE IN SPACE, WITH DIM-TO-OFF FUNCTIONALITY.


3 BUTTON WALL STATION:  
 BUTTON 1: ON/OFF CONTROL OF ASSOCIATED FIXTURES  
 BUTTON 2: DIM UP OF ASSOCIATED FIXTURES  
 BUTTON 3: DIM DOWN OF ASSOCIATED FIXTURES

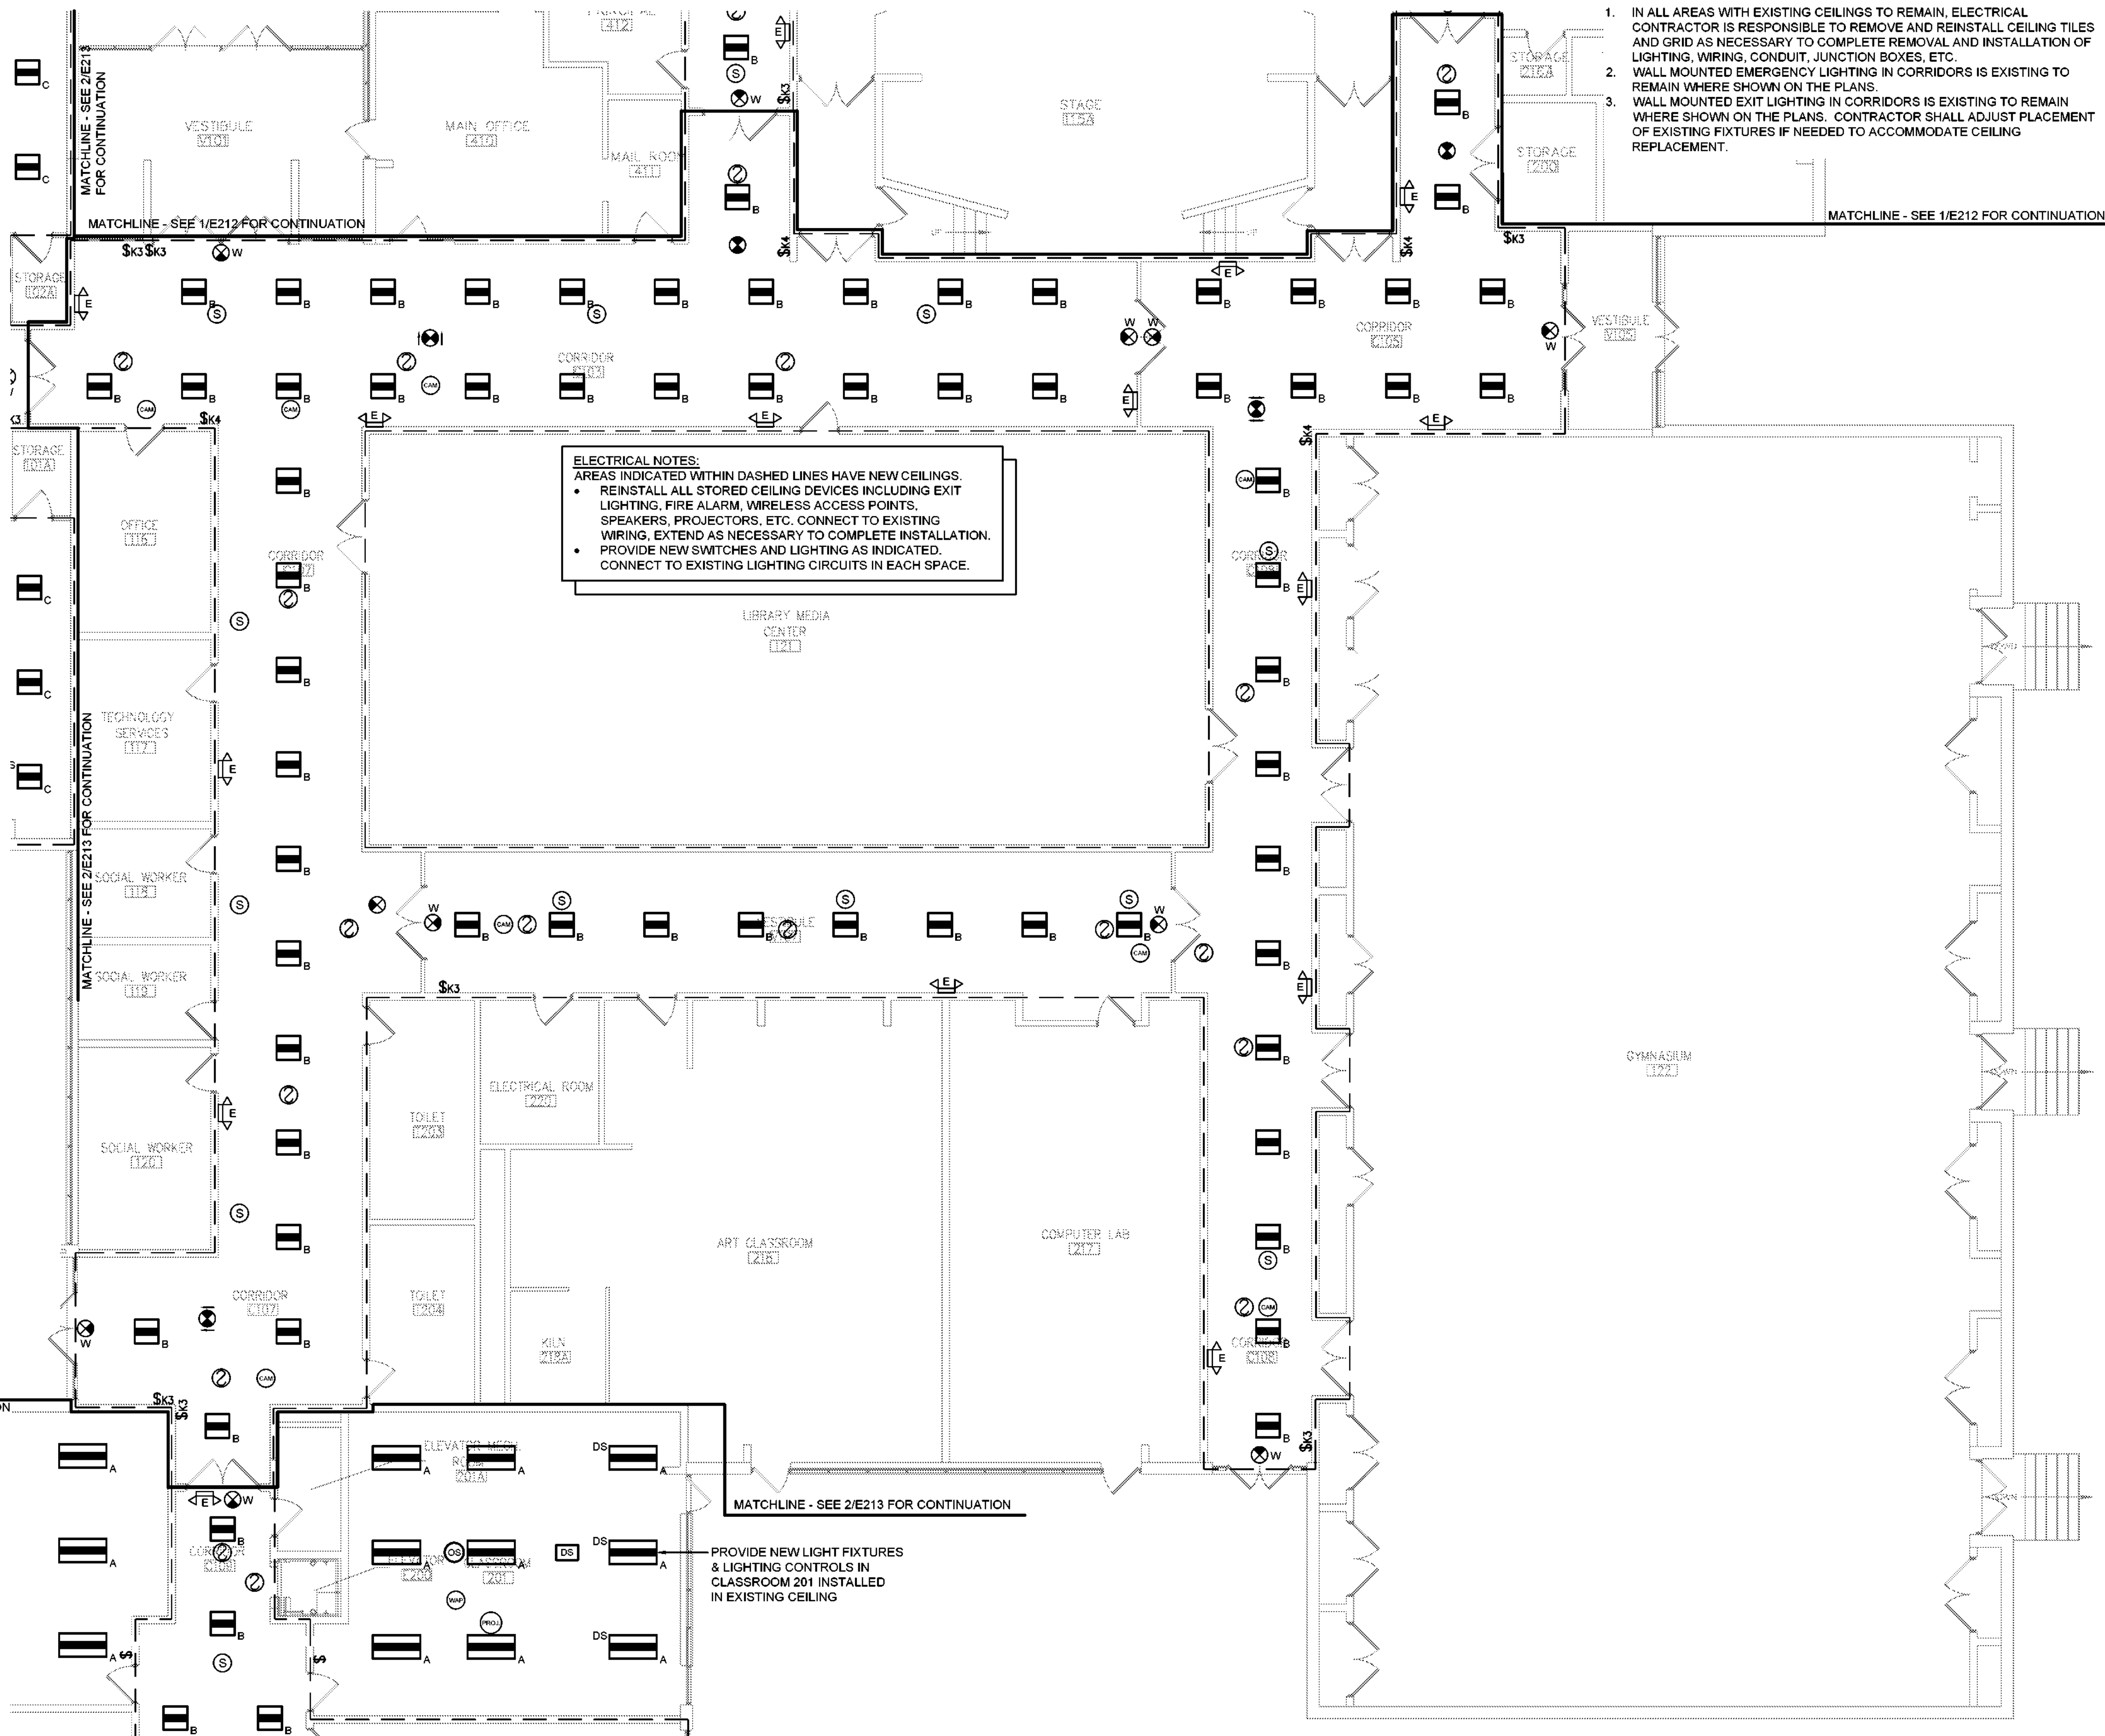

#### ADD ALTERNATE NO. EC-04-001-ES

CEILING(S) TO BE REPLACED IN CLASSROOM 201, 202, 211 & 212 - PROVIDE TYPE C LIGHT FIXTURES AND ASSOCIATED CEILING WORK PER LAYOUTS ABOVE AND ELECTRICAL NOTES


#### KEY PLAN

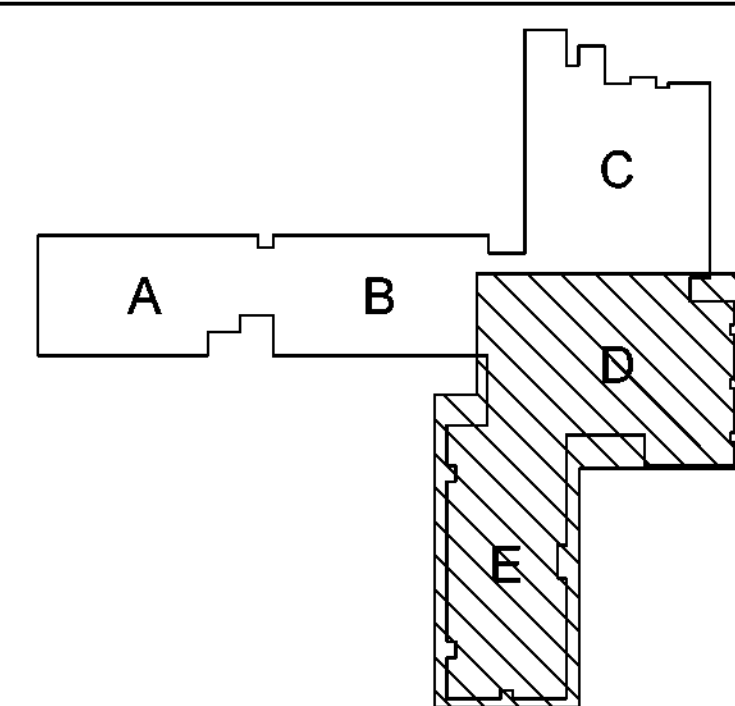


#### General Notes:

- IN ALL AREAS WITH EXISTING CEILINGS TO REMAIN, ELECTRICAL CONTRACTOR IS RESPONSIBLE TO REMOVE AND REINSTALL CEILING TILES AND GRID AS NECESSARY TO COMPLETE REMOVAL AND INSTALLATION OF LIGHTING, WIRING, CONDUIT, JUNCTION BOXES, ETC.
- WALL MOUNTED EMERGENCY LIGHTING IN CORRIDORS IS EXISTING TO REMAIN WHERE SHOWN ON THE PLANS.
- WALL MOUNTED EXIT LIGHTING IN CORRIDORS IS EXISTING TO REMAIN WHERE SHOWN ON THE PLANS. CONTRACTOR SHALL ADJUST PLACEMENT OF EXISTING FIXTURES IF NEEDED TO ACCOMMODATE CEILING REPLACEMENT.

19 Front St. - Newburgh - New York 12550-7601  
 845-561-3179 www.csarch.com

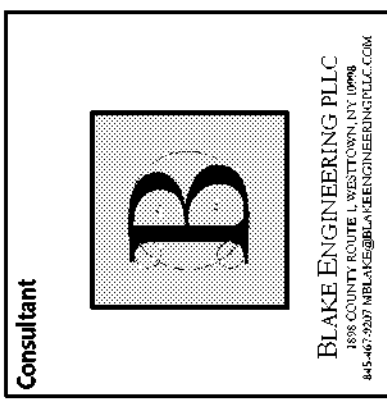

## HIGHLAND CENTRAL SCHOOL DISTRICT HIGHLAND ELEMENTARY SCHOOL 2022 CAPITAL IMPROVEMENT PROJECT - PHASE 1

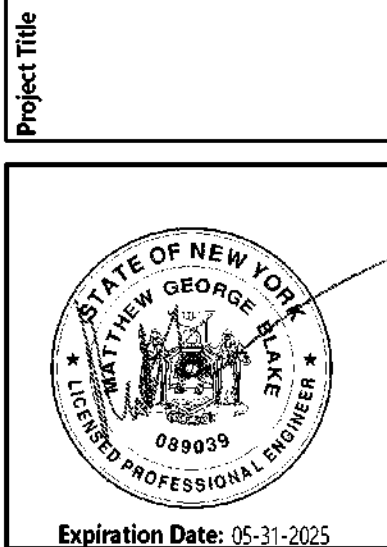

| DATE       | DESCRIPTION        |
|------------|--------------------|
| 05/31/2025 | ISSUED FOR BIDDING |
| 05/31/2025 | REVISION 1         |
| 05/31/2025 | REVISION 2         |
| 05/31/2025 | REVISION 3         |
| 05/31/2025 | REVISION 4         |
| 05/31/2025 | REVISION 5         |
| 05/31/2025 | REVISION 6         |
| 05/31/2025 | REVISION 7         |
| 05/31/2025 | REVISION 8         |
| 05/31/2025 | REVISION 9         |
| 05/31/2025 | REVISION 10        |

Drawn By: BJK  
 Checked By: BJK  
 Date: 05-31-2025  
 CSArch Proj. #: 197-2201-01  
 Issued for Bid: 05/31/2025

Sheet Title  
**AREA D & E  
 FIRST FLOOR  
 LIGHTING  
 PLANS**

Sheet No.  
**HES  
 E213**

CONSTRUCTION DOCUMENTS