


**84 CHALET ROAD
KIAMESHA LAKE, NY 12751**

JCJ ARCHITECTURE
120 HUYSHOPE AVENUE
SUITE 400
HARTFORD, CT 06106
860.247.9226

© 2019 JCJ Architecture

CONSULTANTS:

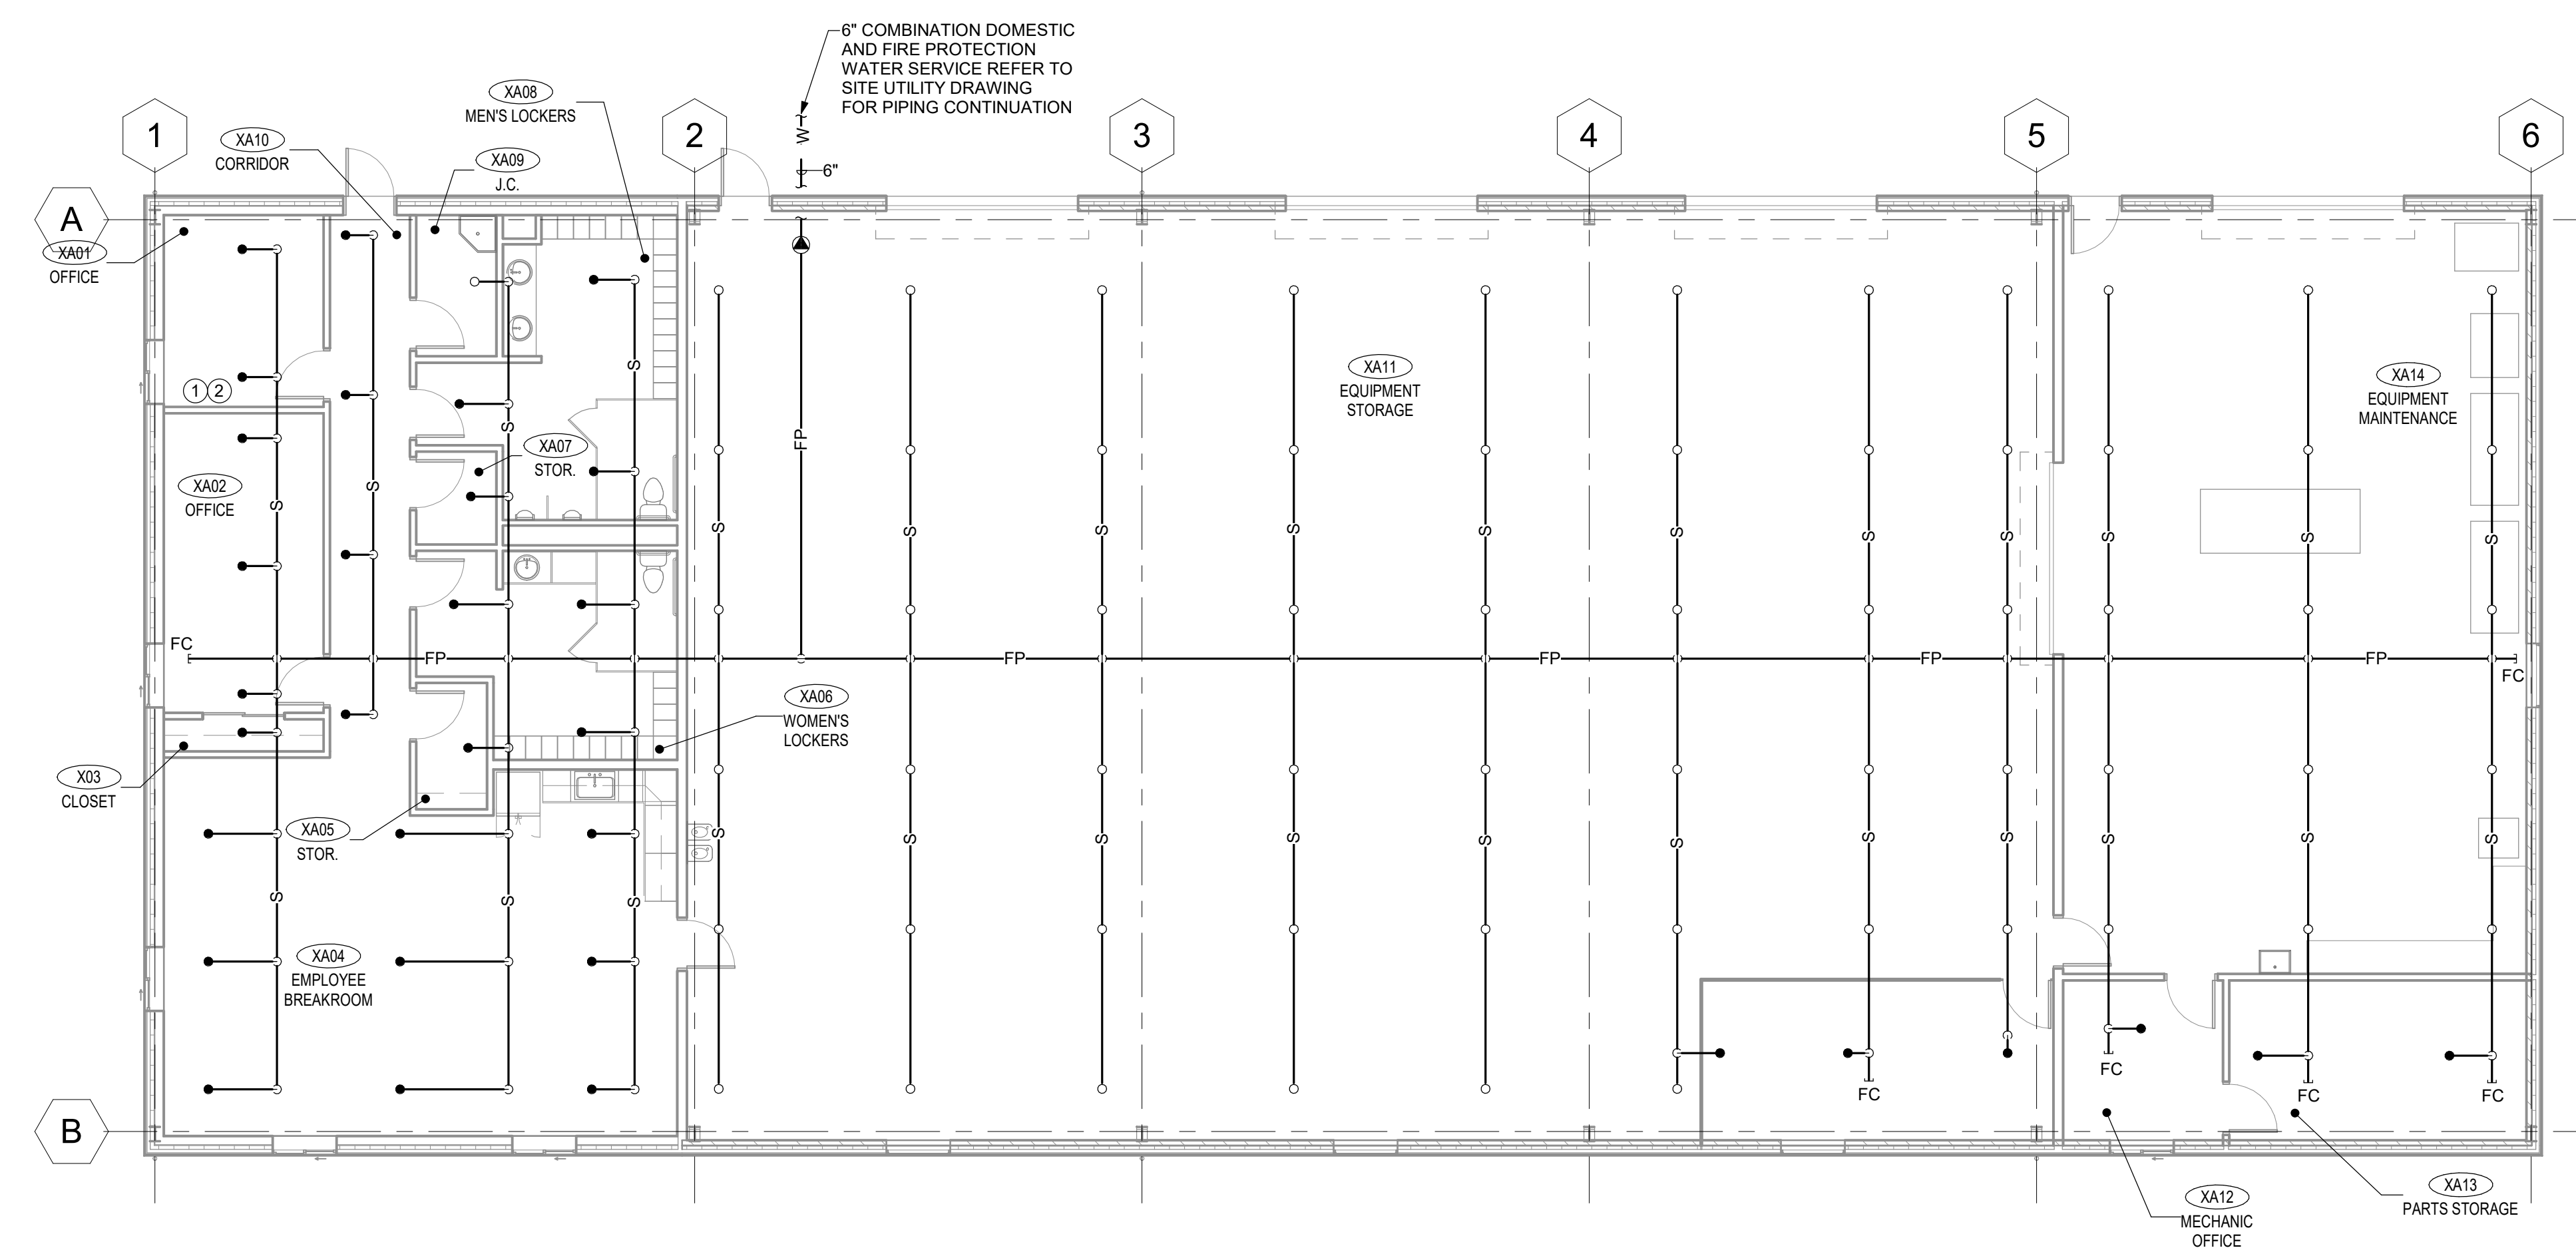

1 MAINTENANCE BUILDING - FIRST FLOOR PLAN - FIRE PROTECTION
1/8" = 1'-0"

1 PROVIDE PENDENT(?) SPRINKLER AND ASSOCIATED PIPING.
2 PROVIDE UPRIGHT SPRINKLER AND ASSOCIATED PIPING.

NOT FOR CONSTRUCTION

P.I.C.	_____	L.D.	_____
P.M.	_____	P.A.	_____

ISSUE	11/08/2019
JOB	H18064.00 PHASE 14
DRAWN	DMS2
SCALE	1/8" = 1'-0"

REVISIONS:

FIRST FLOOR PLAN - FIRE PROTECTION

FP-113