

**84 CHALET ROAD
KIAMESHA LAKE, NY 12751**

JCJARCHITECTURE
120 HUYSHOPE AVENUE
SUITE 400
HARTFORD, CT 06106
860.247.9226

© 2019 JCJ Architecture

CONSULTANTS:

NOT FOR CONSTRUCTION

P.I.C. _____ L.D. _____
P.M. _____ P.A. _____

ISSUE	11/08/2019
JOB	H18064.00 PHASE 14
DRAWN	EAS
SCALE	1/4" = 1'-0"


REVISIONS:

**FIRST FLOOR PLAN -
PLUMBING**

P-110

P-111 DRAWING NOTES

- 1 2" VENT UP FROM BELOW.
- 2 3" VENT UP THRU ROOF.
- 3 1/2" COLD WATER DOWN TO ICE MACHINE.
- 4 1/2" COLD WATER, 1/2" HOT WATER, 2" SANITARY AND 1 1/2" VENT
SERVING WASHER.
- 5 3/4" COLD WATER DOWN TO PRESSURE WASHER.
- 6 3/4" COLD WATER DOWN TO BALL WASHER.

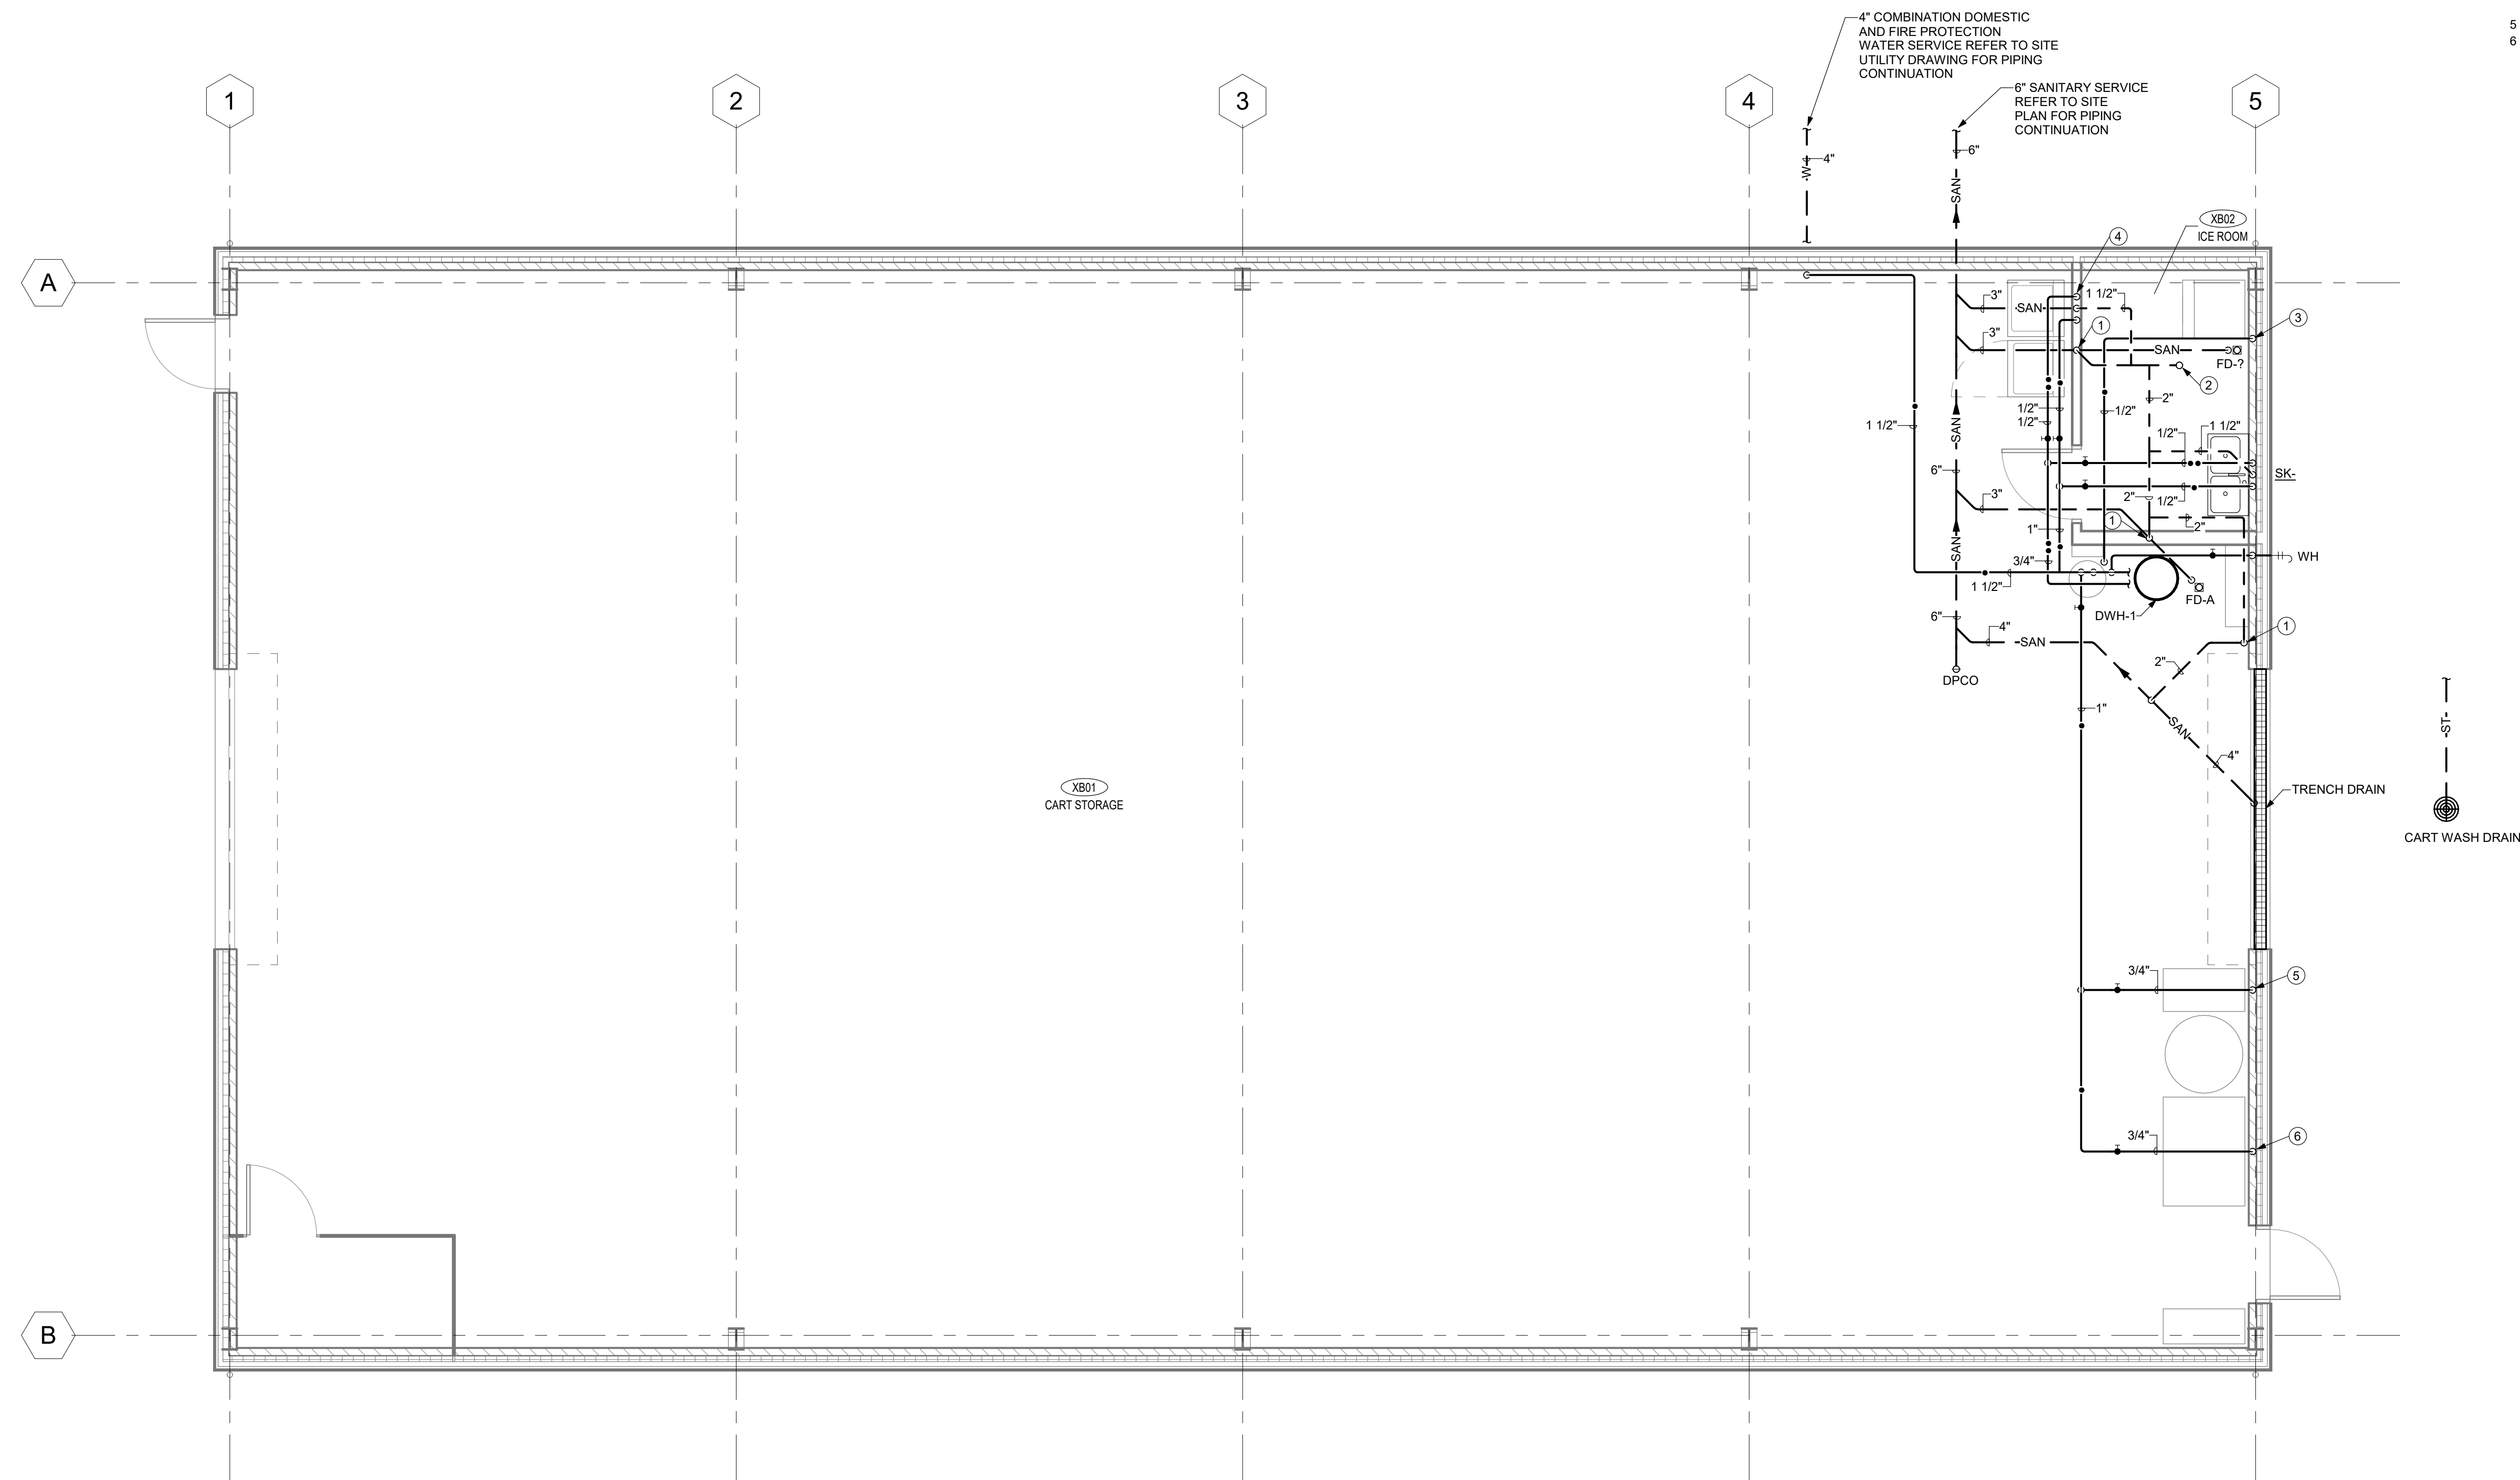

1 CART STORAGE BUILDING - FIRST FLOOR PLAN - PLUMBING
1/4" = 1'-0"