

**84 CHALET ROAD
KIAMESHA LAKE, NY 12751**

JCJARCHITECTURE
120 HUYSHOPE AVENUE
SUITE 400
HARTFORD, CT 06106
860.247.9226

© 2019 JCJ Architecture

CONSULTANTS:
MEP & FP ENGINEER
M/E ENGINEERING
60 LAKEFRONT BOULEVARD, SUITE 320
BUFFALO, NY 14202
716.845.5092

OWNERS CONSULTANT
AKRF ENGINEERING
34 SOUTH BROADWAY, SUITE
WHITE PLAINS, NY 10601
914-949-7336

PERMIT SET
09/30/2021




P.I.C. _____ L.D. _____
P.M. _____ P.A. _____

ISSUE	09/30/21
JOB	H18064.14
DRAWN	DMS2
SCALE	1/8" = 1'-0"

[illegible]

FIRST FLOOR PLAN - FIRE PROTECTION

FP-113

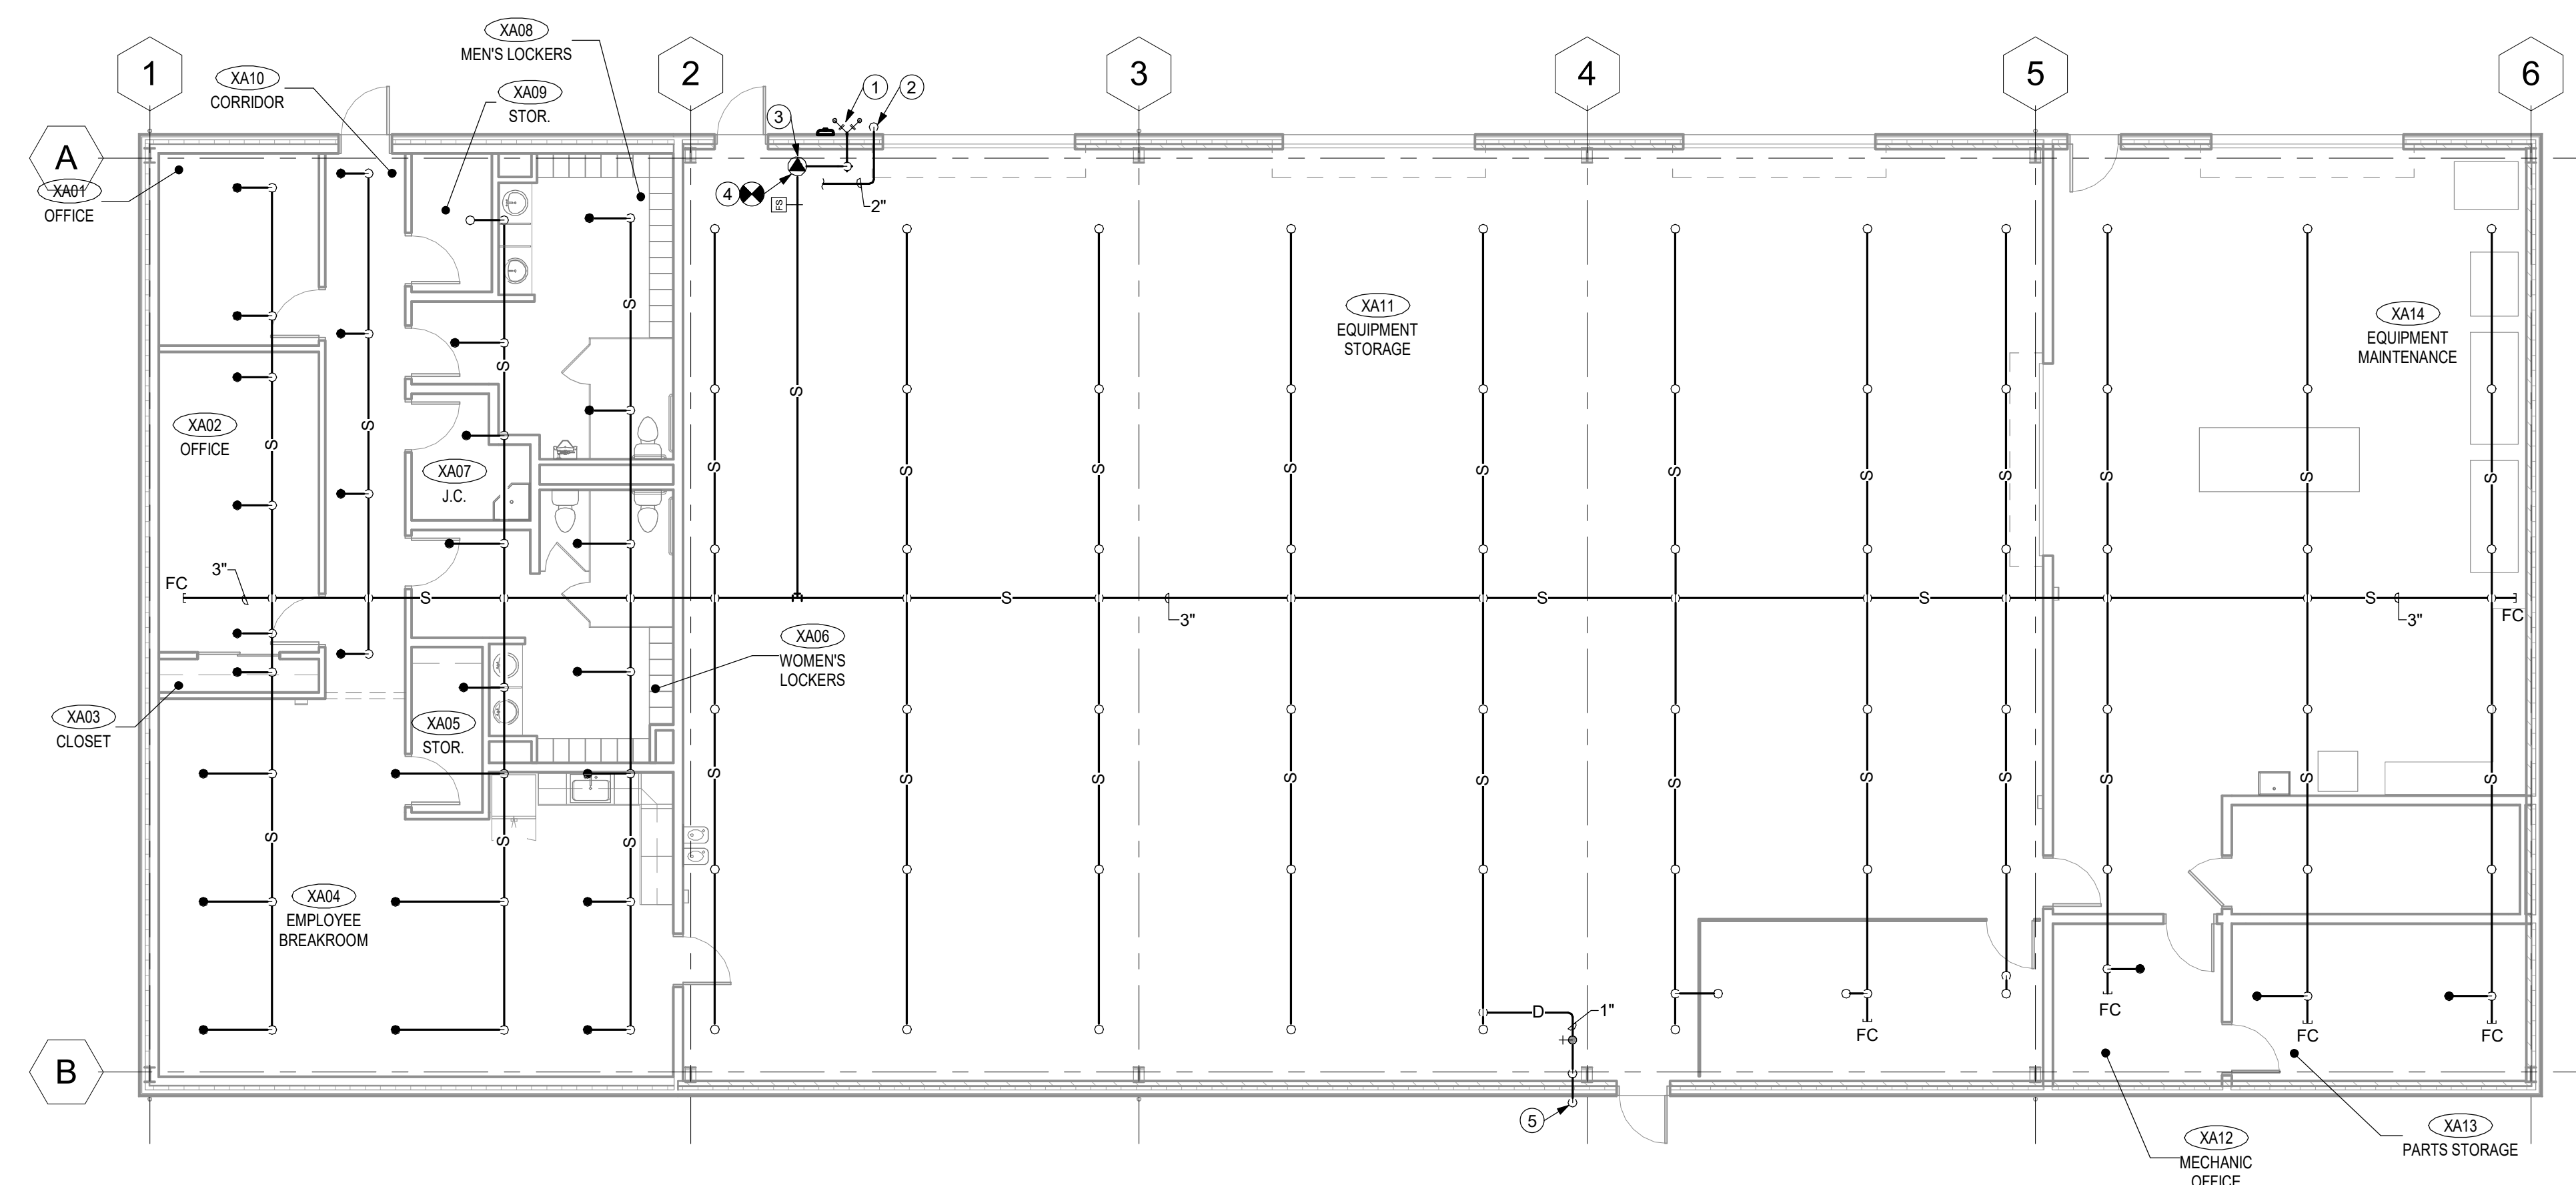

1 MAINTENANCE BUILDING - FIRST FLOOR PLAN - FIRE PROTECTION

FP-111 DRAWING NOTES

- 1 5"x6" STORZ FIRE DEPARTMENT CONNECTION WITH 30 DEGREE ELBOW. VERIFY THREAD WITH LOCAL FIRE DEPARTMENT.
- 2 2" FIRE PROTECTION SYSTEM MAIN DRAIN. TERMINATE AT EXTERIOR 1'-6" ABOVE FINISHED GRADE WITH SPLASHBLOCK.
- 3 PROVIDE WATER MOTOR GONG.
- 4 CONNECT TO OUTLET OF BACKFLOW PREVENTER PROVIDED BY DIVISION 22. PROVIDE JASM CHECK VALVE AND ALL NECESSARY APPURTENANCES.
- 5 TERMINATE 1" INSPECTORS TEST AND DRAIN PIPING AT EXTERIOR 1'-6" ABOVE FINISHED GRADE WITH SPLASHBLOCK. REFER TO DETAIL ON DRAWING PF-002.