

**84 CHALET ROAD
KIAMESHA LAKE, NY 12751**

© 2019 JCJ Architecture

CONSULTANTS:

MEP & FP ENGINEER
M/E ENGINEERING
60 LAKEFRONT BOULEVARD, SUITE 320
BUFFALO, NY 14202
716.845.5092

OWNERS CONSULTANT

AKRF ENGINEERING
34 SOUTH BROADWAY, SUITE
WHITE PLAINS, NY 10601
914-949-7336

PERMIT SET
09/30/2021



P.I.C. _____ L.D. _____
P.M. _____ P.A. _____

ISSUE	09/30/21
JOB	H18064.14
DRAWN	DSL
SCALE	1" = 30'-0"


REVISIONS:

SITE PLAN - MAINTENANCE BUILDING

E-112

SITE PLAN DRAWING NOTES

- 1 PAD MOUNTED 750 KVA TRANSFORMER. VERIFY EXACT LOCATION IN FIELD.
- 2 PROVIDE TWO (2) 2" CONDUITS IN DUCTBANK FROM TRANSFORMER LOCATION TO
- 3 MAINTENANCE BUILDING. STUB CONDUITS UP AT EQUIPMENT ROOM XA15.
- 4 STUB CONDUITS UP 12" ABOVE GRADE AND CAP. PROVIDE CONDUIT SLEWS FOR CLASS 1,
- 5 DIV 2 LOCATIONS.
- 6 ROUTE 2" CONDUITS TO ELECTRICAL XAIS. STUB 12" AFF AND CAP. PROVIDE CONDUIT
- 7 SLEWS FOR CLASS 1, DIV 2 LOCATIONS.
- 8 PROVIDE 24"x24"x36" DEEP HANDHOLE.
- 9 PROVIDE 120V, 20A CIRCUIT FOR SHED'S INTEGRAL LIGHTING.
- 10 VERIFY EXACT LOCATION OF UTILITY POLE IN FIELD.
- 11 PROVIDE 2-4" CONDUITS FOR INCOMING COMMUNICATION IN DUCTBANK TO ROOM XA15.

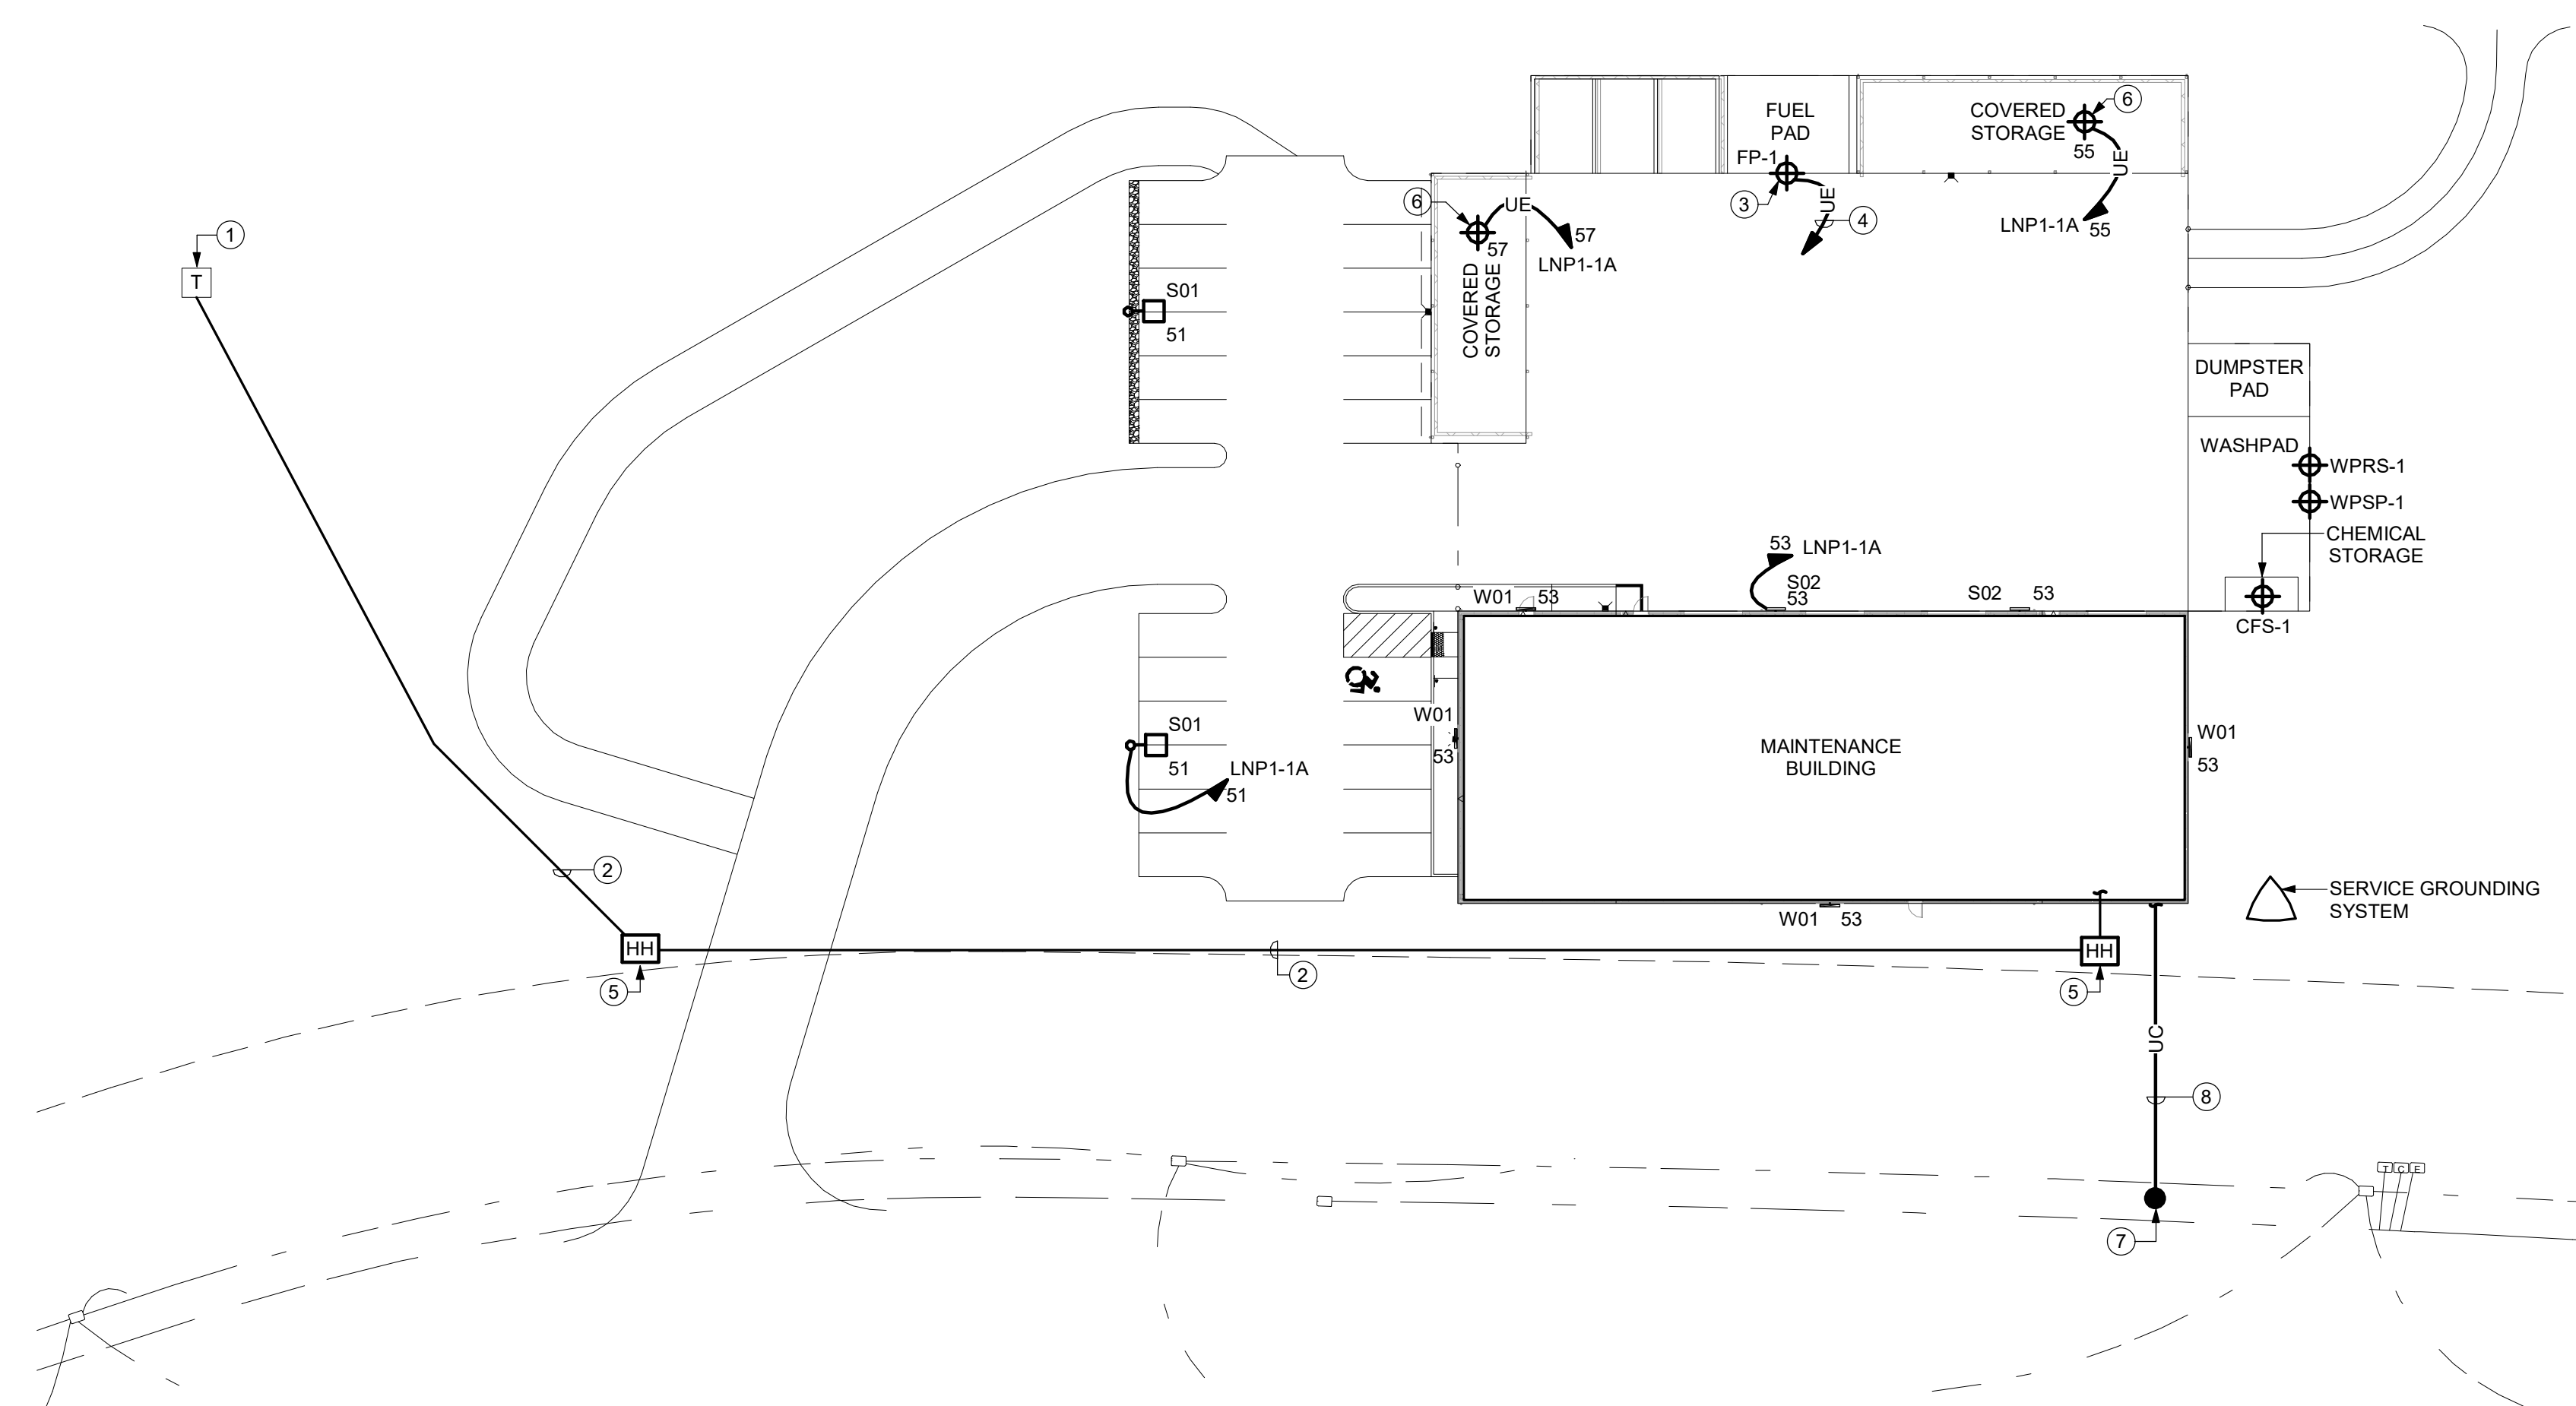

1 MAINTENANCE BUILDING - SITE PLAN - ELECTRICAL
1" = 30'-0"