

**84 CHALET ROAD
KIAMESHA LAKE, NY 12751**

© 2019 JCJ Architecture

CONSULTANTS:

MEP & FP ENGINEER
M/E ENGINEERING
60 LAKEFRONT BOULEVARD, SUITE 320
BUFFALO, NY 14202
716.845.5092

OWNERS CONSULTANT

AKRF ENGINEERING
34 SOUTH BROADWAY, SUITE
WHITE PLAINS, NY 10601
914-949-7336

PERMIT SET
09/30/2021



P.I.C. _____ L.D. _____
P.M. _____ P.A. _____

ISSUE	09/30/21
JOB	H18064.14
DRAWN	DSL
SCALE	1" = 30'-0"


REVISIONS:

SITE PLAN - MAINTENANCE BUILDING

E-112

SITE PLAN DRAWING NOTES

2. PAD MOUNTED 750 KVA TRANSFORMER. VERIFY EXACT LOCATION IN FIELD.
3. PROVIDE TWO (2) 2" CONDUITS IN DUCTBANK FROM TRANSFORMER LOCATION TO MAINTENANCE BUILDING. STUB CONDUITS UP AT EQUIPMENT ROOM XA15.
4. STUB CONDUITS UP 12" ABOVE GRADE AND CAP. PROVIDE CONDUIT SEALS FOR CLASS 1, DIV 2 LOCATIONS.
5. ROUTE 2" CONDUITS TO ELECTRICAL XAIS. STUB 12" AFF AND CAP. PROVIDE CONDUIT SEALS FOR CLASS 1, DIV 2 LOCATIONS.
6. PROVIDE 24"x24"x36" DEEP HANDHOLE.
7. PROVIDE 120V, 20A CIRCUIT FOR SHED'S INTEGRAL LIGHTING.
8. VERIFY EXACT LOCATION OF UTILITY POLE IN FIELD.
9. PROVIDE 2-4" CONDUITS FOR INCOMING COMMUNICATION IN DUCTBANK TO ROOM XA15.

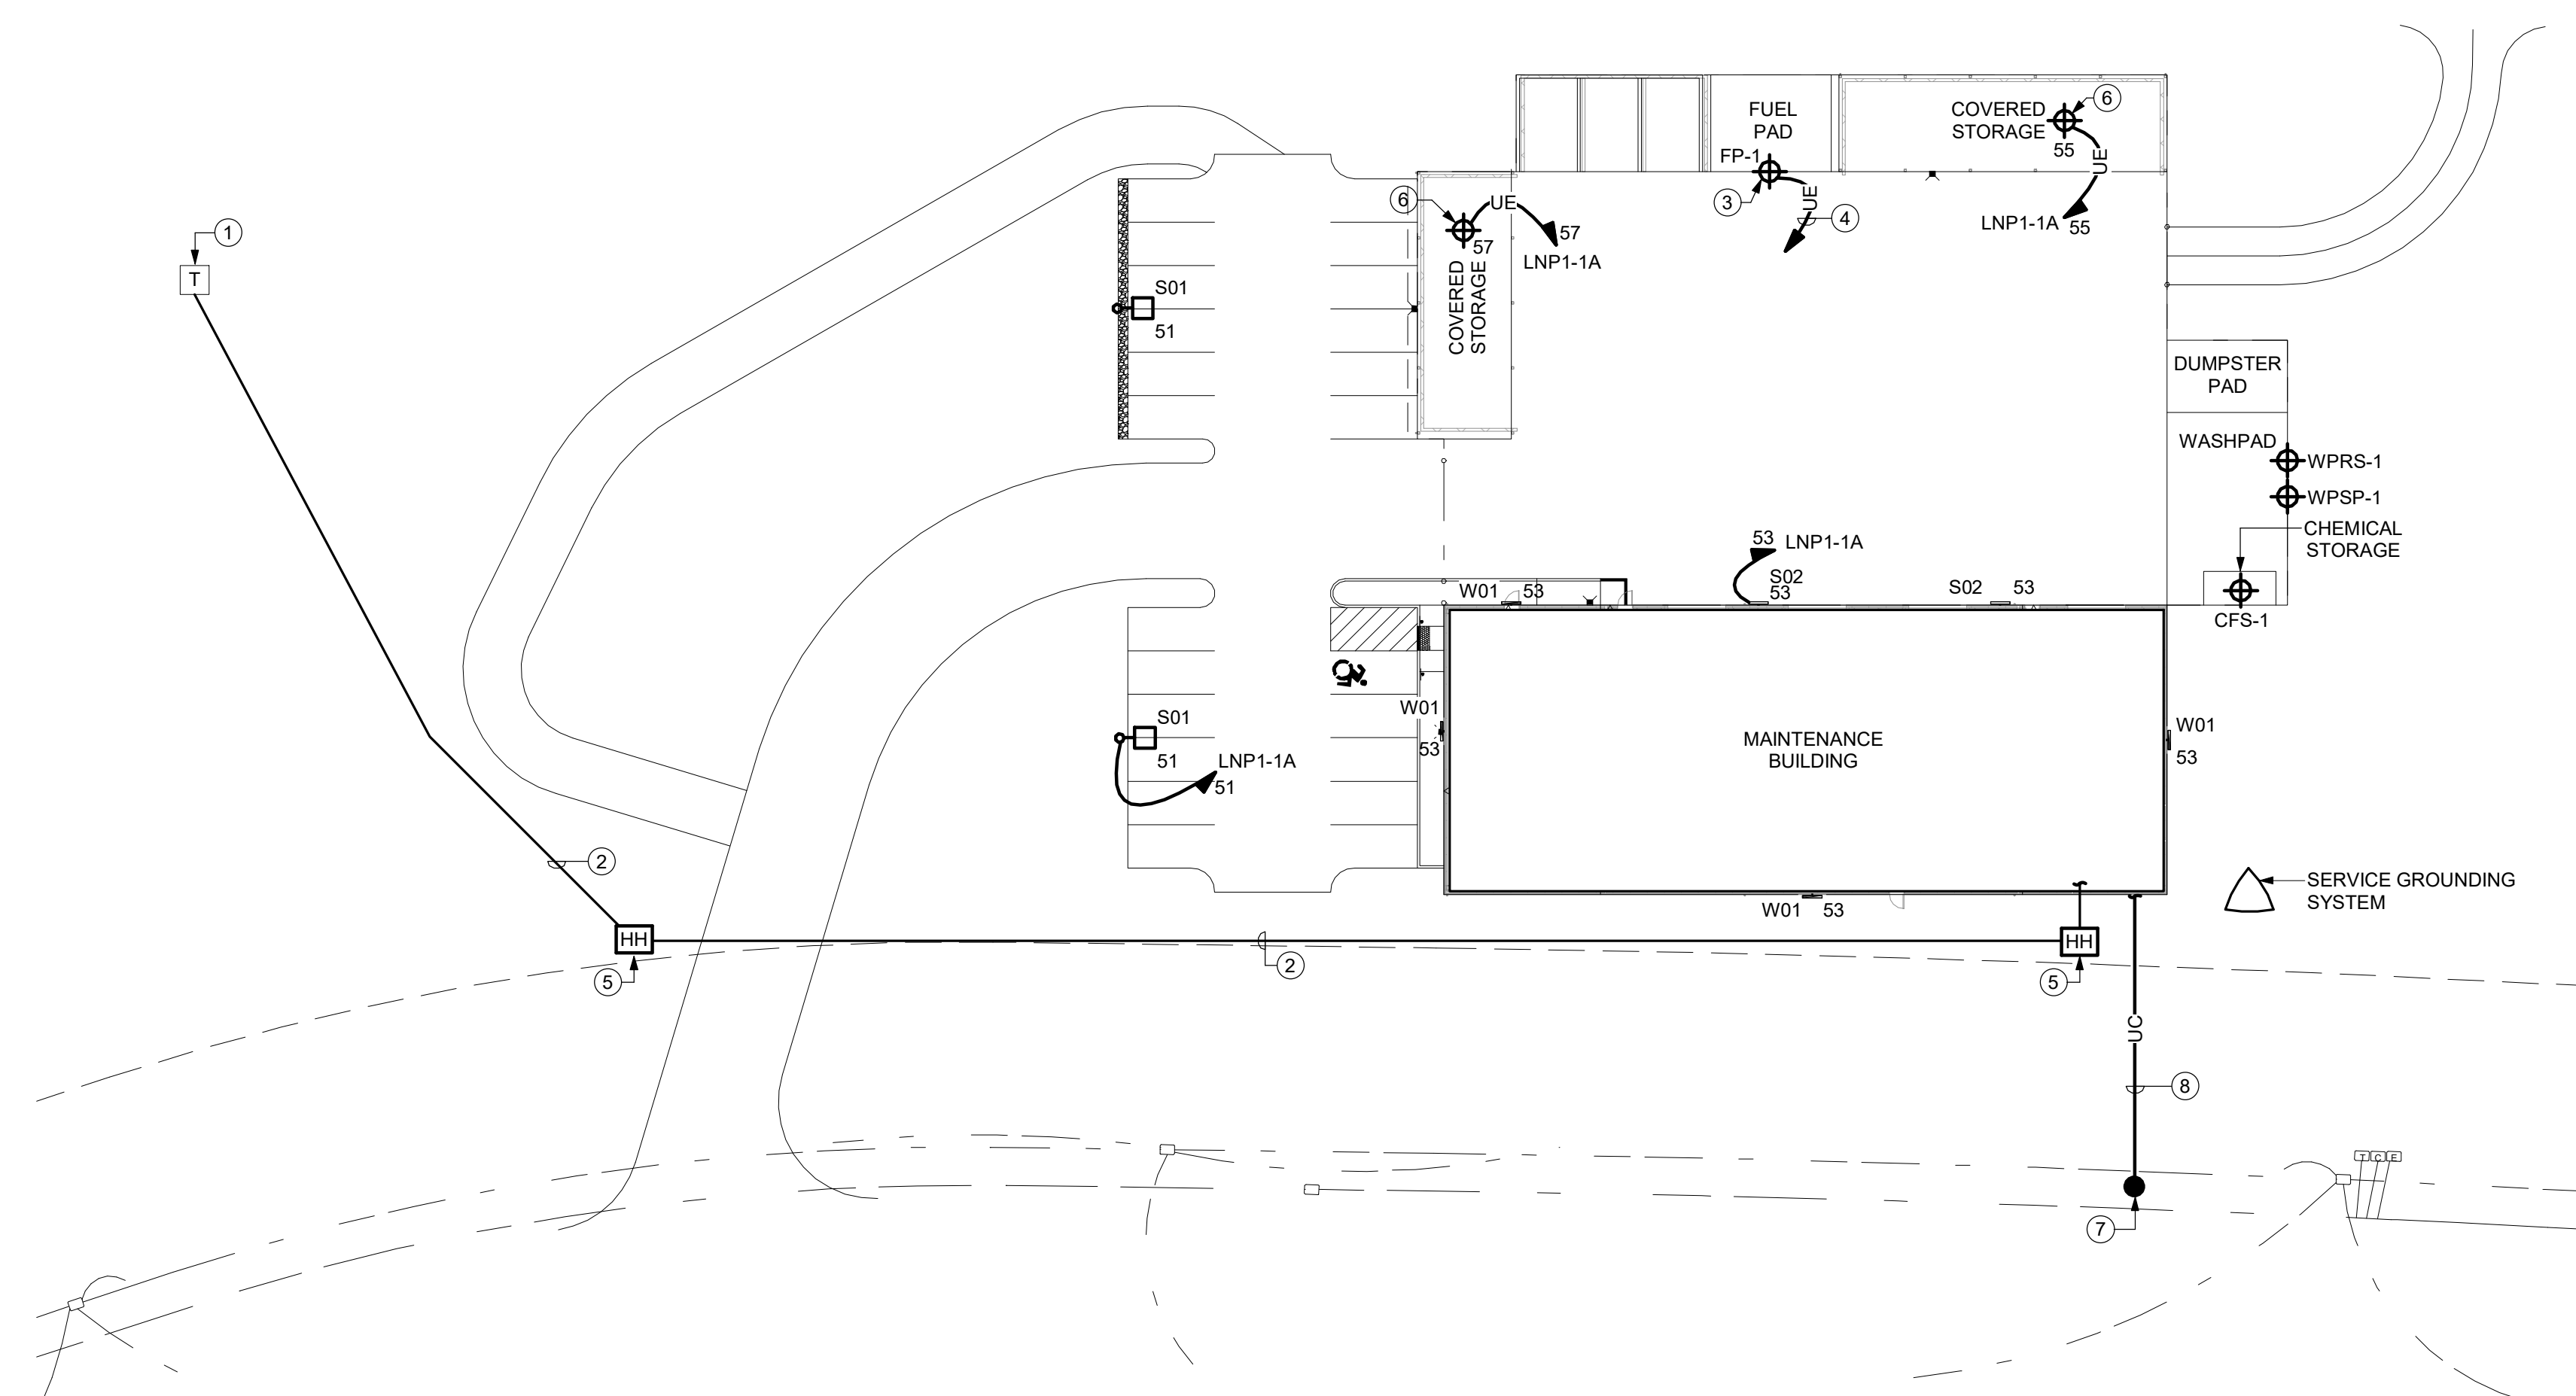

1 MAINTENANCE BUILDING - SITE PLAN - ELECTRICAL