

NORTH ROCKLAND HIGH SCHOOL PROJECTS - PHASE 1

NORTH ROCKLAND HIGH SCHOOL
106 Hammond Road
Thiells, NY 10984

HIGH SCHOOL: SED# 50-02-01-06-0-016-035
PRESS BOX (DEMO): SED# 50-02-01-06-7-026-001
CONCESSIONS-PRESS BOX (NEW): SED# 50-02-01-06-7-079-001
FIELDHOUSE: SED# 50-02-01-06-7-008-001

OWNER:
NORTH ROCKLAND
CENTRAL SCHOOL DISTRICT
65 CHAPEL STREET
GARNERVILLE, NY 10923

ARCHITECT:
MICHAEL SHILALE ARCHITECTS, LLP
140 Park Avenue
New City, NY 10956

**MEP ENGINEER:
GREENMAN-PEDERSEN, INC.
2 Executive Boulevard, Suite 202,
Suffern, NY 10901**

**LANDSCAPE ARCHITECT:
THE LA GROUP
179 Graham Road
Ithaca, NY 14850**

DRAWING No.	DRAWING TITLE	DATE	DRAWING No.	DRAWING TITLE	DATE
A-000	COVER SHEET	01-27-23	A-211	CONCESSIONS/PRESS BOX BUILDING SECTIONS	01-27-23
A-001	LEGENDS, NOTES, UNIT PRICES, ALTS. & ALLOWANCES	01-27-23	A-212	CONCESSIONS/PRESS BOX WALL SECTIONS	03-06-23
B-110	CONCESSIONS/PRESS BOX CODE ANALYSIS	01-27-23	A-214	CONCESSION/PRESS BOX SECTIONS	01-27-23
B-111	CONCESSIONS/PRESS BOX 1ST FLOOR EGRESS PLAN	01-27-23	A-220	WEIGHT/LOCKER ROOM ELEVATIONS	01-27-23
B-112	CONCESSIONS/PRESS BOX 2ND FLOOR EGRESS PLAN	01-27-23	A-221	WEIGHT/LOCKER ROOM SECTIONS	01-27-23
B-120	WEIGHT ROOM/LOCKER ROOM CODE ANALYSIS	01-27-23	A-240	FIELDHOUSE ELEVATIONS	01-27-23
B-121	LOCKER ROOM EGRESS PLAN	01-27-23	A-241	FIELDHOUSE DETAILS	01-27-23
B-122	WEIGHT ROOM EGRESS PLAN	01-27-23	A-410	CONCESSIONS/PRESS BOX 1ST FL RCP	01-27-23
B-130	HIGH SCHOOL RTU CODE ANALYSIS	01-27-23	A-411	CONCESSIONS/PRESS BOX 2ND FL RCP	01-27-23
B-141	FIELDHOUSE EGRESS PLAN	01-27-23	A-420	WEIGHT ROOM REFLECTED CEILING PLAN	01-27-23
	BOUNDARY LINE AND TOPOGRAPHIC SURVEY (SHEET 1 OF 4)	01-27-23	A-421	LOCKER ROOM REFLECTED CEILING PLAN	01-27-23
	BOUNDARY LINE AND TOPOGRAPHIC SURVEY (SHEET 2 OF 4)	01-27-23	A-430	CEILING REMOVAL & INSTALLATION PLAN	01-27-23
	BOUNDARY LINE AND TOPOGRAPHIC SURVEY (SHEET 3 OF 4)	01-27-23	A-510	CONCESSIONS/PRESS BOX WINDOW ELEVATIONS	01-27-23
	BOUNDARY LINE AND TOPOGRAPHIC SURVEY (SHEET 4 OF 4)	01-27-23	A-510.1	CONCESSIONS/PRESS BOX WINDOW DETAILS	01-27-23
AA-000	ASBESTOS ABATEMENT NOTES	01-27-23	A-511	CONCESSIONS/PRESS BOX ROOF DETAILS	01-27-23
AA-100	WEIGHT ROOM ASBESTOS ABATEMENT PLAN	01-27-23	A-511.1	CONCESSIONS/PRESS BOX EPDM ROOF DETAILS	01-27-23
AA-200	FIELD HOUSE ASBESTOS ABATEMENT PLAN	01-27-23	A-512	CONCESSIONS/ PRESS BOX SECTION	03-06-23
C-100	SITE KEY PLAN	01-27-23	A-513	CONCESSIONS/ PRESS BOX DETAILS	01-27-23
C-101	SITE CODE COMPLIANCE PLAN	01-27-23	A-514	CONCESSIONS/ PRESS BOX EIFS DETAILS	01-27-23
C-102	SOIL EROSION AND SEDIMENT CONTROL PLAN	01-27-23	A-515	CONCESSIONS/ PRESS BOX EIFS DETAILS	01-27-23
C-103	SOIL EROSION AND SEDIMENT CONTROL NOTES & DETAILS	01-27-23	A-520	WEIGHT/LOCKER ROOM WINDOW SCHEDULE AND ELEVATION	01-27-23
C-200	SITE DEMOLITION PLAN	01-27-23	A-521	WEIGHT/LOCKER ROOM WINDOW DETAILS	01-27-23
C-201	ADD ALTERNATE SITE DEMOLITION PLAN	01-27-23	A-522	WEIGHT/LOCKER ROOM SHADE DETAILS	01-27-23
C-210	SITE LAYOUT PLAN	01-27-23	A-530	HIGH SCHOOL RTU ROOF DETAILS	01-27-23
C-211	SITE ENLARGEMENT PLAN	01-27-23	A-610	CONCESSIONS/PRESS BOX FINISH SCHEDULE	01-27-23
C-220	SITE GRADING AND DRAINAGE PLAN	01-27-23	A-611	CONCESSIONS/PRESS BOX DOOR SCHEDULE	01-27-23
C-230	SITE UTILITY PLAN	01-27-23	A-612	CONCESSIONS/PRESS BOX MEN'S ROOM INTERIOR ELEVATIONS	01-27-23
C-231	SITE UTILITY PLAN	01-27-23	A-613	CONCESSIONS/PRESS BOX WOMEN'S ROOM INTERIOR ELEVATIONS	01-27-23
C-232	SITE UTILITY PLAN	01-27-23	A-614	CONCESSIONS/PRESS BOX TOILET ROOM PLANS & INTERIOR ELEVATIONS	01-27-23
C-234	ADD ALTERNATE SITE UTILITY PLAN	01-27-23	A-620	WEIGHT/LOCKER ROOM FINISH SCHEDULE	01-27-23
C-240	SITE PLANTING PLAN	01-27-23	A-621	WEIGHT/LOCKER ROOM DOOR SCHEDULE	01-27-23
C-300	FIELD LINES STRIPING PLAN	01-27-23	A-640	FIELDHOUSE FINISH SCHEDULE	01-27-23
C-301	FIELD LINES STRIPING PLAN	01-27-23	A-641	FIELDHOUSE DOOR SCHEDULE	01-27-23
C-500	ATHLETIC FIELD DETAILS	01-27-23	A-690	PARTITION TYPE & DETAILS	01-27-23
C-501	ATHLETIC FIELD DETAILS	01-27-23	A-720	WEIGHT/LOCKER ROOM FLOORING PLAN	01-27-23
C-502	SITE DETAILS	01-27-23	A-721	WEIGHT/LOCKER ROOM EQUIPMENT PLAN	01-27-23
C-503	SITE DETAILS	01-27-23	M-090	PROJECT WIDE MECHANICAL NOTES, SYMBOLS, LEGEND & ABBREV.	01-27-23
C-504	SITE UTILITY DETAILS	01-27-23	M-010	CONCESSIONS/PRESS BOX MECHANICAL NOTES AND SCHEDULES	01-27-23
C-505	SITE UTILITY DETAILS	01-27-23	M-020	WEIGHT/LOCKER ROOM MECHANICAL NOTES AND SCHEDULES	01-27-23
CE-001	ELECTRICAL SYMBOLS, GENERAL NOTES, SCHEDULES, & ABBREV.	01-27-23	M-021	WEIGHT/LOCKER ROOM CONTROL DIAGRAM	01-27-23
CE-002	ELECTRICAL SITE PLAN	01-27-23	M-030	HIGH SCHOOL RTU MECHANICAL NOTES AND SCHEDULES	01-27-23
CE-003	ELECTRICAL SITE LIGHTING PLAN	01-27-23	M-031	HIGH SCHOOL RTU MECHANICAL CONTROL DIAGRAM	01-27-23
CE-110	ELECTRICAL ATHLETIC FIELD LIGHTING AND POWER PLAN	01-27-23	MD-120	WEIGHT/LOCKER ROOM MECHANICAL DEMO PLANS	01-27-23
CE-410	ELECTRICAL EQUIPMENT LAYOUT RISER DIAGRAM	01-27-23	MD-121	WEIGHT/LOCKER ROOM MECHANICAL DEMO ROOF PLANS	01-27-23
CE-510	ELECTRICAL DETAILS SHEET #1	01-27-23	MD-130	HIGH SCHOOL RTU MECHANICAL DEMO PLANS	01-27-23
CE-511	ELECTRICAL DETAILS SHEET #2	01-27-23	M-110	CONCESSIONS/PRESS BOX MECHANICAL FLOOR PLANS	01-27-23
CE-512	ELECTRICAL DETAILS SHEET #3	01-27-23	M-120	WEIGHT/LOCKER ROOM MECHANICAL FLOOR PLANS	01-27-23
CE-513	ELECTRICAL DETAILS SHEET #4	01-27-23	M-121	WEIGHT/LOCKER ROOM MECHANICAL ROOF PLANS	01-27-23
D-110	CONCESSIONS/PRESS BOX DEMO PLAN	01-27-23	M-130	HIGH SCHOOL RTU MECHANICAL ROOF PLANS	01-27-23
D-120	WEIGHT ROOM DEMO PLAN	01-27-23	M-131	LOCKER ROOM PART PLAN	01-27-23
D-121	LOCKER ROOM DEMO PLAN	01-27-23	M-510	CONCESSION/PRESS BOX MECHANICAL DETAILS	01-27-23

[illegible]

Drawn by	MAL/JR
Checked by	MS/JC
Project No.	42051
Scale	AS NOTED
Date	07-29-22

Mechanical and Electrical Engineer:	GREENMAN PEDERSEN, INC 2 EXECUTIVE BOULEVARD, SUITE 202, SUFFERN, NY 10901
Structural Engineer:	— — — —

**NORTH ROCKLAND
HIGH SCHOOL
PROJECTS – PHASE 1**

HIGH SCHOOL. SD# 50-02-01-09-0-016-085
PRESS BOX (BAND). SD# 50-02-01-09-7-028-001
CONCESSIONS-PRESS BOX (NORTH). SD# 50-02-01-09-7-079-001
FIELDHOUSE. SD# 50-02-01-09-7-008-001


106 Hammond Rd.,
Thiells, NY 10984

TOWN OF HARVESTRAW
COUNTY OF ROCKLAND


ES&A
MICHAEL SHILALE ARCHITECTS, L.L.P.
140 Park Avenue New City, NY 10956 Tel 914-705-9200
www.shilale.com

Drawing Title COVER SHEET	Drawing No. A-000
-------------------------------------	-----------------------------


© COPYRIGHT, MICHAEL SHILAE ARCHITECTS LLP. ALL RIGHTS RESERVED.

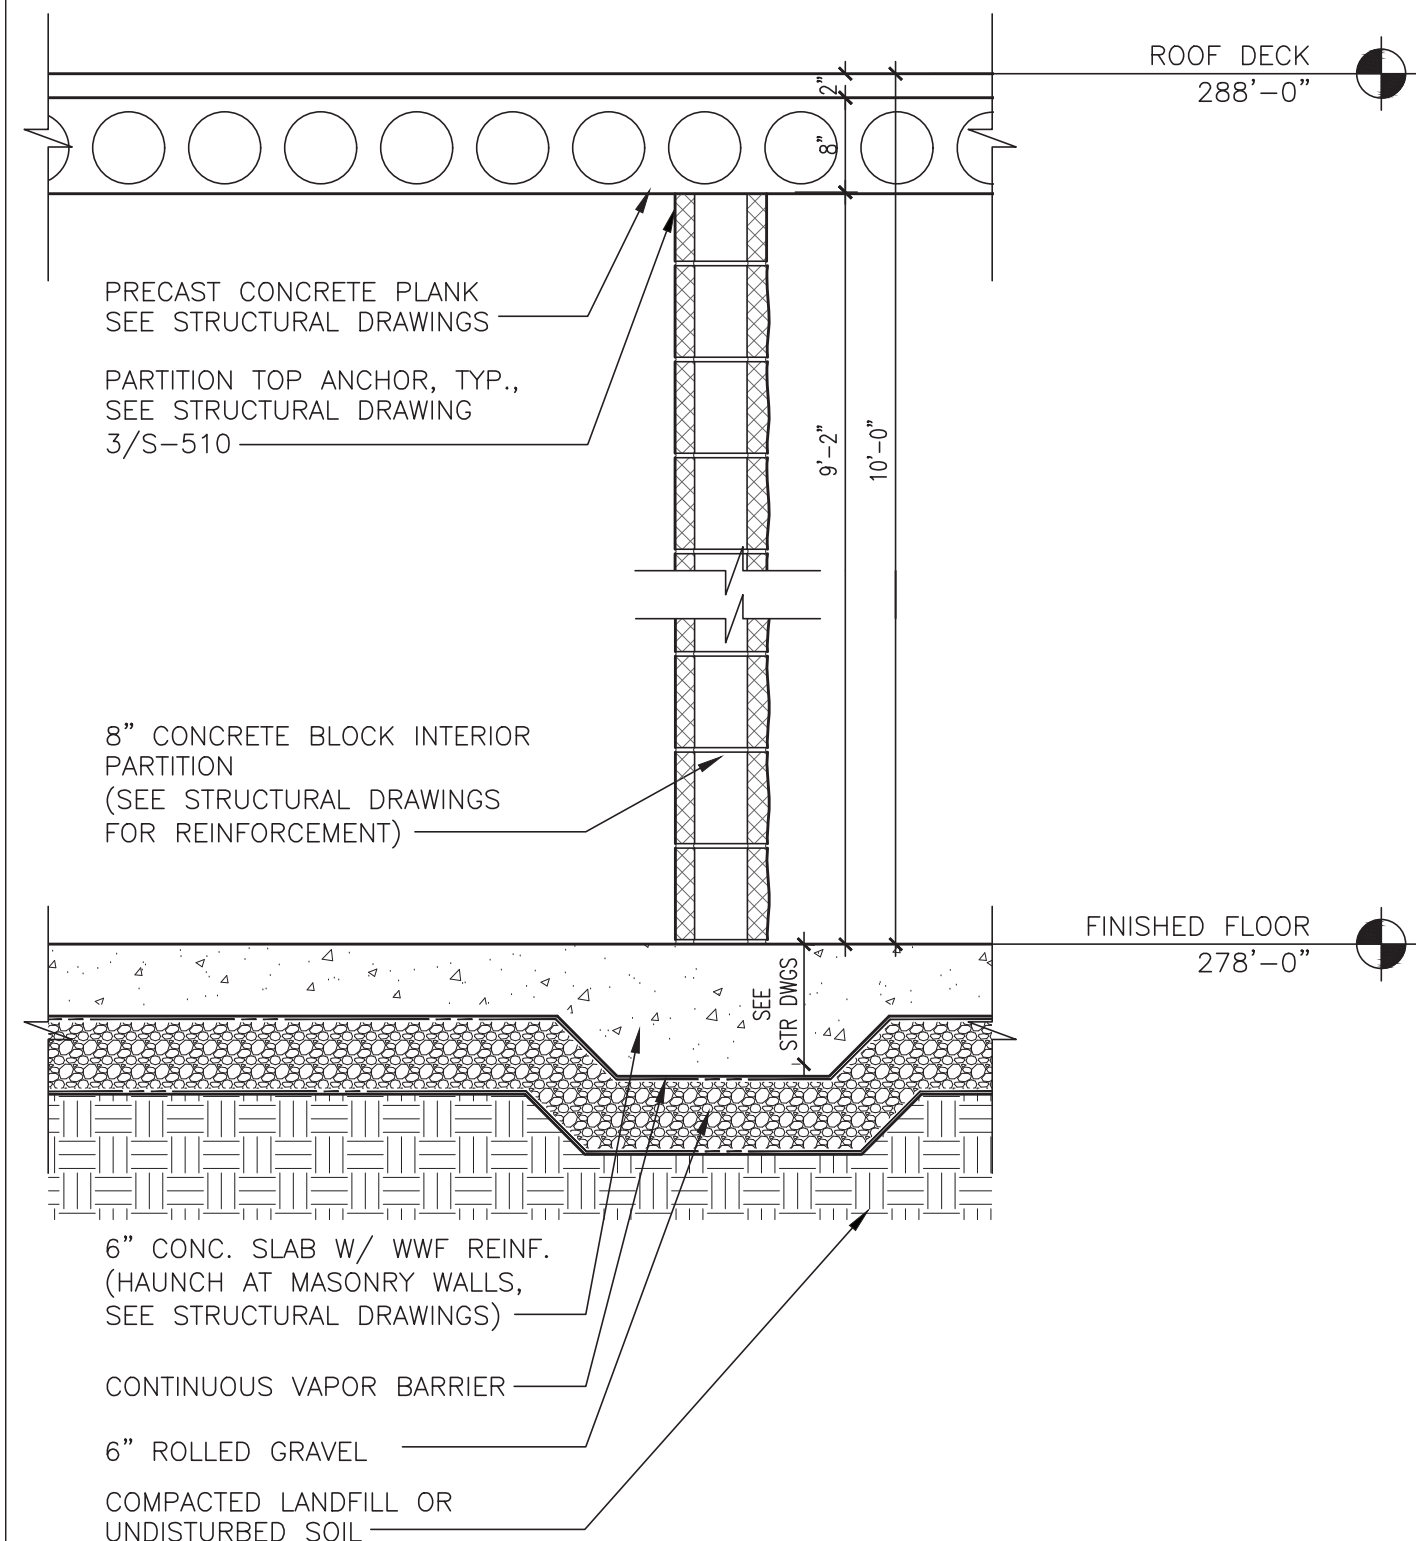


3 WALL SECTION
SCALE: 3/4"=1'-0"

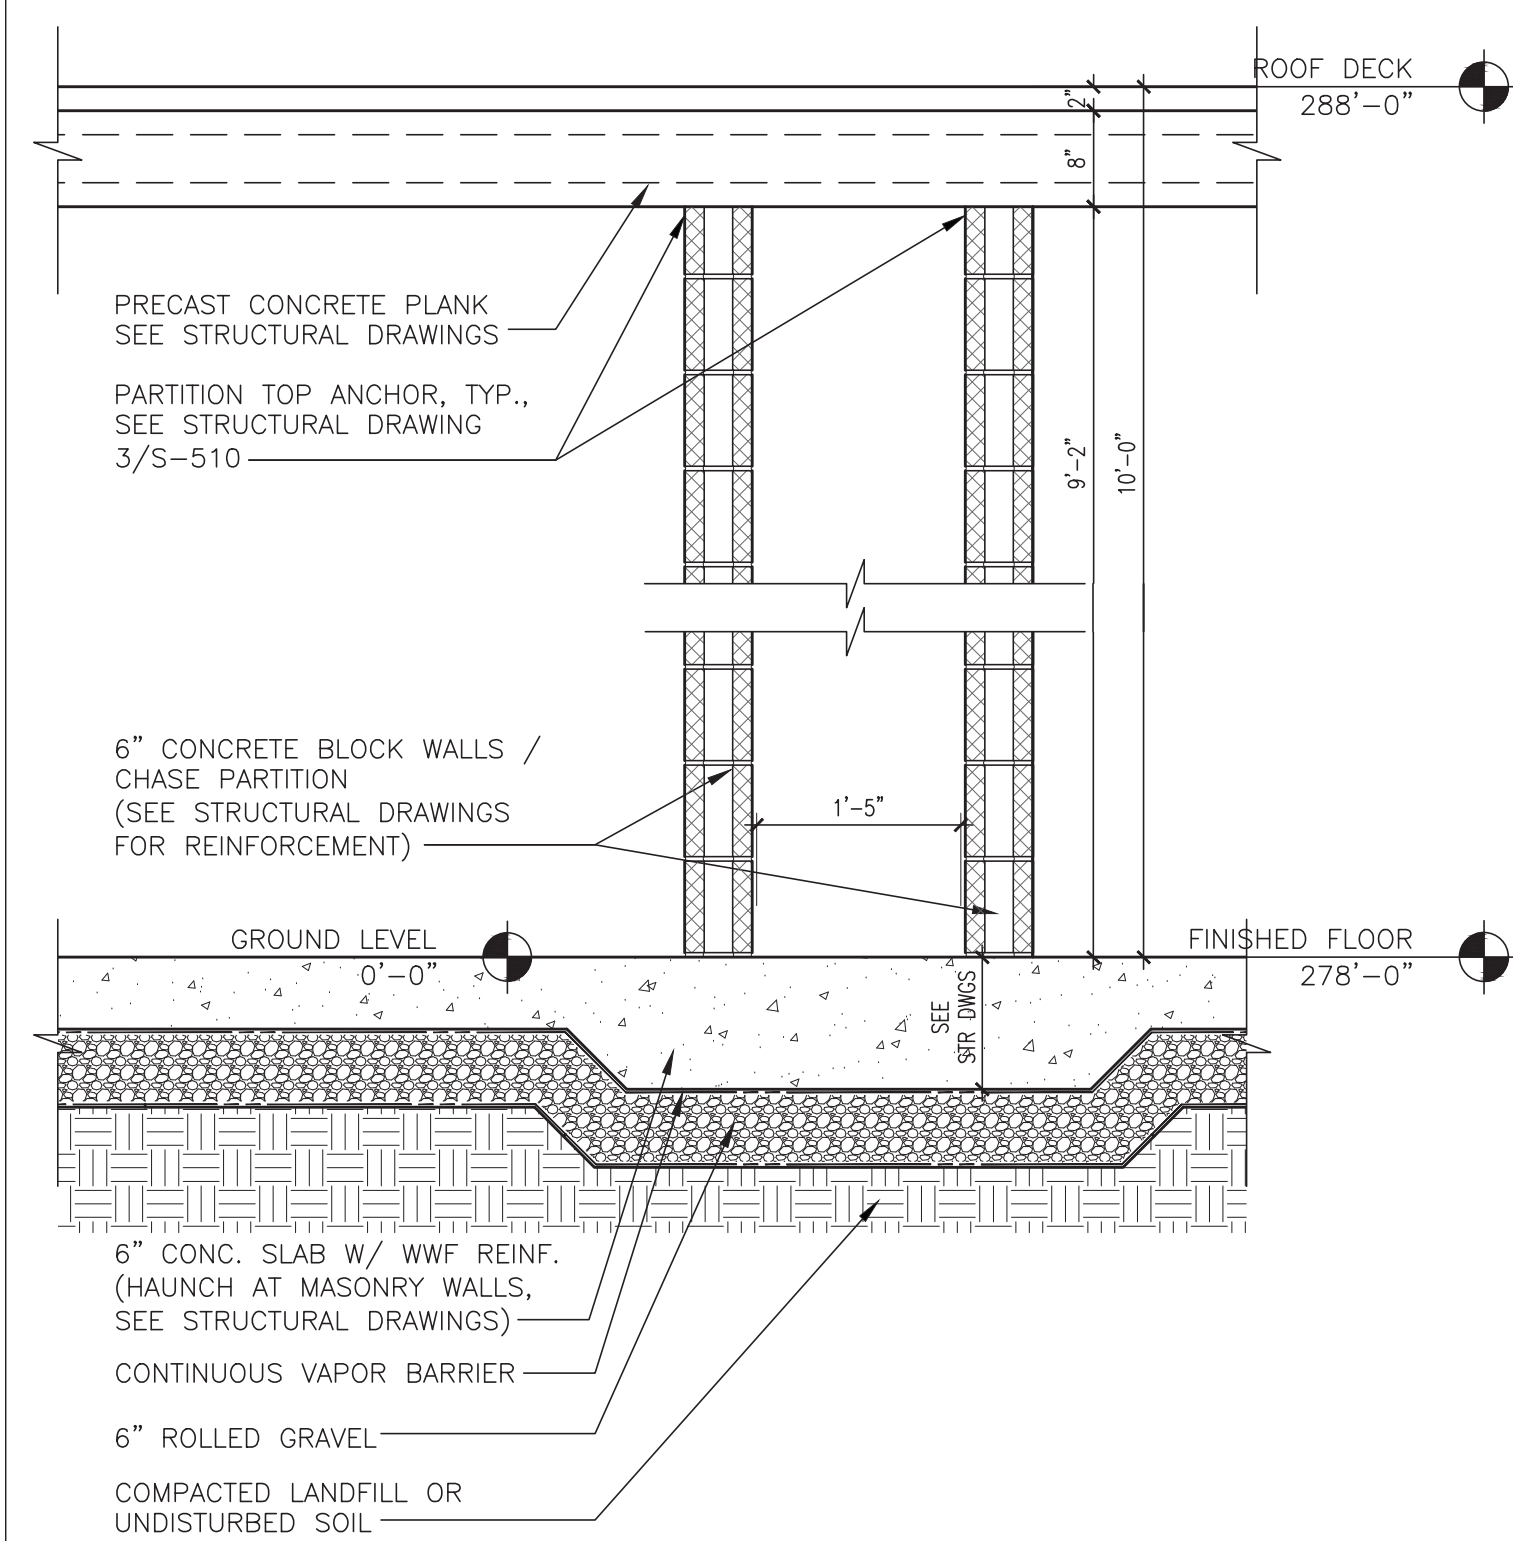

2 WALL SECTION
SCALE: 3/4"=1'-0"

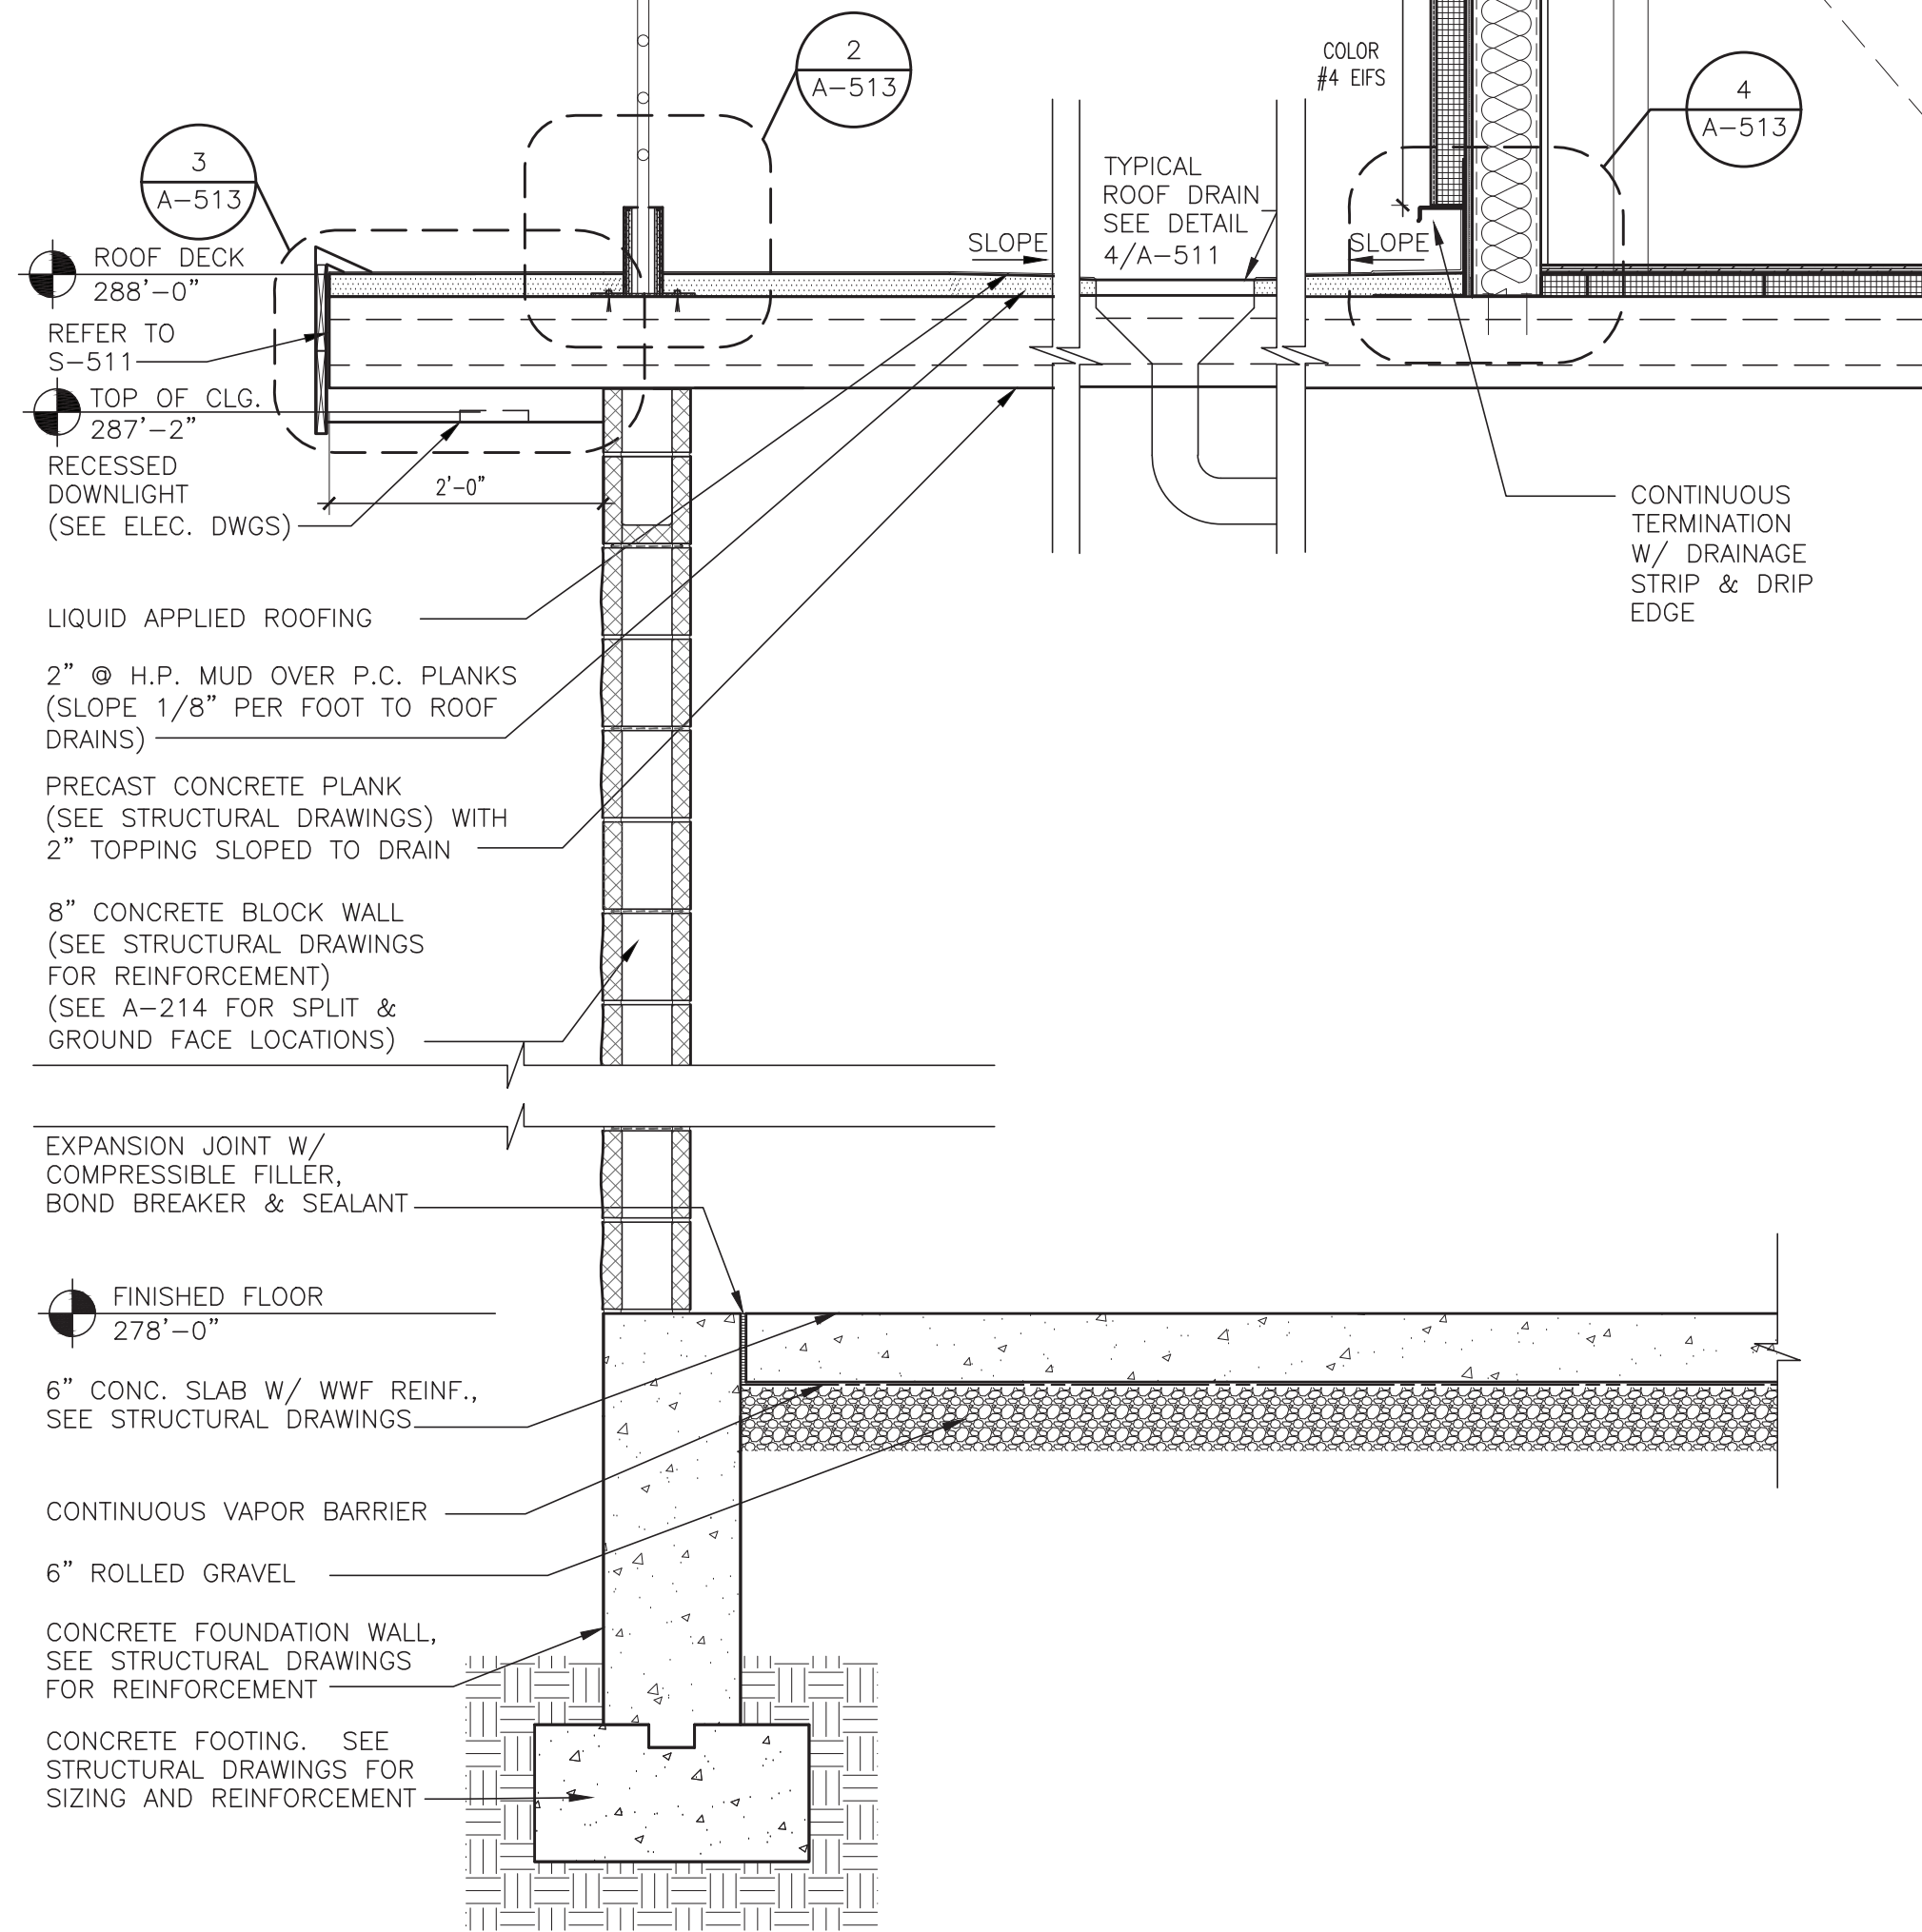

1 WALL SECTION
SCALE: 3/4"=1'-0"

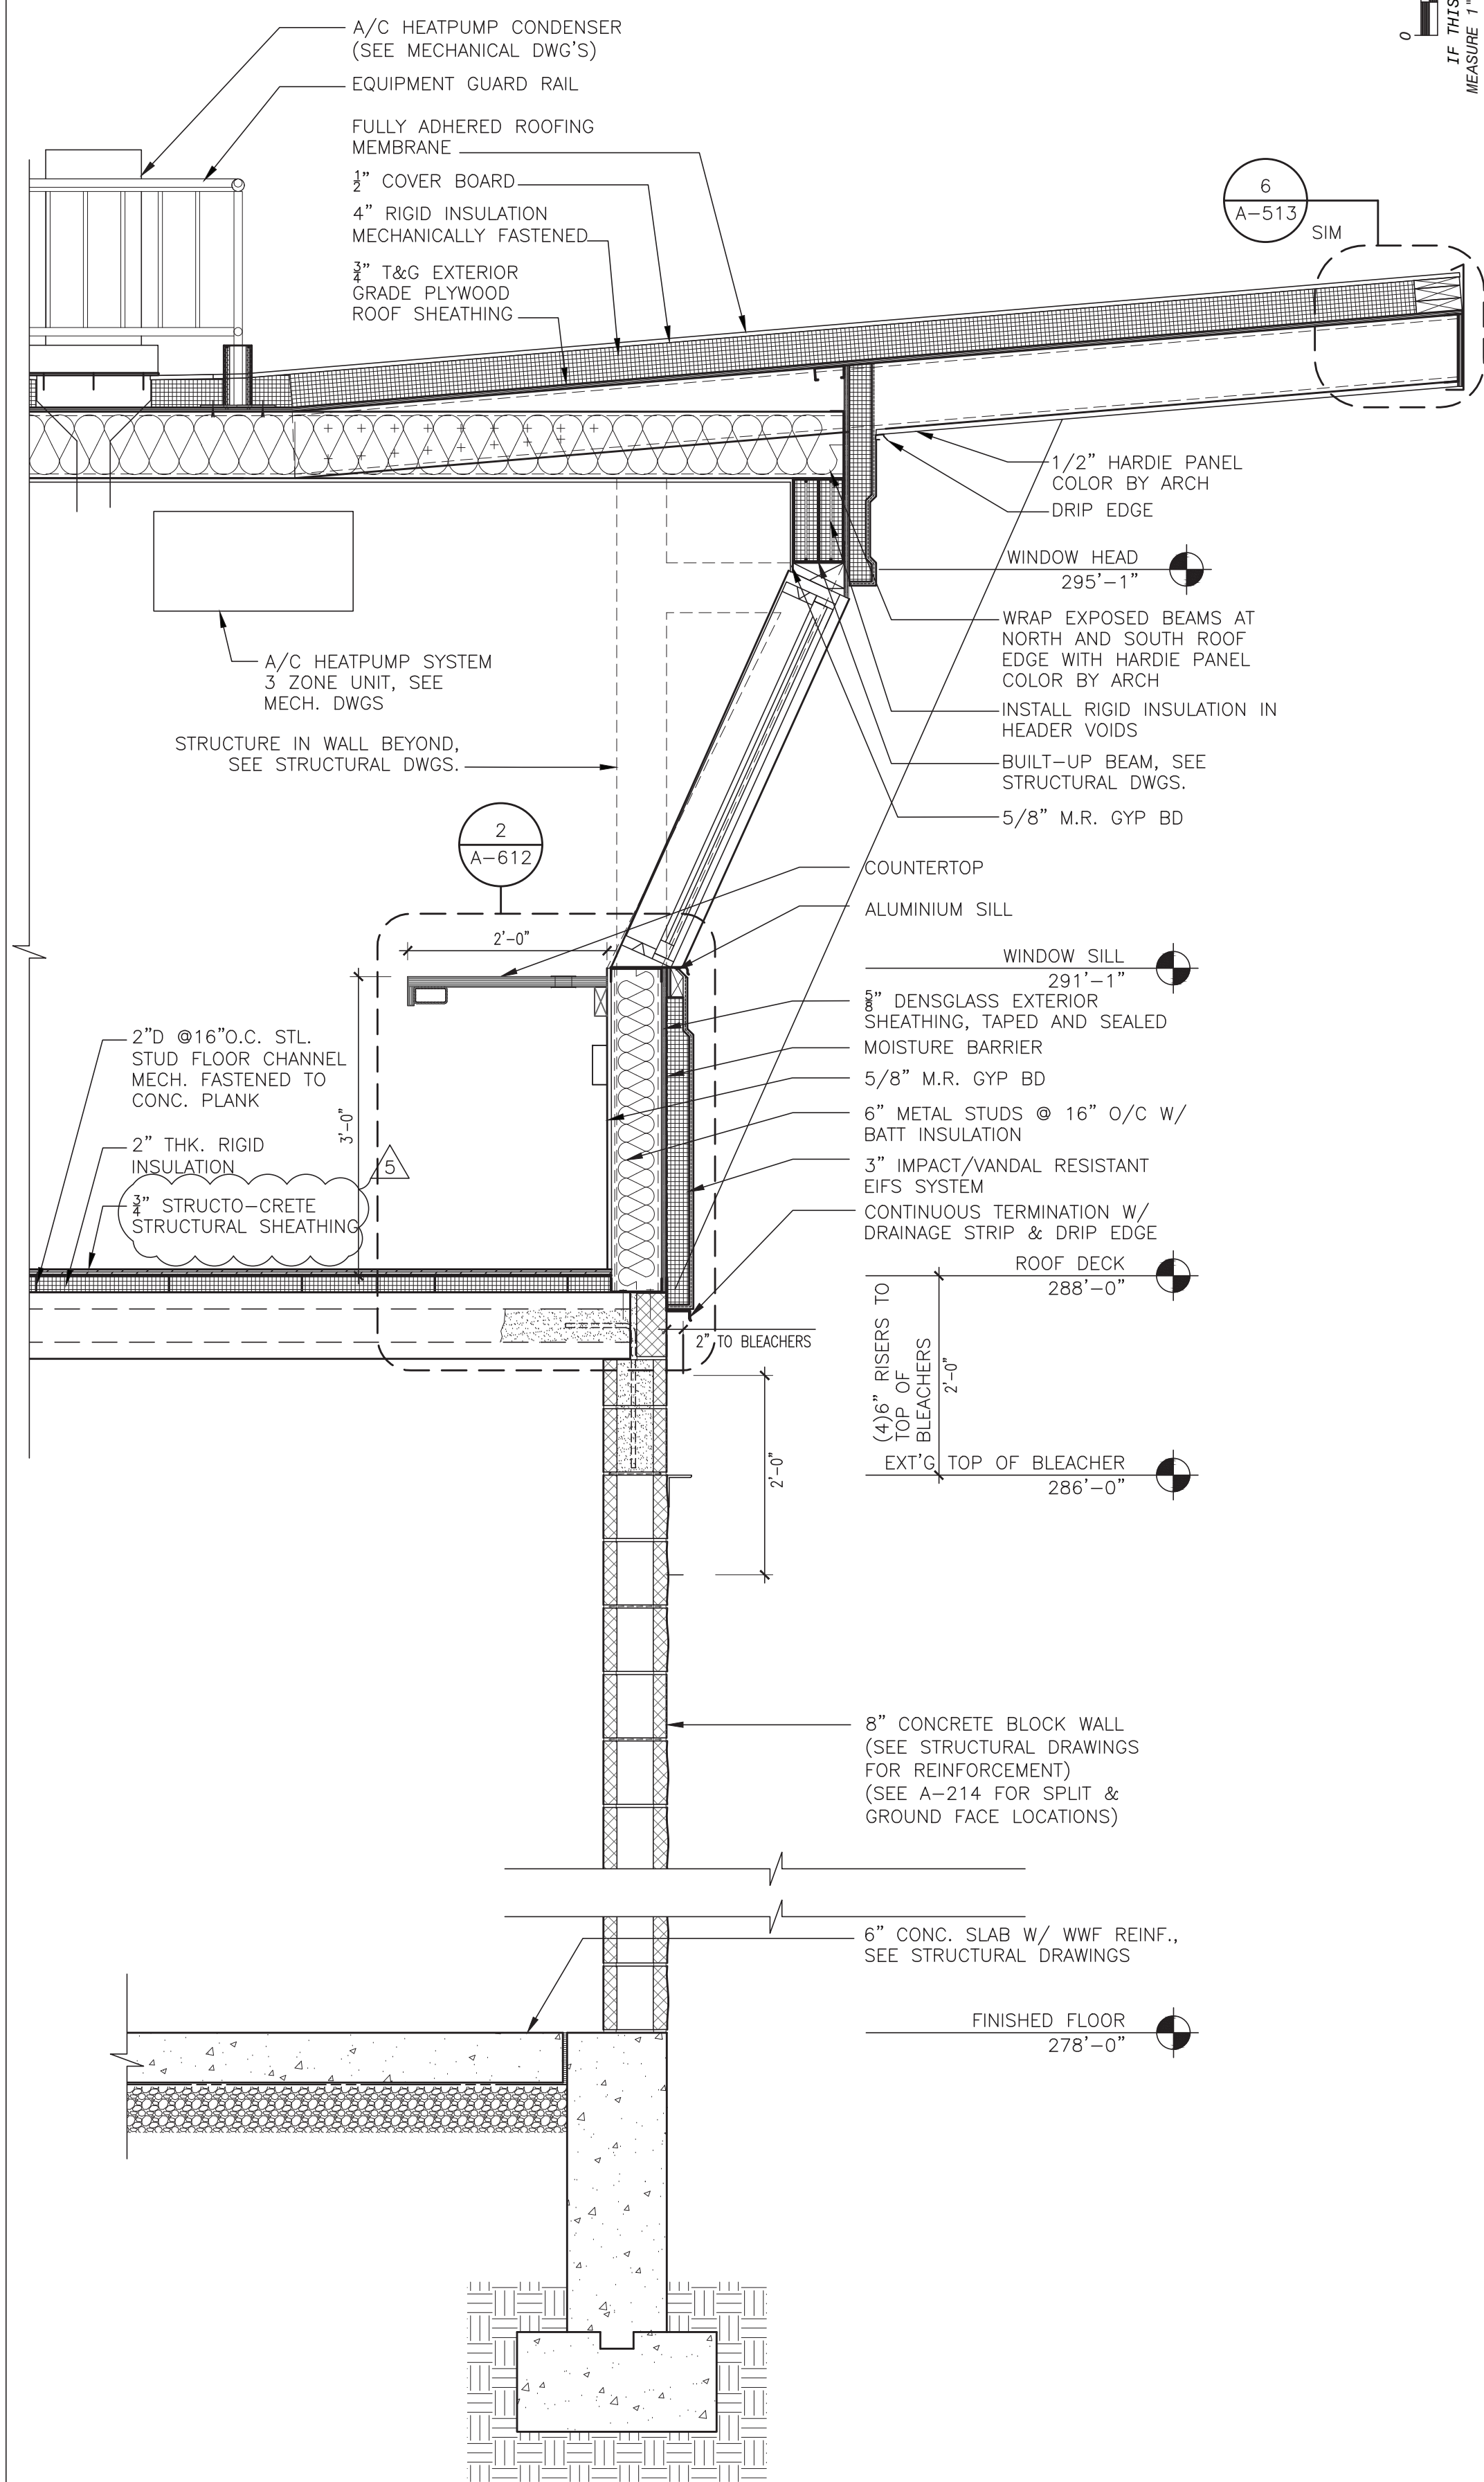

4 WALL SECTION
SCALE: 3/4"=1'-0"

0 1/2 1
IF THIS BAR DOES NOT
MEASURE 1" THEN DRAWING IS
NOT TO FULL SCALE

5	03-06-23	ADDENDUM 1	1
4	01-27-23	REVISIONS	
3	01-12-23	SED ADDENDUM 2	
1	10-28-22	BIDDING DOCUMENTS	
No.	Date	Revisions	

CP	MS/JC	42051	AS NOTED	06-24-22
Drawn by	Checked by	Project No.	Scale	Date



MECHANICAL & ELECTRICAL ENGINEER	STRUCTURAL ENGINEER
GREENMAN PEDERSEN, INC. 1000 ROUTE 202, SUITE 202, SUFFERN, NY 10901	---

NORTH ROCKLAND HIGH SCHOOL PROJECTS - PHASE 1
HIGH SCHOOL: SD# 90-02-01-06-0-008-005 PRESS BOX (D340): SD# 90-02-01-06-0-008-001 PRESS BOX (D340): SD# 90-02-01-06-0-008-001 CONCRETE FOUNDATION: SD# 90-02-01-06-0-008-001
100 HANOVER RD. THURMAN, NY 10984


HSA
MICHAEL SHIALE ARCHITECTS, L.L.P. 140 Park Avenue New York, NY 10022 Tel 945-708-9200 www.shiale.com

CONCRETE FOUNDATION/ PRESS BOX WALL SECTIONS
Drawing No. A-212

 
© COPYRIGHT, MICHAEL SHIALE ARCHITECTS, ALL RIGHTS RESERVED. IT IS A VIOLATION OF THE LAW FOR ANY PERSON, UNLESS ACTING UNDER THE DIRECTION OF A LICENSED ARCHITECT, TO ALTER AN ITEM IN ANY WAY.

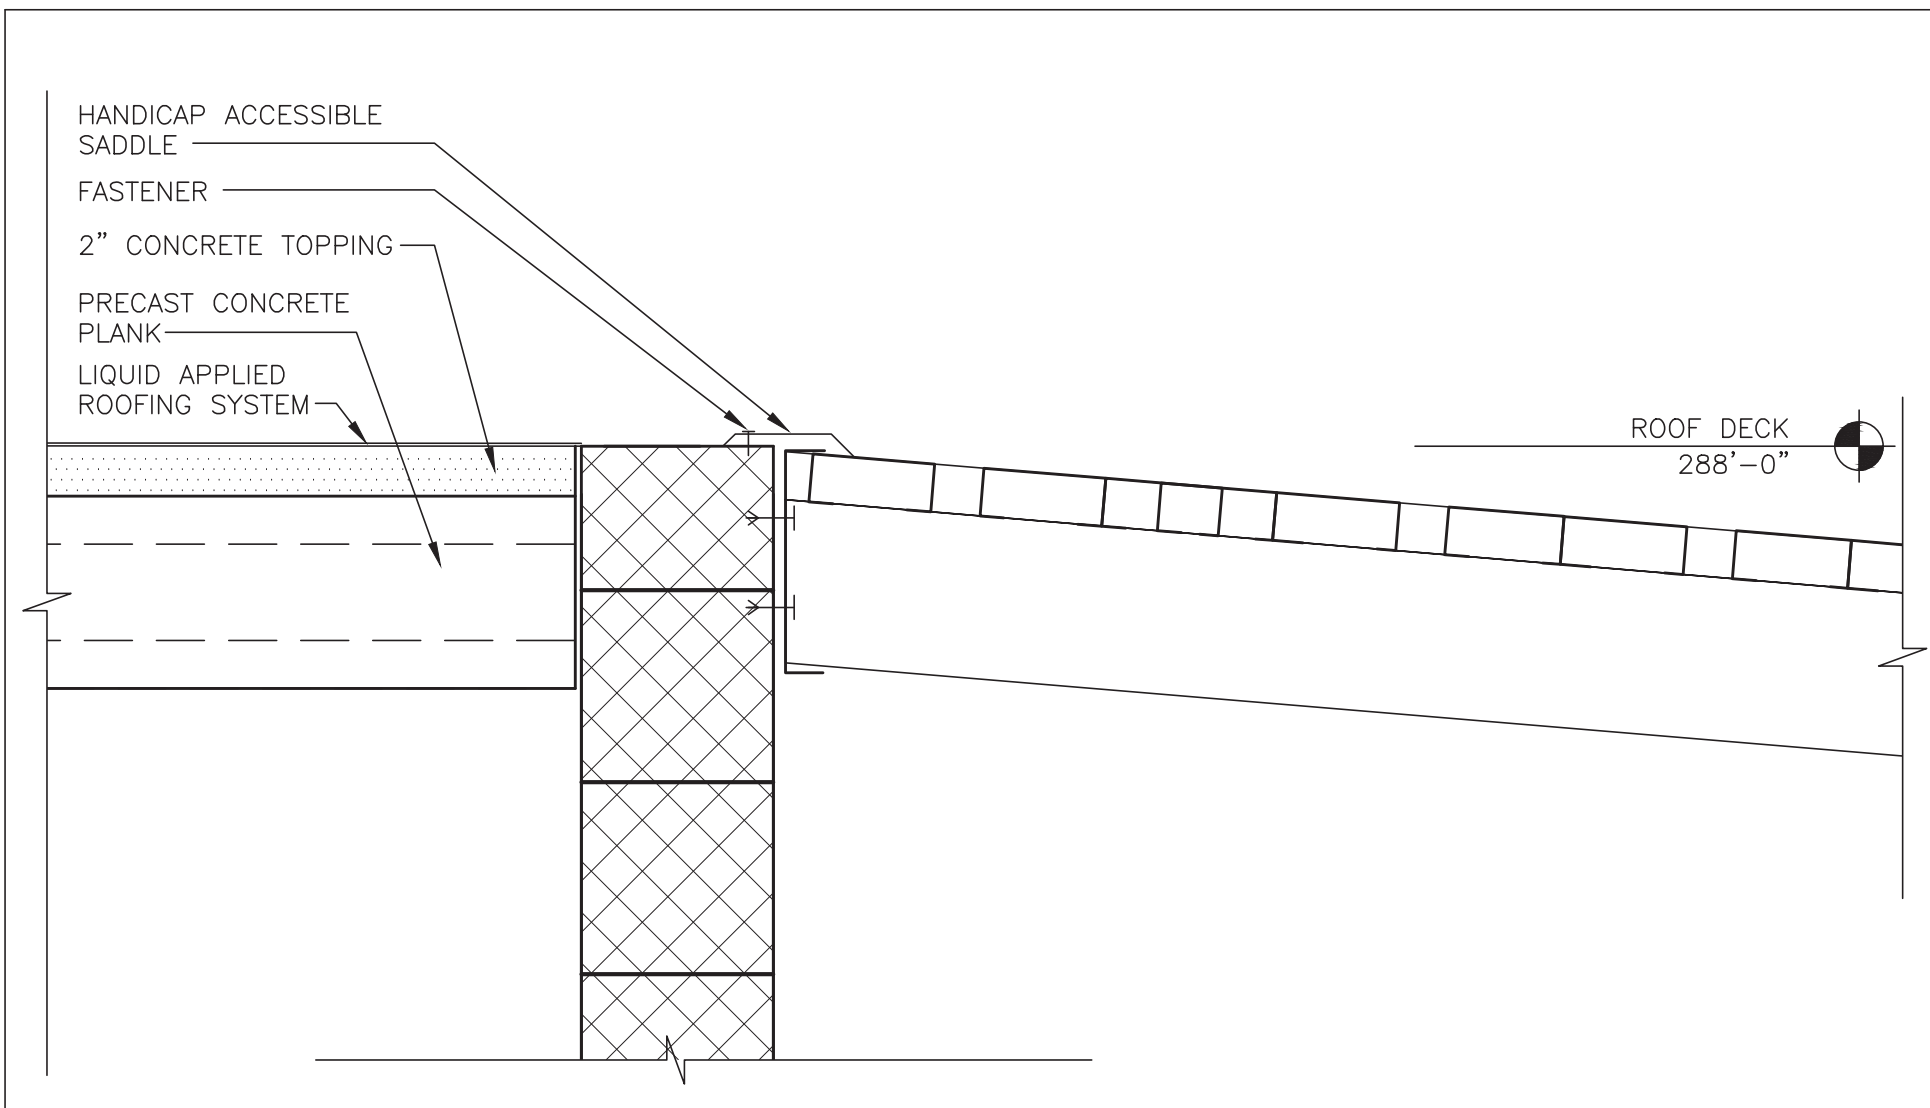


8 RAMP TO ROOF DETAIL
SCALE: 1-1/2"=1'-0"

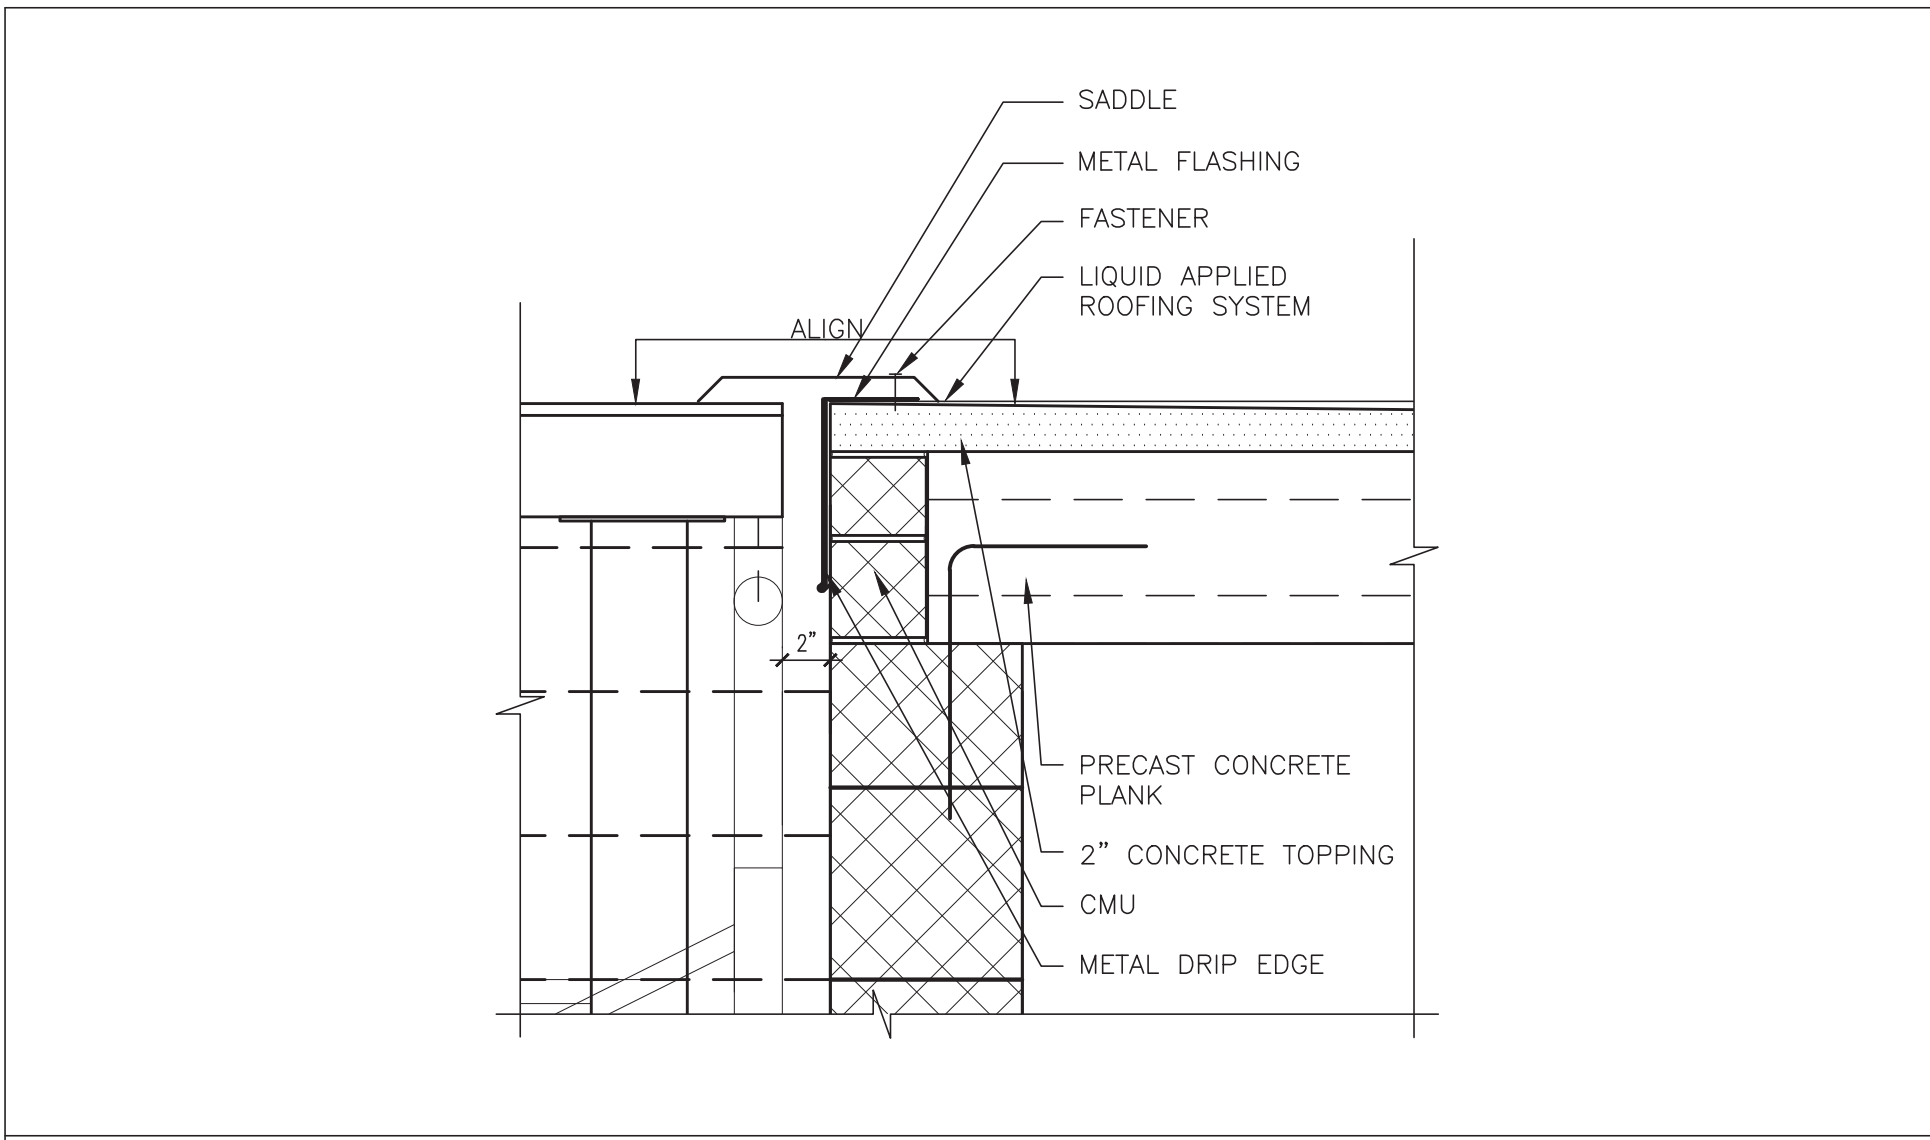


7 STAIR TO ROOF DETAIL
SCALE: 1-1/2"=1'-0"

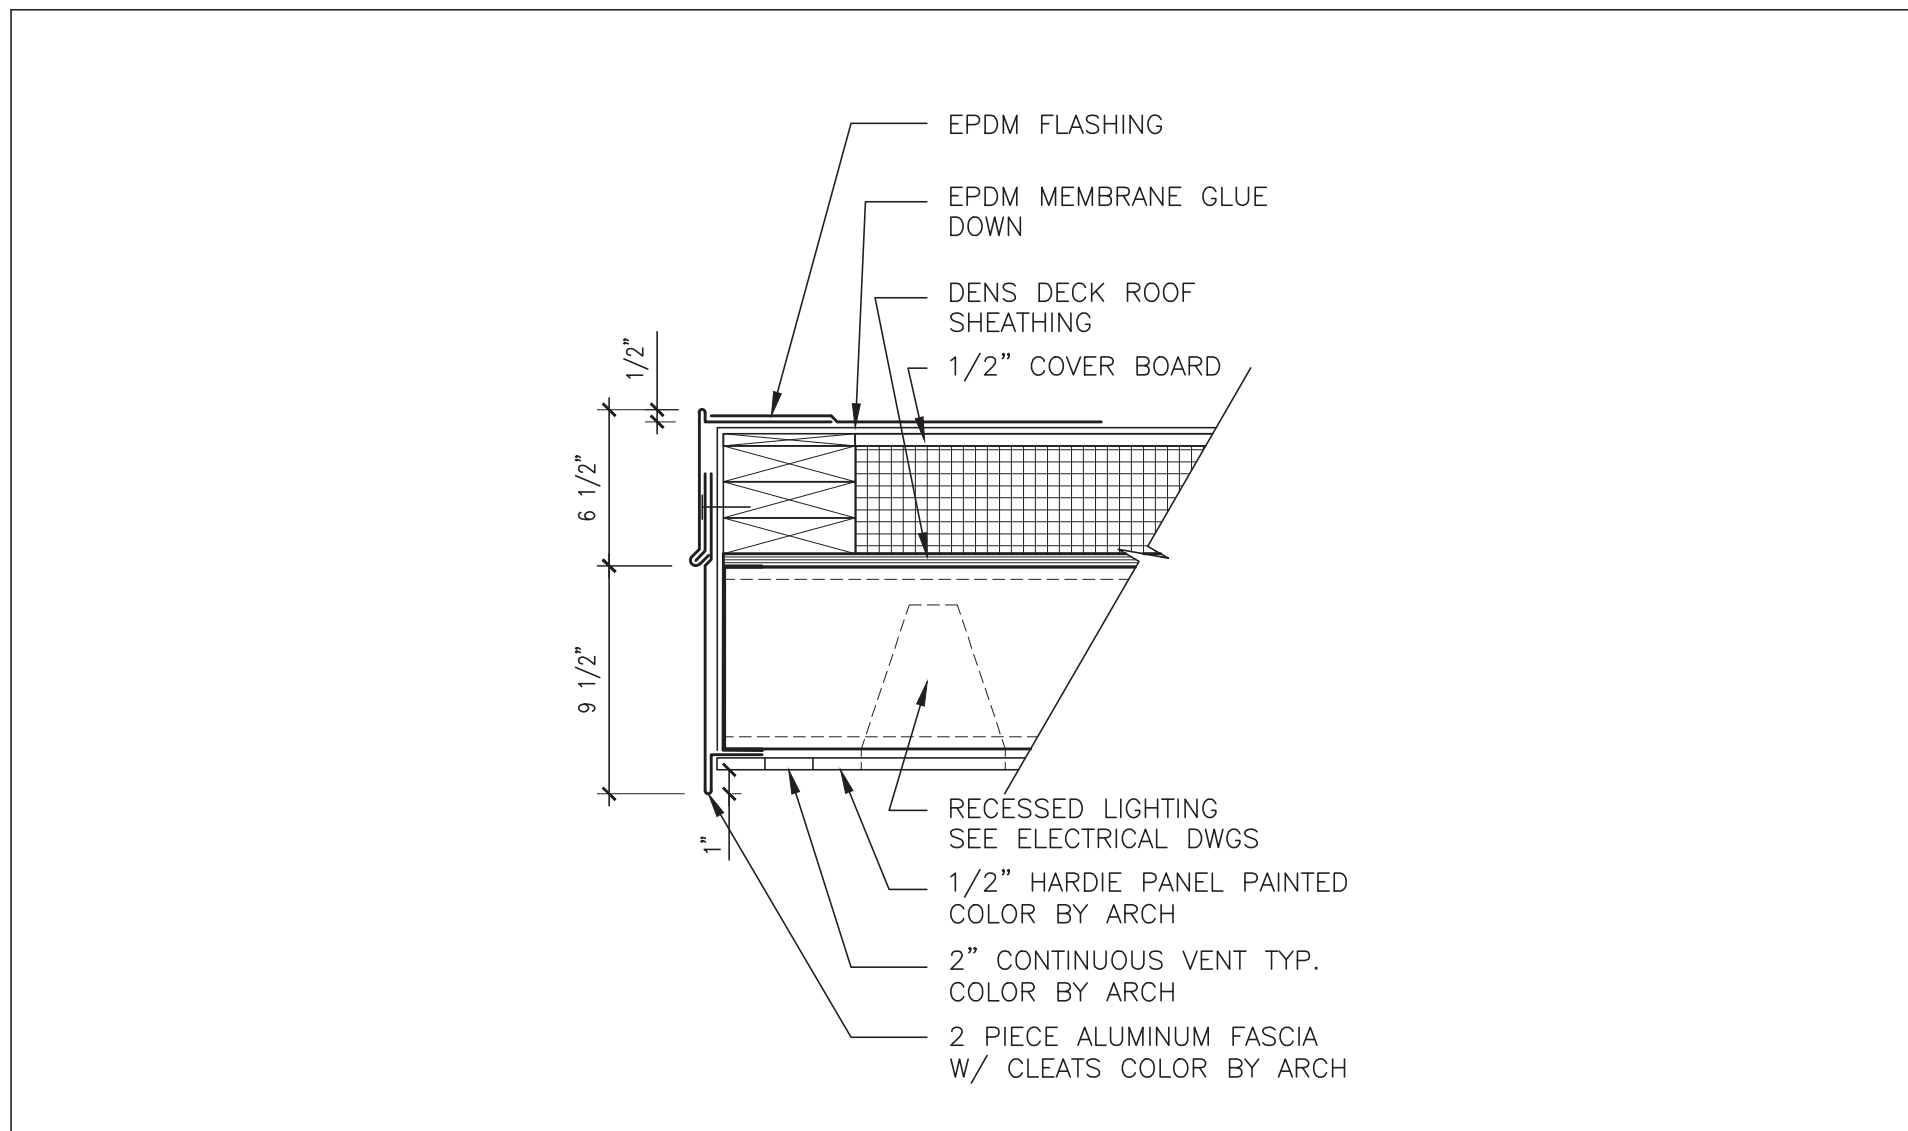


6 SECOND FLOOR FASCIA DETAIL
SCALE: 1-1/2"=1'-0"

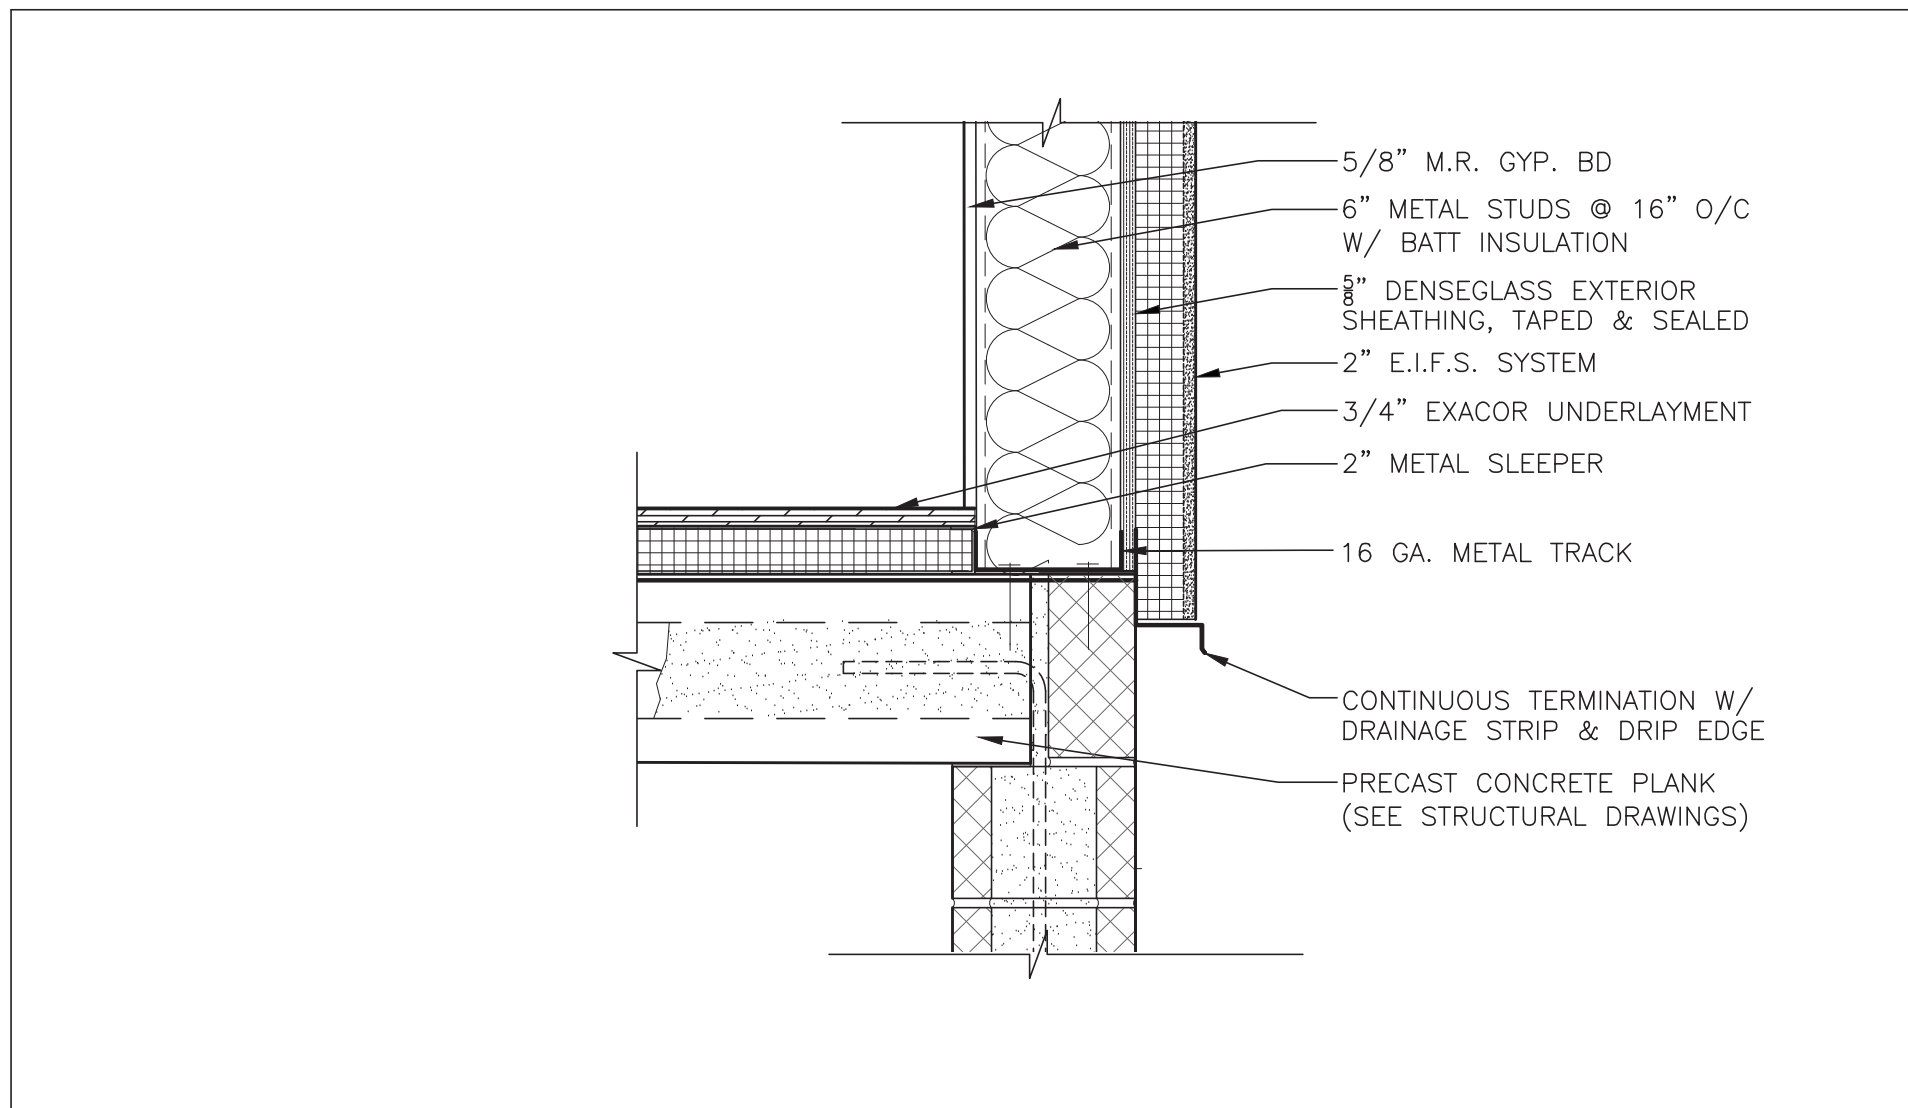


5 PRESS BOX BASE DETAIL @ BLEACHER SIDE
SCALE: 1-1/2"=1'-0"

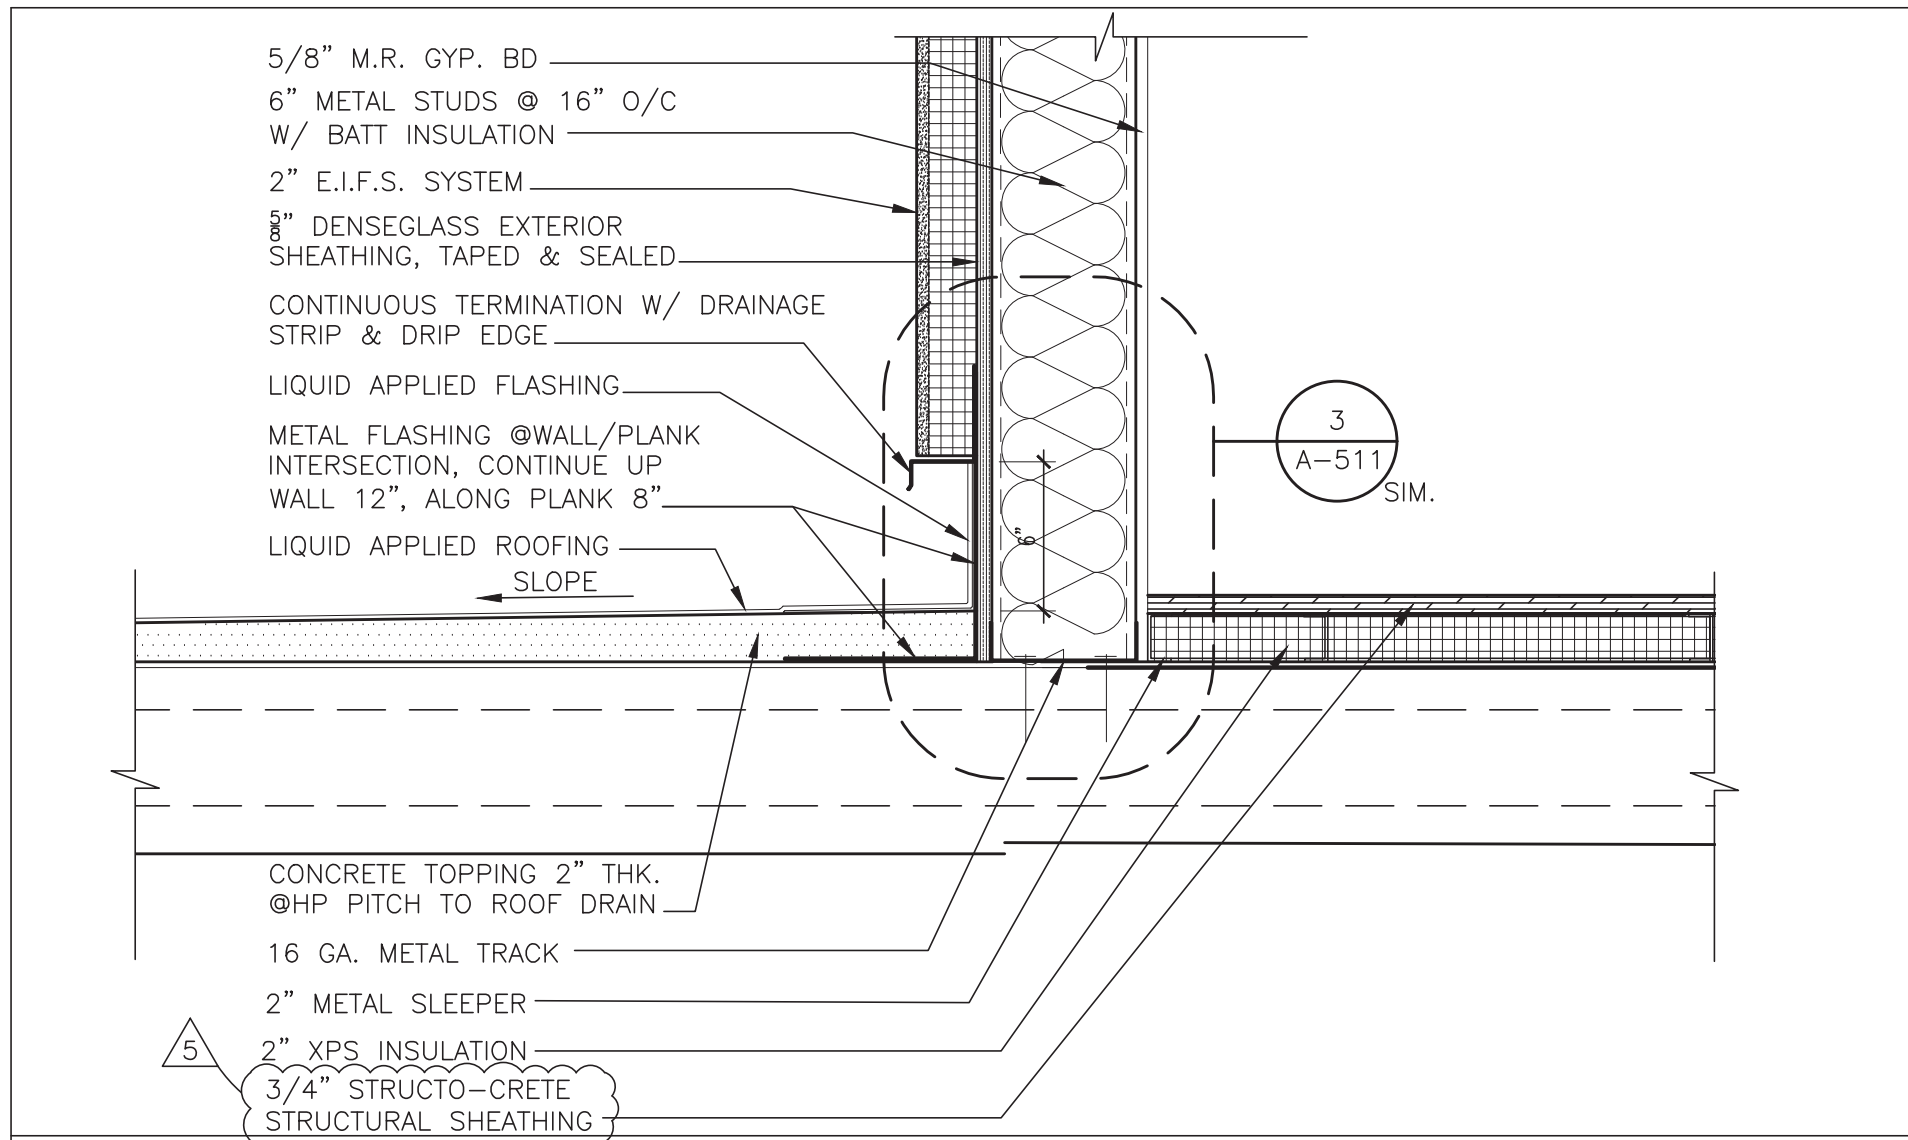


4 CURB DETAIL @ PRESS BOX PERIMETER (TYP.)
SCALE: 1-1/2"=1'-0"

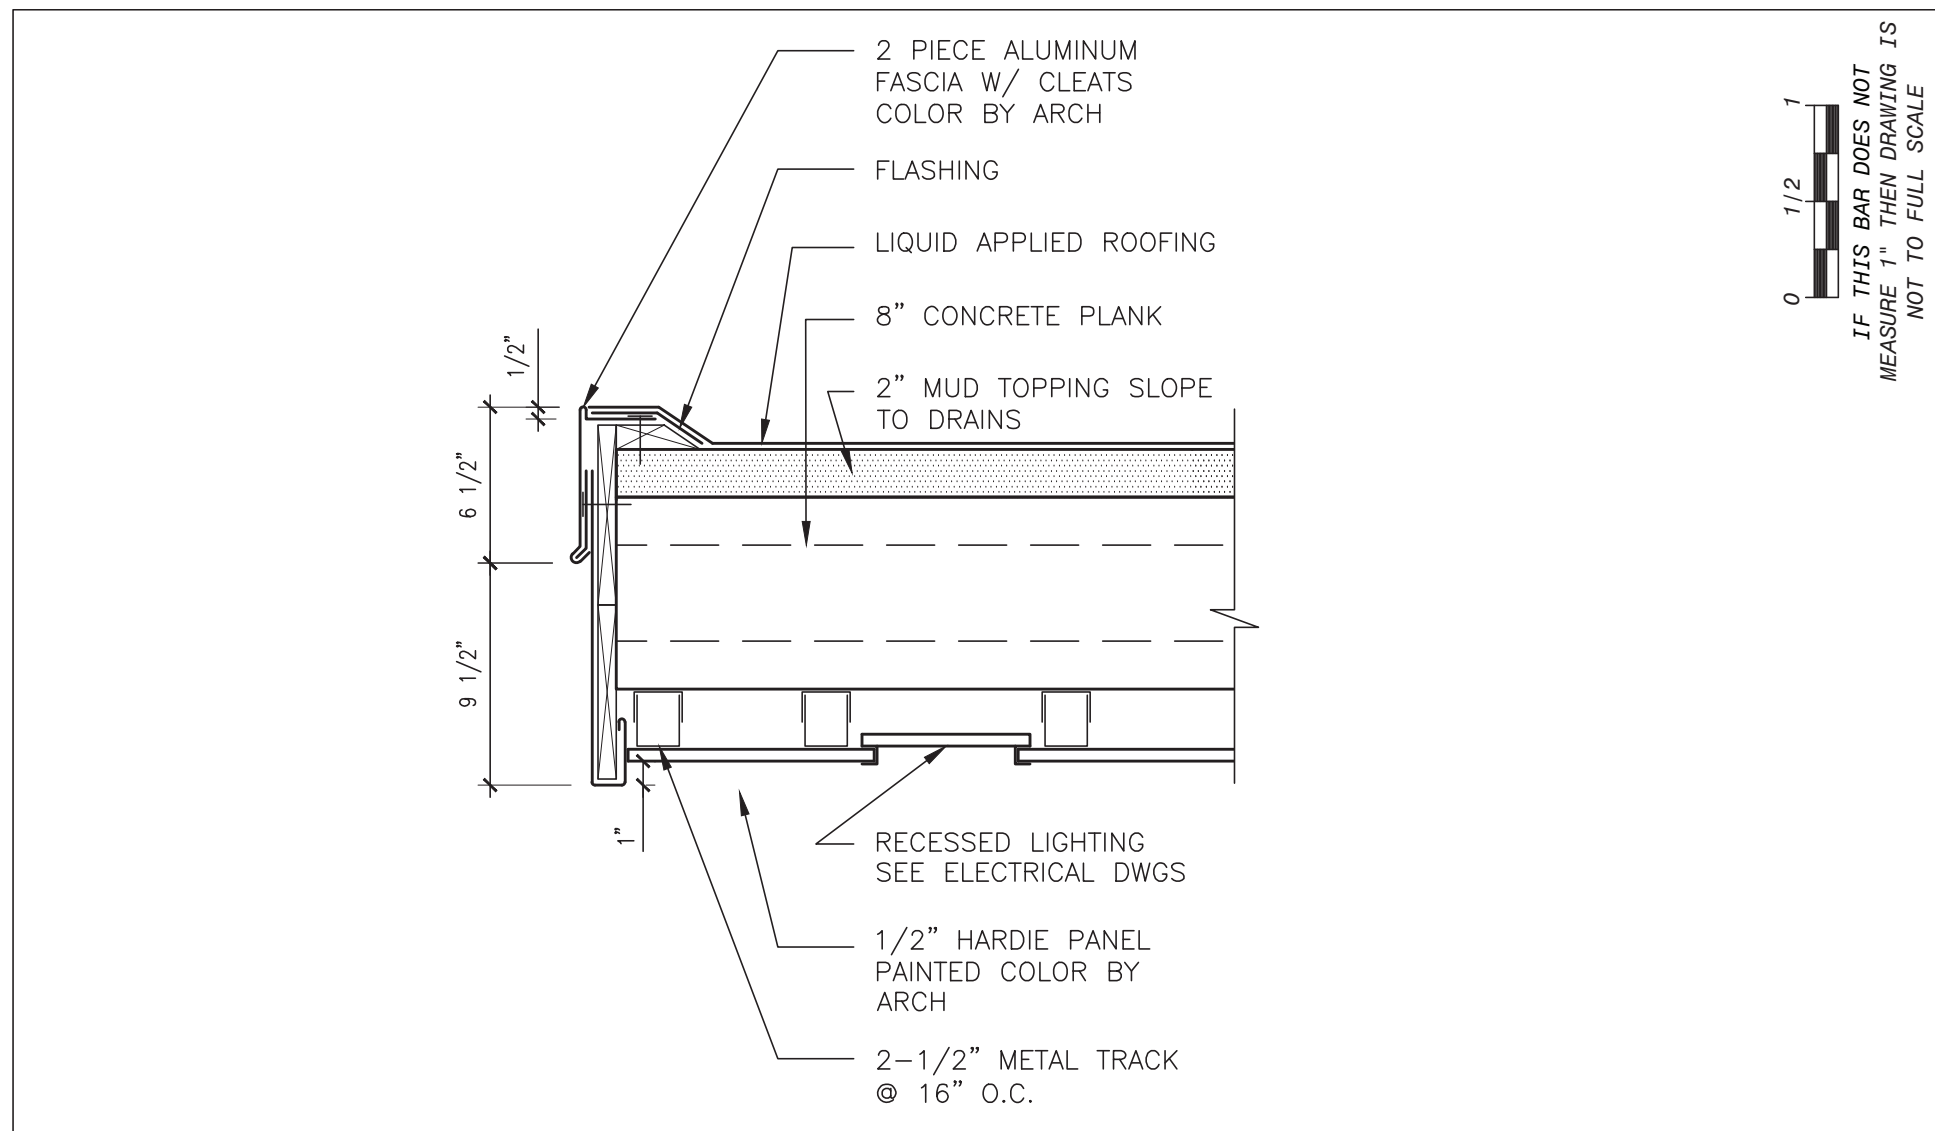


3 FIRST FLOOR FASCIA DETAIL
SCALE: 1-1/2"=1'-0"

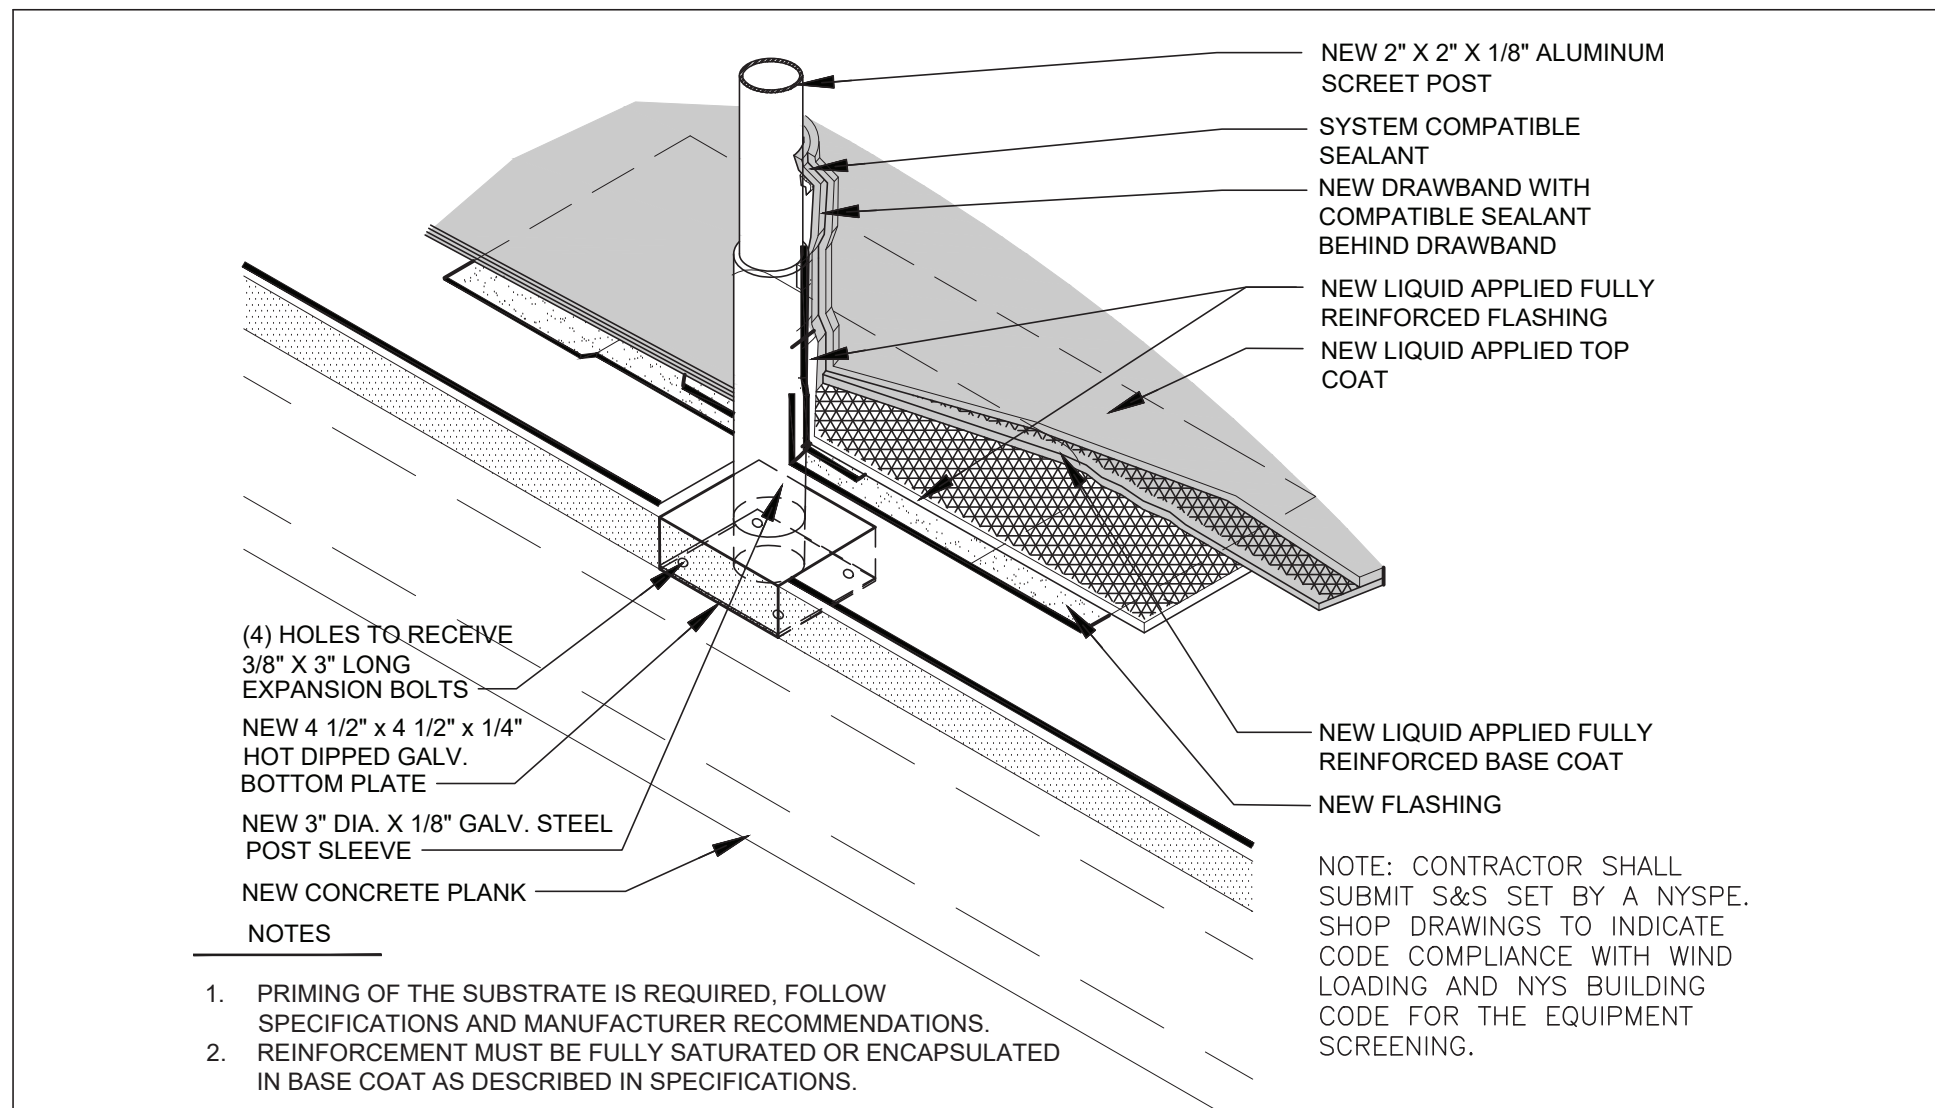

2 PARAPET RAILING DETAIL DETAIL
SCALE: N.T.S.

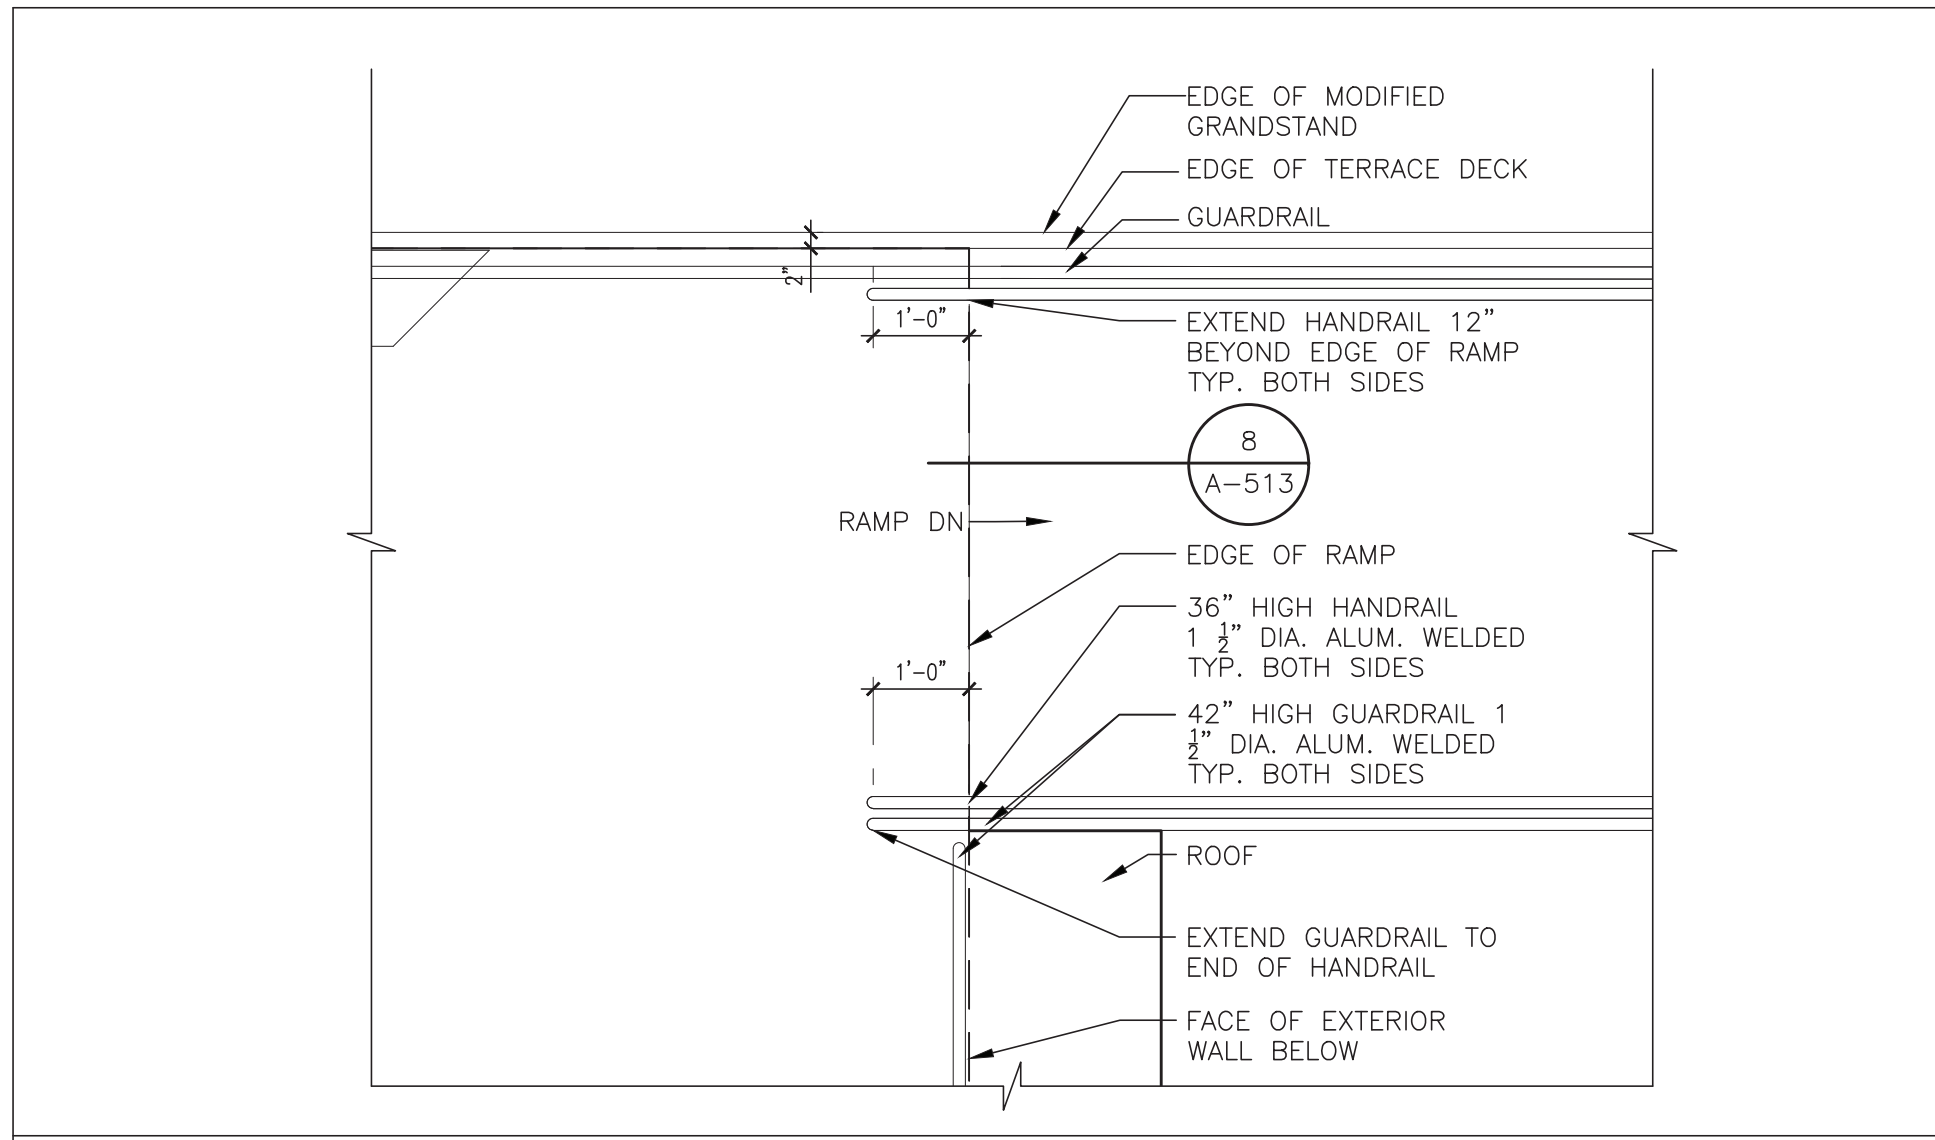


1 PLAN DETAIL @ RAMP
SCALE: 1/2"=1'-0"

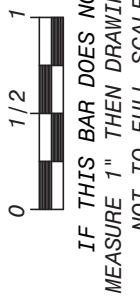

IF THIS BAR DOES NOT MEASURE 1', THEN DRAWING IS NOT TO FULL SCALE

No.	Date	Revisions
5	03-06-23	ADDENDUM 1
4	01-27-23	REVISIONS
3	01-12-23	SED ADDENDUM 2
1	10-28-22	BIDDING DOCUMENTS

 

Drawn by	CP
Checked by	MS/JC
Project No.	42051
Scale	AS NOTED
Date	08-30-22

Mechanical & Electrical Engineer:	GREENMAN PEDERSEN, INC 400 BELMONT PARKWAY MONTEBELLO, NY 10801
Structural Engineer:	---

NORTH ROCKLAND HIGH SCHOOL PROJECTS - PHASE 1	NOTE: CONTRACTOR SHALL SUBMIT S&S SET BY A NYSPE. SHOP DRAWINGS TO INDICATE CODE COMPLIANCE WITH WIND LOADING AND NYS BUILDING CODE FOR THE EQUIPMENT SCREENING.
HIGH SCHOOL: SED# 90-02-01-06-0-006-005 PRESS BOX (RAMP): SED# 90-02-01-06-0-007-001 CONCRESSIONS/ PRESS BOX DETAILS: SED# 90-02-01-06-0-008-001	TOWN OF JAVESSTAM COUNTY OF ROCKLAND 109 Ramapo Rd. Thiells, NY 10984

HSA	MICHAEL SHILALE ARCHITECTS, L.L.P. 140 Park Avenue New City, NY 10868 Tel 914-578-9200 www.shilale.com
------------	--

CONCRESSIONS/ PRESS BOX DETAILS	Drawing No. A-513
---------------------------------	--------------------------

© COPYRIGHT, MICHAEL SHILALE ARCHITECTS, ALL RIGHTS RESERVED. IT IS A VIOLATION OF THE LAW FOR ANY PERSON, UNLESS ACTING UNDER THE DIRECTION OF A LICENSED ARCHITECT, TO ALTER AN ITEM IN ANY WAY.