




CEILING LEGEND

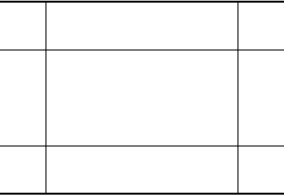


ACOUSTICAL CEILING TILE, TYPE 1

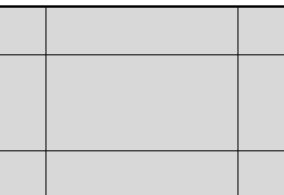

ACOUSTICAL CEILING TILE, TYPE 2

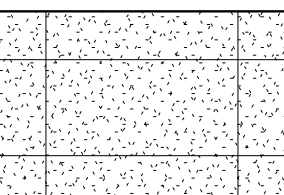


ACOUSTICAL CEILING TILE, TYPE 3

 

2' X 4' LIGHTING FIXTURE



 4' SUSPENDED STRIPLINE FIXTURE



LED LINEAR HIGH BAY LENSED



HIGH LUMEN LED PENDANT



LINEAR DIFFUSER



SUPPLY DIFFUSER




RETURN DIFFUSER



EXHAUST DIFFUSER



RECESSED DOWNLIGHT

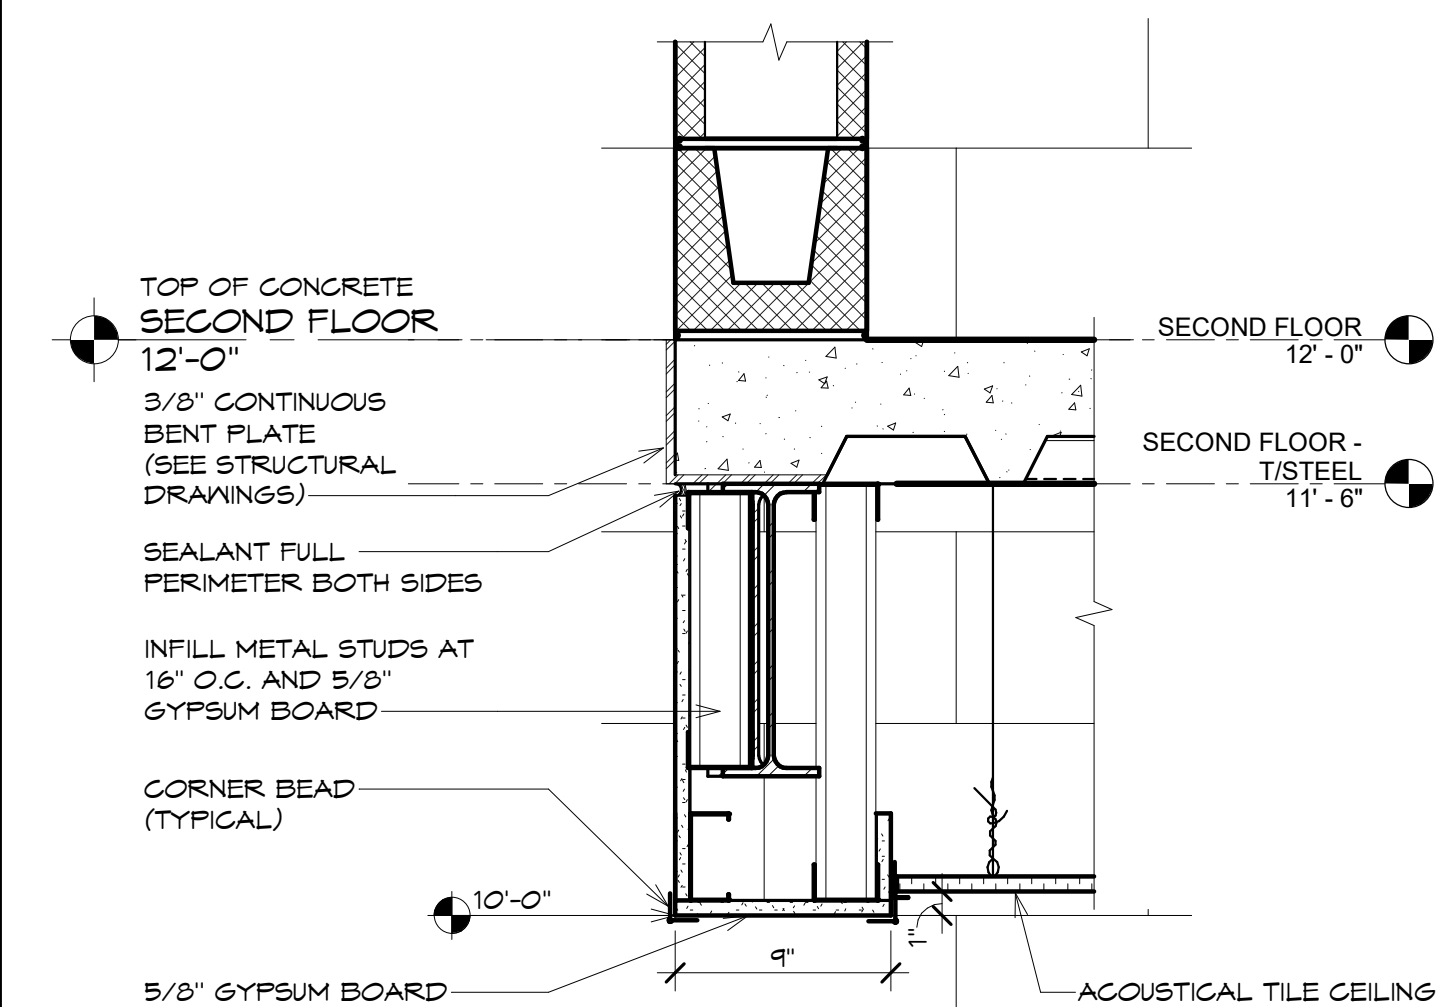

2  
A400  
1 1/2" = 1'-0"  
SOFFIT AT STAIRS

BID PLANS

DATE: 6/9/2023  
DRAWN BY: Author  
SCALE: As Indicated  
REVIEWED BY: Approver  
PROJECT NO.: 21-2343  
FILE:



KEYSTONE ASSOCIATES  
ARCHITECTS, PLANNERS AND ENGINEERS  
WWW.KEYSTONE-PA.COM




DELAWARE D.P.C. ENGINEERING  
CONSULTING AND ENGINEERING  
WWW.DELAWAREENGINEERING.COM

REVISIONS  
DESCRIPTION  
NO. DATE

PORT EVEN FIRE DEPARTMENT,  
ULSTER, NEW YORK

FIRST FLOOR REFLECTED CEILING PLAN  
AND DETAILS

SHEET:  
A400

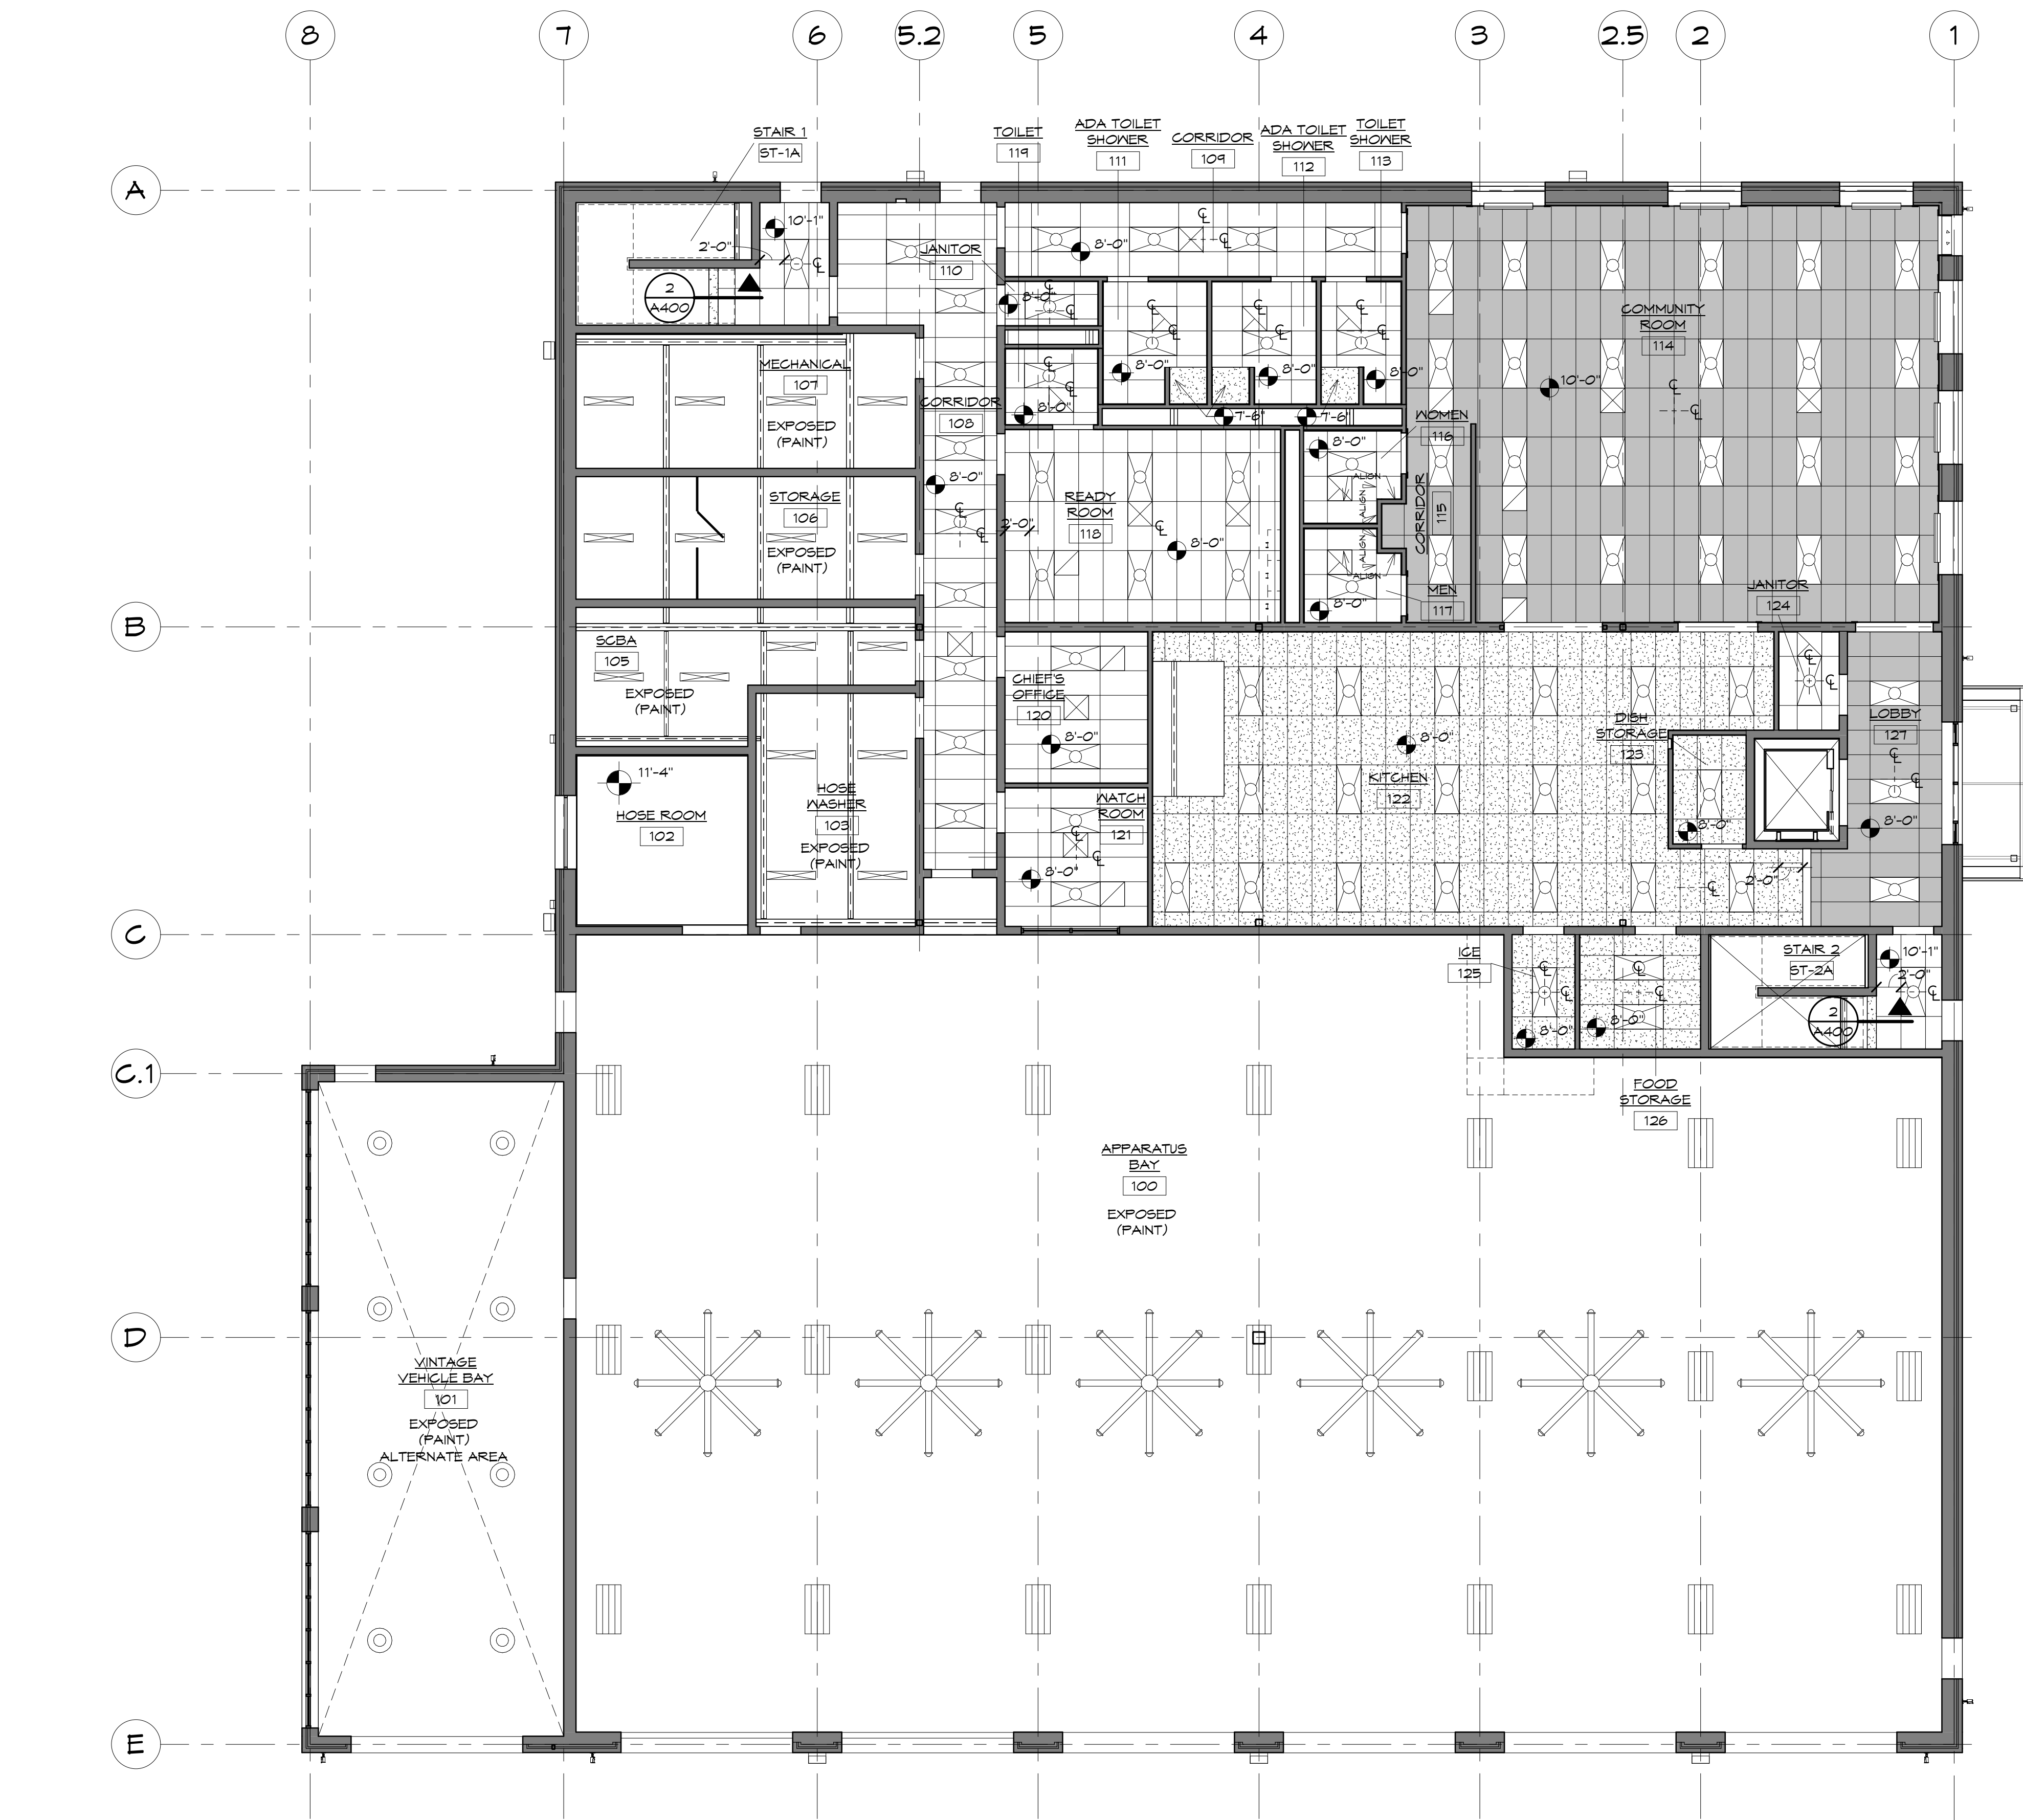

1  
A400  
1/8" = 1'-0"  
REFLECTED CEILING PLAN  
FIRST FLOOR  
PLAN NORTH

WARNING: IT IS A VIOLATION OF NEW YORK EDUCATION LAW SECTION 7209.2, FOR ANY PERSON, UNLESS HE IS ACTING UNDER THE DIRECTION OF A LICENSED PROFESSIONAL ENGINEER OR A SUPERVISOR, TO ALTER THIS DOCUMENT IN ANY WAY. IF ALTERED THE ALTERED PERSON SHALL COME WITH THE REQUIREMENTS OF NEW YORK EDUCATION LAW, SECTION 7209.2.