


H:\Drawings\Port Ewen\Civil site work\KC-106_SIGHT LIGHTING PLAN.dwg

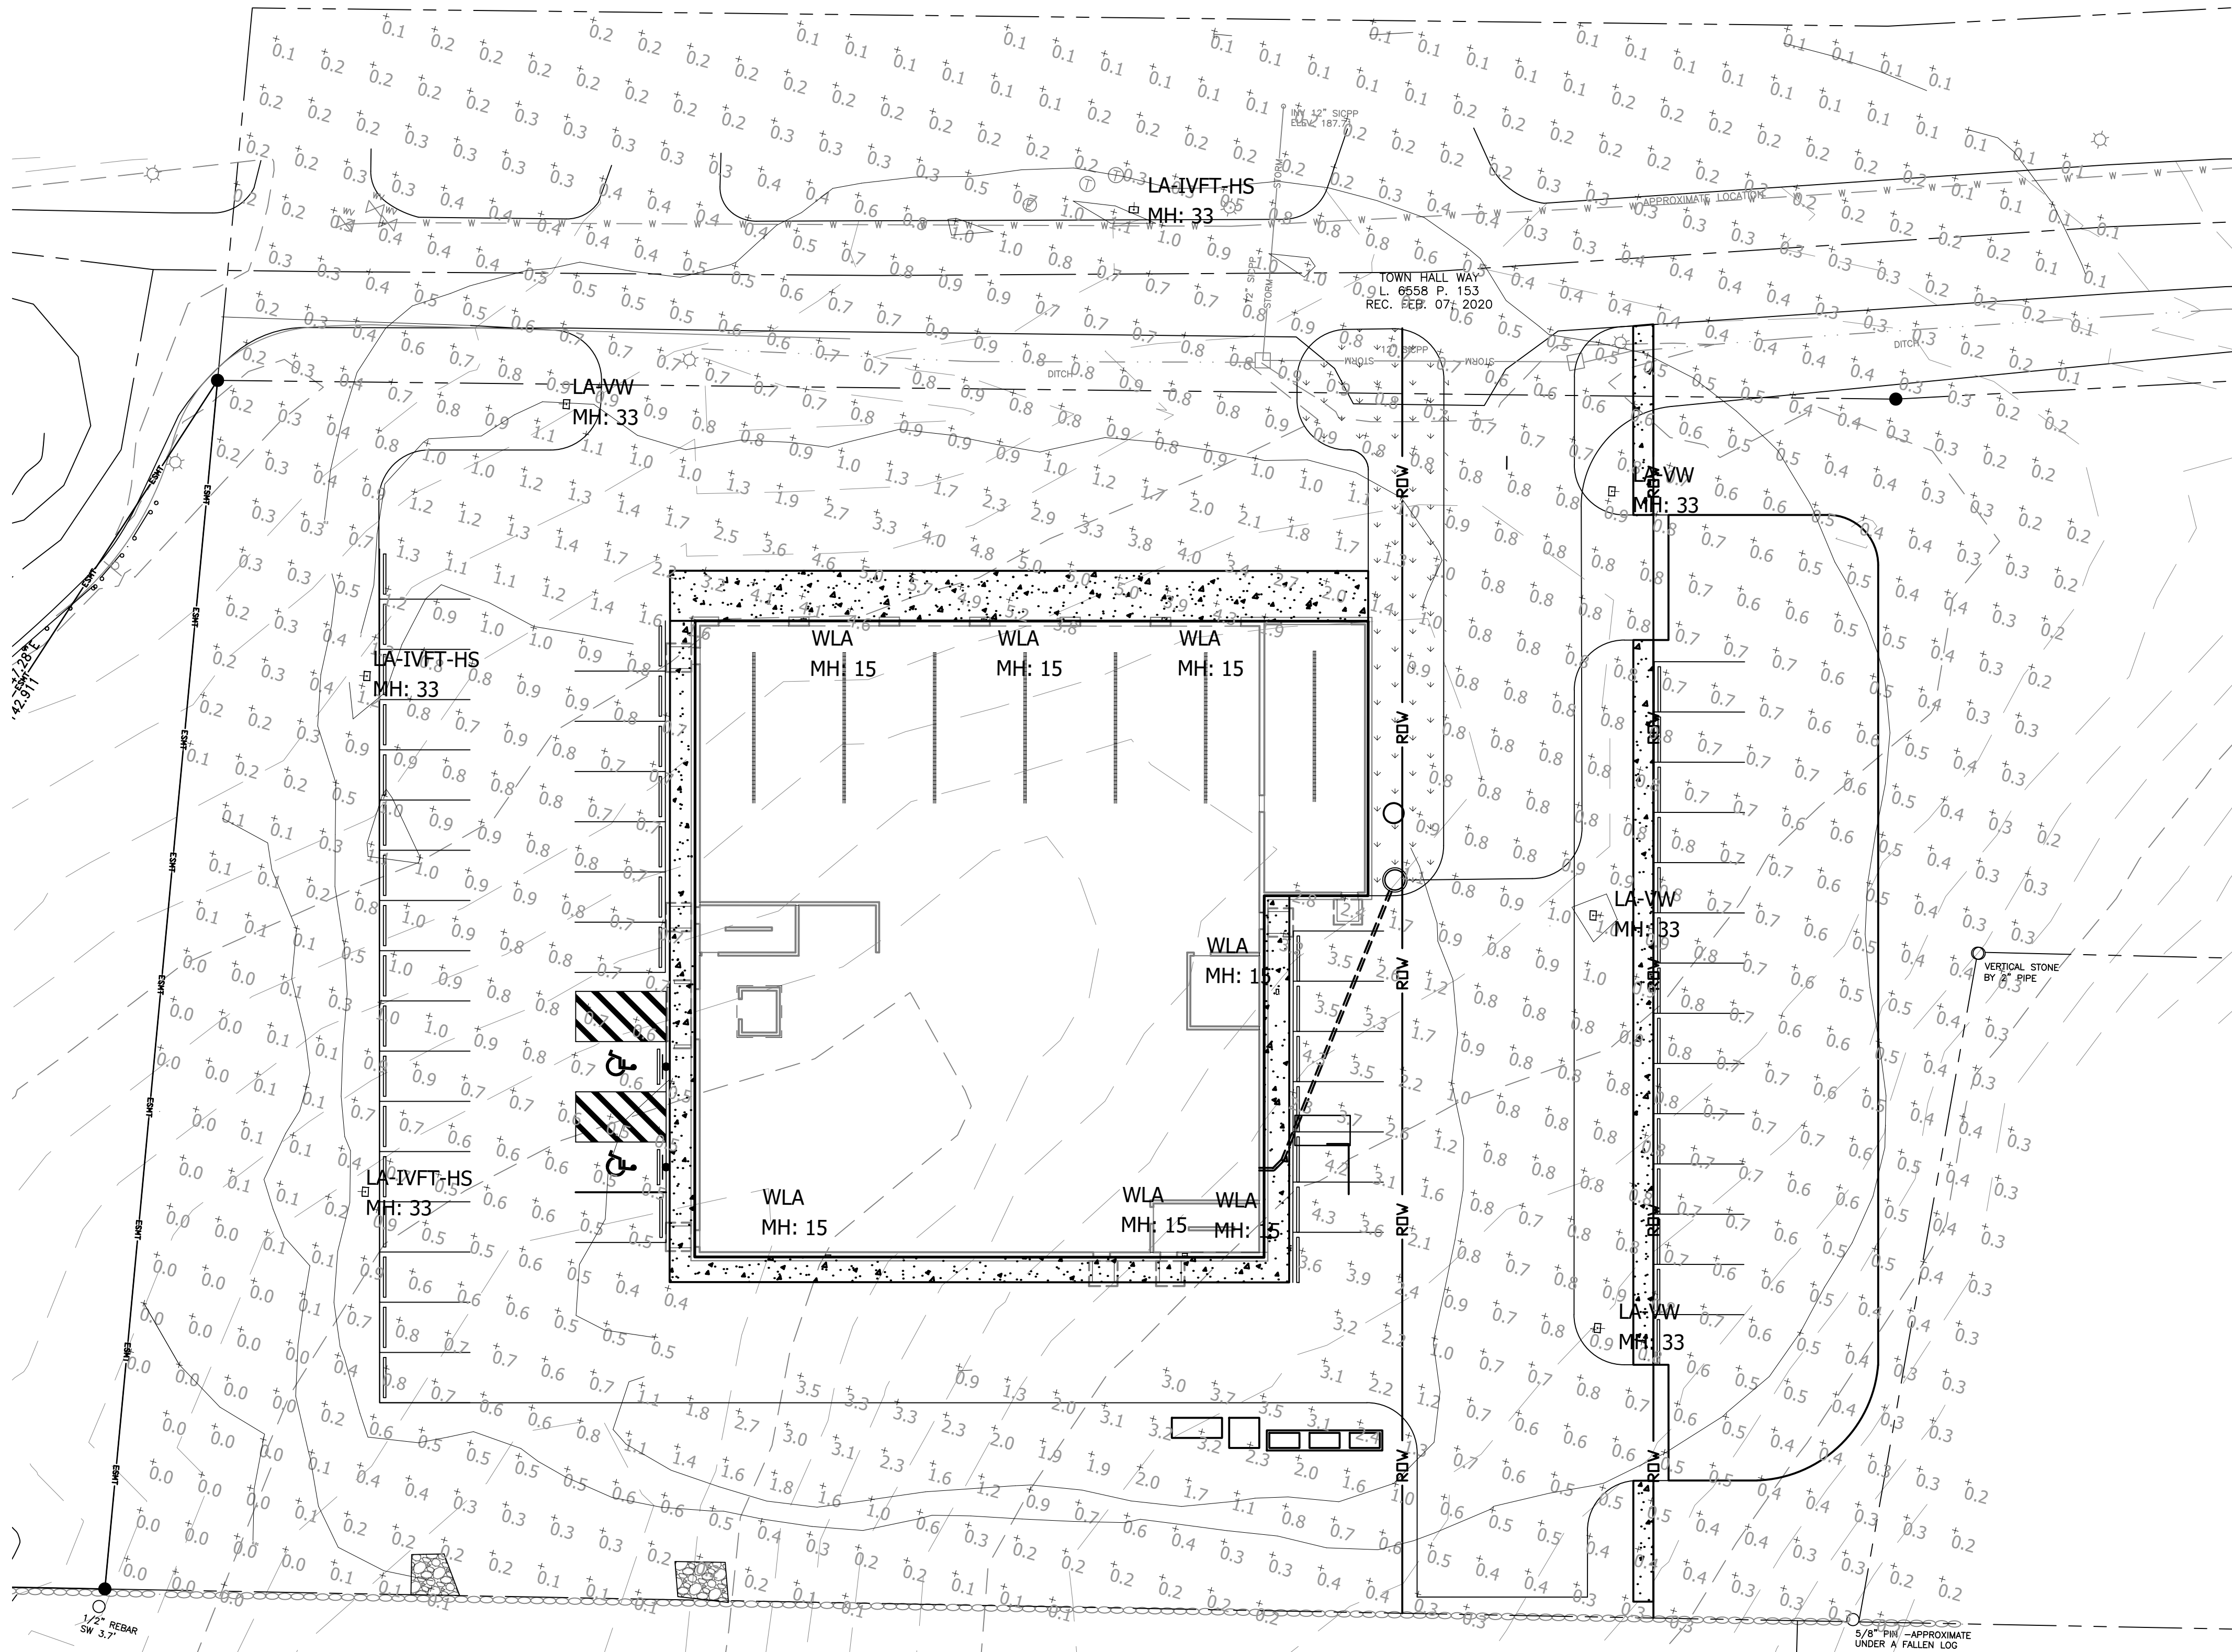

Isoline Legend	
Illuminance (Fc)	
Color	Value
	0.01
	0.1
	0.5
	1

Calculation Summary							
Label	CalcType	Units	Avg	Max	Min	Avg/Min	Max/Min
CalcPts_1	Illuminance	Fc	0.77	5.7	0.0	N.A.	N.A.

Luminaire Schedule												
Symbol	Qty	Label	Arrangement	Lum. Lumens	Lum. Watts	Arr. Watts	Total Watts	LLD	LDD	BF	LLF	BUG Rating
	4	LA-VW	SINGLE	10907	82	82	328	0.950	0.950	1.000	0.903	B4-U0-G2
	3	LA-IVFT-HS	SINGLE	7504	82	82	246	0.950	0.950	1.000	0.903	B1-U0-G2
	7	WLA	SINGLE	4894	59	59	413	0.950	0.950	1.000	0.903	B0-U0-G1
												Description
												GALN-SA2B-730-U-5WQ
												GALN-SA2B-730-U-T4FT-HSS
												GWC-SA1C-730-U-T2-HSS

WARNING: IT IS A VIOLATION OF NEW YORK EDUCATION LAW SECTION 7202.2, FOR ANY PERSON, UNLESS HE IS ACTING UNDER THE DIRECTION OF A LICENSED PROFESSIONAL ENGINEER OR LAND SURVEYOR, TO ALTER THIS DOCUMENT IN ANY WAY. IF ALTERED THE ALTERING PERSON SHALL COMPLY WITH THE REQUIREMENTS OF NEW YORK EDUCATION LAW, SECTION 7202.2.

BID PLANS

SIGHT LIGHTING PLAN

PORT EWEN FIRE
DEPARTMENT
ULSTER COUNTY, NY

REVISIONS

NO.	DATE	DESCRIPTION



DATE:	DRAWN BY:	SCALE:	REVIEWED BY:	PROJECT NO.:	FILE:
02/02/2023	ERNSTJ	AS SHOWN	AS SHOWN	21-0343	C-106_SIGHT LIGHTING PLAN.dwg

SHEET:

C-106