



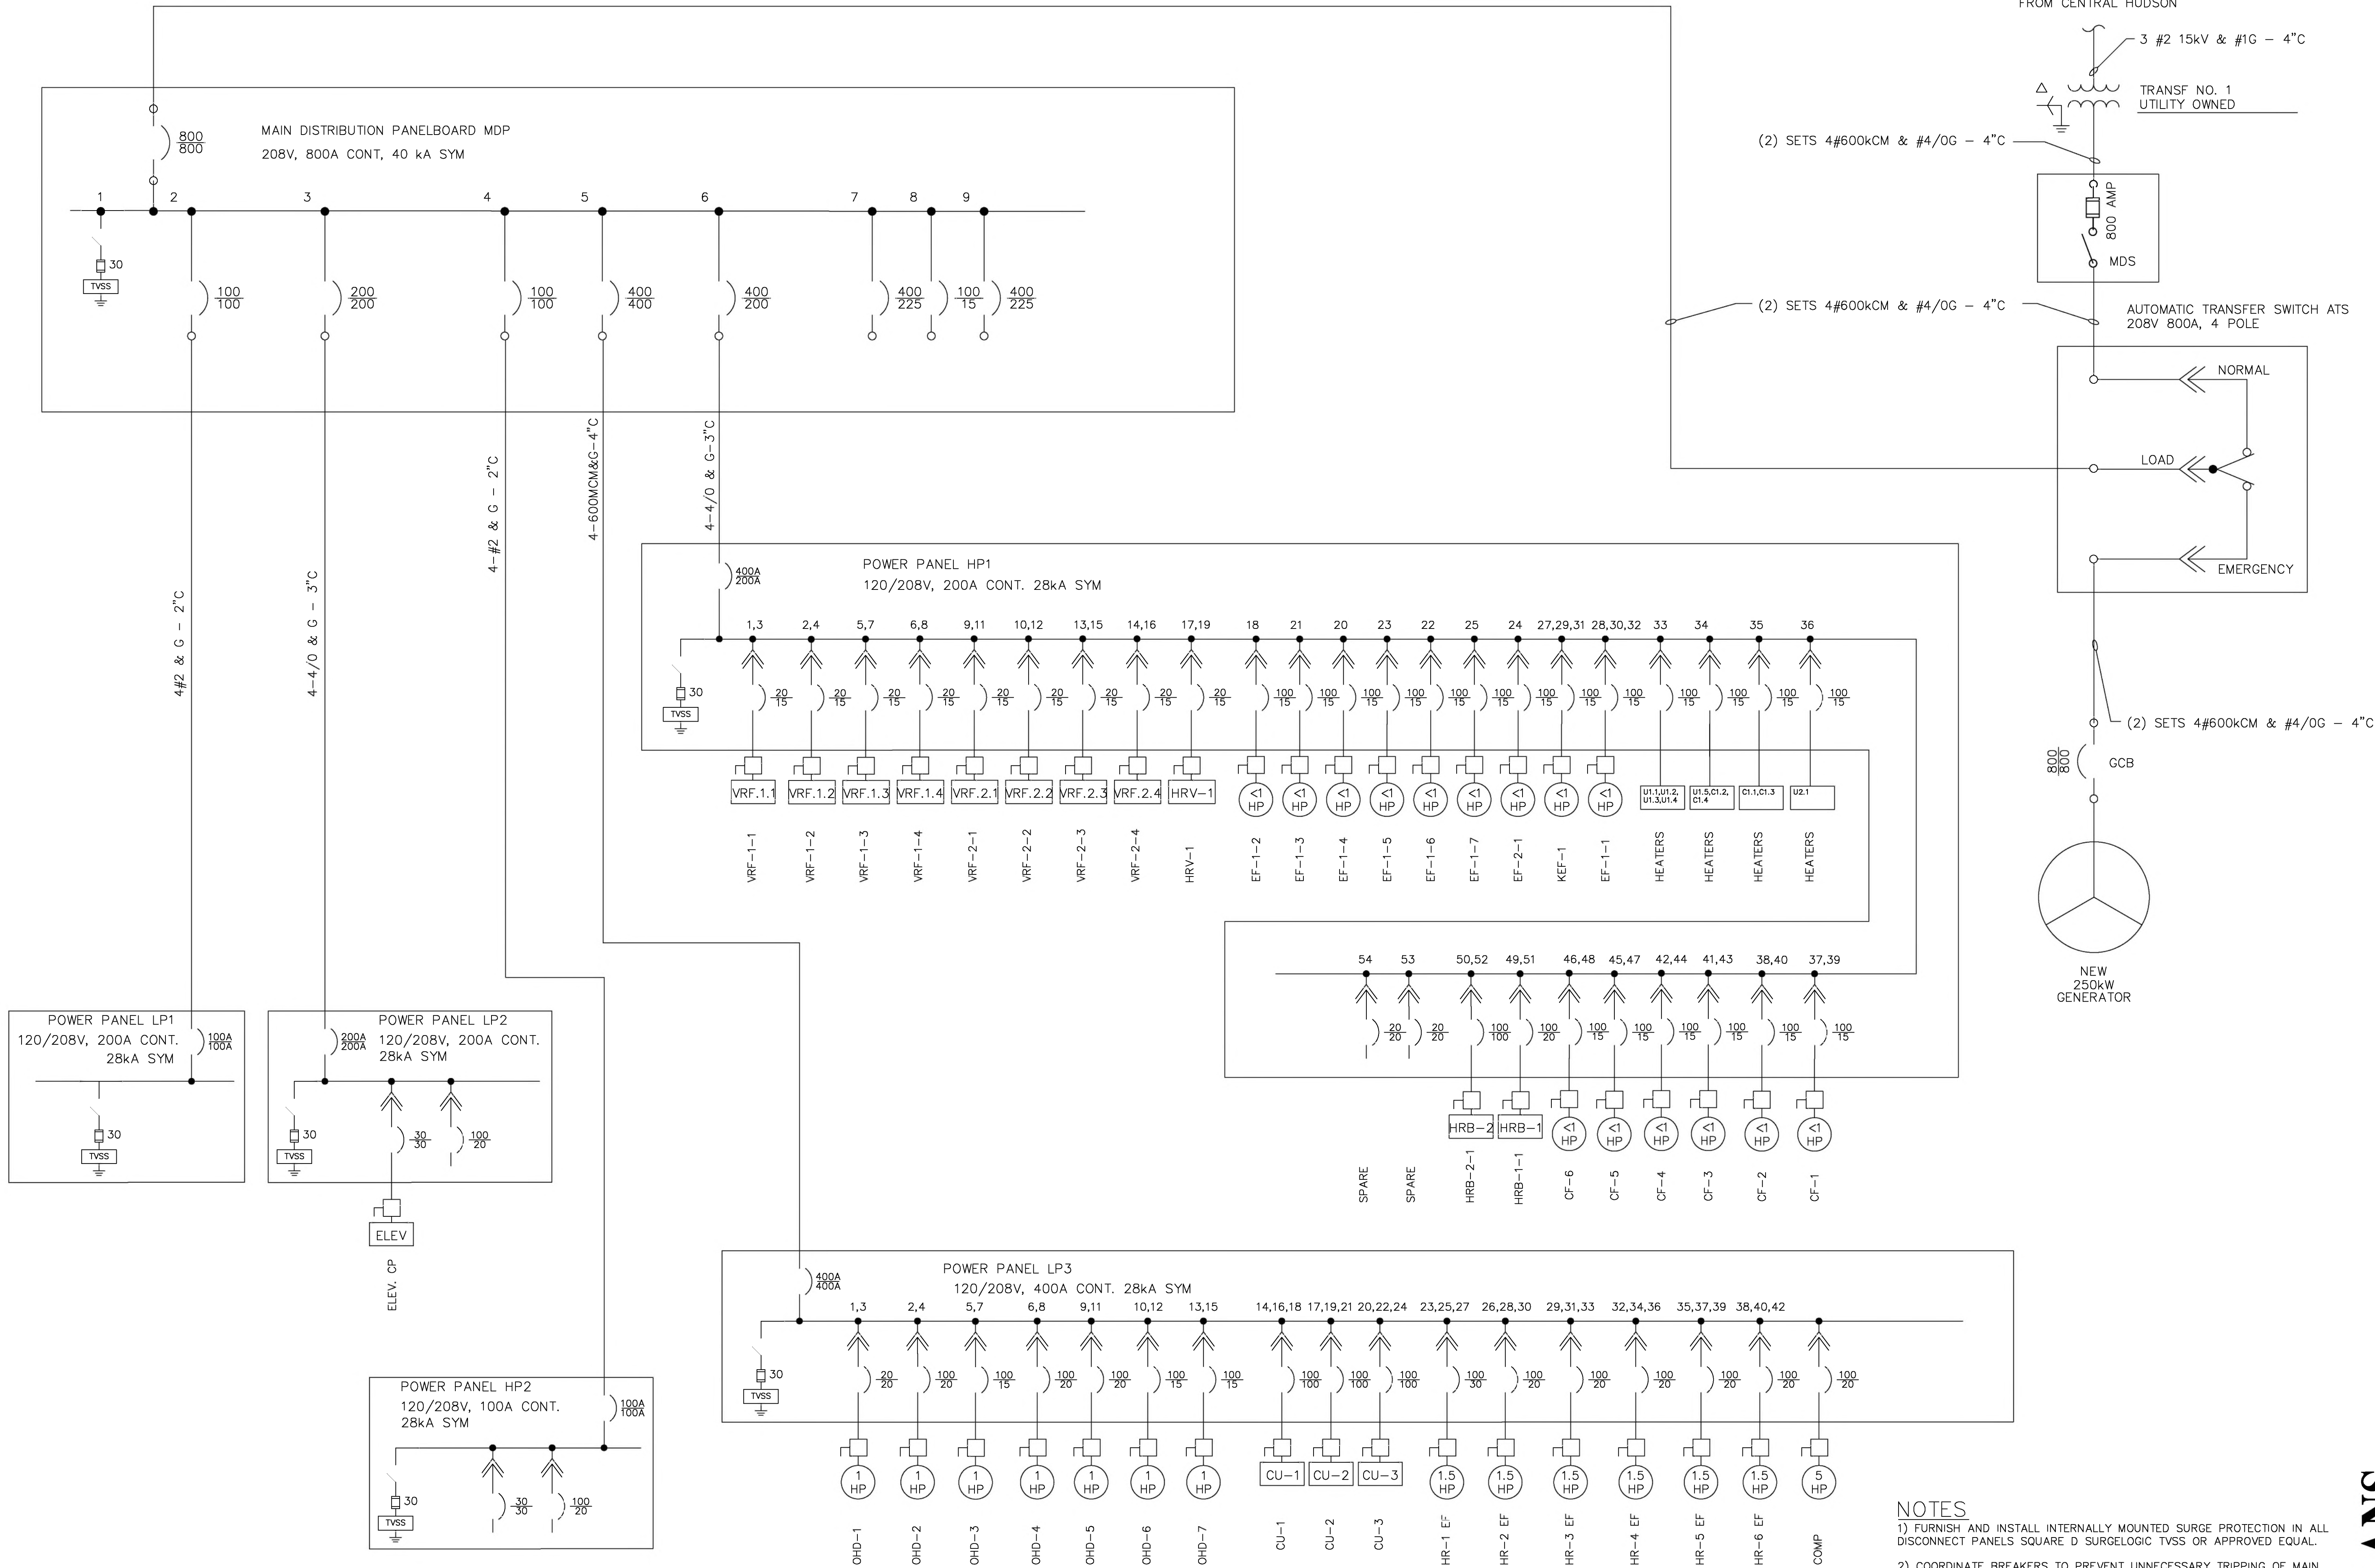

DATE:	6/16/23
DRAWN BY:	AFA
SCALE:	AS SHOWN
REVIEWED BY:	RF
PROJECT NO.:	21243
FILE:	

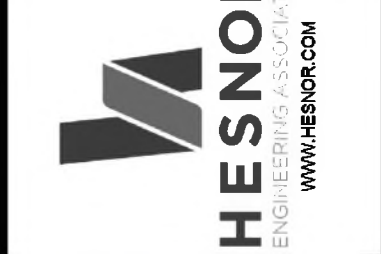

NO.	REVISIONS	
	DATE	DESCRIPTION
1	6/16/23	CONSTRUCTION

PORT EWEN FIRE
DEPARTMENT
ULSTER COUNTY, NY

ONE LINE DIAGRAM

SHEET:
E002

BID PLANS

