


H:\Drawings\Port Ewen\PE_LIGHTING_FIRST_FLOOR 6.7.23.dwg

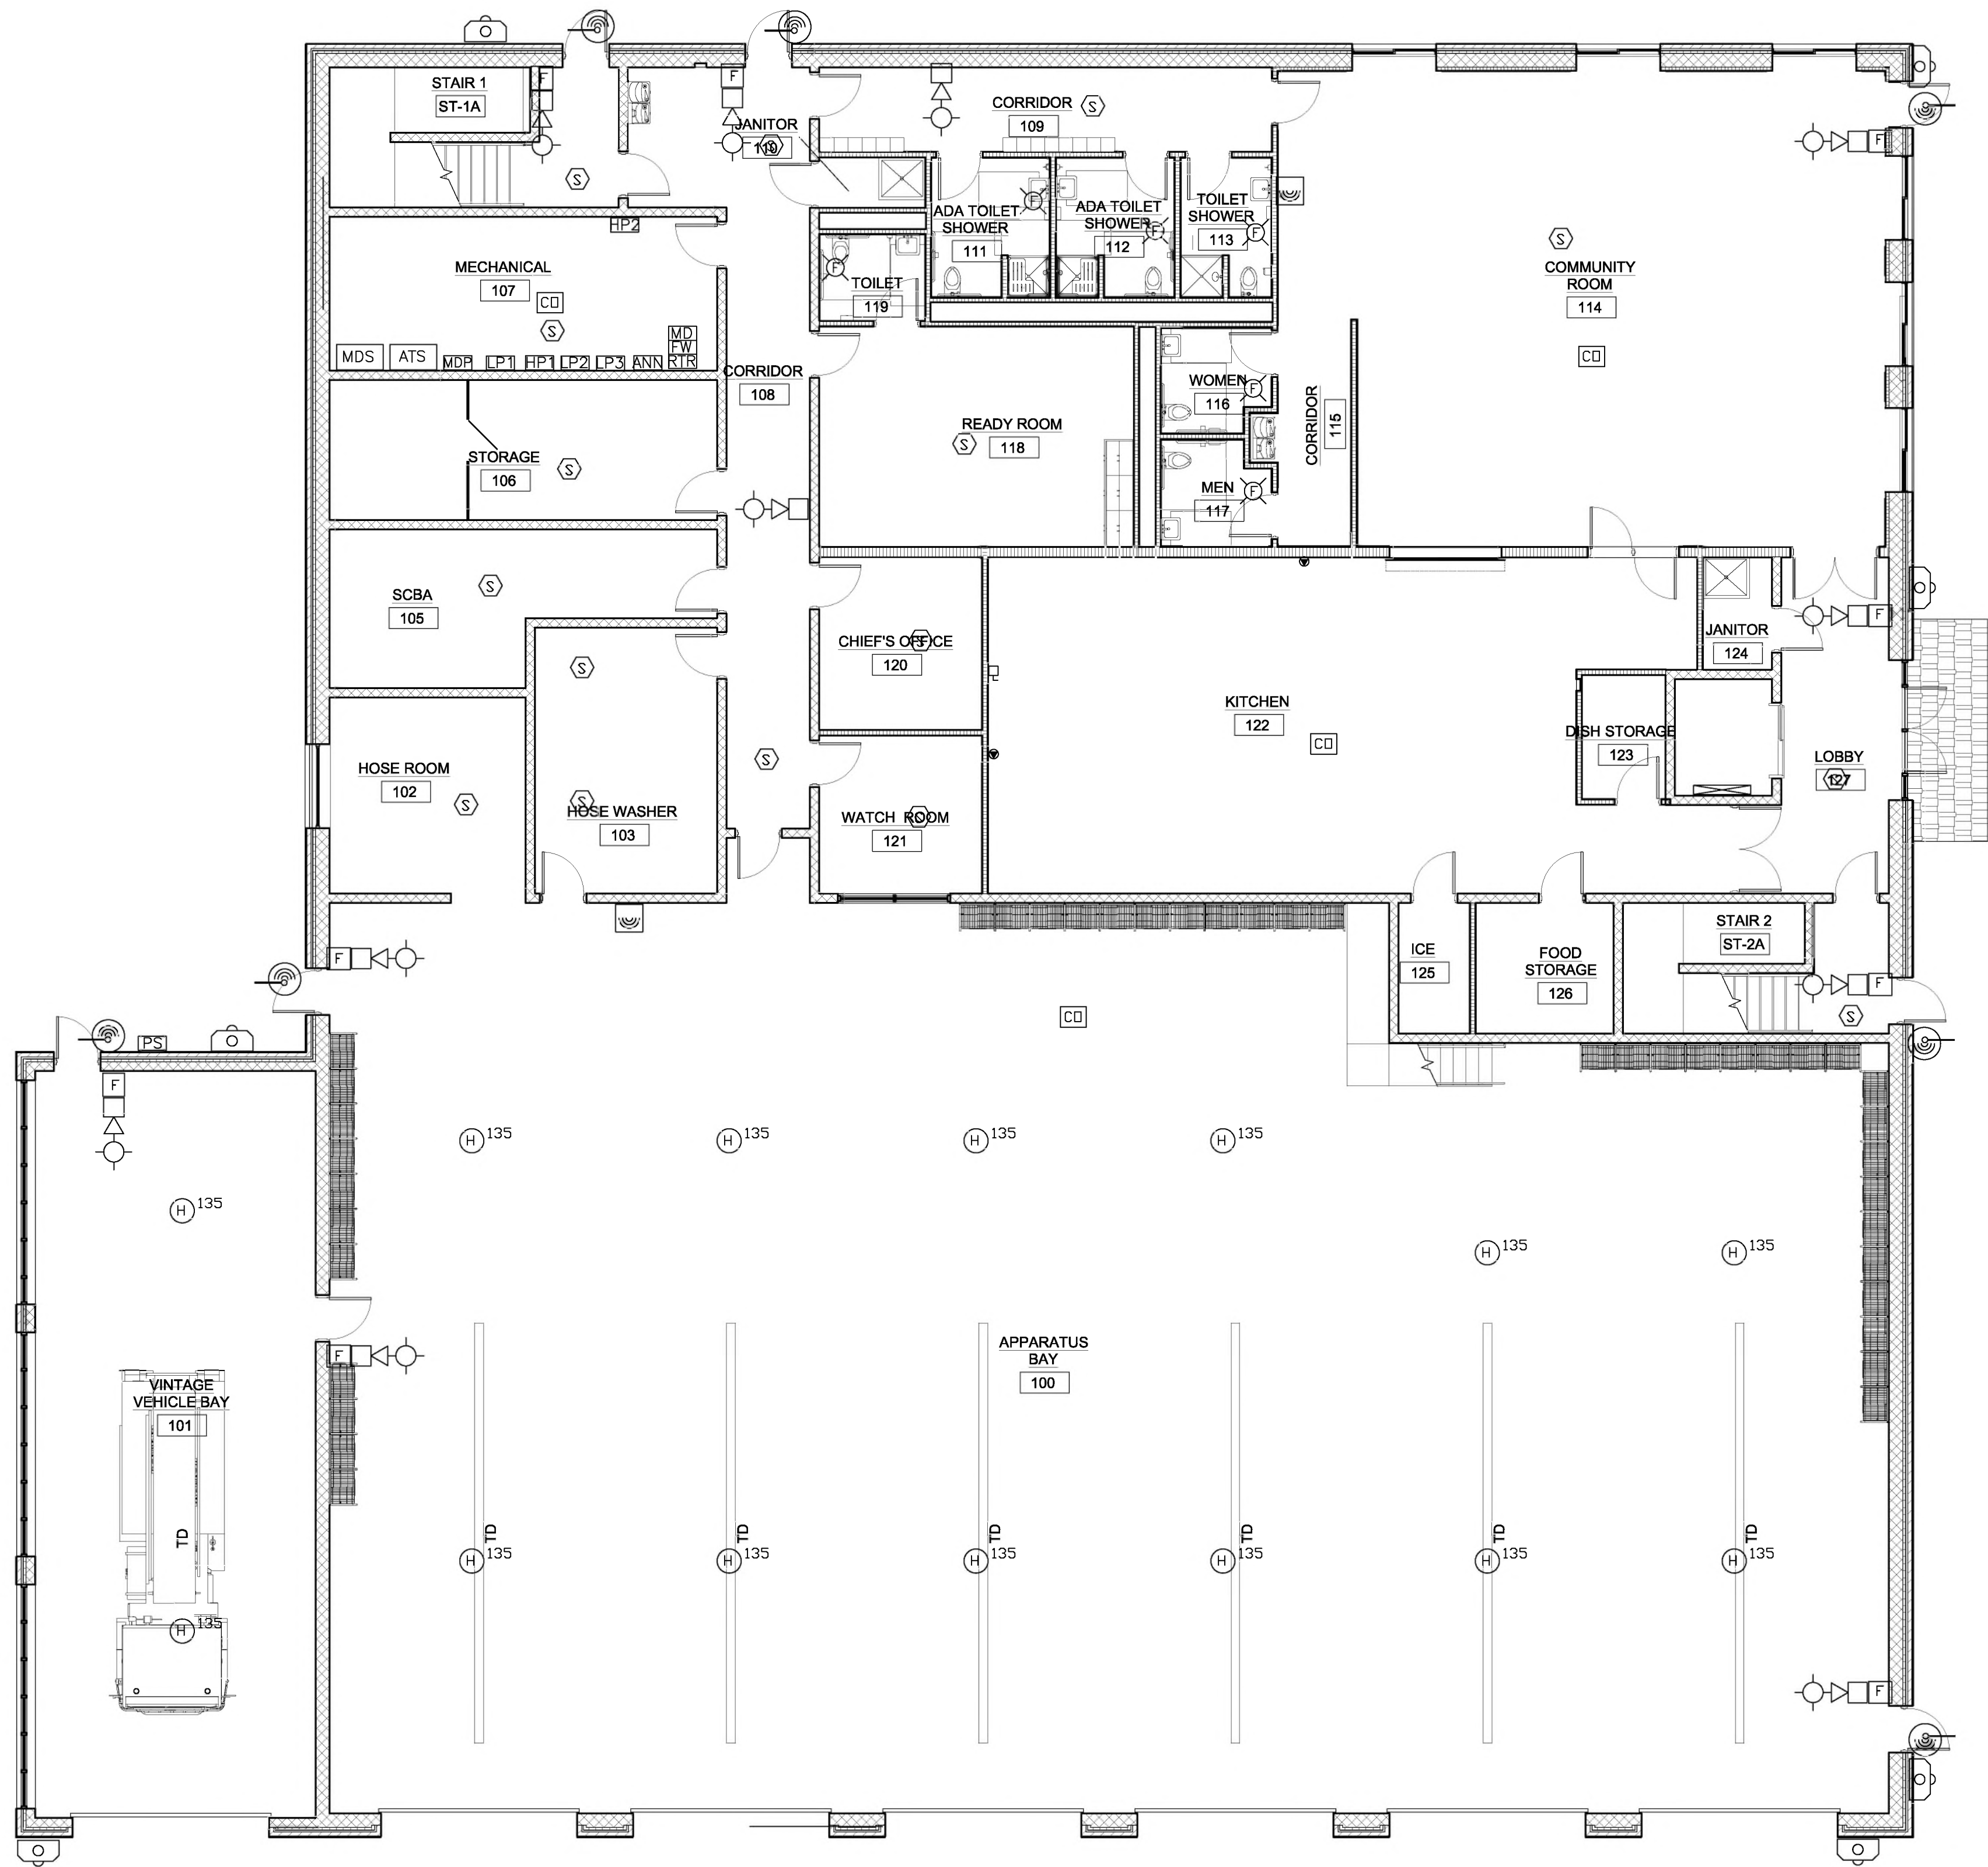

FIRST FLOOR ALARM PLAN
1/8" = 1'-0"

- STROBE LIGHT WITH HORN
- STROBE LIGHT
- PULL STATION WITH KEY RESET
- SMOKE DETECTOR PHOTO ELECTRIC
- HEAT DETECTOR X=135 FOR 135DEG RATE OF RISE AND X=190 FOR 190DEG RATE OF RISE
- SUPPRESSION SYSTEM SUPERVISION
- DOOR HOLDER WALL MOUNT
- ADDRESSABLE MINI MODULE
- EXPLOSION PROOF SMOKE DETECTOR
- EXPLOSION PROOF PULL STATION WITH KEY RESET
- EXTERIOR STROBE LIGHT WITH HORN
- ANNUNCIATOR
- CARBON MONOXIDE DETECTOR

NOTES
1) THE ELECTRICAL CONTRACTOR SHALL FURNISH AND INSTALL ALL COMPONENTS OF THE FIRE ALARM SYSTEM. THIS SHALL INCLUDE DEVICES, CONDUCTORS, CONTROLLERS, ETC..



BID PLANS

FIRST FLOOR ALARM
PLAN

PORT EWEN FIRE
DEPARTMENT
ULSTER COUNTY, NY

REVISIONS

NO.	DATE	DESCRIPTION
1	6/16/23	CONSTRUCTION



DELAWARE
ENGINEERING, D.P.C.
WWW.DELAWAREENGINEERING.COM

KEYSTONE
ASSOCIATES
WWW.KEYSTONEPC.COM

HESNOR
ENGINEERING ASSOCIATES
WWW.HESNOR.COM

DATE:	6/22/2023
DRAWN BY:	AA
SCALE:	AS SHOWN
REVIEWED BY:	AA
PROJECT NO.:	212543
FILE:	

WARNING: IT IS A VIOLATION OF NEW YORK EDUCATION LAW SECTION 7209.2, FOR ANY PERSON, UNLESS HE IS ACTING UNDER THE DIRECTION OF A LICENSED PROFESSIONAL ENGINEER OR LAND SURVEYOR, TO ALTER THIS DOCUMENT IN ANY WAY. IF ALTERED THE ALTERING PERSON SHALL COMPLY WITH THE REQUIREMENTS OF NEW YORK EDUCATION LAW, SECTION 7209.2.