


H:\Drawings\Port Ewen\PE_ELEC_KITCHEN.dwg

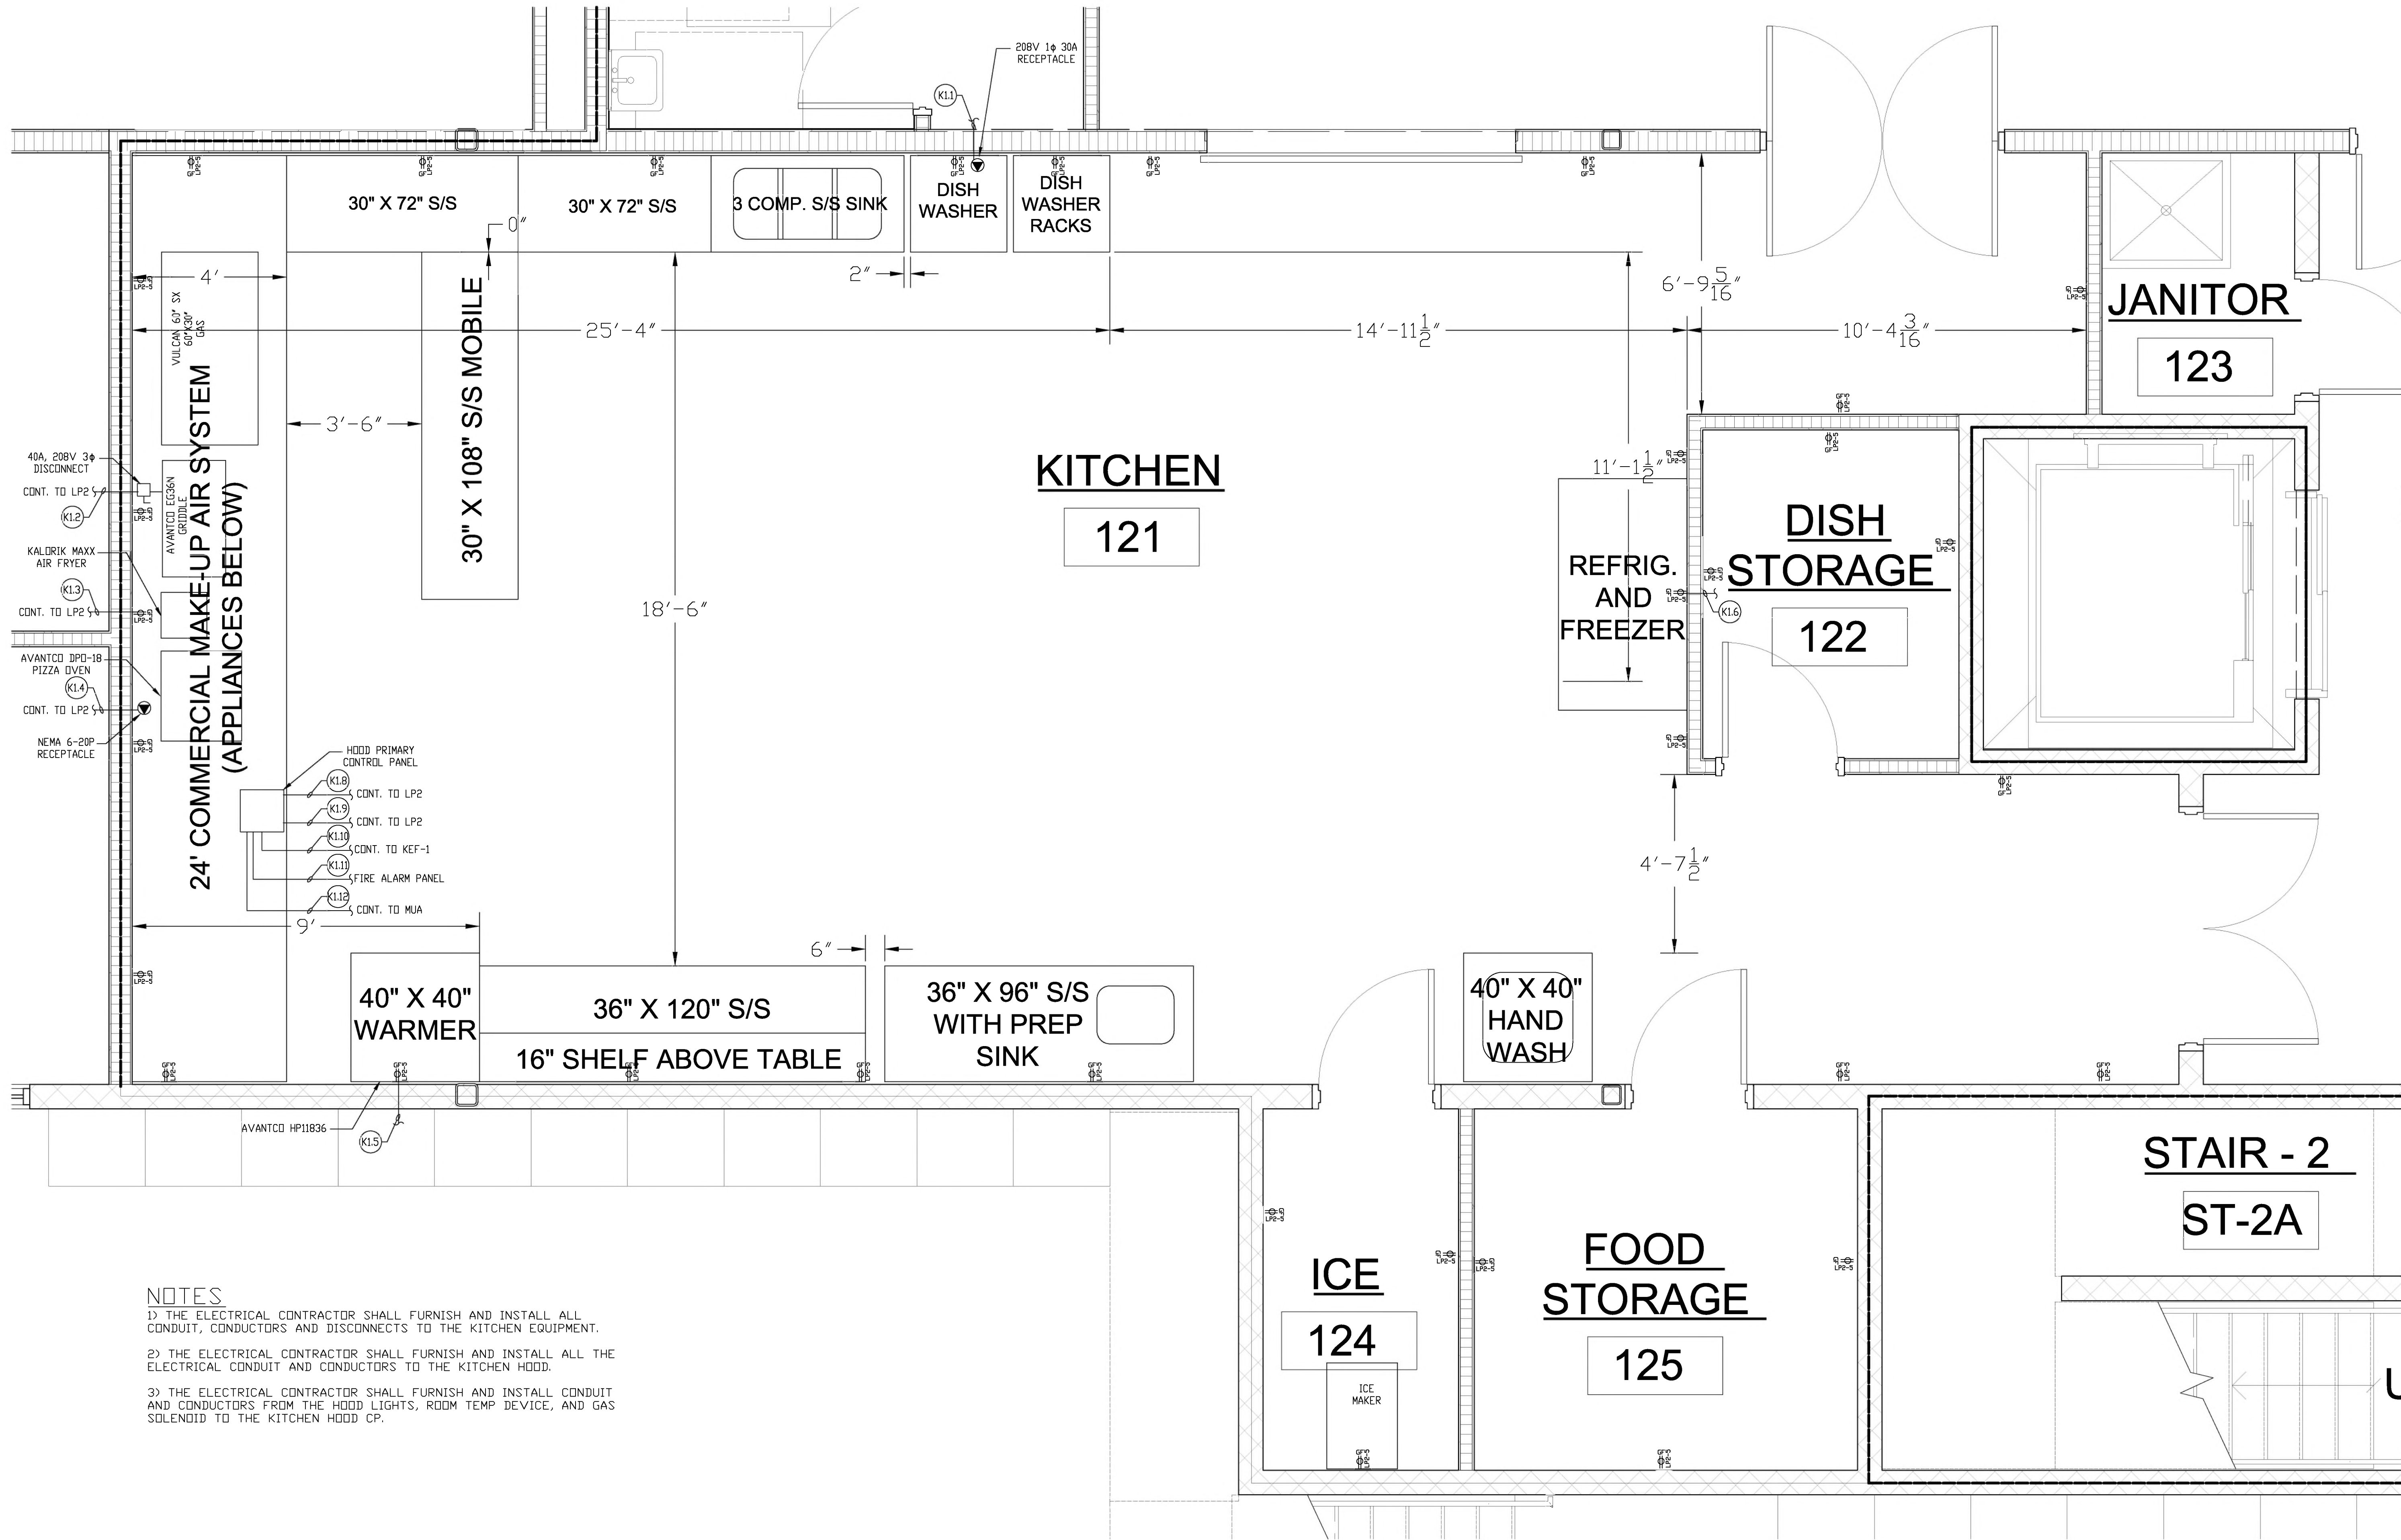

NOTES

- 1) THE ELECTRICAL CONTRACTOR SHALL FURNISH AND INSTALL ALL CONDUIT, CONDUCTORS AND DISCONNECTS TO THE KITCHEN EQUIPMENT.
- 2) THE ELECTRICAL CONTRACTOR SHALL FURNISH AND INSTALL ALL THE ELECTRICAL CONDUIT AND CONDUCTORS TO THE KITCHEN HOOD.
- 3) THE ELECTRICAL CONTRACTOR SHALL FURNISH AND INSTALL CONDUIT AND CONDUCTORS FROM THE HOOD LIGHTS, ROOM TEMP DEVICE, AND GAS SOLENOID TO THE KITCHEN HOOD CP.

FIREHOUSE KITCHEN ELECTRICAL PLAN

1/2" = 1'-0"

DATE: 6/18/23
DRAWN BY: AA
SCALE: AS SHOWN
REVIEWED BY: AA
PROJECT NO.: 212543
FILE:



NO.	REVISIONS	
	DATE	DESCRIPTION
1	6/18/23	CONSTRUCTION

PORT EWEN FIRE
DEPARTMENT
ULSTER COUNTY, NY

FIREHOUSE KITCHEN
ELECTRICAL PLAN

SHEET:
E105

BID PLANS

WARNING: - IT IS A VIOLATION OF NEW YORK EDUCATION LAW SECTION 7209.3, FOR ANY PERSON, UNLESS HE IS ACTING UNDER THE DIRECTION OF A LICENSED PROFESSIONAL ENGINEER OR LAND SURVEYOR, TO ALTER THIS DOCUMENT IN ANY WAY. IF ALTERED THE ALTERING PERSON SHALL COMPLY WITH THE REQUIREMENTS OF NEW YORK EDUCATION LAW, SECTION 7209.2.