


NOTES

1. THE ELECTRICAL CONTRACTOR SHALL FURNISH AND INSTALL POWER TO ALL ELEVATOR COMPONENTS..
2. THE ELECTRICAL CONTRACTOR SHALL FURNISH AND INSTALL ALL RECEPTACLES. THIS SHALL INCLUDE A 120V CIRCUIT WITH 3#12 IN 3/4" CONDUIT.
3. THE ELECTRICAL CONTRACTOR SHALL FURNISH AND INSTALL THE ELECTRICAL TO EACH OF THE OVERHEAD DOORS.
4. ELECTRICAL CONTRACTOR TO SUPPLY AND INSTALL 1 RESCUE PHONE IN 2ND FLOOR ELEVATOR LOBBY RATH 2100-958NSR OR ENGINEER APPROVED EQUAL
5. THE ELECTRICAL CONTRACTOR SHALL FURNISH AND INSTALL ALL ETHERNET AND PHONE JACKS ALONG WITH CABLE.
6. THE ELECTRICAL CONTRACTOR SHALL FURNISH AND INSTALL POWER TO THE WATER FOUNTAIN.

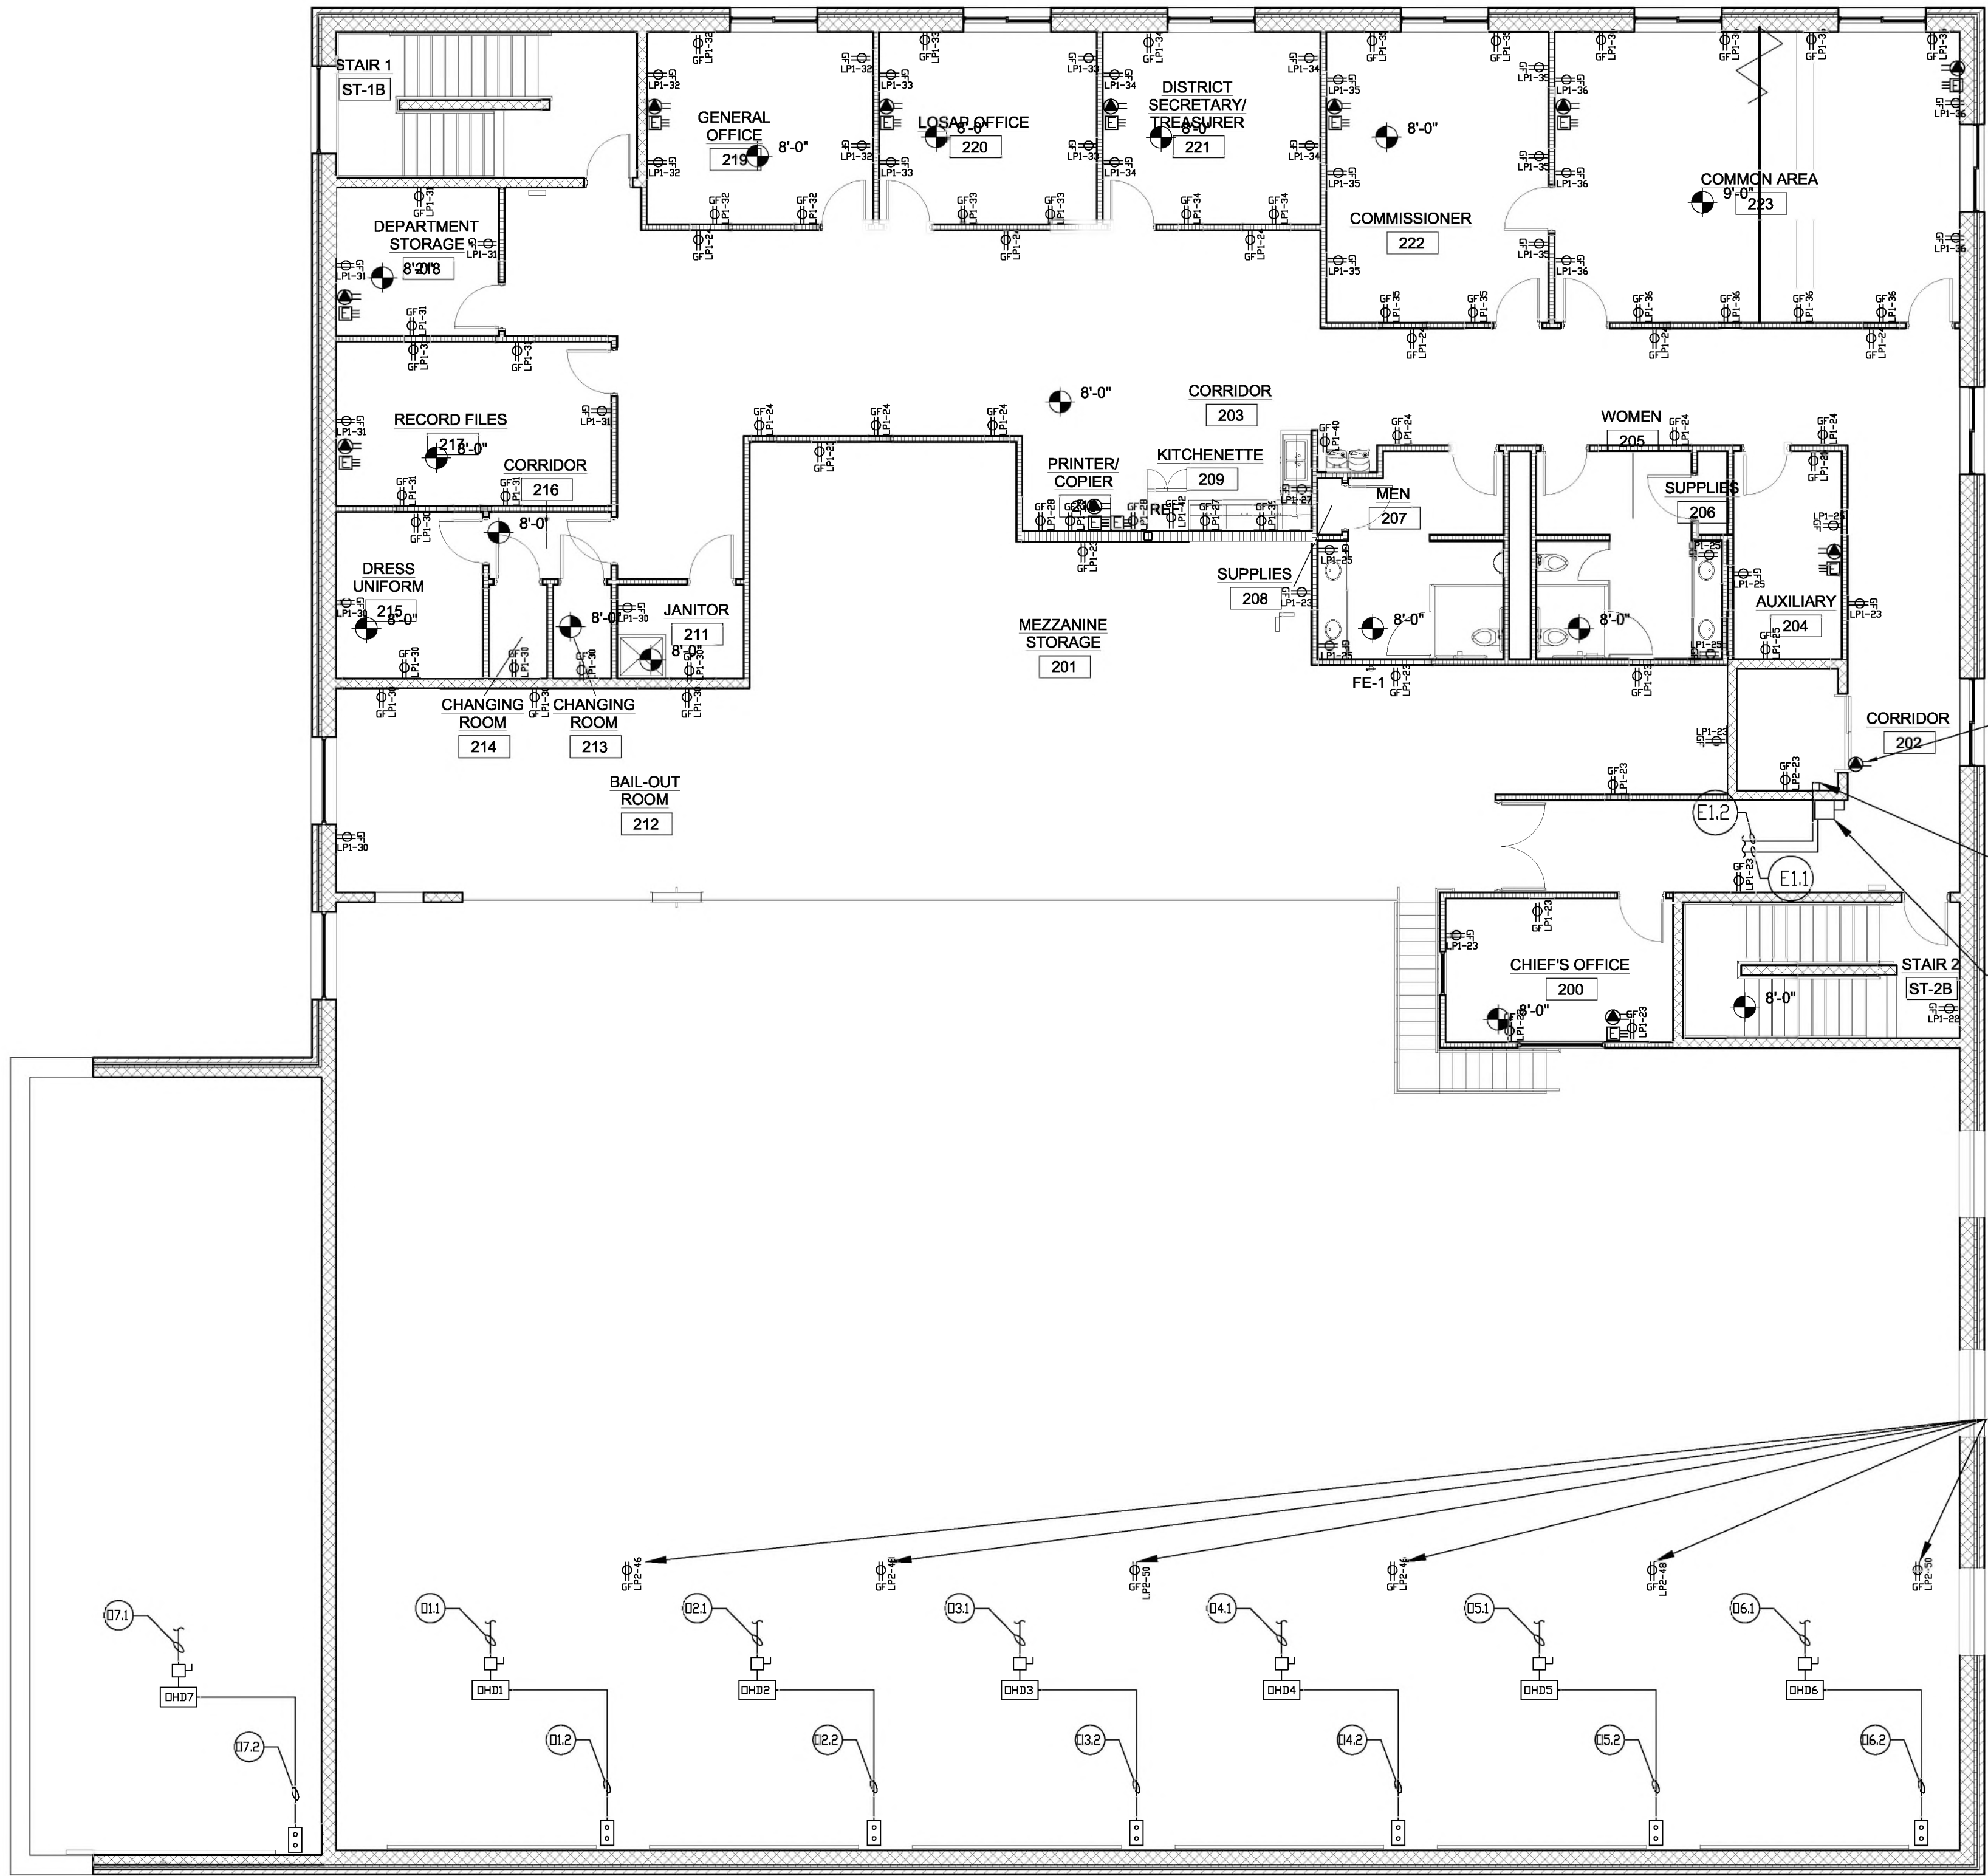

SECOND FLOOR POWER PLAN

1/8" = 1'-0"

DATE: 6/20/23
DRAWN BY: AA
SCALE: AS SHOWN
REVIEWED BY: AA
PROJECT NO.: 21243
FILE:



REVISIONS		DESCRIPTION
NO.	DATE	DESCRIPTION
1	6/16/23	CONSTRUCTION

PORT EWEN FIRE
DEPARTMENT
ULSTER COUNTY, NY

SECOND FLOOR
POWER PLAN

SHEET:
E-200

BID PLANS



WARNING: IT IS A VIOLATION OF NEW YORK EDUCATION LAW SECTION 7209.3, FOR ANY PERSON, UNLESS HE IS ACTING UNDER THE DIRECTION OF A LICENSED PROFESSIONAL ENGINEER OR LAND SURVEYOR, TO ALTER THIS DOCUMENT IN ANY WAY. IF ALTERED THE ALTERING PERSON SHALL COMPLY WITH THE REQUIREMENTS OF NEW YORK EDUCATION LAW, SECTION 7209.2.