


H:\Drawings\Port Ewen\PE_LIGHTING_SECOND_FLOOR_4.27.23.dwg

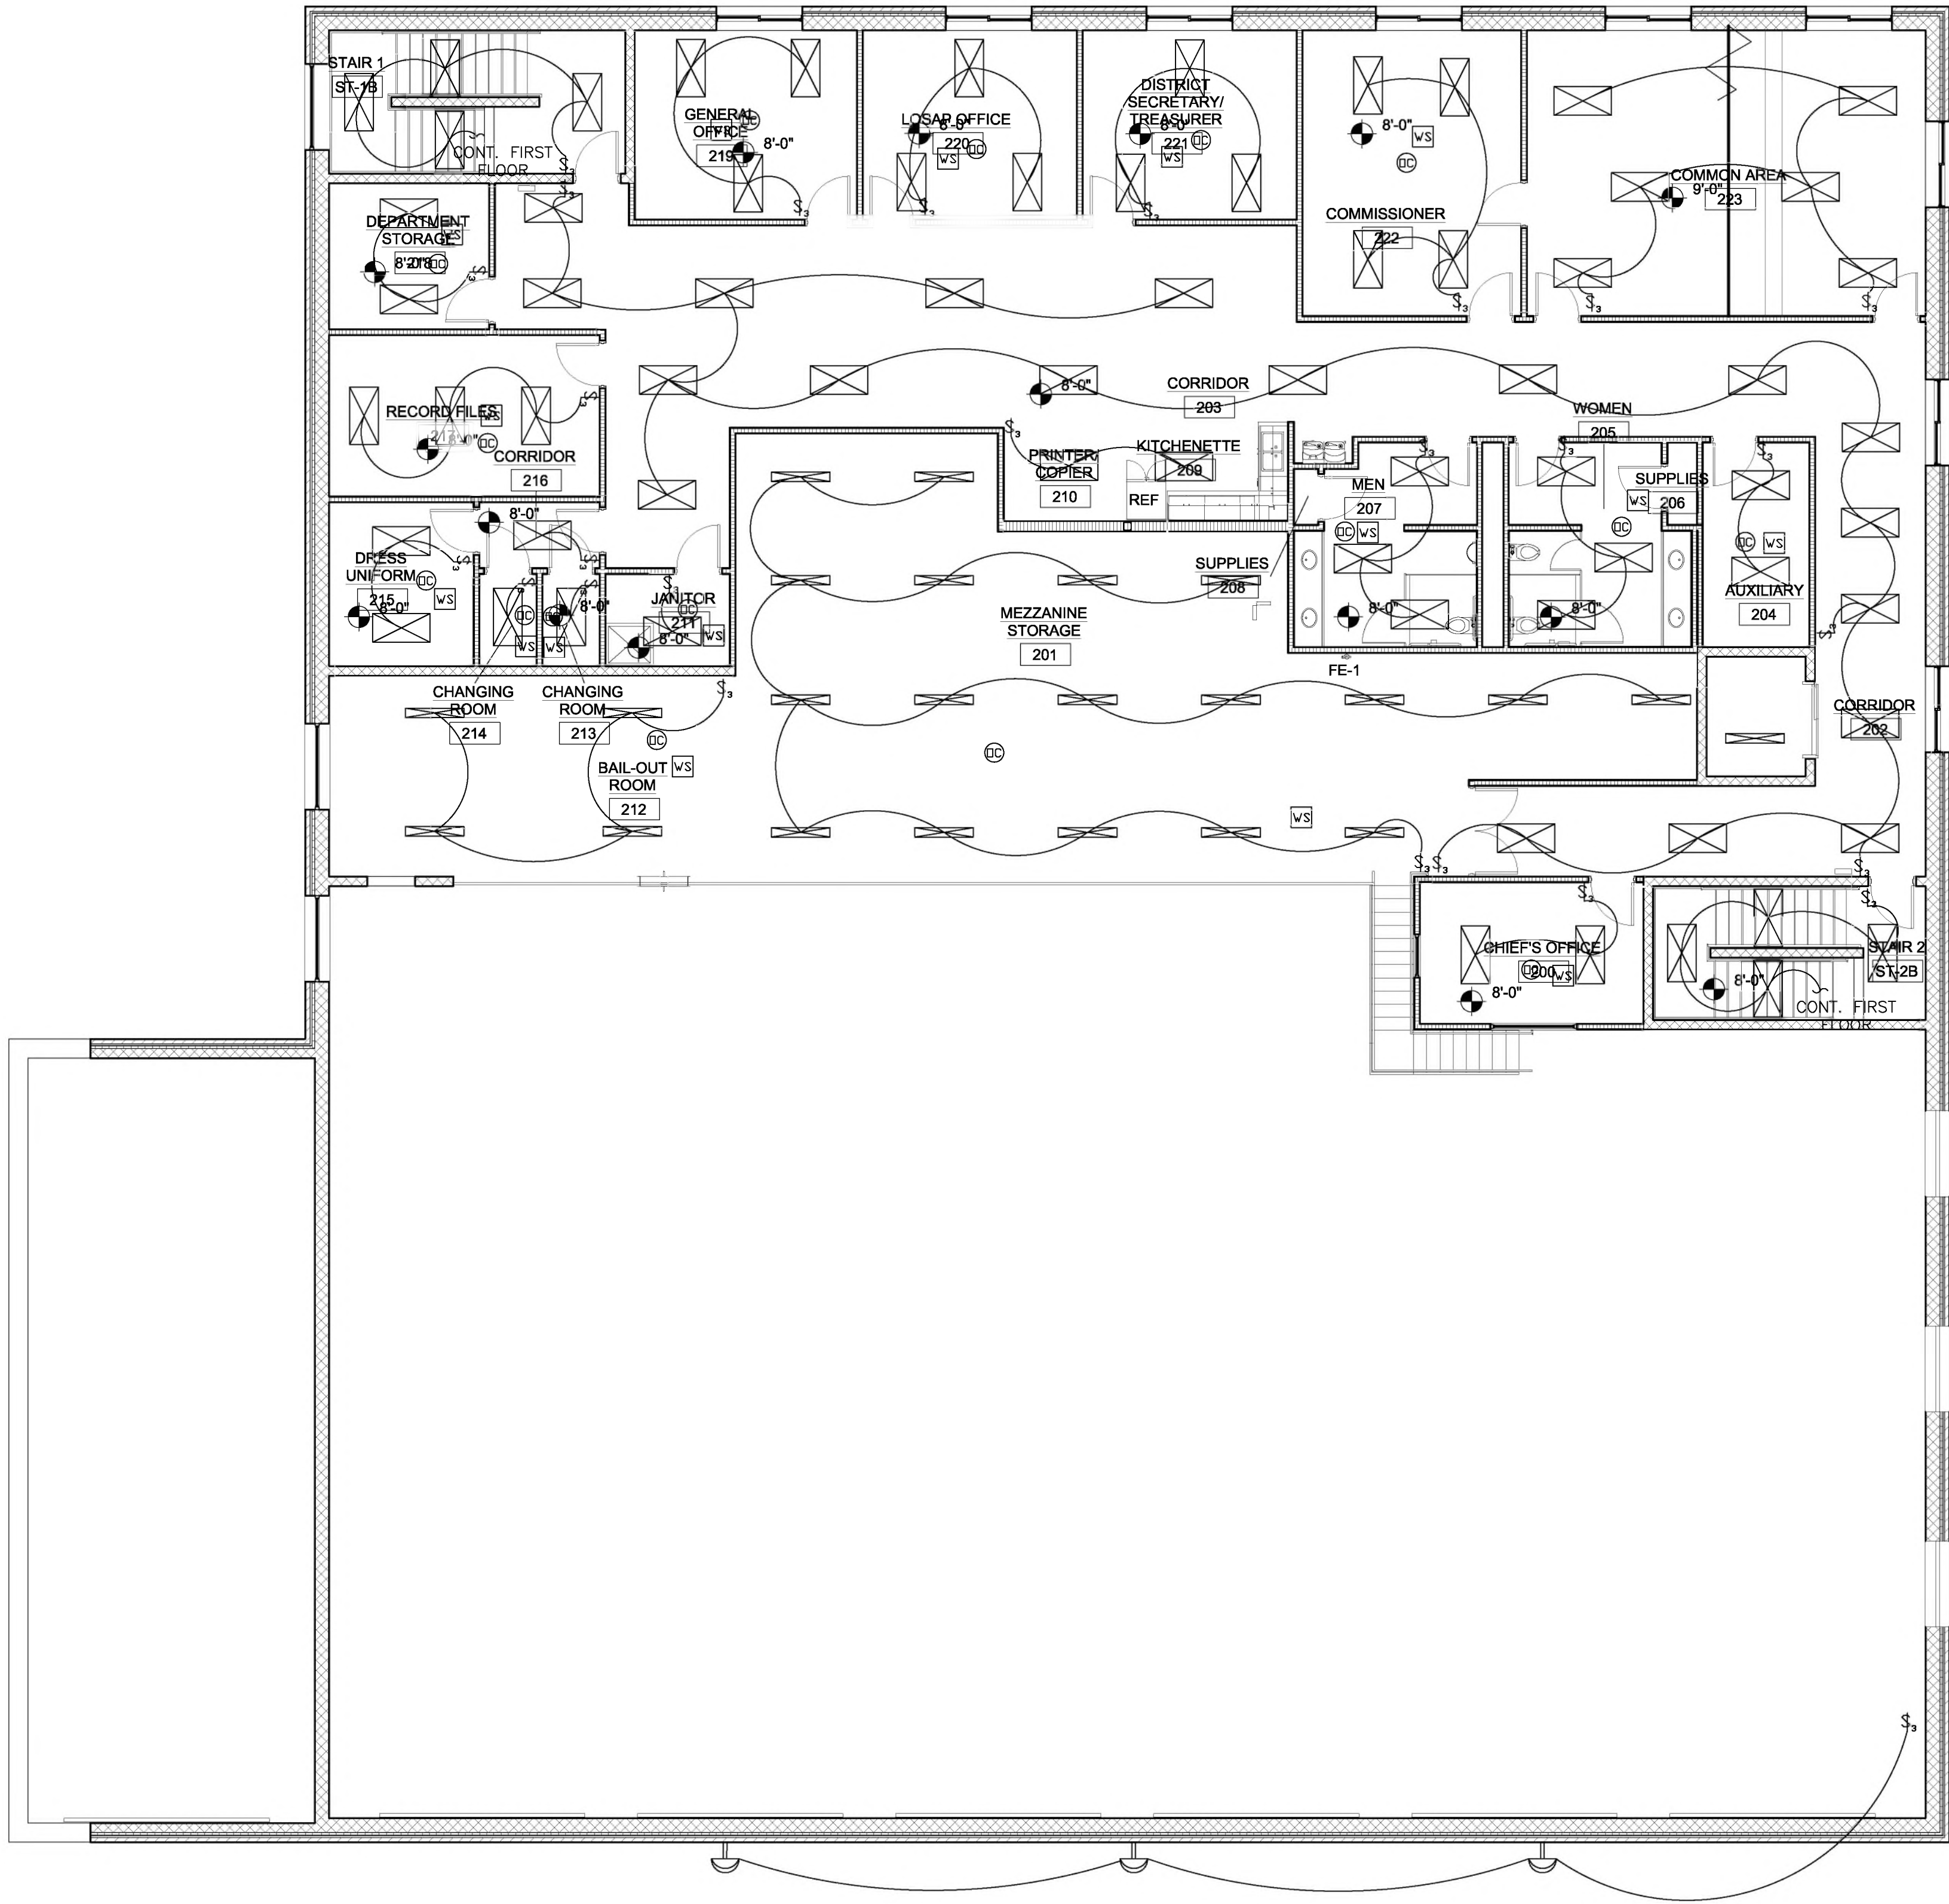

SECOND FLOOR LIGHTING PLAN
1/8" = 1'-0"

- NOTES
1. THE RLM LIGHTS ABOVE THE GARAGE DOORS SHALL BE USED TO LIGHT UP THE SIGN. ASSUME A 17' ELEVATION.
 2. ELECTRICAL CONTRACTOR SHALL FURNISH AND INSTALL A DUSK TO DAWN PHOTO CELL ON THE RLM CIRCUIT.



WARNING - IT IS A VIOLATION OF NEW YORK EDUCATION LAW SECTION 7209.2, FOR ANY PERSON, UNLESS HE IS ACTING UNDER THE DIRECTION OF A LICENSED PROFESSIONAL ENGINEER OR LAND SURVEYOR, TO ALTER THIS DOCUMENT IN ANY WAY. IF ALTERED THE ALTERING PERSON SHALL COMPLY WITH THE REQUIREMENTS OF NEW YORK EDUCATION LAW, SECTION 7209.2.

SHEET:
E-201

SECOND FLOOR
LIGHTING PLAN

PORT EWEN FIRE
DEPARTMENT
ULSTER COUNTY, NY

REVISIONS

NO.	DATE	DESCRIPTION
1	6/16/23	CONSTRUCTION



DATE: 7/26/23
DRAWN BY: AA
SCALE: AS SHOWN
REVIEWED BY: AA
PROJECT NO.: 21243
FILE: