


H:\Drawings\Port Ewen\PE_LIGHTING_SECOND_FLOOR_4.27.23.dwg

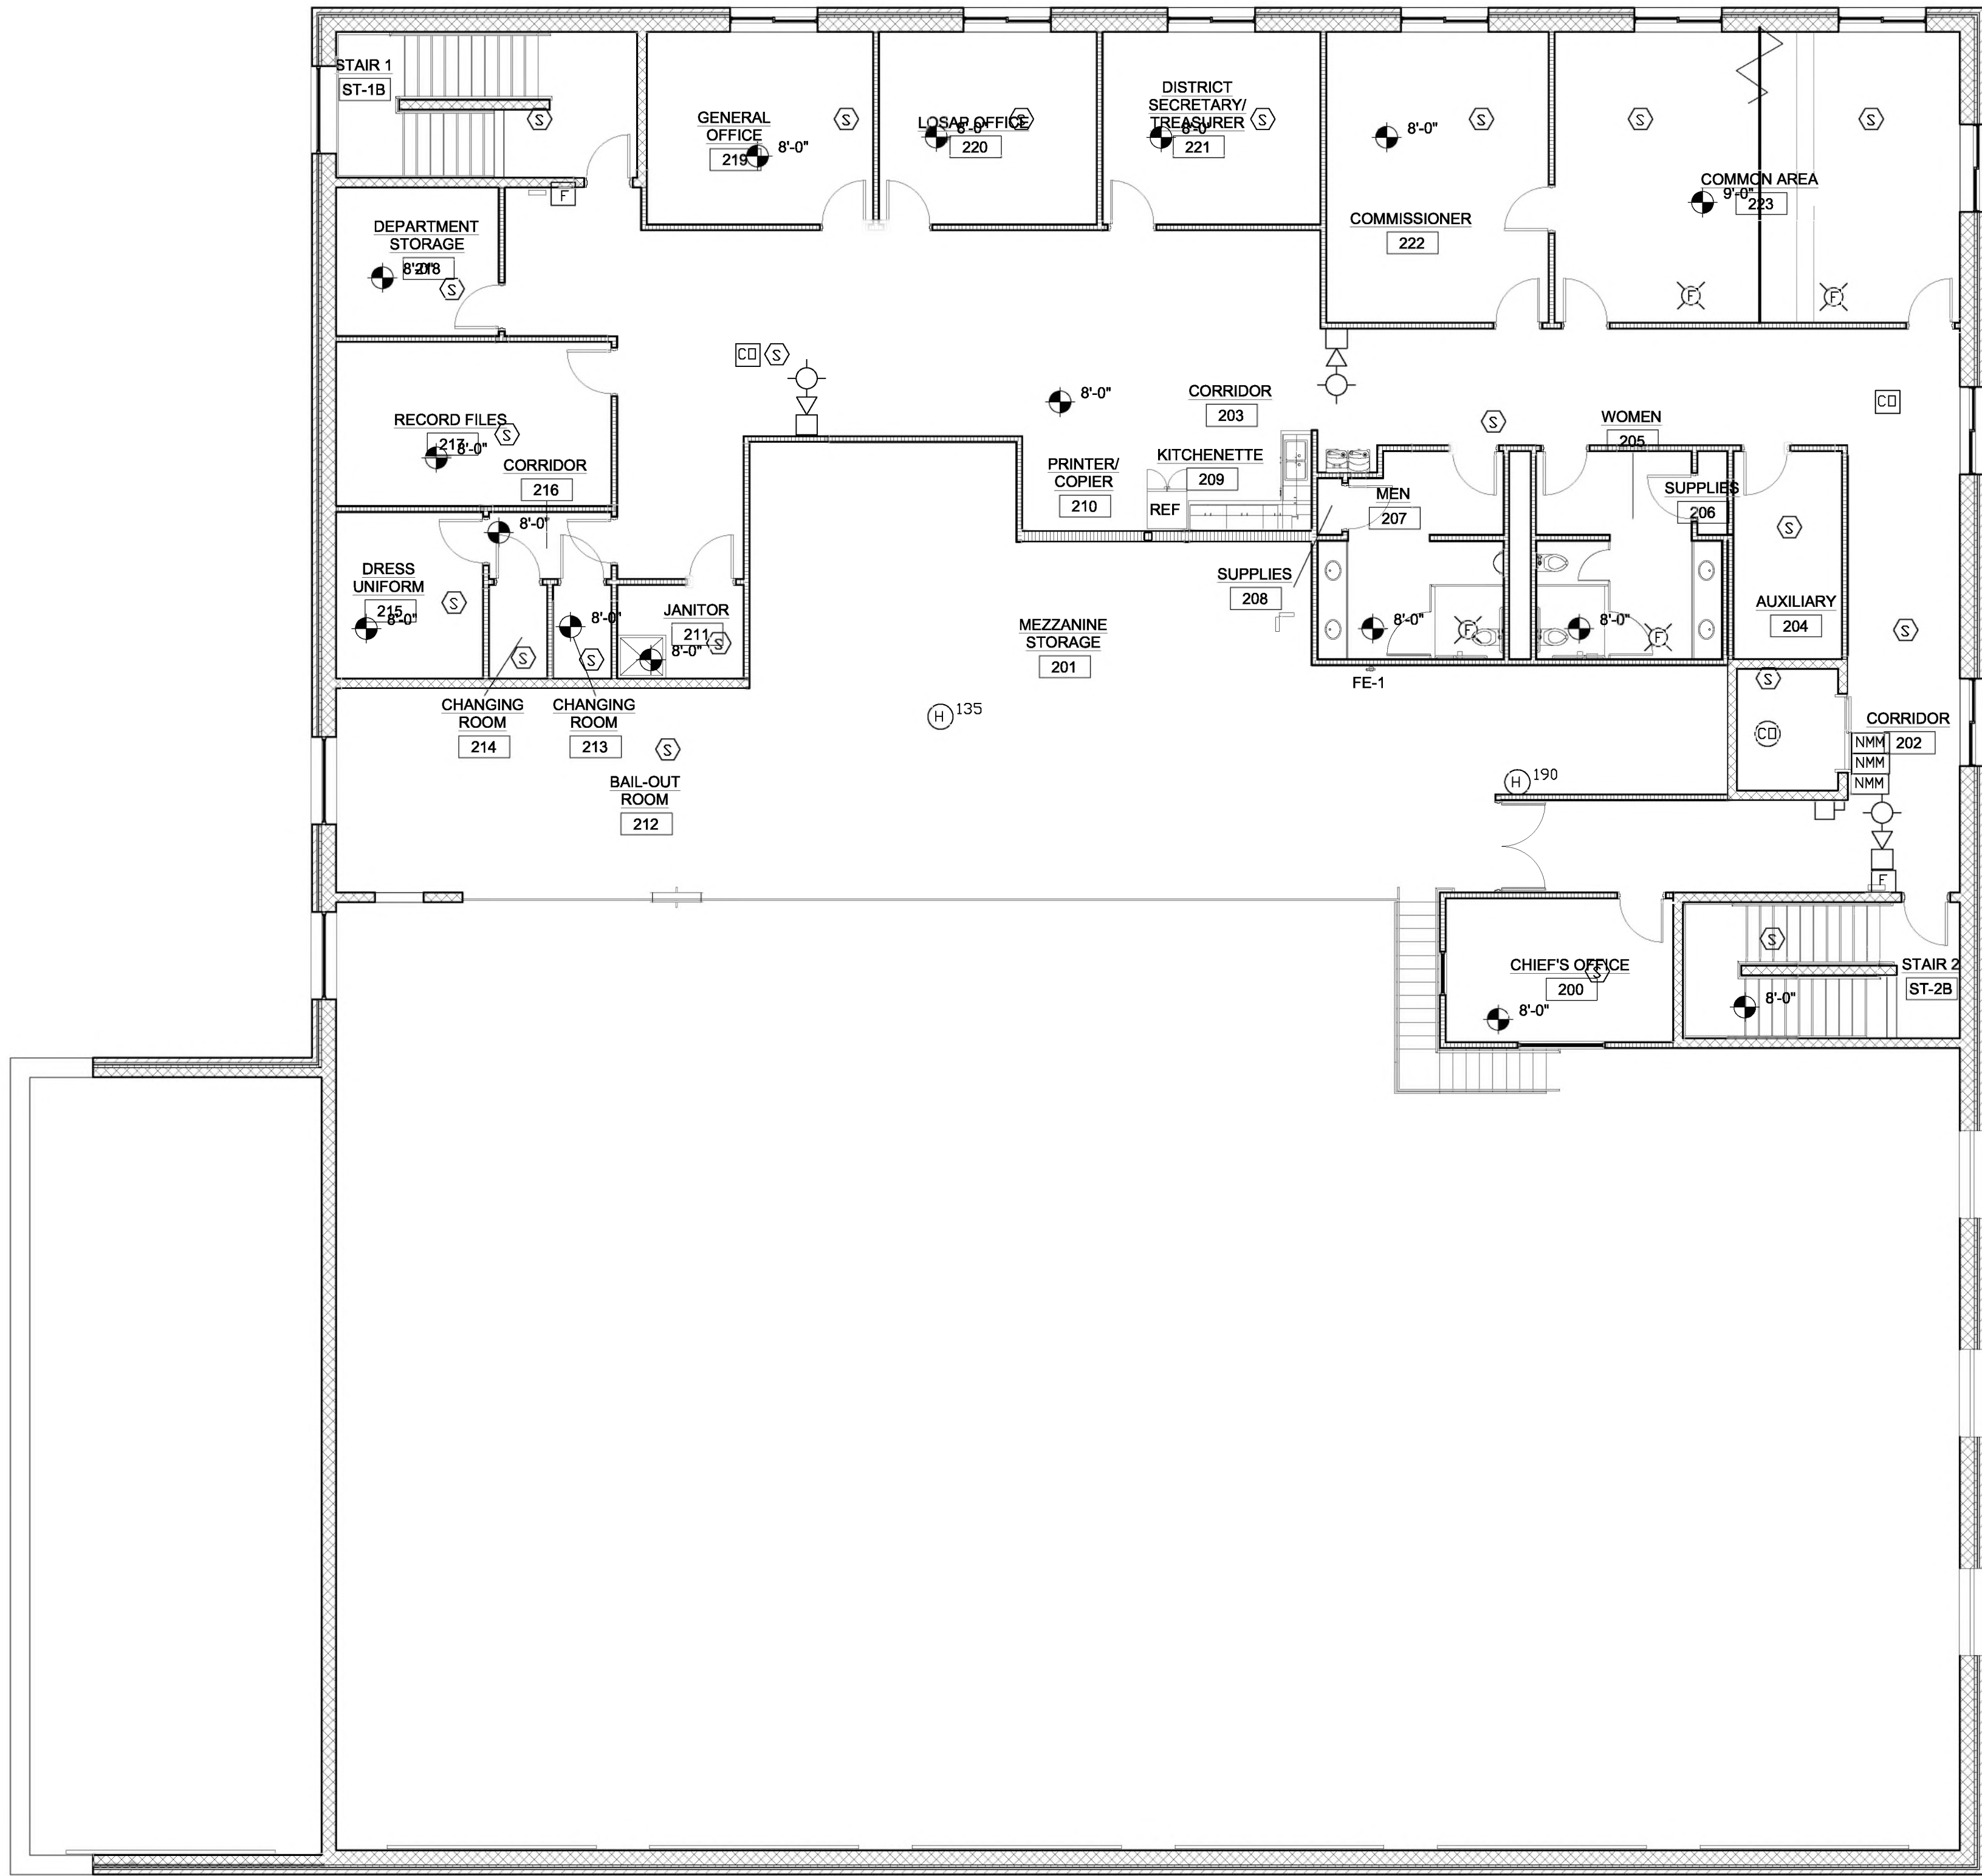


SECOND FLOOR FIRE ALARM PLAN
1/8" = 1'-0"

- STROBE LIGHT WITH HORN
- STROBE LIGHT
- PULL STATION WITH KEY RESET
- SMOKE DETECTOR PHOTO ELECTRIC
- HEAT DETECTOR X=135 FOR 135DEG RATE OF RISE AND X=190 FOR 190DEG RATE OF RISE
- CARBON MONOXIDE DETECTOR
- SUPPRESSION SYSTEM SUPERVISION
- DOOR HOLDER WALL MOUNT
- ADDRESSABLE MINI MODULE
- EXPLOSION PROOF SMOKE DETECTOR
- EXPLOSION PROOF PULL STATION WITH KEY RESET
- EXTERIOR STROBE LIGHT WITH HORN
- ANNUNCIATOR



WARNING: IT IS A VIOLATION OF NEW YORK EDUCATION LAW SECTION 7209.3, FOR ANY PERSON, UNLESS HE IS ACTING UNDER THE DIRECTION OF A LICENSED PROFESSIONAL ENGINEER OR LAND SURVEYOR, TO ALTER THIS DOCUMENT IN ANY WAY. IF ALTERED THE ALTERING PERSON SHALL COMPLY WITH THE REQUIREMENTS OF NEW YORK EDUCATION LAW, SECTION 7209.2.

DATE:	6/29/23
DRAWN BY:	AA
SCALE:	AS SHOWN
REVIEWED BY:	AA
PROJECT NO.:	212543
FILE:	

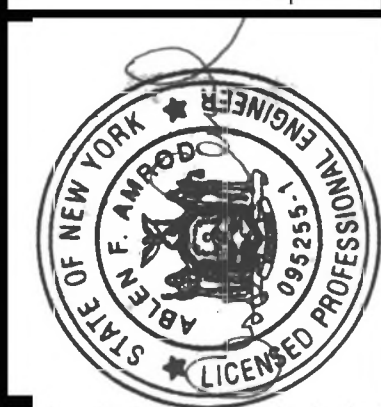

REVISIONS	
NO.	DESCRIPTION
1	CONSTRUCTION

PORT EWEN FIRE
DEPARTMENT
ULSTER COUNTY, NY

SECOND FLOOR
FIRE ALARM PLAN

SHEET:
E-202

BID PLANS