


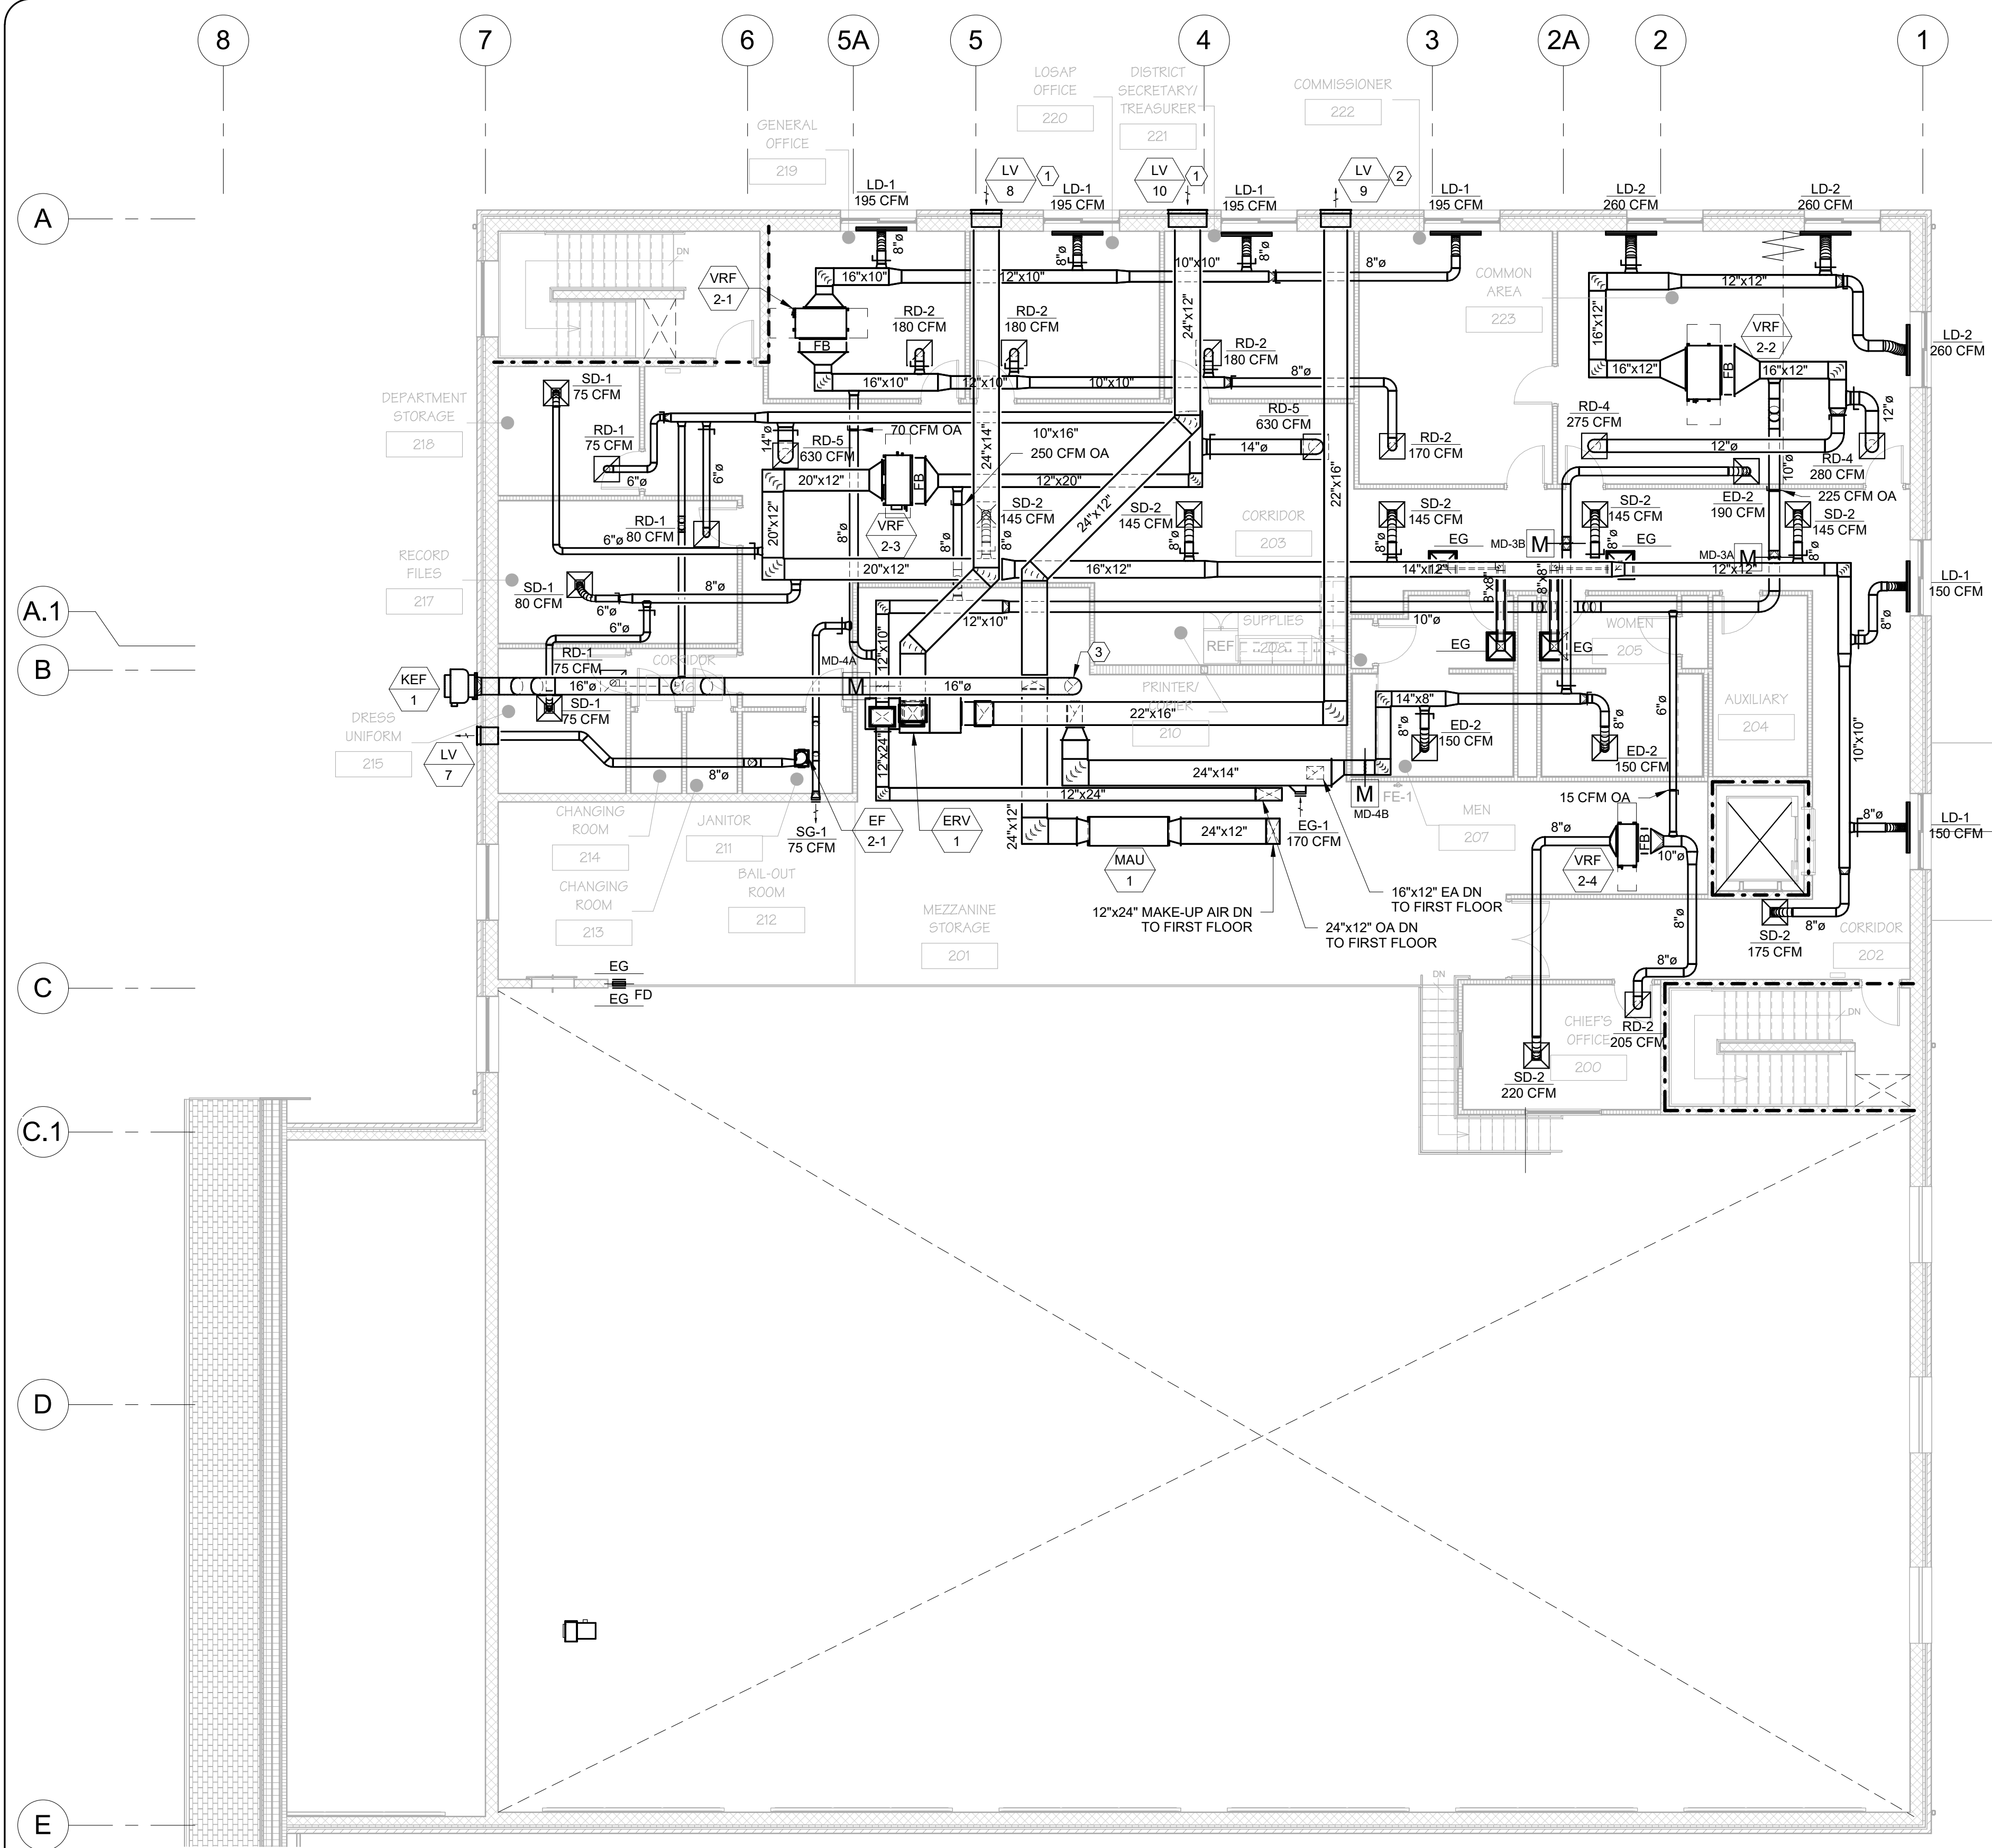

KEYED NOTES

1

INTAKE SHALL BE NO CLOSER THAN 10- FEET HORIZONTALLY FROM ANY EXHAUST, PARKING, VENTS, ETC.
- BRING ANY CONCERNS TO ENGINEER'S ATTENTION.

2

EXHAUST SHALL BE NO CLOSER THAN 3- FEET FROM ANY OPERABLE OPENINGS.
- BRING ANY CONCERNS TO ENGINEER'S ATTENTION.

3

16"ø GREASE DUCT FROM HOOD BELOW TO KEF-1.
TRANSITION AS REQUIRED FOR CONNECTIONS.
SEE SECTION 23 51 01.

BID PLANS

DATE: 06/21/2023
DRAWN BY: AOS
SCALE: 1/8" = 1' - 0"
REVIEWED BY: TJH
PROJECT NO.: 20-2006
FILE:

HESNOR
ENGINEERING & ARCHITECTURE
WWW.HESNOR.COM

KEYSTONE ASSOCIATES
ARCHITECTS
WWW.KEYSTONEARCHITECTS.COM

DELAWARE D.P.C.
CONSULTING ENGINEERS
WWW.DELAWAREENGINEERING.COM

REVISIONS

NO.	DATE	DESCRIPTION
1	Date 1	Revision 1

HVAC PLAN - SECOND FLOOR

PORT EWEN FIRE
DEPARTMENT, ULSTER, NEW
YORK

SHEET:

M102