


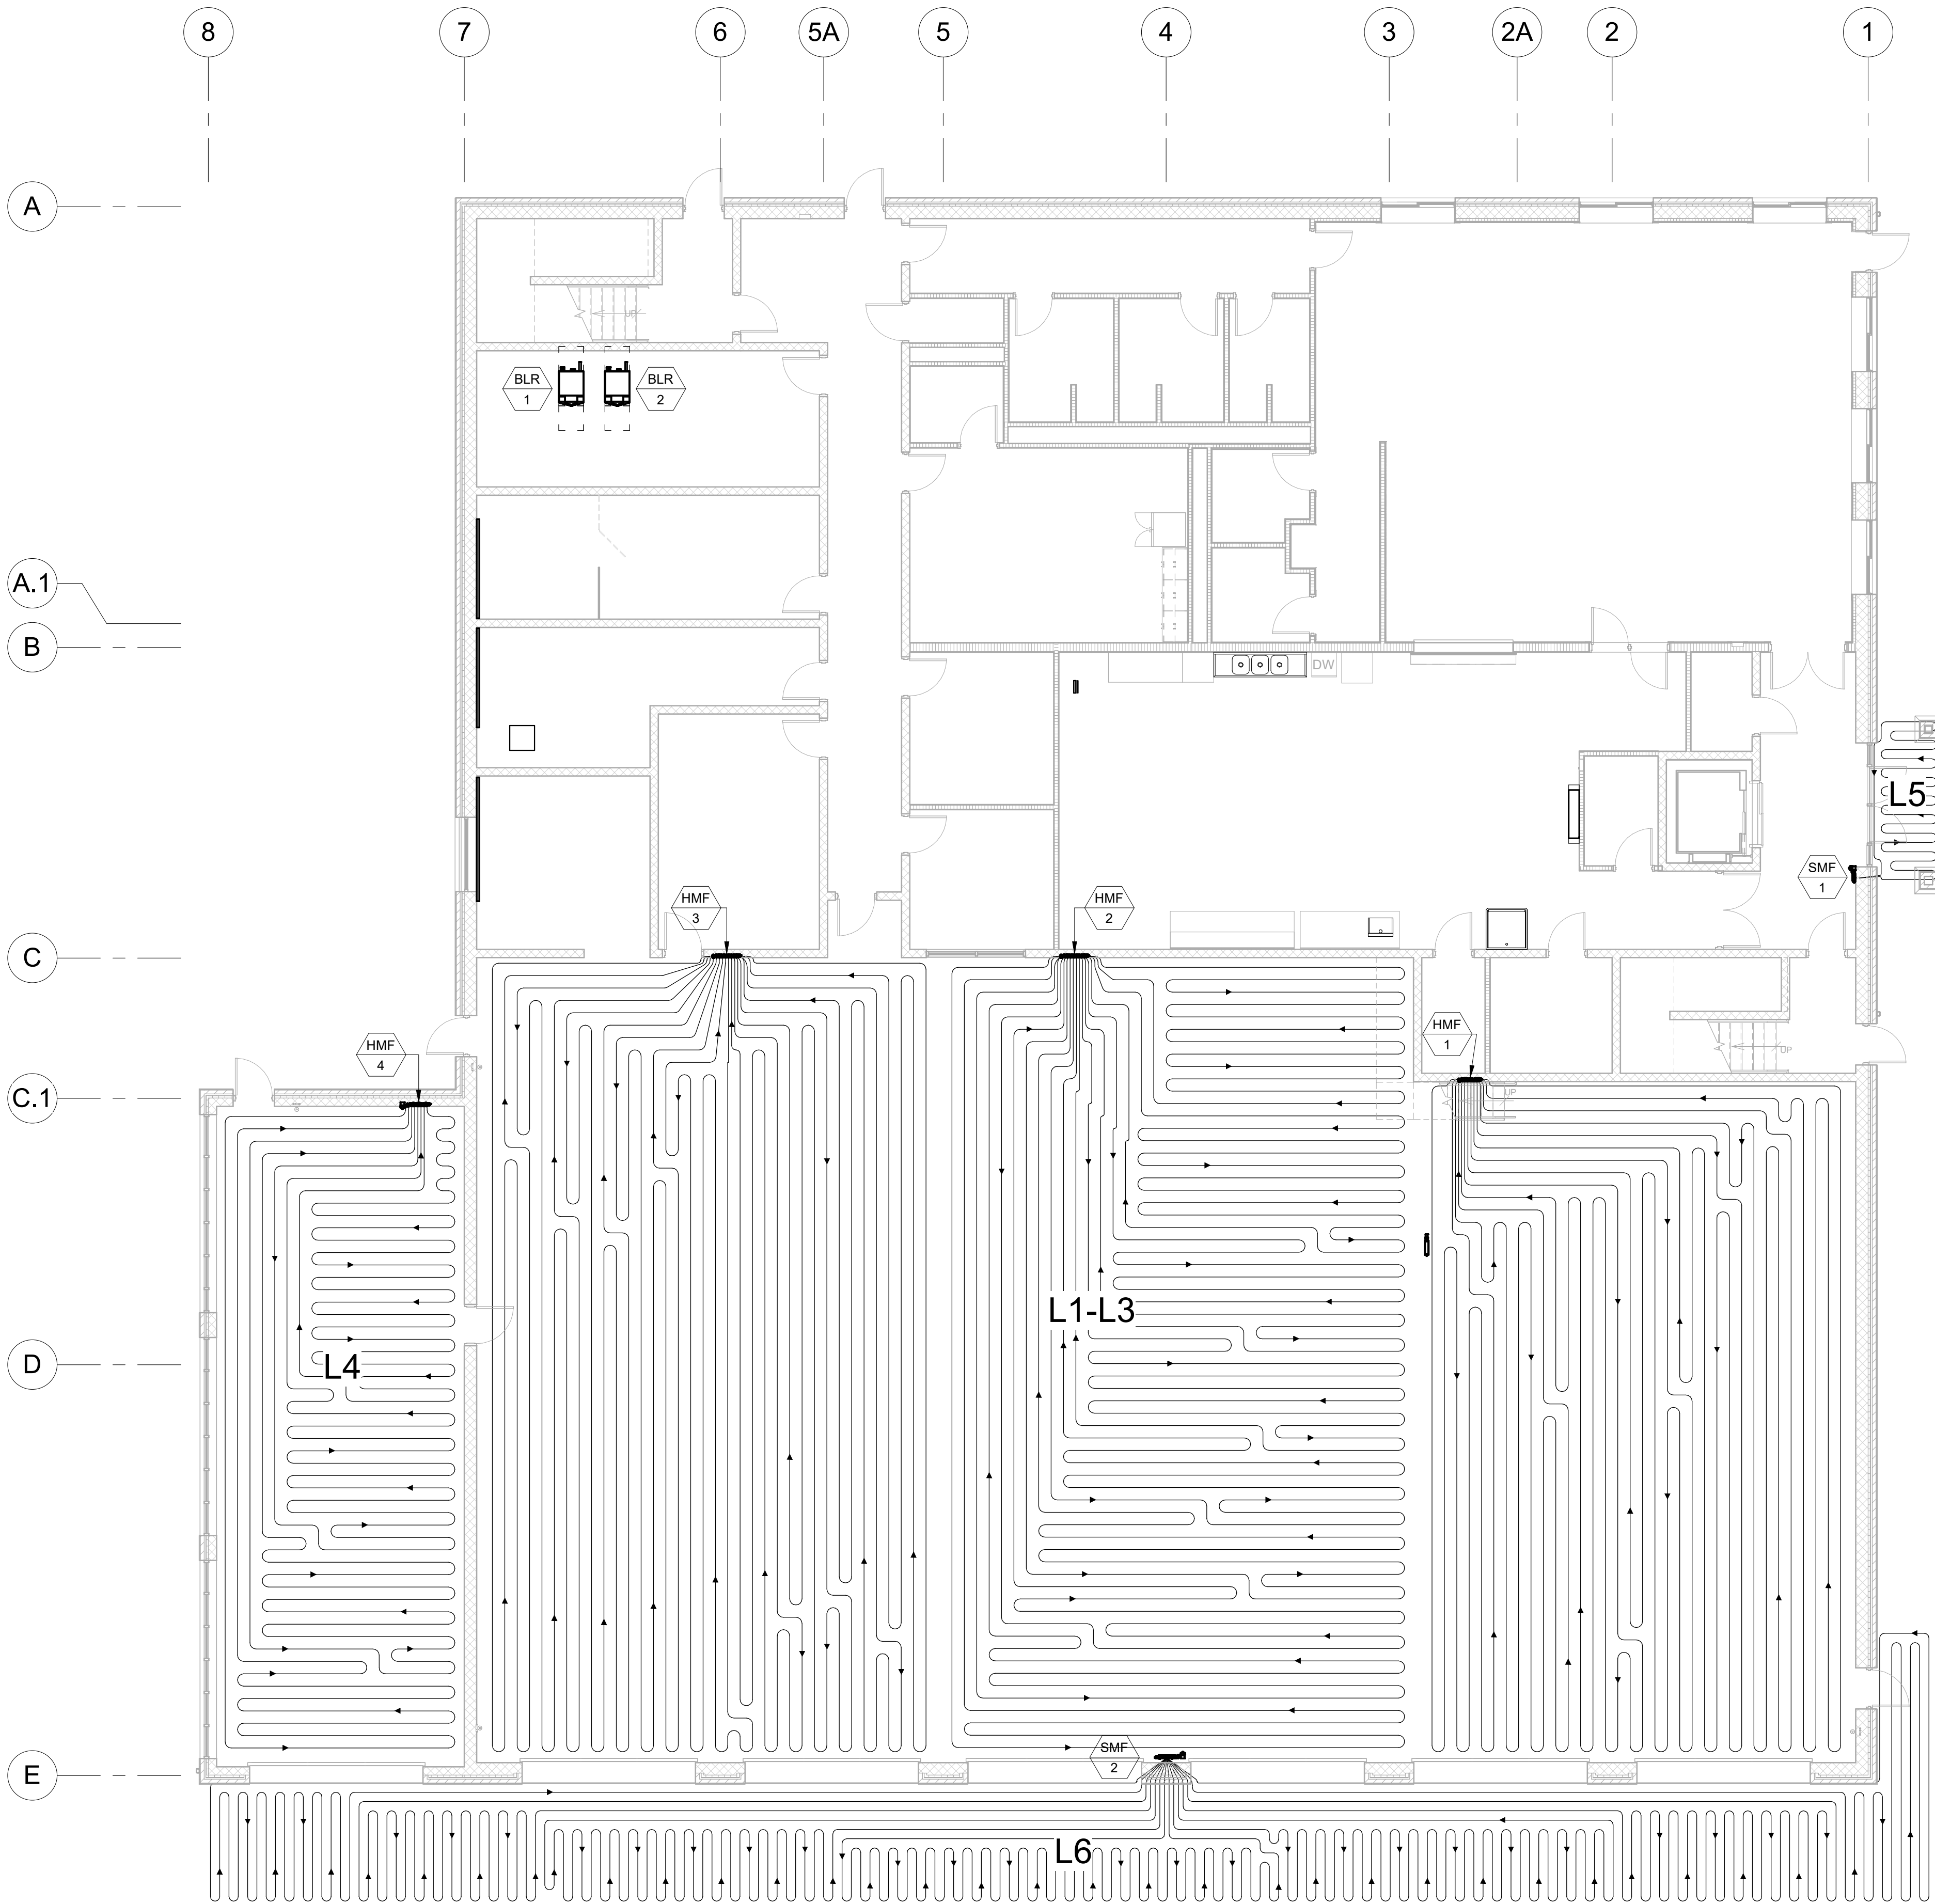

IN-SLAB HEATING:
LOOPS L-1 - L-3 APPARATUS BAY
LOOP L-4 VINTAGE VEHICLE BAY
LOOP L-5 LOBBY (40% PROPYLENE GLYCOL)
LOOP L-6 APRON (40% PROPYLENE GLYCOL)

NOTE
- SEE DWG M201 FOR PIPING PLAN
- SEE DWG M601 FOR ONE-LINE DIAGRAM

BID PLANS

DATE: 06/21/2023
DRAWN BY: AOS
SCALE: 1/8" = 1' - 0"
REVIEWED BY: TJH
PROJECT NO.: 20-2006
FILE:


HESNOR
ENGINEERING ASSOCIATES
WWW.HESNOR.COM


KEYSTONE
ASSOCIATES
WWW.KEYSTONEASSOCIATES.COM


DELAWARE
ENGINEERING, D.P.C.
CIVIL AND ENVIRONMENTAL ENGINEERING
WWW.DELAWAREENGINEERING.COM

REVISIONS	
NO.	DESCRIPTION

PORT EWEN FIRE
DEPARTMENT, ULSTER, NEW
YORK

IN-SLAB HEATING PLAN
FIRST FLOOR

SHEET:
M201B