


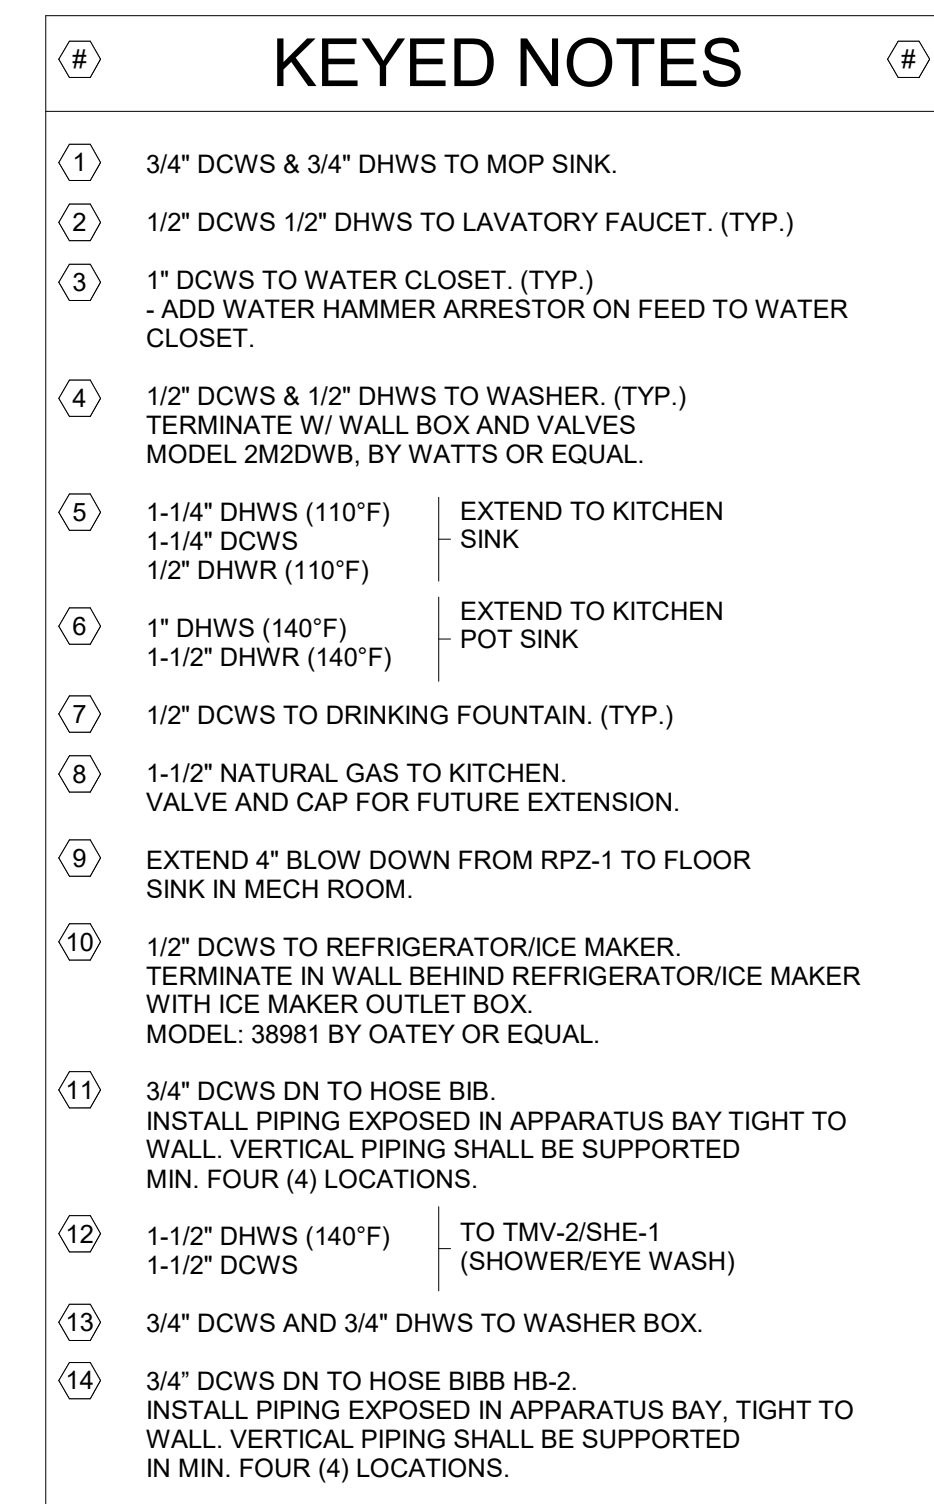

DATE:	06/21/2023
DRAWN BY:	AOS
SCALE:	1/8" = 1' - 0"
REVIEWED BY:	TJH
PROJECT NO.:	20-2006
FILE:	

[illegible]

PORT EWEN FIRE
DEPARTMENT, ULSTER, NEW
YORK

POTABLE WATER FIRST FLOOR PLAN

SHEET:

P101

BID PLANS