

POLICE LOCKER ROOM RENOVATIONS



ARCHITECTURAL

Sheet Number	Sheet Name	Current Revision Date
T-000.00	TITLE SHEET EGRESS PLANS	11/3/23
G-100.00	GENERAL NOTES/ ADA NOTES	11/3/23
EN-100.00	ENERGY CODE- ENVELOPE AND INTERIOR LIGHTING	11/3/23
A-101.00	DEMO/ CONSTRUCTION PLANS	11/3/23
A-102.00	RCP/ ROOF PLAN	11/3/23
A-500.00	ELEVATIONS, DETAILS	11/3/23
A-900.00	PARTITION TYPES	11/3/23
A-952.00	SPECIFICATIONS- EFIS	11/3/23
A-953.00	SPECIFICATIONS- ROOFING, ROOFING DETAILS	11/3/23
A-954.00	SPECIFICATIONS- DOORS, HARDWARE	11/3/23
A-955.00	SPECIFICATION- FINISHES	11/3/23
F-100.00	REFERENCE ONLY FURNITURE PLAN	11/3/23

STRUCTURAL

S100.00	GENERAL NOTES
S101.00	FOUNDATION PLAN AND DETAILS
S102.00	ROOF FRAMING PLAN AND DETAILS

CIVIL

C-100.00	SITE IMPROVEMENTS
----------	-------------------

MECHANICAL

M-000	MECHANICAL COVER SHEET
M-001	MECHANICAL NOTES
M-100	MECHANICAL 1ST FLOOR PLAN - DEMOLITION
M-101	MECHANICAL ROOF PLAN - DEMOLITION (NOT ISSUED)
M-200	MECHANICAL 1ST FLOOR PLAN - DUCTWORK
M-201	MECHANICAL ROOF PLAN - DUCTWORK
M-300	MECHANICAL 1ST FLOOR PLAN - PIPING
M-301	MECHANICAL ROOF PLAN - PIPING (NOT ISSUED)
M-400	MECHANICAL DIAGRAMS
M-500	MECHANICAL SCHEDULES
M-501	MECHANICAL SCHEDULES (NOT ISSUED)
M-600	MECHANICAL DETAILS
M-601	MECHANICAL DETAILS
M-700	MECHANICAL SPECIFICATIONS
M-701	MECHANICAL SPECIFICATIONS
M-702	MECHANICAL SPECIFICATIONS

EN-100 ENERGY CODE COMPLIANCE SHEET

ELECTRICAL


E-000	ELECTRICAL COVER SHEET
E-001	ELECTRICAL NOTES
E-100	ELECTRICAL 1ST FLOOR PLAN - DEMOLITION
E-200	ELECTRICAL 1ST FLOOR PLAN - LIGHTING
E-300	ELECTRICAL 1ST FLOOR PLAN - POWER
E-301	ELECTRICAL ROOF PLAN - POWER
E-400	ELECTRICAL SINGLE LINE DIAGRAM
E-500	ELECTRICAL SCHEDULES
E-600	ELECTRICAL DETAILS
E-700	ELECTRICAL SPECIFICATIONS
E-701	ELECTRICAL SPECIFICATIONS

FIRE ALARM

FA-000	FIRE ALARM COVER SHEET
FA-100	FIRE ALARM 1ST FLOOR PLAN (NOT ISSUED)

SPRINKLER

SP-000	SPRINKLER COVER SHEET
SP-100	SPRINKLER FLOOR PLAN
SP-200	SPRINKLER RISER DIAGRAM (NOT ISSUE)
SP-300	SPRINKLER DETAILS
SP-400	SPRINKLER SPECIFICATIONS

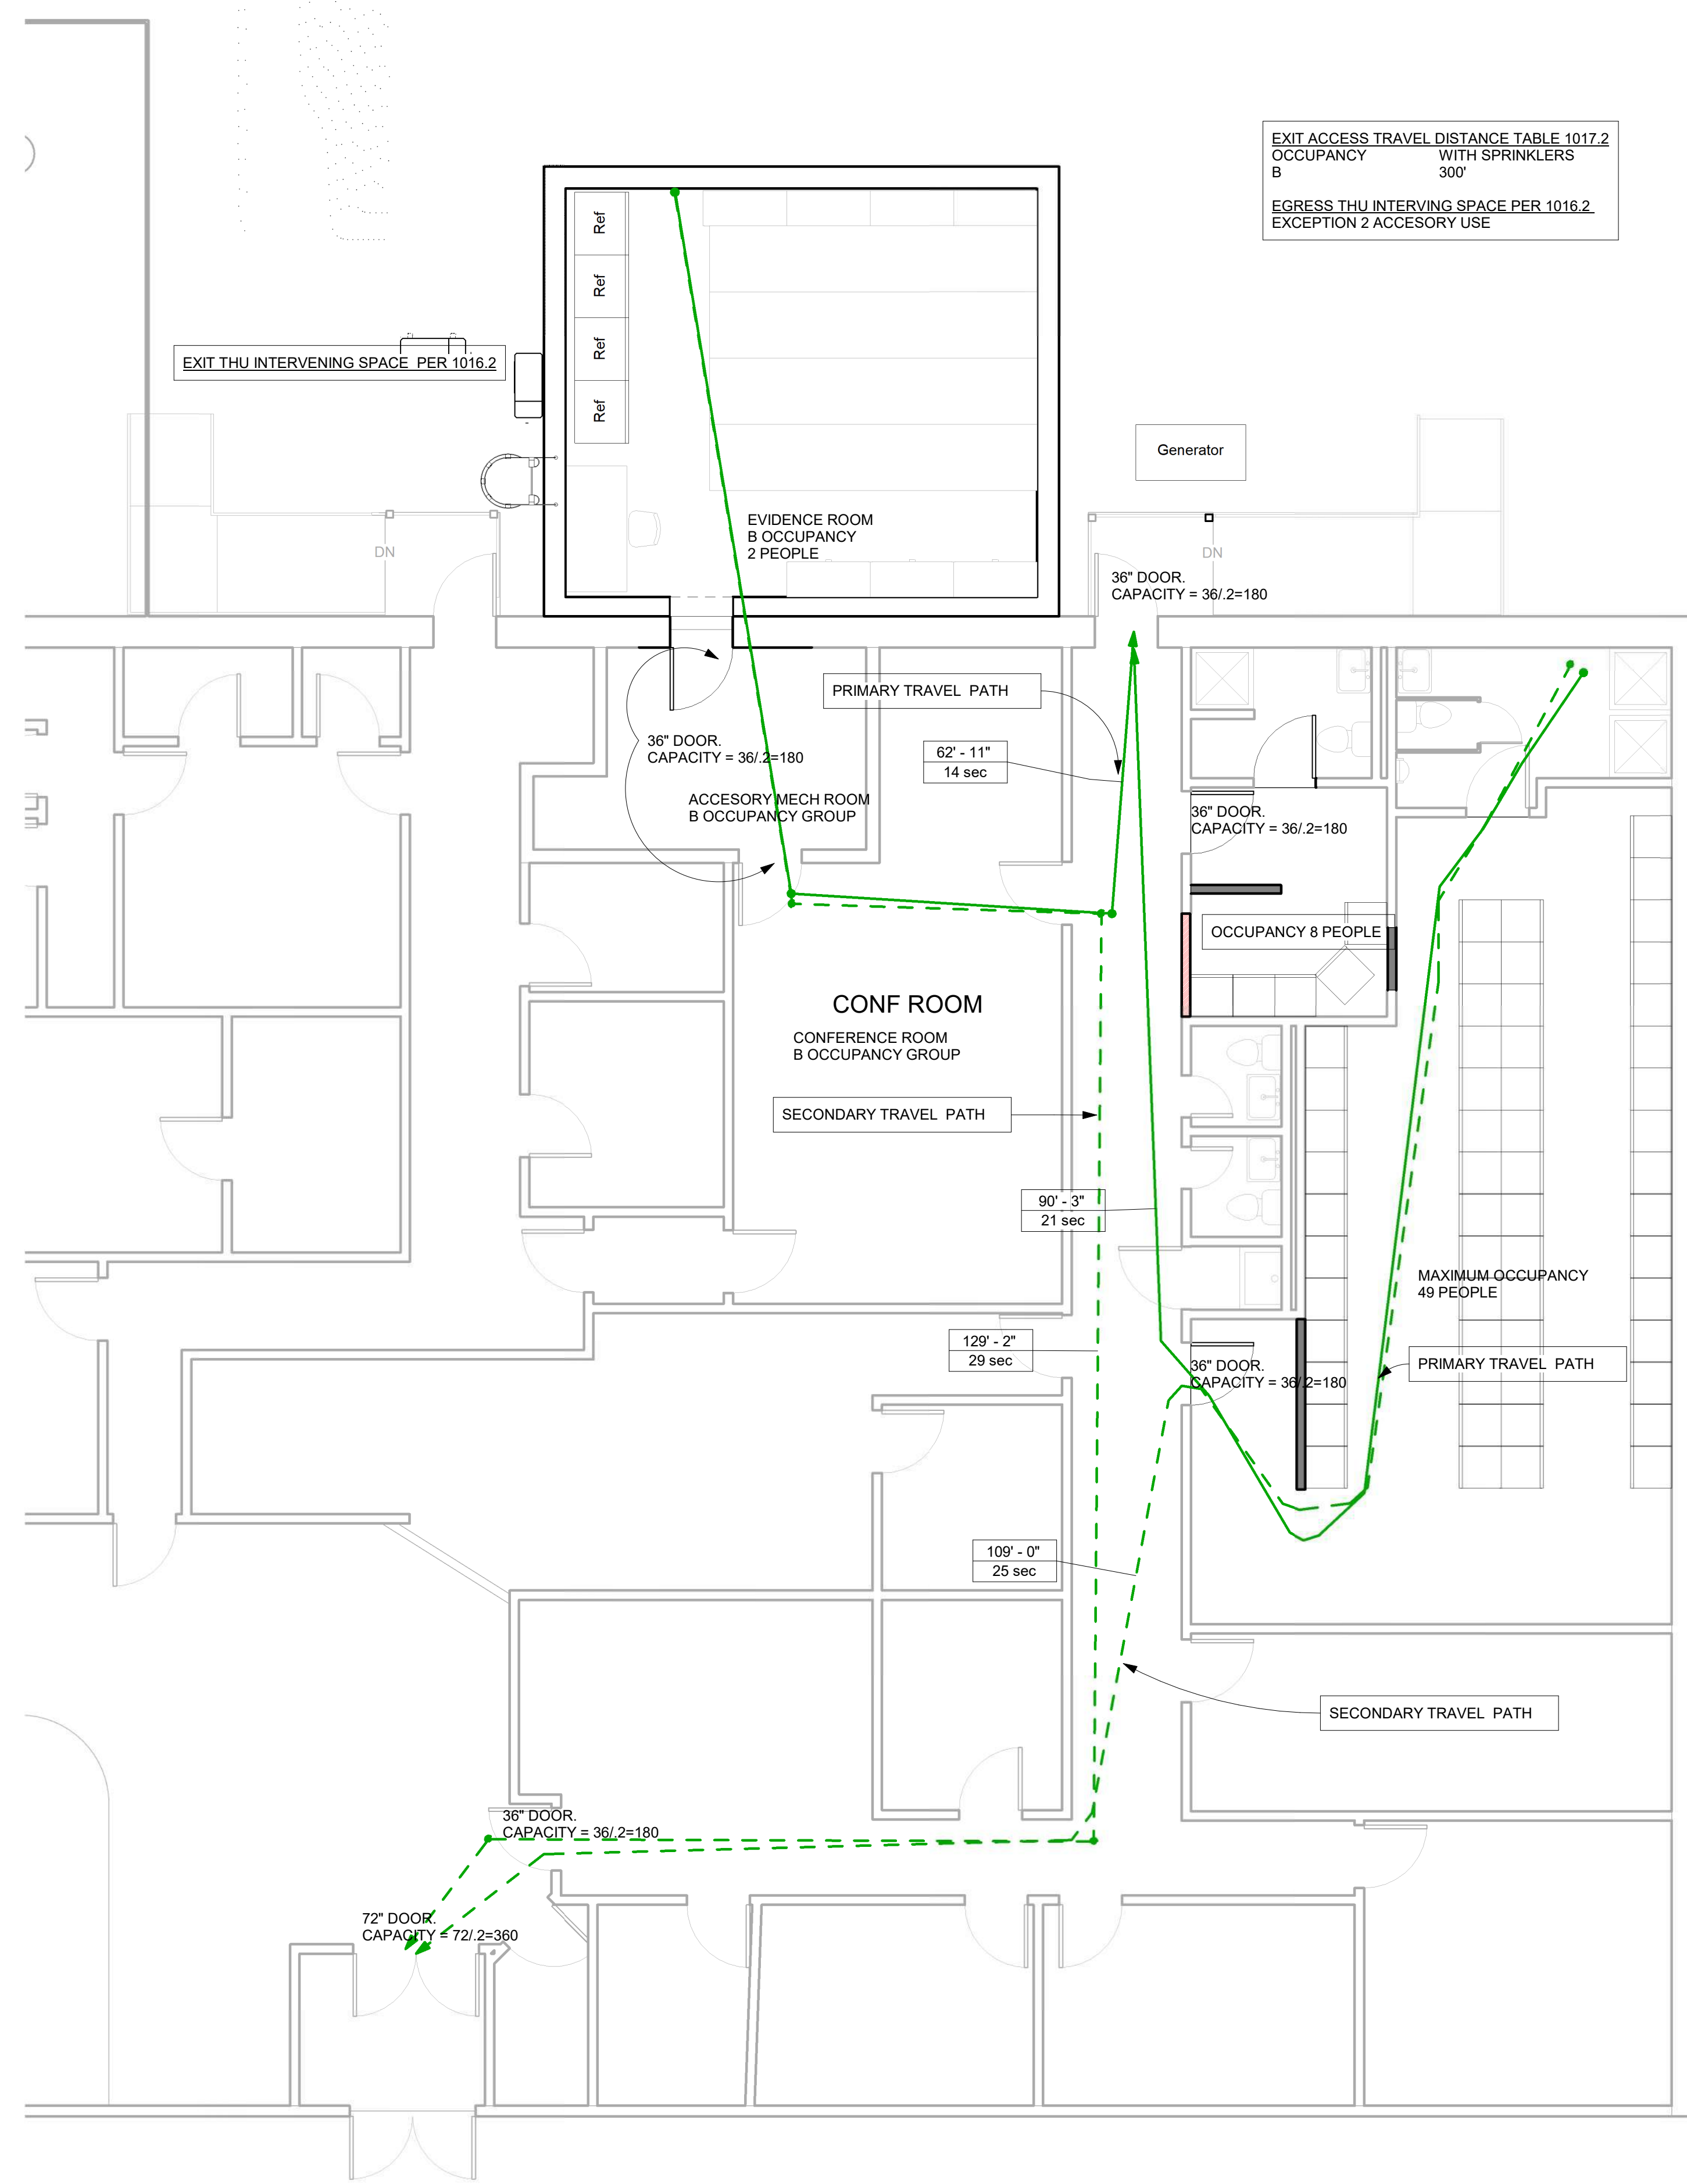


No.	Description	Date
1	ISSUED FOR BID	11/3/23

THESE CAD FILES MAY NOT BE USED, DUPLICATED, MODIFIED OR CHANGED IN ANY MANNER WITHOUT THE WRITTEN CONSENT OF BERG + MOSS ARCHITECTS PC. THE USER AND ITS AGENTS WILL BE LIABLE FOR ANY UNAUTHORIZED USE, DUPLICATION, MODIFICATION OR CHANGE.



SPRING VALLEY POLICE LOCKER UPGRADES

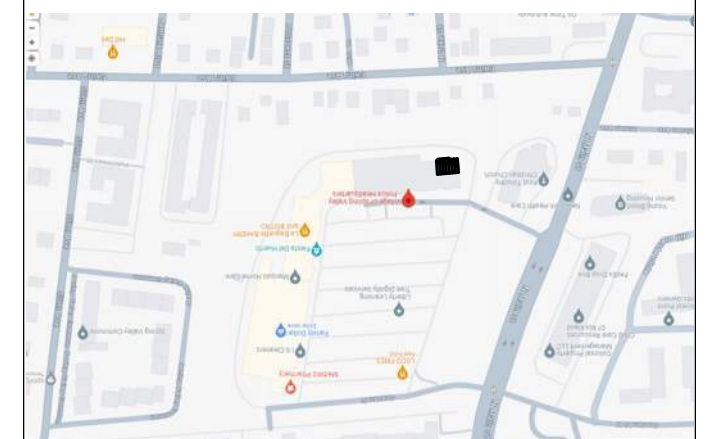

DRAWING TITLE
TITLE SHEET EGRESS PLANS

DRAWING NO.
T-000.00

SEAL & SIGNATURE

ISSUE DATE: 9-27-23
 SCALE: 3/16" = 1'-0"
 DWG BY: Author
 CHK BY: 0

JOB NUMBER