


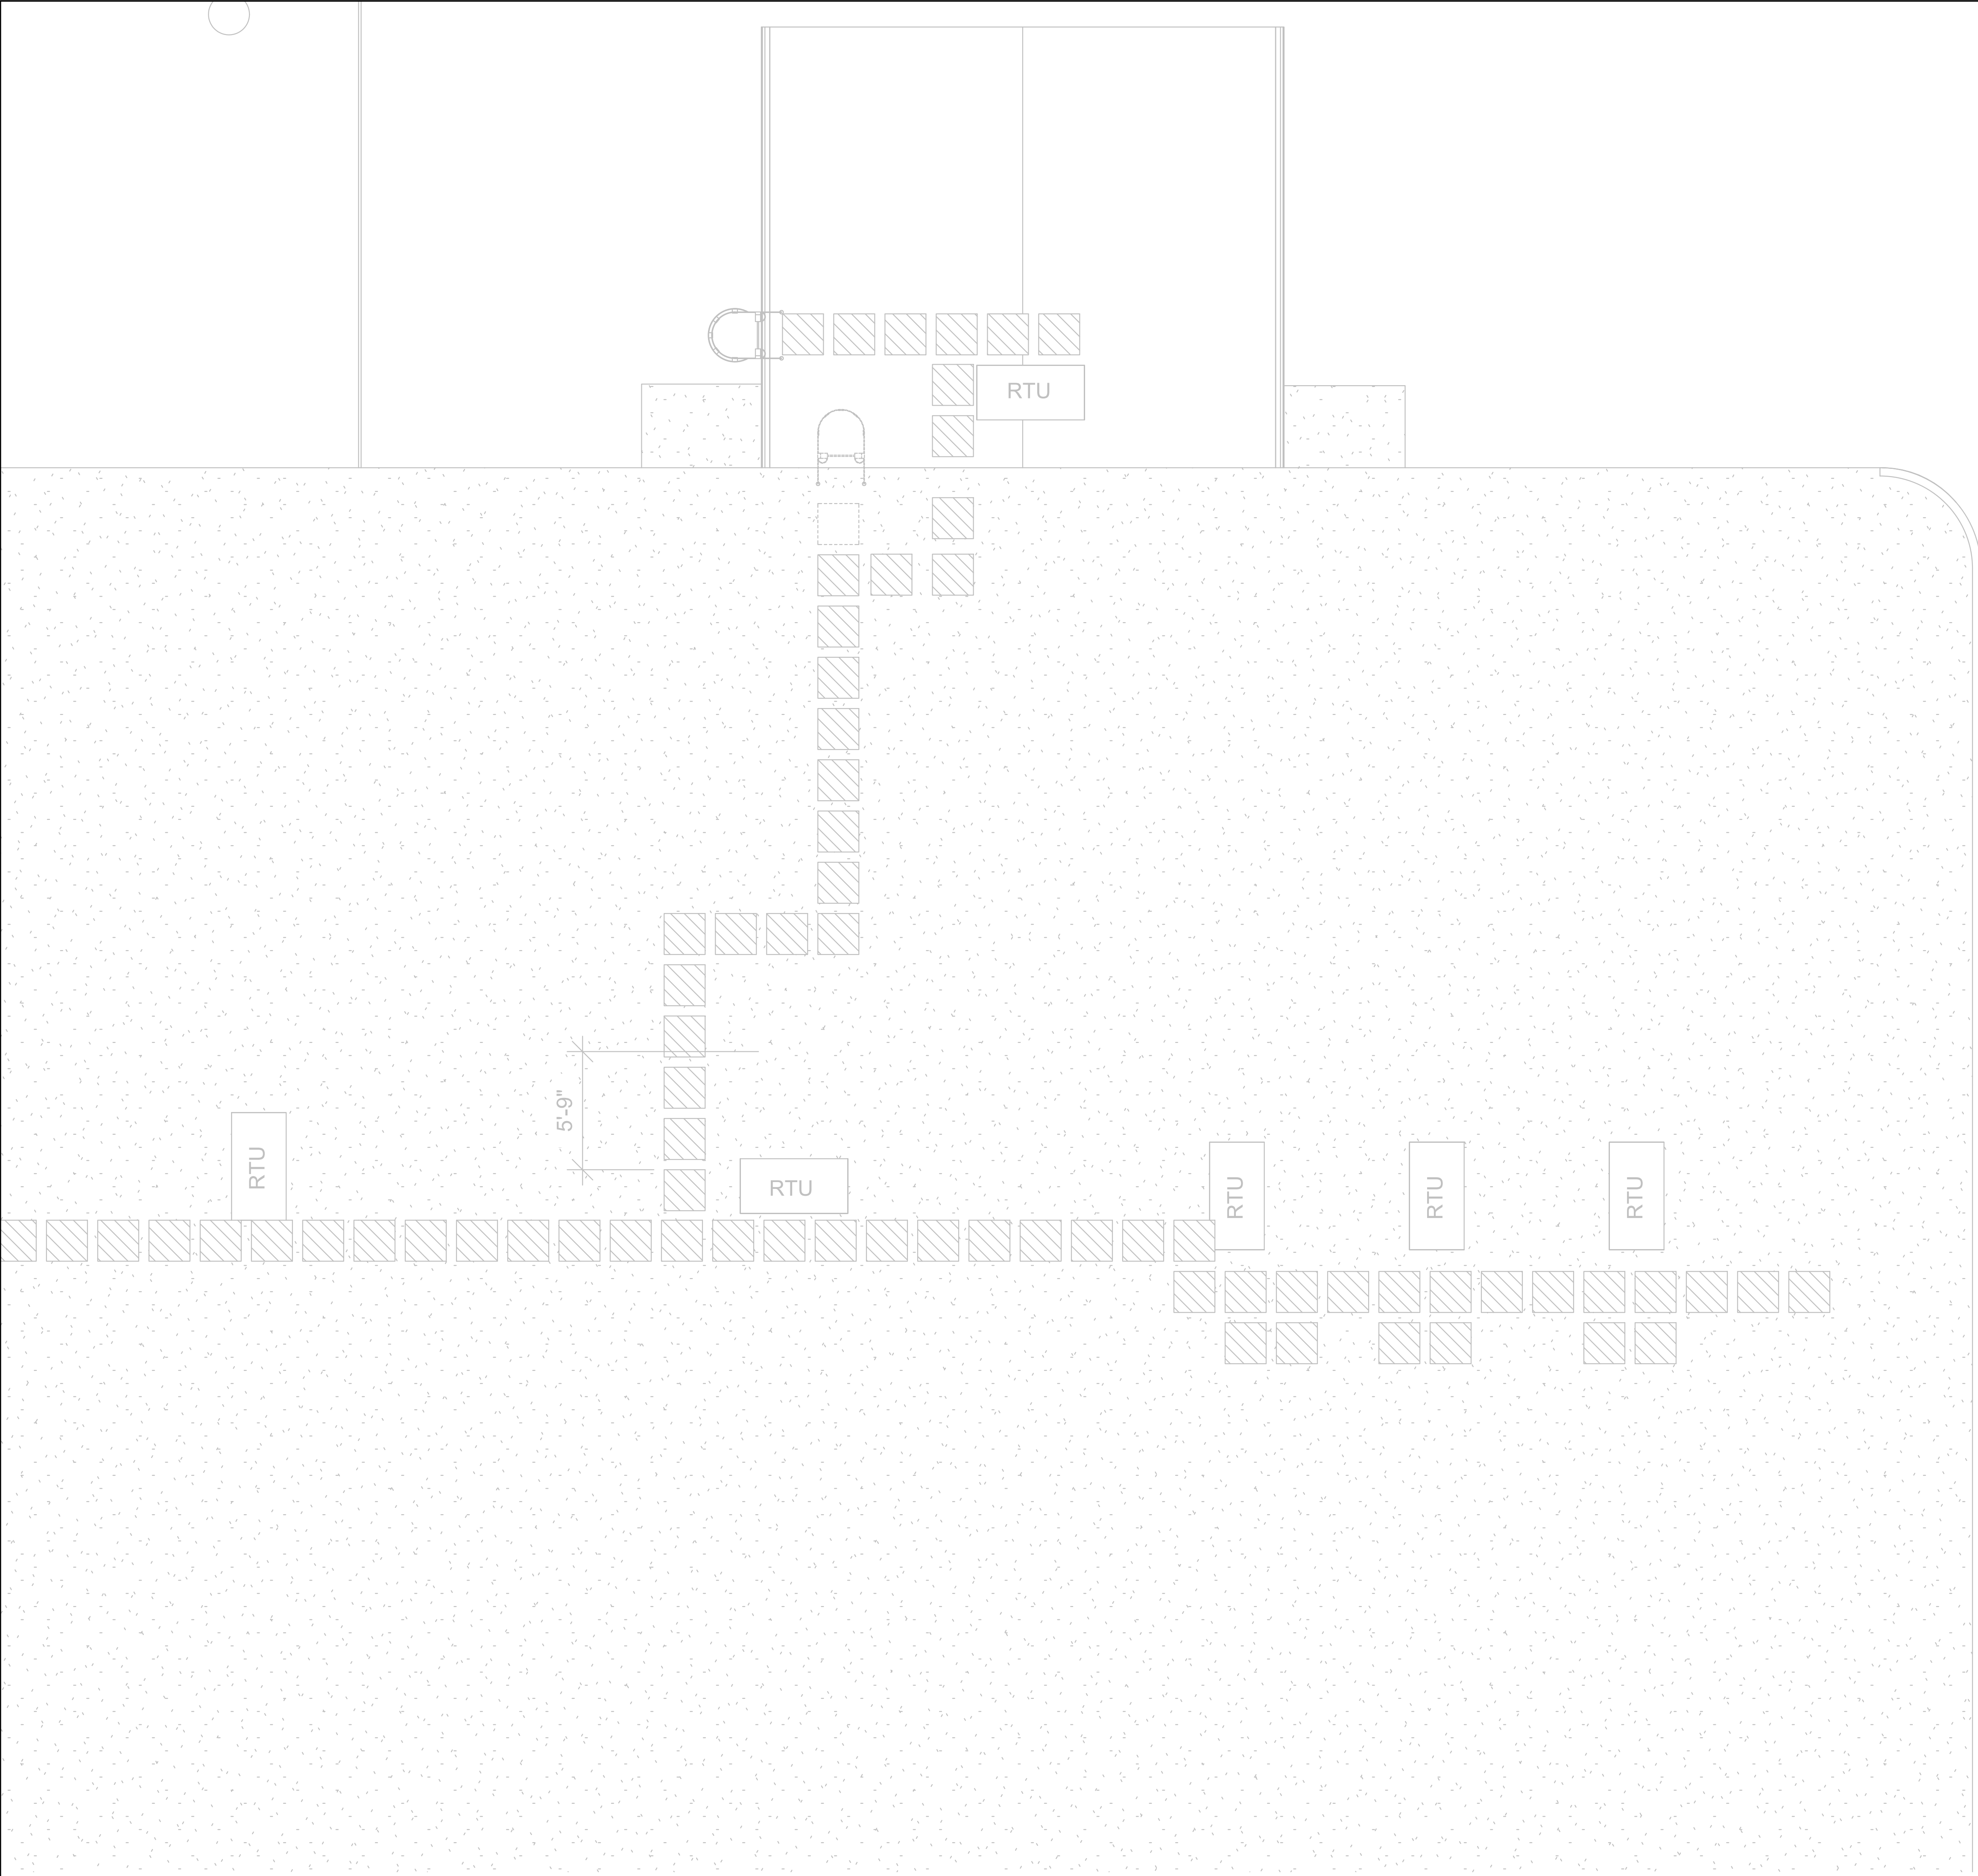

Berg+Moss Architects

BMA

BERG + MOSS ARCHITECTS PC

THE BEACON BUILDING

473 MAIN STREET No. 1

BEACON, NY 12508

T: 845 831 1318

INFO@BERGMOSS.COM

STRUCTURAL/ CIVIL ENGINEERS

Colliers

COLLIERS ENGINEERING & DESIGN

555 Hudson Valley Ave, Ste 101

New Windsor, NY 12553

MECHANICAL ENGINEERS

LEG

AC

LEGACY ENGINEERS

498 Seventh Avenue, 17th Floor South

New York, NY 10018

No.	Description	Date
1	ISSUED FOR BID	11/03/23



SPRING VALLEY
POLICE LOCKER
UPGRADES



DRAWING TITLE
ELECTRICAL ROOF PLAN -
DEMOLITION

DRAWING NO.
E-101.00

SEAL & SIGNATURE

ISSUE DATE: 9-27-23

SCALE: NTS

DWG BY: DWN

CHK BY: CHECK

JOB NUMBER
23025-00