



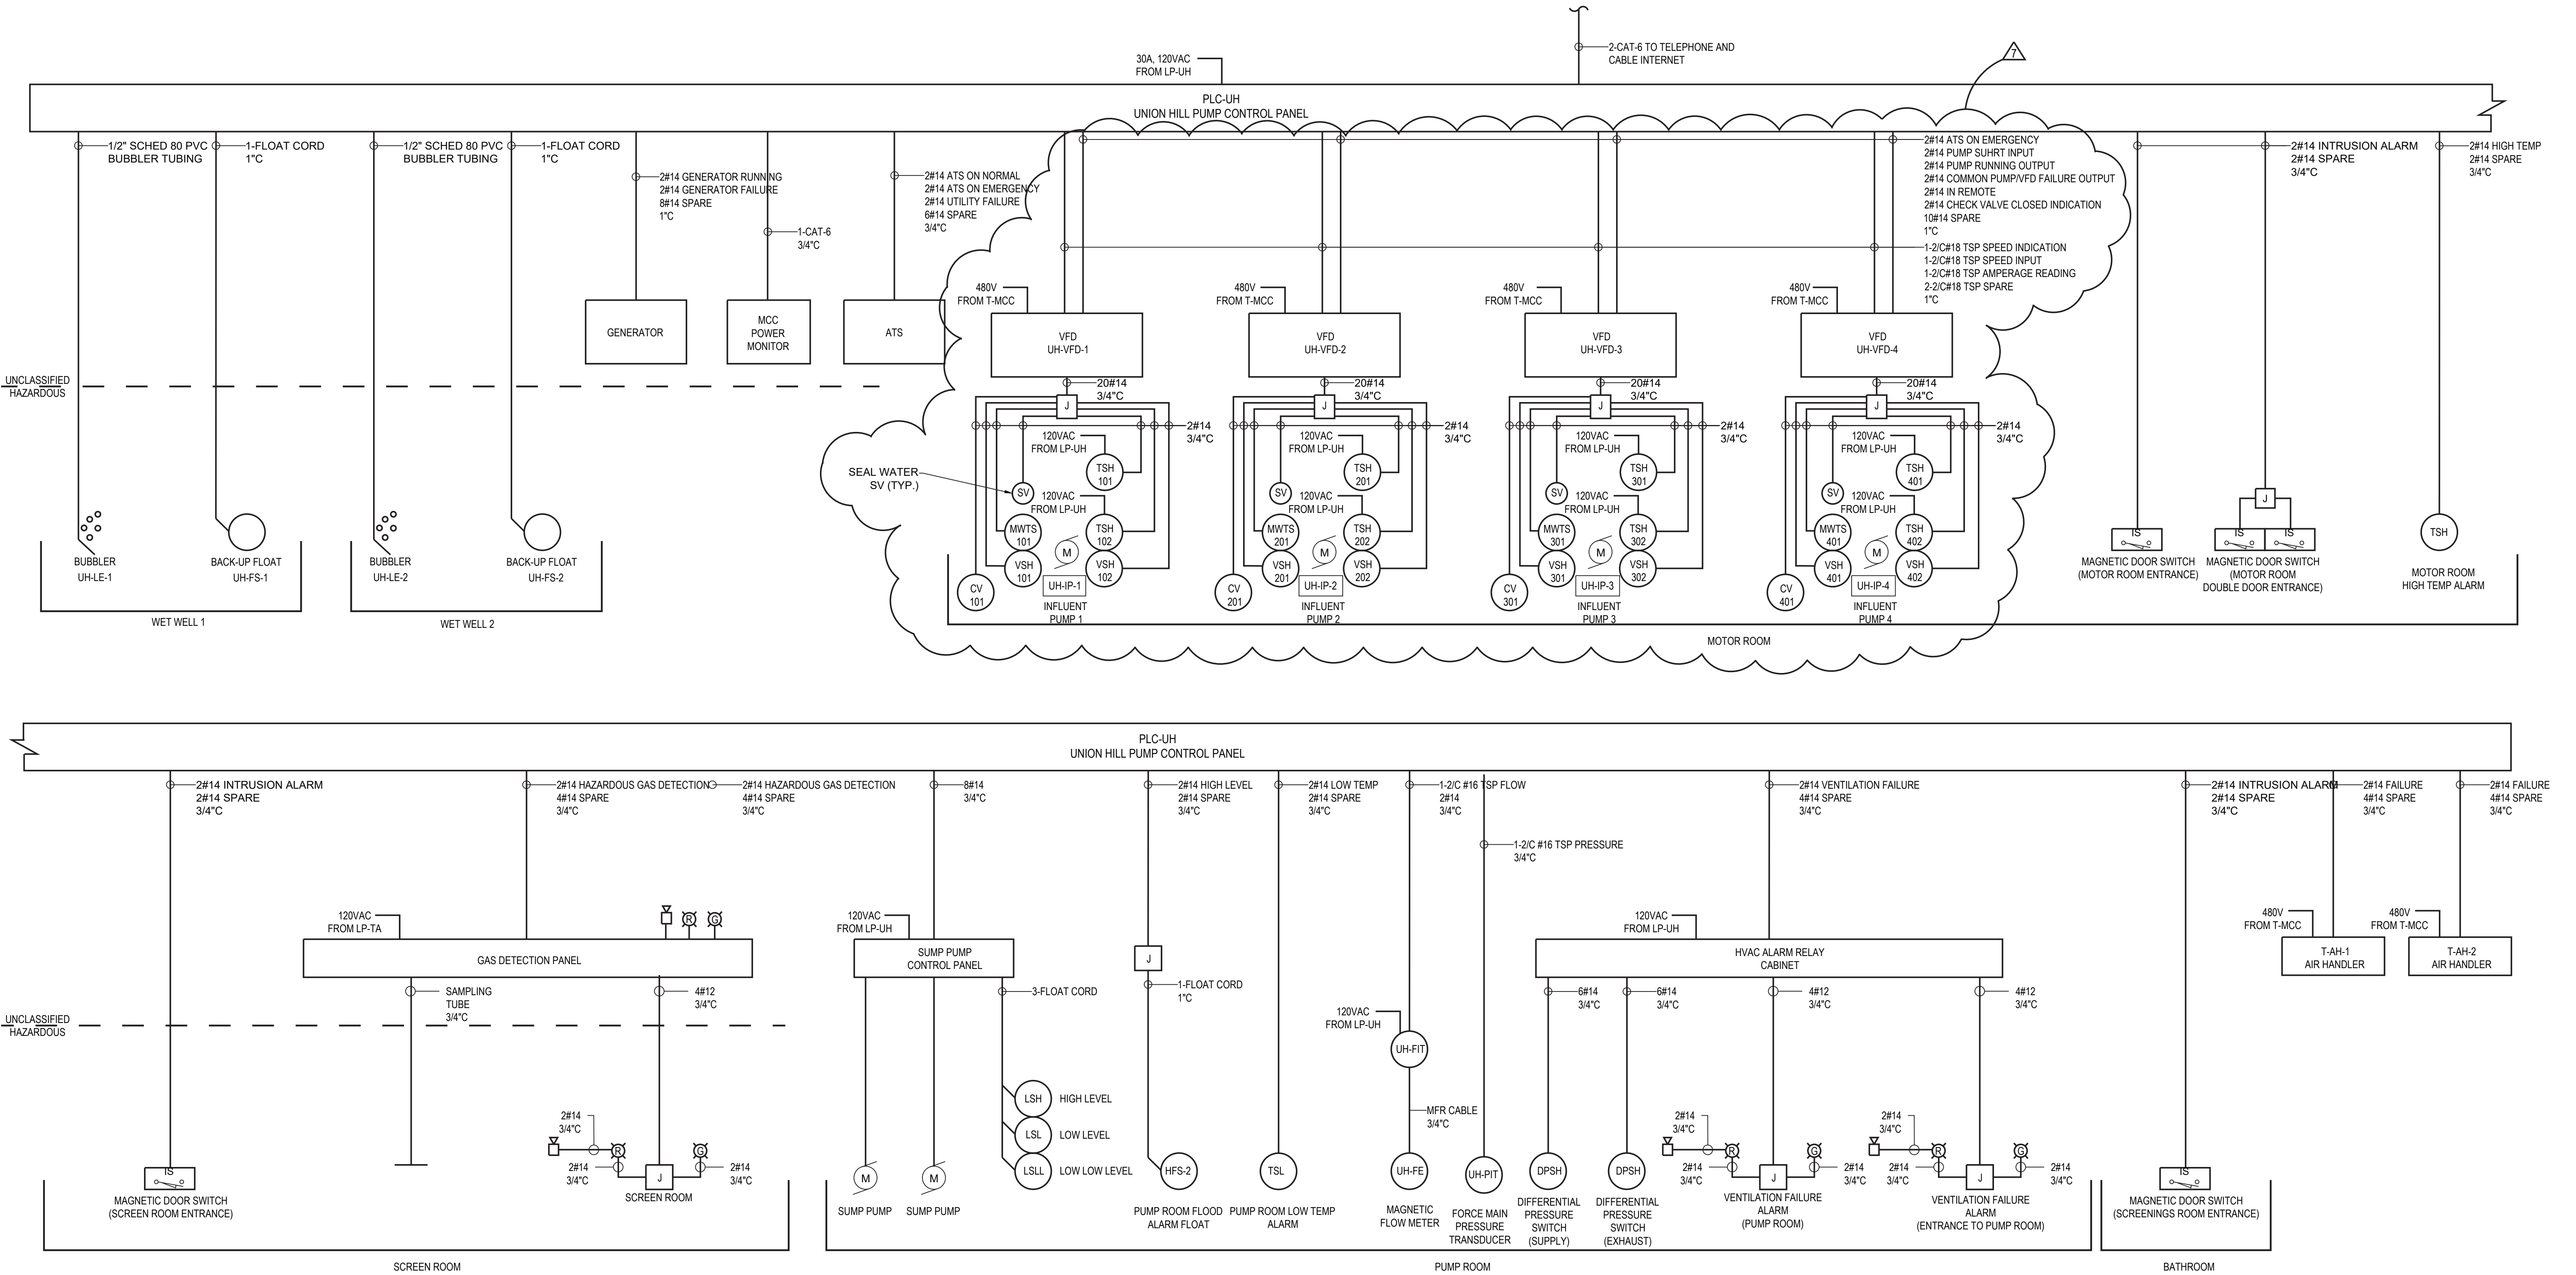

CONTROL SINGLE LINE DIAGRAM
 SCALE: NONE

NOTES:
 1. PROVIDE SEAL-OFFS AS REQUIRED AT HAZARDOUS AREA BOUNDARIES.

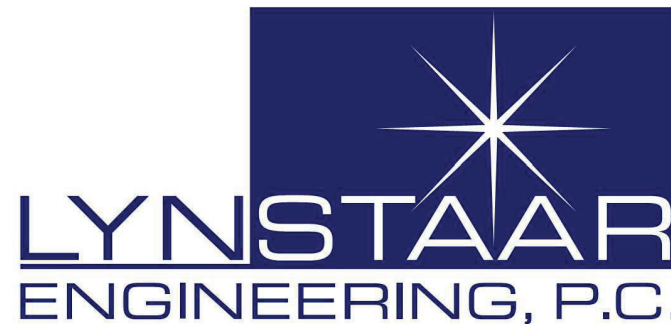

Environmental
 Design & Research,
 Landscape Architecture, Engineering
 & Environmental Services, D.P.C.
 217 Montgomery Street, Suite 1100
 Syracuse, New York 13202
 P. 315.471.0688

PROJECT TITLE: **UNION HILL AND TALLMAN AVE
 PUMP STATION UPGRADE**

PROJECT LOCATION: **ROCKLAND COUNTY, NEW YORK**
 CLIENT: **ROCKLAND COUNTY SEWER DISTRICT No 1**

DRAWING TITLE: **UNION HILL PUMP STATION CONTROL DIAGRAM**

DRAWINGS ISSUED FOR / REVISIONS				CONTRACT #RFB-RC-SWR-2022-06		
NO.	DATE	ISSUED FOR / REVISION	BY	CHK	APP	EDR JOB#: 21213
7	08/2023	ADDENDUM 4	LSE	JGD	GRL	DATE: 06/2023
2	07/22	90 PERCENT DESIGN REVIEW	LSE	JGD	GRL	SCALE: NO SCALE
3	09/22	FOR REGULATORY REVIEW	LSE	JGD	GRL	DRAWN BY: BL
4	01/23	100 PERCENT DESIGN REVIEW	LSE	JGD	GRL	CHECKED BY: GRL/JGD
5	03/23	100 PERCENT DESIGN REVIEW	LSE	JGD	GRL	DRAWING NUMBER:
6	06/23	FOR BID	LSE	JGD	GRL	E-110

CONTRACT
1