


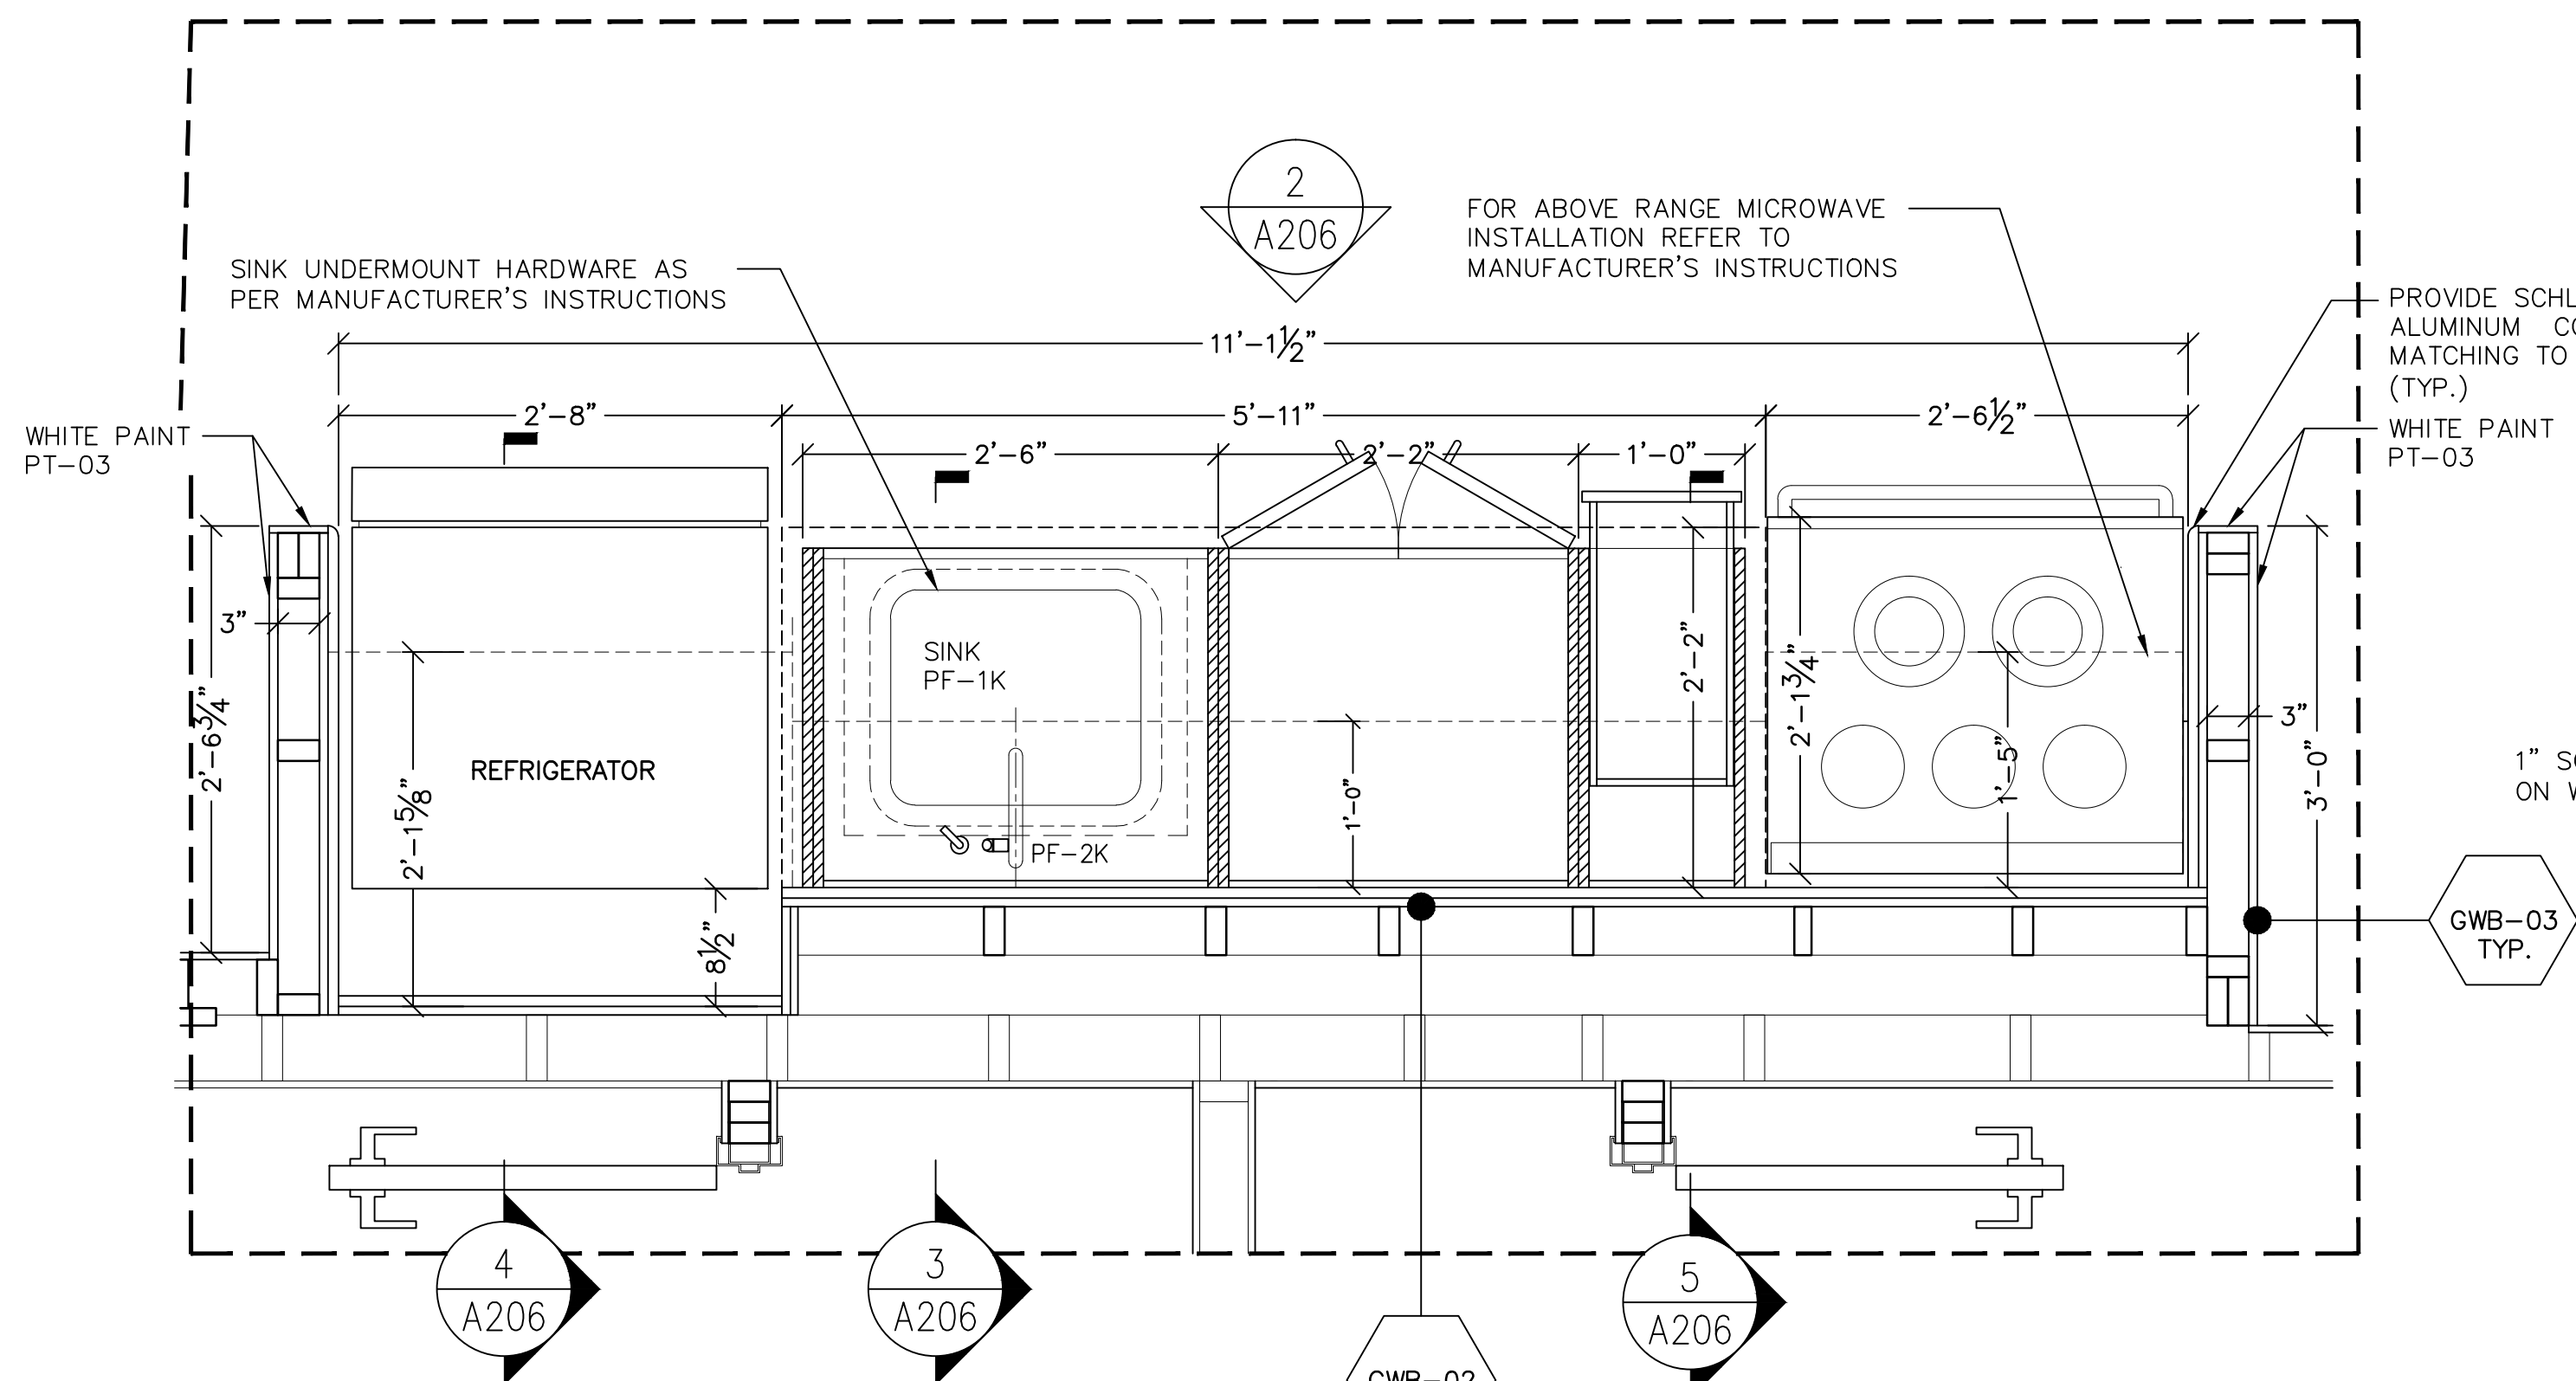


1 ENLARGED LAYOUT PLAN

A206

0 6" 1' 2' 4'

SCALE: 1" = 1'-0"

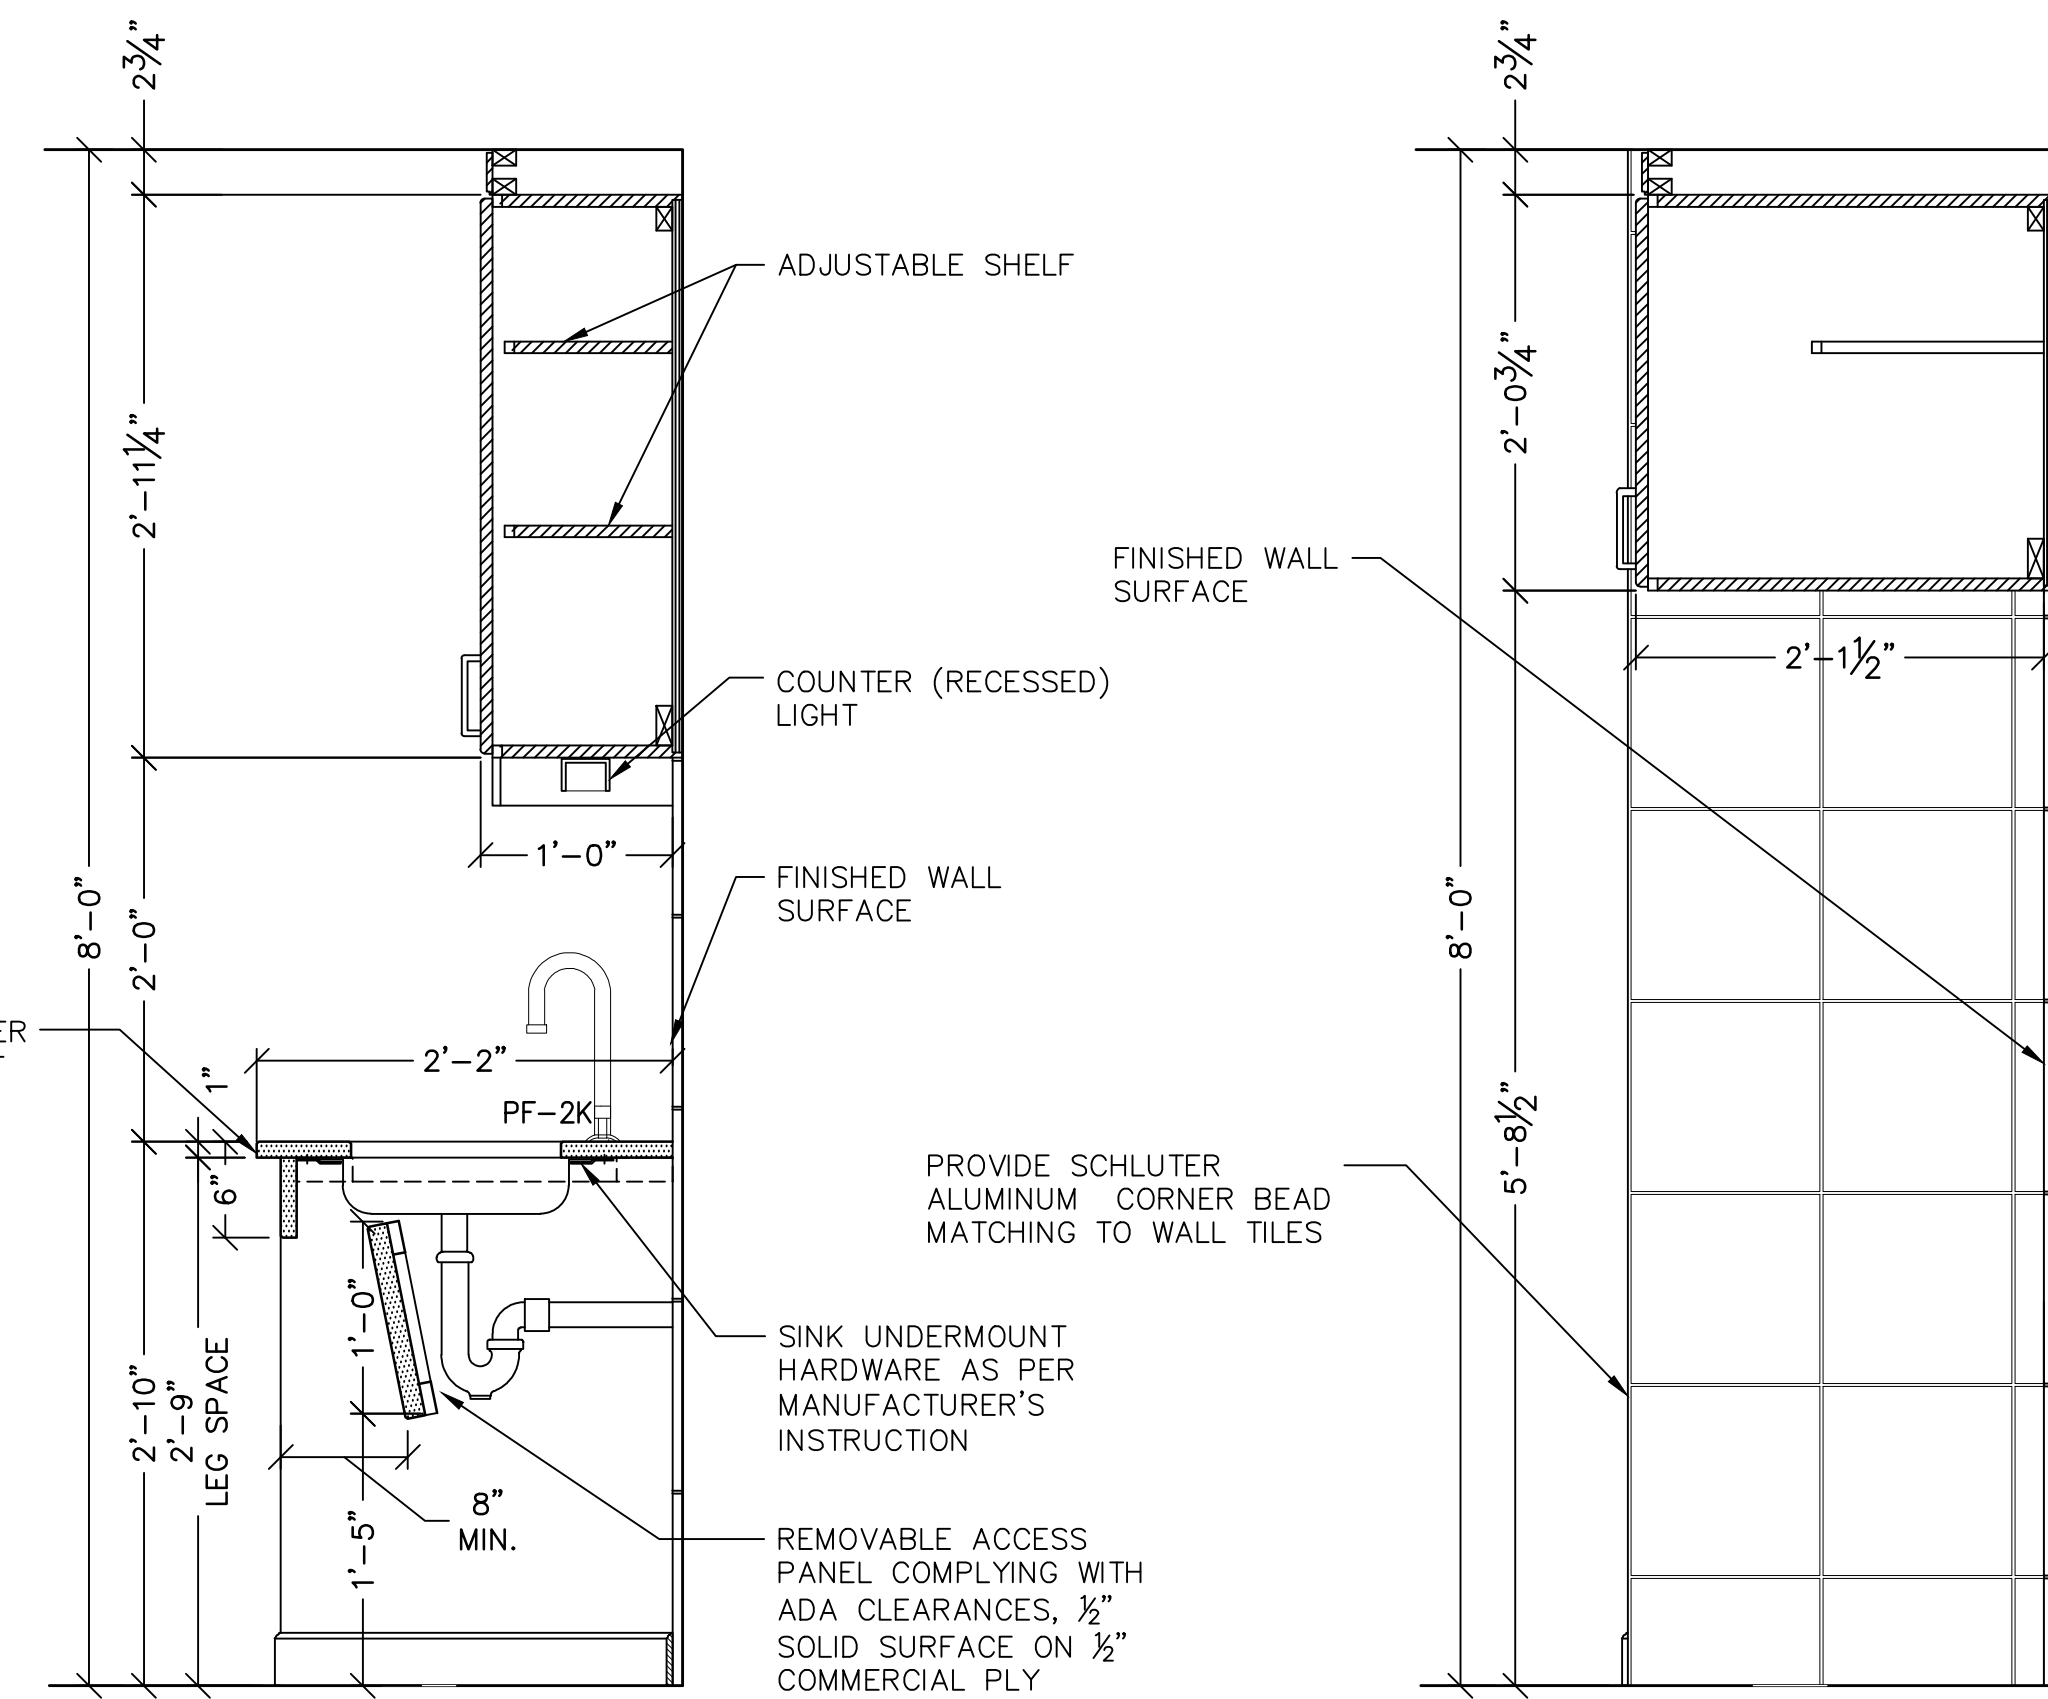

3 SECTION @ SINK

A206

0 6" 1' 2' 4'


SCALE: 1" = 1'-0"

4 SECTION @ REFRIGERATOR

A206

0 6" 1' 2' 4'

SCALE: 1" = 1'-0"

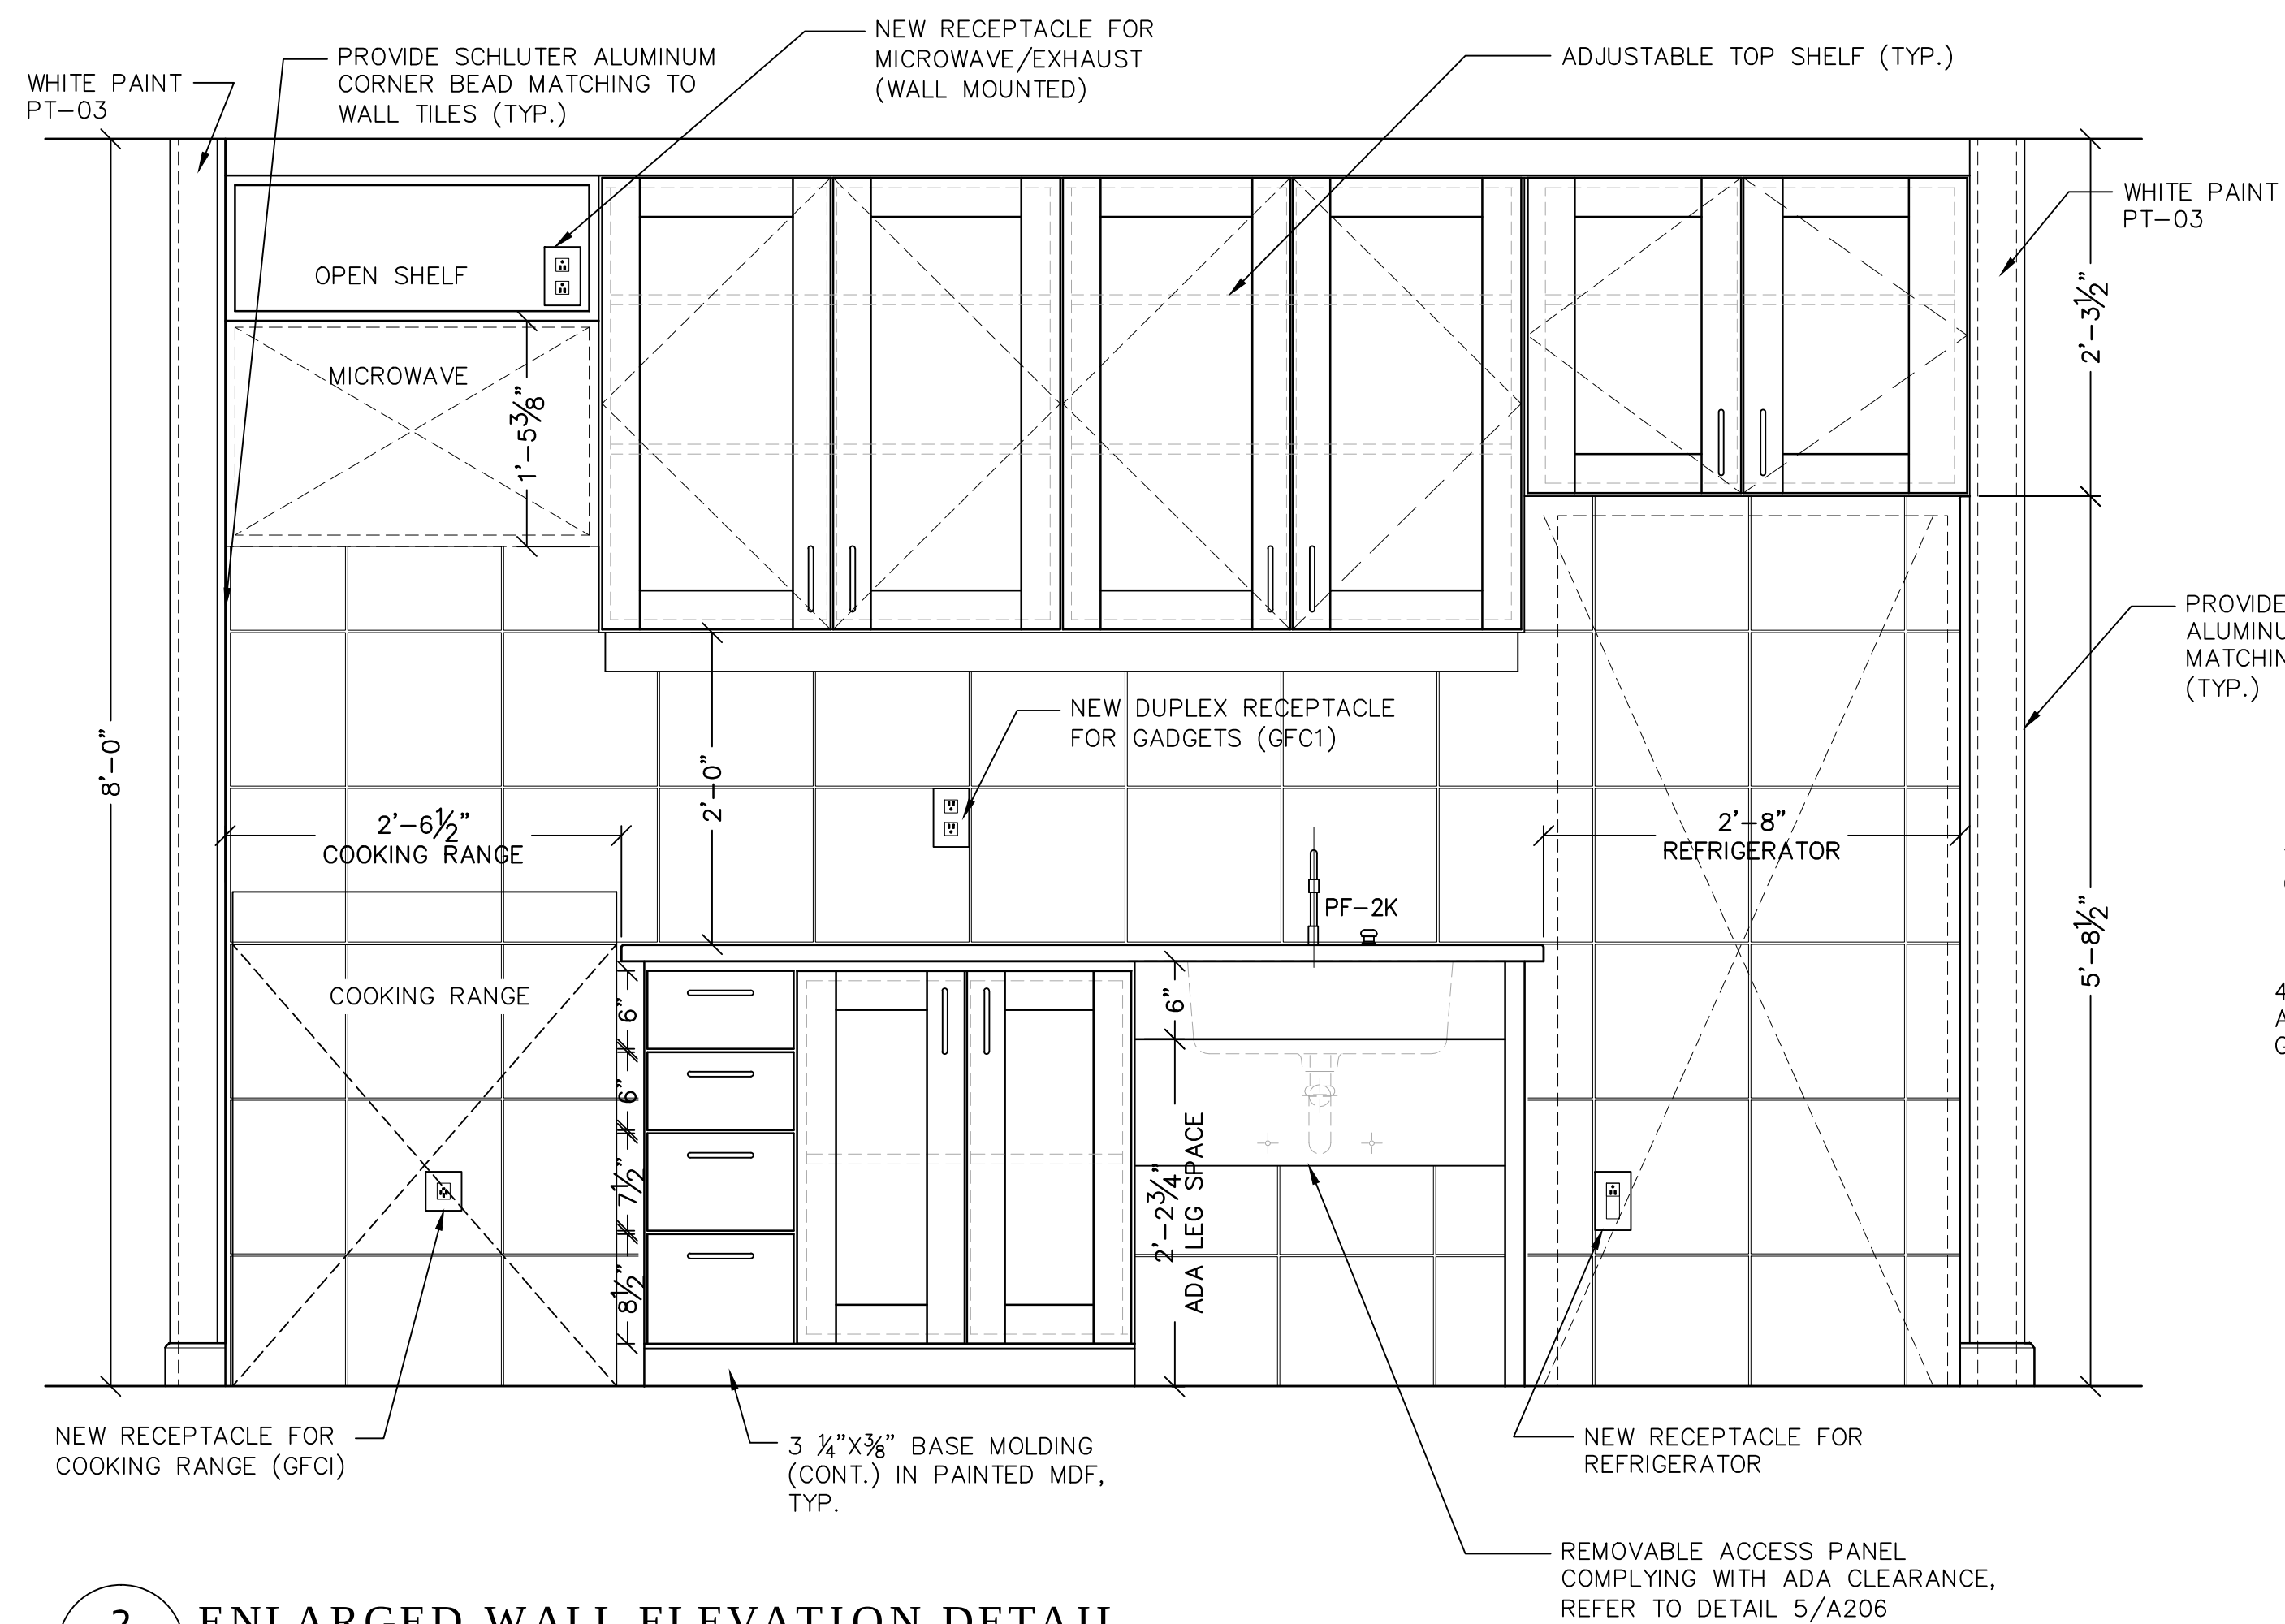


2 ENLARGED WALL ELEVATION DETAIL

A206

0 6" 1' 2' 4'

SCALE: 1" = 1'-0"

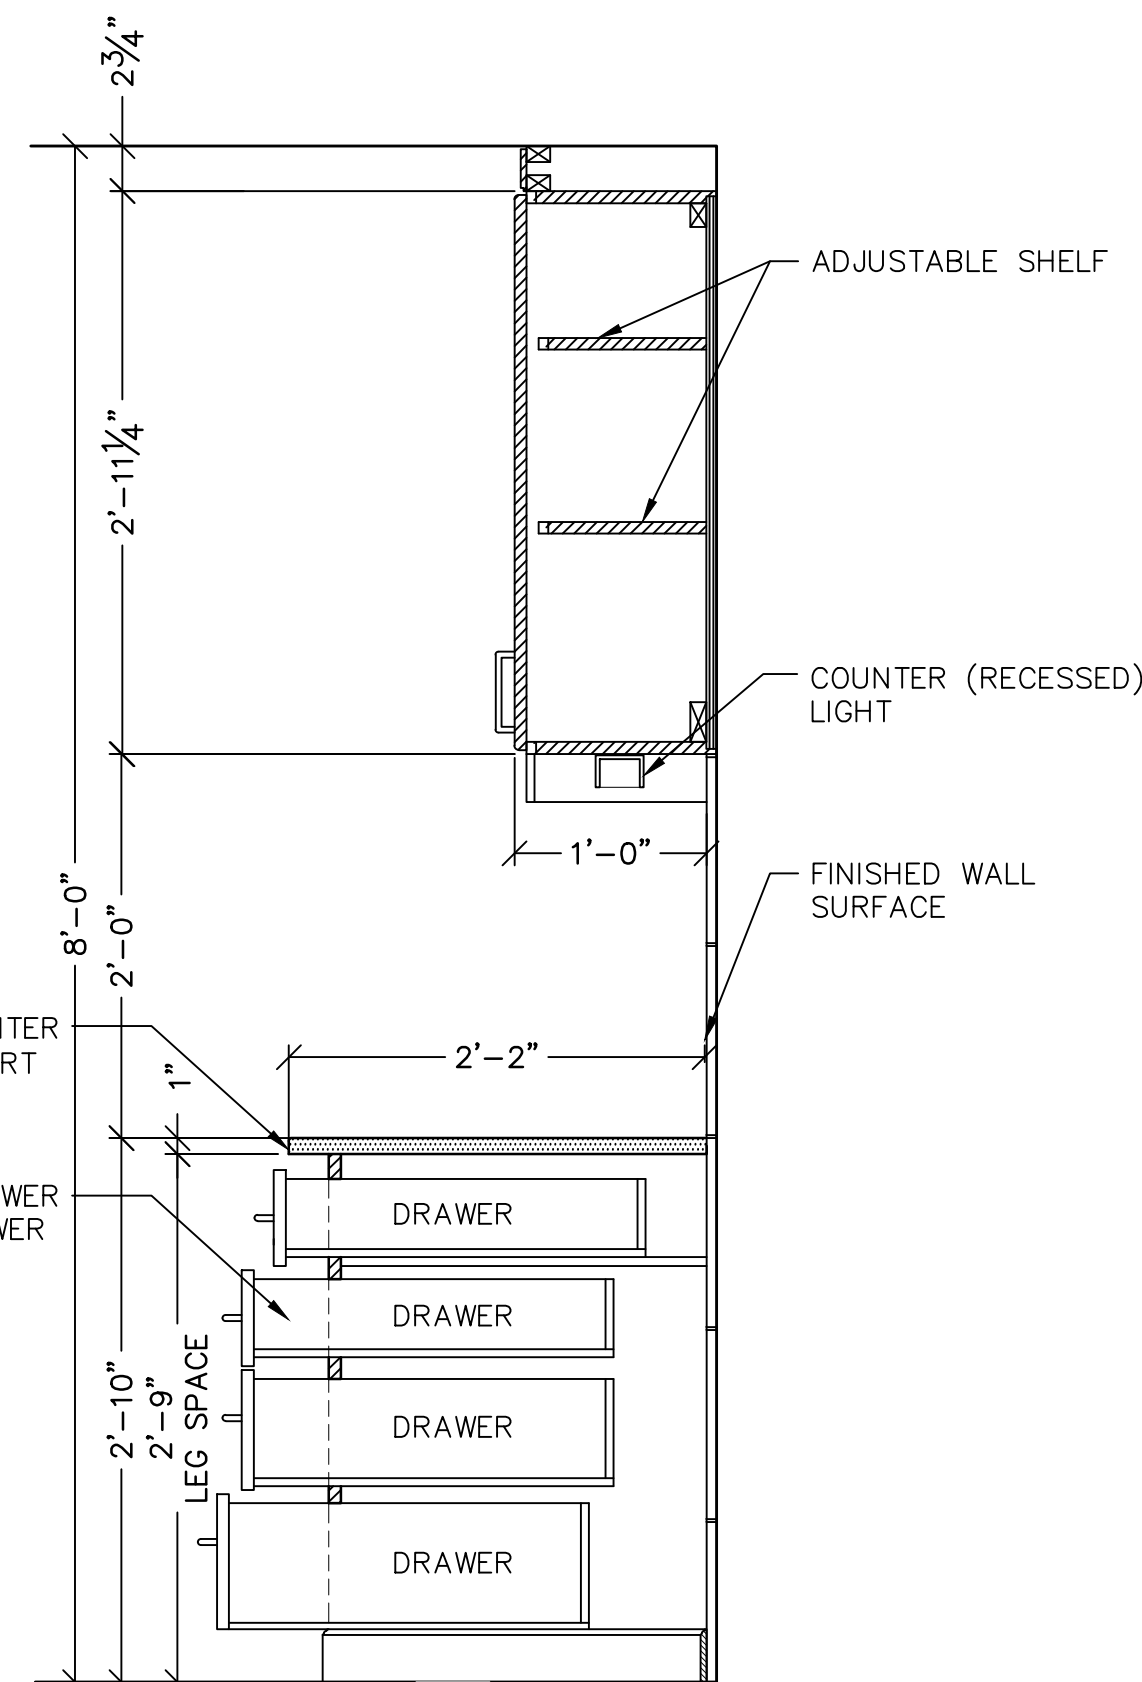

5 SECTION @ KITCHEN DRAWERS

A206

0 6" 1' 2' 4'

SCALE: 1" = 1'-0"

NOTES

1. LEVEL SUBFLOOR AS REQUIRED PRIOR TO INSTALLING FINISH FLOOR.
2. STAGGER SUBFLOOR JOINTS IN BOTH DIRECTIONS.
3. PROVIDE COLOR SAMPLES AND FULL SIZE TILE SAMPLES FOR APPROVAL PRIOR TO INSTALLATION OF TILES/VINYL PLANKS.
4. FOR SHOWER AREA, BATHROOM AND KITCHEN WALLS, USE SCHLUTER KERDI MEMBRANE, CORNER STRIPS AND FIXTURE AND FAUCET SEALS.
5. FOR BATHROOM FLOOR UNCOUPLING MEMBRANE, USE SCHLUTER DITRA OR APPROVED EQUAL.
6. DOOR STOP IN BATHROOM, TO BE INSTALLED ON BASEBOARD/TILED WALL. DO NOT INSTALL ON FINISH FLOOR.
7. ELECTRICAL RECEPTACLES NEAR WET AREA TO BE GFCI OUTLETS.

LEGEND

- VINYL FLOOR PLANK (VF-01)
- CERAMIC TILES (KITCHEN)
- 12"x12" CERAMIC FLOOR TILES (BATHROOM)
- 2"x2" CERAMIC FLOOR TILES (SHOWER)
- PLYWOOD/SUBFLOOR

AFRIDI ASSOCIATES CONSULTING ENGINEERS

19 West 21st Street
New York, NY 10010
Tel: (212) 243-0725
Fax: (212) 243-0725

510 Broadhollow Road
Melville, NY 11747
Tel: (631) 465-0786
Fax: (631) 465-0788

aafridi@afridiassociates.com

LIZARDOS

LONG ISLAND | NEW YORK CITY | CHARLOTTE | DANBURY

200 Old Country Road | Suite 670
Mineola, NY 11501
516 484 1020 Lizardos.com

Lizardos Engineering Associates D.P.C.

Designer: AKBER AFRIDI, P.E.
Drawn by: AZHER MALIK
Checked by: AKBER AFRIDI, P.E.

Project: INTERIOR RENOVATIONS OF THE COMMONS APARTMENTS 10.1 (ADA COMPLIANT) & 10.3

Address:
735 Anderson Hill Road
Purchase NY 10577


Drawing Title:
ENLARGED KITCHEN DETAILS,
ADA APARTMENT 10.1

Drawing No.:
A206.00


Scale: AS NOTED

Date: 08/24/2020


SU-040623

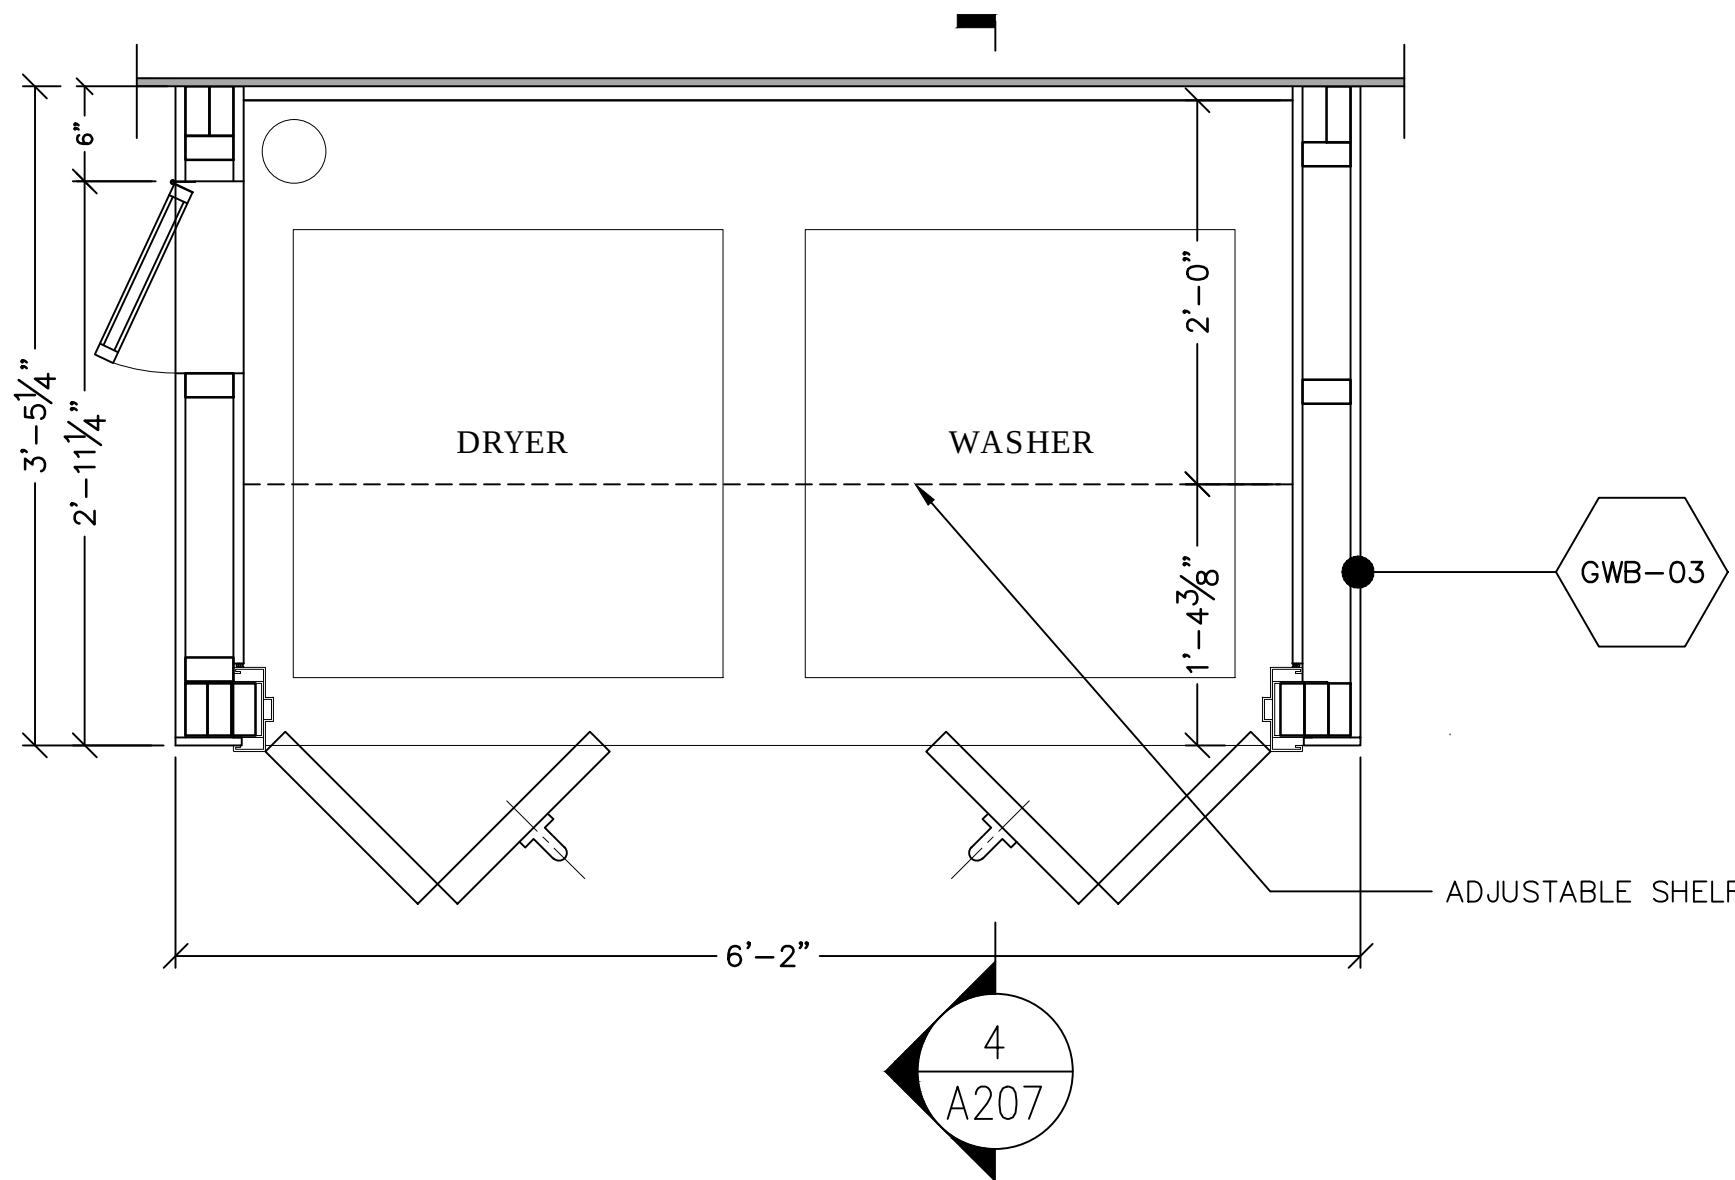


1 ADA LAUNDRY/UTILITY CLOSET
A207
0 6" 1' 2' 4'
SCALE: 1" = 1'-0"

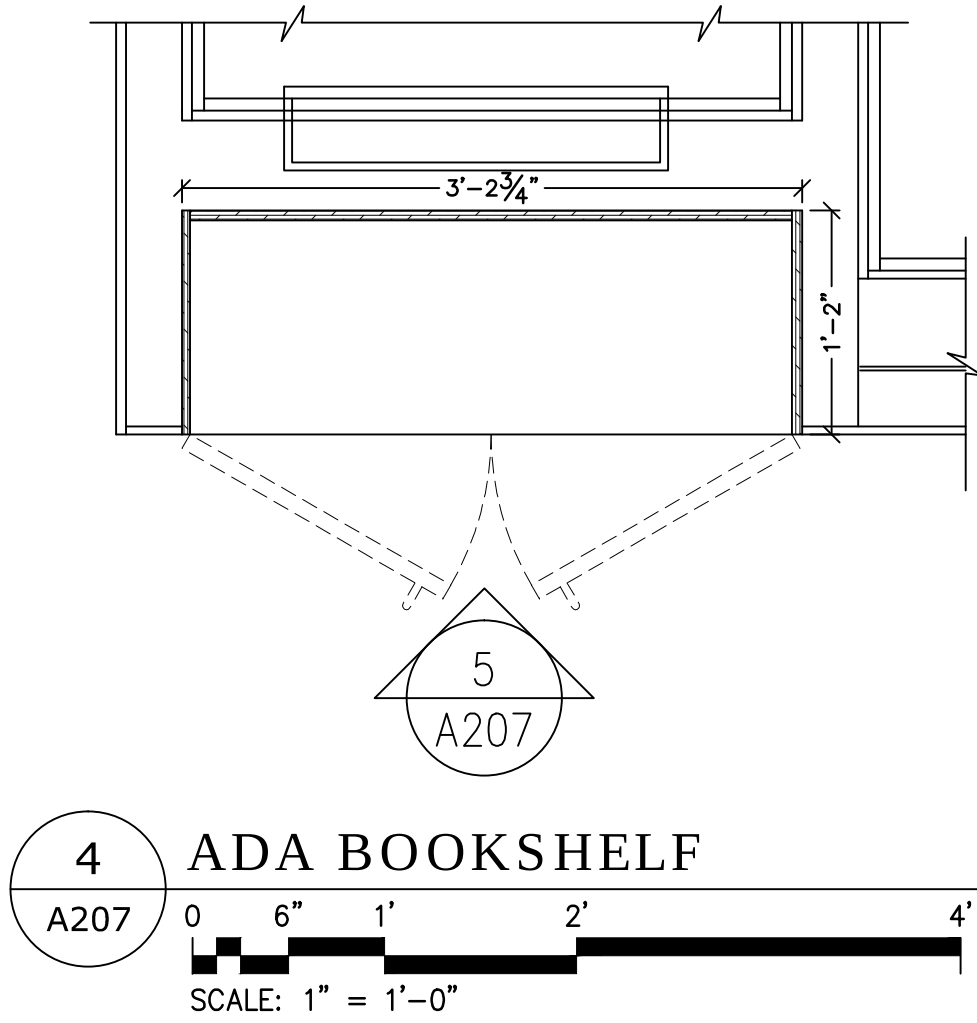


4 ADA BOOKSHELF
A207
0 6" 1' 2' 4'
SCALE: 1" = 1'-0"

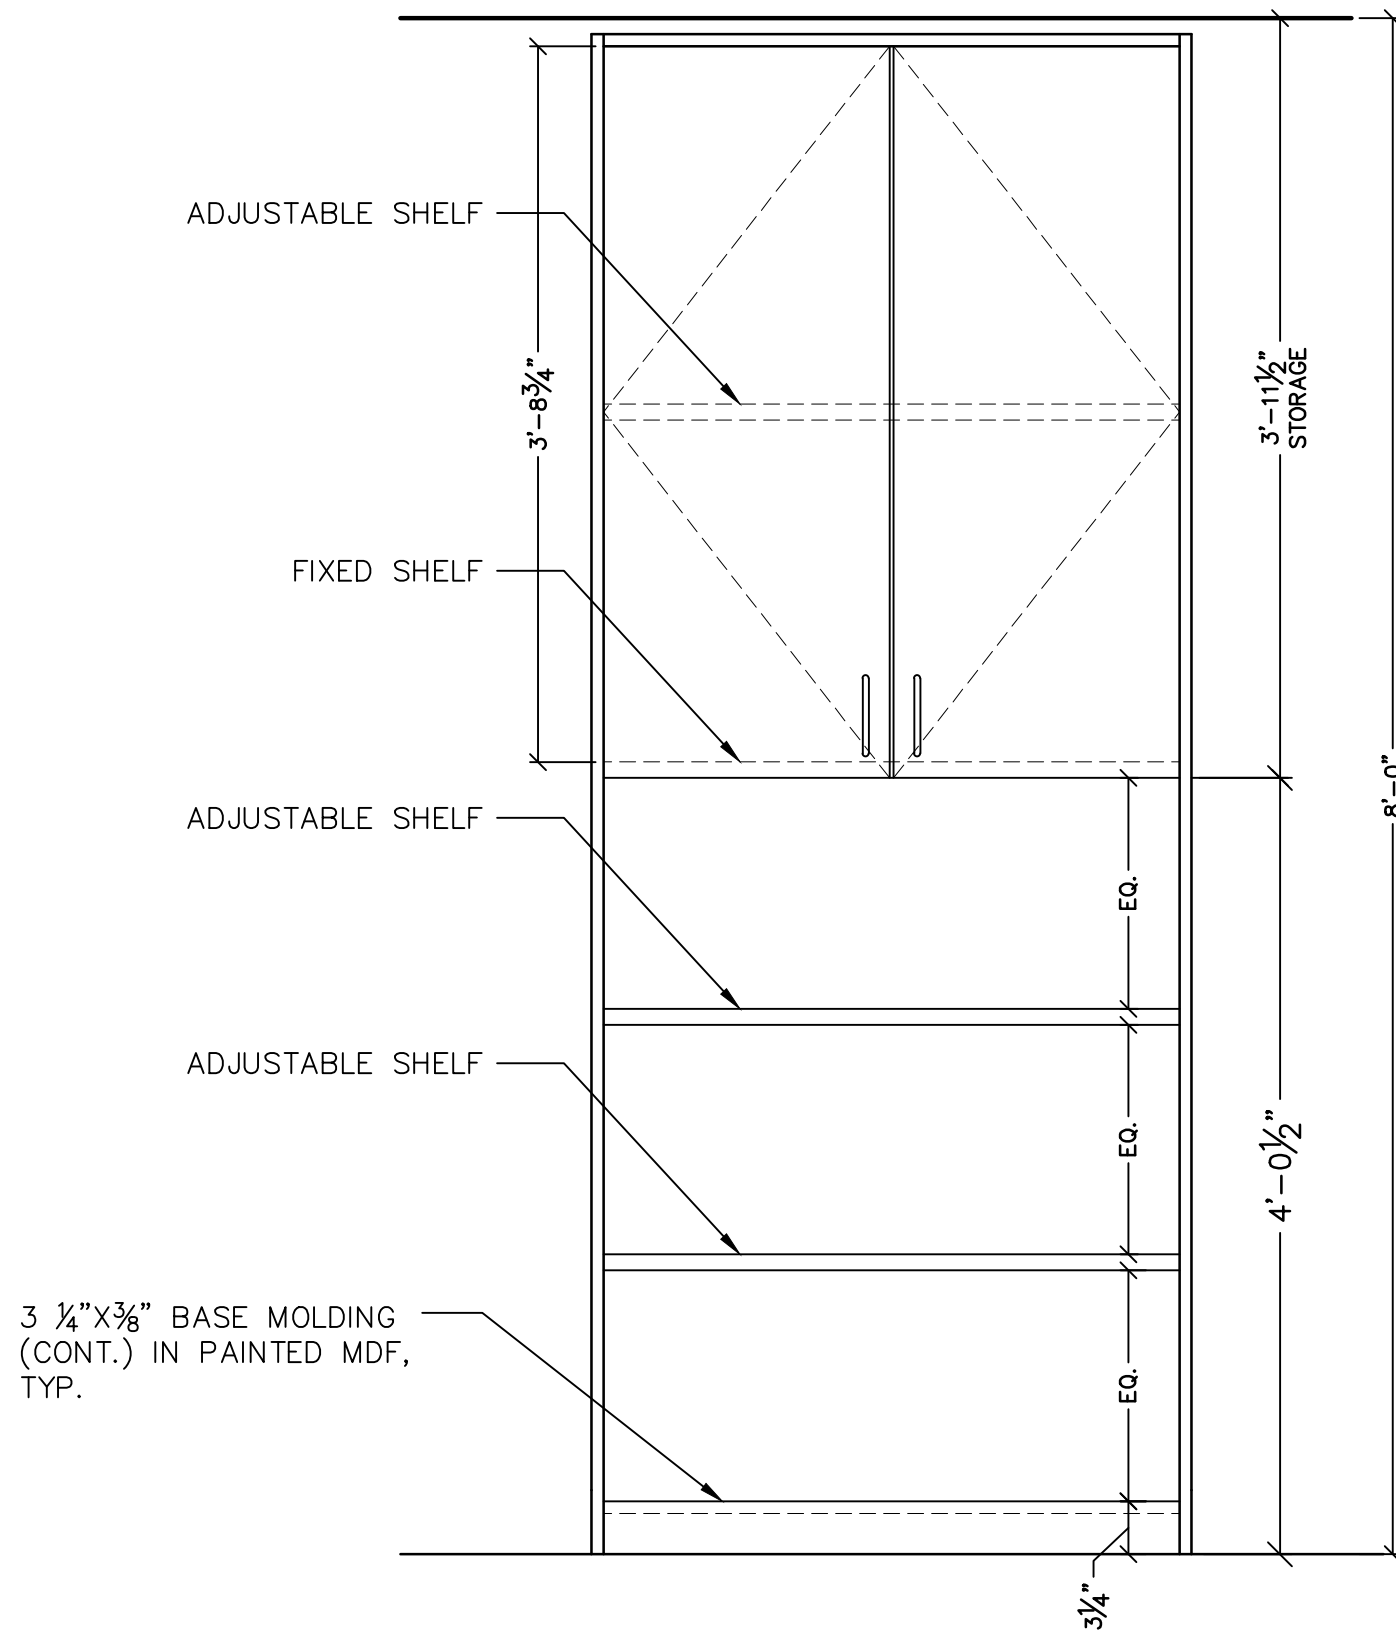

5 ELEV. BOOK SHELF (10.1)
A207
0 6" 1' 2' 4'
SCALE: 1" = 1'-0"

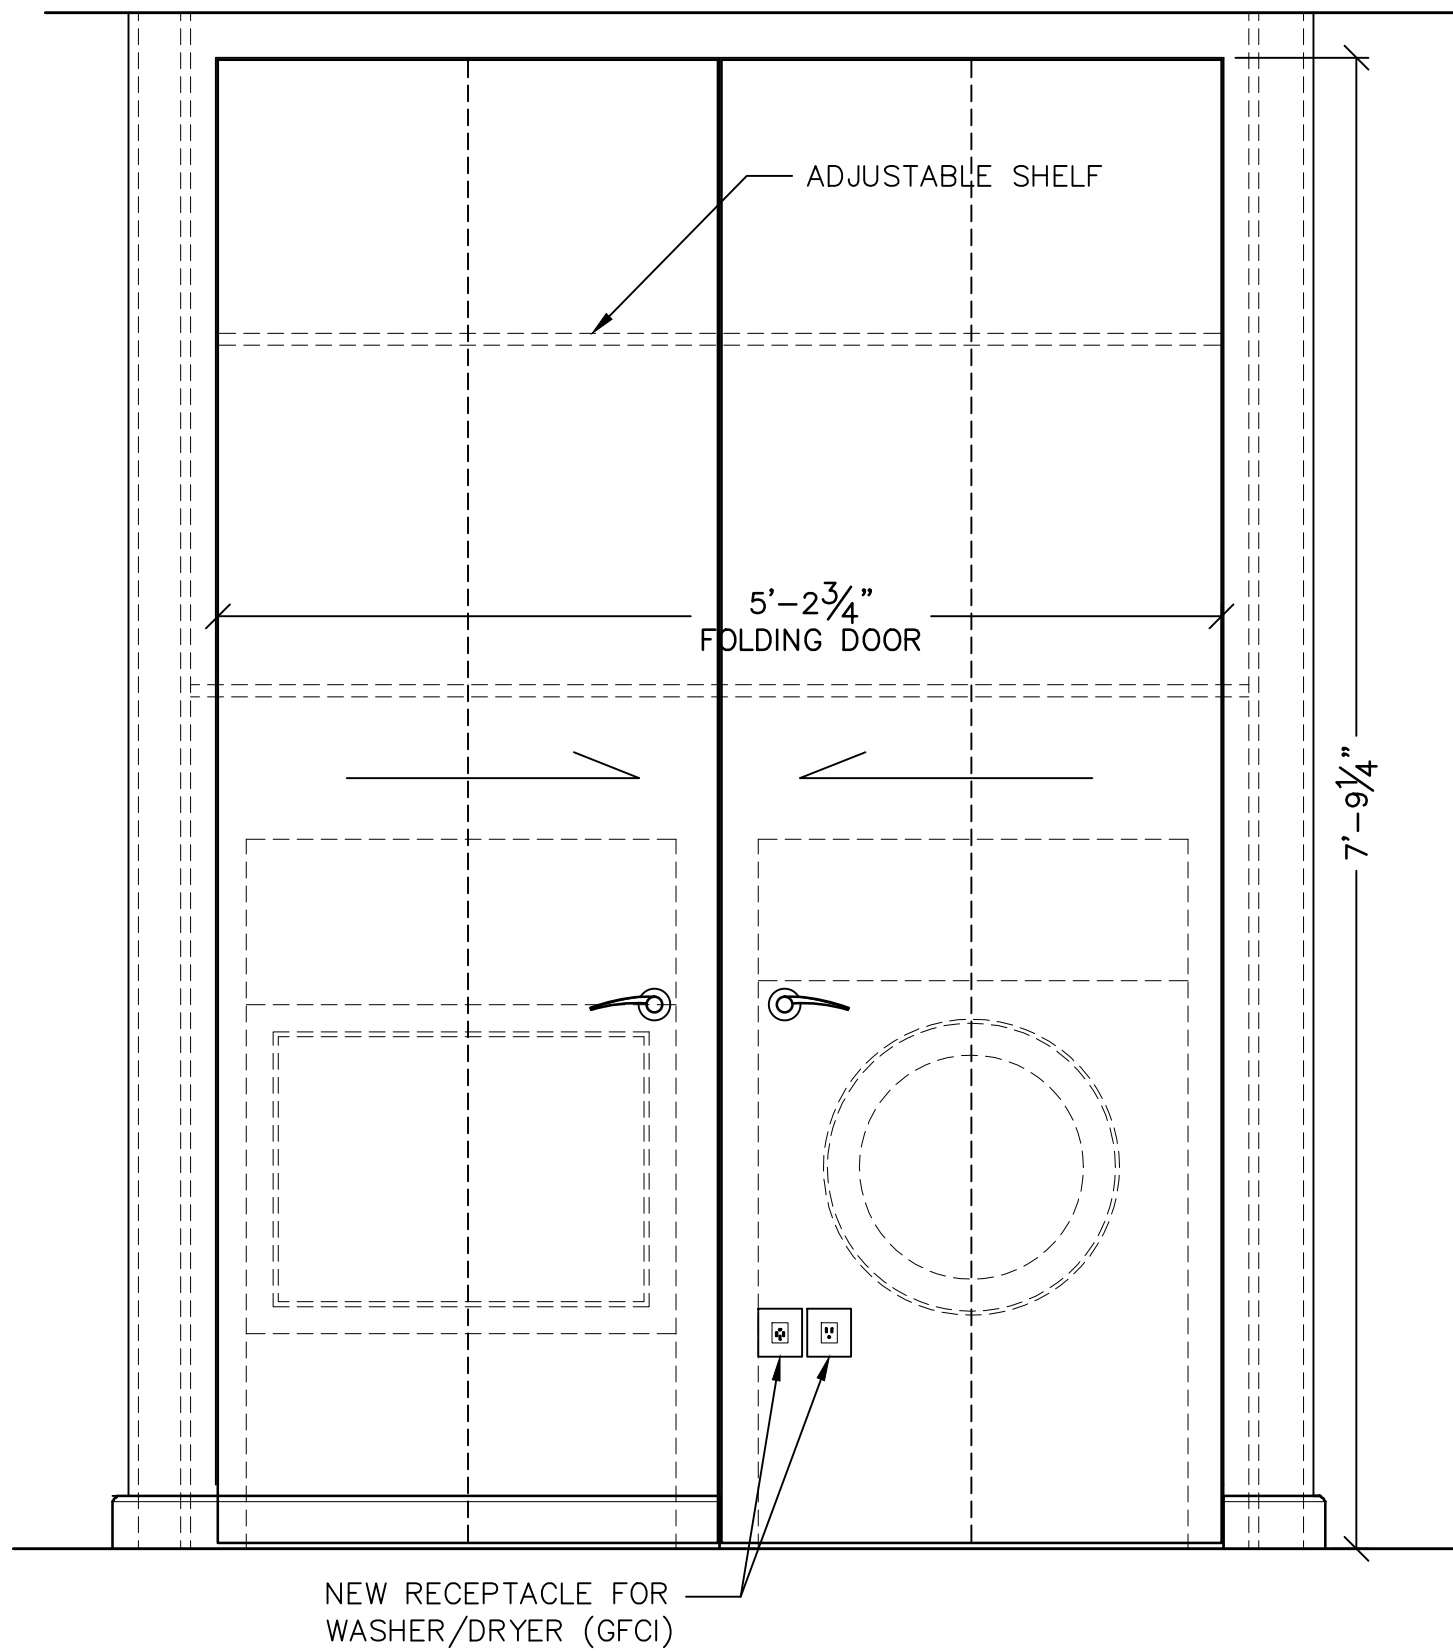

2 ADA KITCHEN SINK SECTION
A207
0 6" 1' 2' 4'
SCALE: 1" = 1'-0"

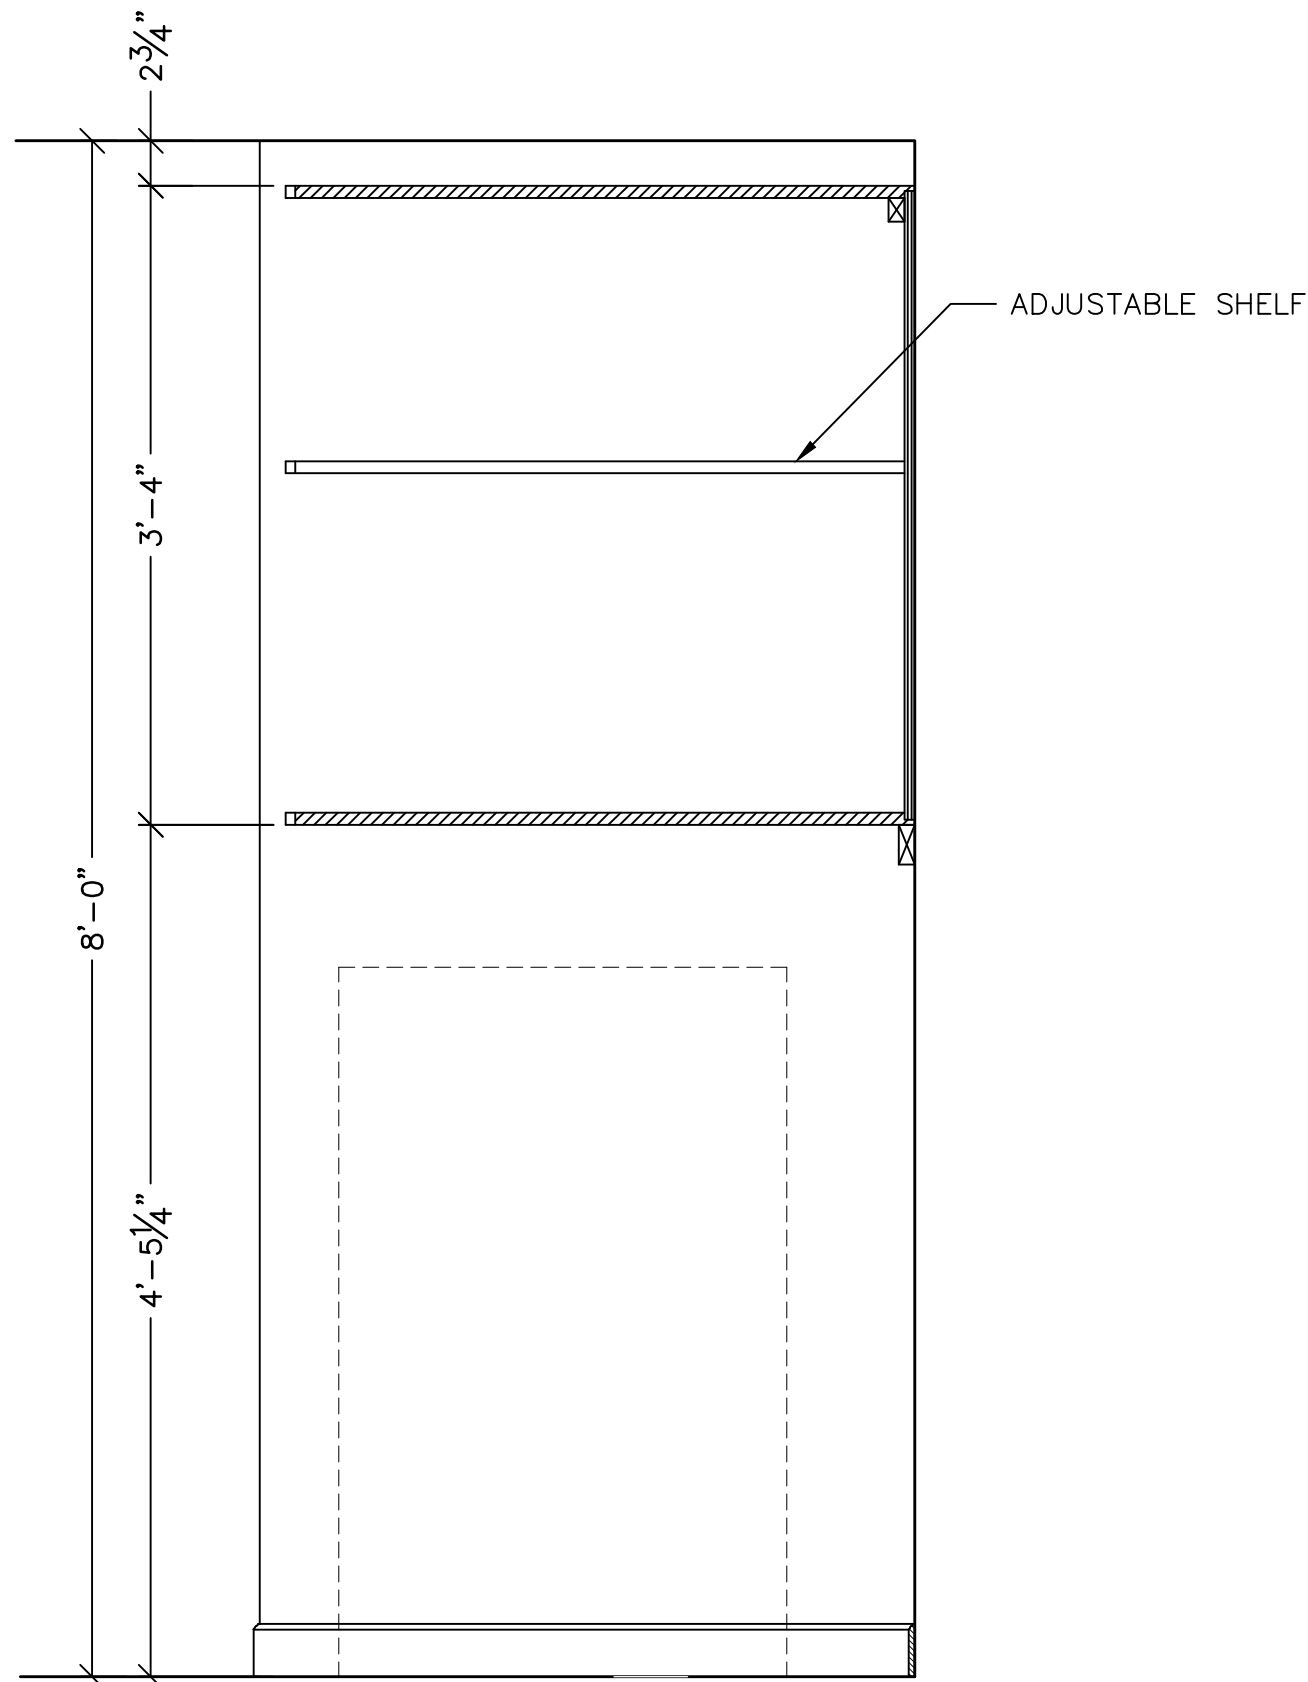

3 ADA LAUNDRY CABINET
A207
0 6" 1' 2' 4'
SCALE: 1" = 1'-0"

AFRIDI ASSOCIATES
CONSULTING ENGINEERS

19 West 21st Street
New York, NY 10010
Tel: (212) 243-0725
Fax: (212) 243-0725
510 Broadhollow Road
Melville, NY 11747
Tel: (631) 465-0786
Fax: (631) 465-0788
aafриди@afридиassociates.com

LIZARDOS

LONG ISLAND | NEW YORK CITY | CHARLOTTE | DANBURY

200 Old Country Road | Suite 670
Mineola | NY 11501
516 484 1020 Lizardos.com

Lizardos Engineering Associates D.P.C.

Designer: AKBER AFRIDI, P.E.
Drawn by: AZHER MAJIK
Checked by: AKBER AFRIDI, P.E.

Project:
**INTERIOR RENOVATIONS OF
THE COMMONS APARTMENTS
10.1 (ADA COMPLIANT) & 10.3**

Address:
735 Anderson Hill Road
Purchase NY 10577


Drawing Title:
**MILLWORK DETAILS
ADA APARTMENT 10.1**

Drawing No.:
A207.00


Scale: AS NOTED

Date: 08/24/2020


SU-040623

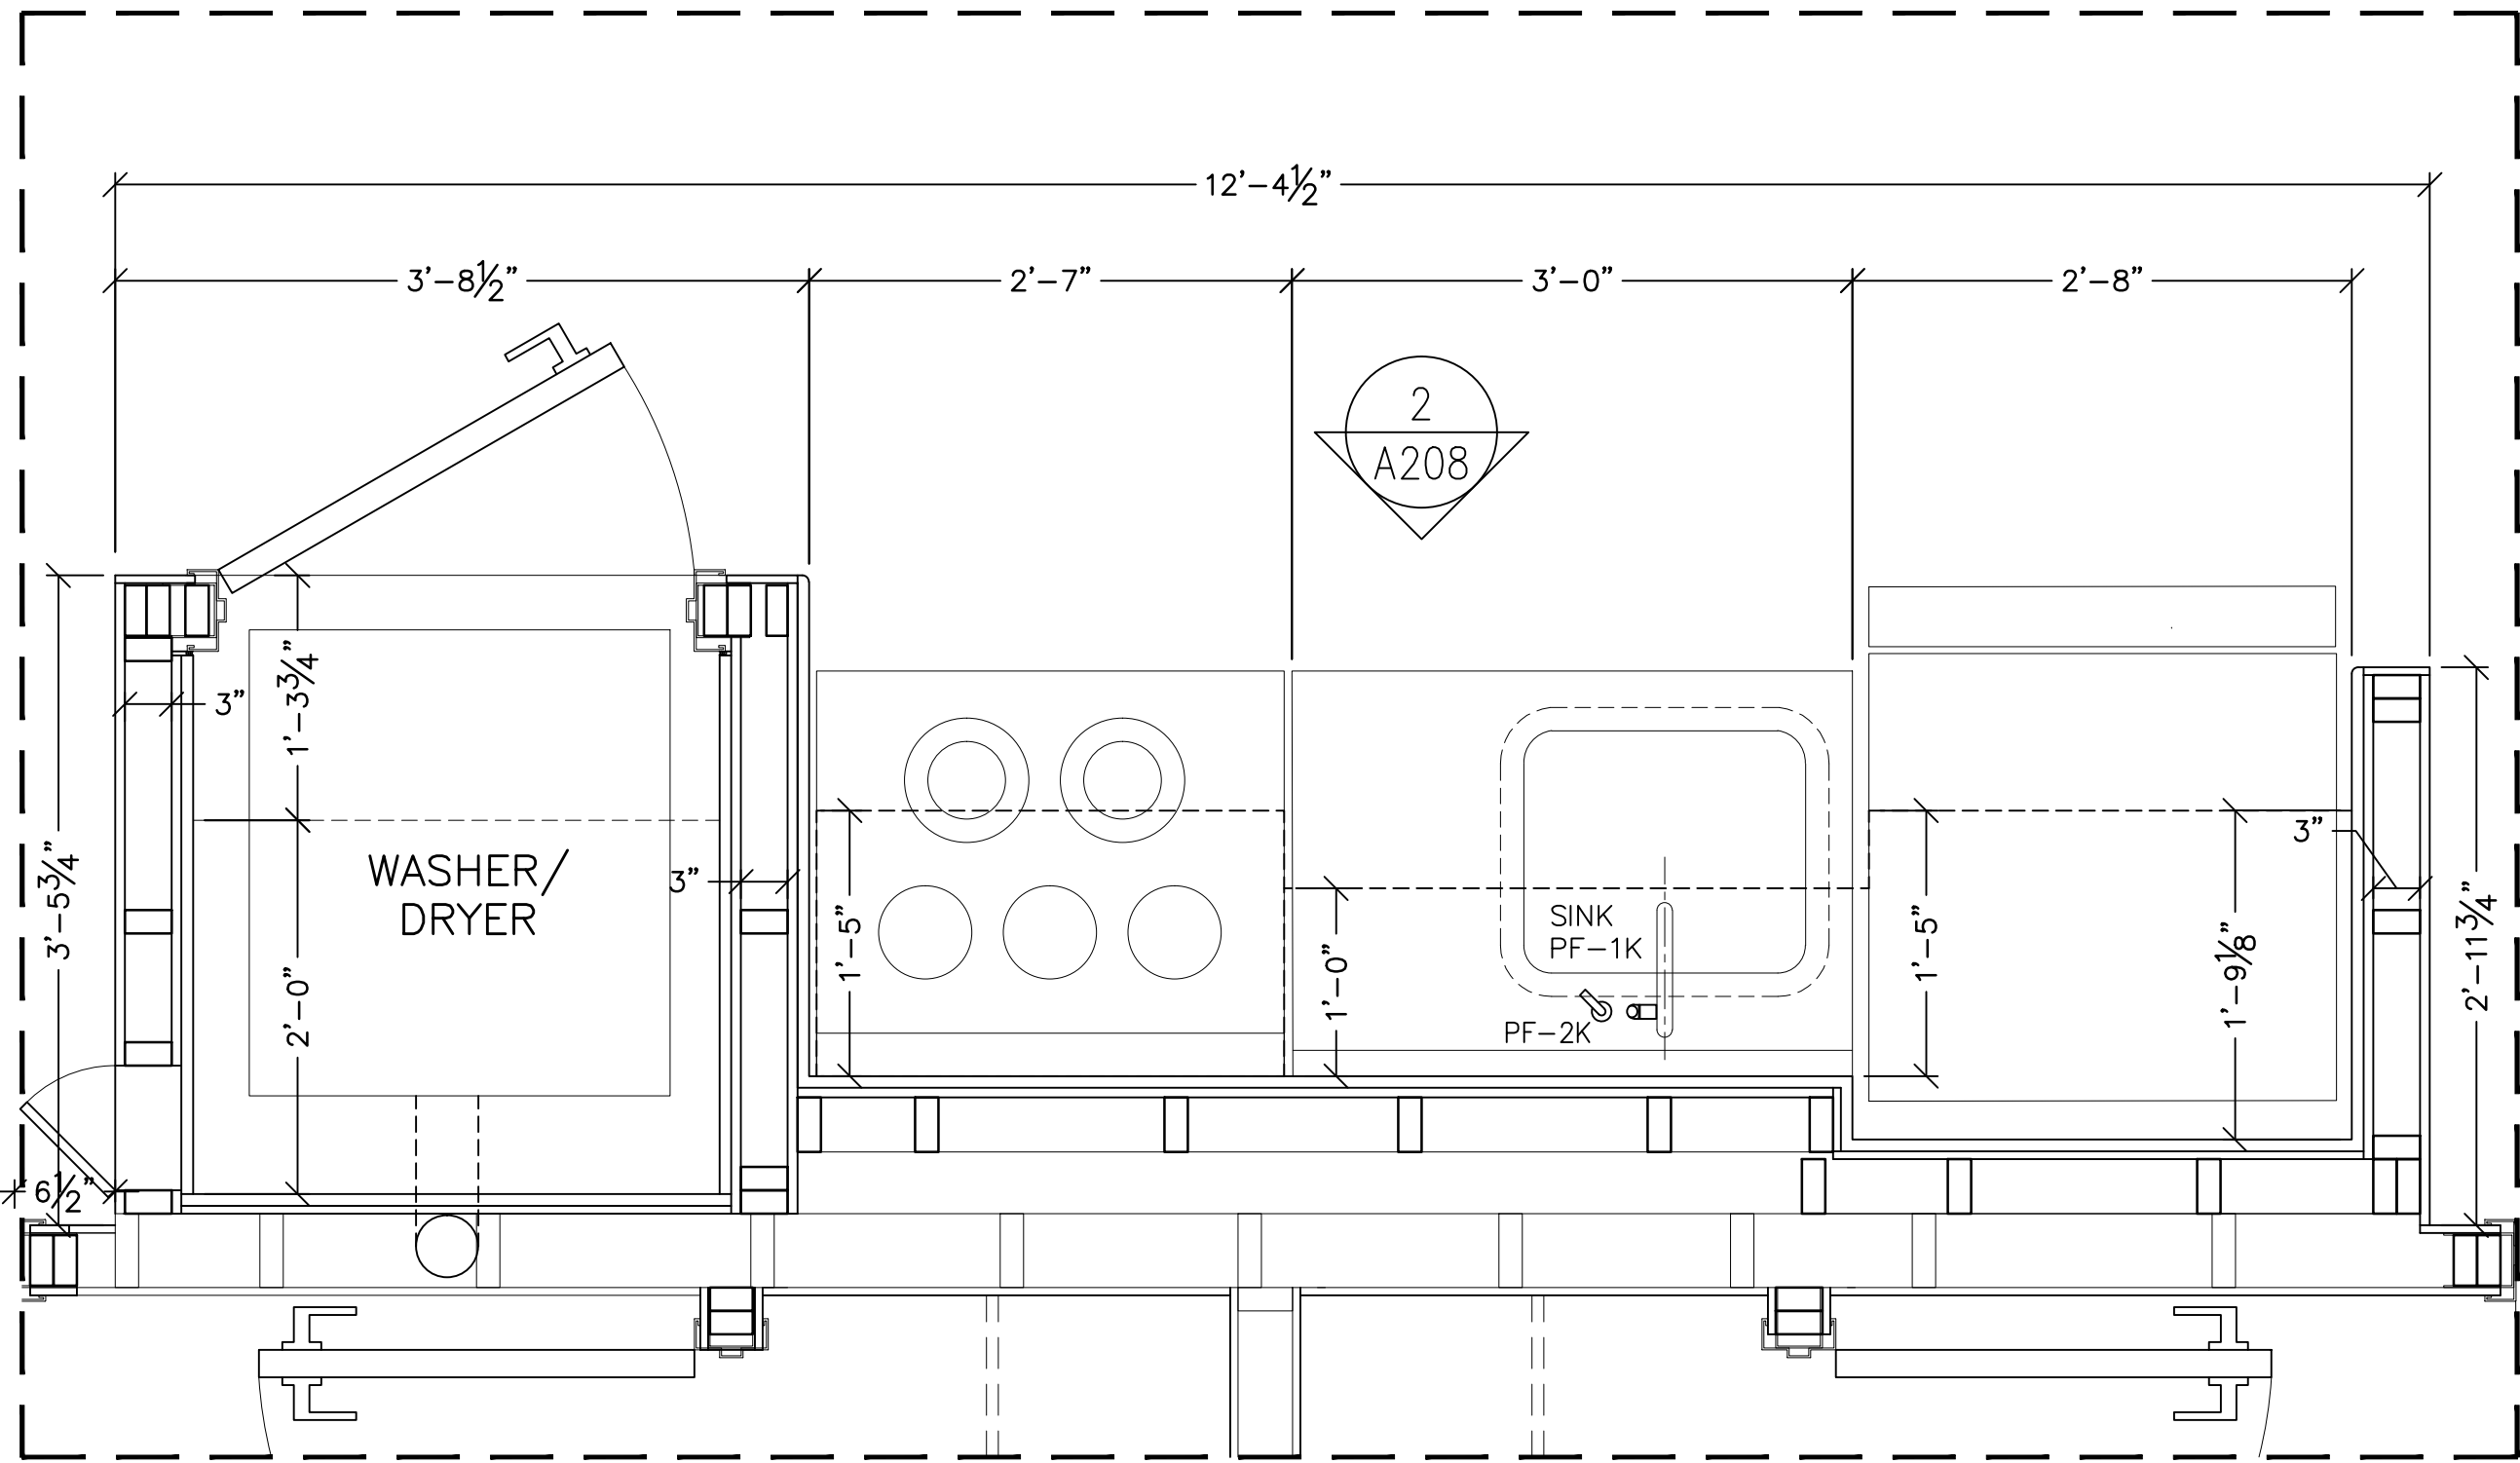


1 ENLARGED LAYOUT PLAN
A206
0 6" 1' 2' 4'
SCALE: 1" = 1'-0"

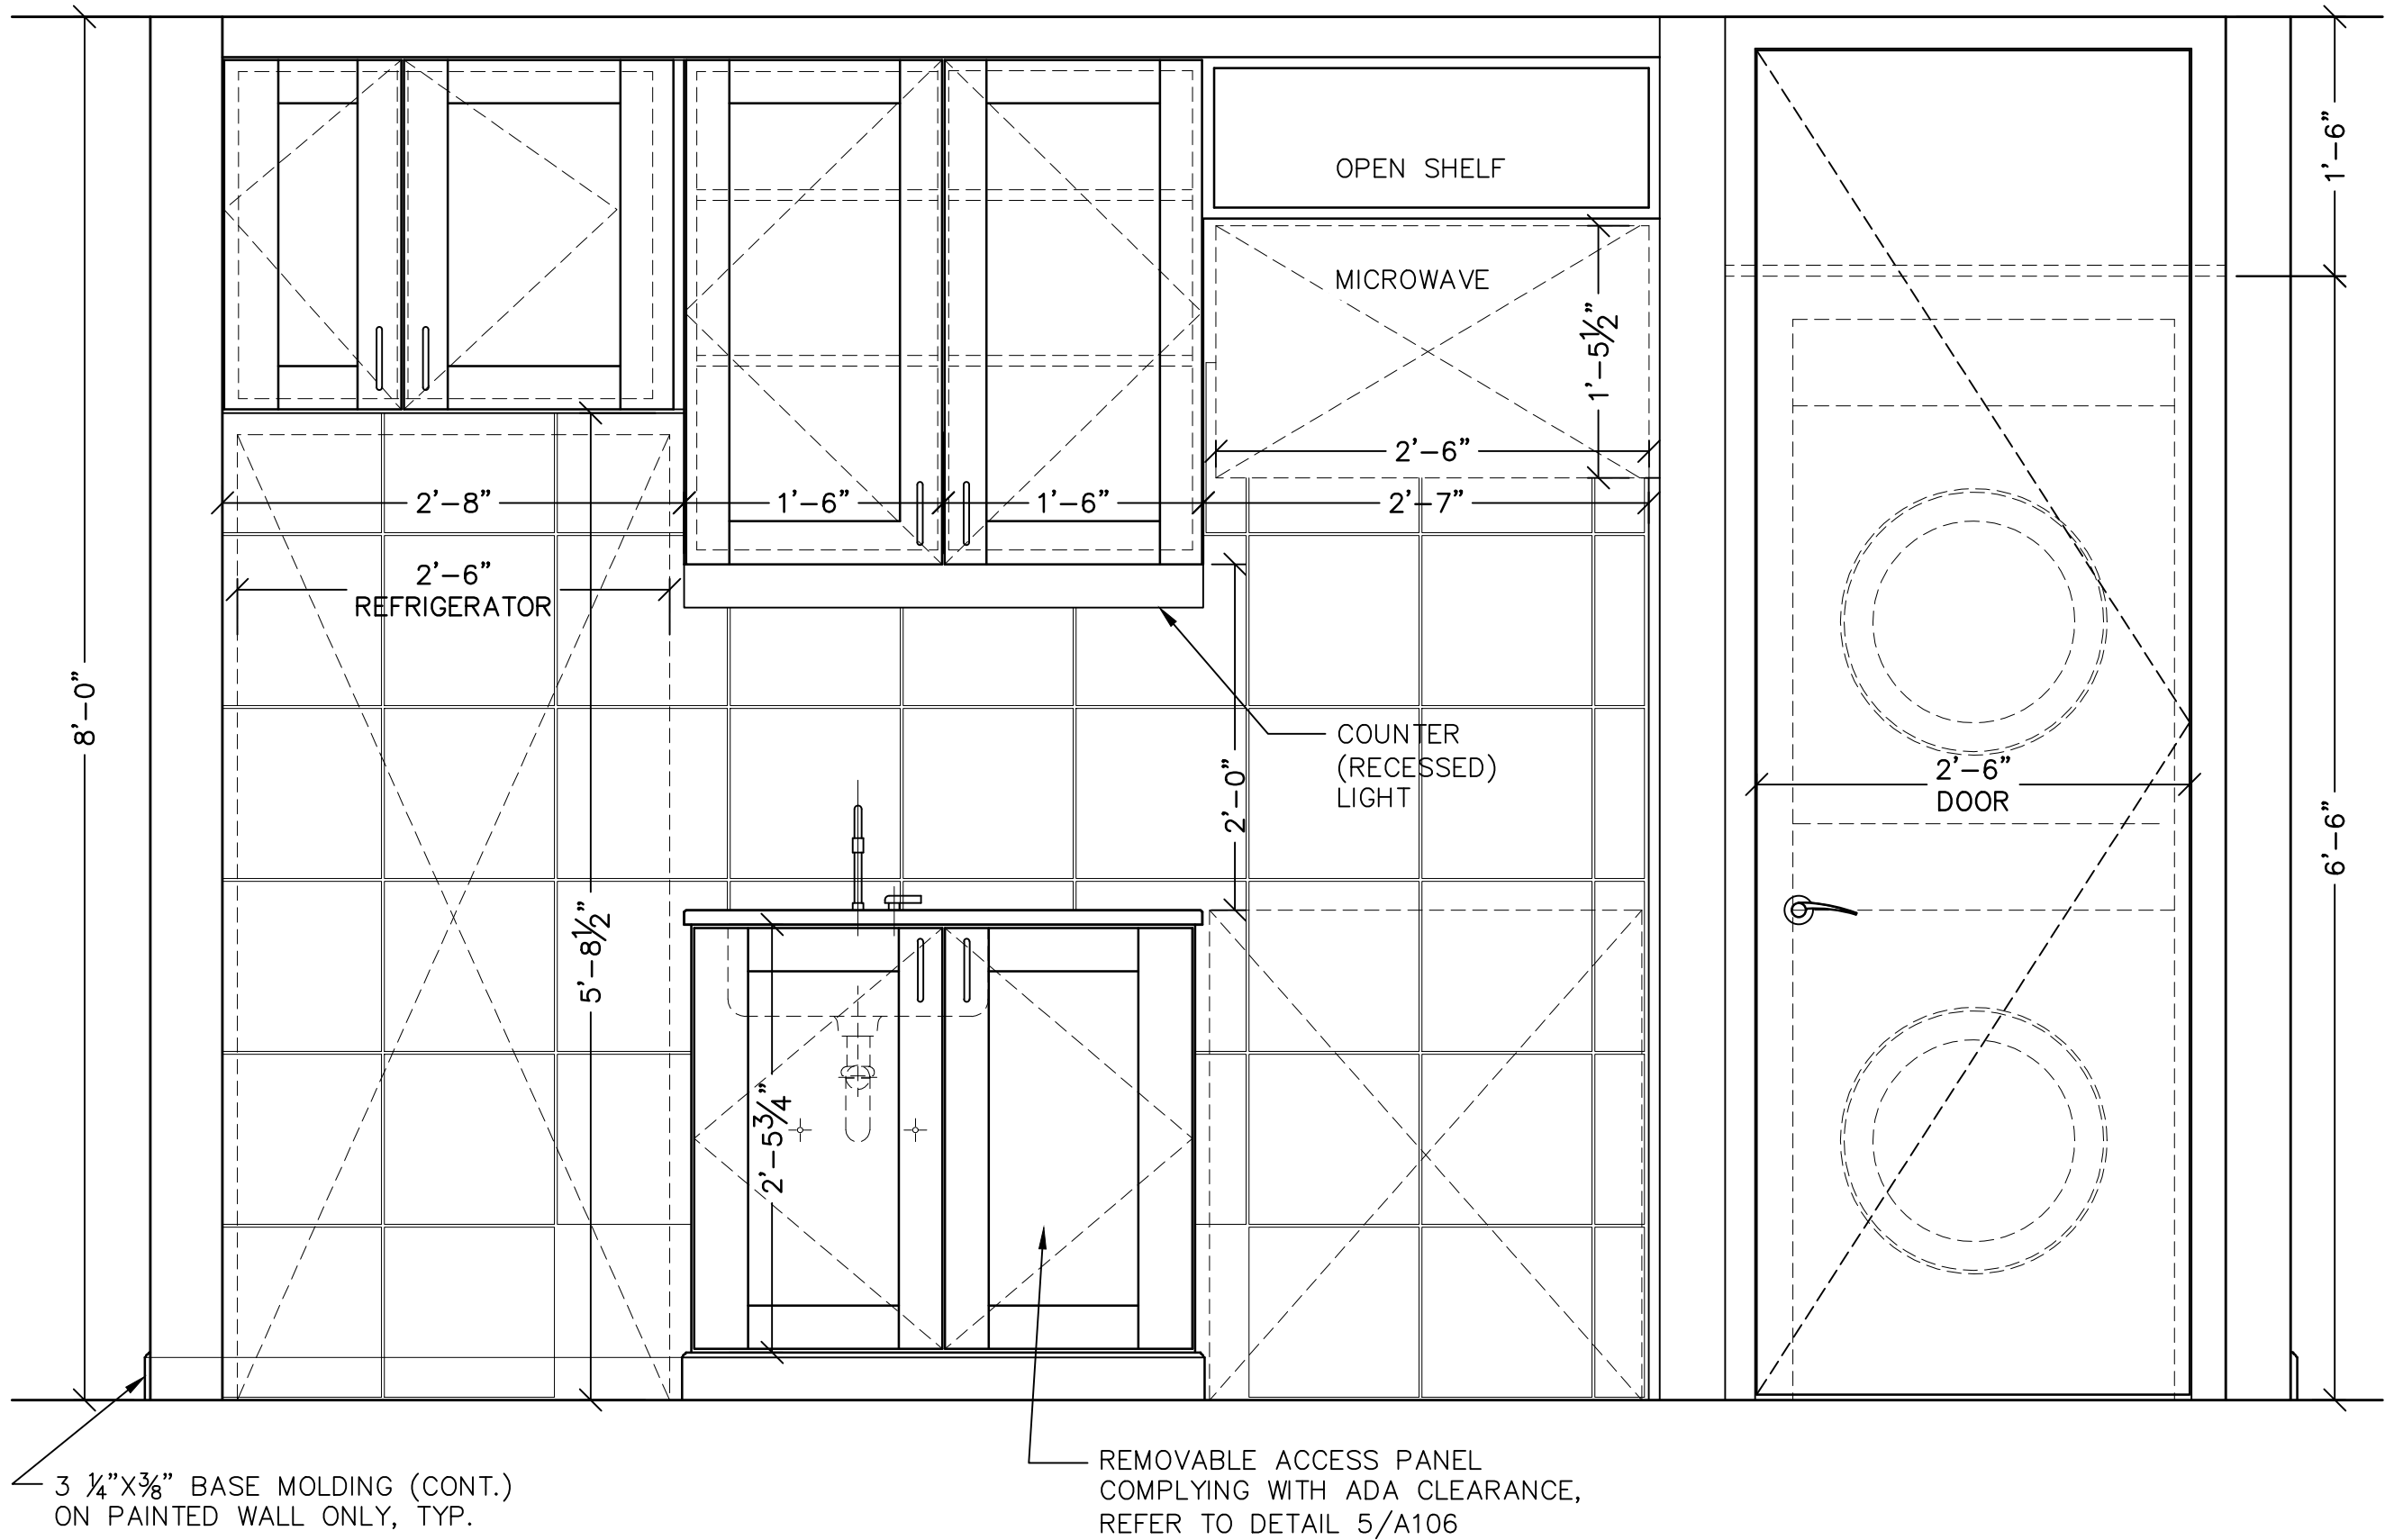

2 ELEVATION - WALL / TILE DETAILS
A208
0 6" 1' 2' 4'
SCALE: 1" = 1'-0"

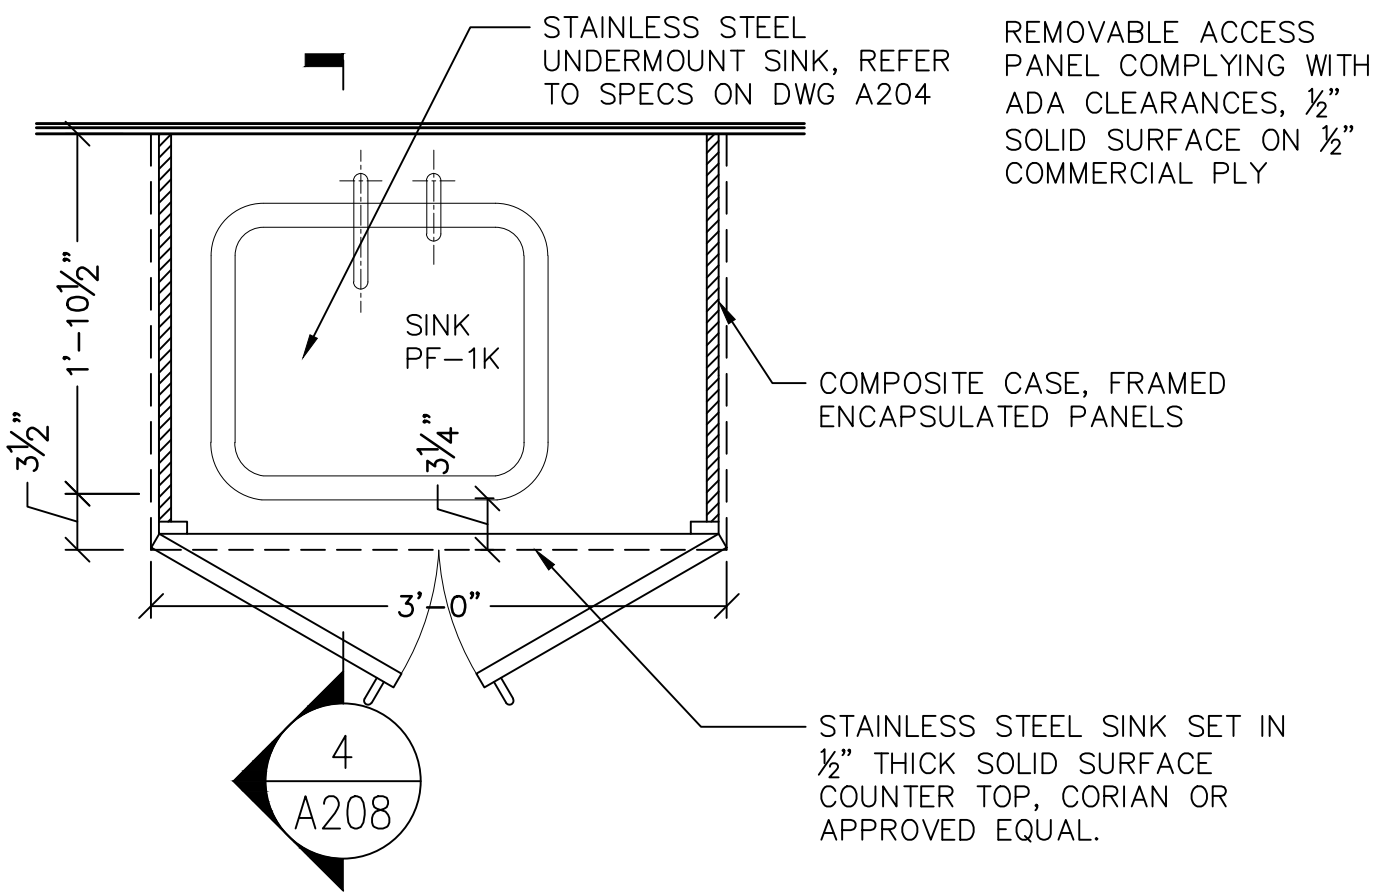

3 ADA KITCHEN SINK DETAIL
A208
0 6" 1' 2' 4'
SCALE: 1" = 1'-0"

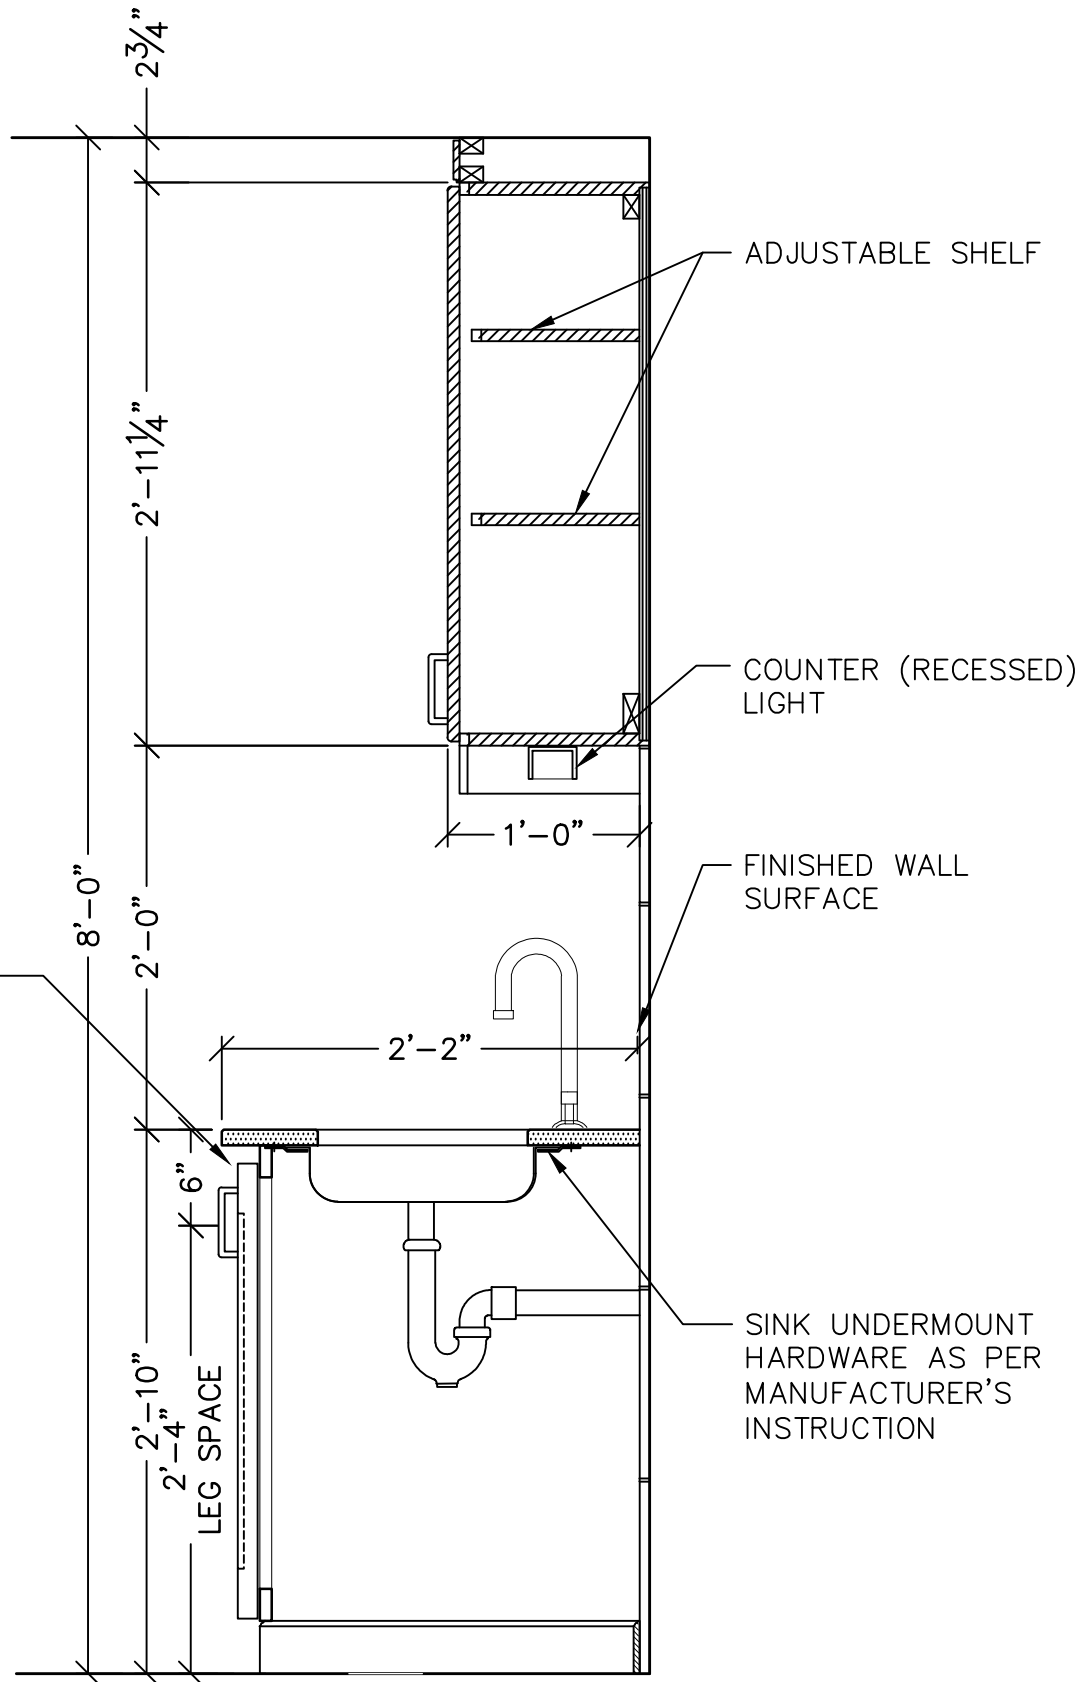

4 KITCHEN SINK DETAIL
A208
0 6" 1' 2' 4'
SCALE: 1" = 1'-0"

- NOTES**
1. LEVEL SUBFLOOR AS REQUIRED PRIOR TO INSTALLING FINISH FLOOR.
 2. STAGGER SUBFLOOR JOINTS IN BOTH DIRECTIONS.
 3. PROVIDE COLOR SAMPLES AND FULL SIZE TILE SAMPLES FOR APPROVAL PRIOR TO INSTALLATION OF TILES/VINYL PLANKS.
 4. FOR SHOWER AREA, BATHROOM AND KITCHEN WALLS, USE SCHLUTER KERDI MEMBRANE, CORNER STRIPS AND FIXTURE AND FAUCET SEALS.
 5. FOR BATHROOM FLOOR UNCOUPLING MEMBRANE, USE SCHLUTER DITRA OR APPROVED EQUAL.
 6. DOOR STOP IN BATHROOM, TO BE INSTALLED ON BASEBOARD/TILED WALL. DO NOT INSTALL ON FINISH FLOOR.
 7. ELECTRICAL RECEPTACLES NEAR WET AREA TO BE GFCI OUTLETS.

- LEGEND**
- VINYL FLOOR PLANK (VF-01)
 - 12"x12" CERAMIC TILES (KITCHEN)
 - 12"x12" CERAMIC FLOOR TILES (BATHROOM)
 - PLYWOOD/SUBFLOOR

AFRIDI ASSOCIATES
CONSULTING ENGINEERS

19 West 21st Street
New York, NY 10010
Tel: (212) 243-0725
Fax: (212) 243-0725

510 Broadhollow Road
Melville, NY 11747
Tel: (631) 465-0786
Fax: (631) 465-0788

aafridi@afridiassociates.com

LIZARDOS

LONG ISLAND | NEW YORK CITY | CHARLOTTE | DANBURY

200 Old Country Road | Suite 670
Mineola | NY 11501
516 484 1020 Lizardos.com

Lizardos Engineering Associates D.P.C.

Designer: AKBER AFRIDI, P.E.
Drawn by: AZHER MALIK
Checked by: AKBER AFRIDI, P.E.

Project:
**INTERIOR RENOVATIONS OF
THE COMMONS APARTMENTS
10.1 (ADA COMPLIANT) & 10.3**

Address:
735 Anderson Hill Road
Purchase NY 10577


Drawing Title:
**ENLARGED KITCHEN DETAILS,
APARTMENT 10.3**

Drawing No.:
A208.00

Scale: AS NOTED

Date: 08/24/2020

SU-040623

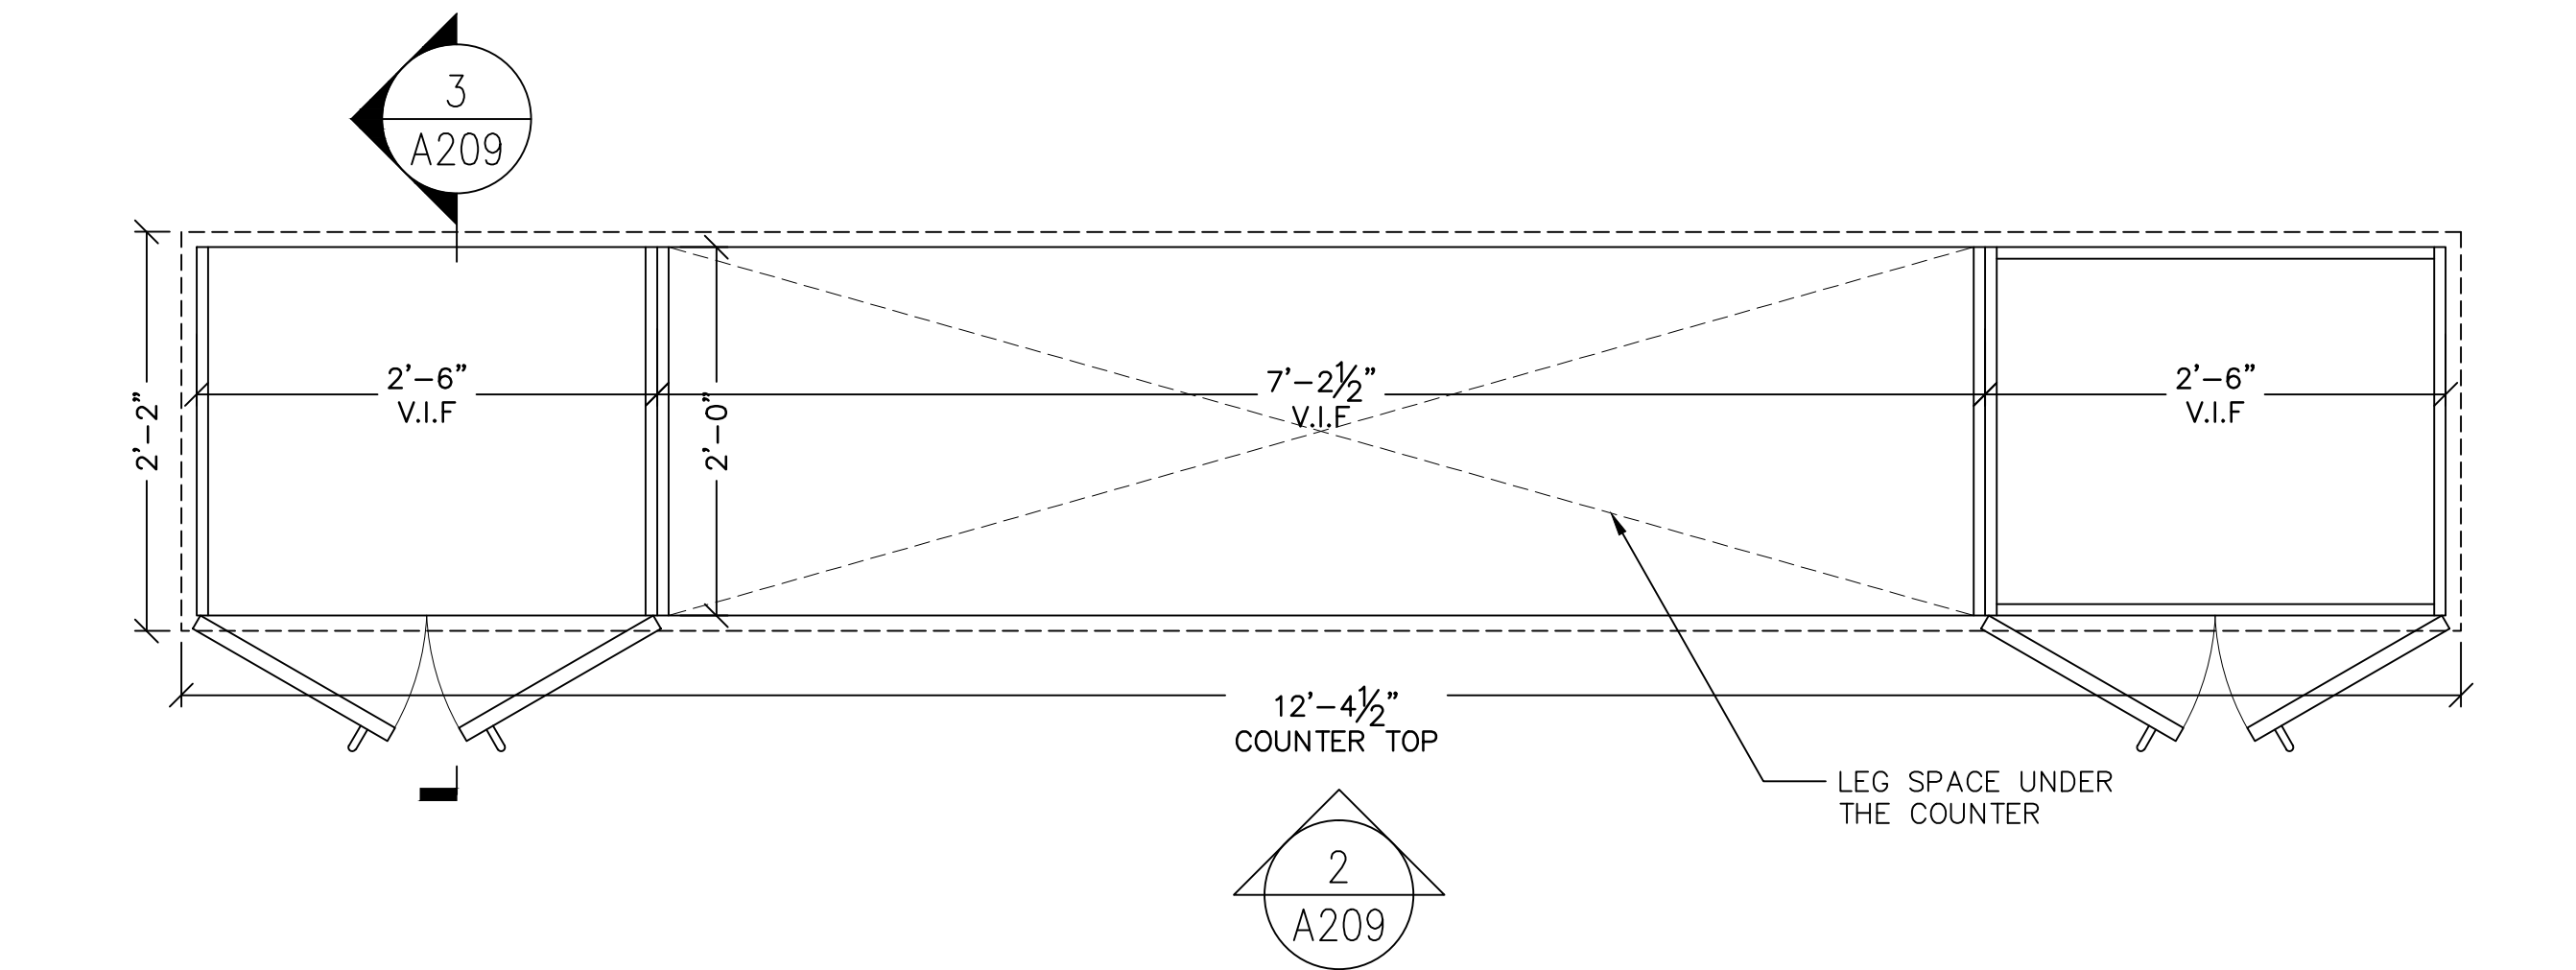


1
A209

ENLARGED PLAN DETAILS - DINING COUNTER

0 6" 1' 2' 4'

SCALE: 1" = 1'-0"

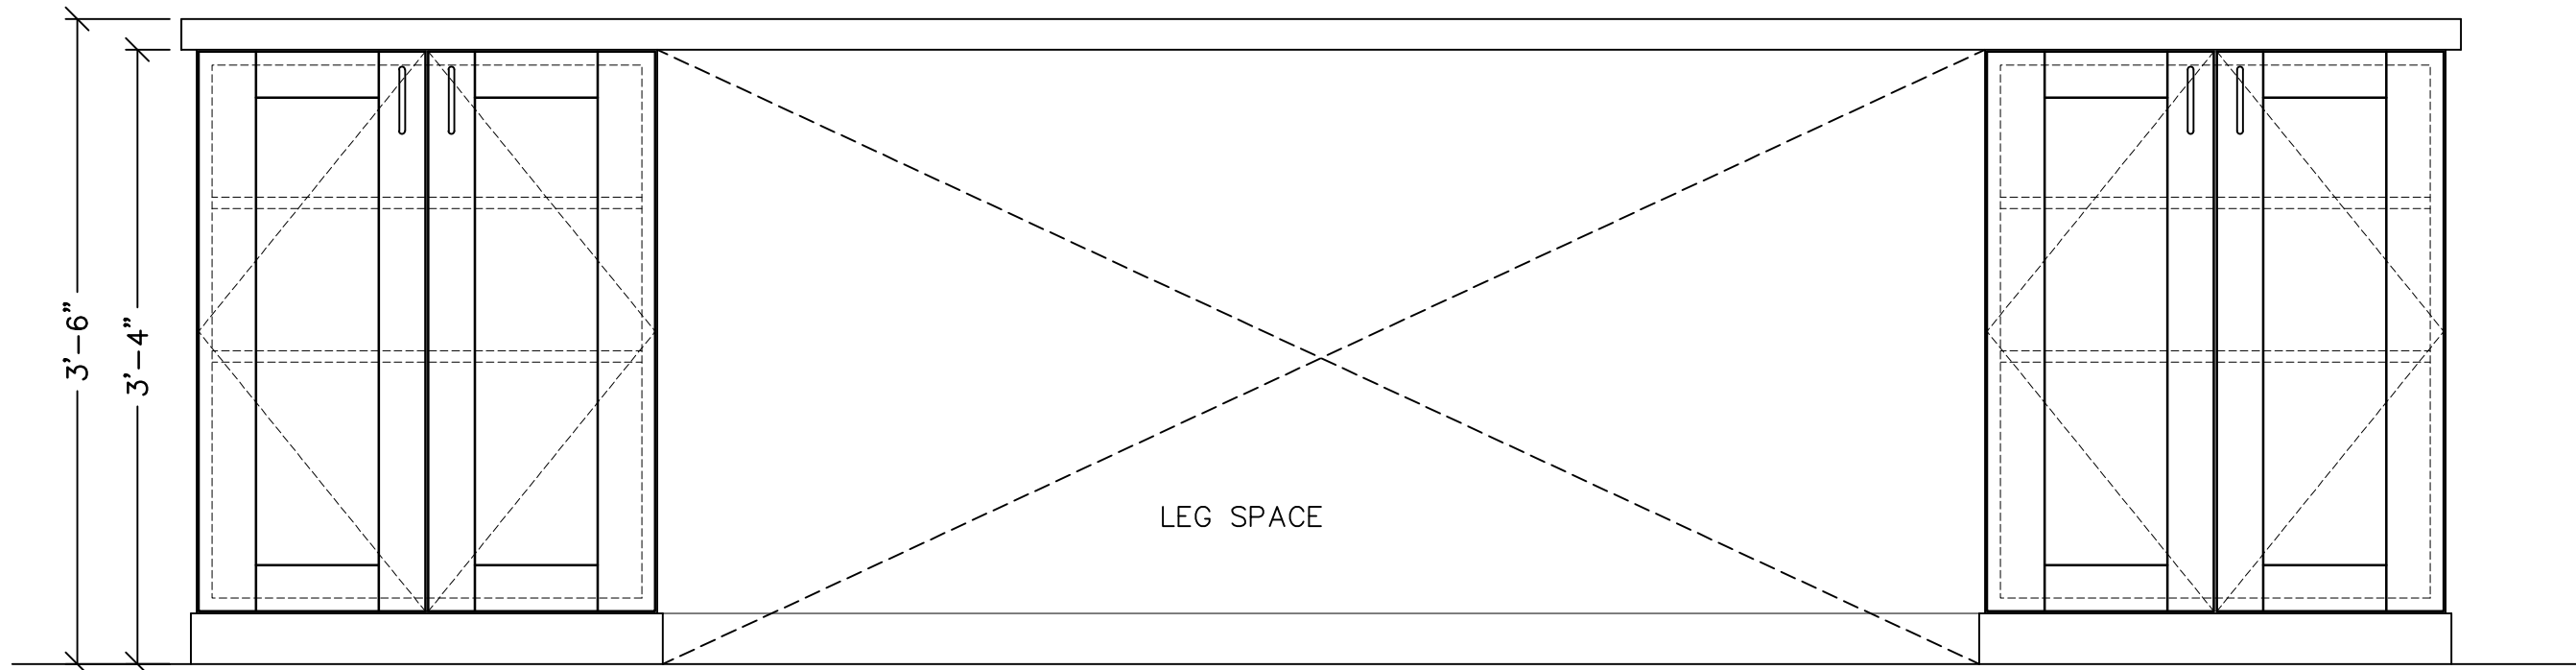


2
A209

TYP. ELEVATION - DINING COUNTER / WALL CABINETS

0 6" 1' 2' 4'

SCALE: 1" = 1'-0"

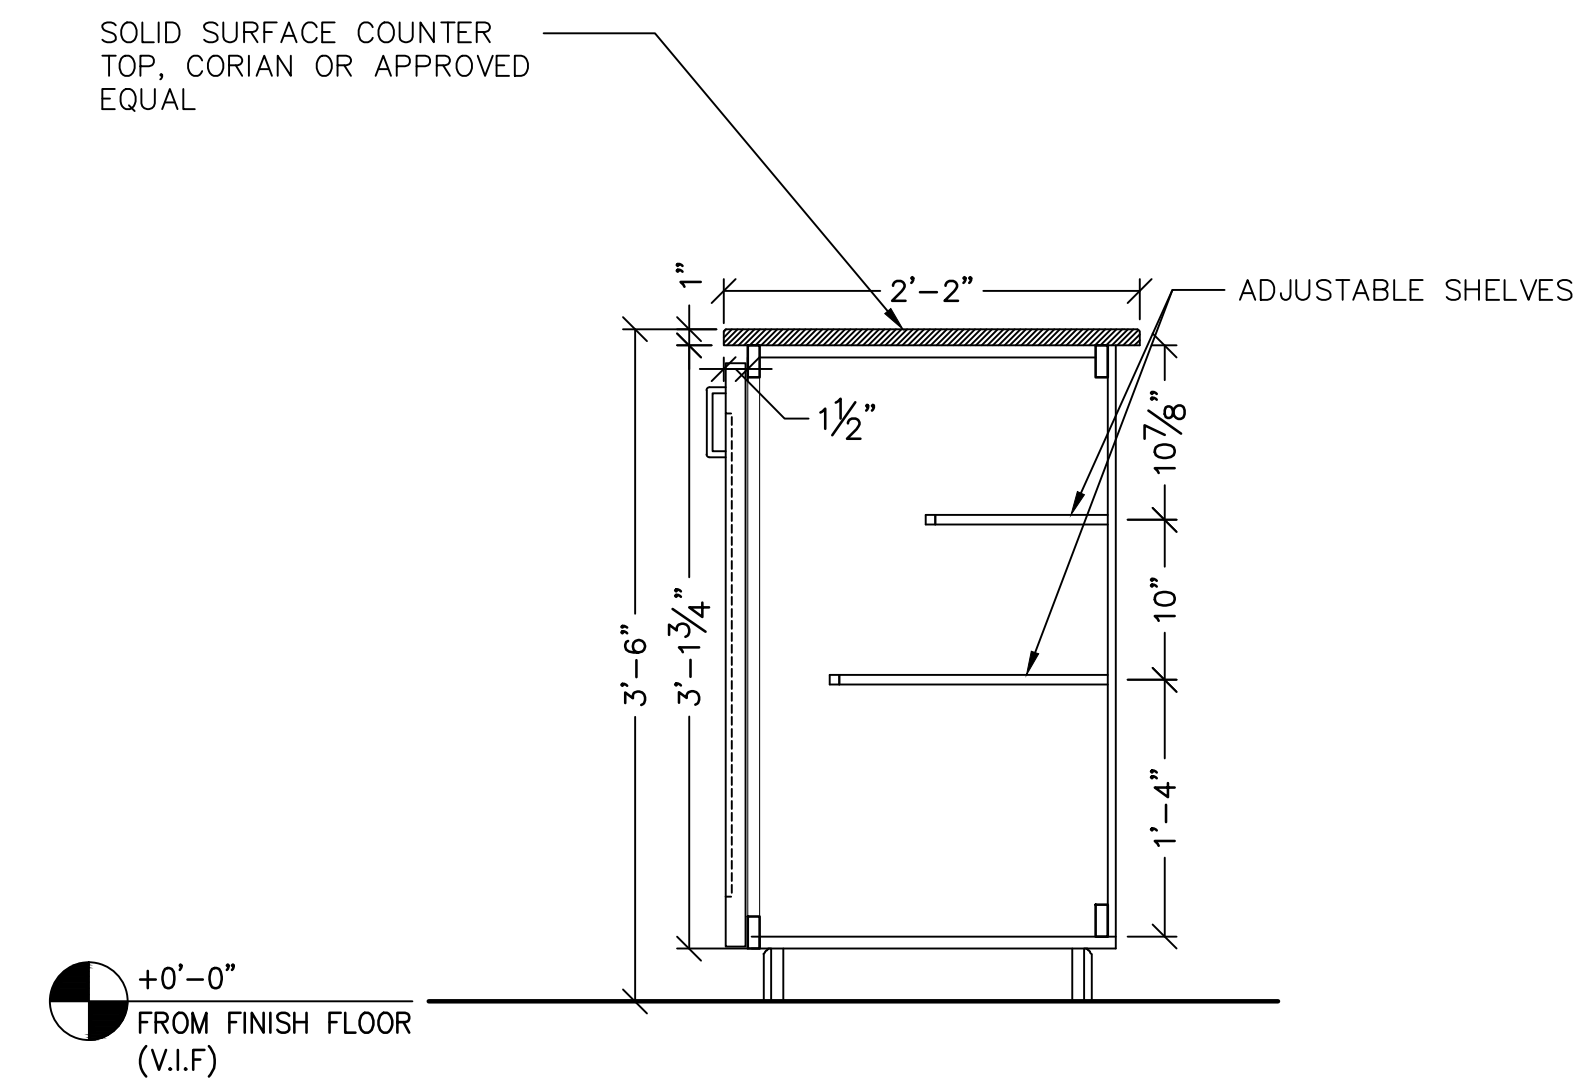

3
A209

ADA DINING COUNTER
SECTION DETAIL

0 6" 1' 2' 4'

SCALE: 1" = 1'-0"

AFRIDI ASSOCIATES
CONSULTING ENGINEERS

19 West 21st Street
New York, NY 10010
Tel: (212) 243-0725
Fax: (212) 243-0725

510 Broadhollow Road
Melville, NY 11747
Tel: (631) 465-0786
Fax: (631) 465-0788

aafridi@afriassociates.com

LIZARDOS

LONG ISLAND | NEW YORK CITY | CHARLOTTE | DANBURY

200 Old Country Road | Suite 670
Mineola | NY 11501
516 484 1020 Lizardos.com

Lizardos Engineering Associates D.P.C.

Designer: AKBER AFRIDI, P.E.
Drawn by: AZHER MALIK
Checked by: AKBER AFRIDI, P.E.

Project:
**INTERIOR RENOVATIONS OF
THE COMMONS APARTMENTS
10.1 (ADA COMPLIANT) & 10.3**

Address:
735 Anderson Hill Road
Purchase NY 10577

Drawing Title:
**MILLWORK DETAILS
APARTMENT 10.3**


Drawing No.:
A209.00

Scale: AS NOTED


Date: 08/24/2020

SU-040623


AFRIDI 2206

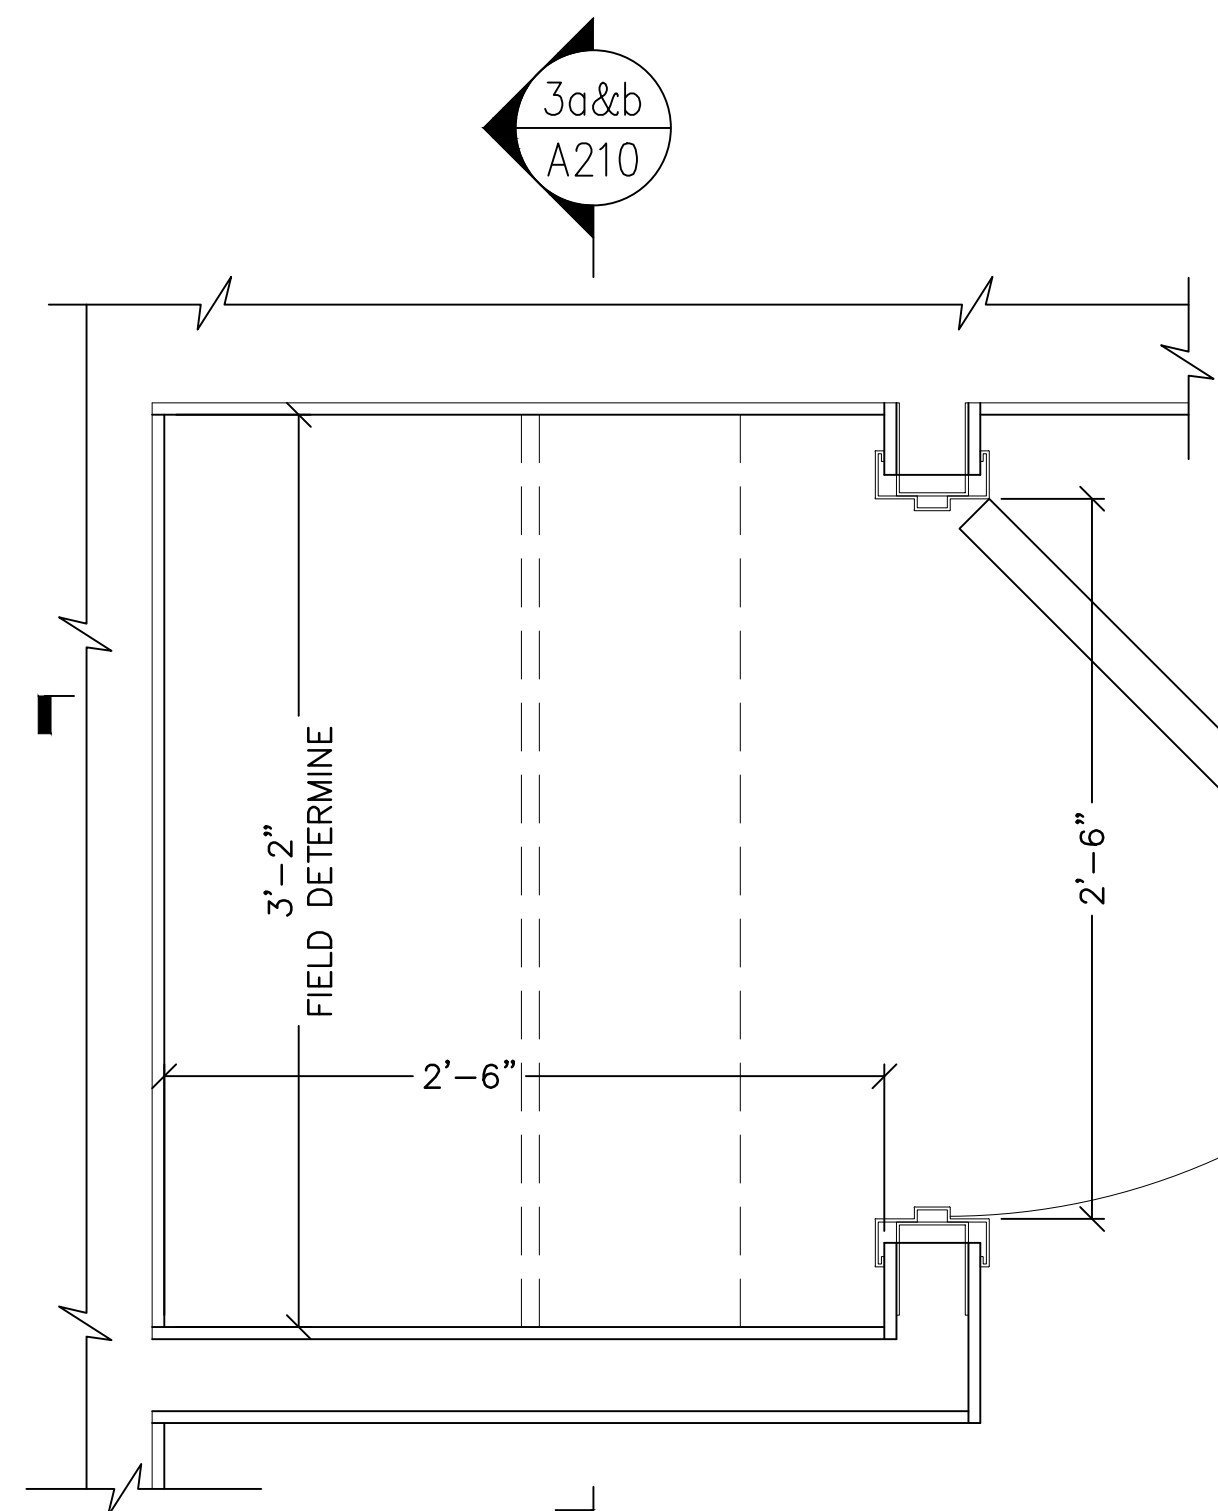


1 ENLARGED PLAN - BEDROOM CLOSET
A210
SCALE: 1 1/2" = 1'-0"

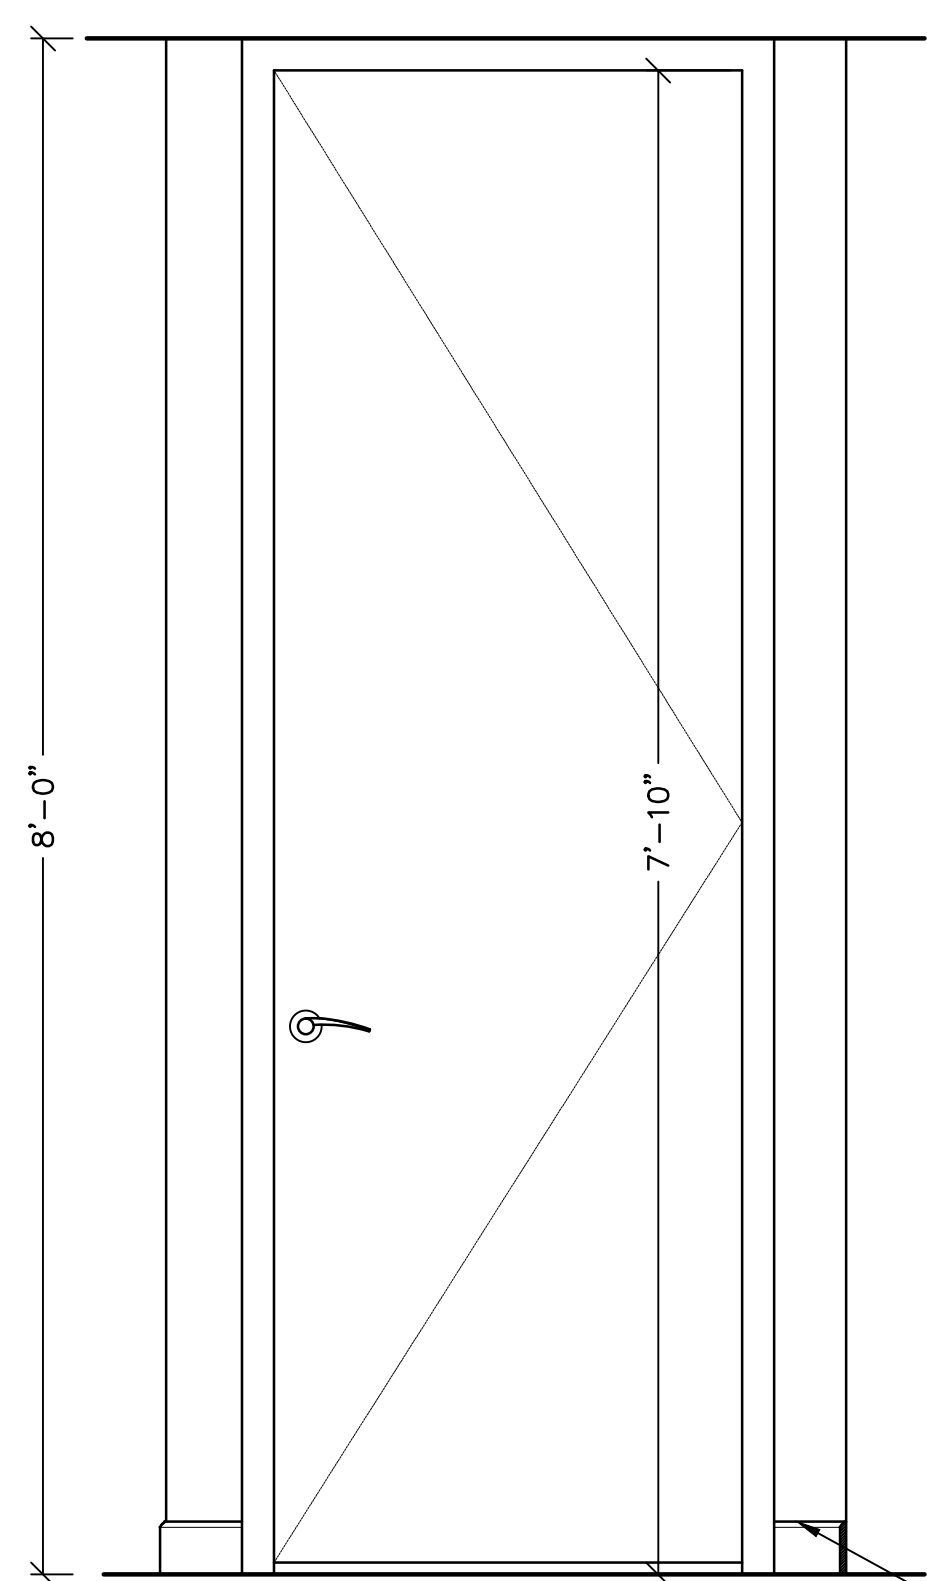

2a ELEV. CLOSET DOOR (10.1) ADA
A210
SCALE: 1" = 1'-0"

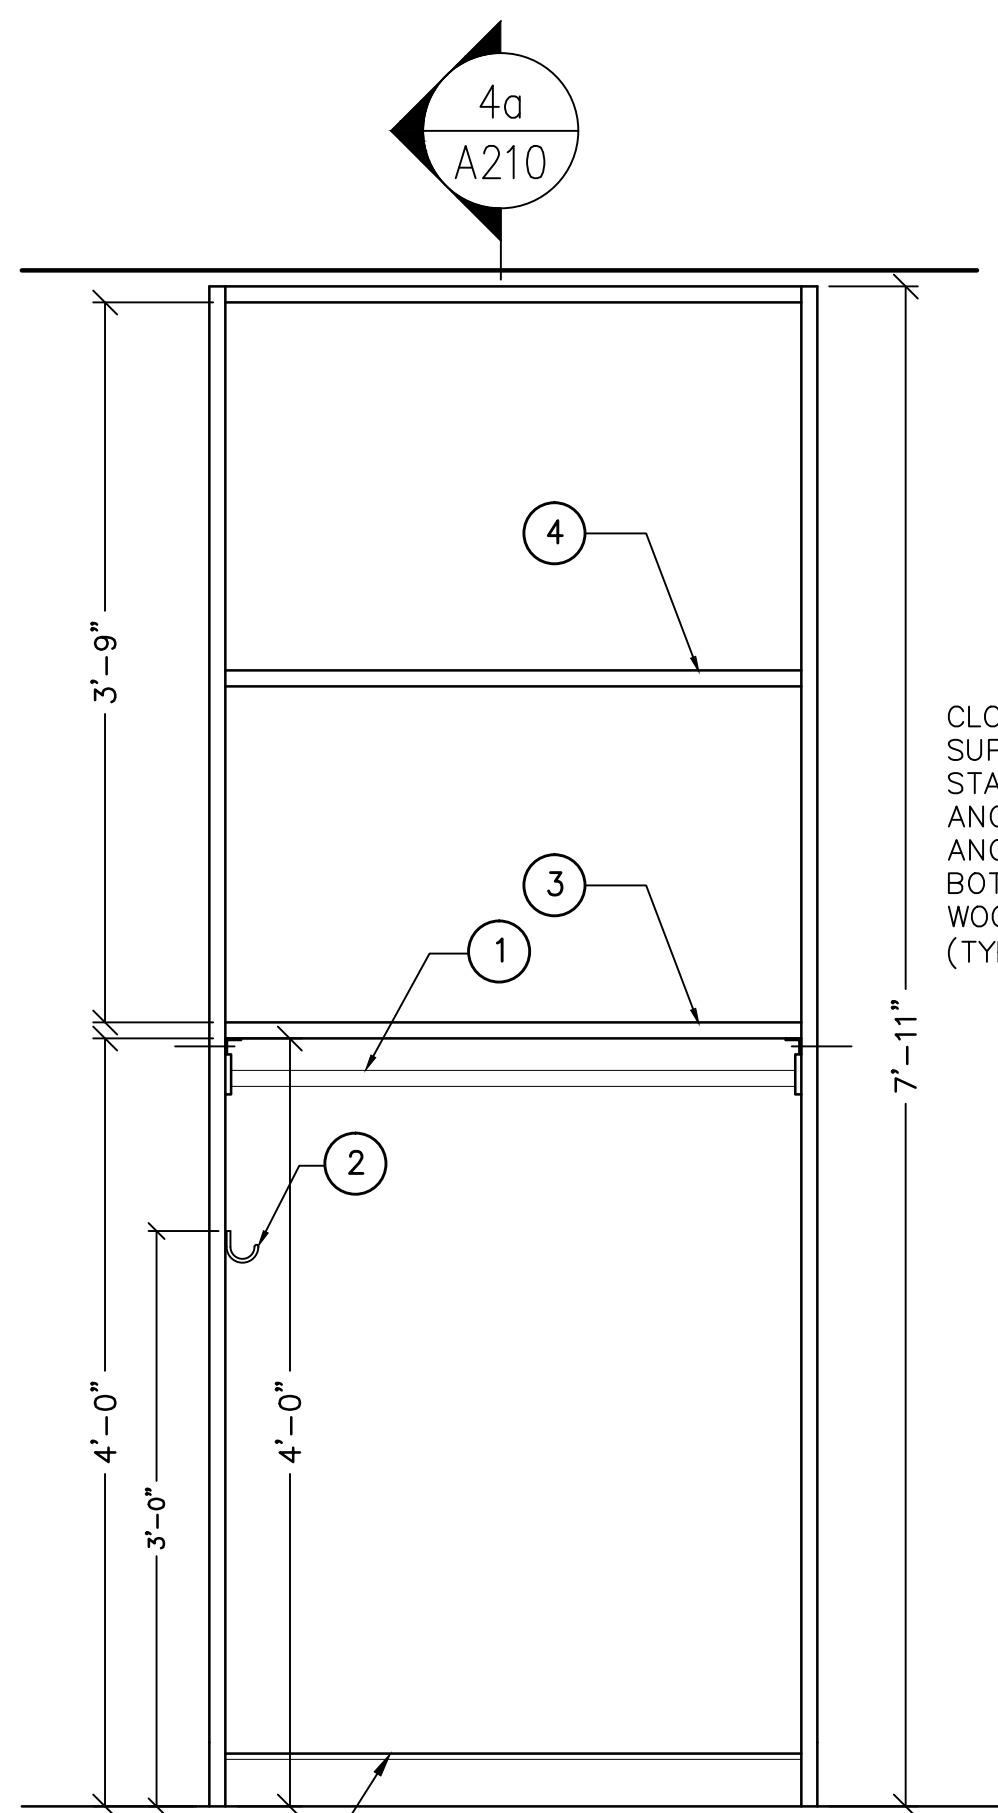

3a ELEV. CLOSET (10.1) ADA
A210
SCALE: 1" = 1'-0"

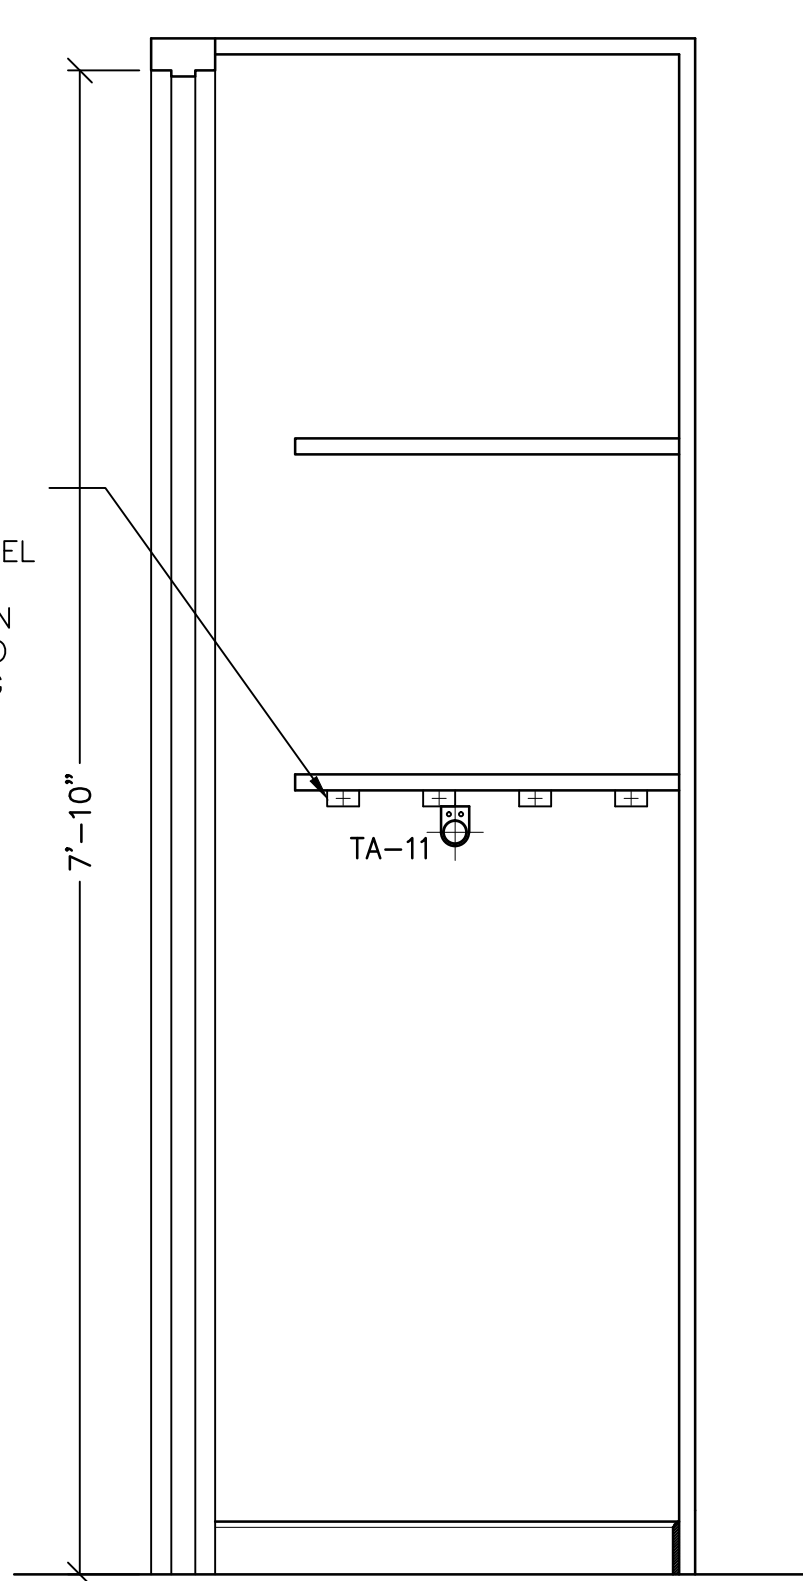


4a SECTION CLOSET (10.1) ADA
A210
SCALE: 1" = 1'-0"


LEGEND			
W-1	GRADE 1 PLYWD. W/ PLAIN SAWN WHITE BIRCH VENEER	H-1	DOOR LEVER
W-2	GRADE 2 PLYWD. W/ PLAIN SAWN WHITE BIRCH VENEER	H-3	HINGE (4 PER DOOR)
W-3	PLAIN SAWN WHITE BIRCH HARDWOOD		

KEYED NOTES


- CLOTHES HANGING ROD/FLANGES AS PER SPECS.
- UMBRELLA HOOK ROD AS PER SPECS.
- FIXED SHELF (ABOVE), WITH HARD WOOD EDGE (TYP).
- ADJUSTABLE SHELF (ABOVE), WITH HARD WOOD EDGE (TYP).

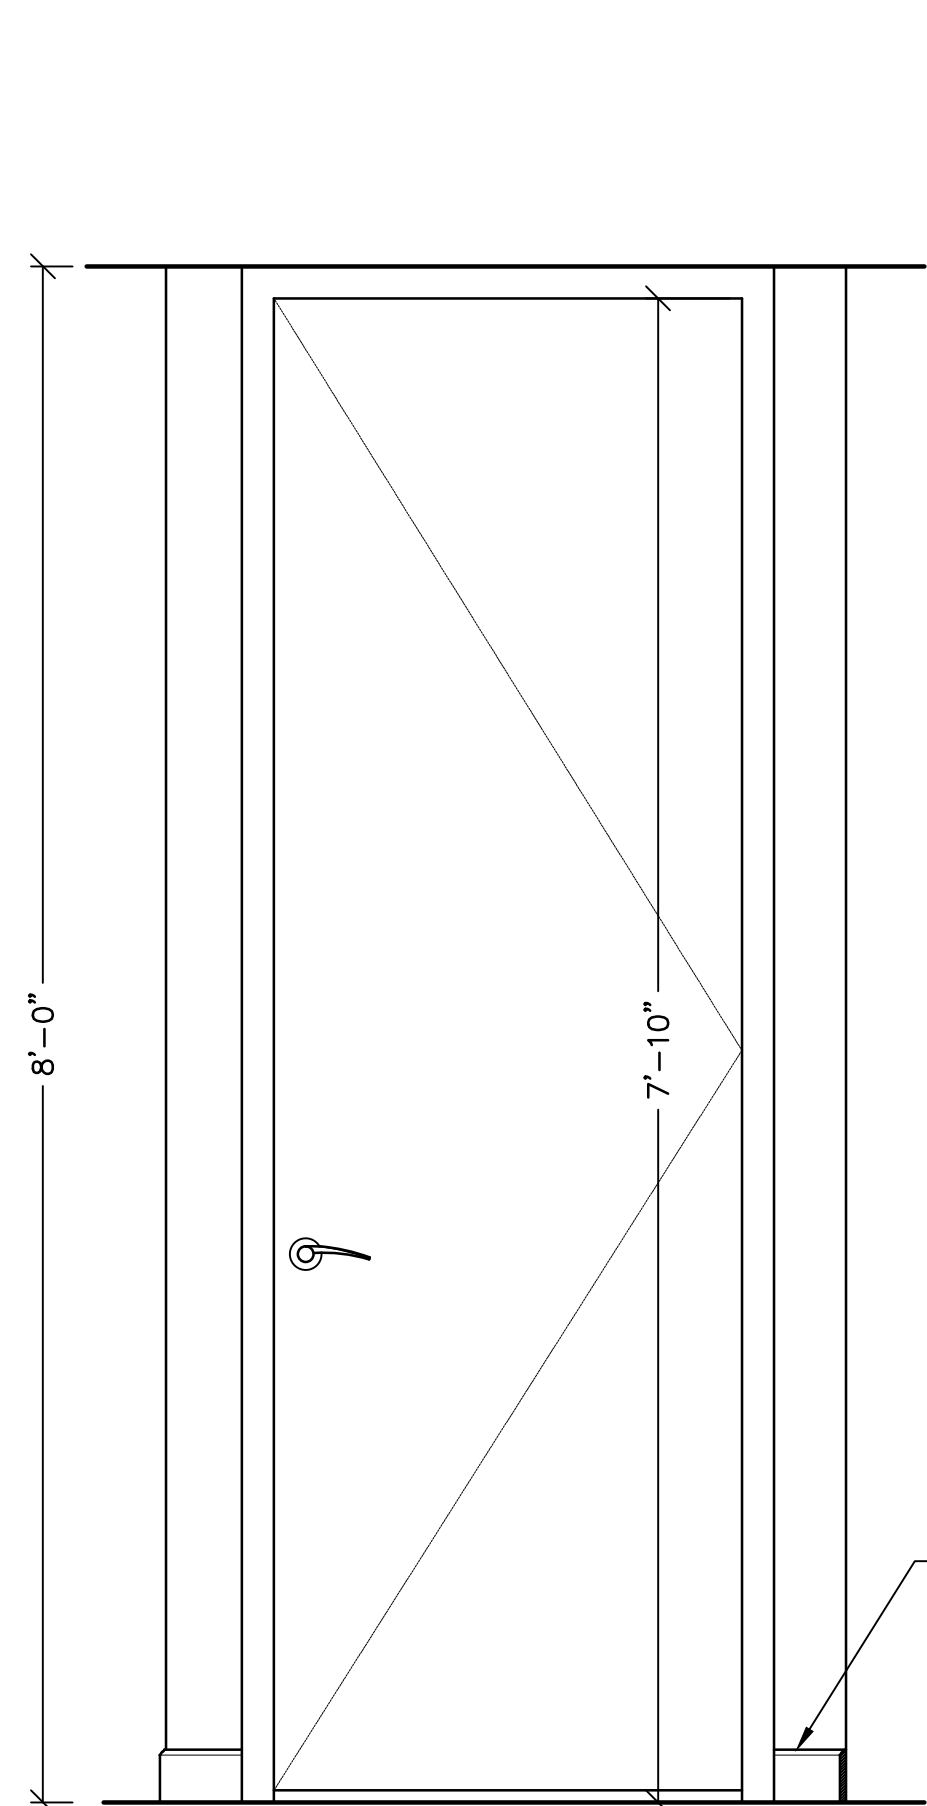

2b ELEV. CLOSET DOOR (10.3)
A210
SCALE: 1" = 1'-0"

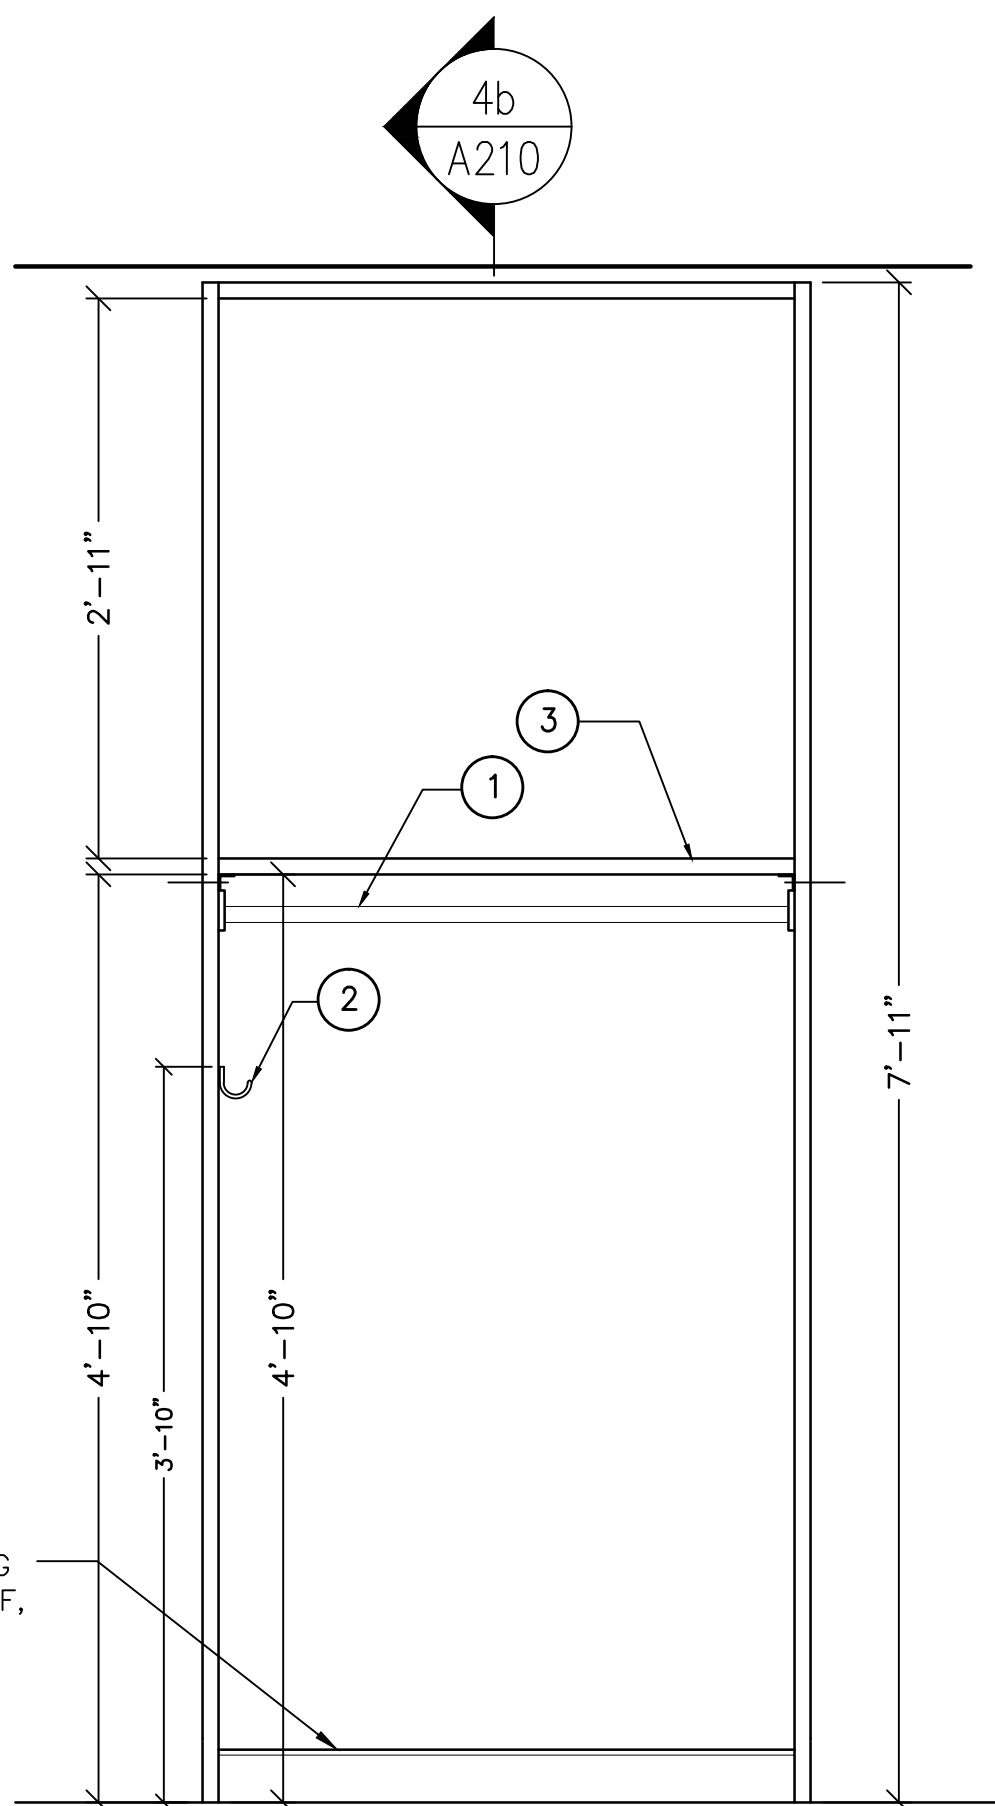

3b ELEV. CLOSET (10.3)
A210
SCALE: 1" = 1'-0"

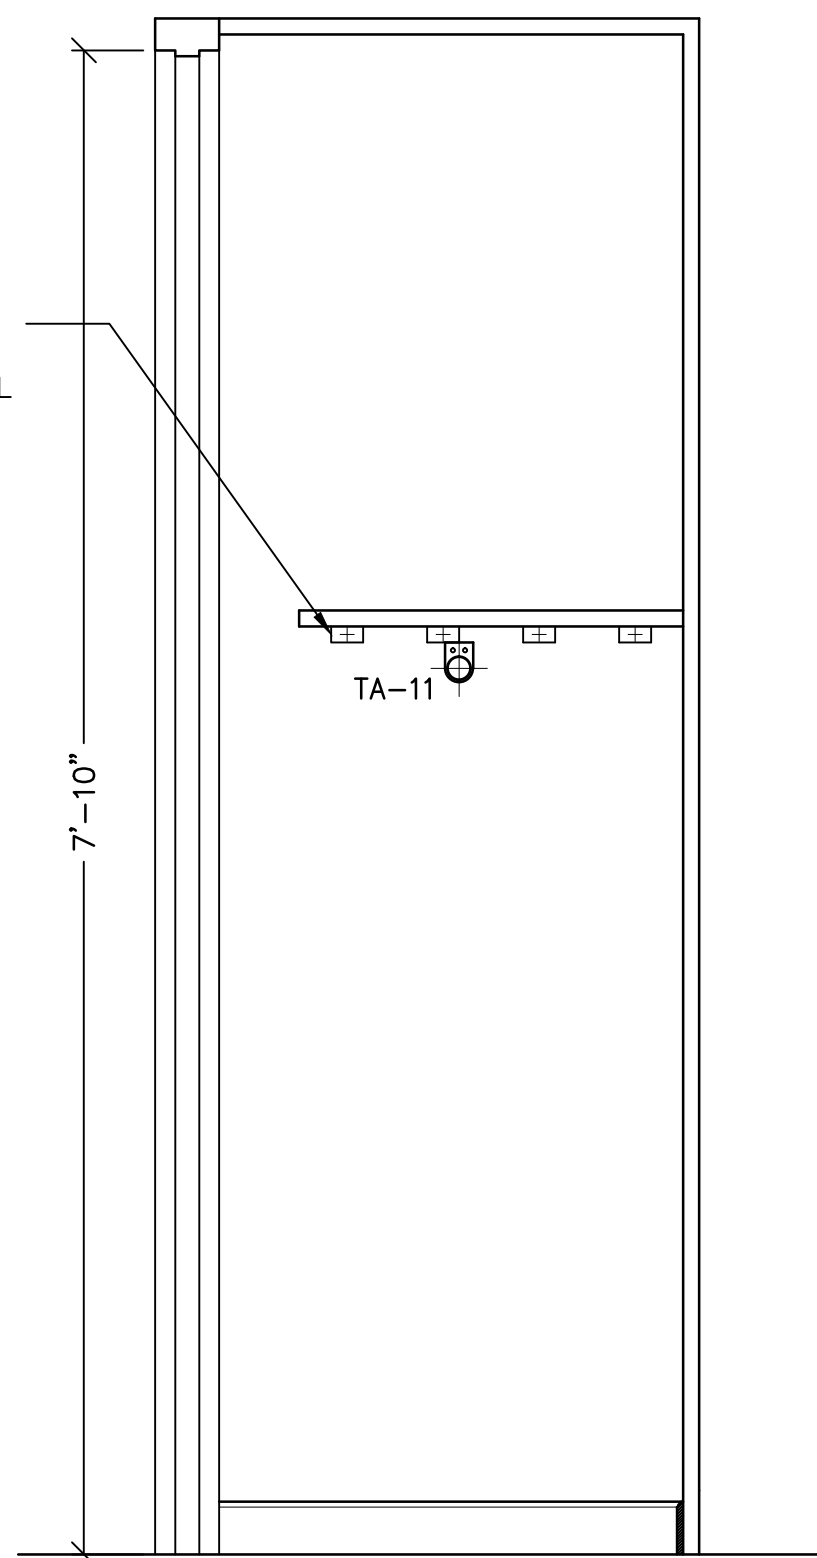

4b SECTION CLOSET (10.3)
A210
SCALE: 1" = 1'-0"

AFRIDI ASSOCIATES
CONSULTING ENGINEERS

19 West 21st Street
New York, NY 10010
Tel: (212) 243-0725
Fax: (212) 243-0725

510 Broadhollow Road
Melville, NY 11747
Tel: (631) 465-0786
Fax: (631) 465-0788

aafridi@afriassociates.com

LIZARDOS

LONG ISLAND | NEW YORK CITY | CHARLOTTE | DANBURY

200 Old Country Road | Suite 670
Mineola | NY 11501
516 484 1020 Lizardos.com

Lizardos Engineering Associates D.P.C.

Designer:	AKBER AFRIDI, P.E.
Drawn by:	AZHER MALIK
Checked by:	AKBER AFRIDI, P.E.

Project:
**INTERIOR RENOVATIONS OF
THE COMMONS APARTMENTS
10.1 (ADA COMPLIANT) & 10.3**

Address:
735 Anderson Hill Road
Purchase NY 10577


Drawing Title:
**BEDROOM CLOSET DETAILS
(TYP.)**

Drawing No.:
A210.00

Scale: AS NOTED

Date: 08/24/2020


SU-040623

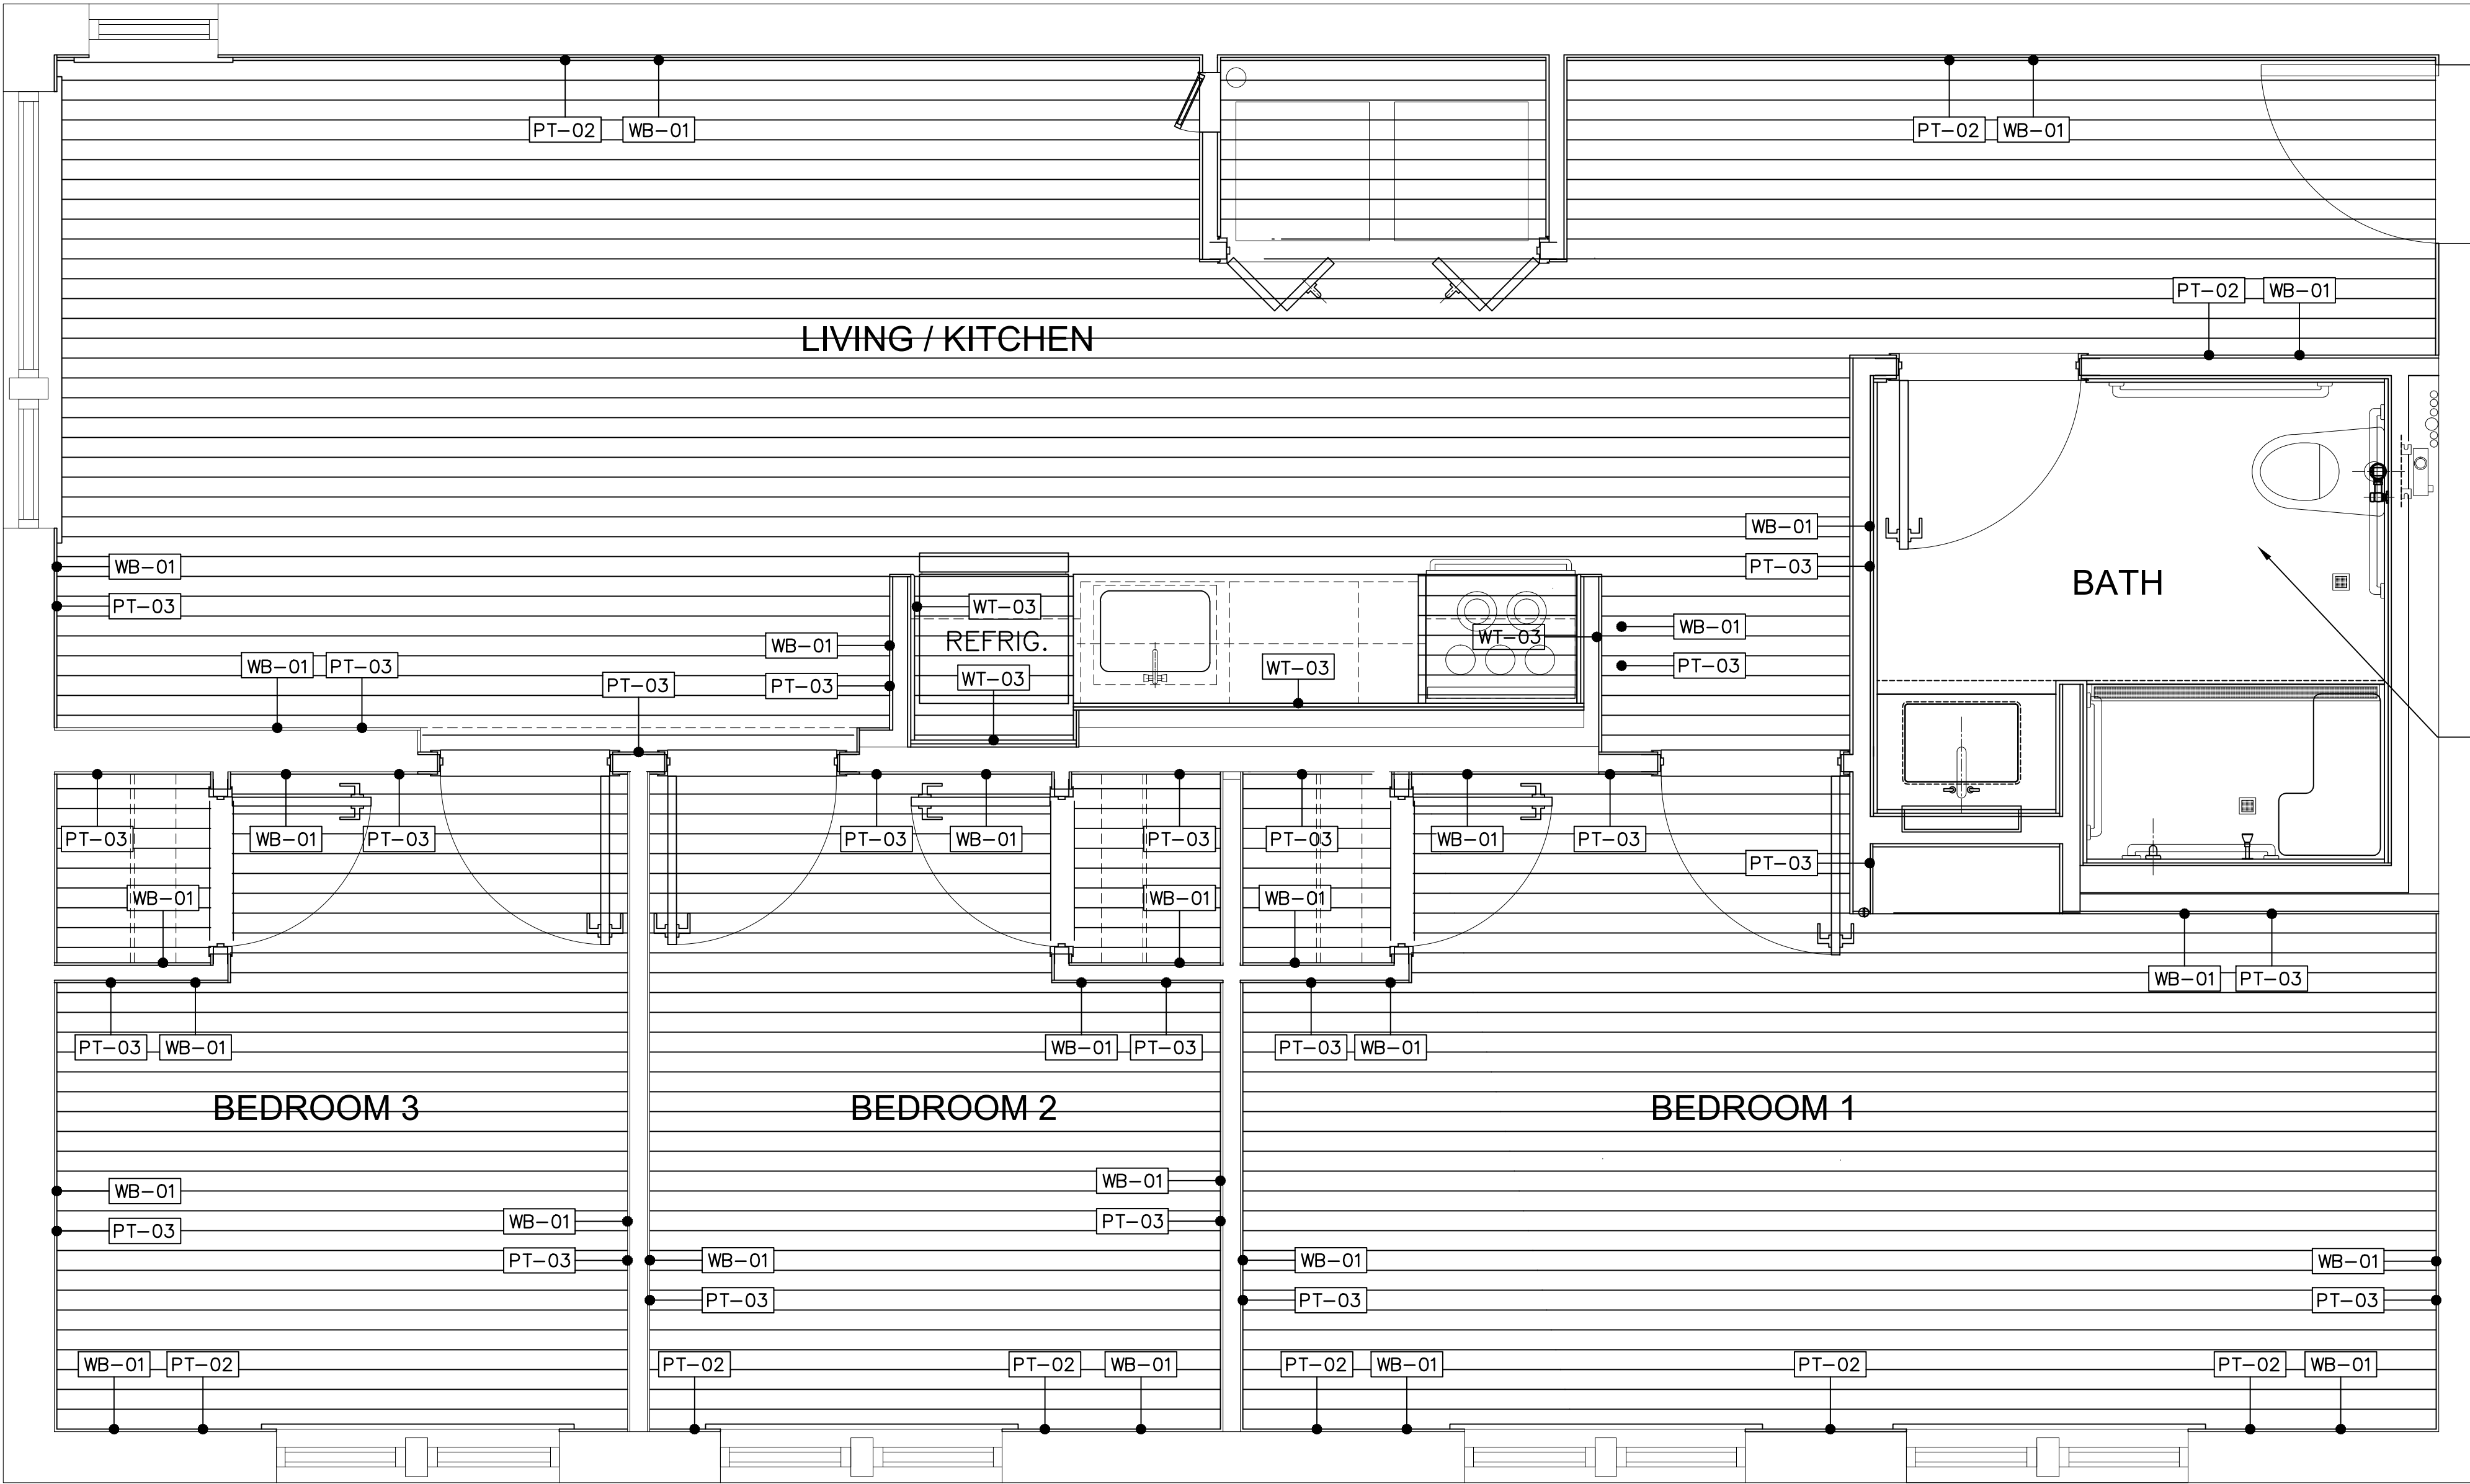

- LEGEND**
- VINYL FLOOR PLANK (VF-01)
 - CERAMIC TILES (KITCHEN)
 - 12"x12" CERAMIC FLOOR TILES (BATHROOM)
 - 2"x2" CERAMIC FLOOR TILES (SHOWER)
 - PLYWOOD/SUBFLOOR

- NOTES**
- LEVEL SUBFLOOR AS REQUIRED PRIOR TO INSTALLING FINISH FLOOR.
 - PROVIDE WATERPROOFING MEMBRANE UNDER NEW KITCHEN BASE CABINETS AND SINK AS PER VINYL PLANKING MANUFACTURER'S INSTRUCTIONS.
 - PROVIDE COLOR SAMPLES AND FULL SIZE TILE SAMPLES FOR APPROVAL PRIOR TO INSTALLATION.
 - USE VINYL FLOOR MANUFACTURER'S INSTRUCTION FOR INSTALLING UNDERLAYMENT.
 - ALL DOOR STOPS TO BE INSTALLED ON BASEBOARD/TILED WALL. DO NOT INSTALL ON FINISH FLOOR.
 - ELECTRICAL RECEPTACLES NEAR WET AREA TO BE GFCI OUTLETS.

FOR BATHROOM FLOOR FINISH REFER TO DWG A202

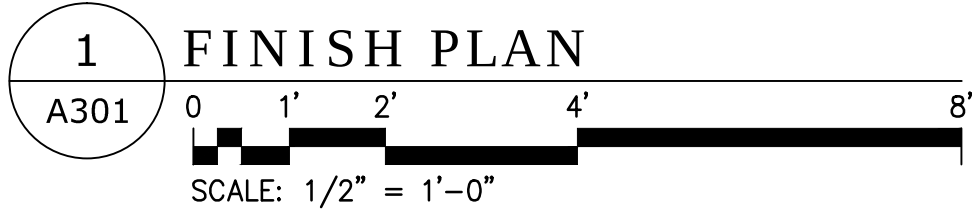

FINISH SCHEDULE				
FIN. TAG	FIN. DESCRIPTION	MANUFACTURER	FIN. SPECS	NOTES
TILE FINISH				
FT-01	CERAMIC FLOOR TILE	DALTILE	12"x12", COLOR TBD	BATHROOM FLOOR
FT-02	CERAMIC FLOOR TILE (SHOWER AREA)	DALTILE	(2"x2" MOSAIC) CERMIC, MATT FINISH, COLOR CODE D617	SHOWER AREA
WT-03	GLAZED CERAMIC WALL TILE	DALTILE	12"x12", WHITE	KITCHEN WALLS
WT-03	GLAZED CERAMIC WALL TILE	DALTILE	4"x12", VITRUVIAN LIGHT GREY GLOSSY	BATHROOM WALLS
WT-04	GLAZED CERAMIC WALL TILE	DALTILE	4"x12", MOD WALL GLOSSY ARCTIC WHITE 0190	BATHROOM WALLS

VINYL FLOOR PLANKING				
VF-01	VINYL	LIFEPROOF	8.7" W BURNT OAK CLICK LOCK, LUXURY VINYL PLANK FLOORING	LIVING AREA/ FOYER BEDROOMS
WALL BASE				
WB-01	WOOD (PRIMED)	WOODGRAIN MILLWORK	5/8" x 4 1/4" x 96" LATEX PAINT, MATCHING TO PT-01	FOYER, LIVING AREA, BEDROOM, KITCHEN (SIDE WALLS), LAUNDRY
PAINT				
PT-01	WHITE	BENJAMIN MOORE	COLOR: SUPER WHITE, OC-152 FINISH: EGGSHELL	TRIM, DOORS, CEILING REFER TO FLOOR PLAN
PT-02	LIGHT GREY	BENJAMIN MOORE	COLOR: COVENTRY GRAY, HC-169 FINISH: SATIN	ACCENT WALL REFER TO FLOOR PLAN
PT-03	WHITE	BENJAMIN MOORE	COLOR: DECORATOR'S WHITE, OC-149 FINISH: EGGSHELL	LIVING AREA, BEDROOM

AFRIDI ASSOCIATES
CONSULTING ENGINEERS

19 West 21st Street
New York, NY 10010
Tel: (212) 243-0725
Fax: (212) 243-0725

510 Broadhollow Road
Melville, NY 11747
Tel: (631) 465-0786
Fax: (631) 465-0788

aafridi@afridiassociates.com

LIZARDOS
LONG ISLAND | NEW YORK CITY | CHARLOTTE | DANBURY

200 Old Country Road | Suite 670
Mineola | NY 11501
516 484 1020 Lizardos.com

Lizardos Engineering Associates D.P.C.

Designer: AKBER AFRIDI, P.E.

Drawn by: AZHER MALIK

Checked by: AKBER AFRIDI, P.E.

Project:
INTERIOR RENOVATIONS OF THE COMMONS APARTMENTS 10.1 (ADA COMPLIANT) & 10.3


Address:
735 Anderson Hill Road
Purchase NY 10577

Drawing Title:
FINISHES PLAN (FLOOR & WALL) ADA APARTMENT 10.1

Drawing No.:
A301.00

Scale: AS NOTED


Date: 08/24/2020

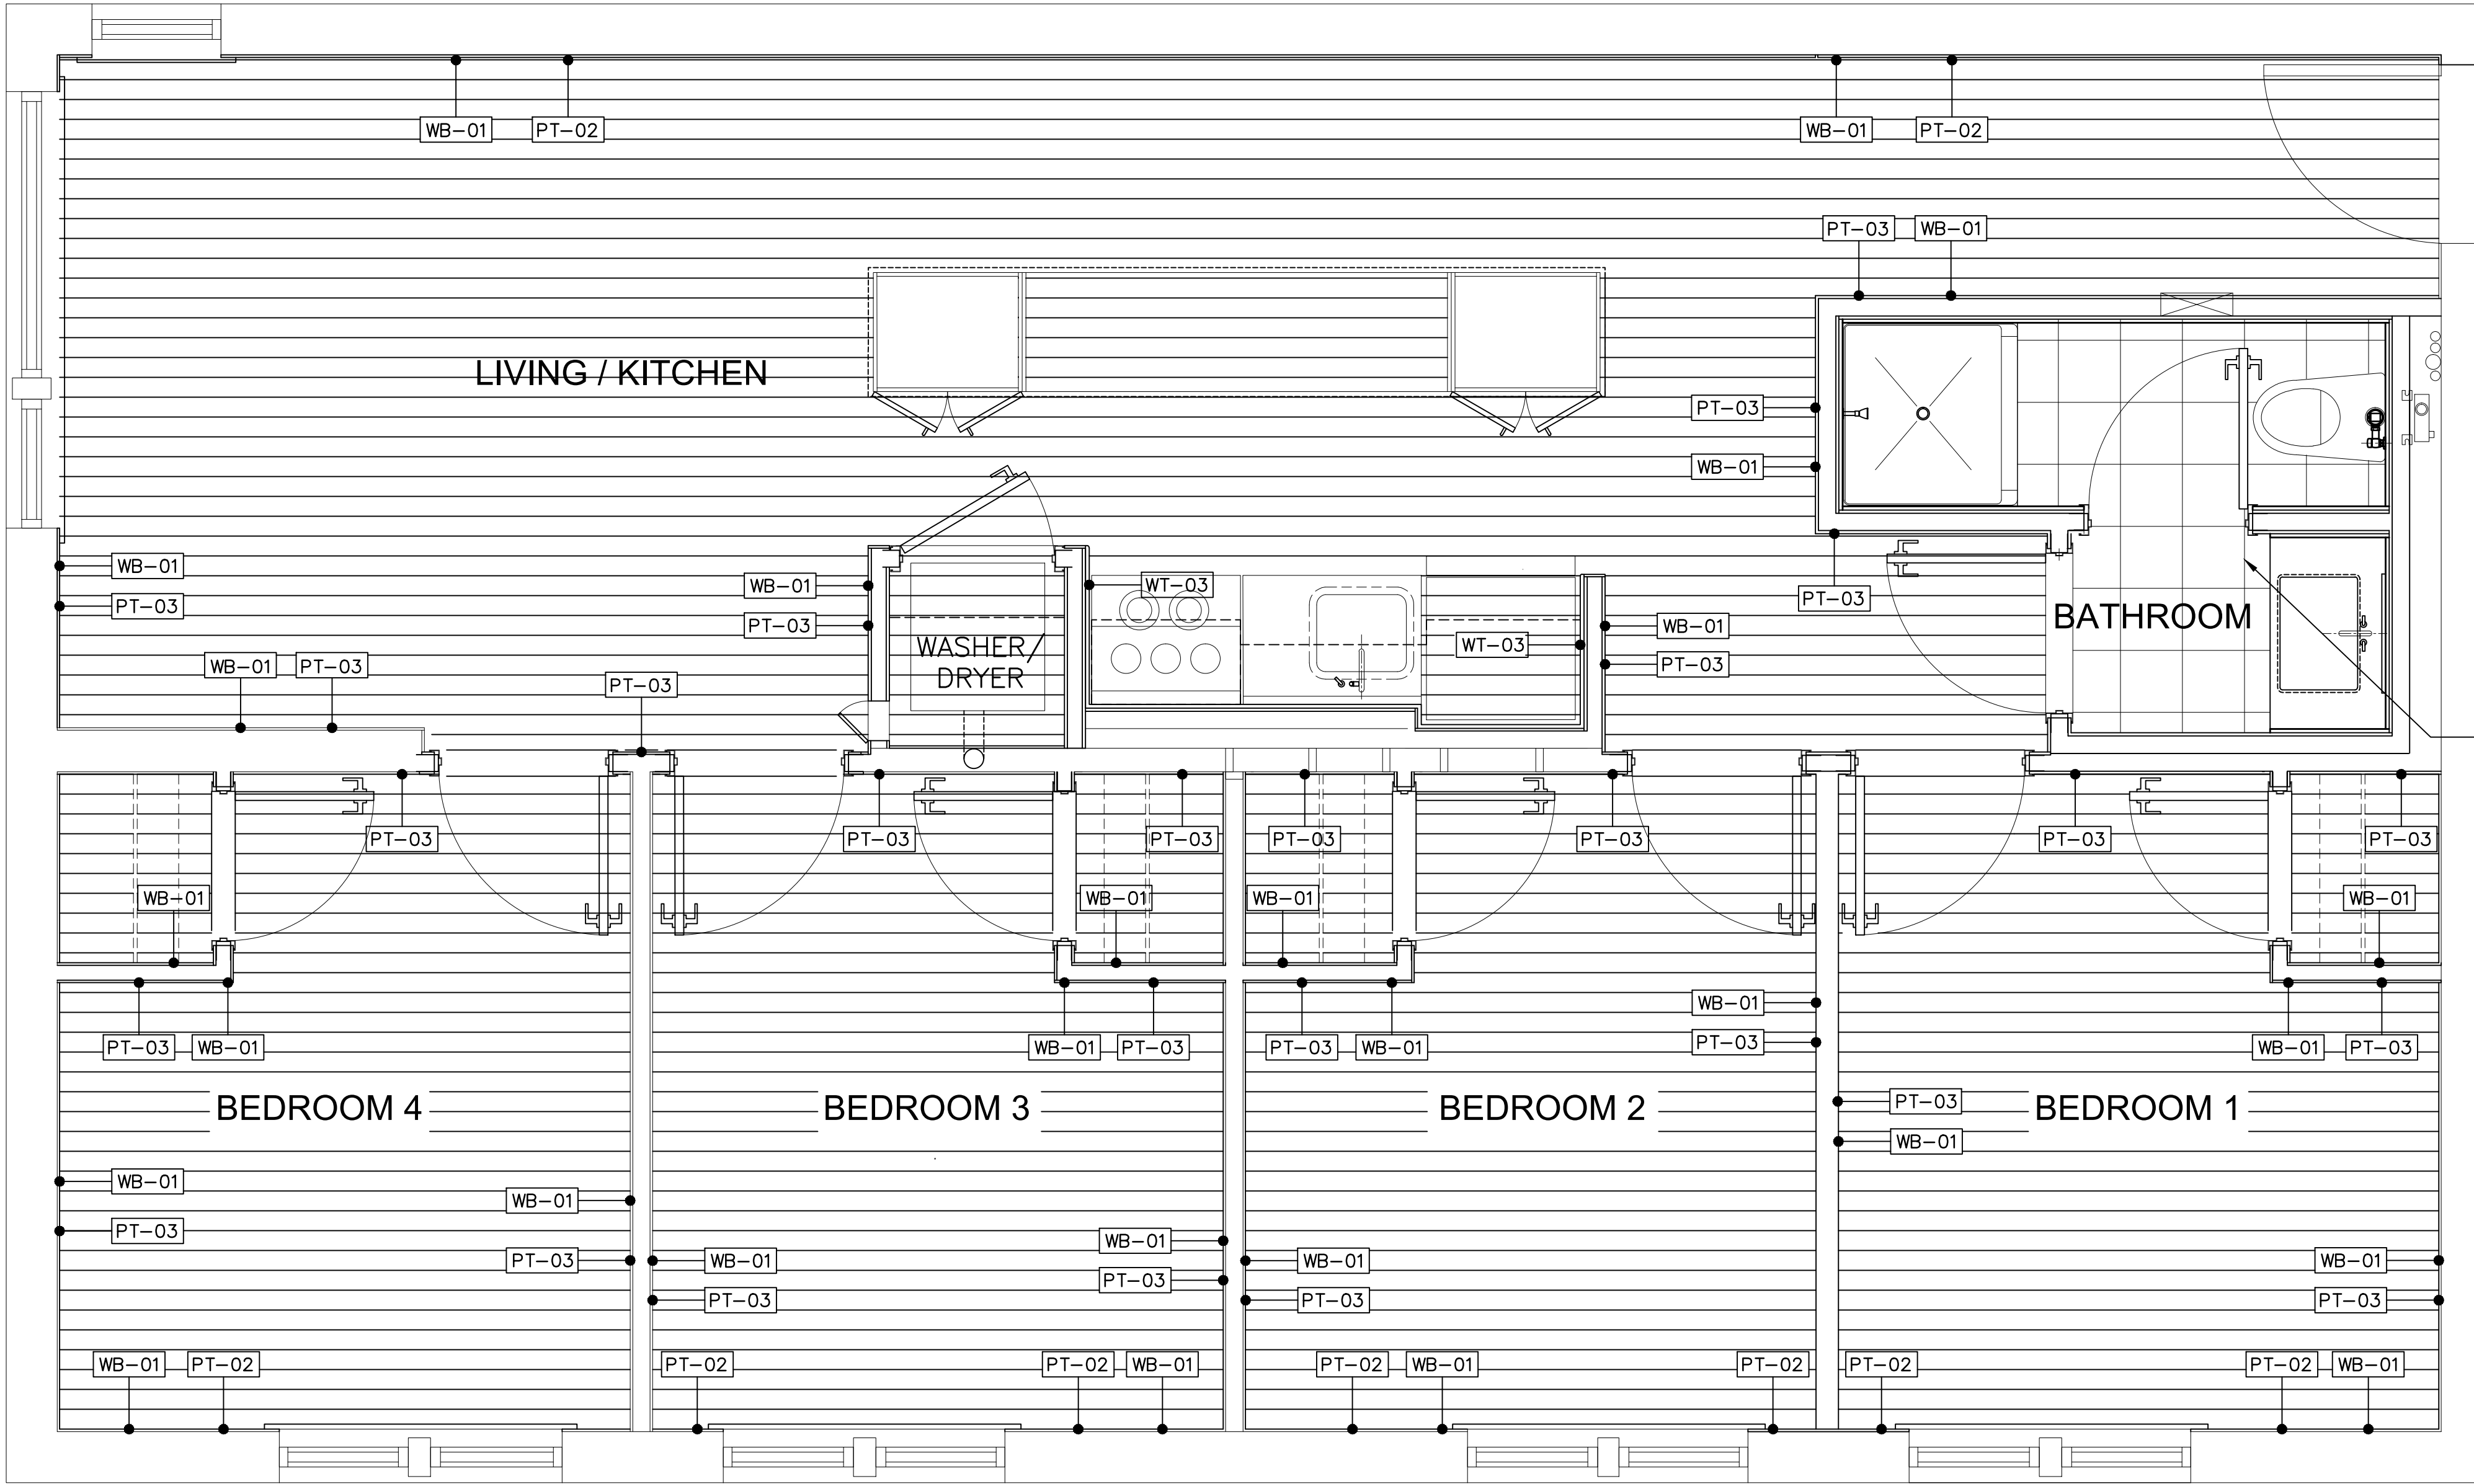

- LEGEND**
- VINYL FLOOR PLANK (VF-01)
 - CERAMIC TILES (KITCHEN)
 - 12"x12" CERAMIC FLOOR TILES (BATHROOM)
 - 2"x2" CERAMIC FLOOR TILES (SHOWER)
 - PLYWOOD/SUBFLOOR

- NOTES**
- LEVEL SUBFLOOR AS REQUIRED PRIOR TO INSTALLING FINISH FLOOR.
 - PROVIDE WATERPROOFING MEMBRANE UNDER NEW KITCHEN BASE CABINETS AND SINK AS PER VINYL PLANKING MANUFACTURER'S INSTRUCTIONS.
 - PROVIDE COLOR SAMPLES AND FULL SIZE TILE SAMPLES FOR APPROVAL PRIOR TO INSTALLATION.
 - USE VINYL FLOOR MANUFACTURER'S INSTRUCTION FOR INSTALLING UNDERLAYMENT.
 - ALL DOOR STOPS TO BE INSTALLED ON BASEBOARD/TILED WALL. DO NOT INSTALL ON FINISH FLOOR.
 - ELECTRICAL RECEPTACLES NEAR WET AREA TO BE GFCI OUTLETS.

FOR BATHROOM FLOOR FINISH REFER TO DWG A204

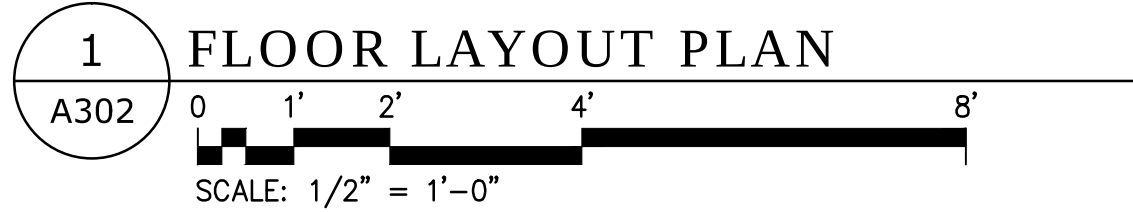

FINISH SCHEDULE				
FIN. TAG	FIN. DESCRIPTION	MANUFACTURER	FIN. SPECS	NOTES
TILE FINISH				
FT-01	CERAMIC FLOOR TILE	DALTILE	12"x12", COLOR TO BE DECIDED	BATHROOM FLOOR
FT-02	—	—	—	—
WT-03	GLAZED CERAMIC WALL TILE	DALTILE	12"x12", WHITE	KITCHEN WALLS
WT-03	GLAZED CERAMIC WALL TILE	DALTILE	4"x12", VITRUVIAN LIGHT GREY GLOSSY	BATHROOM WALLS
WT-04	GLAZED CERAMIC WALL TILE	DALTILE	4"x12", MOD WALL GLOSSY ARCTIC WHITE 0190	BATHROOM WALLS

VINYL FLOOR PLANKING				
VF-01	VINYL	LIFEPROOF	8.7" W BURNT OAK CLICK LOCK, LUXURY VINYL PLANK FLOORING	LIVING AREA/ FOYER BEDROOMS
WALL BASE				
WB-01	WOOD (PRIMED)	WOODGRAIN MILLWORK	5/8" x 4 1/2" x 96" LATEX PAINT, MATCHING TO PT-01	FOYER, LIVING AREA, BEDROOM, KITCHEN (SIDE WALLS)
PAINT				
PT-01	WHITE	BENJAMIN MOORE	COLOR: SUPER WHITE, OC-152 FINISH: EGGSHELL	TRIM, DOORS, CEILING REFER TO FLOOR PLAN
PT-02	LIGHT GREY	BENJAMIN MOORE	COLOR: COVENTRY GRAY, HC-169 FINISH: SATIN	ACCENT WALL REFER TO FLOOR PLAN
PT-03	WHITE	BENJAMIN MOORE	COLOR: DECORATOR'S WHITE, OC-149 FINISH: EGGSHELL	LIVING AREA, BEDROOM

AFRIDI ASSOCIATES
CONSULTING ENGINEERS

19 West 21st Street
New York, NY 10010
Tel: (212) 243-0725
Fax: (212) 243-0725

510 Broadhollow Road
Melville, NY 11747
Tel: (631) 465-0786
Fax: (631) 465-0788
aafridi@afridiassociates.com

LIZARDOS
LONG ISLAND | NEW YORK CITY | CHARLOTTE | DANBURY

200 Old Country Road | Suite 670
Mineola | NY 11501
516 484 1020 Lizardos.com

Lizardos Engineering Associates D.P.C.


Designer:	AKBER AFRIDI, P.E.
Drawn by:	AZHER MALIK
Checked by:	AKBER AFRIDI, P.E.

Project:
INTERIOR RENOVATIONS OF THE COMMONS APARTMENTS 10.1 (ADA COMPLIANT) & 10.3

Address:
735 Anderson Hill Road
Purchase NY 10577

Drawing Title:
FINISHES PLAN (FLOOR & WALL) APARTMENT 10.3

Drawing No.:	A302.00
Scale:	AS NOTED
Date:	08/24/2020

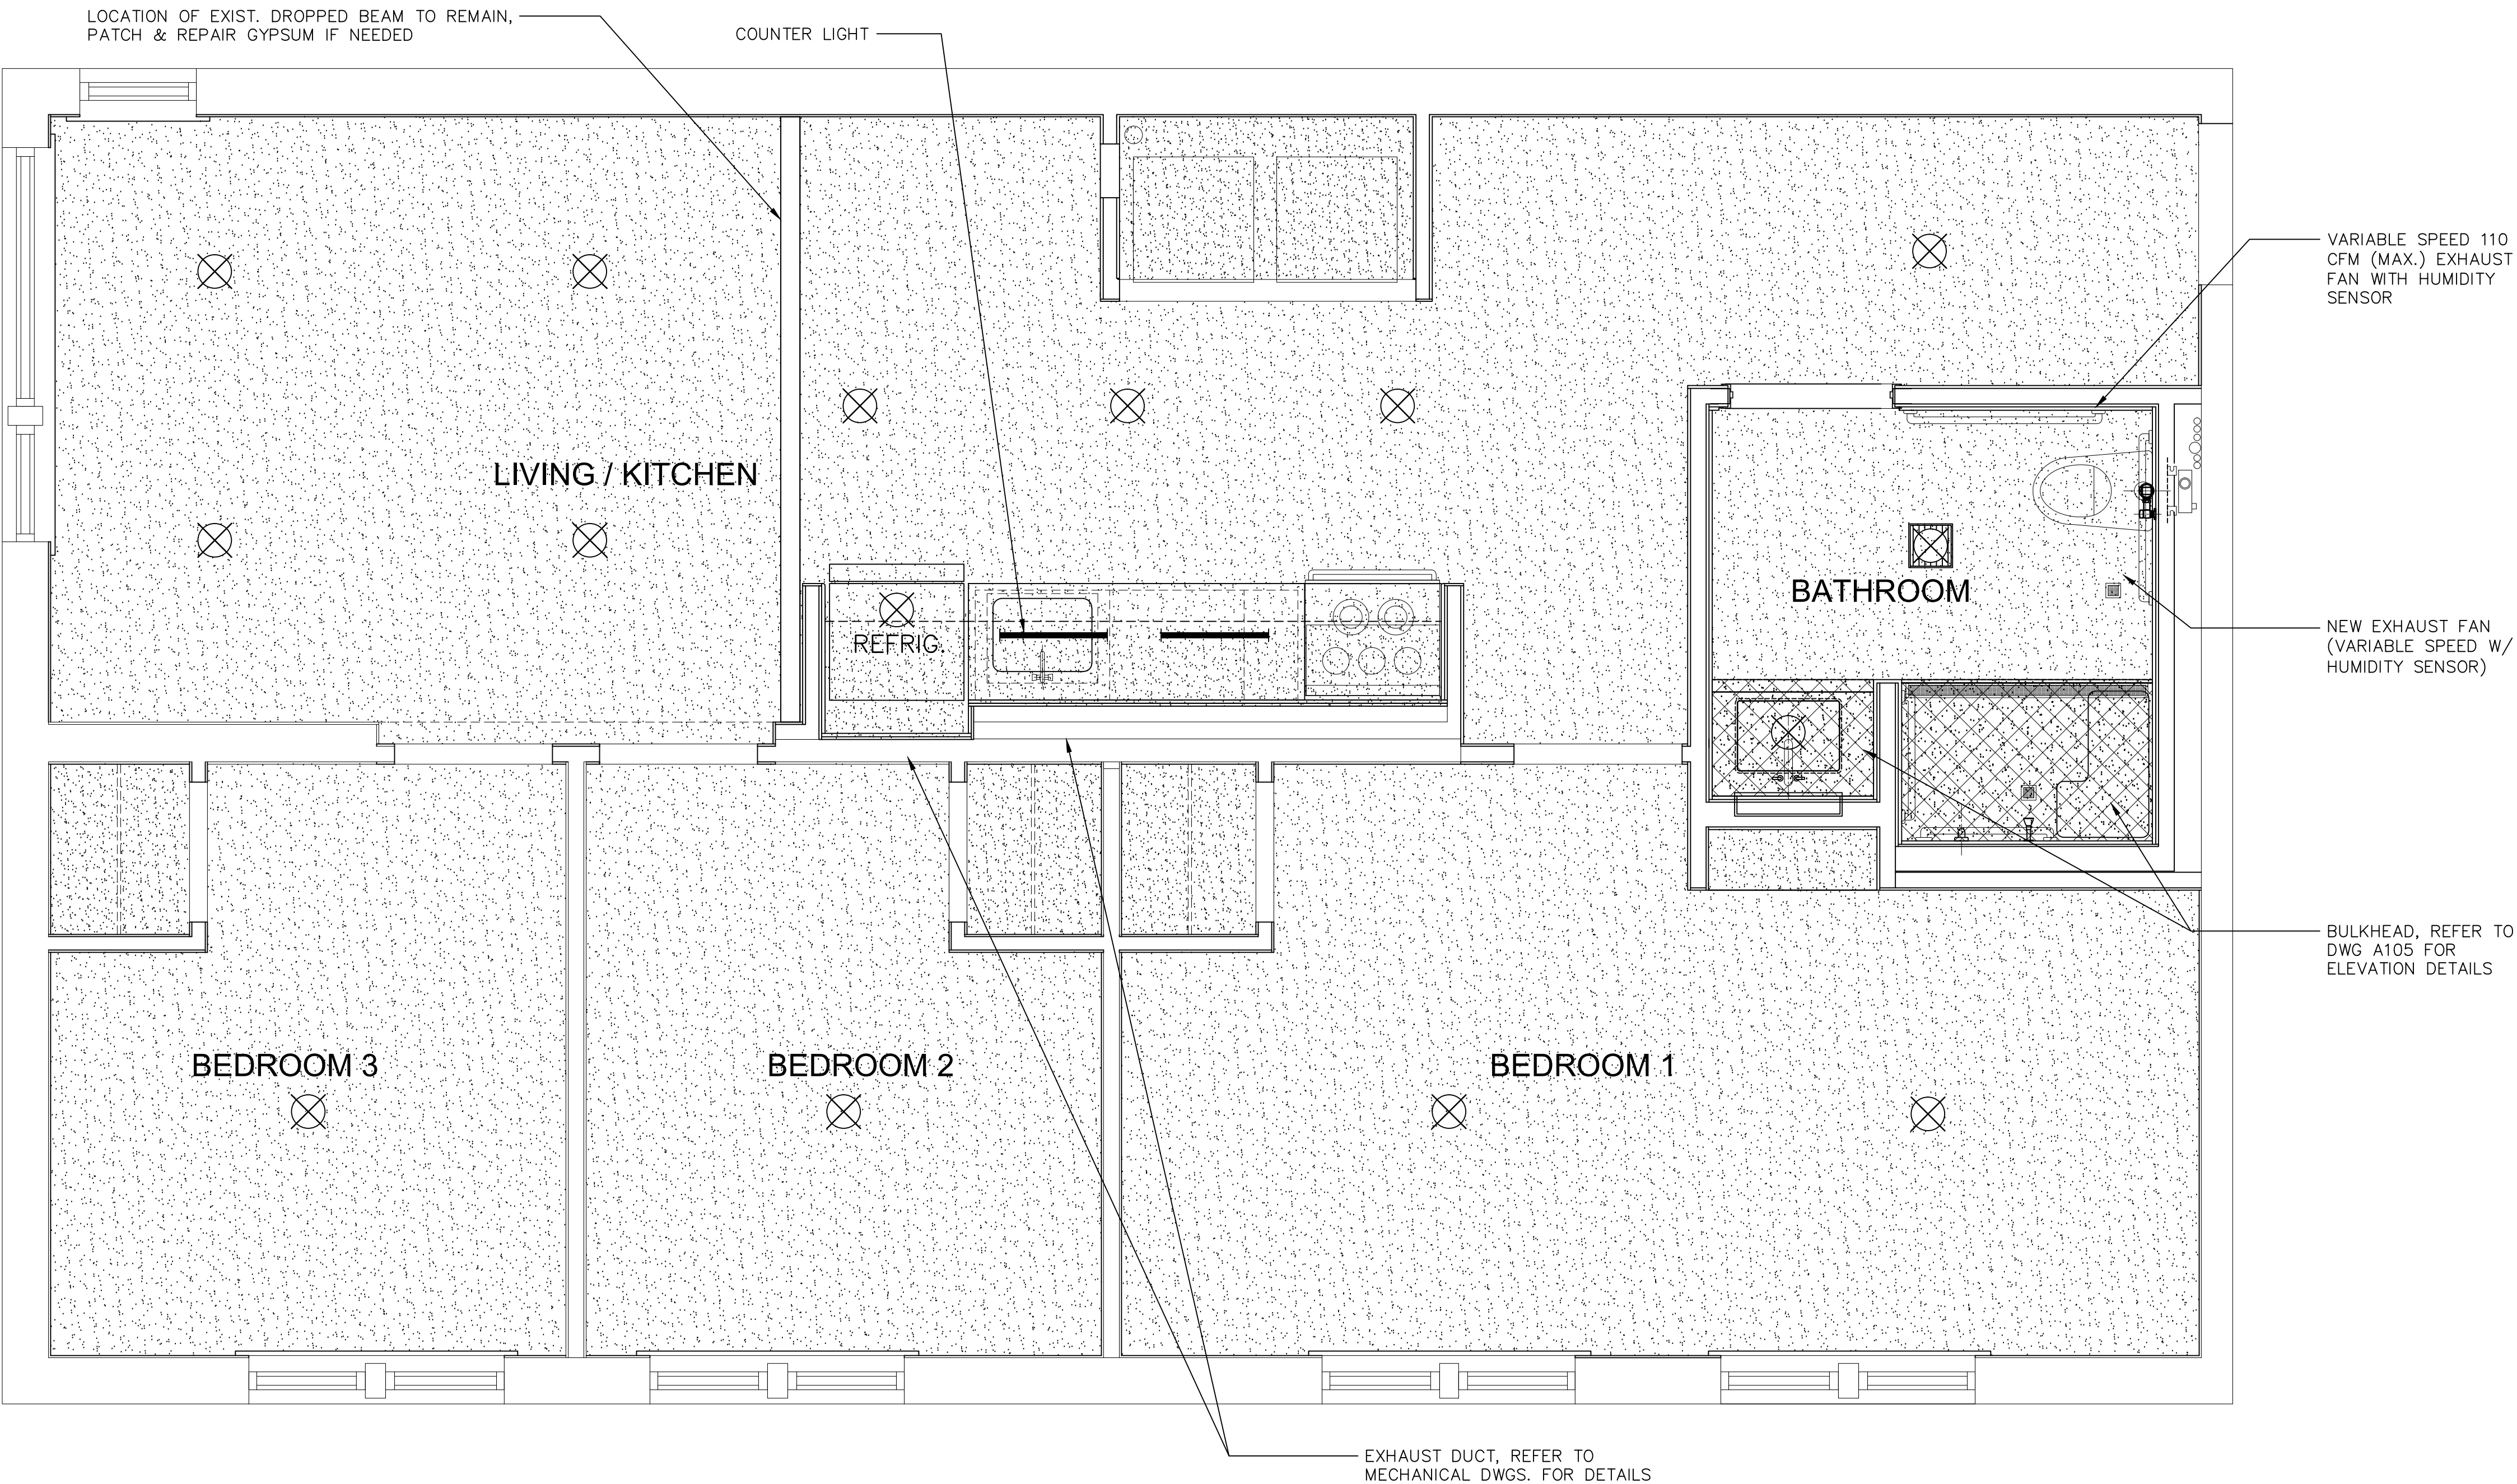

1 REFLECTED CEILING PLAN
A303
0 1' 2' 4' 8'
SCALE: 1/2" = 1'-0"

FINISH SCHEDULE				
FIN. TAG	FIN. DESCRIPTION	MANUFACTURER	FIN. SPECS	NOTES
CEILING FINISH				
GWB-01	GYPSUM WALL BOARD CEILING	USG	5/8" GYPSUM WALL BOARD WITH USG DRYWALL SUSPENSION SYSTEM OR LIGHT GAUGE FRAMING AT SOFFITS, FINISH AS NOTED	FOYER, LIVING AREA, BEDROOM REFER TO CEILING PLAN
GWB-02	WONDERBOARD LITE, BACKER BOARD OR APPROVED EQUAL.	CUSTOM BUILDING PRODUCTS	7/16" WONDERBOARD LITE OR APPROVED EQUAL, BACKER BOARD FOR BATHROOM AND KITCHEN WALLS	BATHROOM CEILING, SINK AND SHOWER AREA SOFFIT, KITCHEN SOFFIT REFER TO CEILING PLAN
GWB-03	GOLD BOND, PURPLE XP MOLD & MOISTURE RESISTANT DRYWALL	GOLD BOND BUILDING PRODUCTS	1/2" GOLD BOND, PURPLE XP MOLD & MOISTURE RESISTANT DRYWALL ON WOOD FRAMING, AS SHOWN IN DRAWING.	FOR EXISTING DRYWALL REPAIR AND NEW WALLS IN FOYER, LIVING AREA, BEDROOM

SU-040623


AFRIDI ASSOCIATES
CONSULTING ENGINEERS

19 West 21st Street
New York, NY 10010
Tel: (212) 243-0725
Fax: (212) 243-0725






510 Broadhollow Road
Melville, NY 11747
Tel: (631) 465-0786
Fax: (631) 465-0788
aafridi@afriassociates.com

LIZARDOS
LONG ISLAND | NEW YORK CITY | CHARLOTTE | DANBURY
200 Old Country Road | Suite 670
Mineola | NY 11501
516 484 1020 Lizardos.com
Lizardos Engineering Associates D.P.C.

Designer:	AKBER AFRIDI, P.E.
Drawn by:	AZHER MALIK
Checked by:	AKBER AFRIDI, P.E.
Project: INTERIOR RENOVATIONS OF THE COMMONS APARTMENTS 10.1 (ADA COMPLIANT) & 10.3	
Address: 735 Anderson Hill Road Purchase NY 10577	
Drawing Title: FINISHES (CEILING & SOFFIT) ADA APARTMENT 10.1	
	Drawing No.: A303.00
	Scale: AS NOTED
	Date: 08/24/2020

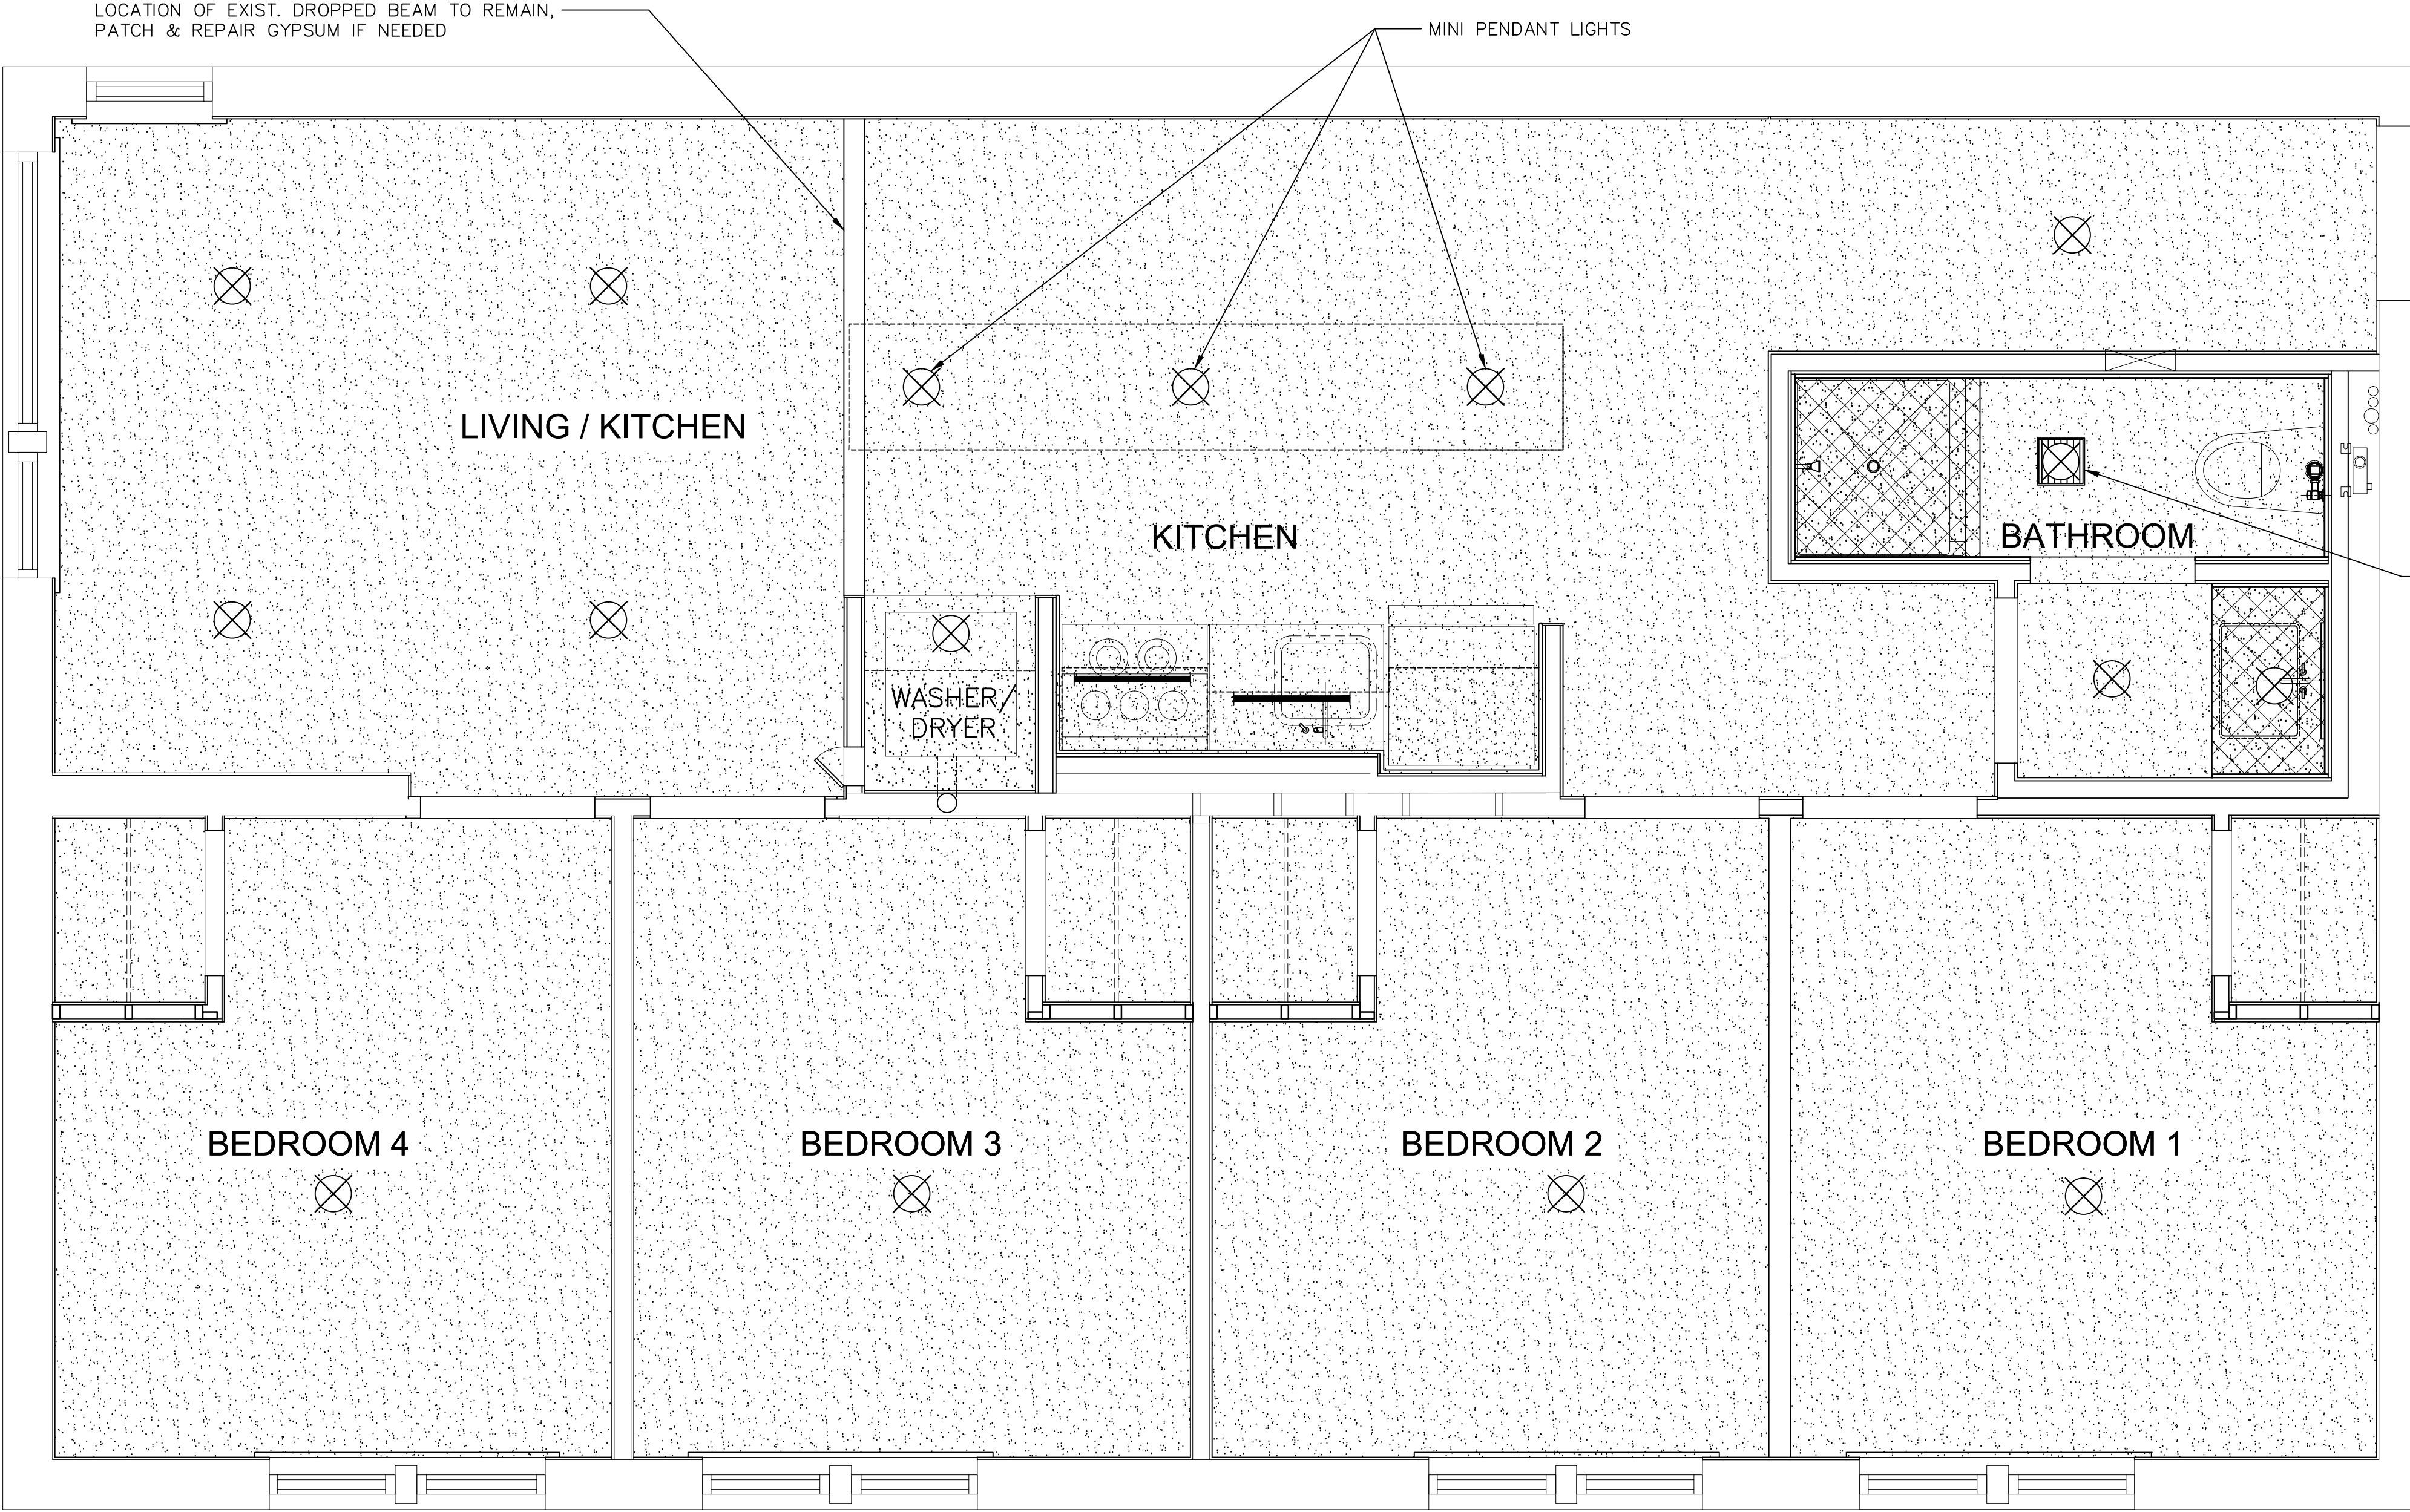

LEGEND

 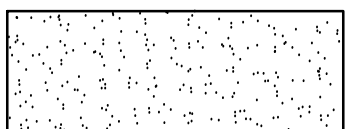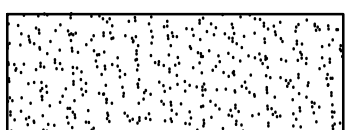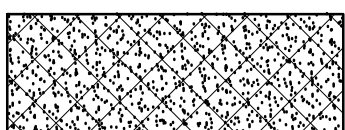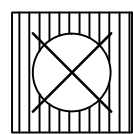-  SHEETROCK (MOISTURE RESISTANT)
-  SHEETROCK (ABOVE CABINETS/SHELVES)
-  GWB-02 WET AREA
-  CEILING MOUNTED LUMINAIRE
-  CEILING MOUNTED EXHAUST FAN (15"x15") W/ LIGHT & HUMIDITY SENSOR

1 REFLECTED CEILING PLAN
A304
0 1' 2' 4' 8'
SCALE: 1/2" = 1'-0"

FINISH SCHEDULE				
FIN. TAG	FIN. DESCRIPTION	MANUFACTURER	FIN. SPECS	NOTES
CEILING FINISH				
GWB-01	GYPSUM WALL BOARD CEILING	USG	5/8" GYPSUM WALL BOARD WITH USG DRYWALL SUSPENSION SYSTEM OR LIGHT GAUGE FRAMING AT SOFFITS, FINISH AS NOTED	FOYER, LIVING AREA, BEDROOM REFER TO CEILING PLAN
GWB-02	WONDERBOARD LITE, BACKER BOARD OR APPROVED EQUAL.	CUSTOM BUILDING PRODUCTS	7/16" WONDERBOARD LITE OR APPROVED EQUAL, BACKER BOARD FOR BATHROOM AND KITCHEN WALLS	BATHROOM CEILING, SINK AND SHOWER AREA SOFFIT, KITCHEN SOFFIT REFER TO CEILING PLAN
GWB-03	GOLD BOND, PURPLE XP MOLD & MOISTURE RESISTANT DRYWALL	GOLD BOND BUILDING PRODUCTS	1/2" GOLD BOND, PURPLE XP MOLD & MOISTURE RESISTANT DRYWALL ON WOOD FRAMING, AS SHOWN IN DRAWING.	FOR EXISTING DRYWALL REPAIR AND NEW WALLS IN FOYER, LIVING AREA, BEDROOM

AFRIDI ASSOCIATES
CONSULTING ENGINEERS

19 West 21st Street
New York, NY 10010
Tel: (212) 243-0725
Fax: (212) 243-0725
510 Broadhollow Road
Melville, NY 11747
Tel: (631) 465-0786
Fax: (631) 465-0788
aafridi@afriassociates.com

LIZARDOS

LONG ISLAND | NEW YORK CITY | CHARLOTTE | DANBURY

200 Old Country Road | Suite 670
Mineola | NY 11501
516 484 1020 Lizardos.com

Lizardos Engineering Associates D.P.C.

Designer: AKBER AFRIDI, P.E.
Drawn by: AZHER MALIK
Checked by: AKBER AFRIDI, P.E.

Project:
**INTERIOR RENOVATIONS OF
THE COMMONS APARTMENTS
10.1 (ADA COMPLIANT) & 10.3**

Address:
735 Anderson Hill Road
Purchase NY 10577



Drawing Title:
**FINISHES (CEILING & SOFFIT)
APARTMENT 10.3**

Drawing No.:
A304.00

Scale: AS NOTED

Date: 08/24/2020

SU-040623

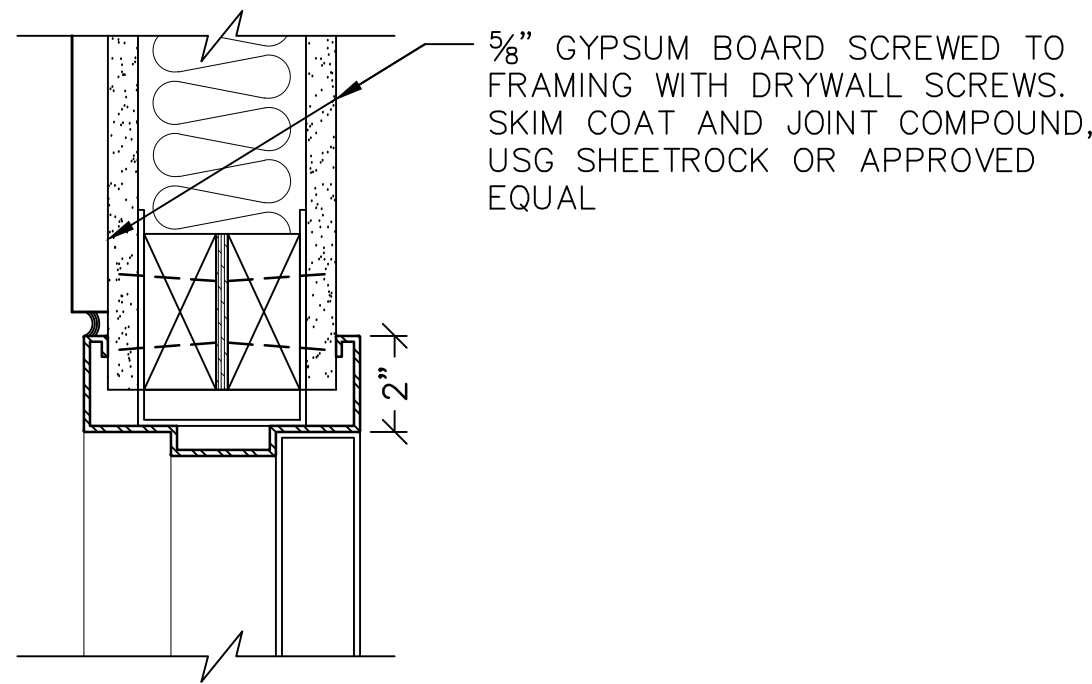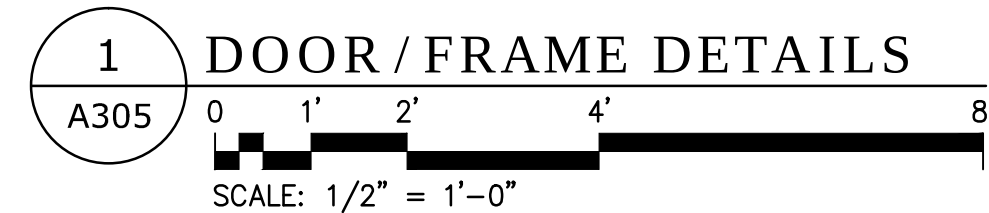

NOTES:

1. ALL DOORS SHOULD HAVE HOLLOW METAL DOOR, SHOP PAINTED JAMBS, MATCHING TO DOOR FINISH, WITH APPROPRIATE DOOR HARDWARE.
2. G.C. TO PROVIDE SPECIFICATION CATALOGUE FOR EOR'S APPROVAL.
3. G.C. TO SUBMIT HARDWARE SAMPLES PRIOR TO PLACING ORDER.

SEE DOOR SCHEDULE AND SPECIFICATION FOR HARDWARE REQUIREMENTS:


FINISH FLOOR TO CENTER LINE OF HARDWARE:

KNOB ON LOCK OR LATCH	3"
-----------------------	----

TOP HINGE – 5" FROM FRAME HEAD RABBET TO TOP OF HINGE.


CENTER HINGE – EQUAL DISTANCE FROM TOP AND BOTTOM HINGE.

BOTTOM HINGE – 10" FROM FINISH FLOOR TO UNDERSIDE OF HINGE.

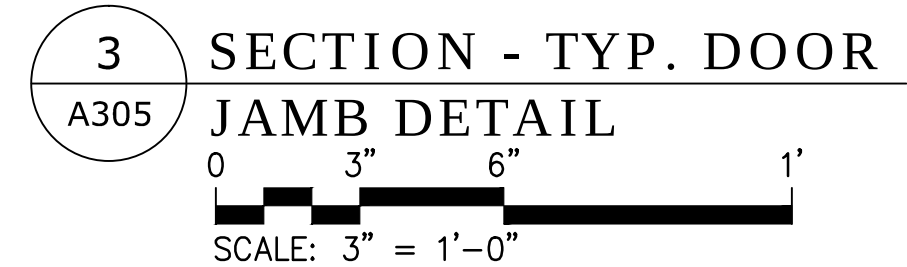

HARDWARE SCHEDULE			
REFER TO SPECIFICATIONS – SECTION 08 70 00 FINISH HARDWARE			
SET 1:		SET 2:	
3	DOOR HARDWARE/4" ROUND HINGE 5/8"	3	DOOR HARDWARE/4" ROUND HINGE 5/8"
1	F40MER626 – MERANO PRIVACY DOOR LEVER SET	1	F40MER626 – MERANO PRIVACY DOOR LEVER SET
1	61–C619, DOOR ACCESSORIES / SOLID DOOR STOP	1	61–C619, DOOR ACCESSORIES / SOLID DOOR STOP
SET 3:		SET 4:	
3	DOOR HARDWARE/4" ROUND HINGE 5/8"	3	DOOR HARDWARE/4" ROUND HINGE 5/8"
1	F40ACC619 – ACCENT PRIVACY DOOR SET	1	F51AMER626 – MERANO SINGLE CYLINDER KEYED/DOOR LEVER SET
		1	436–619, DOOR ACCESSORIES / FLOOR DOOR STOP
SET 5:		SET 6:	
3	DOOR HARDWARE/4" ROUND HINGE 5/8"	4	DOOR HARDWARE/4" ROUND HINGE 5/8"
1	F51AMER626 – MERANO SINGLE CYLINDER KEYED/DOOR LEVER SET	1	F40ACC619 – ACCENT PRIVACY DOOR SET
1	436–619, DOOR ACCESSORIES / FLOOR DOOR STOP	1	
SET 7:		SET 8:	
4	DOOR HARDWARE/4" ROUND HINGE 5/8"	4	DOOR HARDWARE/4" ROUND HINGE 5/8"
1	F10MER626 – MERANO PASSAGE DOOR LEVER SET	2	F10MER626 – MERANO PASSAGE DOOR LEVER SET

Date: 08/24/2020

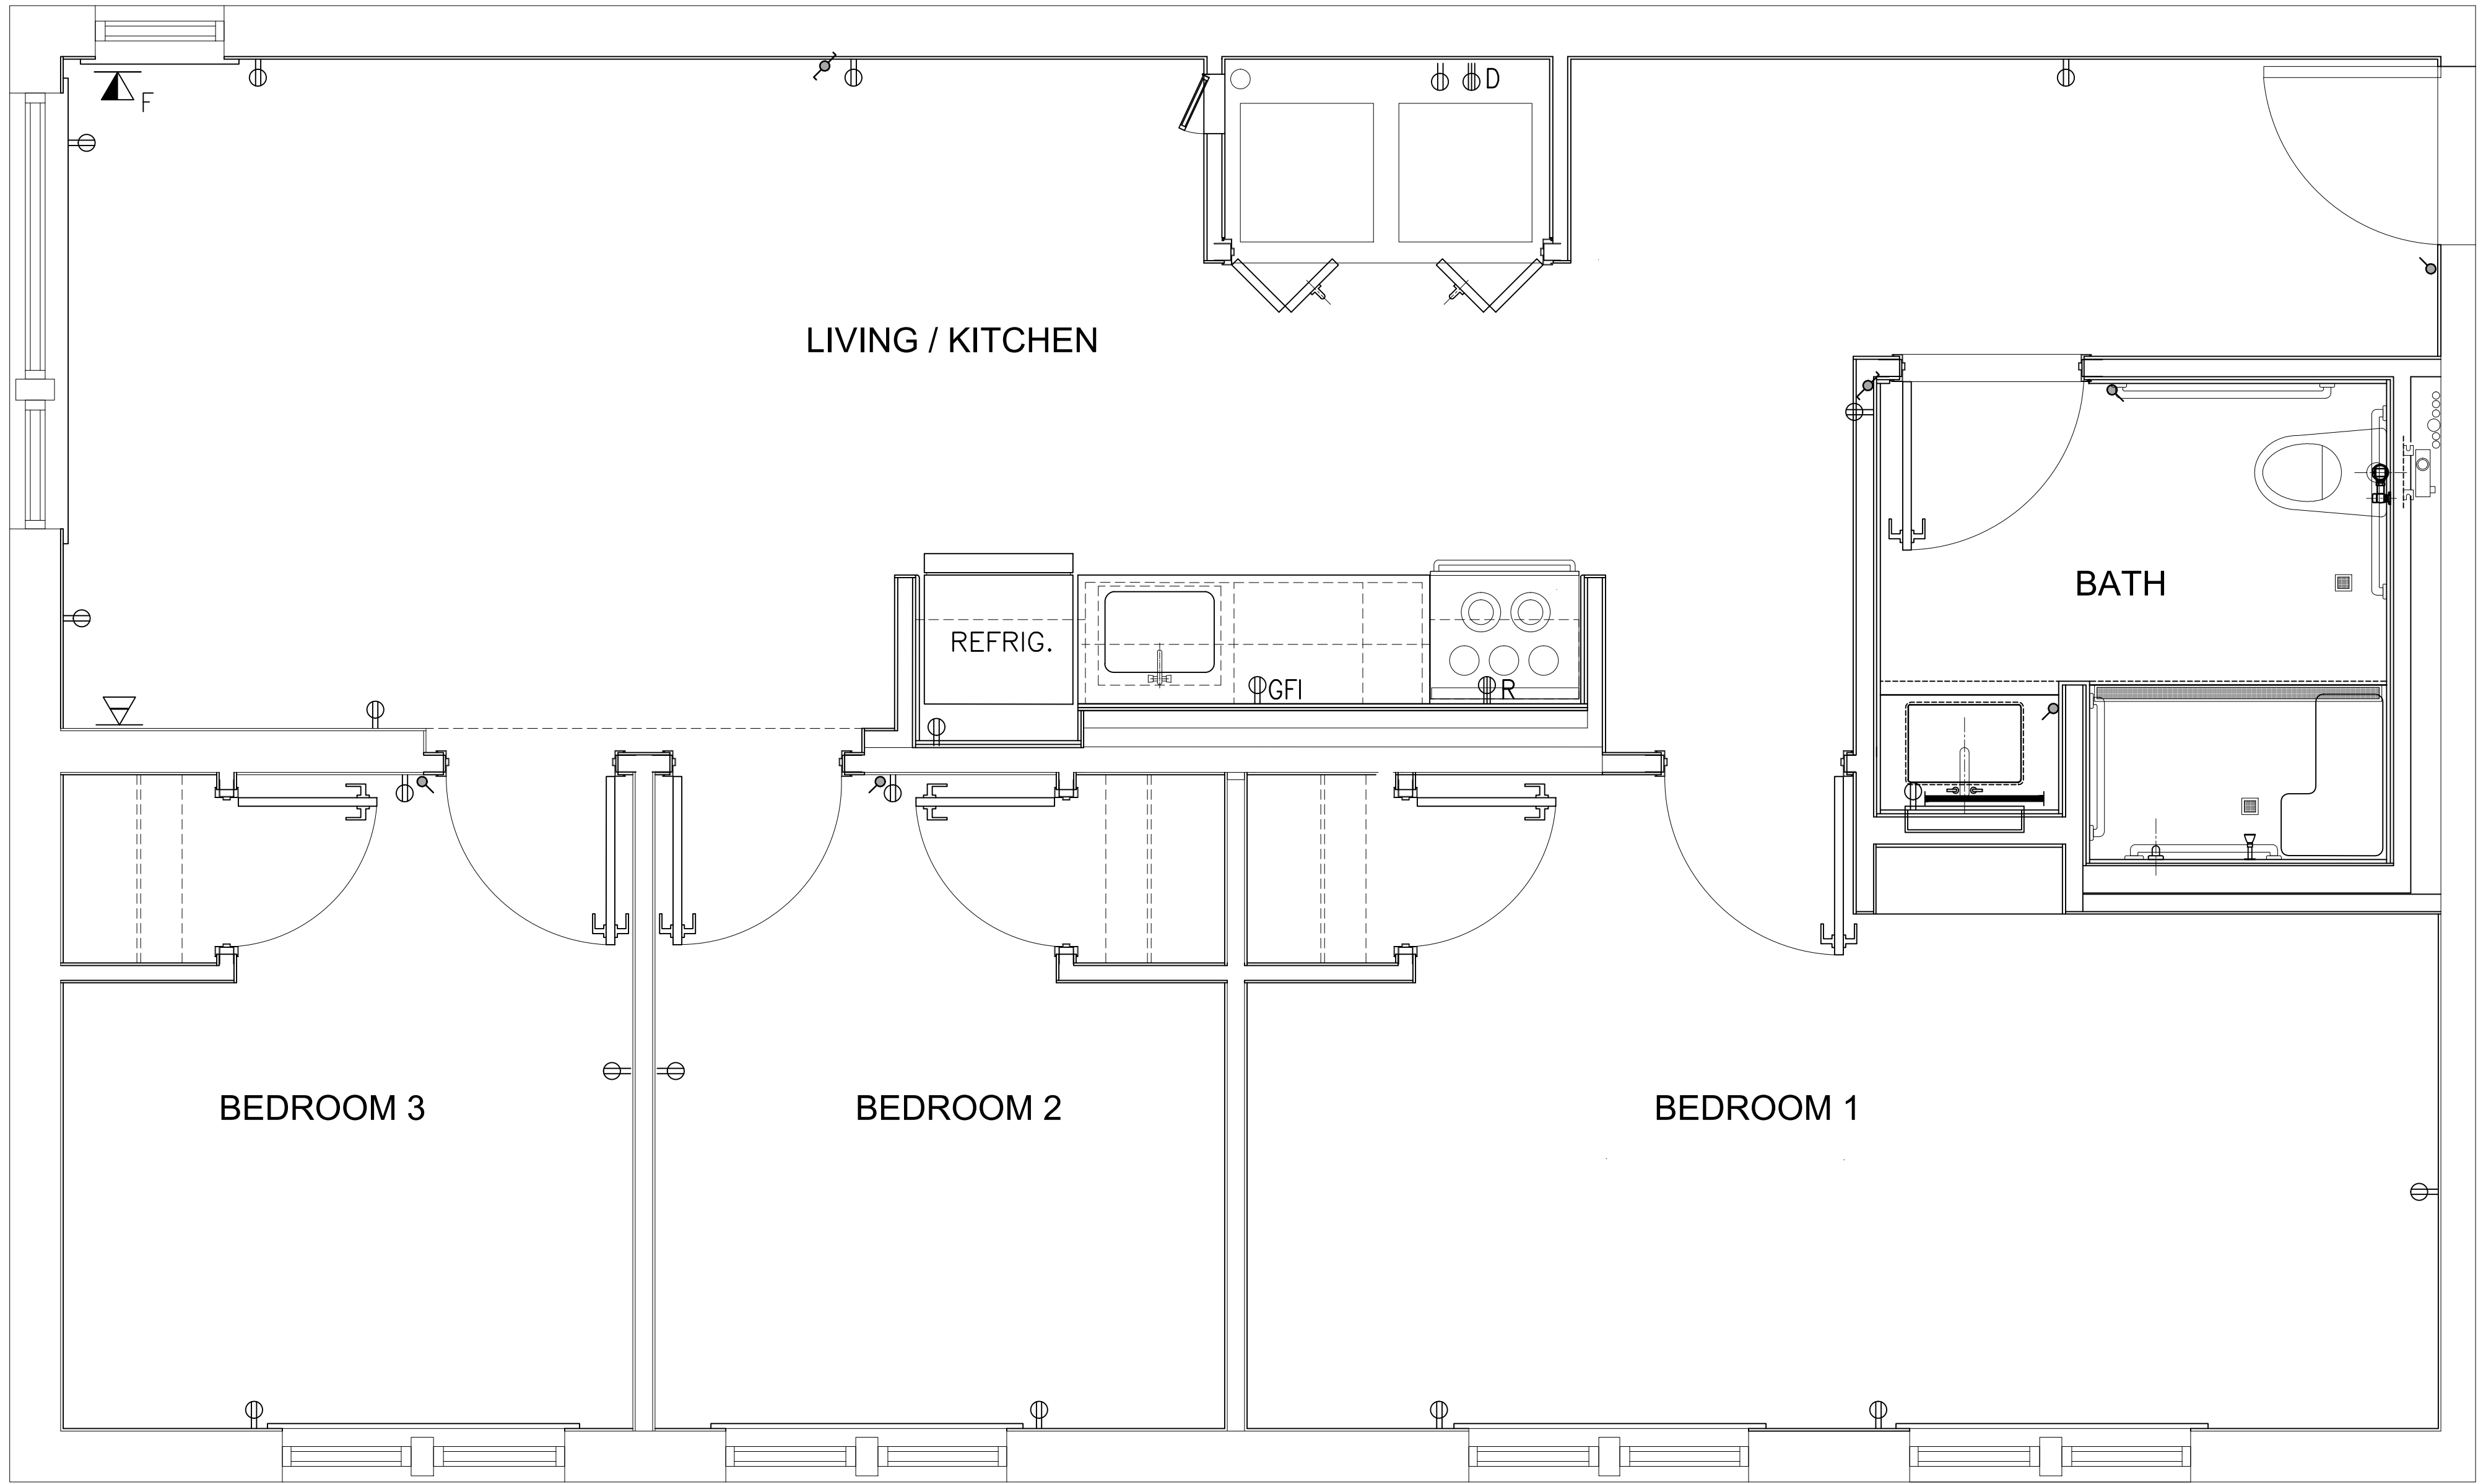

1 ELECTRICAL LAYOUT PLAN
A401
SCALE: 1/2" = 1'-0"

LIGHTING AND POWER

SYMBOL	DESCRIPTION
	CEILING MOUNTED LUMINAIRE
	WALL MOUNTED (MIRROR) LIGHT
	15AMP - 20 AMP RECEPTACLE (12" A.F.F)
	240v - 40 AMP RECEPTACLE (12" A.F.F)
	240v - 60 AMP RECEPTACLE (12" A.F.F)
	SWITCH
	3-WAY SWITCH
	COMBINATION DATA/TV OUTLET W/DUPLEX JACKS LABELLED "DATA" & "TV" (MOUNTED AT 18" A.F.F.)
	TV OUTLET WITH SINGLE JACK LABELLED "TV" MOUNTED AT 18" A.F.F.
	TELEPHONE OUTLET FOR STANDARD DESK INSTRUMENT, WITH DUPLEX-JACKS, LABELED 'VOICE' AND 'DATA', MOUNTED AT 18" A.F.F, 'F' INDICATES FURNITURE MOUNTED.
	CEILING MOUNTED EXHAUST FAN (15"x15") W/ LIGHT & HUMIDITY SENSOR

NOTE: REFER TO ELECTRICAL DRAWINGS

AFRIDI ASSOCIATES
CONSULTING ENGINEERS

19 West 21st Street
New York, NY 10010
Tel: (212) 243-0725
Fax: (212) 243-0725
aafridi@afridiassociates.com

510 Broadhollow Road
Melville, NY 11747
Tel: (631) 465-0786
Fax: (631) 465-0788

LIZARDOS

LONG ISLAND | NEW YORK CITY | CHARLOTTE | DANBURY

200 Old Country Road | Suite 670
Mineola | NY 11501
516 484 1020 Lizardos.com

Lizardos Engineering Associates D.P.C.

Designer: AKBER AFRIDI, P.E.
Drawn by: AZHER MALIK
Checked by: AKBER AFRIDI, P.E.

Project:
**INTERIOR RENOVATIONS OF
THE COMMONS APARTMENTS
10.1 (ADA COMPLIANT) & 10.3**

Address:
735 Anderson Hill Road
Purchase NY 10577


Drawing Title:
**ELECTRICAL LAYOUT PLAN
ADA APARTMENT 10.1**

Drawing No.:
A401.00

Scale: AS NOTED

Date: 08/24/2020

SU-040623

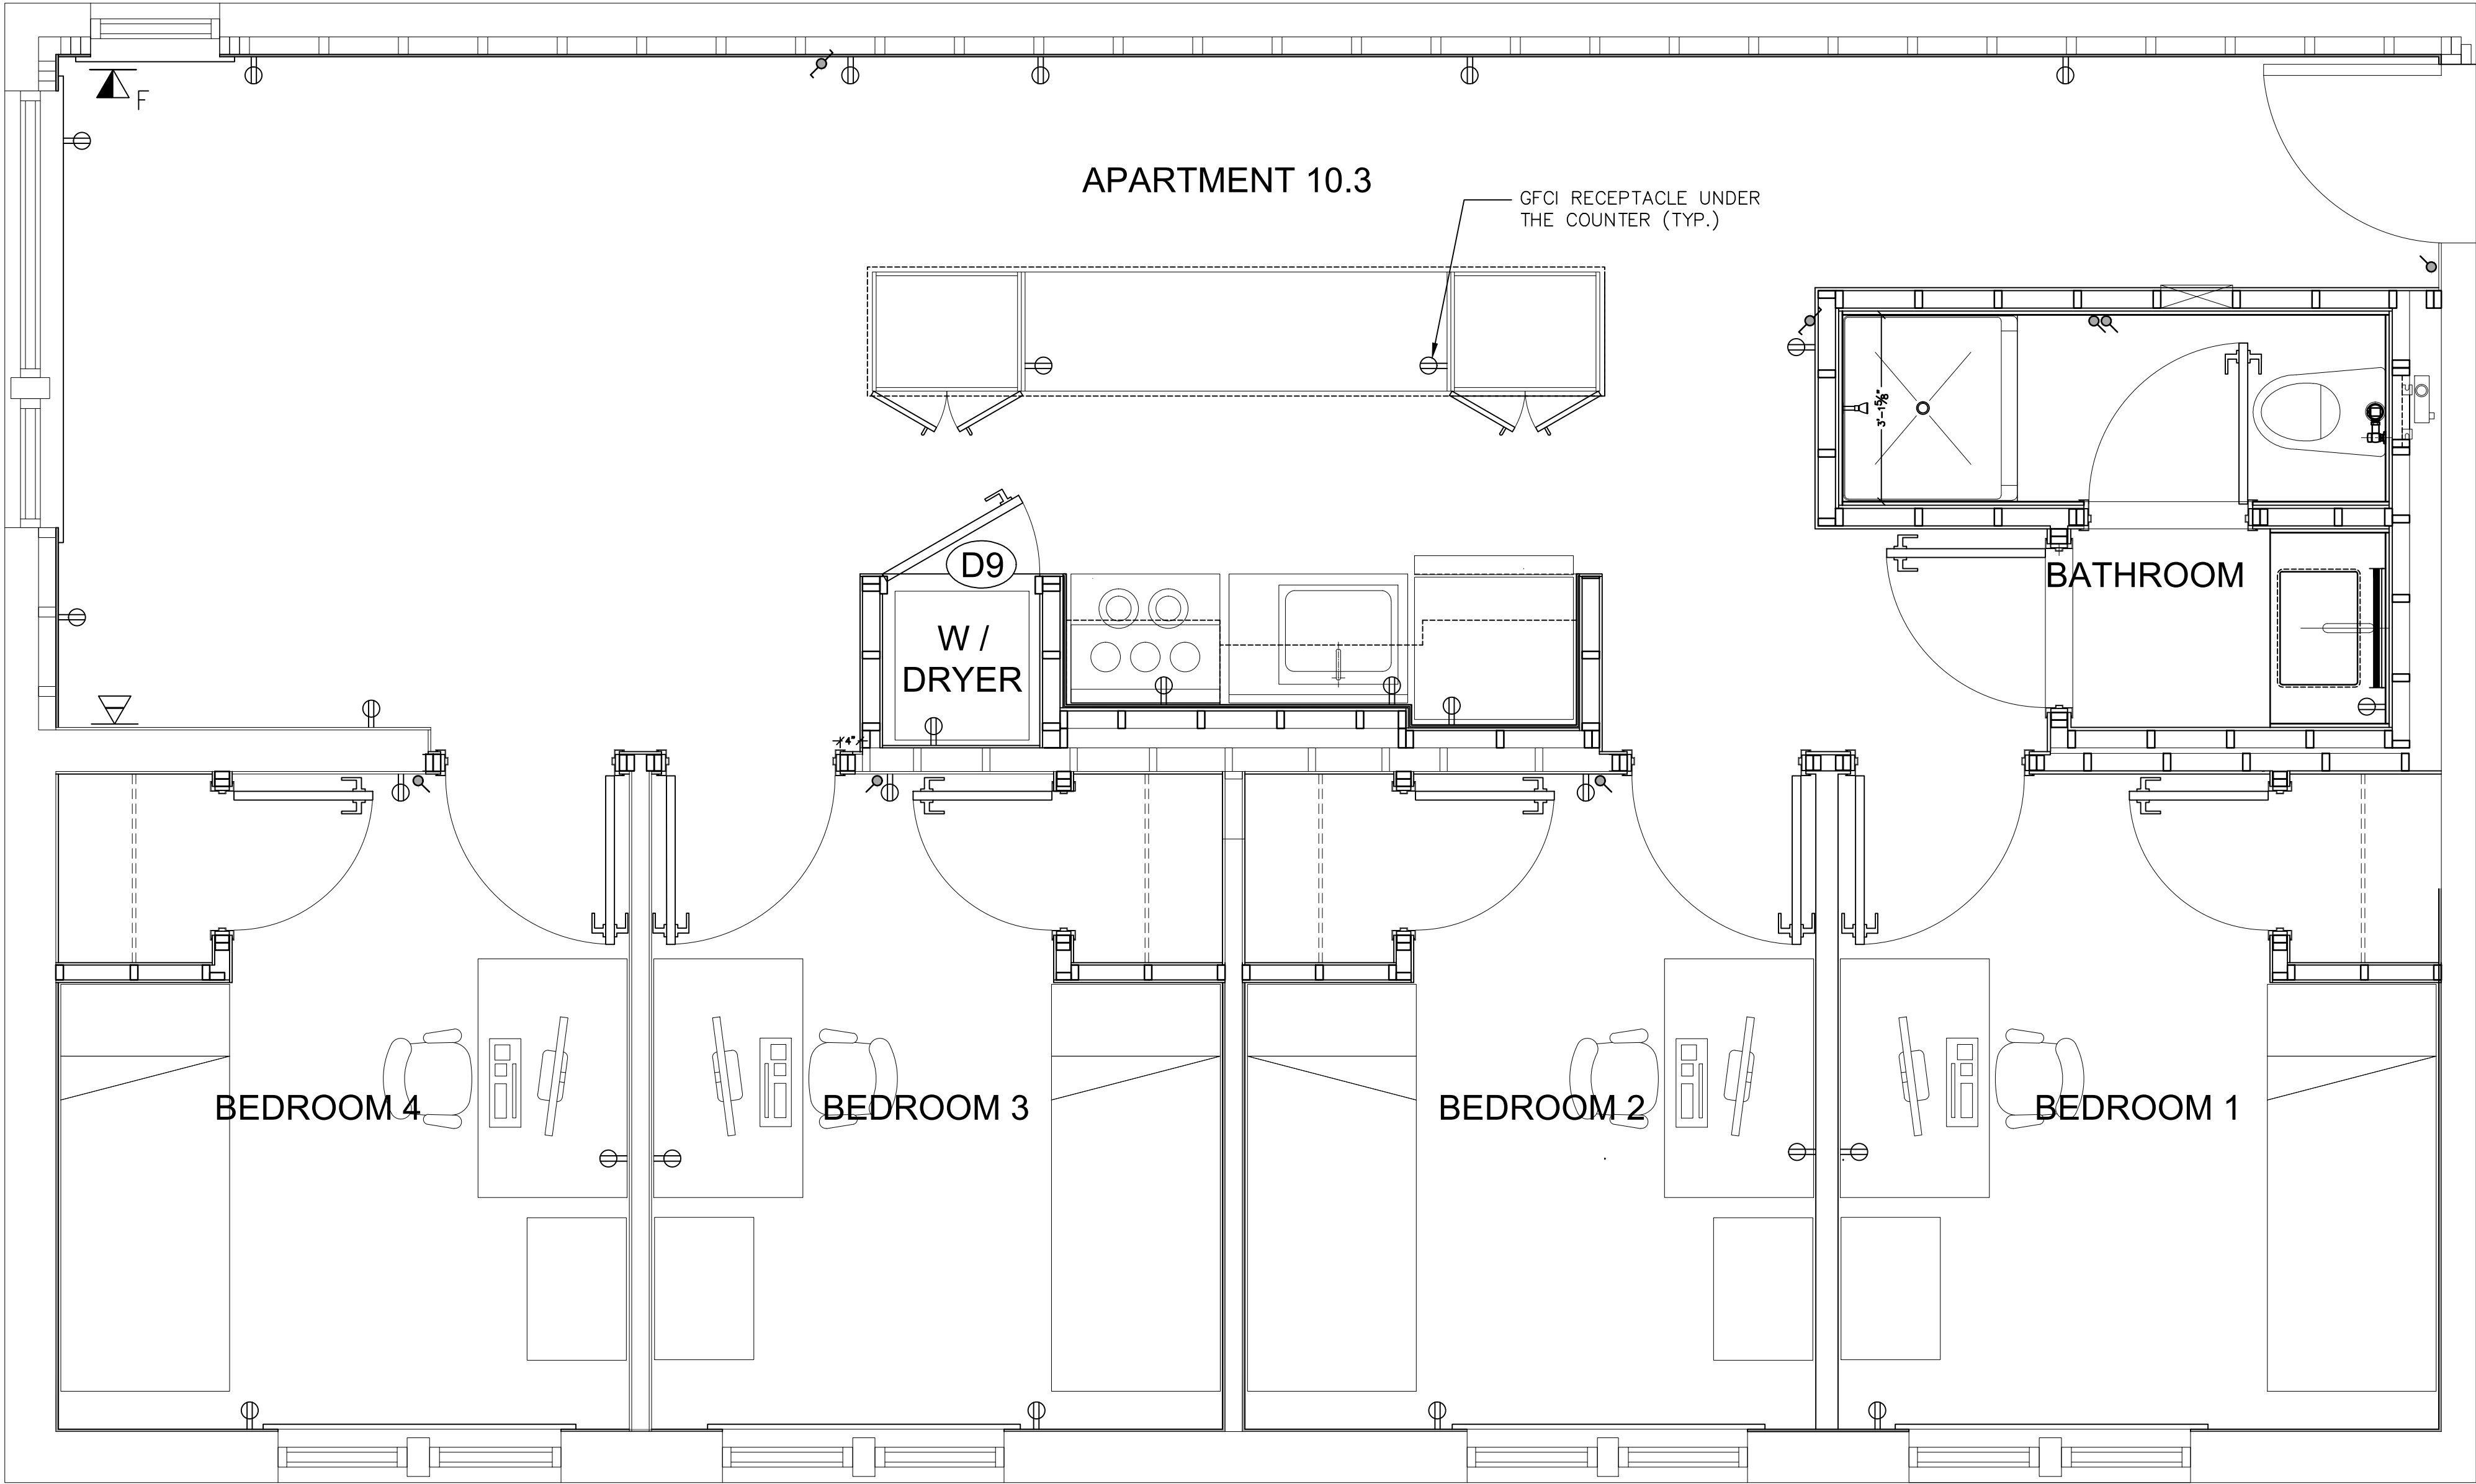

LIGHTING AND POWER

SYMBOL	DESCRIPTION
	CEILING MOUNTED LUMINAIRE
	WALL MOUNTED (MIRROR) LIGHT
	15AMP - 20 AMP RECEPTACLE (12" A.F.F)
	SWITCH
	TWO WAY SWITCH
	COMBINATION DATA/TV OUTLET W/DUPLEX JACKS LABELLED "DATA" & "TV" (MOUNTED AT 18" A.F.F.)
	TV OUTLET WITH SINGLE JACK LABELLED "TV" MOUNTED AT 18" A.F.F.
	TELEPHONE OUTLET FOR STANDARD DESK INSTRUMENT, WITH DUPLEX-JACKS, LABELED "VOICE" AND "DATA", MOUNTED AT 18" A.F.F., "F" INDICATES FURNITURE MOUNTED.
	CEILING MOUNTED EXHAUST FAN (15"x15") W/HUMIDITY SENSOR

NOTE: REFER TO ELECTRICAL DRAWINGS

1 ELECTRICAL LAYOUT PLAN
A402
SCALE: 1/2" = 1'-0"

AFRIDI ASSOCIATES
CONSULTING ENGINEERS

19 West 21st Street
New York, NY 10010
Tel: (212) 243-0725
Fax: (212) 243-0725
510 Broadhollow Road
Melville, NY 11747
Tel: (631) 465-0786
Fax: (631) 465-0788
aafridi@afridiassociates.com

LIZARDOS

LONG ISLAND | NEW YORK CITY | CHARLOTTE | DANBURY

200 Old Country Road | Suite 670
Mineola | NY 11501
516 484 1020 Lizardos.com

Lizardos Engineering Associates D.P.C.

Designer: AKBER AFRIDI, P.E.
Drawn by: AZHER MALIK
Checked by: AKBER AFRIDI, P.E.

Project:
**INTERIOR RENOVATIONS OF
THE COMMONS APARTMENTS
10.1 (ADA COMPLIANT) & 10.3**

Address:
735 Anderson Hill Road
Purchase NY 10577

Drawing Title:
**ELECTRICAL LAYOUT PLAN
APARTMENT 10.3**

Drawing No.:
A402.00

Scale: AS NOTED

Date: 08/24/2020

SU-040623