



HALLEL BUILDING GYMNASIUM ALTERATION


175 ROUTE 340
SPARKILL, NY 10976

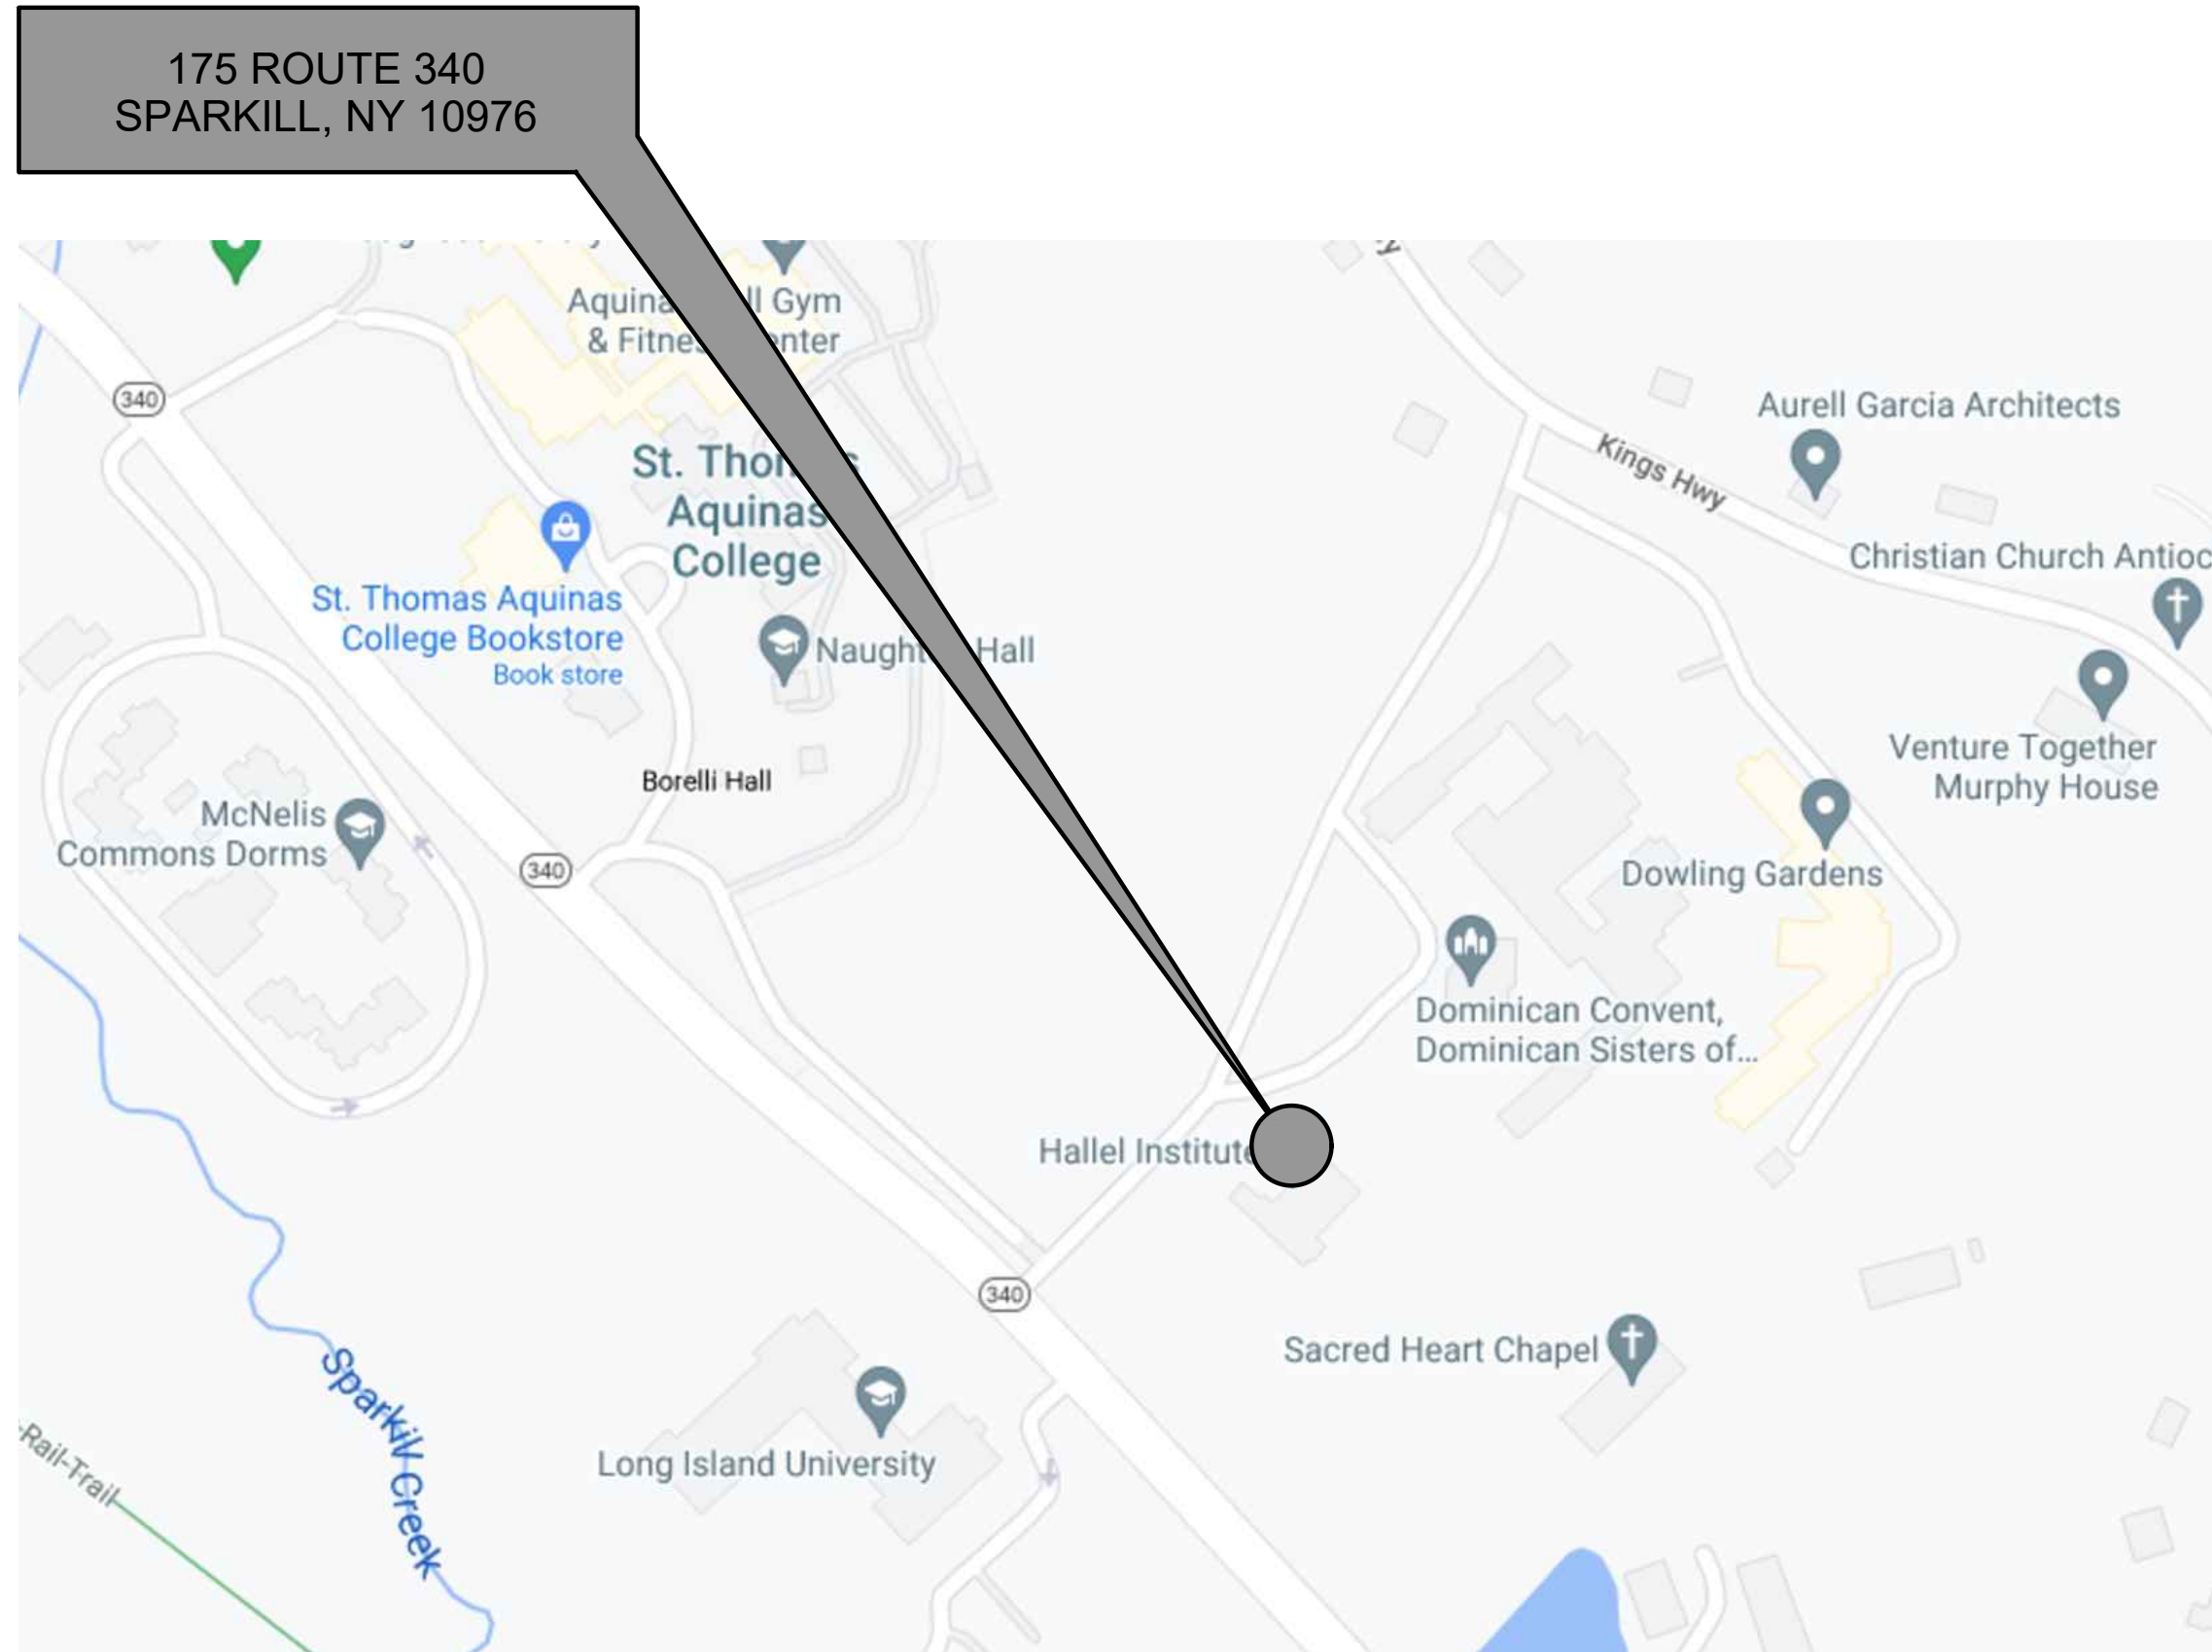

1 LOCATION MAP
N.T.S.

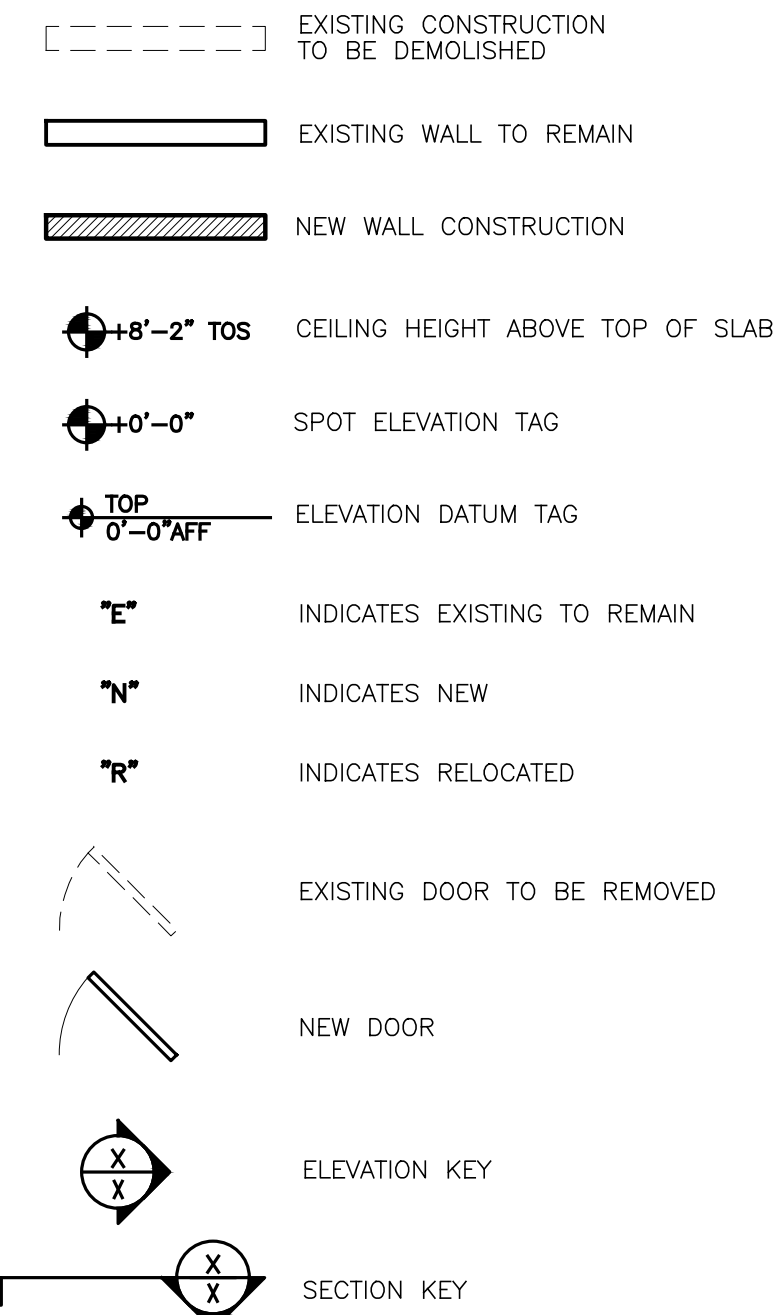

2 DRAWING SYMBOLS
N.T.S.

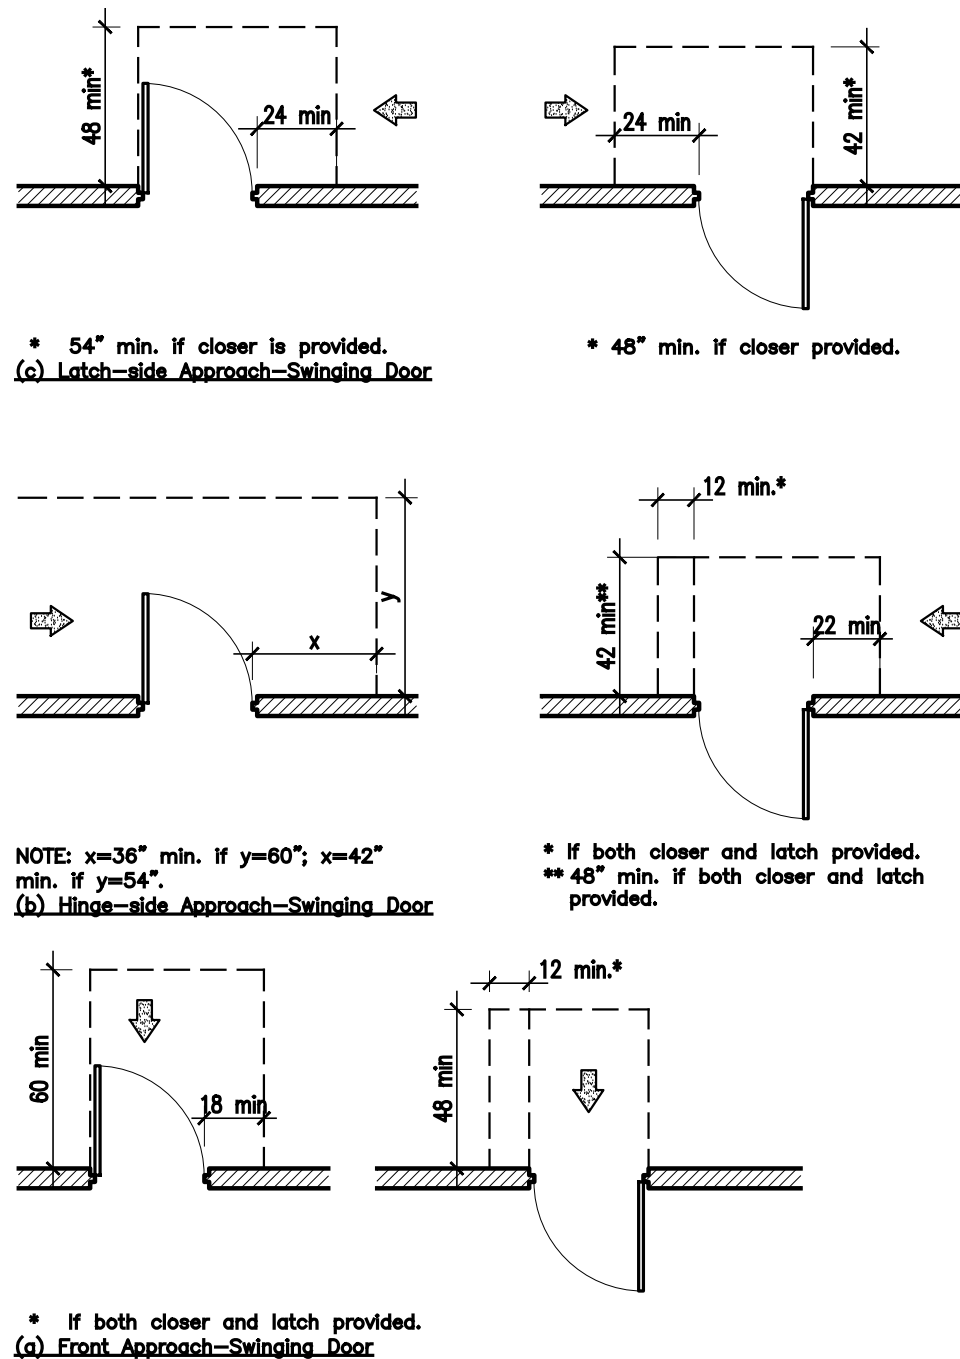

3 DOOR MANEUVERING CLEARANCES
N.T.S.

ARCHITECTURAL

- G.1 LOCATION MAP, SYMBOLS, DOOR MANEUVERING CLEARANCES, ABBREVIATIONS, DRAWING LIST
G.2 CODE REVIEW AND EGRESS PLAN
A.1 PARTIAL DEMOLITION PLAN AND PARTIAL CONSTRUCTION PLAN
A.2 PARTIAL ROOF PLAN AND PARTIAL REFLECTED CEILING PLAN
A.3 PARTIAL CONSTRUCTION PLAN AND PARTIAL REFLECTED CEILING PLAN
A.4 EXTERIOR ELEVATIONS
A.5 EXTERIOR ELEVATIONS
A.6 BUILDING SECTIONS
A.7 ENLARGED PLANS
A.8 ENLARGED PLANS
A.9 DOOR, WINDOW AND STOREFRONT SCHEDULES AND DETAILS
A.10 PARTIAL FINISH PLAN AND SPECIFICATIONS
A.11 SIGNAGE LOCATION PLAN, SCHEDULE AND ELEVATIONS

PLUMBING

- P.001 PLUMBING DEMOLITION PLAN
P.101 PLUMBING PLANS
P.102 PLUMBING GAS PLAN
P.201 PLUMBING RISER DIAGRAMS
P.301 PLUMBING DETAILS
P.401 PLUMBING SPECIFICATIONS

5 DRAWING LIST
N.T.S.

MECHANICAL

- M.001 MECHANICAL DEMOLITION PLAN
M.101 MECHANICAL PLAN
M.201 MECHANICAL SCHEDULES
M.202 MECHANICAL PIPING AND WIRING DIAGRAMS
M.203 MECHANICAL DETAILS
M.301 MECHANICAL SPECIFICATIONS

ELECTRICAL

- E.001 ELECTRICAL DEMOLITION PLAN
E.101 ELECTRICAL LIGHTING PLAN
E.102 ELECTRICAL POWER PLAN
E.201 ELECTRICAL SPECIFICATIONS

FIRE ALARM

- FA.101 FIRE ALARM PLAN

- SCOREBOARD
BASKETBALL BACKSTOPS AND EQUIPMENT
VOLLEYBALL NET AND EQUIPMENT
BLEACHERS
LOCKERS
GYMNASIUM FLOOR PREP, FLOOR COATING, STRIPING
VENDING MACHINES
GOLF SIMULATOR EQUIPMENT
WINDOW TREATMENT
GYM WALL PADDING
SOUND SYSTEM

6 OWNER SUPPLIED ITEMS
N.T.S.

AFF	Above Finished Floor	FA	Fire Alarm	NIC	Not In Contract
ACT	Acoustic Ceiling Tile	FE	Fire Extinguisher	NIS	Not To Scale
ADJ	Adjustable	FT	Fin Tube	NO	Number
ALUM	Aluminum	FDB	Face of Block/Brick	NOM	Nominal
ANG	Angle	FW	Face of Wall		
APPROX	Approximate	FI	Finish, Finished	OC	On Center
ARCH	Architect(ural)	FH	Full Height	OD	Opening
AI	At	FT	Finish, Finished	OD	Outside Diameter
AUX	Auxiliary	FR	Fire Rated	OPP	Opposite
		FL/RL	Floor	OPP	Opposite Handed
BET	Between	FD	Floor Drain	PNL	Panel
BM	Beam	FOUND	Foundation	PTD	Painted
BLDG	Building	FTG	Footings	PLYMD/PLMD	Plywood
BLK	Block	G	Gas	PLA	Plastic Laminate
BLK	Blocking	GA	Gauge	PREP	Preparation
BO	Board	GC	General Contractor	PSI	Pounds Per Square Inch
BOT	Bottom	GEN	General	PSF	Pounds Per Square Foot
B.O.	Bottom of	GL	Glass	R	Riser
		GR	Grade	RD	Roof Drain
CAB	Cabinet	GWS/GYP BD	Gypsum Wall Board	REC	Recessed/Reception
CAT	Catalog	GFCI	Ground Fault Current Interrupt	REF	Reflected
CLG	Ceiling	HC	Handicapped	REF	Reflected Ceiling Plan
CLJ	Control Joint	HDWR	Hardware	REINFT	Reinforce(ft)
CL	Center Line	HWD	Hardwood	RELOC	Relocate
CL / CL	Clean Out	HVAC	Heating/Ventilation & Air Conditioning	REQ	Required
CLO	Closet	H/HT	Height	RES	Resilient
CLO	Closet	HM	Hollow Metal	RM	Room
CMU	Concrete Masonry Unit	HR	Hour	RO	Rough Opening
COND	Concrete	HOR/HORIZ	Horizontal	SCH	Schedule
COORD	Coordinate	HTR	Heater	SEP	Separate
CORR	Corridor	HW	Hot Water	SM	Similar
CW	Cold Water	ID	Inside Diameter	SPEC	Specification
COL	Column	INSUL	Insulation	SF	Square Feet
CONST	Construction	INT	Interior	STL	Stainless Steel
CONT	Continuous	INCL	Include (d)(ing)	STR	Structural, Structure
CONTR	Contractor	INV	Invert	SW	Switch
CER	Ceramic	JT	Joint	SQ	Square
		J-BOX	Junction Box	SUSP	Suspended
D	Deep	W	Wide	SYN	Synthetic
DN	Down	UL	Underwriter's Laboratories	THK	Thick
DET	Detail/Detector			T.O.	Top Of
DM	Dimension			TYP	Typical
DWG	Drawing			TEMP	Tempered
DWG	Diagonal				
DSP	Dispenser				
E	East				
ELEC	Electric, Electrical				
ELV	Elevation (Feet & Inches)				
EQUIP	Equipment				
EQ	Equal				
EX	Exterior				
EXT	Existing				
EXT	Expansion Joint				
EXT	Exterior				
EFS	Exterior Insulation Finish System				

4 ABBREVIATIONS
N.T.S.

09.26.23 ADDENDUM NO.1
09.14.23 FOR BID
08.25.23 FOR PERMIT

HALLEL BUILDING
GYMNASIUM ALTERATION

175 ROUTE 340SPARKILL, NY 10976

arcari iovino

ARCHITECTS PC

21 CROSS AVENUE
MIDLAND PARK, NJ 07432-1811
(201) 444-0753 FAX (201) 444-0839

LOCATION PLAN, SYMBOLS, DOOR
MANEUVERING CLEARANCES,
ABBREVIATIONS & DRAWING LIST

SCALE: AS NOTED

DATE: 08.25.2023

FILE: 2280/Current/G.1 General Info








©2023

arcari & iovino

ARCHITECTS PC

FIRE EXTINGUISHER CABINET

BASIS OF DESIGN:
LARSEN'S STAINLESS STEEL 2409-5R 1 1/2" SEMI
RECESSED CABINET, VERTICAL DUO DOOR, TEMPERED
SAFETY GLASS, BLACK VERTICAL DIE WHITE LETTERING,
RECESSED HANDLE AND MP5 MULTIPURPOSE DRY
CHEMICAL EXTINGUISHER

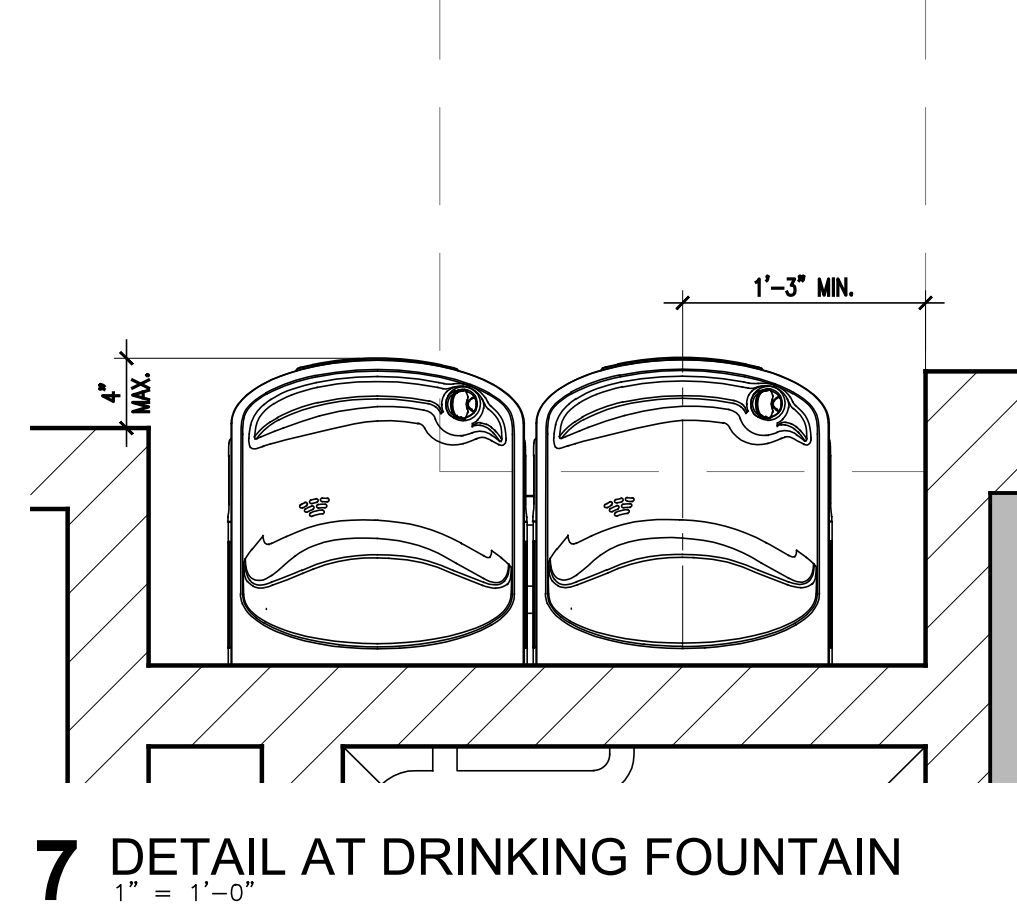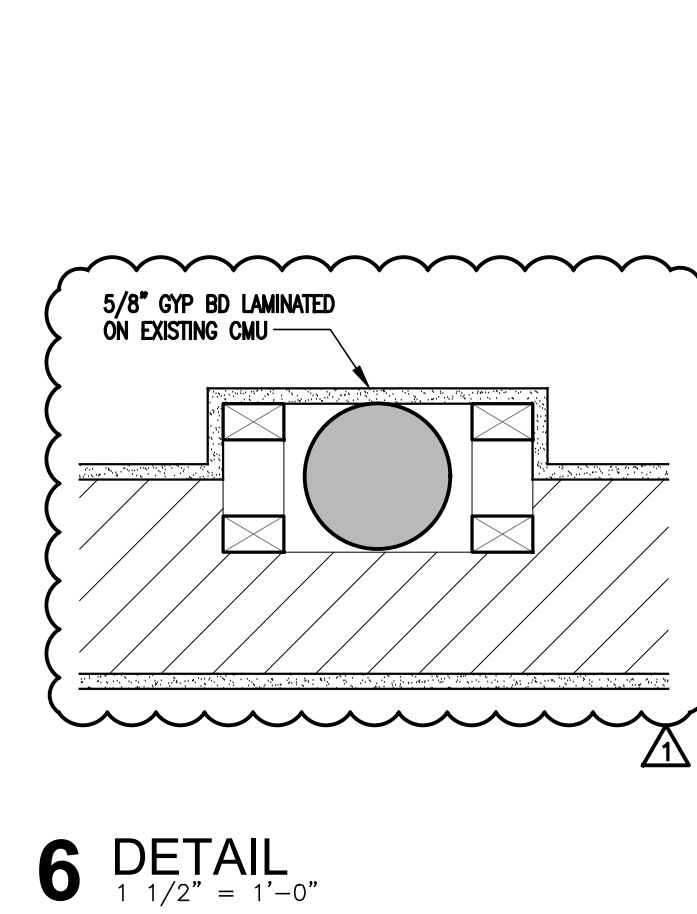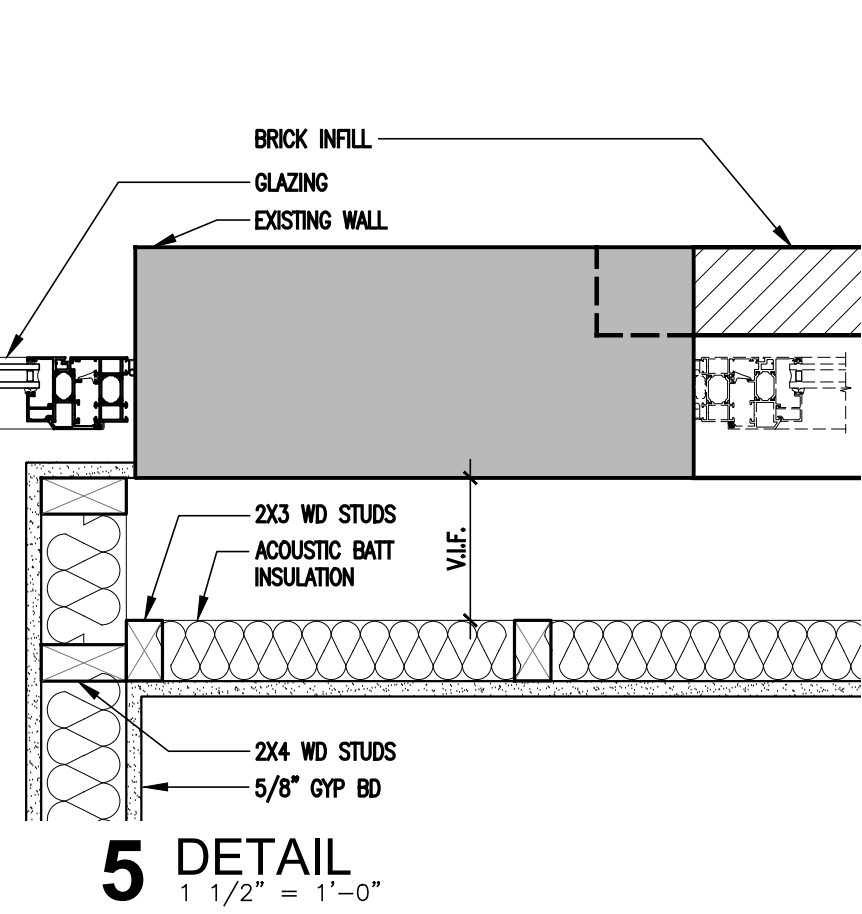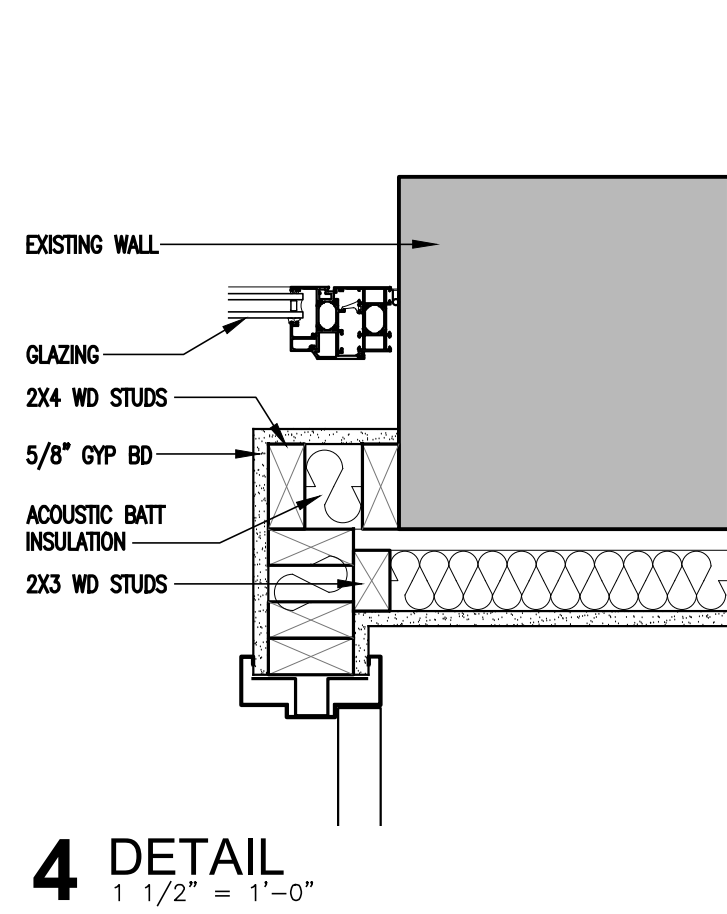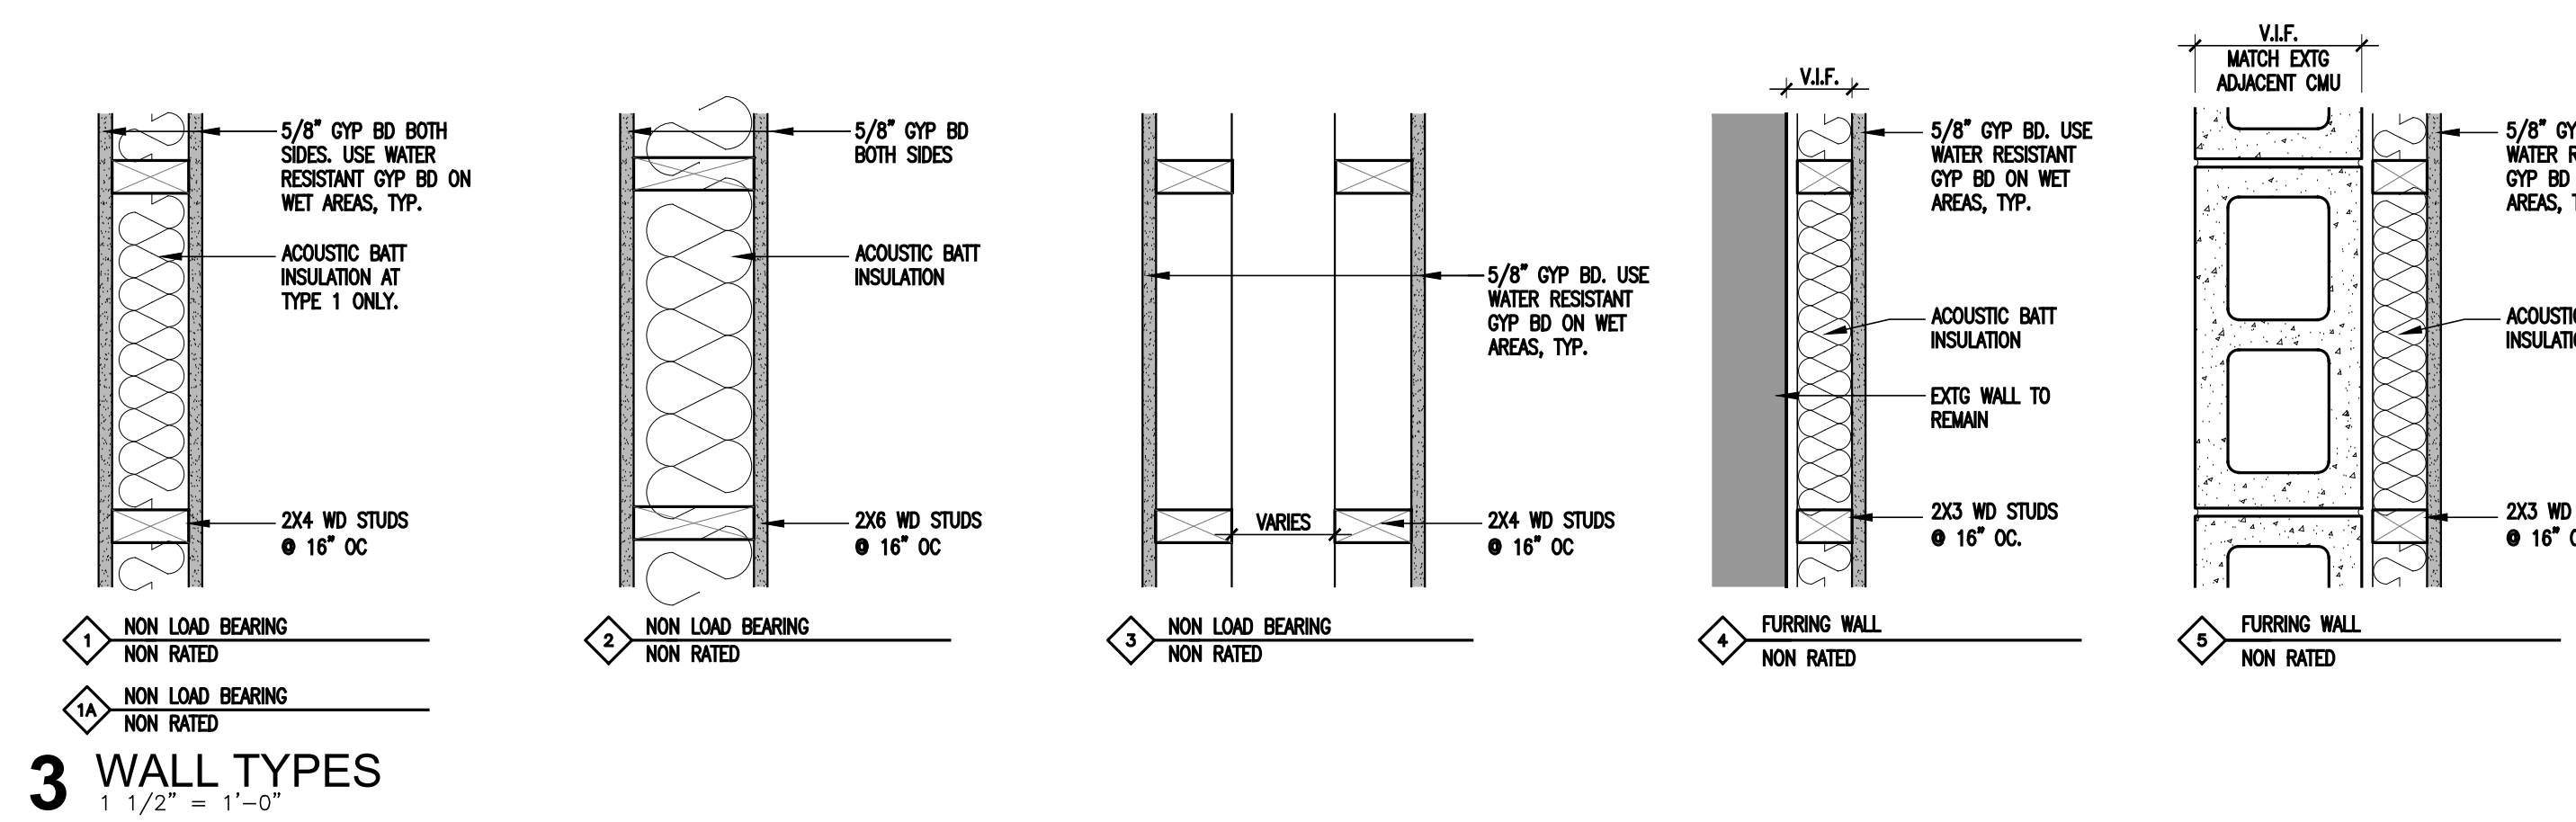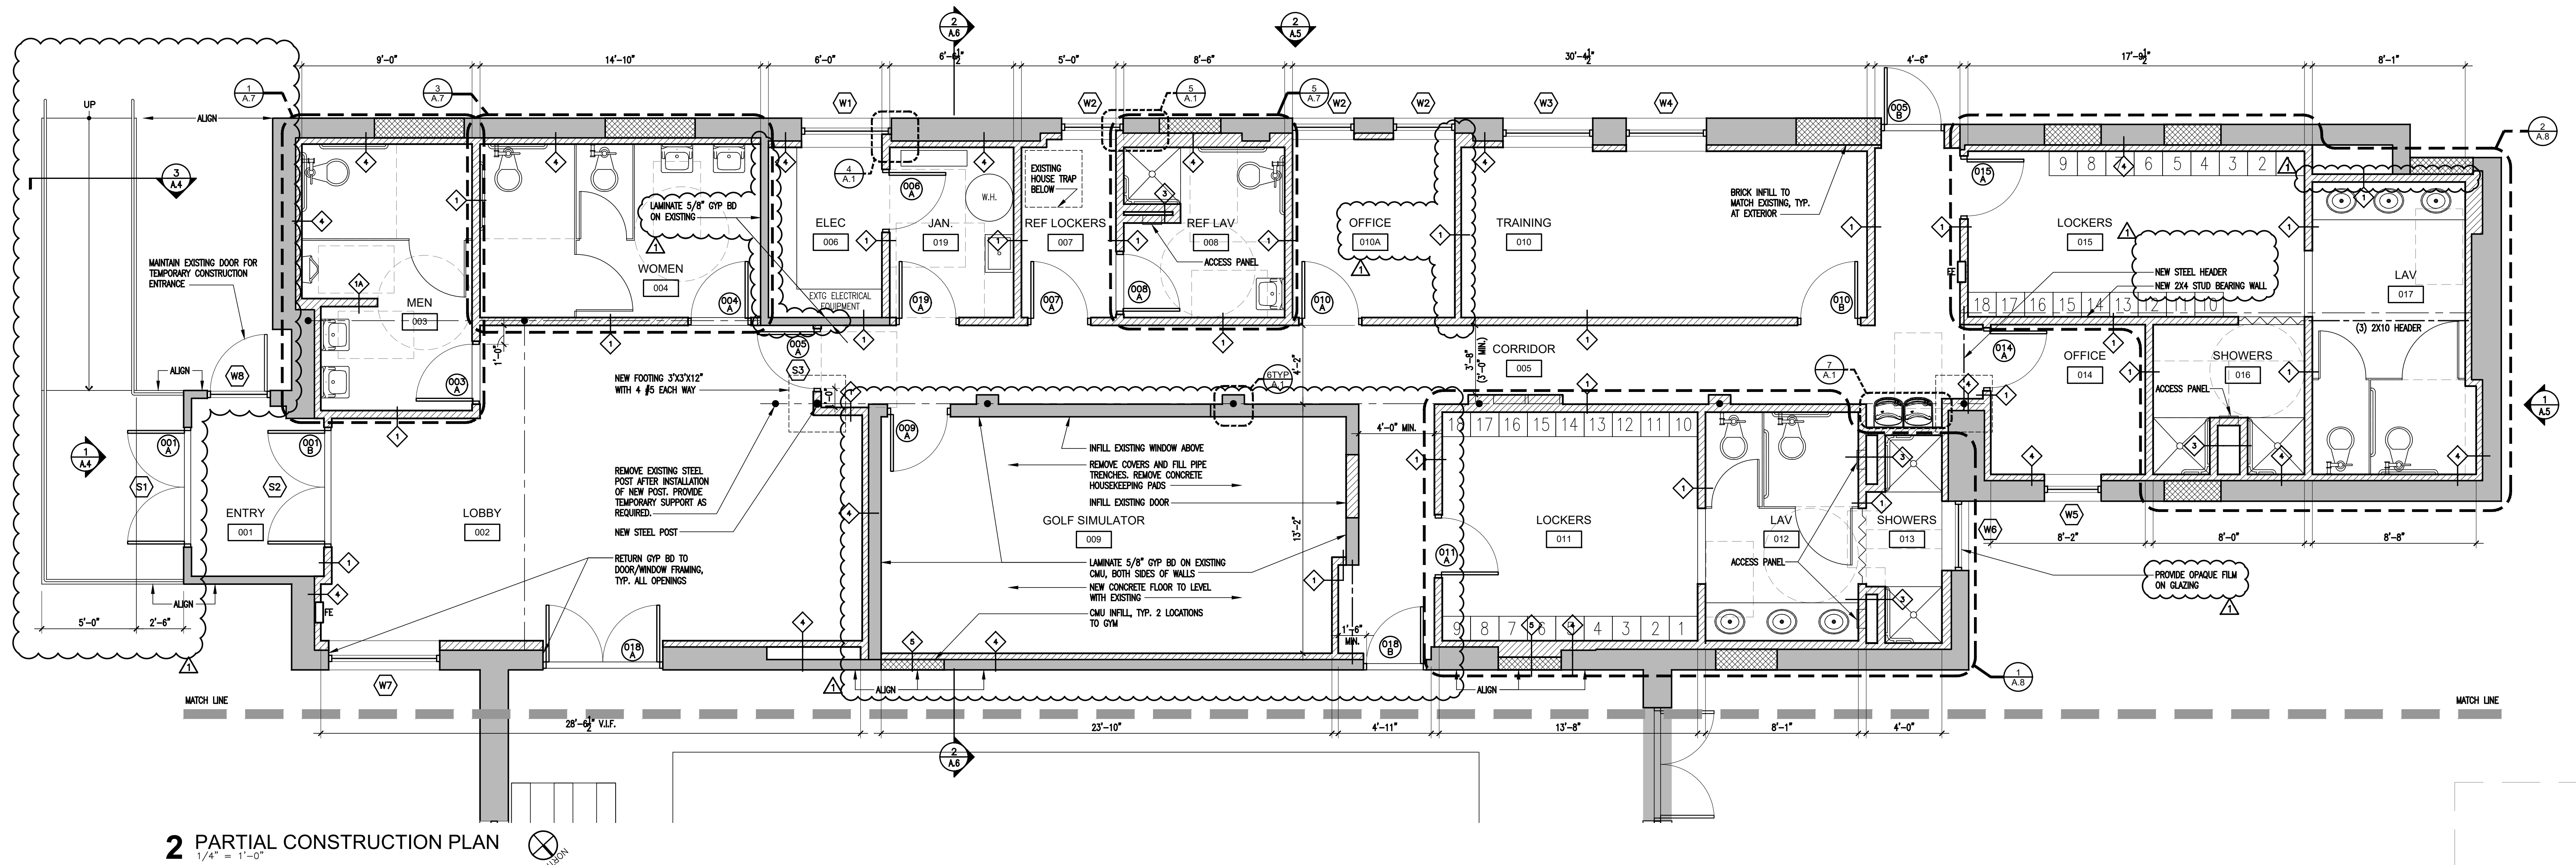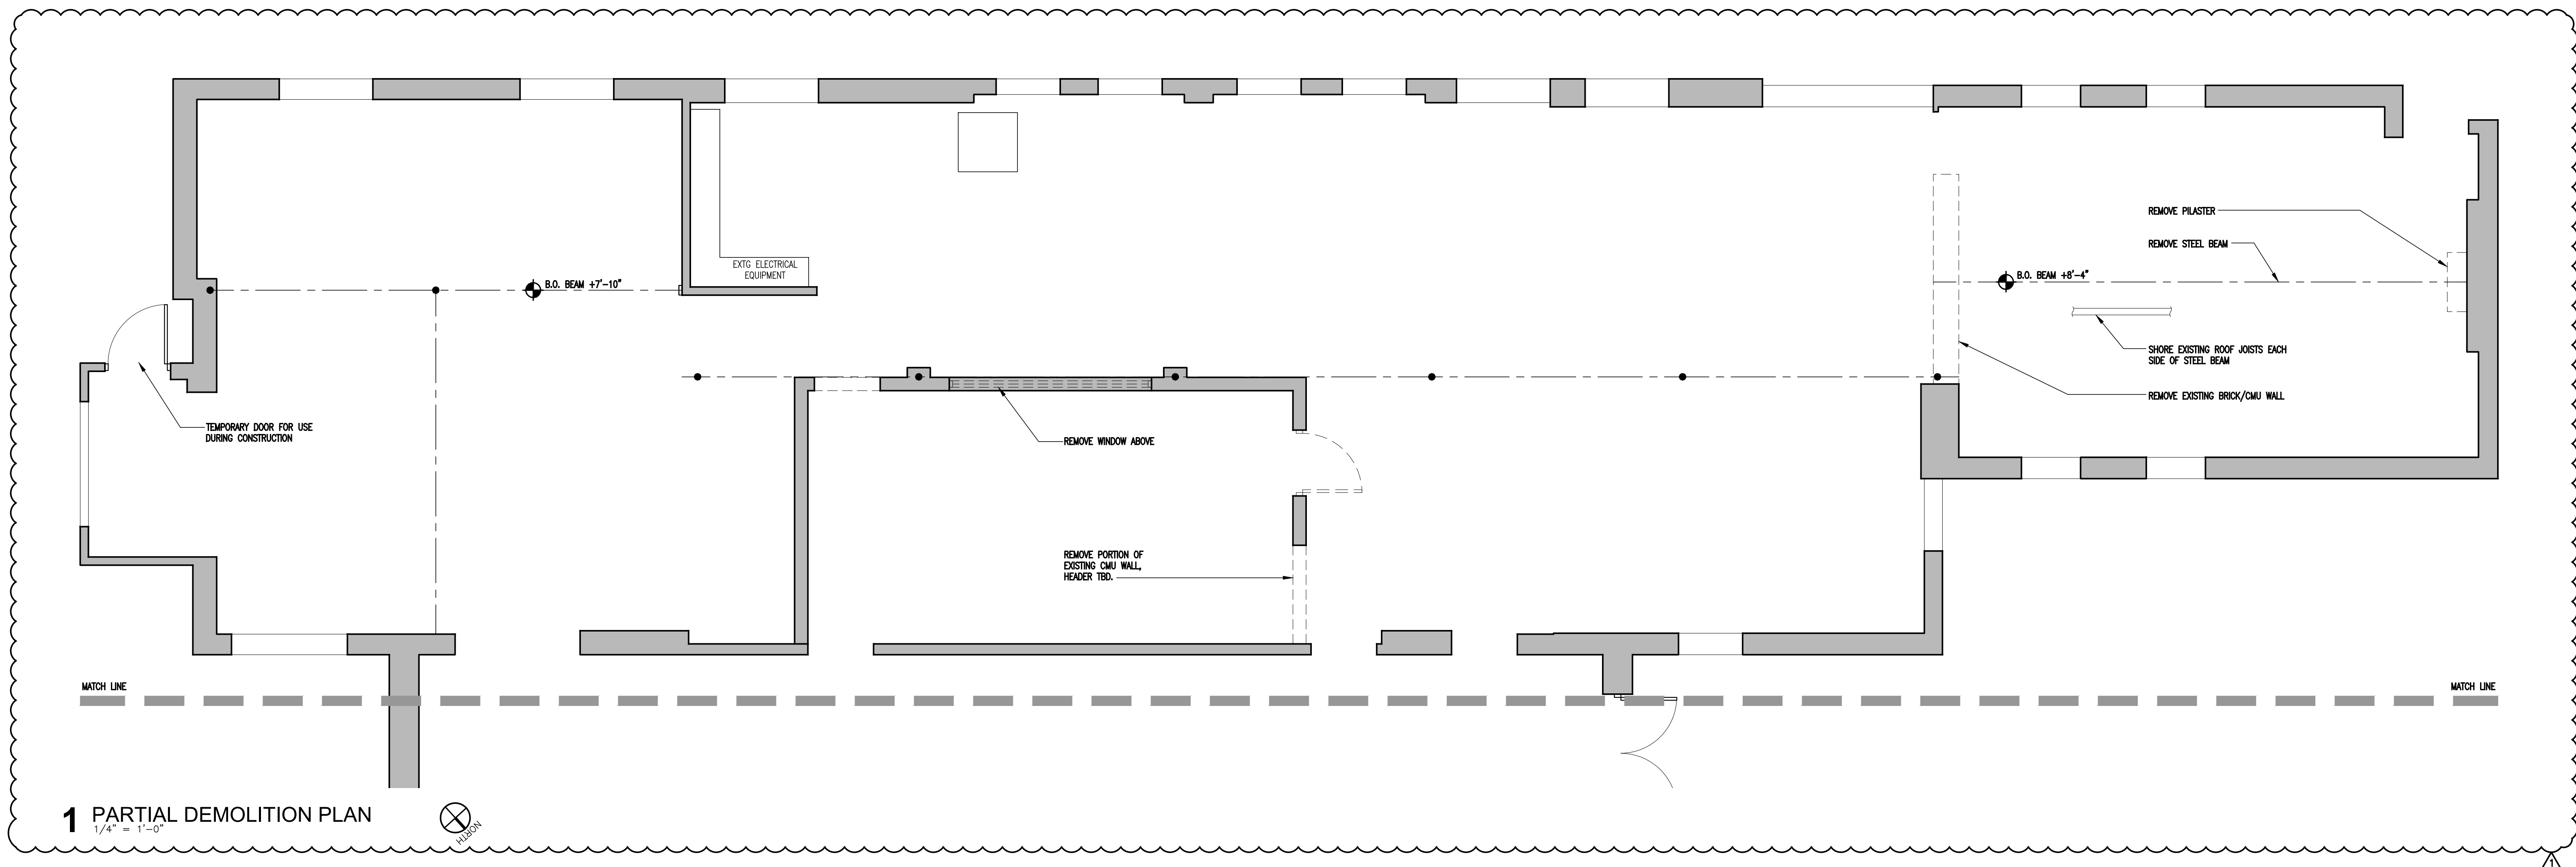


09.26.23 ADDENDUM NO.1
09.14.23 FOR BID
08.25.23 FOR PERMIT

HALLEL BUILDING GYMNASIUM ALTERATION

175 ROUTE 340 SPARKILL, NY 10976



EDWARD ARCARI NYR020765 ANTHONY IOVINO NYR023349

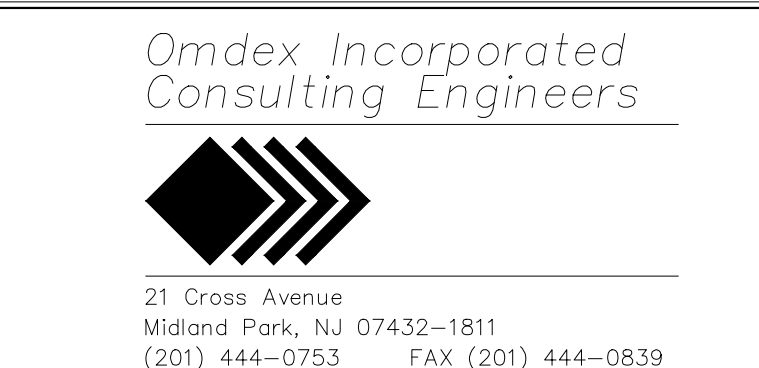

PARTIAL DEMOLITION PLAN AND PARTIAL CONSTRUCTION PLAN

SCALE: AS NOTED


DATE: 08.25.2023

FILE: 2280/Current/A.1-A.2 Support Plans


©2023 arcari iovino ARCHITECTS PC

A.1

CEILING LEGEND

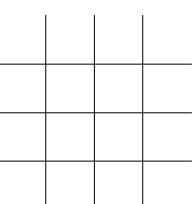

 ANGLED TEGULAR CEILING TILE IN 15/16" SUSPENDED GRID. GRID TO BE CENTERED IN ROOM UNLESS OTHERWISE NOTED. SEE FINISHES FOR SPECIFICATION.



PAINTED GYPSUM BOARD



2'x2' RECESSED LED



WALL MOUNTED LED



6" LED DOWNLIGHT



EXTERIOR LED WALL SCONCE



 
INTERIOR EMERGENCY LIGHT



EXTERIOR EMERGENCY LIGHT




EMERGENCY EXIT FIXTURE




ARROW INDICATES FACE


SEE ELECTRICAL DRAWING FOR THE COMPLETE LIGHTING FIXTURE SCHEDULE

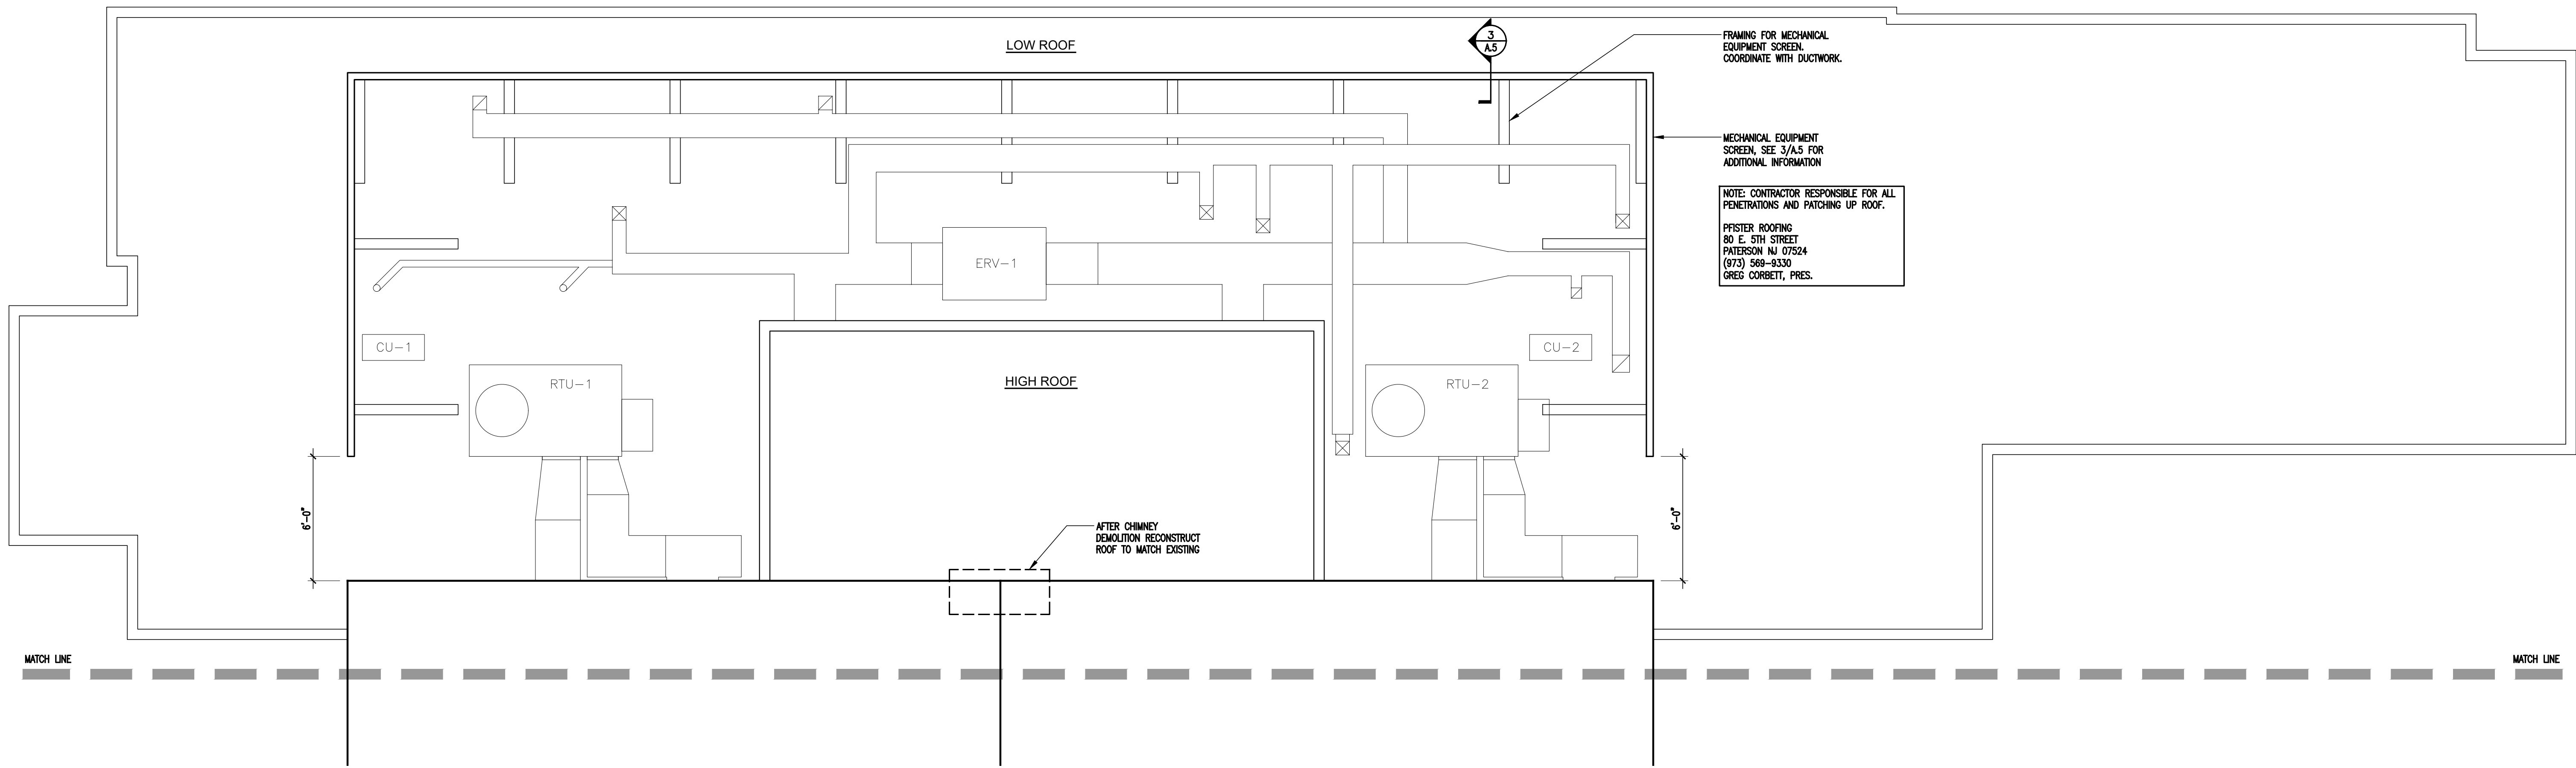


1 PARTIAL ROOF PLAN
1/4" = 1'-0"

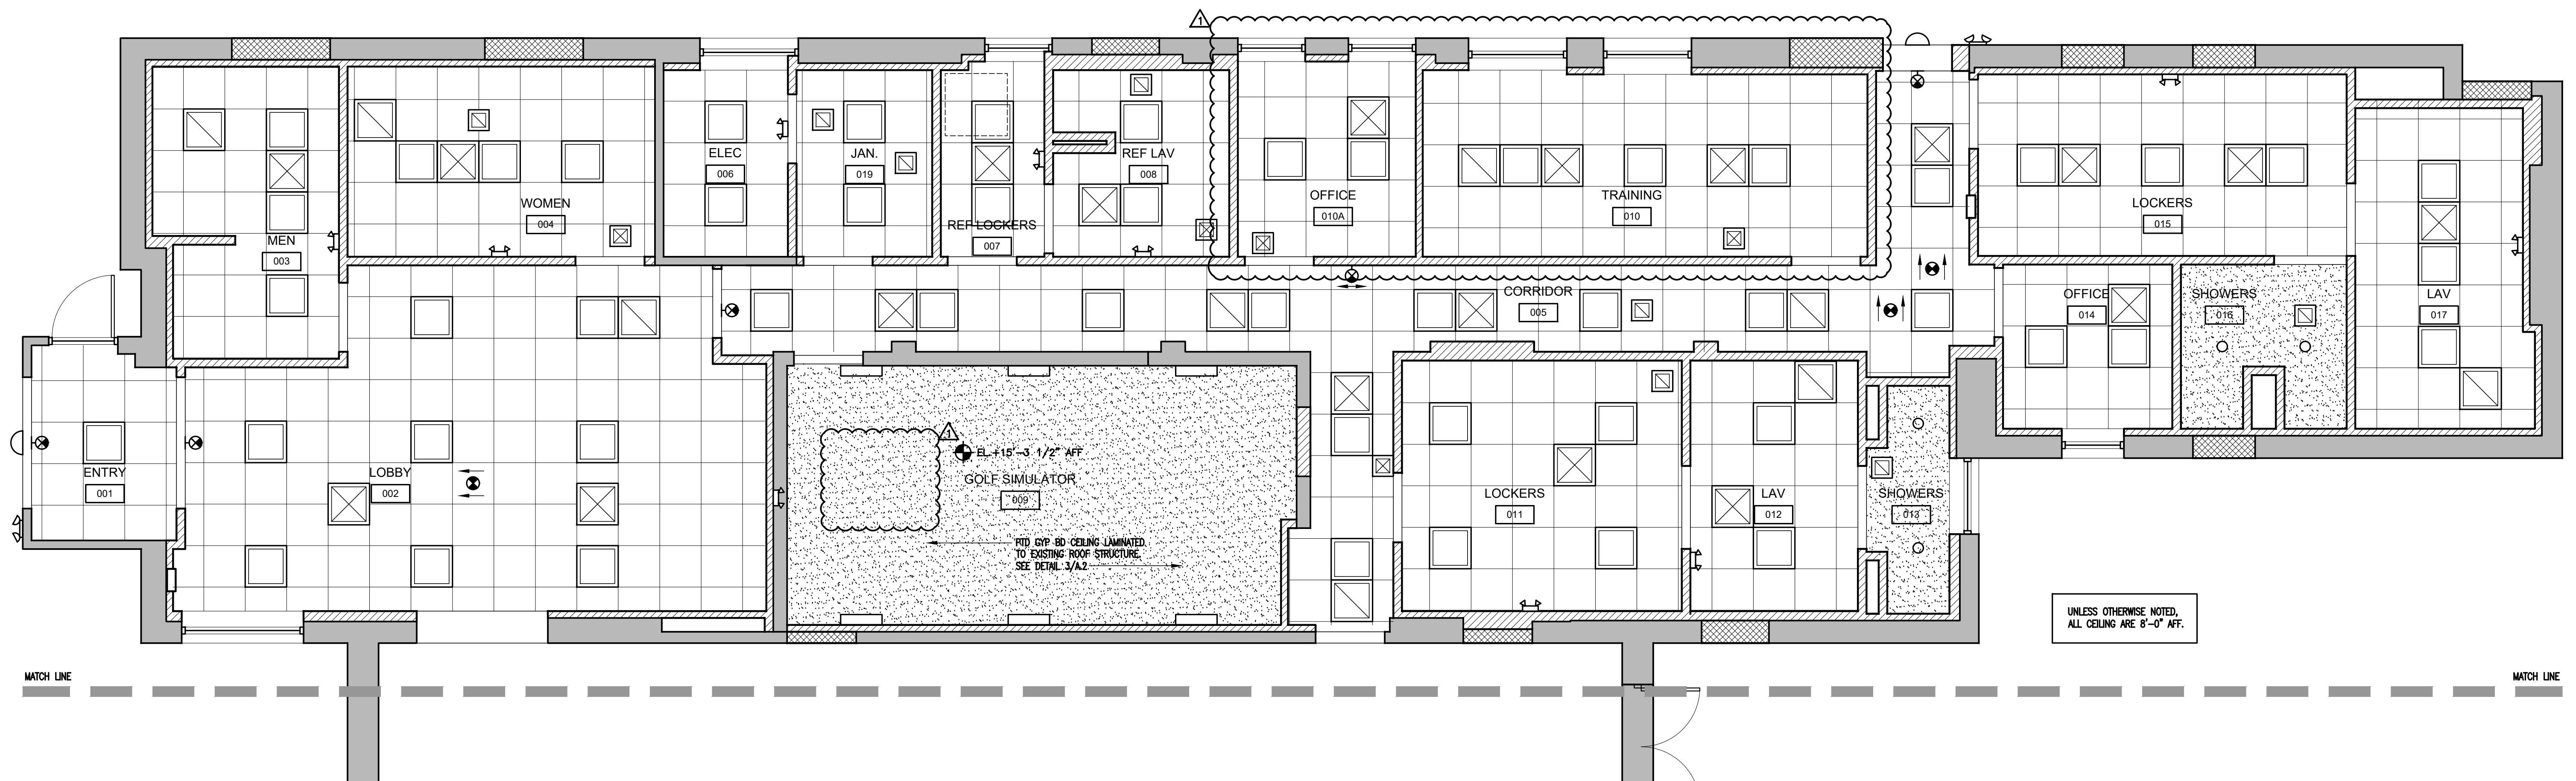

2 PARTIAL REFLECTED CEILING PLAN
1/4" = 1'-0"

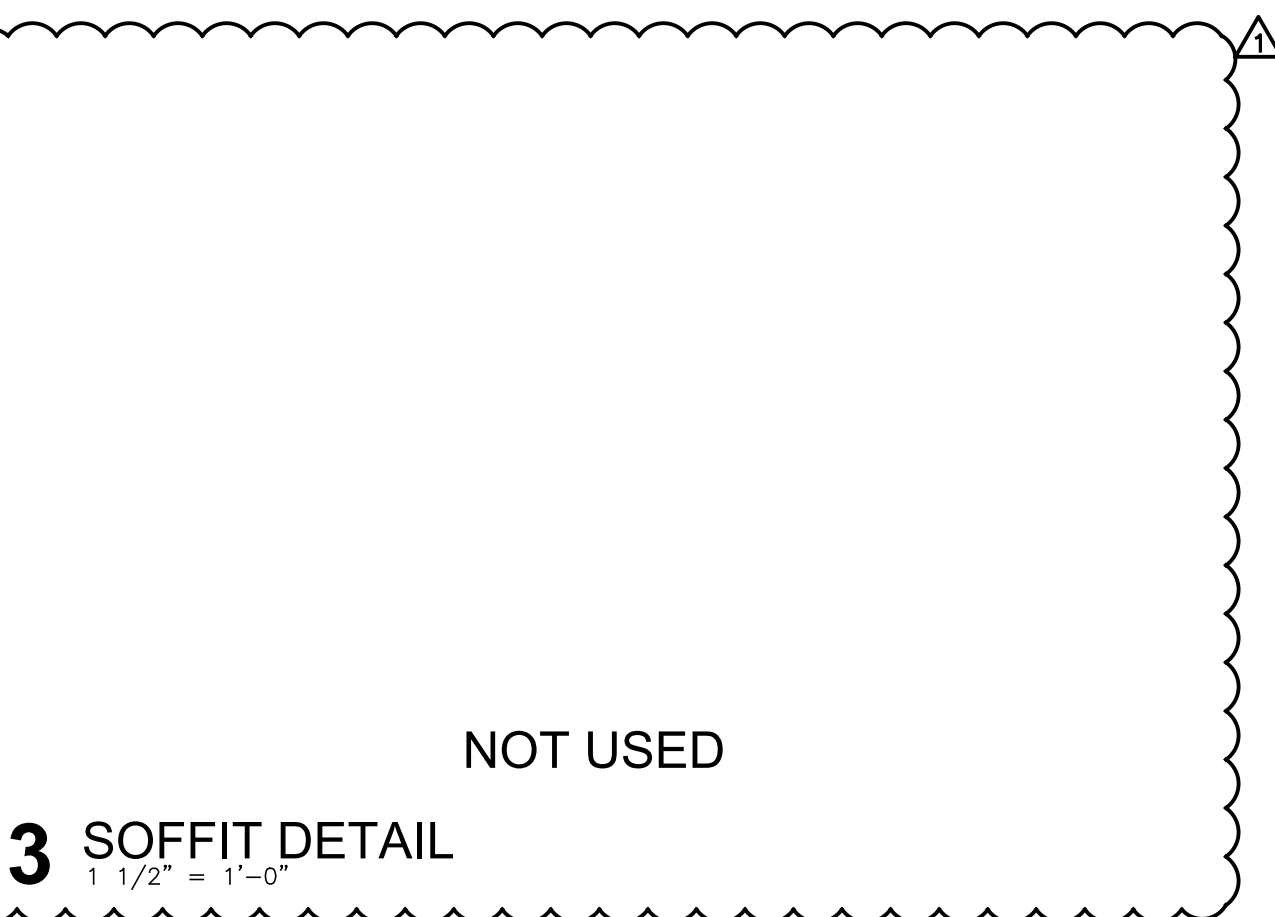

3 SOFFIT DETAIL
1 1/2" = 1'-0"

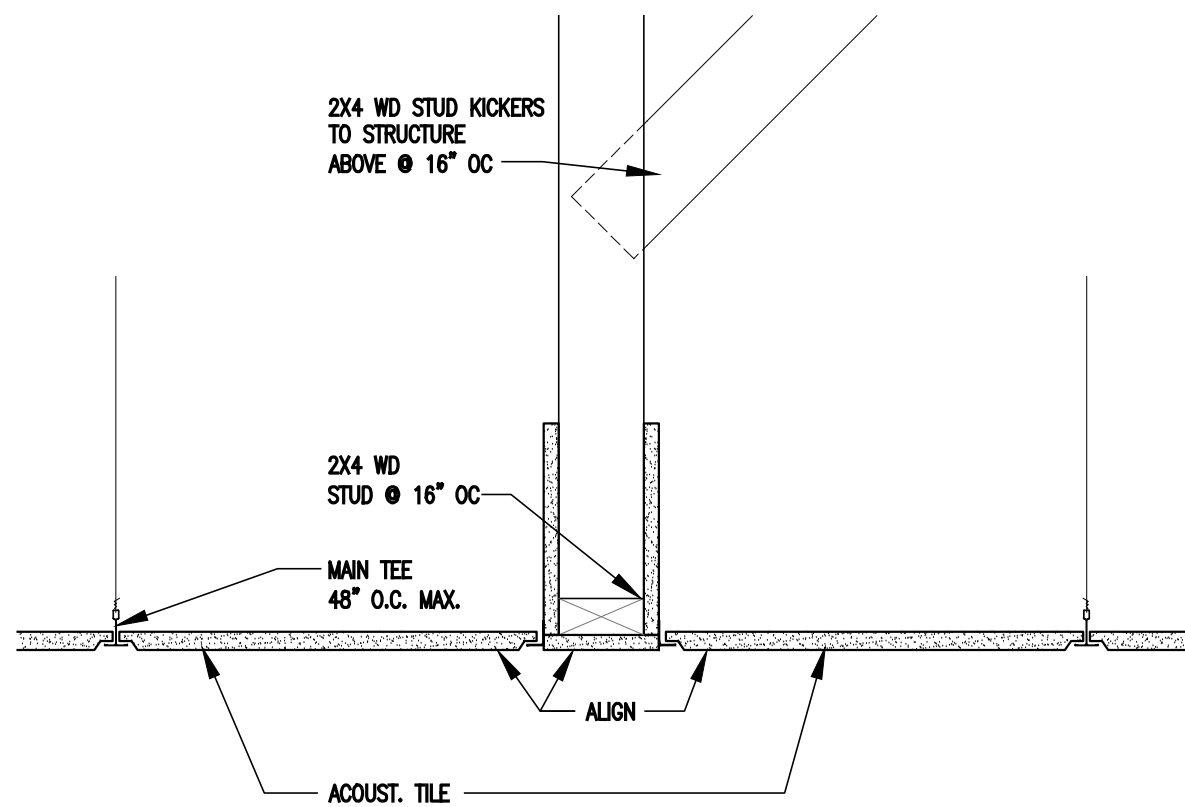

4 ACOUSTIC CEILING TILE DETAIL
1 1/2" = 1'-0"

09.26.23 ADDENDUM NO.1
09.14.23 FOR BID
08.25.23 FOR PERMIT

HALLEL BUILDING
GYMNASIUM ALTERATION

175 ROUTE 340 SPARKILL, NY 10976

arcari iovino
ARCHITECTS PC

REGISTERED ARCHITECT
ANTHONY IOVINO
STATE OF NEW YORK
020765

ONE KATHERINE STREET
LITTLE FERRY, NJ 07643
201 641 0650 FAX 201 641 0626
WWW.AJARCHS.COM

EDWARD ARCARI NYR020765 ANTHONY IOVINO NYR023349

Omdex Incorporated
Consulting Engineers

21 Cross Avenue
Midland Park, NJ 07432-1811
(201) 444-0753 FAX (201) 444-0839

PARTIAL ROOF PLAN AND
PARTIAL REFLECTED CEILING PLAN


SCALE: AS NOTED

DATE: 08.25.2023


FILE: 2260Current/A.1-A.2 Support Plans

©2023 arcari & iovino ARCHITECTS PC

A.2

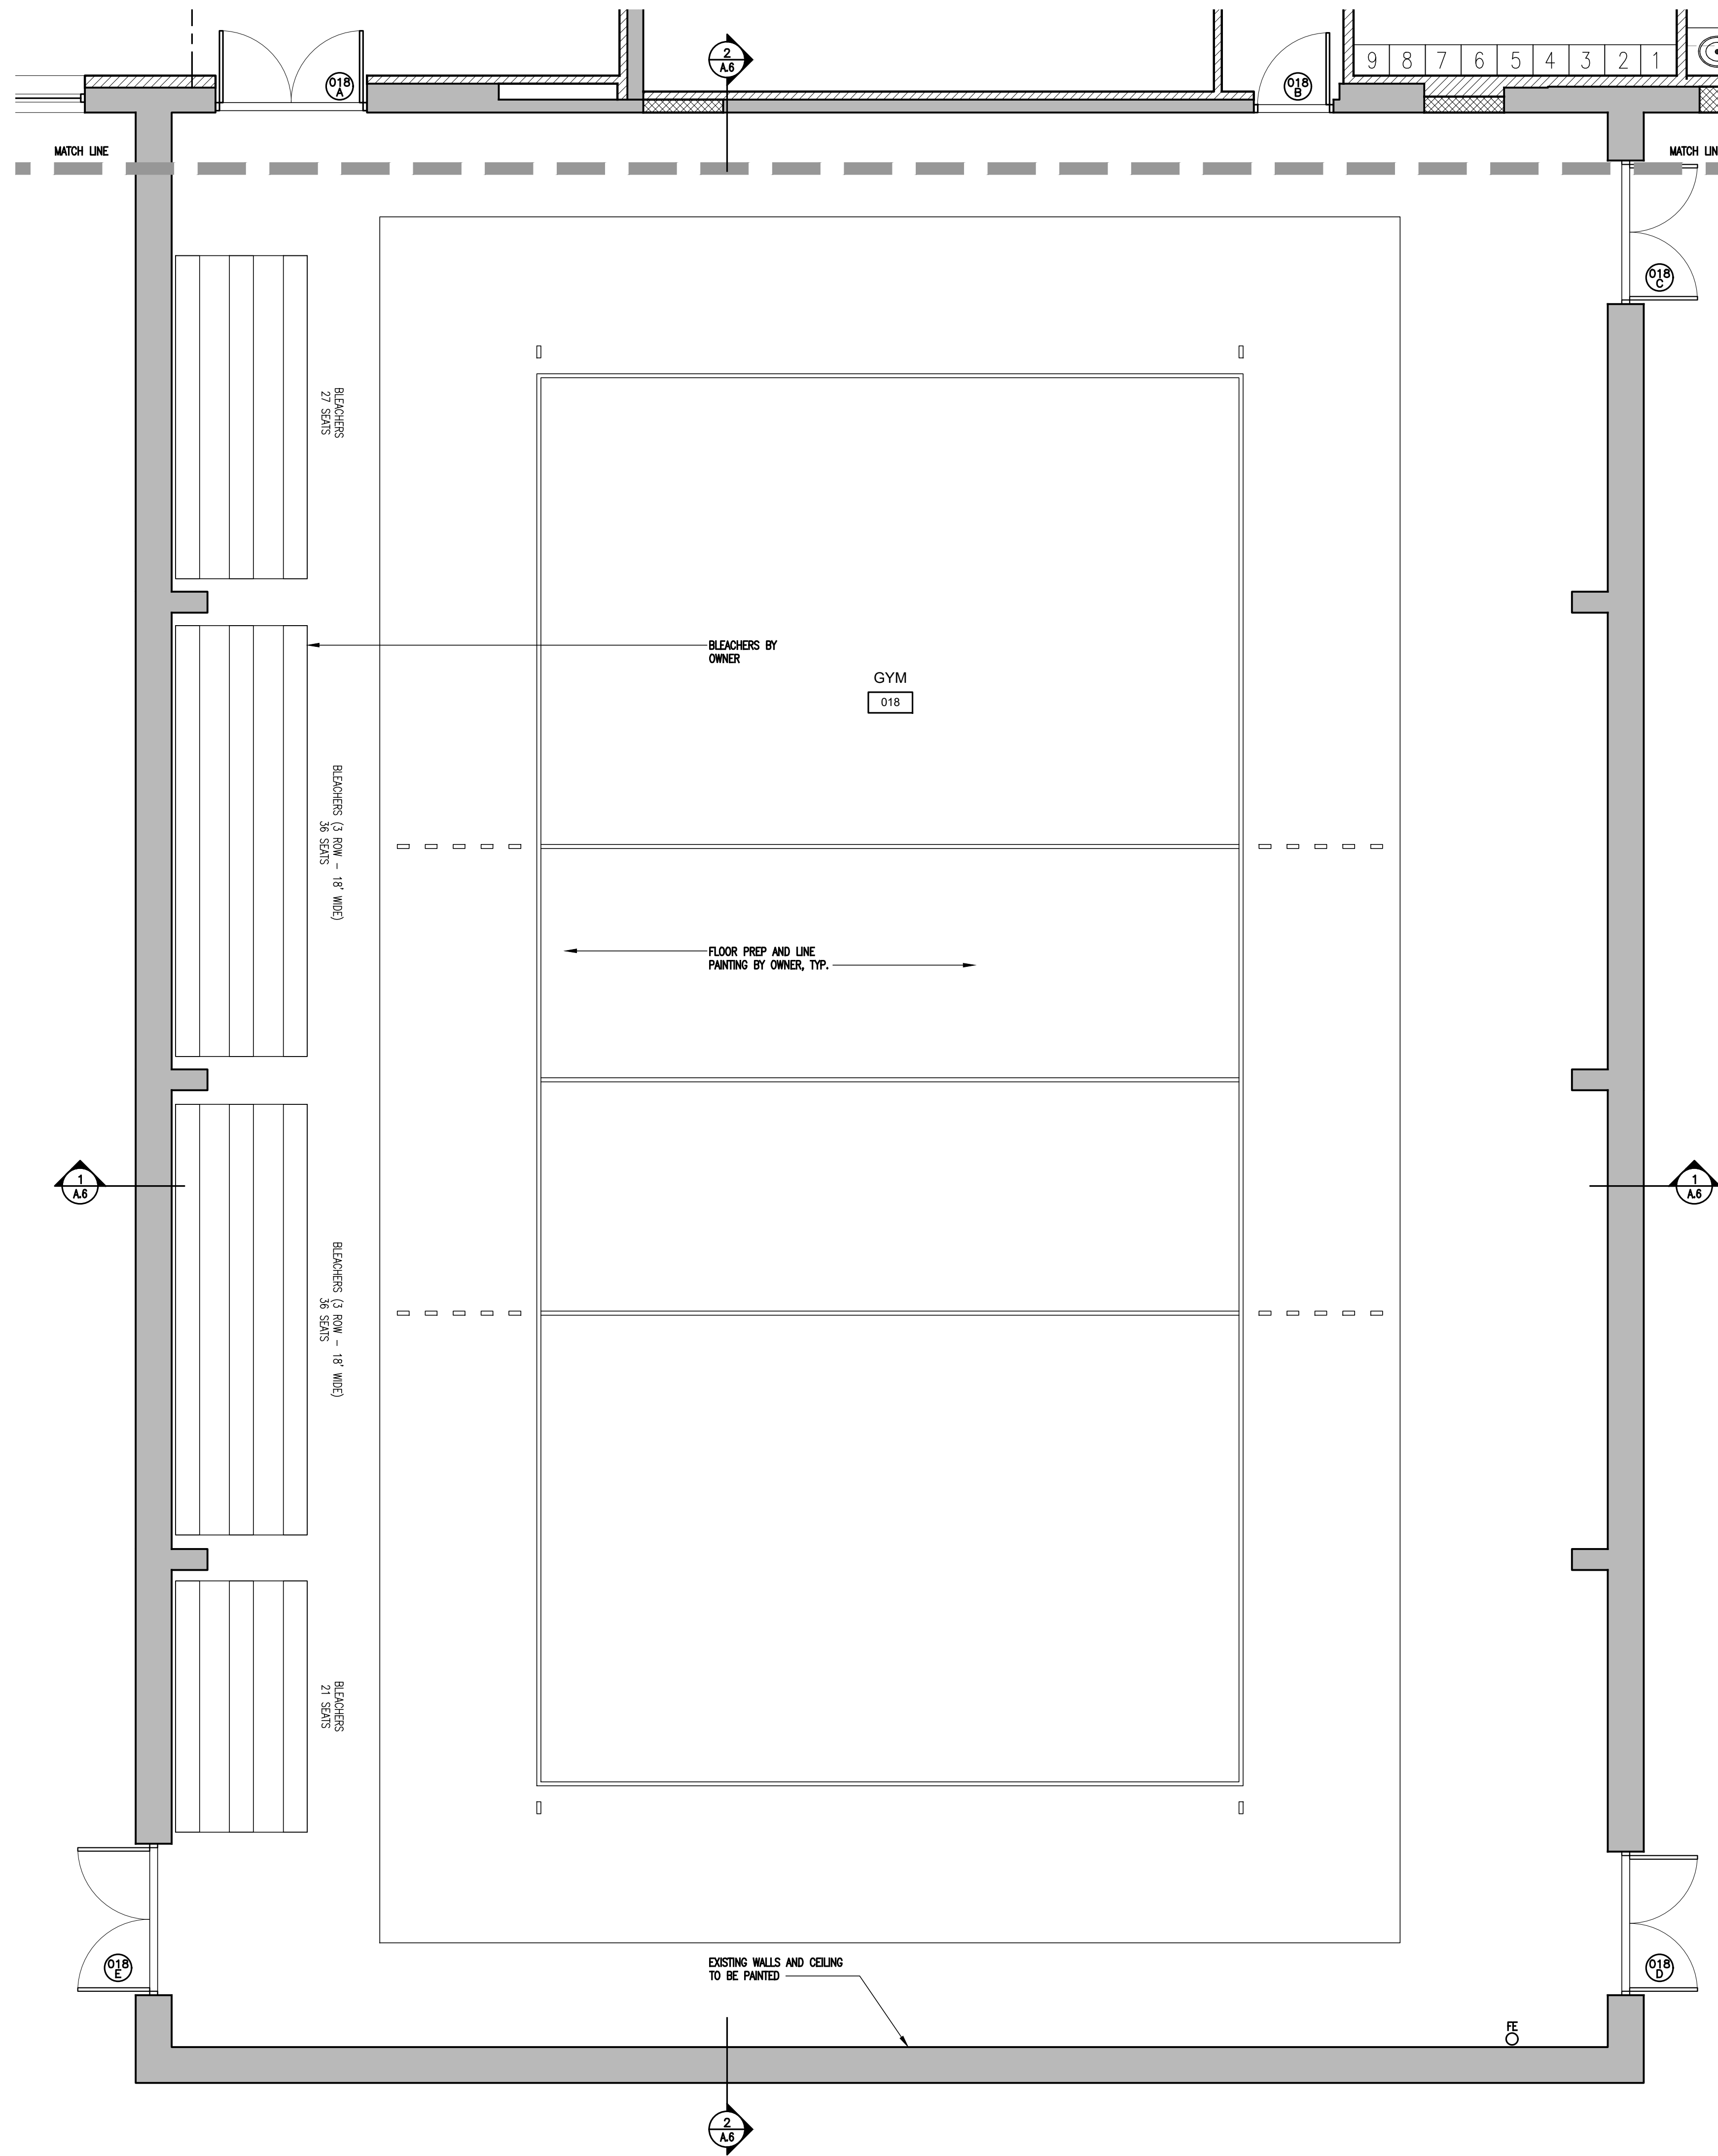

1 PARTIAL CONSTRUCTION PLAN
1/4" = 1'-0"

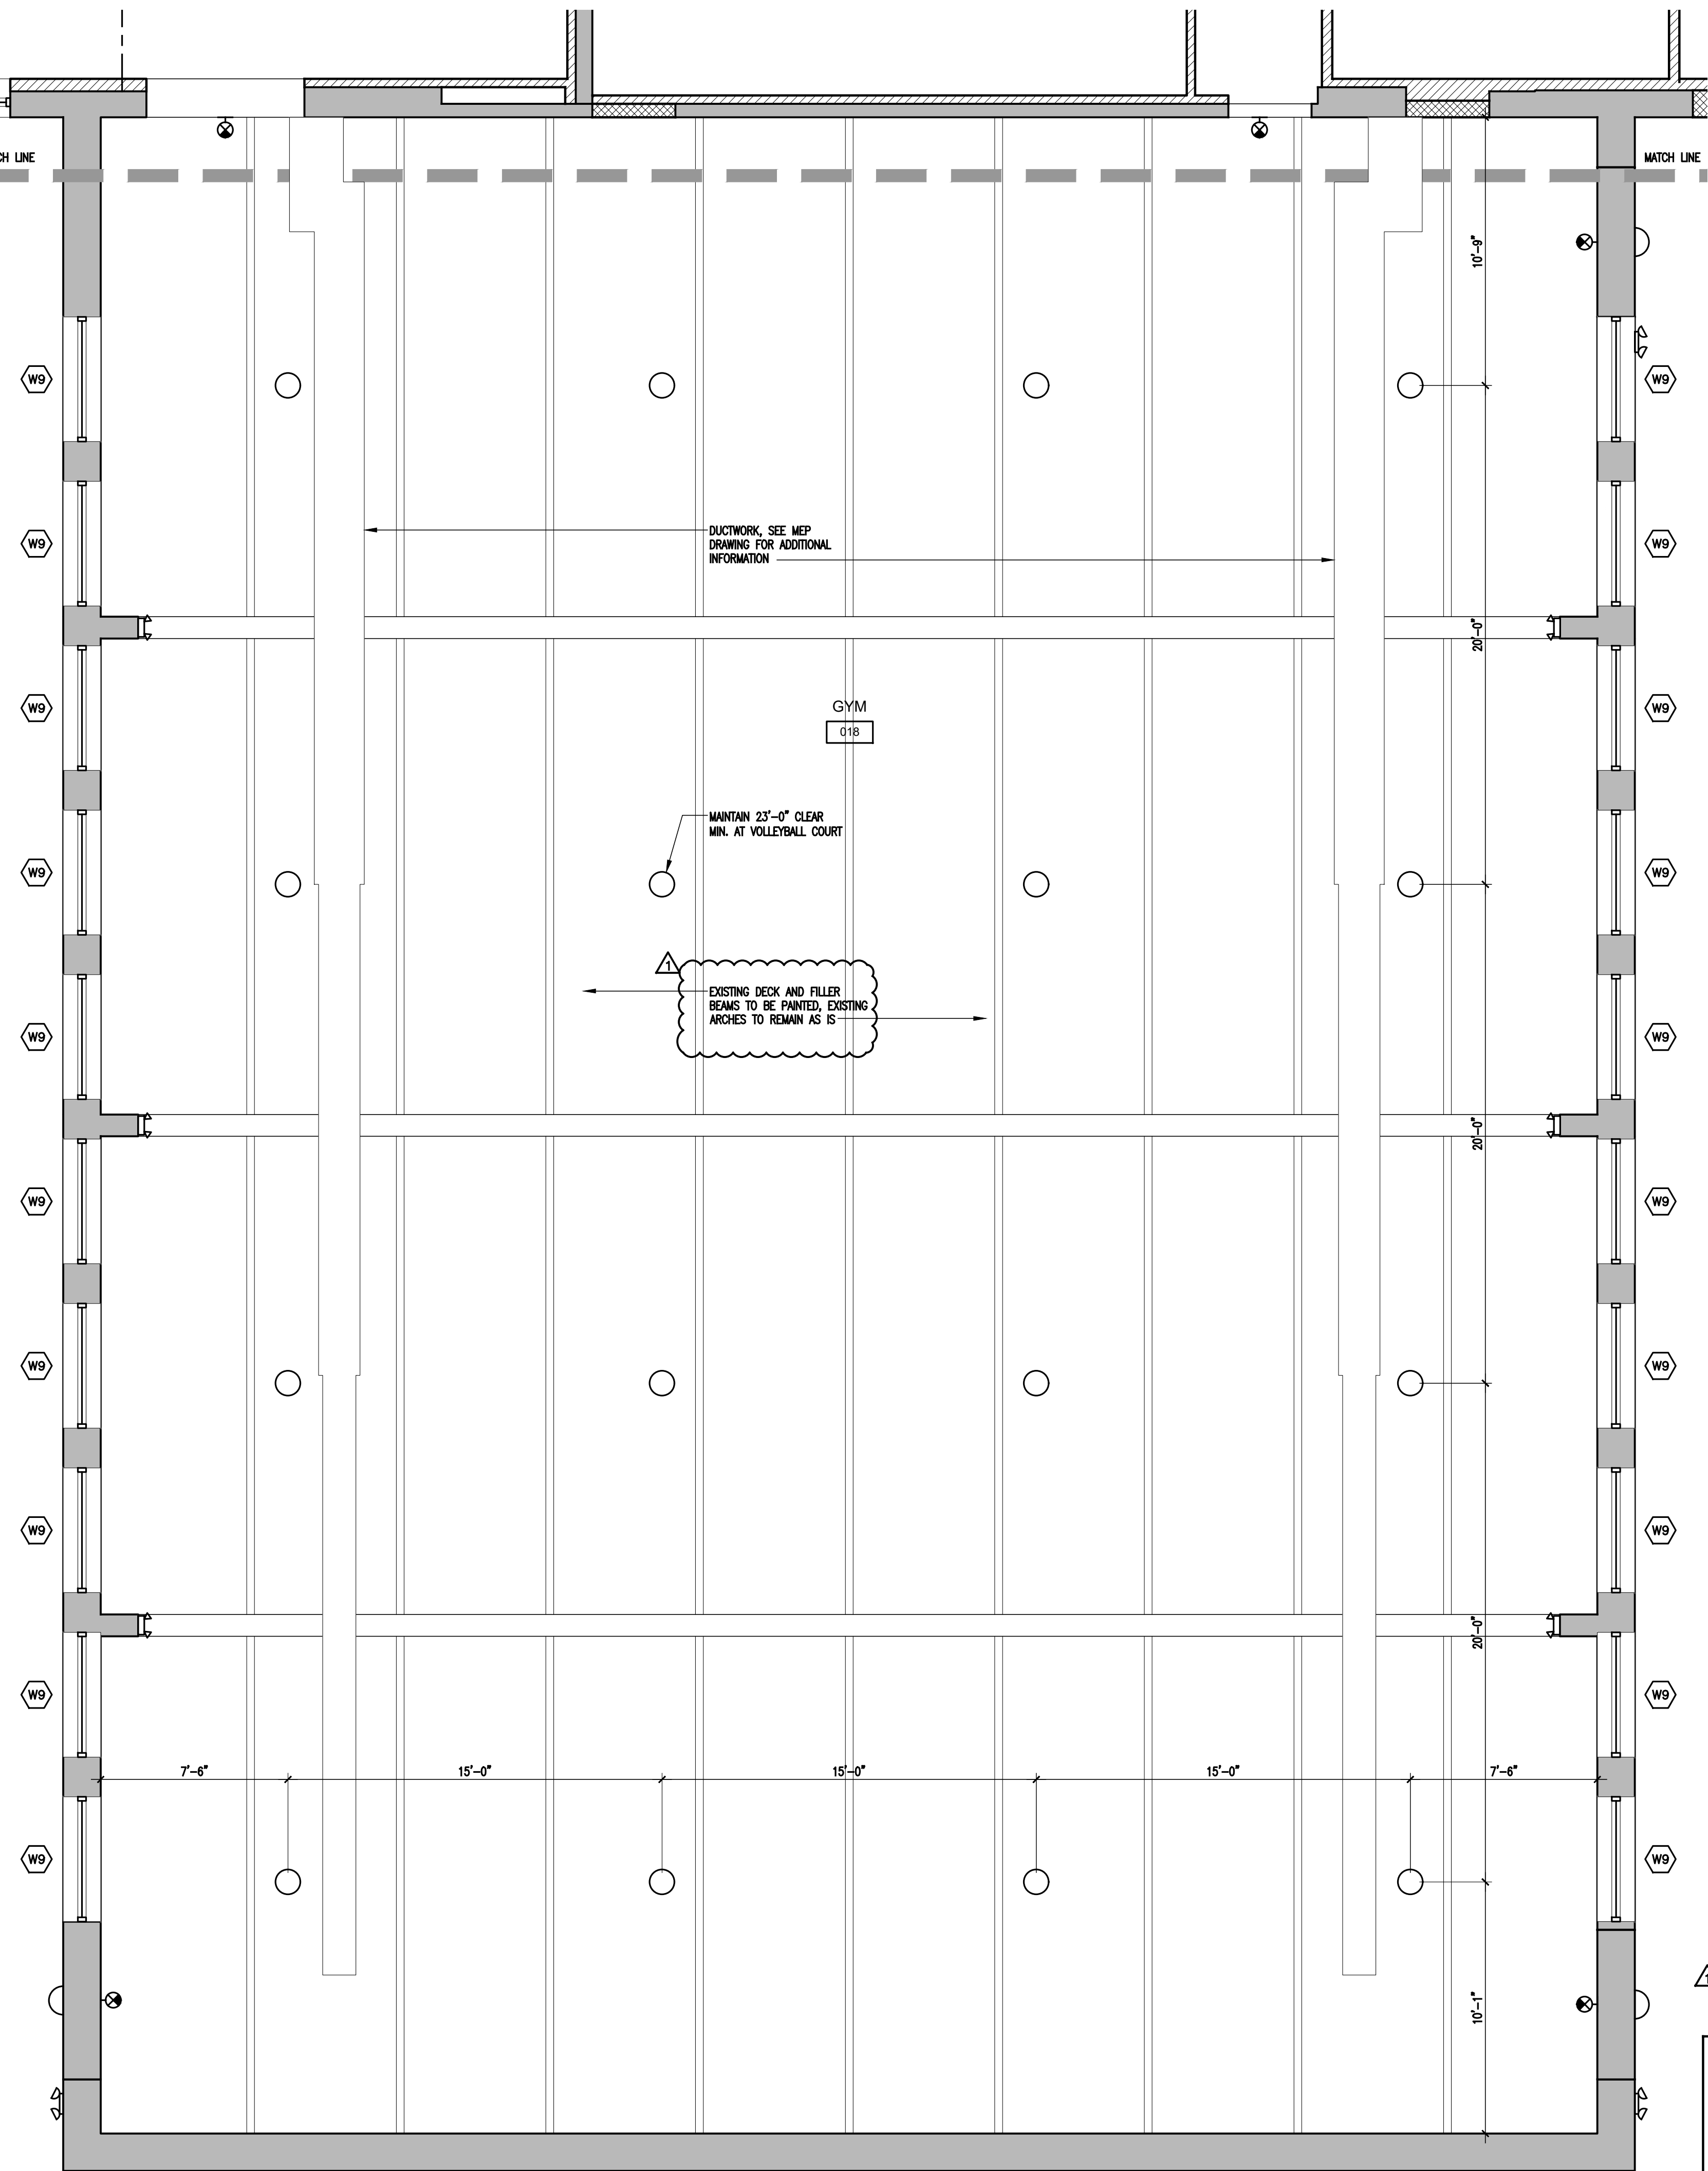

2 PARTIAL REFLECTED CEILING PLAN
1/4" = 1'-0"

CEILING LEGEND

- LED PENDANT
- ◡ EXTERIOR LED WALL SCONCE
- ⬆ INTERIOR EMERGENCY LIGHT
- ⬆ EXTERIOR EMERGENCY LIGHT
- ⊗ EX EMERGENCY EXIT FIXTURE
- ARROW INDICATES FACE

SEE ELECTRICAL DRAWING FOR THE COMPLETE LIGHTING FIXTURE SCHEDULE


09.26.23 ADDENDUM NO.1
09.14.23 FOR BID
08.25.23 FOR PERMIT

HALLEL BUILDING GYMNASIUM ALTERATION

175 ROUTE 340 SPARKILL, NY 10976




EDWARD ARCARI NYR020765 ANTHONY IOVINO NYR023349

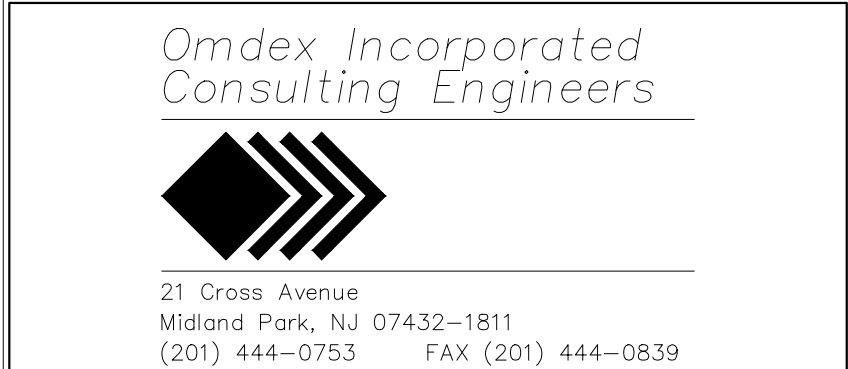


PARTIAL CONSTRUCTION PLAN AND PARTIAL REFLECTED CEILING PLAN

SCALE: AS NOTED
DATE: 08.25.2023
FILE: 2260/Current/A.3 Gym Plans
©2023 arcari & iovino ARCHITECTS PC


A.3

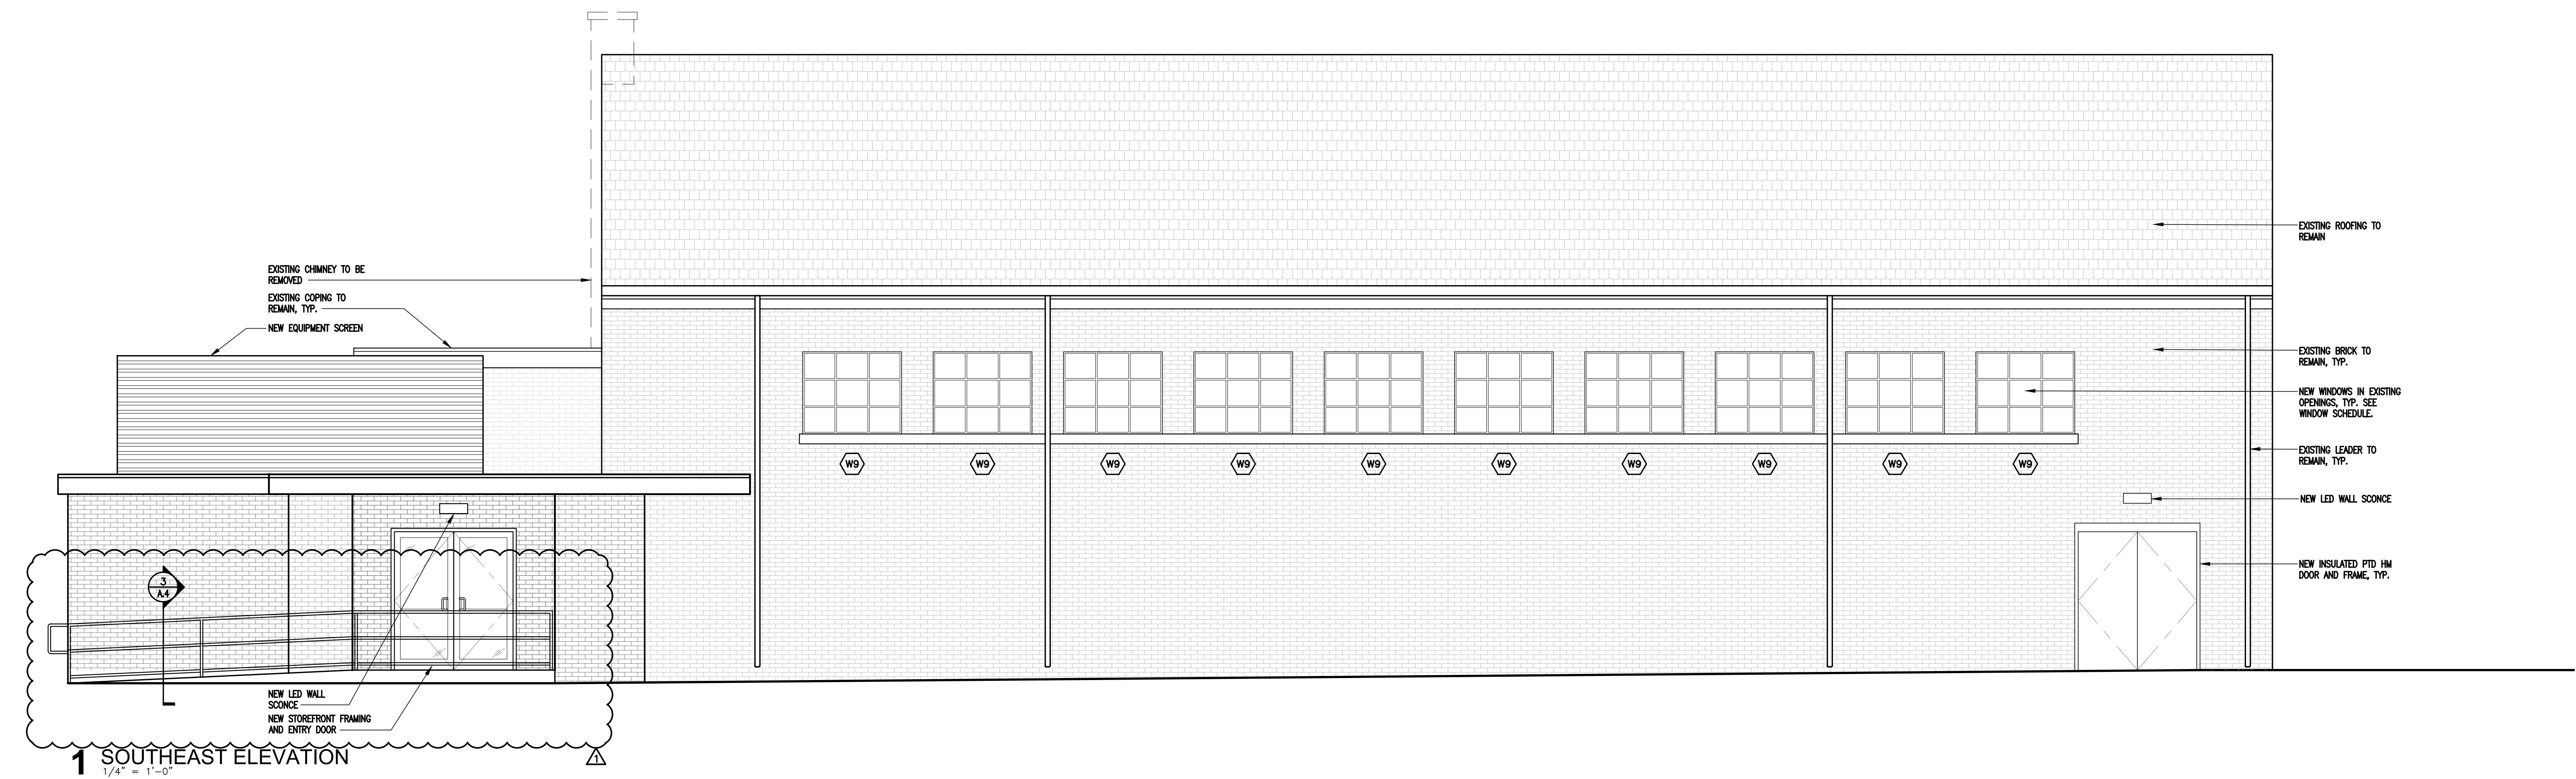

1 SOUTHEAST ELEVATION
1/4" = 1'-0"

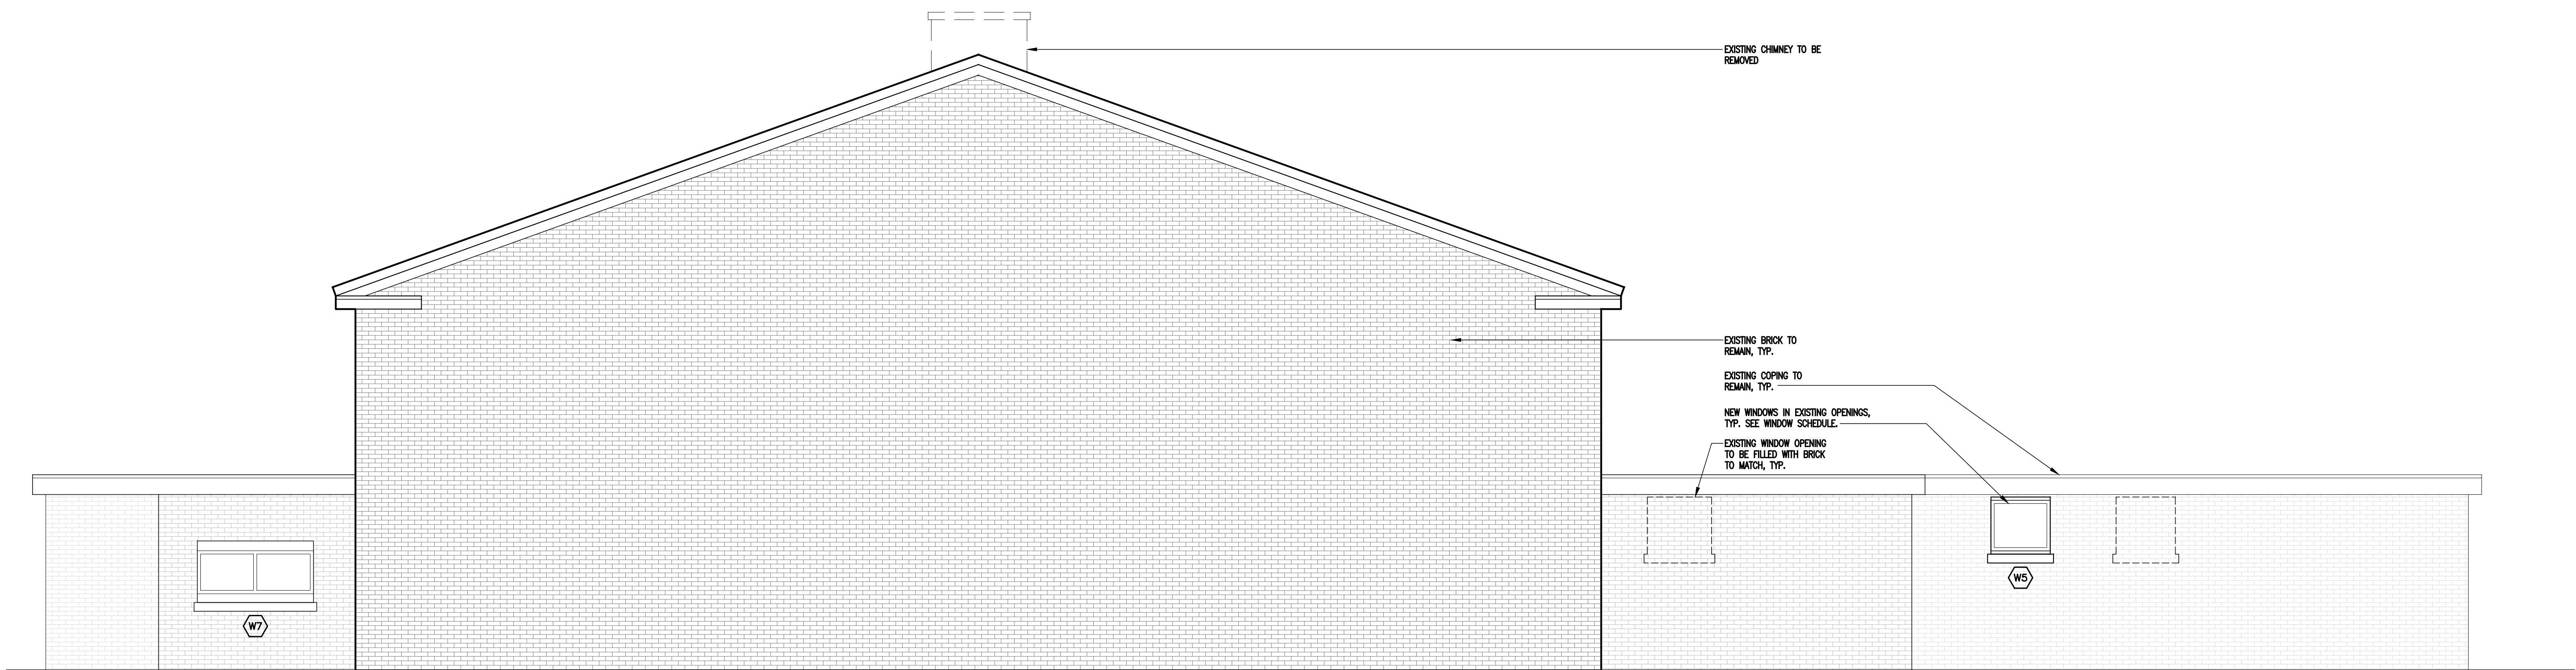

2 NORTHEAST ELEVATION
1/4" = 1'-0"

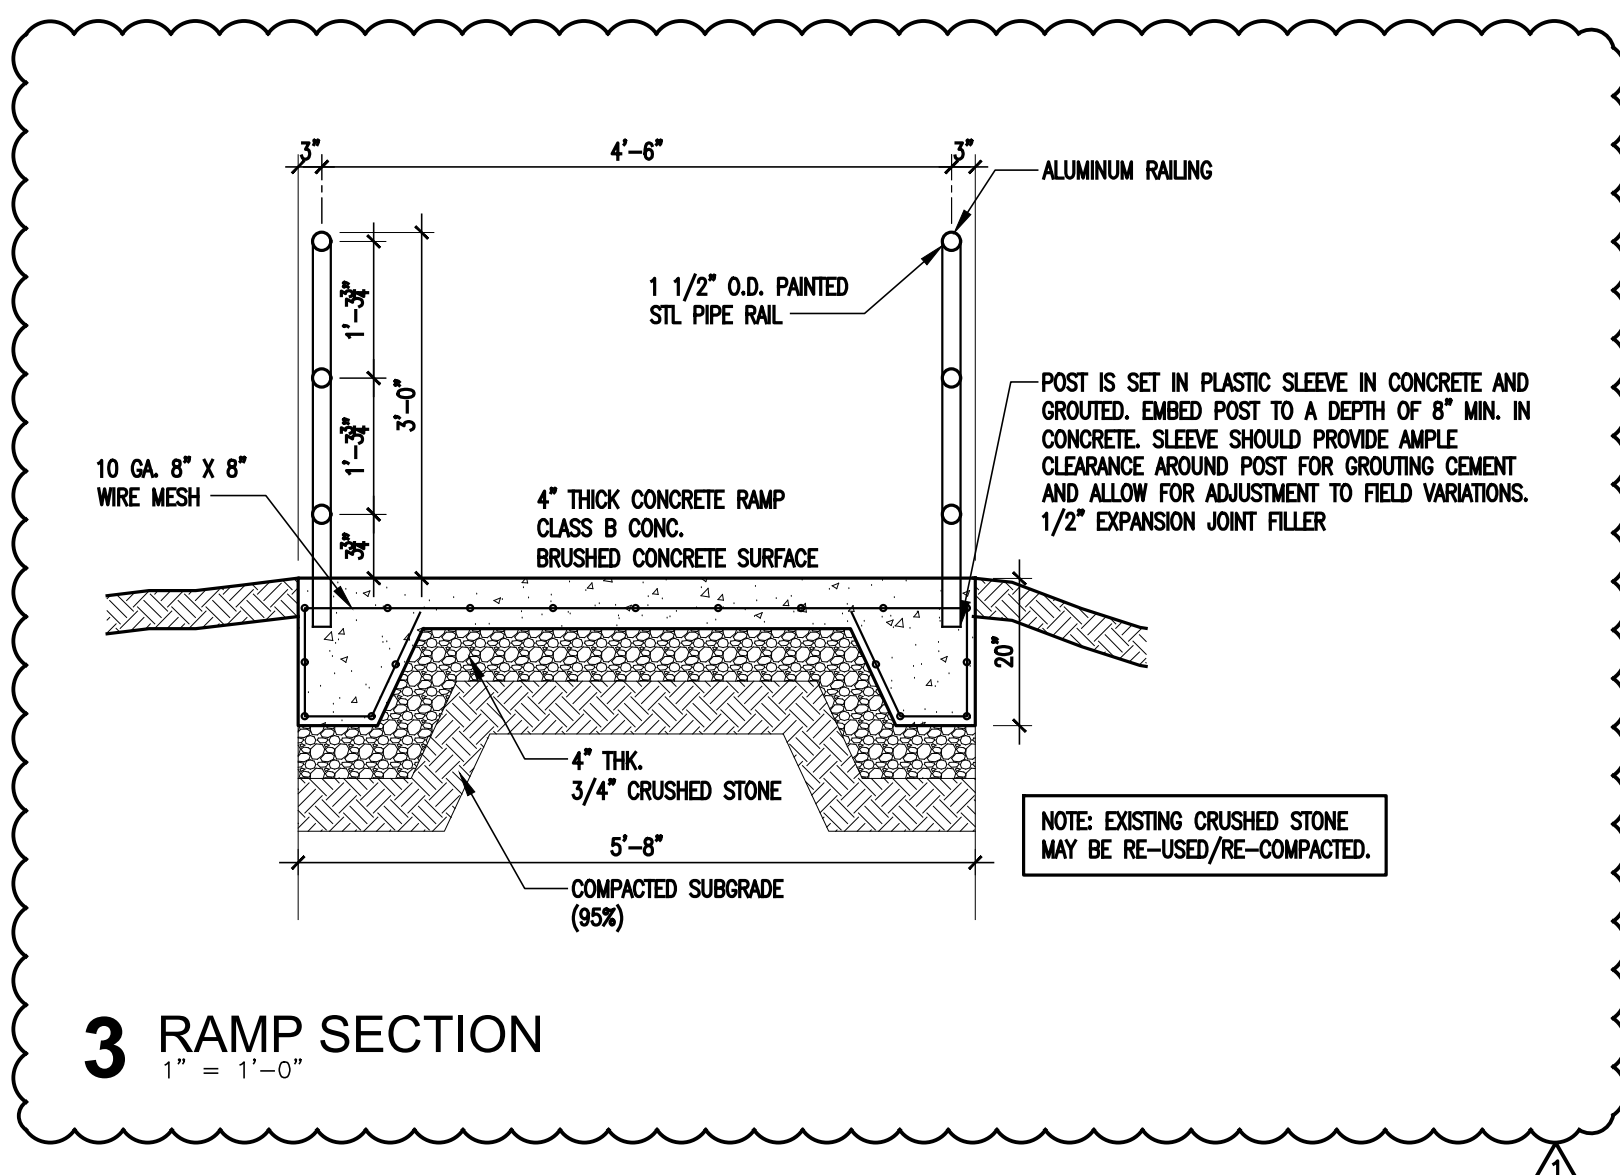

3 RAMP SECTION
1\"/>

09.26.23 ADDENDUM NO.1
09.14.23 FOR BID
08.25.23 FOR PERMIT

**HALLEL BUILDING
GYMNASIUM ALTERATION**

175 ROUTE 340 SPARKILL, NY 10976

arcari iovino
ARCHITECTS PC
ONE KATHERINE STREET
LITTLE FERRY, NJ 07643
201 641 0650 FAX 201 641 0626
WWW.AARCHS.COM

EDWARD ARCARI NYR020765 ANTHONY IOVINO NYR023349

Omdex Incorporated
Consulting Engineers

21 Cross Avenue
Midland Park, NJ 07432-1811
(201) 444-0753 FAX (201) 444-0839

BUILDING ELEVATIONS

SCALE: AS NOTED

DATE: 08.25.2023


FILE: 2260/Current/A.4 Ext Elevations

©2023 arcari & iovino ARCHITECTS PC


A.4

ARCHITECTURAL LOUVERS V6JN5 6" DEEP NARROW
BLADE EXTRUDED ALUMINUM SCREEN WITH
STURDISTRICT ROOFTOP FRAMING SYSTEM FOR
LOUVERED EQUIPMENT SCREENS



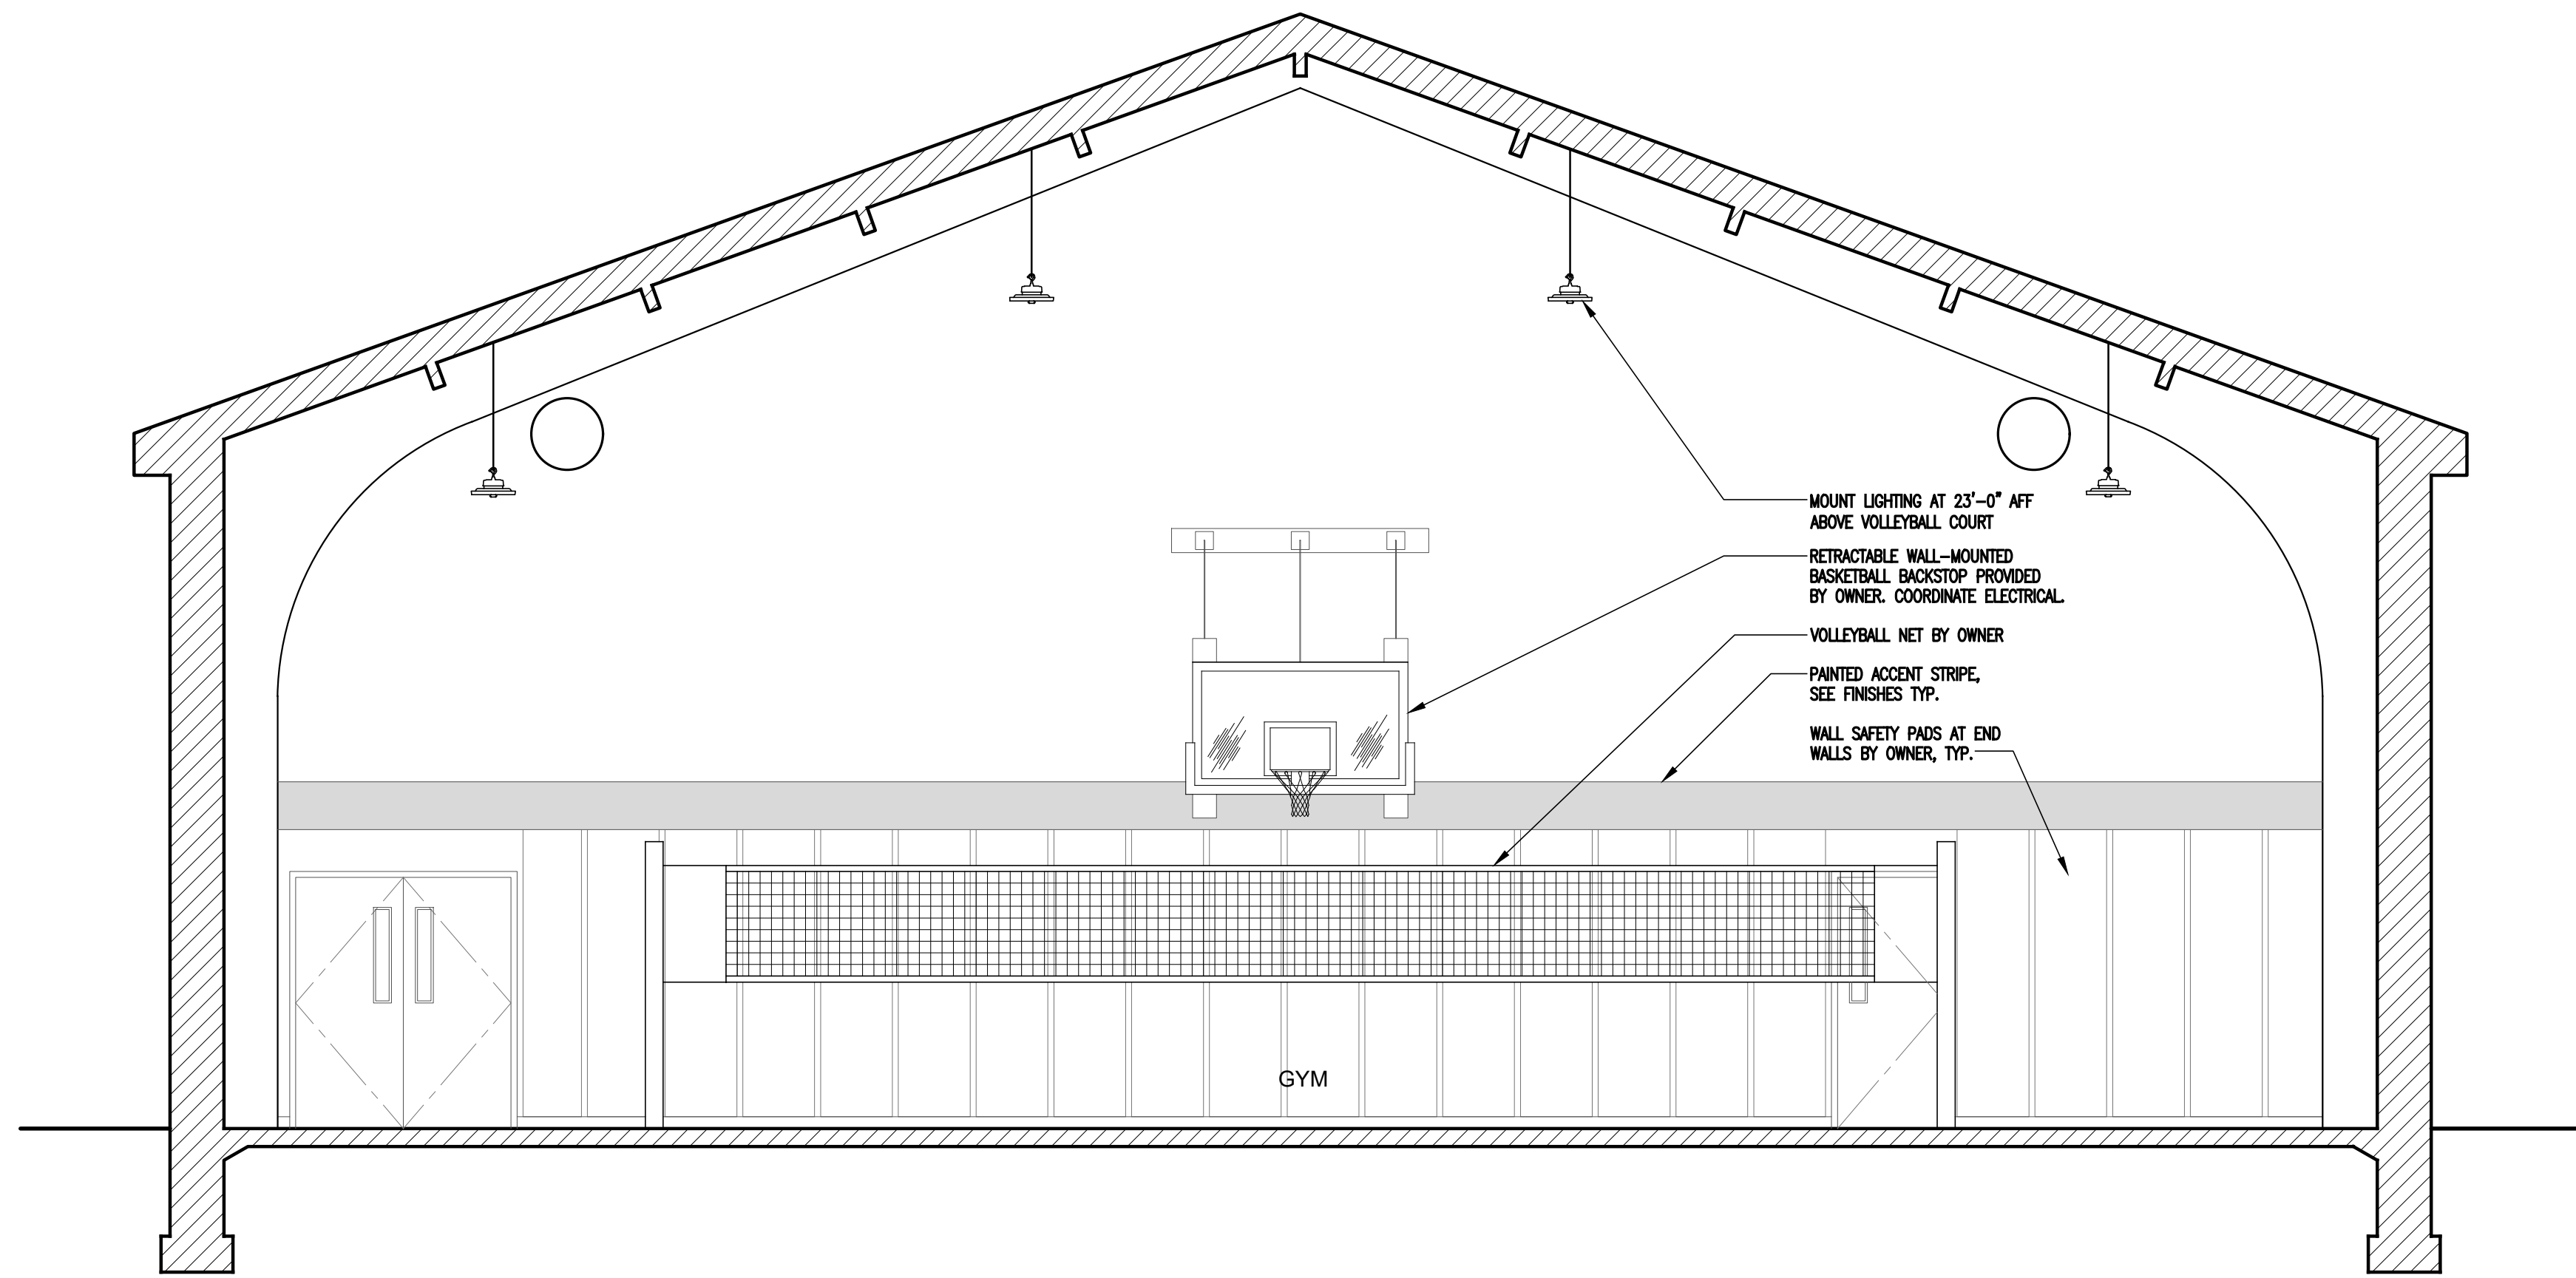



1 SECTION
1/4" = 1'-0"

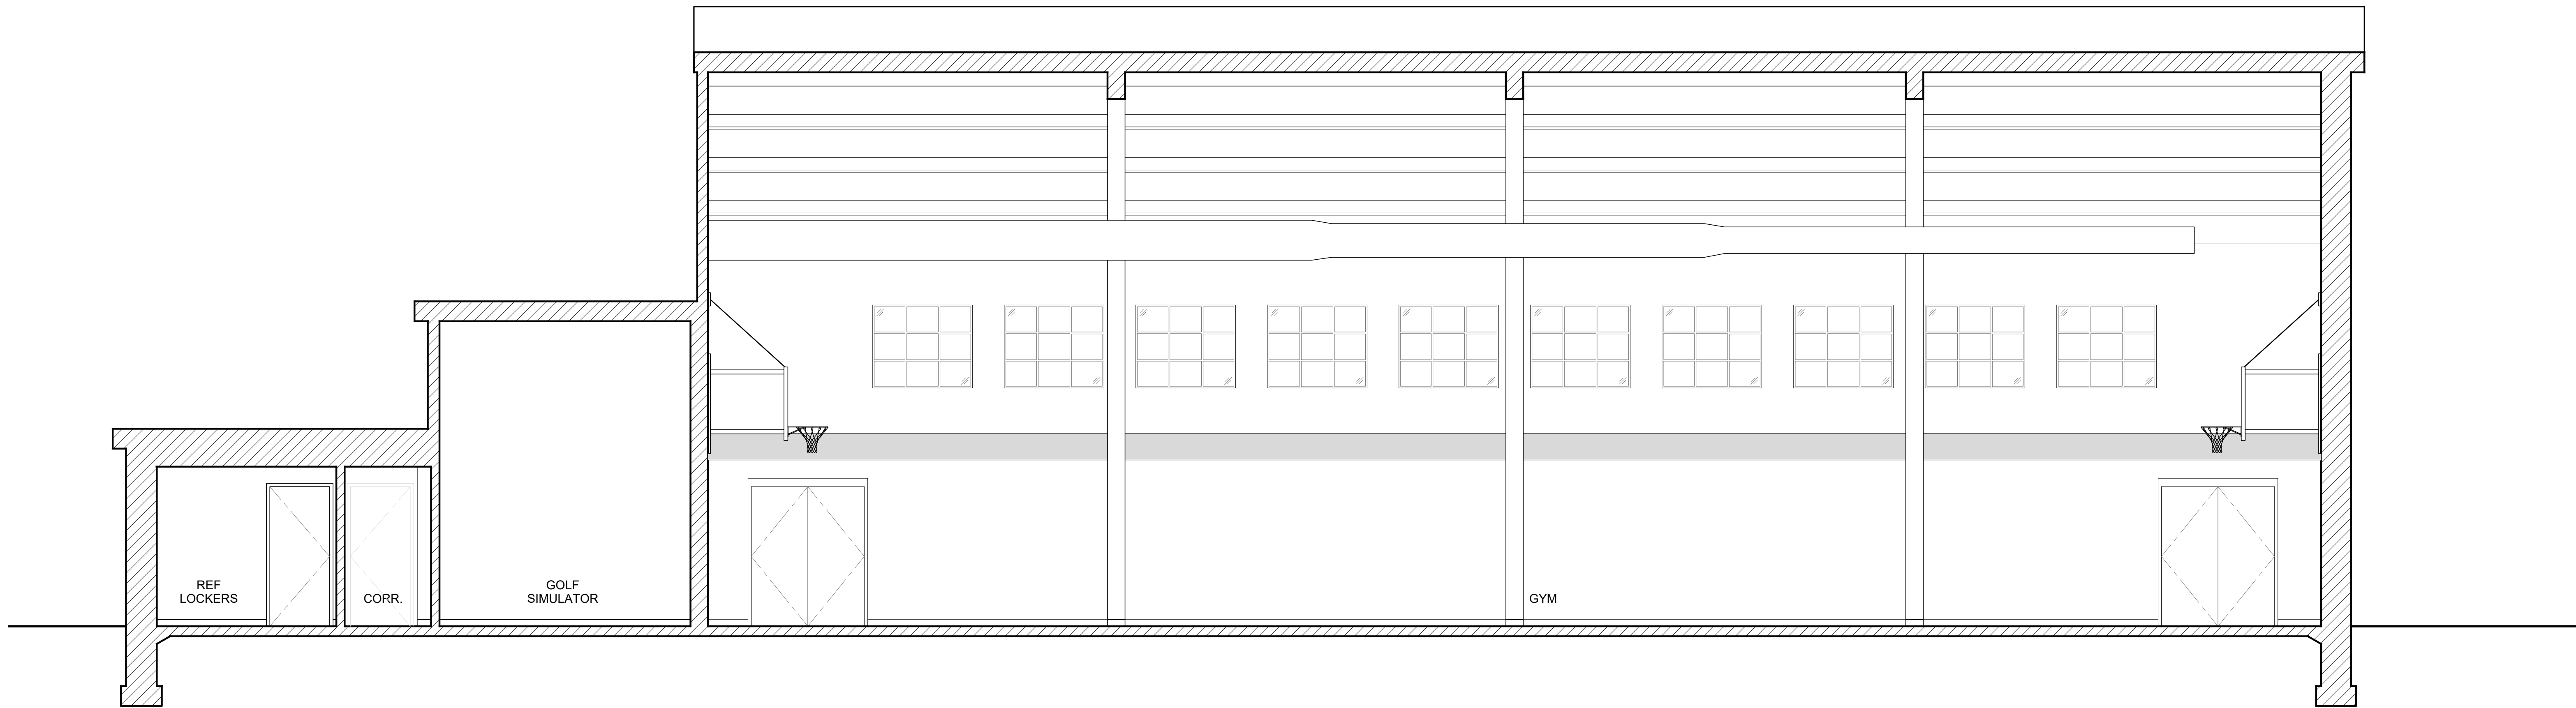


2 SECTION
1/4" = 1'-0"

09.26.23 ADDENDUM NO.1
09.14.23 FOR BID
08.25.23 FOR PERMIT

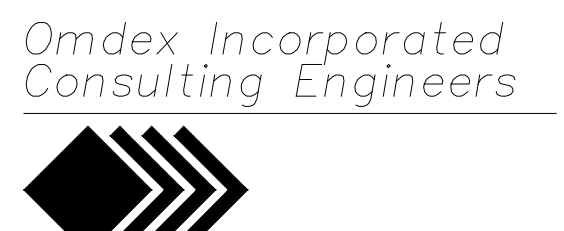HALLEL BUILDING GYMNASIUM ALTERATION	
175 ROUTE 340	SPARKILL, NY 10976
	
EDWARD ARCARI NYR020765 ANTHONY IOVINO NYR023349	
	
21 Cross Avenue Midland Park, NJ 07432-1811 (201) 444-0753 FAX (201) 444-0839	
BUILDING SECTIONS	
SCALE: AS NOTED DATE: 08.25.2023 FILE: 2260/Current/A.6 Sections	A.6
©2023 arcari & iovino ARCHITECTS PC	

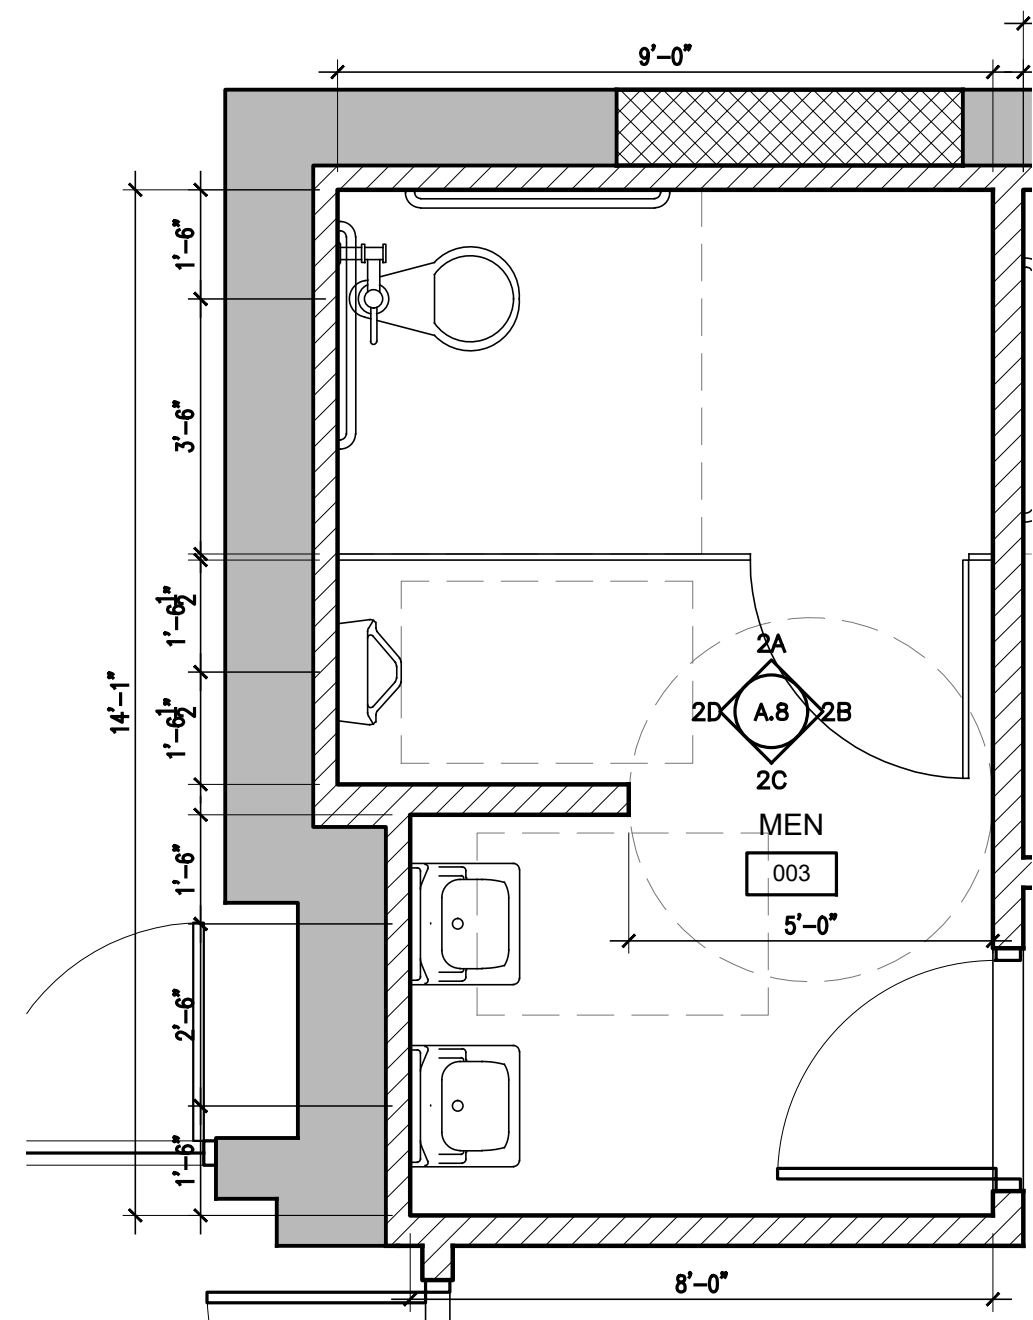


1 MEN 003 ENLARGED PLAN
3/8" = 1'-0"

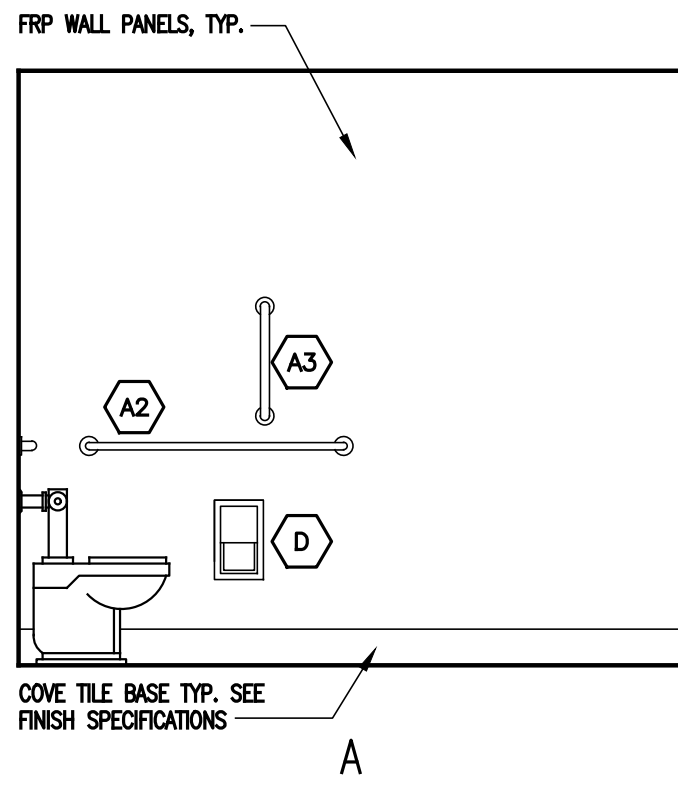


2 MEN 003 ELEVATIONS
3/8" = 1'-0"

NOTES ARE TYPICAL FOR ALL ELEVATIONS

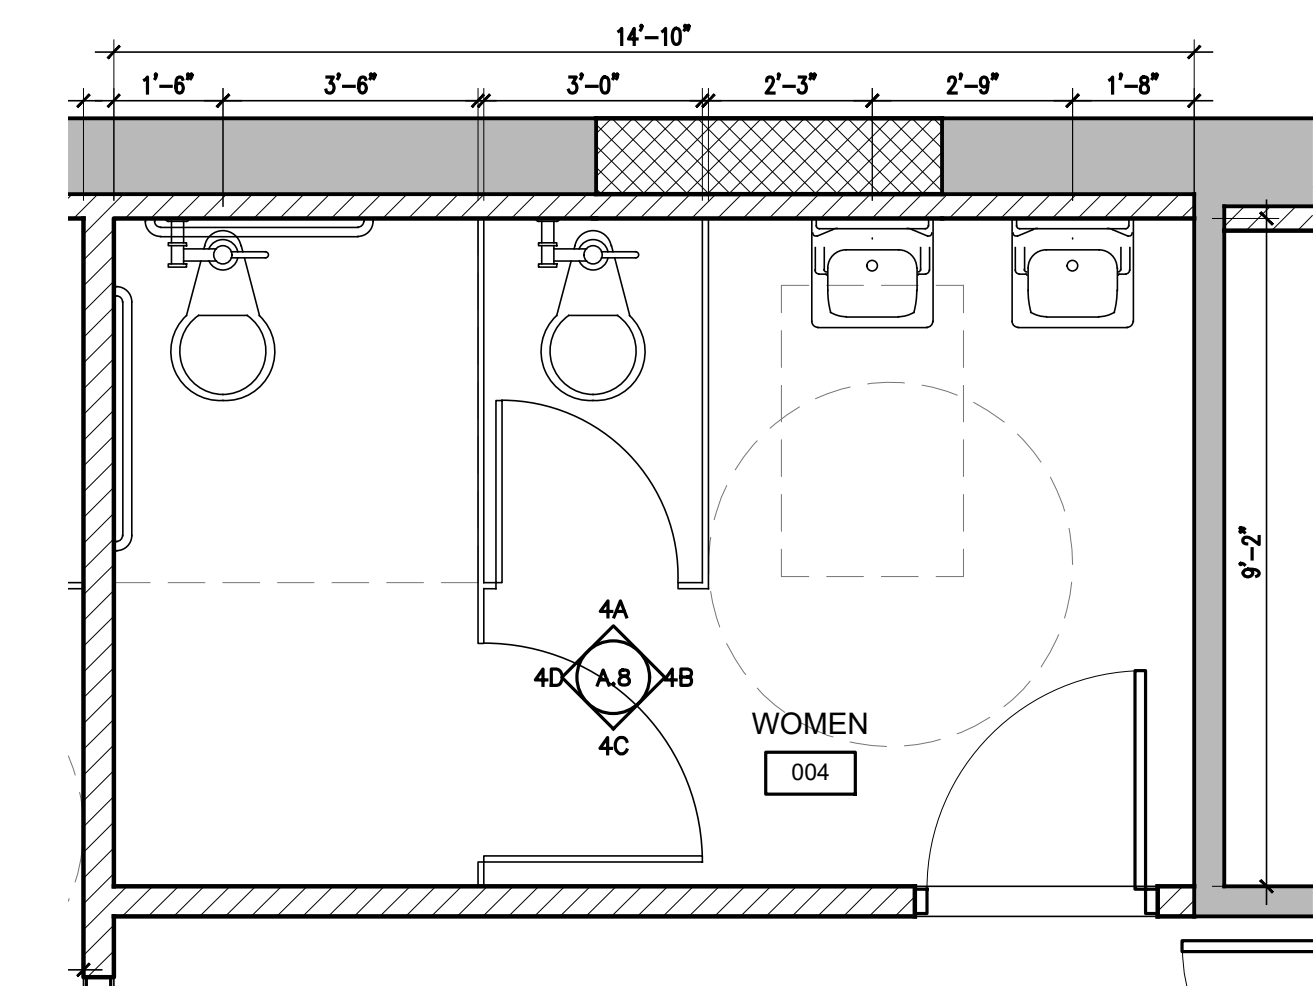


3 WOMEN 004 ENLARGED PLAN
3/8" = 1'-0"

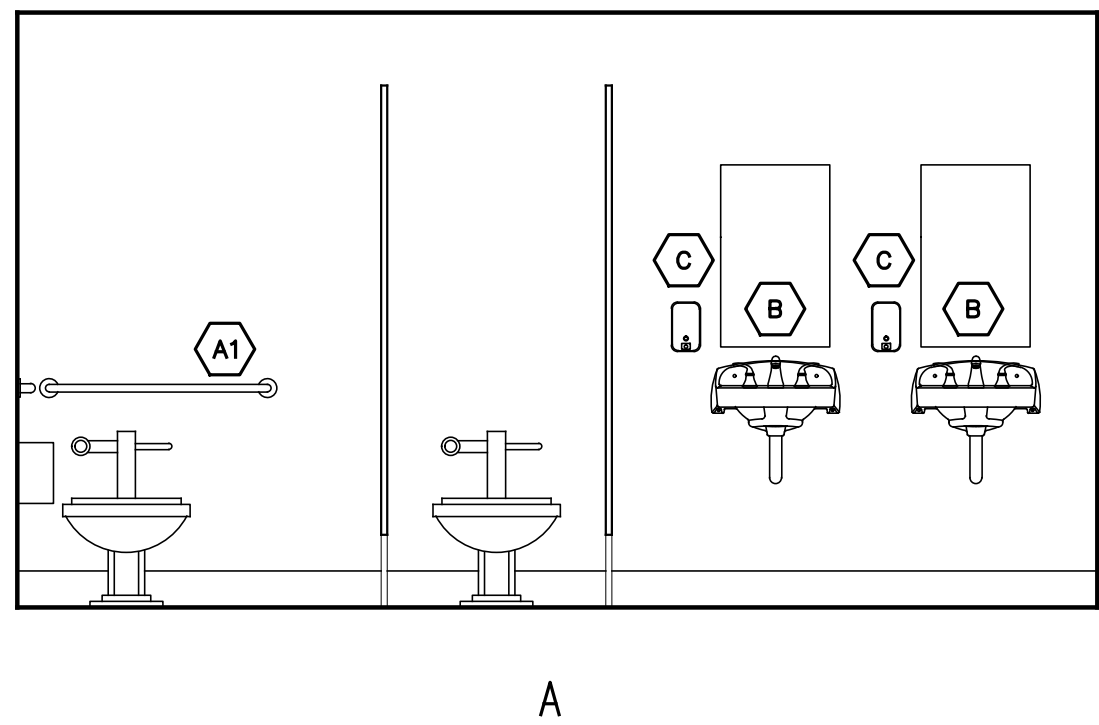


4 WOMEN 004 ELEVATIONS
3/8" = 1'-0"

SEE 2A FOR TYPICAL NOTES

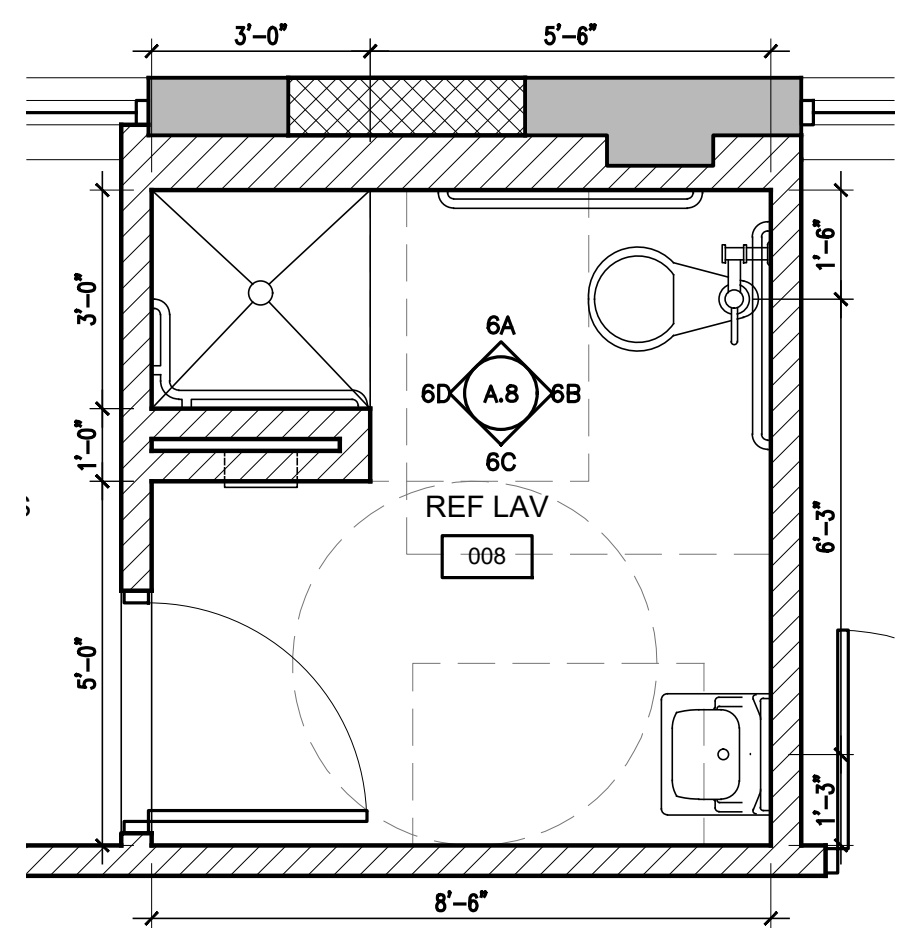


5 REF LOCKERS 007 ENLARGED PLAN
3/8" = 1'-0"

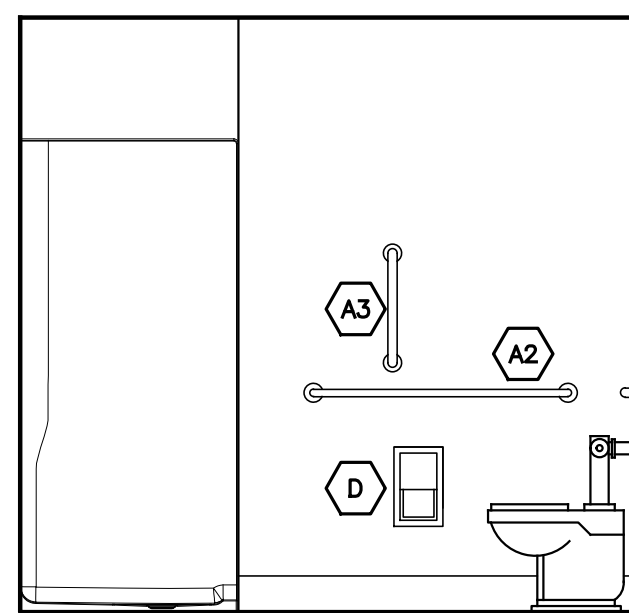


6 REF LOCKERS 007 ELEVATIONS
3/8" = 1'-0"


SEE 2A FOR TYPICAL NOTES

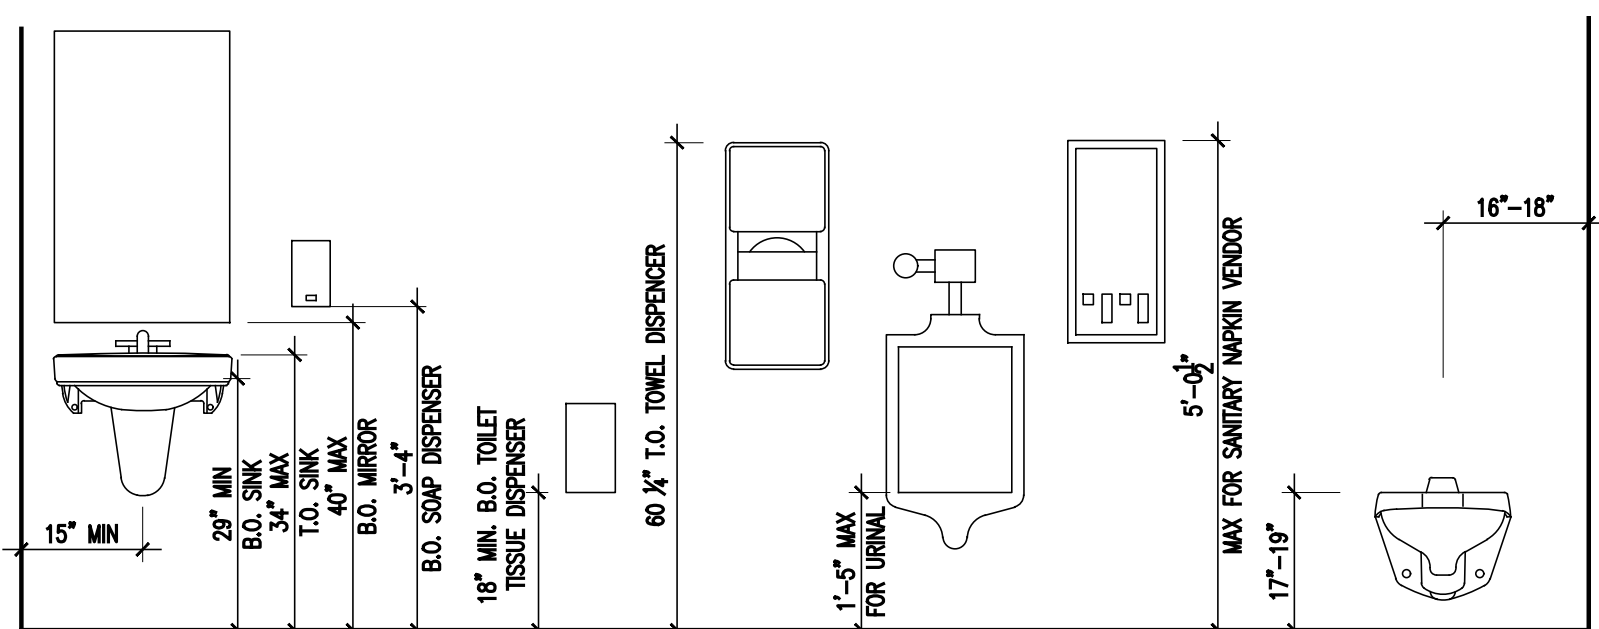

7 ADA MOUNTING HEIGHTS
1/2" = 1'-0"

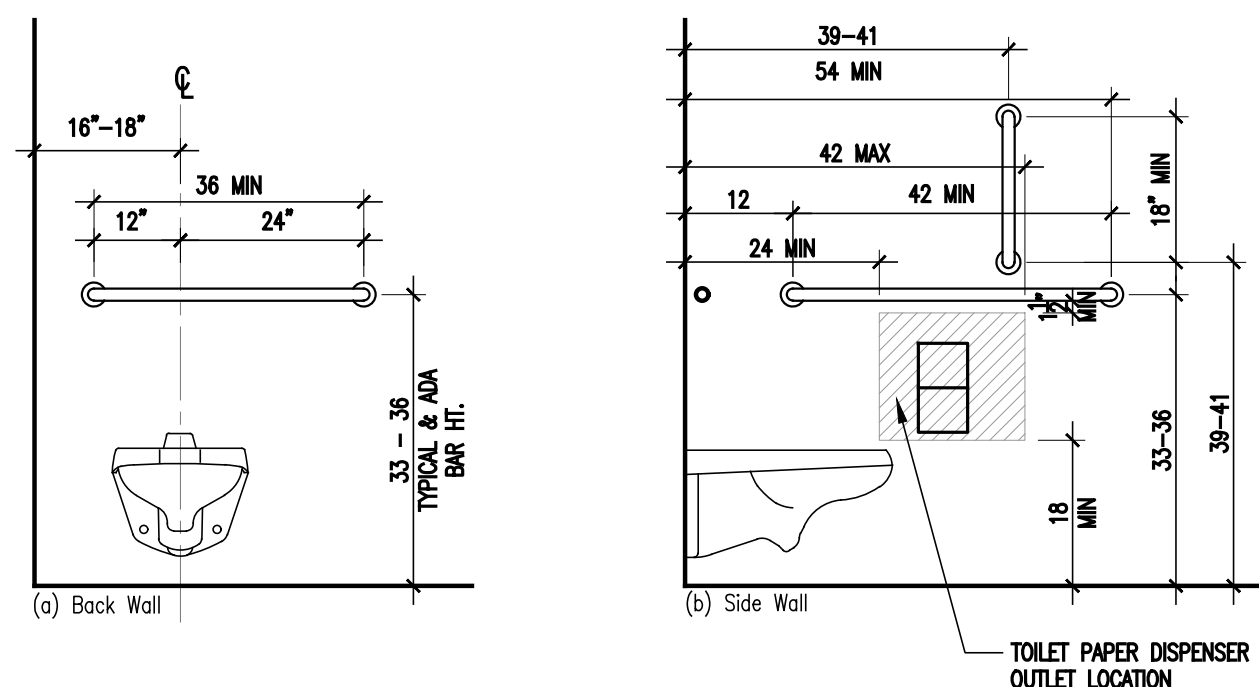

8 TOILET HEIGHT
1/2" = 1'-0"

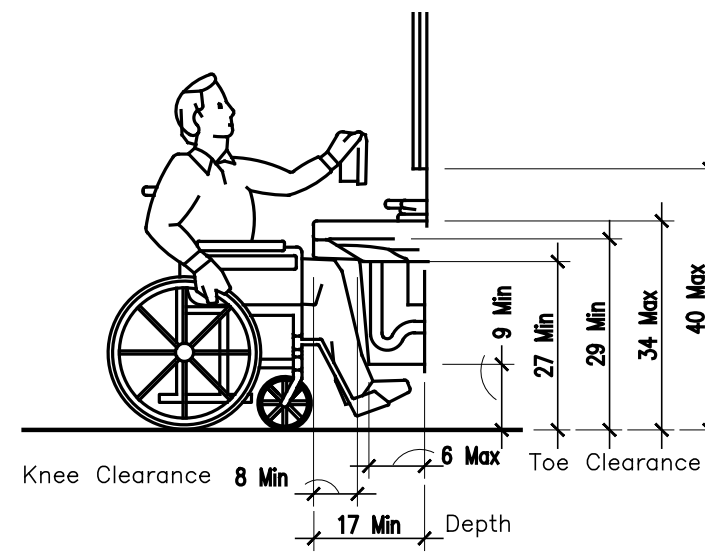

9 MIN ADA CLEARANCES AT LAVS.
1/4" = 1'-0"

ACCESSORY SCHEDULE

ITEM	DESCRIPTION	BASIS OF DESIGN MODEL NO.	NOTES
A1	1-1/4" STAINLESS STEEL GRAB BARS WITH SNAP FLANGE, 36" LONG	BOBRICK B-5806	SATIN FINISH STAINLESS STEEL
A2	1-1/4" STAINLESS STEEL GRAB BARS WITH SNAP FLANGE, 42" LONG	BOBRICK B-5806	SATIN FINISH STAINLESS STEEL
A3	1-1/4" STAINLESS STEEL GRAB BARS WITH SNAP FLANGE, 18" LONG	BOBRICK B-5806	SATIN FINISH STAINLESS STEEL
B	24"X30" WALL-MOUNTED MIRROR	BOBRICK B-165-2436	SATIN FINISH STAINLESS STEEL
C	SURFACE-MOUNTED SOAP DISPENSER	BOBRICK B-2013	SATIN FINISH STAINLESS STEEL
D	TOILET TISSUE DISPENSER	BOBRICK B-4288	SATIN FINISH STAINLESS STEEL
E	SANITARY NAPKIN DISPENSER	BOBRICK B-254	SATIN FINISH STAINLESS STEEL
F	PAPER TOWEL DISPENSER AND WASTE RECEPTACLE	BOBRICK B-4368(G)	SATIN FINISH STAINLESS STEEL
G	PARTITIONS	BOBRICK DURALINE SERIES	SATIN FINISH STAINLESS STEEL

FOR MOUNTING OPTIONS, S = SURFACE MOUNTED, SR = SEMI-RECESSED, R = RECESSED

PLUMBING NOTES

- 1) INSTALL WATERPROOFING AT ALL TILE FLOORS
- 2) COORDINATE LAYOUT TO INSURE THAT COVE BASE ALIGNS AROUND ENTIRE ROOM (NO CUT TILE ACCEPTABLE)
- 3) PROVIDE BLOCKING AT ALL ACCESSORIES. COORDINATE REQUIRED LOCATIONS WITH MANUFACTURERS INSTALLATION INSTRUCTIONS.
- 4) PROVIDE PORCELAIN TILE ACCESSORIES TO ENSURE FULL FLOOR AND WALL INSTALLATION (INCLUDING AND NOT LIMITED TO INSIDE AND OUTSIDE TILE CORNERS)
- 5) INSTALL PIPE WRAP AT ALL EXPOSED PIPING, TYP. SEE PLUMBING DRAWINGS FOR SPECIFICATION.
- 6) ALL PLUMBING ACCESSORIES AND SPECIFICATIONS ARE BASIS OF DESIGN
- 7) SEE MEP DRAWINGS FOR ADA-COMPLIANT BARRIER-FREE SHOWER, TRANSFER SHOWER, AND SHOWER ACCESSORIES. INSTALL PER MFPY'S RECOMMENDATIONS FOR FULL ADA COMPLIANCE.

09.26.23 ADDENDUM NO.1
09.14.23 FOR BID
08.25.23 FOR PERMIT

HALLEL BUILDING GYMNASIUM ALTERATION
175 ROUTE 340 SPARKILL, NY 10976

arcari iovino
REGISTERED ARCHITECTS
ARCHITECTS PC
ONE KATHERINE STREET
LITTLE FERRY, NJ 07643
201 641 0650 FAX 201 641 0626
WWW.AJARCHS.COM


EDWARD ARCARI NYR020765 ANTHONY IOVINO NYR023349

Omdex Incorporated Consulting Engineers
21 Cross Avenue
Midland Park, NJ 07432-1811
(201) 444-0753 FAX (201) 444-0839


ENLARGED PLANS

SCALE: AS NOTED
DATE: 08.25.2023
FILE: 2260CurrentA.7 Enlarged Plans
©2023 arcari & iovino ARCHITECTS PC


A.7

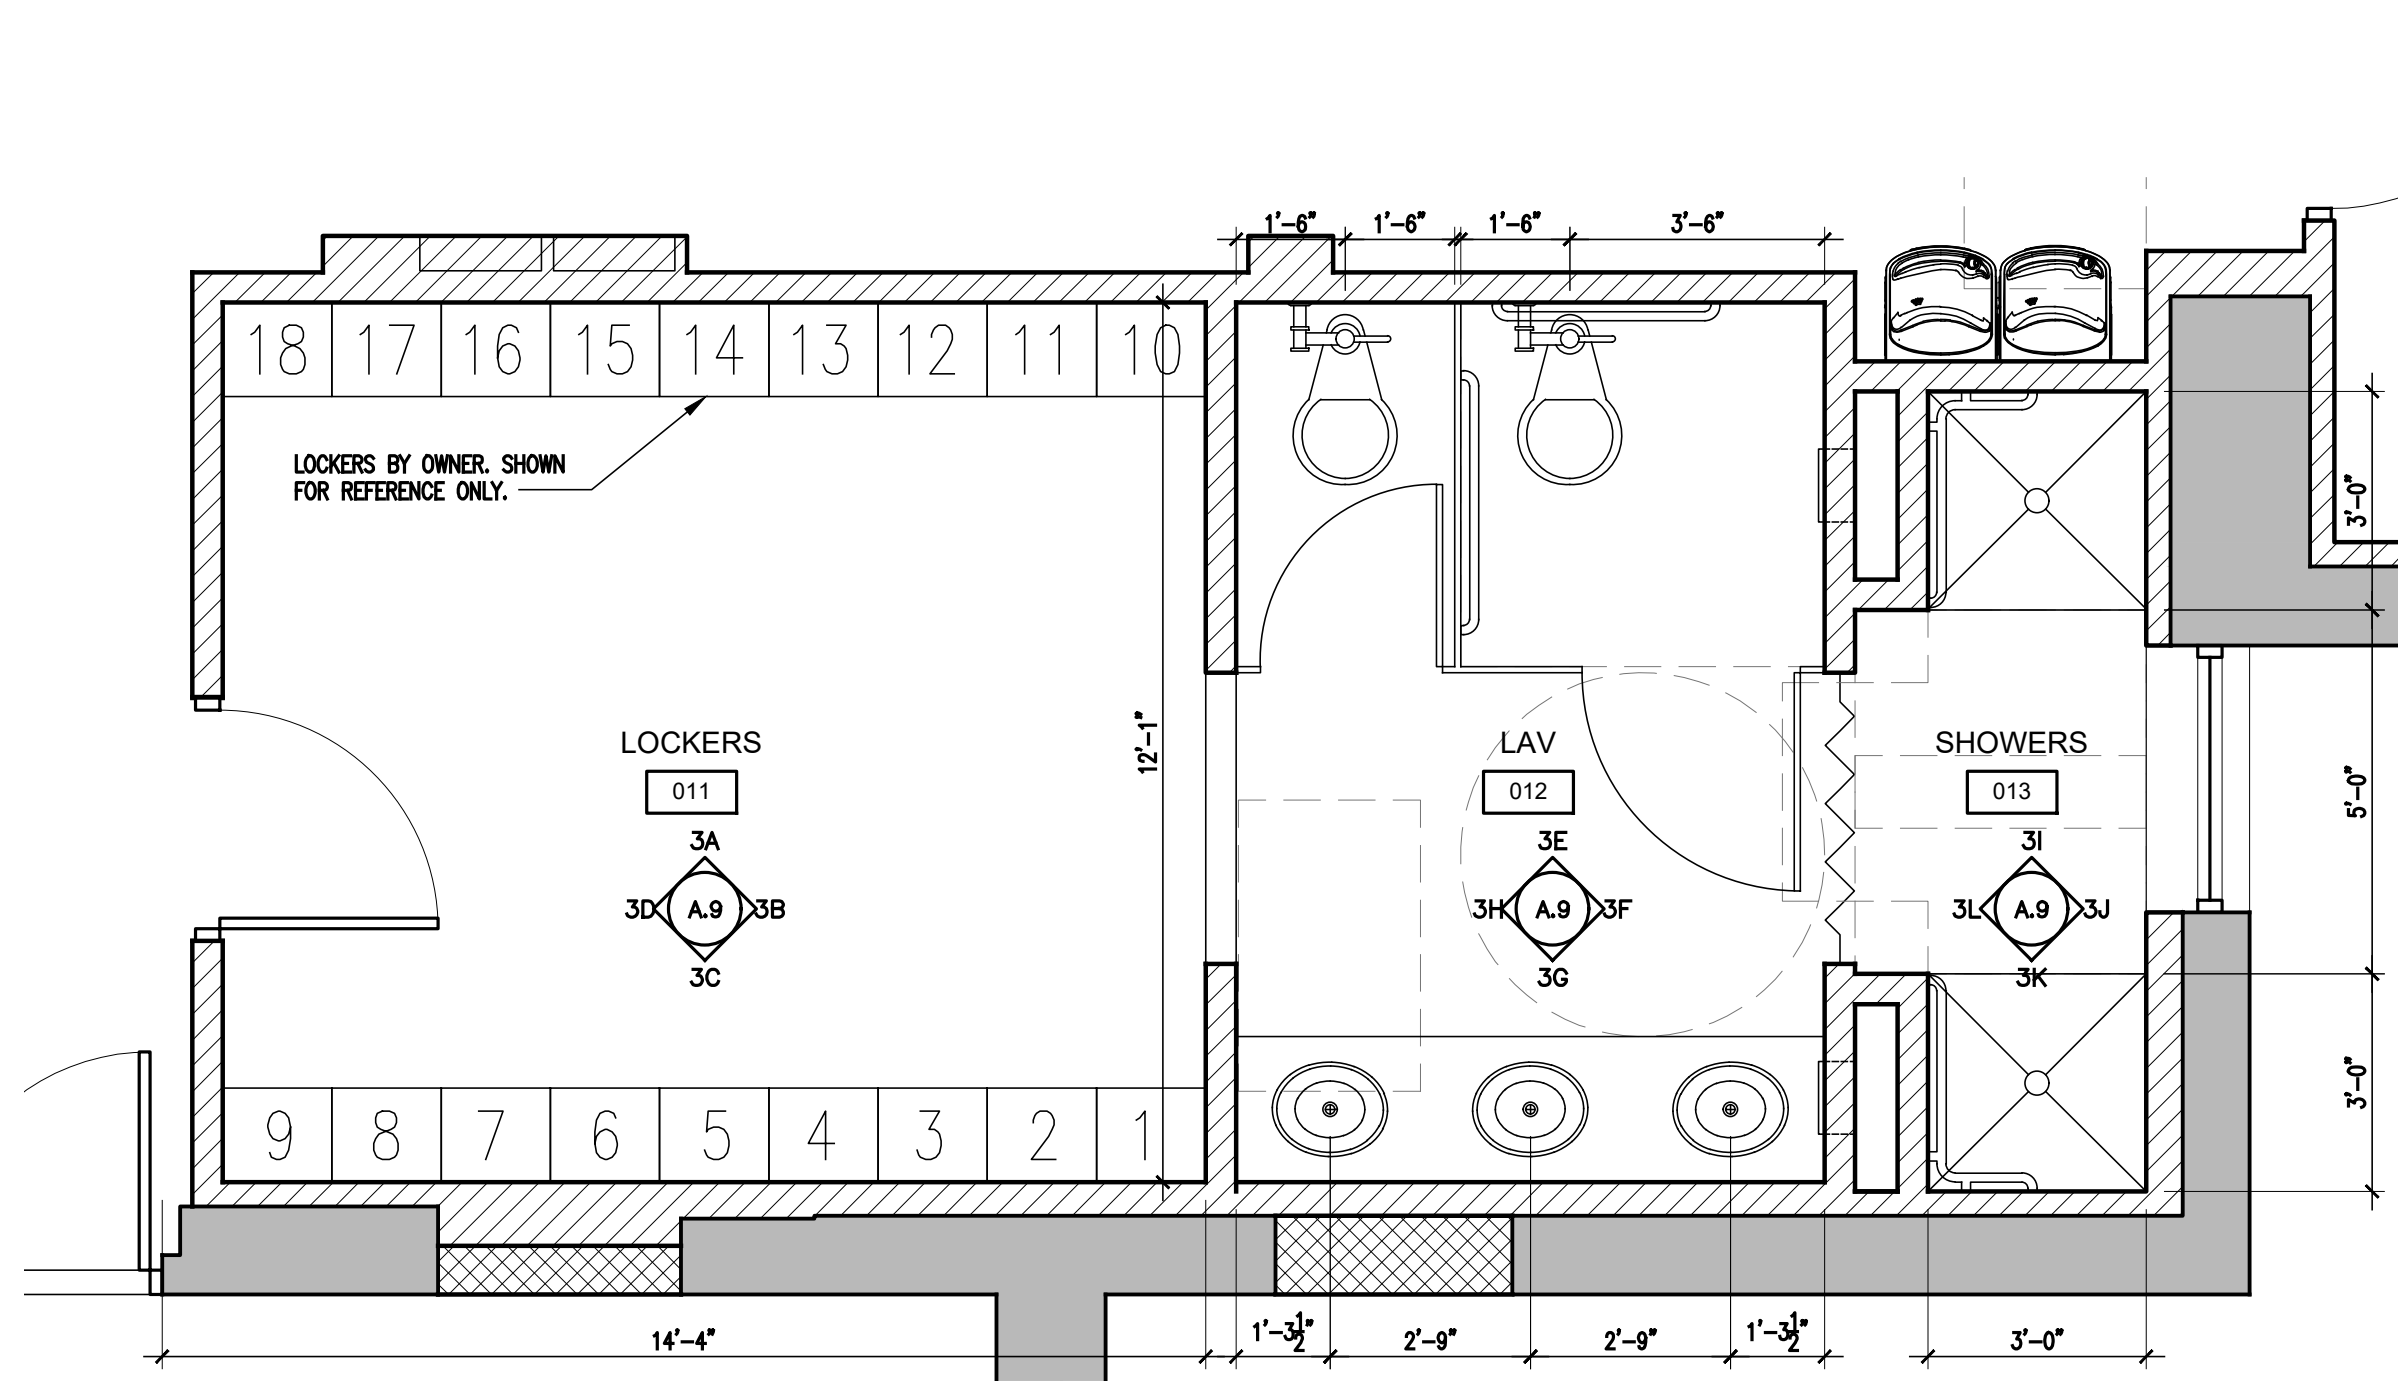


1 LOCKERS 011 ENLARGED PLAN
3/8" = 1'-0"

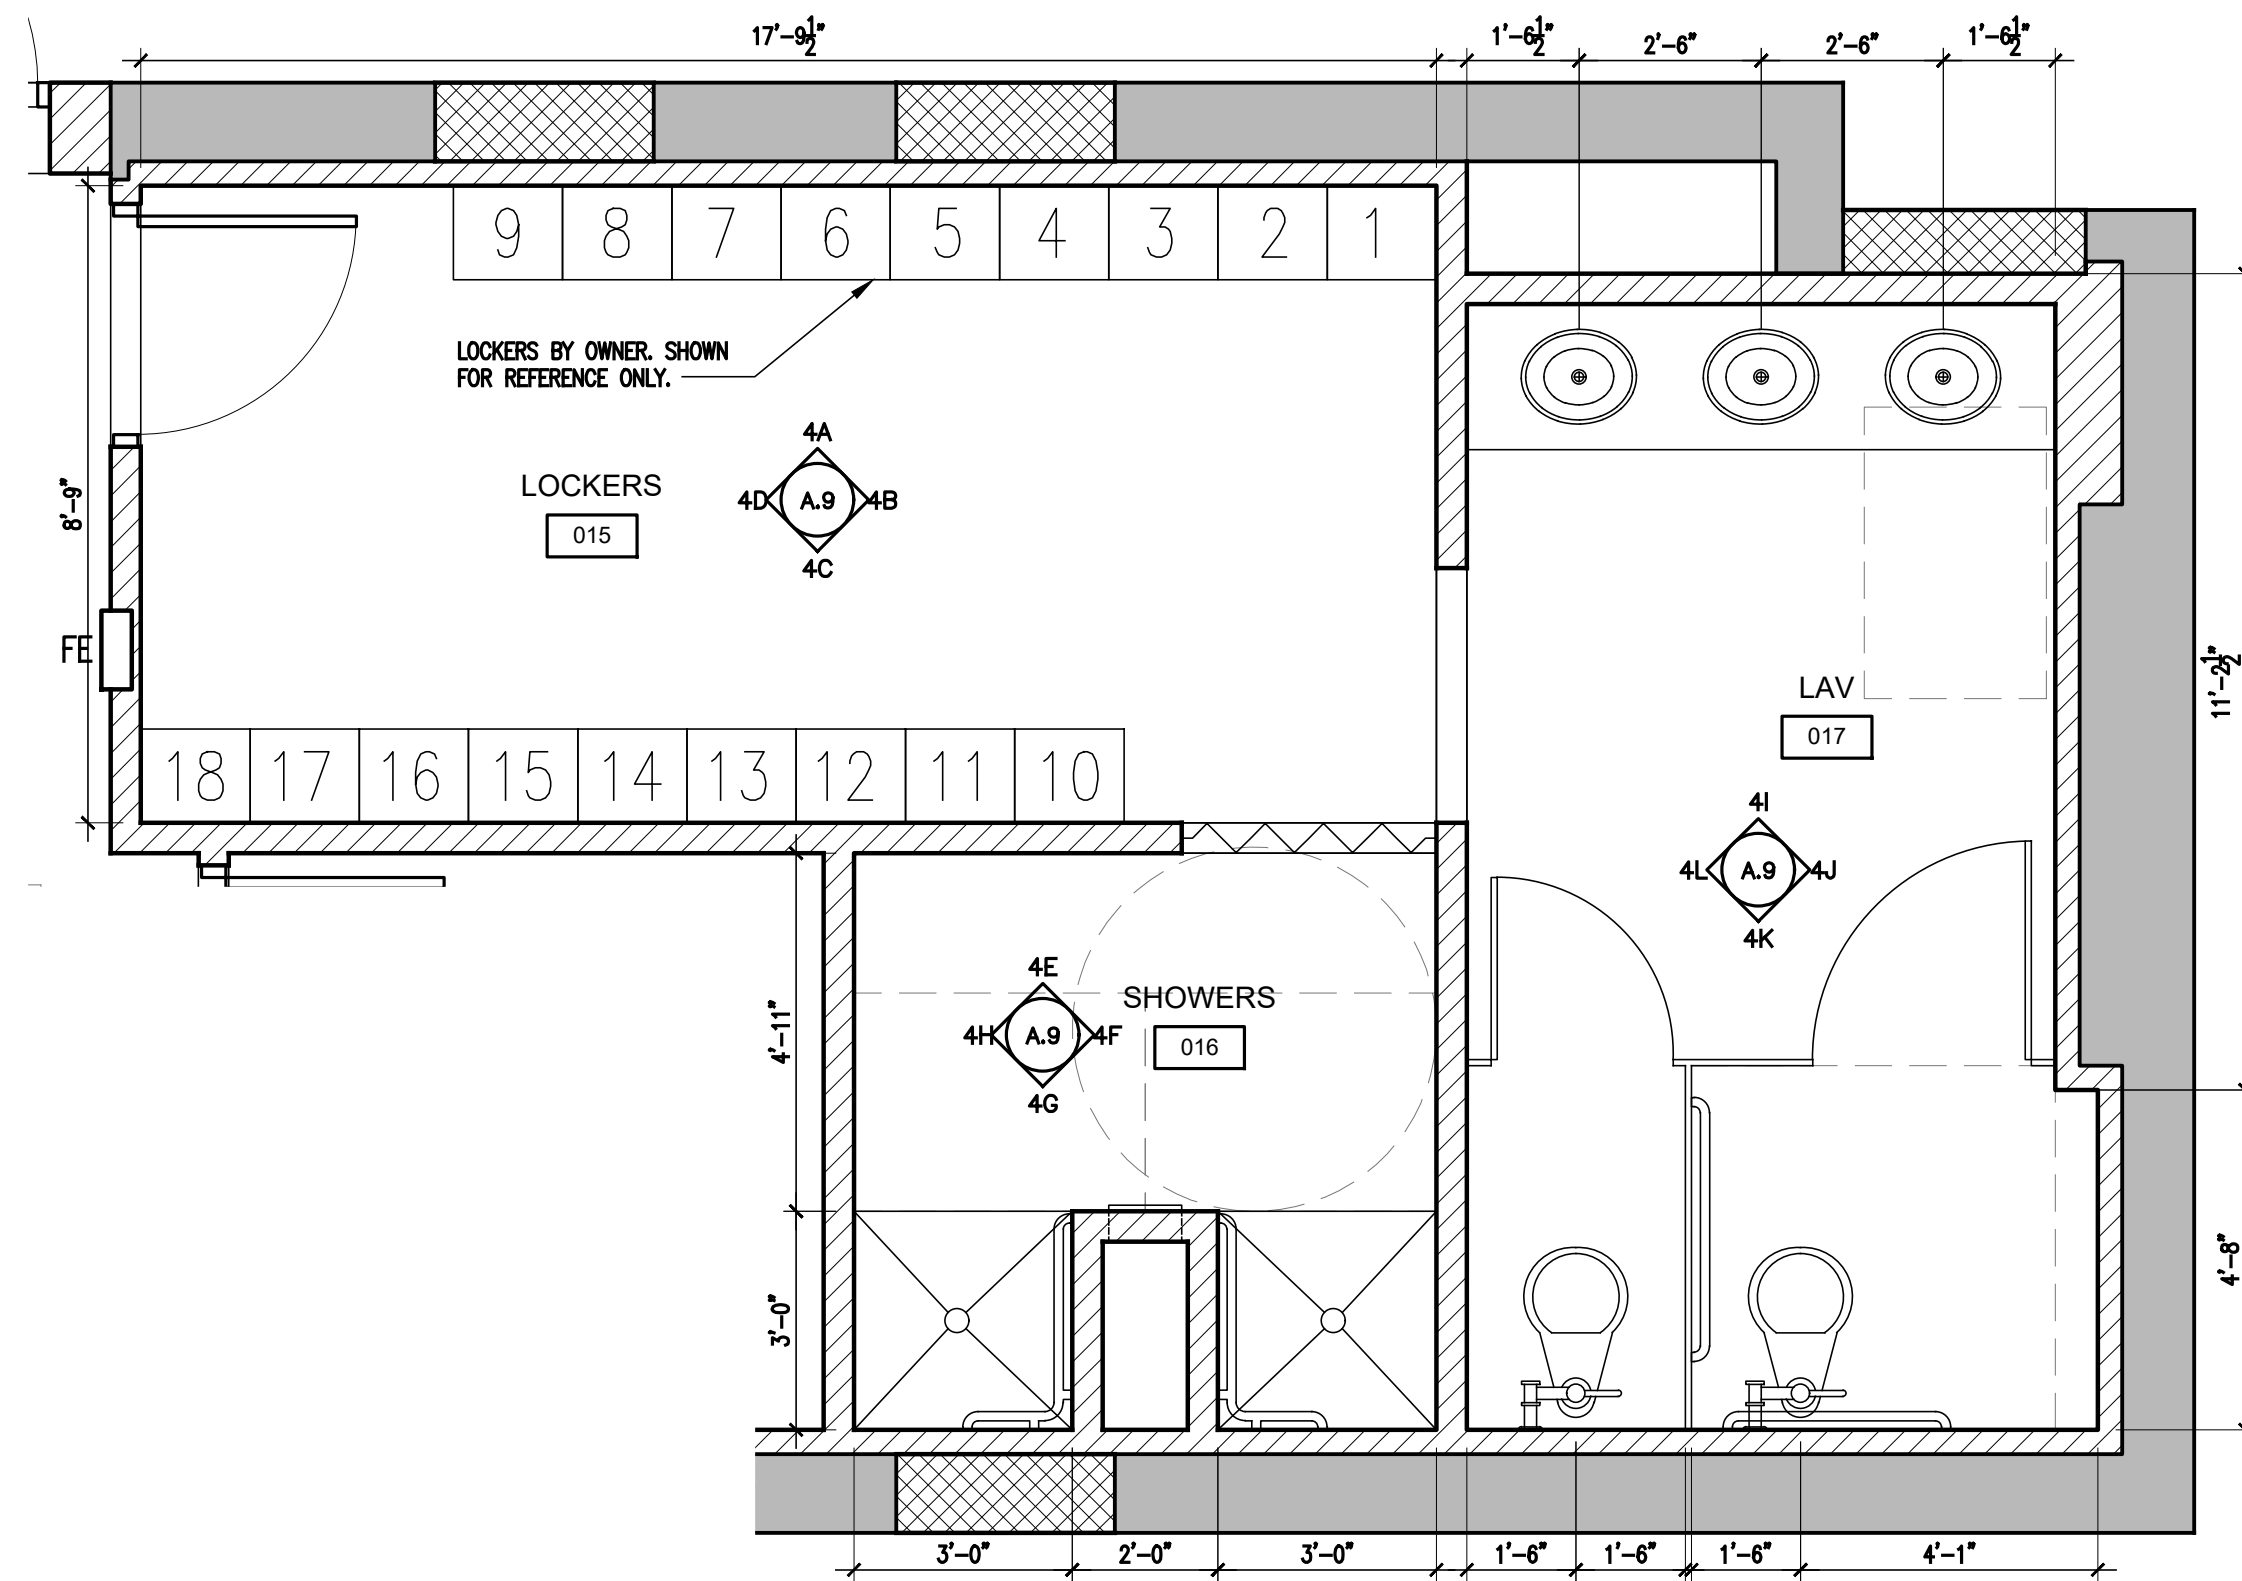


2 LOCKERS 015 ENLARGED PLAN
3/8" = 1'-0"

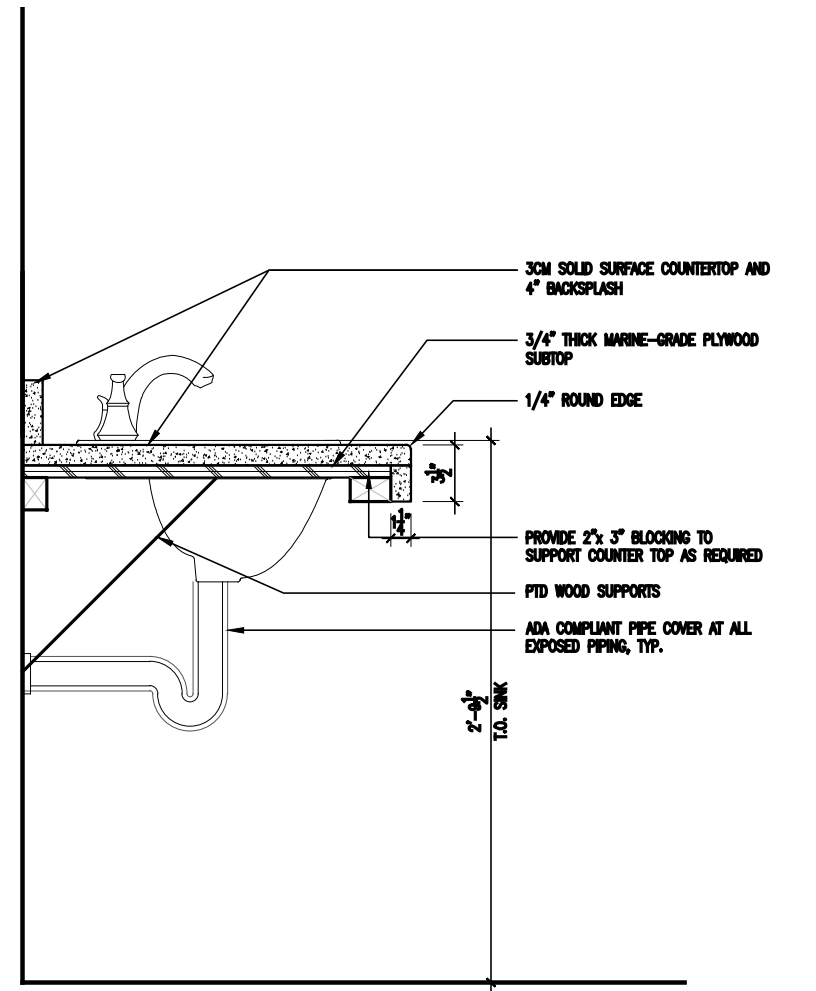

5 TYPICAL SECTION AT SINK COUNTER
1" = 1'-0"

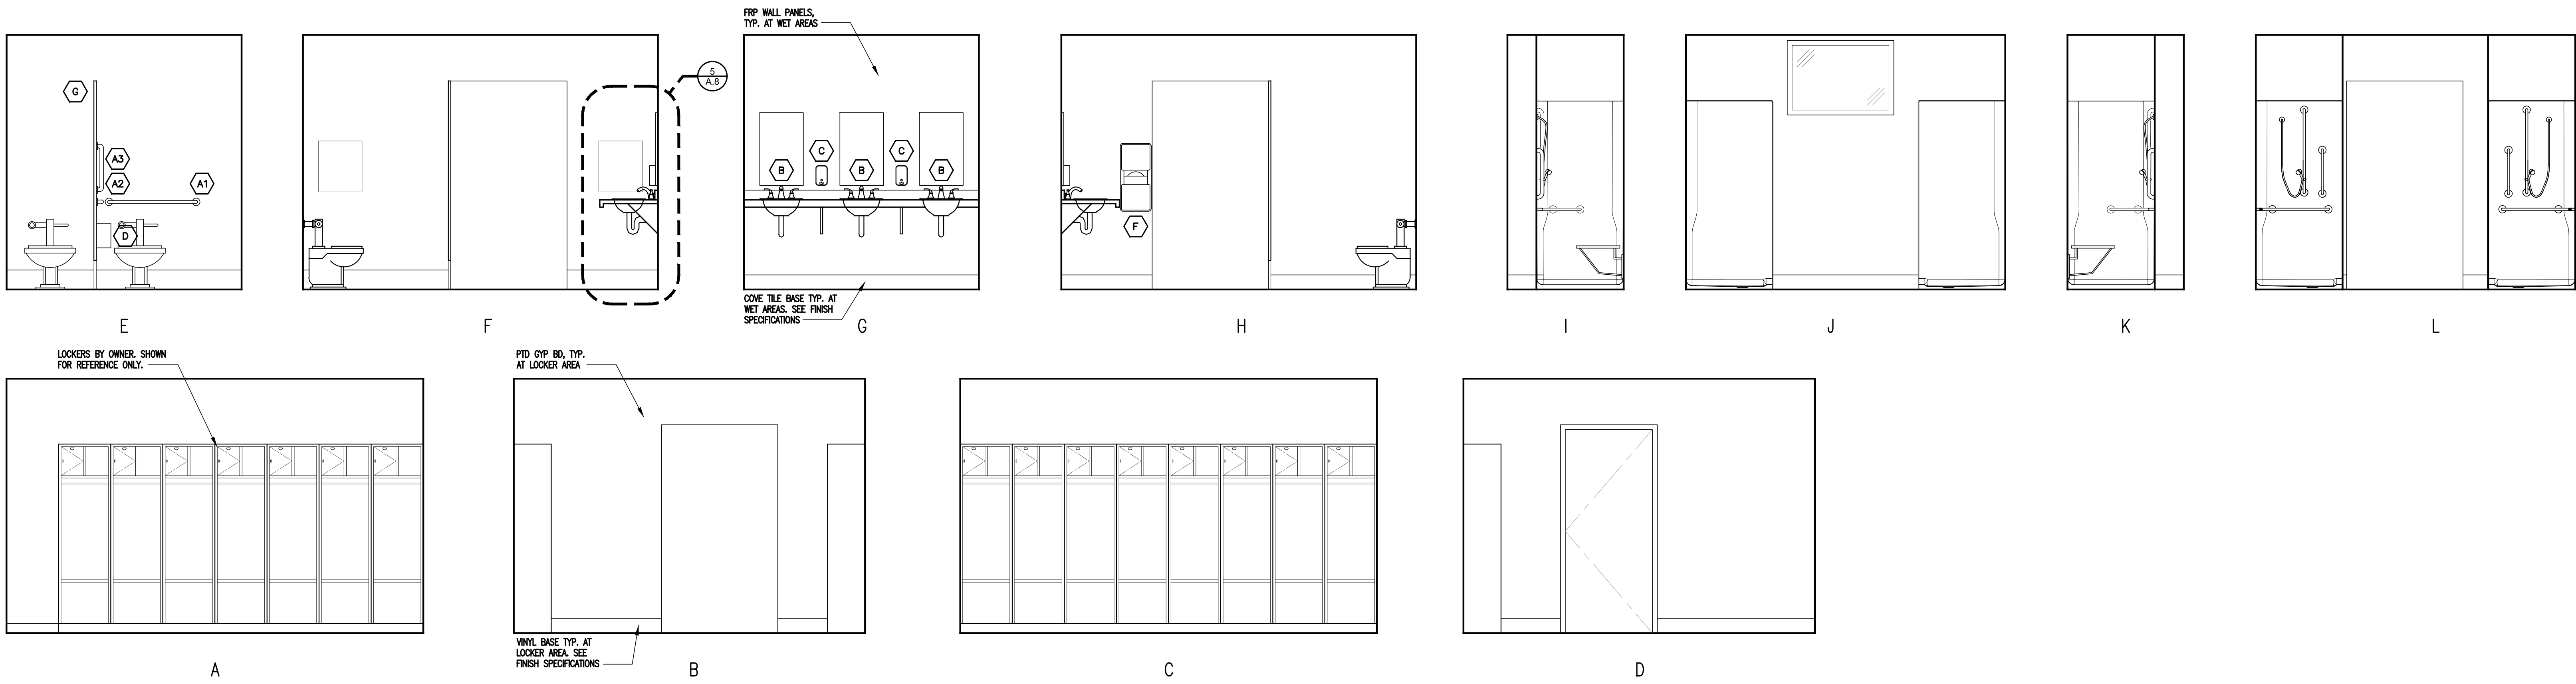

3 LOCKERS 011 ELEVATIONS
3/8" = 1'-0"

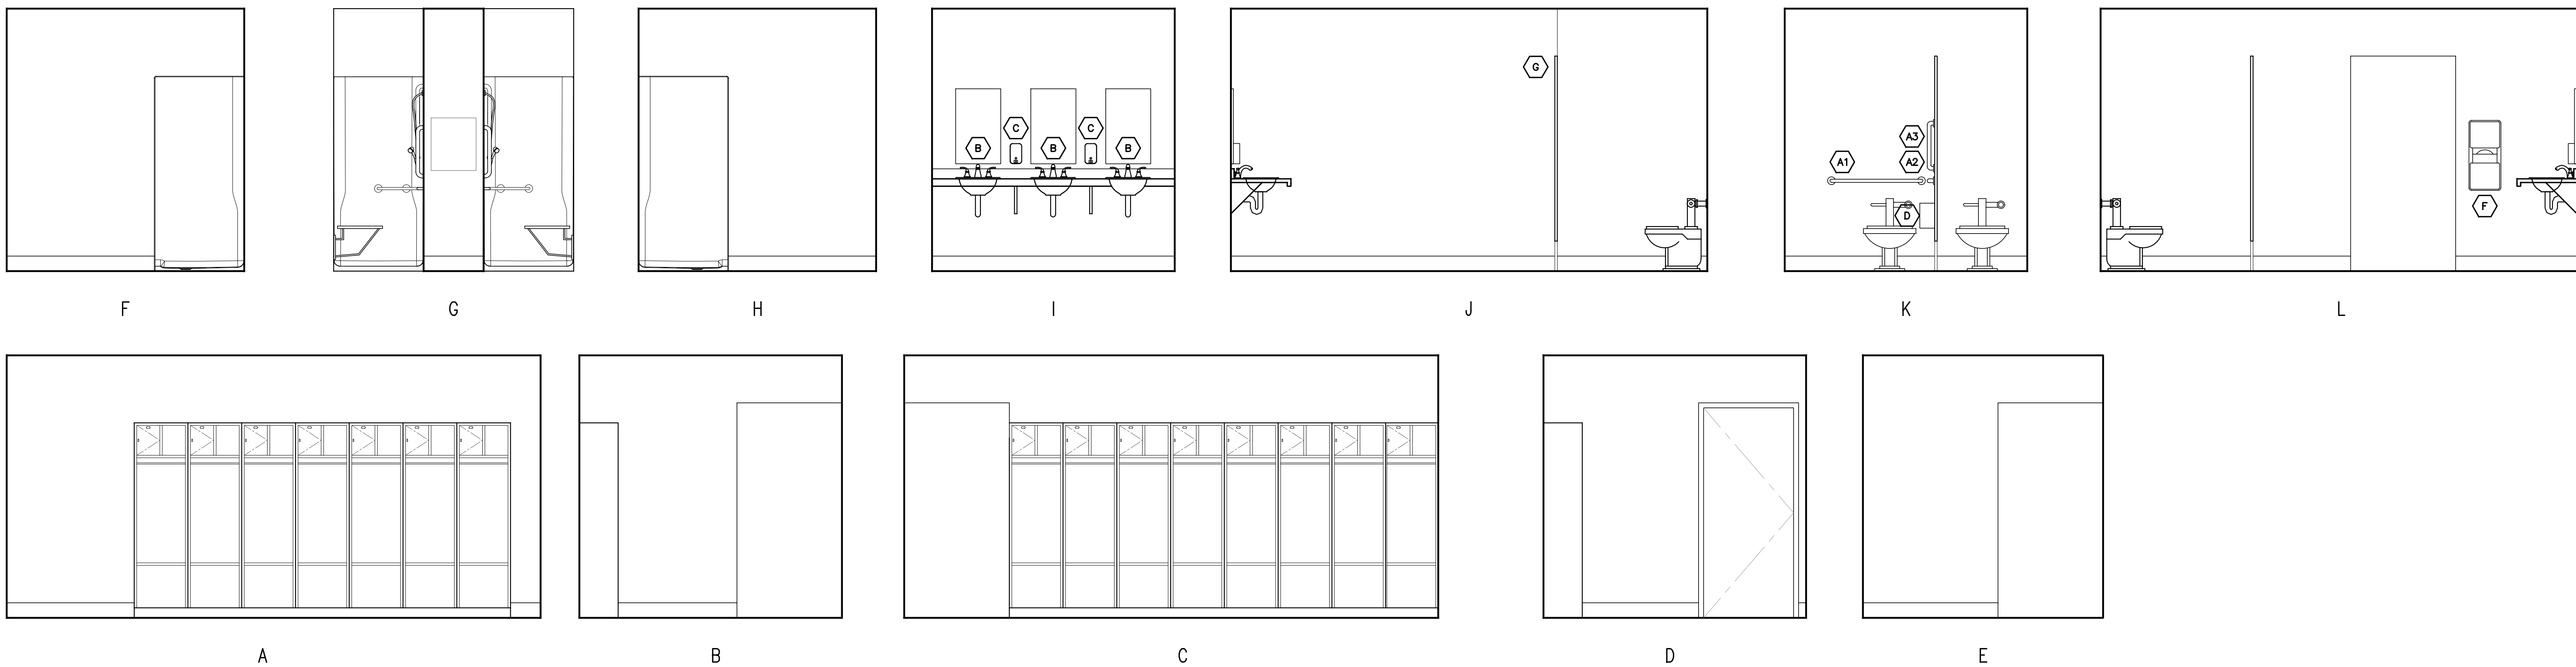

4 LOCKERS 015 ELEVATIONS
3/8" = 1'-0"

09.26.23 ADDENDUM NO.1
09.14.23 FOR BID
08.25.23 FOR PERMIT

HALLEL BUILDING
GYMNASIUM ALTERATION

175 ROUTE 340 SPARKILL, NY 10976

arcari iovino
ARCHITECTS PC
ONE KATHERINE STREET
LITTLE FERRY, NJ 07643
201 641 0650 FAX 201 641 0626
WWW.AIARCHS.COM

EDWARD ARCARI NYR020765 ANTHONY IOVINO NYR023349

Omdex Incorporated
Consulting Engineers
21 Cross Avenue
Midland Park, NJ 07432-1811
(201) 444-0753 FAX (201) 444-0839

ENLARGED PLANS

SCALE: AS NOTED

DATE: 08.25.2023


FILE: 2260CurrentA.7 Enlarged Plans

©2023 arcari & iovino ARCHITECTS PC

A.8

DOOR SCHEDULE																																						
LOCATION			DOOR										FRAME				DETAILS			FIRE RATING	HARDWARE											REMARKS		NO.				
NO.	FROM	TO	EXTERIOR	INTERIOR	SINGLE	PAIR	SWING	TYPE	DOOR MATL	DOOR THK	WIDTH (LEAF)	HEIGHT (LEAF)	TYPE	MAT'L	WALL MAT'L	DEPTH	HEAD	JAMB	SILL		LOCK FUNCTION	HINGES	LOCKSET	TEXT DEVICE	CLOSER	PULL/PUSH	FLUSH BOLTS	ASTRAGALS	WEATHERSTRIP	THRESHOLD	KICK PLATE	SILENCERS	DOOR STOP		COAT HOOK	COORDINATE FRAME AND DOOR SIZES WITH PLANS.		
001A	001	EXT	○	○	○	○	○	RH/LH	C	HM	1-3/4"	3'-0"	7'-0"	S1	AL	MAS	4 1/2"	SEE S1	6A	—	—	A	B	A	C	A	—	—	—	—	—	—	—	—	—	001A		
001B	001	002	—	○	○	○	○	RHR/LHR	D	HM	1-3/4"	3'-0"	7'-0"	S2	AL	GYP	4 1/2"	SEE S2	6A	—	—	E	B	A	C	A	—	—	—	—	—	—	—	—	—	001B		
003A	002	003	—	—	○	○	—	LH	A	HM	1-3/4"	3'-0"	7'-0"	A	HM	GYP	5 3/4"	4A	5A	6C	—	—	B	A	A	—	B	—	—	—	—	—	—	—	—	003A		
004A	002	004	—	—	○	○	—	RH	A	HM	1-3/4"	3'-0"	7'-0"	A	HM	GYP	5 3/4"	4A	5A	6C	—	—	B	A	A	—	B	—	—	—	—	—	—	—	—	004A		
005A	002	005	—	—	○	○	—	LHR	D	HM	1-3/4"	3'-0"	7'-0"	S3	AL	GYP	4 1/2"	SEE S3	—	—	—	A	B	A	—	A	—	—	—	—	—	—	—	—	—	PROVIDE HOLD-OPEN OPTION	005A	
005B	005	EXT	○	○	○	○	—	LH	A	HM	1-3/4"	3'-0"	7'-0"	A	HM	MAS	5 3/4"	4C	5C	6A	—	—	A	C	A	—	A	—	—	—	—	—	—	—	—	005B		
006A	019	006	—	—	○	○	—	RHR	A	HM	1-3/4"	3'-0"	7'-0"	A	HM	GYP	5 3/4"	4A	5A	—	—	C	A	A	—	—	—	—	—	—	—	—	—	A	B	—	006A	
007A	005	007	—	—	○	○	—	LH	A	HM	1-3/4"	3'-0"	7'-0"	A	HM	GYP	5 3/4"	4A	5A	—	—	A	A	A	—	B	—	—	—	—	—	—	A	A	A	—	007A	
008A	007	008	—	—	○	○	—	RH	A	HM	1-3/4"	3'-0"	7'-0"	A	HM	GYP	5 3/4"	4A	5A	6C	—	—	D	A	A	—	—	—	—	—	—	—	A	A	A	—	008A	
009A	005	009	—	—	○	○	—	RH	B	HM	1-3/4"	3'-0"	7'-0"	A	HM	GYP	5 3/4"	4A	5A	6B	—	—	B	A	A	—	B	—	—	—	—	—	—	A	A	—	PROVIDE HOLD-OPEN OPTION	009A
010A	005	010	—	—	○	○	—	LH	A	HM	1-3/4"	3'-0"	7'-0"	A	HM	GYP	5 3/4"	4A	5A	—	—	—	A	A	A	—	—	—	—	—	—	—	—	A	A	—	010A	
010B	005	010	—	—	○	○	—	RH	A	HM	1-3/4"	3'-0"	7'-0"	A	HM	GYP	5 3/4"	4A	5A	—	—	—	A	A	A	—	—	—	—	—	—	—	—	A	A	—	010B	
011A	005	011	—	—	○	○	—	RH	A	HM	1-3/4"	3'-0"	7'-0"	A	HM	GYP	5 3/4"	4A	5A	—	—	—	B	A	A	—	B	—	—	—	—	—	A	B	—	PROVIDE HOLD-OPEN OPTION	011A	
014A	005	014	—	—	○	○	—	LH	A	HM	1-3/4"	3'-0"	7'-0"	A	HM	GYP	5 3/4"	4A	5A	—	—	—	A	A	A	—	—	—	—	—	—	—	—	A	A	—	014A	
015A	005	015	—	—	○	○	—	LH	A	HM	1-3/4"	3'-0"	7'-0"	A	HM	GYP	5 3/4"	4A	5A	—	—	—	B	A	A	—	B	—	—	—	—	—	—	A	A	—	PROVIDE HOLD-OPEN OPTION	015A
018A	002	018	—	—	○	○	—	RHR/LHR	B	HM	1-3/4"	3'-0"	7'-0"	A	HM	CMU	5 3/4"	4B	5B	6A	—	—	B	A	B	A	—	—	—	—	—	—	A	A	—	PROVIDE HOLD-OPEN OPTION	018A	
018B	005	018	—	—	○	○	—	LHR	B	HM	1-3/4"	3'-0"	7'-0"	A	HM	CMU	5 3/4"	4B	5B	6A	—	—	B	A	A	—	A	—	—	—	—	—	A	A	—	PROVIDE HOLD-OPEN OPTION	018B	
018C	018	EXT	○	—	—	—	—	○ RH/LH	A	HM	1-3/4"	3'-0"	7'-0"	B	HM	MAS	5 3/4"	4D	5C	6A	—	—	A	C	A	B	A	—	A	A	A	—	—	—	—	PROVIDE HOLD-OPEN OPTION	018C	
018D	018	EXT	○	—	—	—	—	○ RH/LH	A	HM	1-3/4"	3'-0"	7'-0"	B	HM	MAS	5 3/4"	4D	5C	6A	—	—	A	C	A	B	A	—	A	A	A	—	—	—	—	PROVIDE HOLD-OPEN OPTION	018D	
018E	018	EXT	○	—	—	—	—	○ RH/LH	A	HM	1-3/4"	3'-0"	7'-0"	B	HM	MAS	5 3/4"	4D	5C	6A	—	—	A	C	A	B	A	—	A	A	A	—	—	—	—	PROVIDE HOLD-OPEN OPTION	018E	
019A	005	019	—	—	○	○	—	LH	A	HM	1-3/4"	3'-0"	7'-0"	A	HM	GYP	5 3/4"	4A	5A	—	—	—	C	A	A	—	—	—	—	—	—	—	—	A	A	—	019A	

1 DOOR SCHEDULE

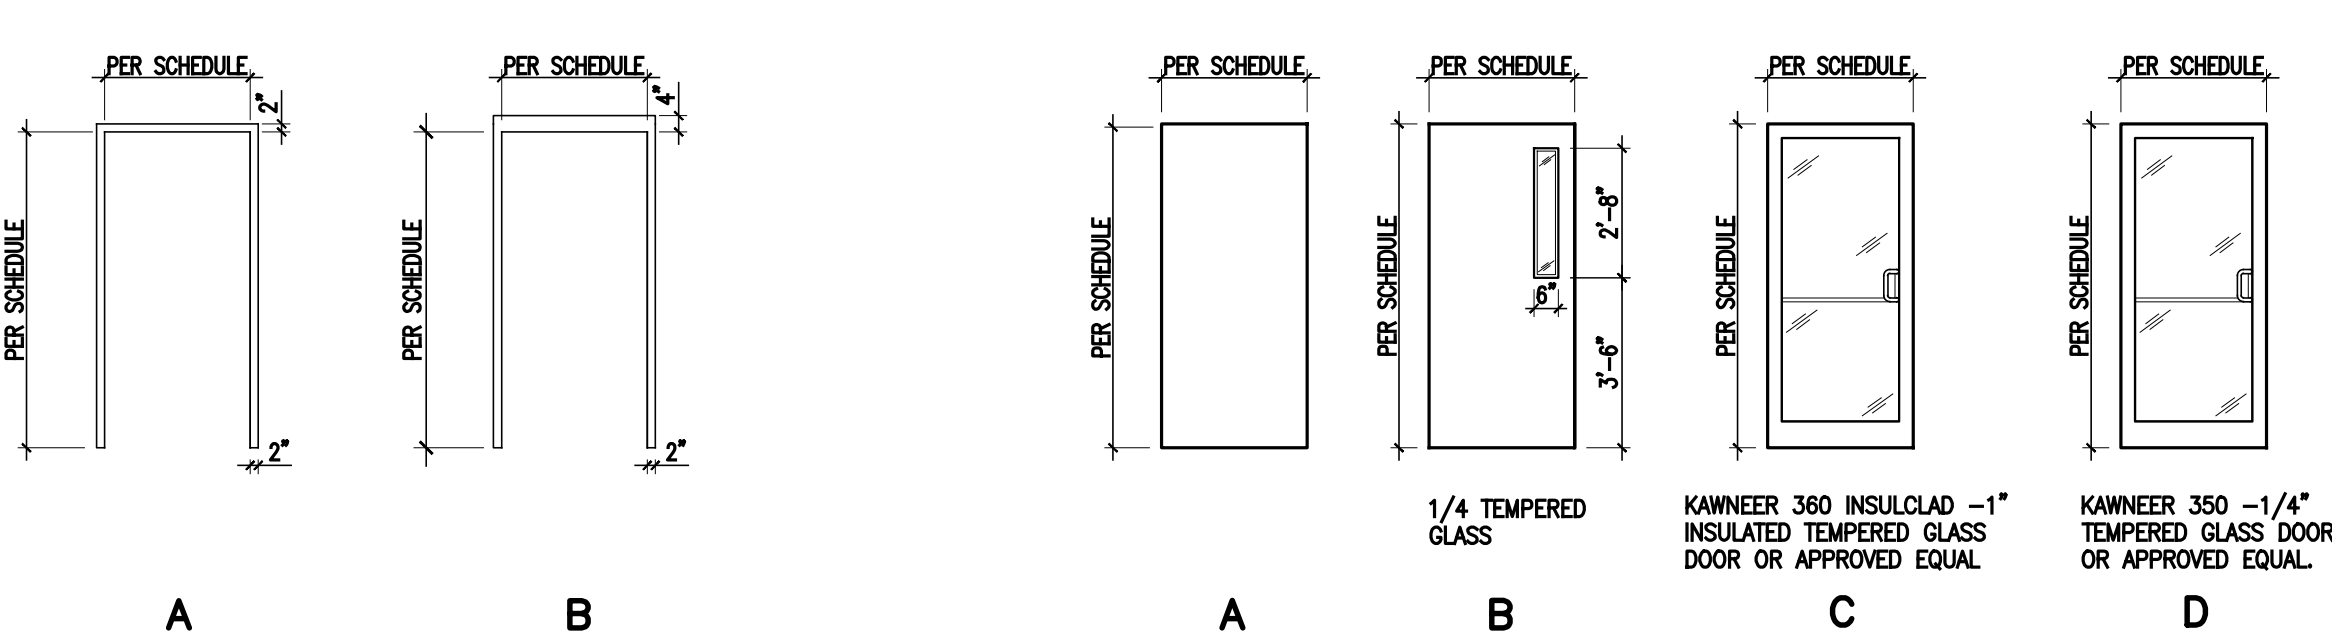

2 DOOR FRAMES

1/4"=1'-0"

3 DOOR TYPES


1/4"=1'-0"

WINDOW SCHEDULE										
NO.	WINDOW TYPE		INTERIOR EXTENSION	GLASS TYPE	WINDOW SIZE (NOM)		JAMB	HEAD	SILL	REMARKS
	WIDTH V.I.F.	HEIGHT V.I.F.			WIDTH V.I.F.	HEIGHT V.I.F.				
W1	DOUBLE HUNG	EXT	GL-1	4'-9"	3'-11 1/4"	9A	9C	9B	EXISTING MASONRY OPENING, V.I.F.	W1
W2	AWNING	EXT	GL-1	3'-3"	2'-8 3/4"	9A	9C	9B	EXISTING MASONRY OPENING, V.I.F.	W2
W3	AWNING	EXT	GL-1	4'-9"	2'-8 3/4"	9A	9C	9B	EXISTING MASONRY OPENING, V.I.F.	W3
W4	AWNING	EXT	GL-1	4'-3"	2'-8 3/4"	9A	9C	9B	EXISTING MASONRY OPENING, V.I.F.	W4
W5	AWNING	EXT	GL-1	3'-0"	2'-6 3/4"	9A	9C	9B	EXISTING MASONRY OPENING, V.I.F.	W5
W6	AWNING	EXT	GL-1	3'-8"	2'-6 3/4"	9A	9C	9B	EXISTING MASONRY OPENING, V.I.F.	W6
W7	AWNING	EXT	GL-1	5'-10 1/2"	2'-2"	9A	9C	9B	EXISTING MASONRY OPENING, V.I.F.	W7
W8	FIXED	EXT	GL-1	3'-4"	5'-0"	9A	9C	9B	EXISTING MASONRY OPENING, V.I.F.	W8
W9	FIXED	EXT	GL-1	5'-0"	4'-2"	9A	9C	9B	EXISTING MASONRY OPENING, V.I.F.	W9

STOREFRONT SCHEDULE										
NO.	TYPE		INTERIOR EXTENSION	GLASS TYPE	SIZE (NOM)		JAMB	HEAD	SILL	REMARKS
	WIDTH V.I.F.	HEIGHT V.I.F.			WIDTH V.I.F.	HEIGHT V.I.F.				
S1	STOREFRONT	EXT	GL-1	6'-4"	7'-2"	11A	11D	11C		S1
S2	STOREFRONT	INT	GL-2	6'-4"	7'-2"	11B	11E	11C		S2
S3	STOREFRONT	INT	GL-2	3'-4"	7'-2"	11B	11E	11C		S3


7 WINDOW & STOREFRONT SCHEDULE

NTS

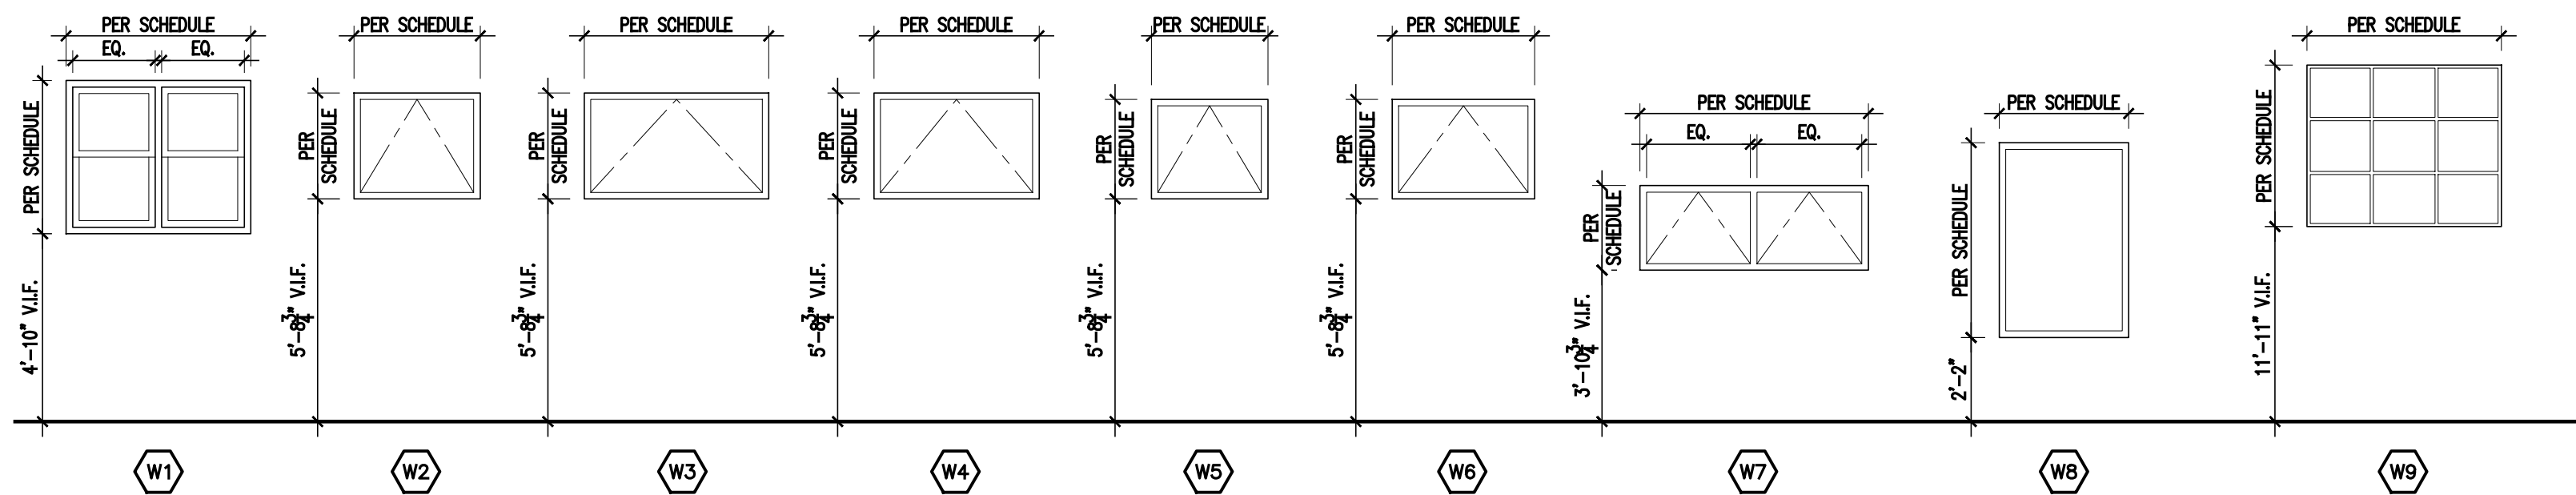


8 WINDOW TYPES

1/4"=1'-0"

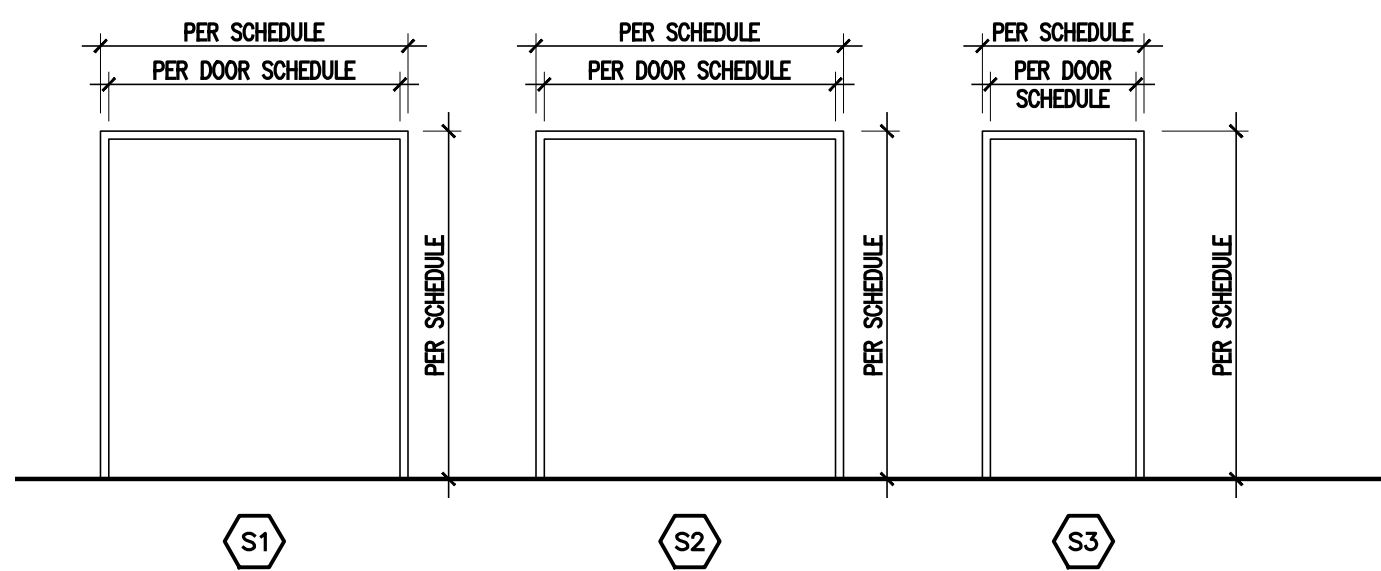





10 STOREFRONT TYPES

1/4"=1'-0"

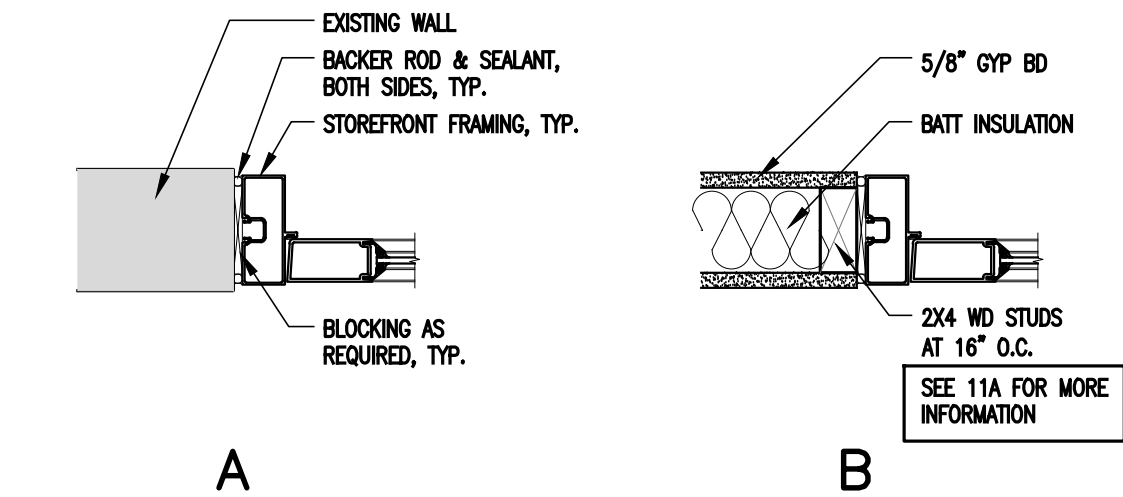



11 STOREFRONT DETAILS

1 1/2"=1'-0"

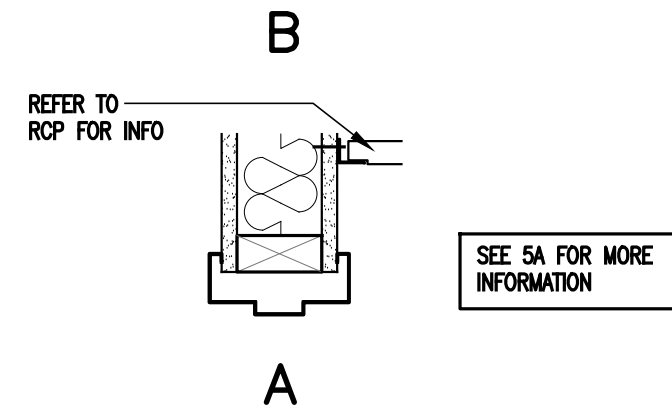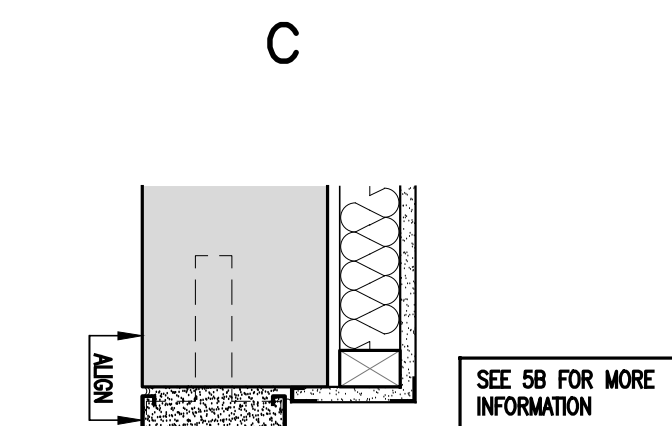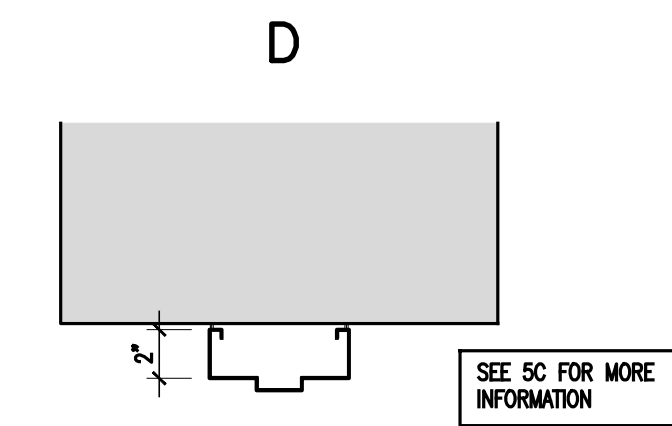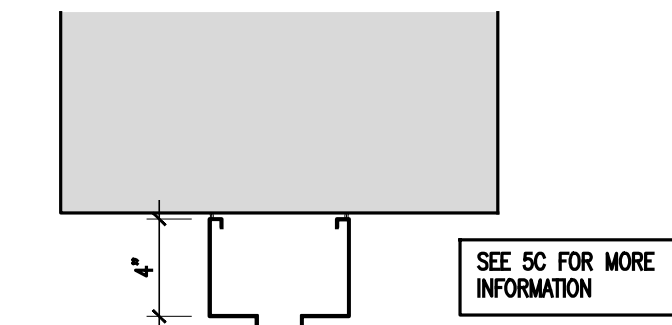




4 DOOR HEAD DETAILS

1 1/2"=1'-0"

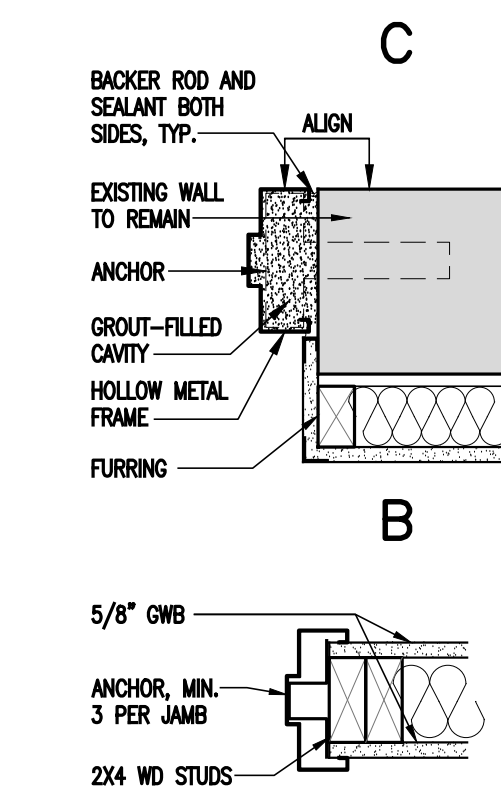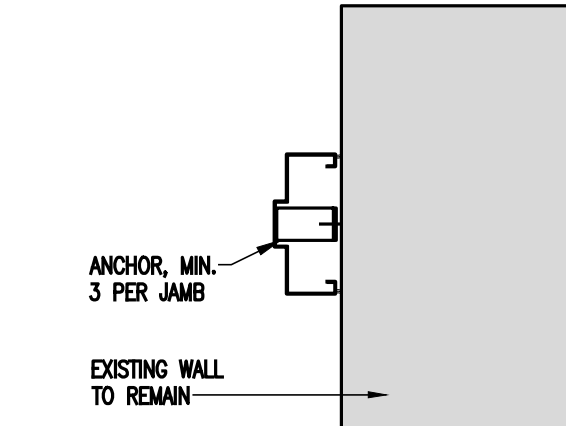




5 DOOR JAMB DETAILS

1 1/2"=1'-0"

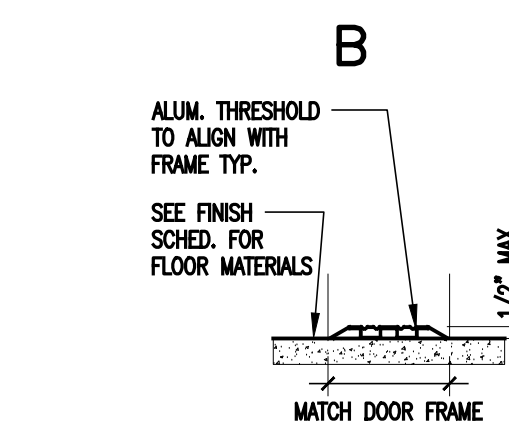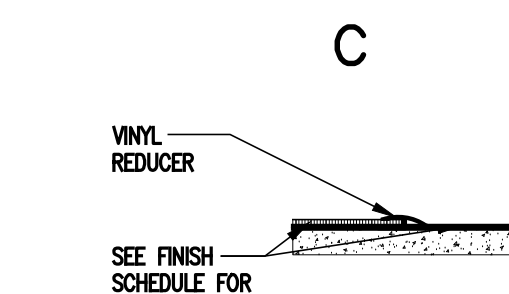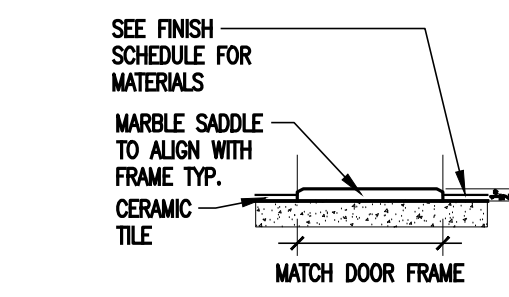



6 SILL DETAILS

1 1/2"=1'-0"

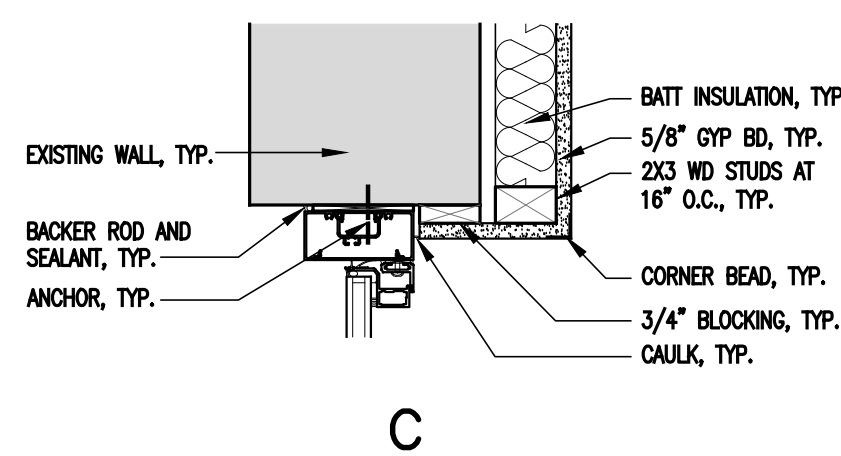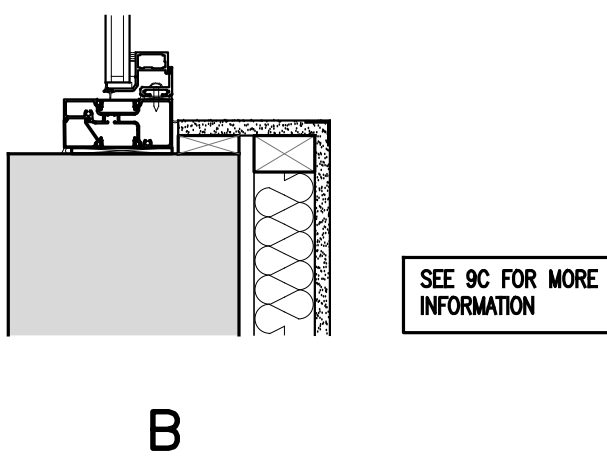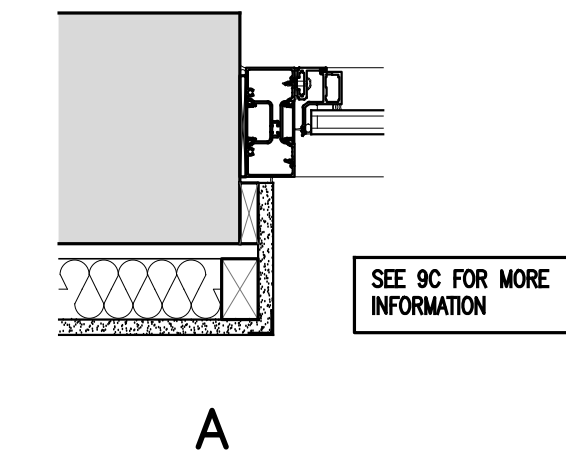

9 WINDOW DETAILS

1 1/2"=1'-0"

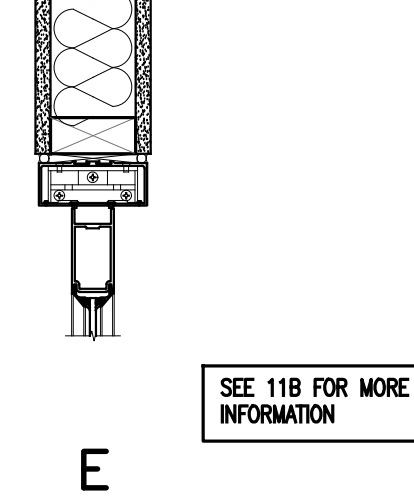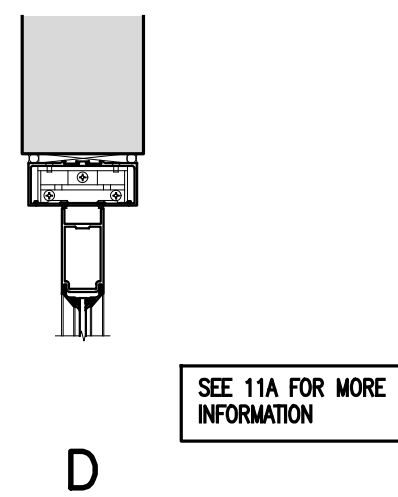

DOOR HARDWARE

LOCK FUNCTION

- A ENTRANCE/OFFICE LOCK
- B CLASSROOM LOCK
- C STOREROOM LOCK
- D PRIVACY LOCK
- E PASSAGE LOCK

HINGES

- A STANDARD WEIGHT BALL BEARING FIVE KNUCKLE FULL MORTISE HINGES. FINISH: US26D. (3) PER LEAF
- B CONTINUOUS GEAR HINGE
- C CONTINUOUS HINGE

BASIS OF DESIGN:
ASSA ABLOY, SARGENT 10 LINE, US26D FINISH

LOCKSET

- A CYLINDER LOCKSET, LEVER

BASIS OF DESIGN:
ASSA ABLOY, SARGENT 351 POWERSLIDE, US26D FINISH

EXIT DEVICE

- A NOT USED
- B SURFACE VERTICAL ROD PANIC HARDWARE WITH LEVER AT EXTERIOR, LESS BOTTOM ROD
- C CONCEALED VERTICAL ROD PANIC HARDWARE WITH LEVER AT EXTERIOR

BASIS OF DESIGN:
ASSA ABLOY, HARROW DESIGN SARGENT 80 SERIES

CLOSER

- A PUSH SIDE PARALLEL ARM CLOSER
- B PULL SIDE CLOSER

BASIS OF DESIGN:
ASSA ABLOY, SARGENT 351 POWERSLIDE, US26D FINISH (PROVIDE 1 PER LEAF)

PULL/PUSH

- A ROCKWOOD BF15747 (PROVIDE 1 PER LEAF)

FLUSH BOLTS

- A ROCKWOOD 555 WITH 570 DUSTPROOF STRIKE

ASTRAGALS

- A PEMKO 303AV ASTRAGALS

- B BY DOOR MANUFACTURER

WEATHERSTRIP

- A PEMKO 34SAP DOOR SWEEP W/ PEMKO 297AS PERIMETER GASKETING

- B DOOR MANUFACTURER

THRESHOLD

- A PEMKO 254X4 AFG 9% THERMALLY BROKEN THRESHOLD

- B BY DOOR MANUFACTURER

KICK PLATE

- A PEMKO 8" HIGH KICK PLATE. FINISH: US26D

SILENCERS

- A ROCKWOOD 608 SILENCERS

DOOR STOP

- A ROCKWOOD 401 DOOR STOP. FINISH: US26D

- B SARGENT 1540S OVERHEAD STOP. FINISH: US26D

COAT HOOK

- A ROCKWOOD RM810. FINISH: US26D

GLASS TYPE

- GL-1: VITRO SOLARBAN72 INSULATED GLASS WITH ARGON FILL
- GL-2: 1/4" FULLY TEMPERED FLOAT GLASS

WINDOW SYSTEM


BASIS OF DESIGN:
KAWNEER TRIFAB VS 451T GLASSVENT
PROJECT-OUT/OUTSWING CASSETT AS INDICATED ON WINDOW SCHEDULE
THERMALLY BROKEN WINDOW OR APPROVED EQUAL WITH INSECT SCREENS

STOREFRONT SYSTEM

BASIS OF DESIGN:
EXTERIOR FRAMING
KAWNEER TRIFAB VS 451T THERMALLY BROKEN FRAMING SYSTEM OR APPROVED EQUAL
INTERIOR FRAMING
KAWNEER TRIFAB VS 450 NON THERMALLY BROKEN FRAMING SYSTEM OR APPROVED EQUAL

09.26.23 ADDENDUM NO.1
09.14.23 FOR BID
08.25.23 FOR PERMIT

HALLEL BUILDING GYMNASIUM ALTERATION

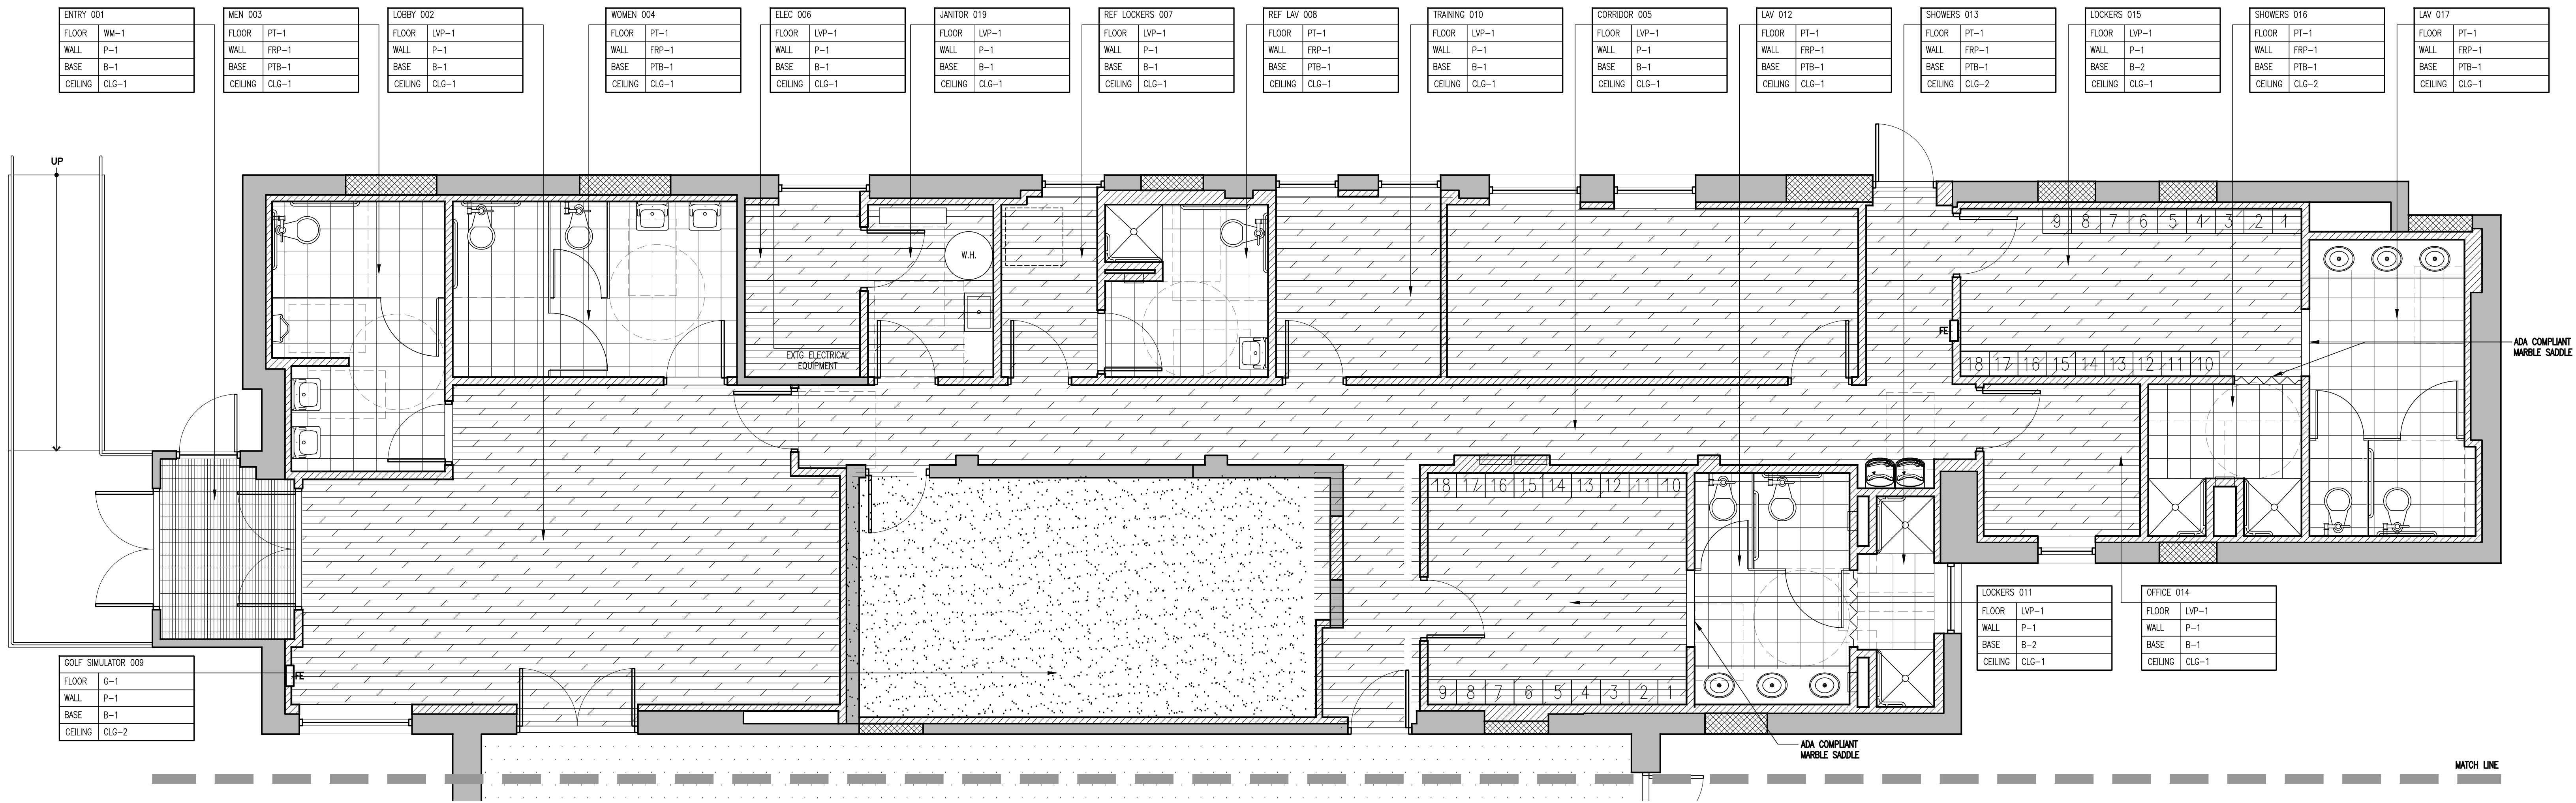

1 PARTIAL FINISH PLAN

1/4" = 1'-0"



FLOOR FINISHES

PORCELAIN TILE:

PT-1	PORCELAIN TILE CROSSVILLE COLORBLOX 2.0 SIZE: 12"x12" COLOR: TBD GROUT: TBD
------	---

LUXURY VINYL PLANK:

LVP-1	LUXURY VINYL PLANK MANNINGTON SPACIA SERIES WOOD LUXURY VINYL PLANK WITH MICRO-BEVEL EDGE, GLUE DOWN SIZE: 6"x48" COLOR: TBD
-------	---

WALK-OFF MAT

WM-1	WALK OFF MAT MATINC AMARCO ARENA TILE COLOR: TBD THICKNESS: 1/2"
------	--

GOLF GREEN

G-1	GOLF GREEN SYNLAWN PRECISION PUTT MAT
-----	---

WALL FINISHES

WALL BASE:

B-1 VINYL BASE	JOHNSONITE TRADITIONAL VINYL BASE 4" COVE STYLE COLOR: TBD
----------------	--

B-2 VINYL BASE	JOHNSONITE TRADITIONAL VINYL BASE 6" COVE STYLE COLOR: TBD
----------------	--

PTB-1	PORCELAIN CERAMIC TILE BASE CROSSVILLE COLORBLOX 2.0 SIZE: 6"x12" COLOR: TBD
-------	---

FRP:

FRP-1	FRP MARLITE STANDARD FRP, SMOOTH COLOR: TBD
-------	---

PAINT:

P-1	GENERAL BENJAMIN MOORE COLOR: TBD FINISH: TBD
-----	--

P-2	DOORS & WINDOW FRAMES BENJAMIN MOORE COLOR: TBD FINISH: TBD
-----	--

CEILING FINISHES

GENERAL ACOUSTIC CLG TILE:

CLG-1	STYLE: ARMSTRONG ULTIMA HIGH NRG COLOR: WHITE SIZE: 24" X 24" X 7/8" GRID: 1/8" PRELUDE EXPOSED TEE GRID COLOR: BLIZZARD WHITE
-------	--

PAINTED GYP BOARD:

CLG-2	GENERAL BENJAMIN MOORE COLOR: TBD FINISH: TBD
-------	--

NOTE: ENTIRE FLOOR TO RECEIVE GYPCRETE
LEVELLING. GYPCRETE TO STOP BEFORE FLOOR
TRANSITIONS AT GYM AND EXTERIOR DOORS TO
ALLOW FOR SLOPED TRANSITION AT THE TIME
OF FLOORING INSTALLATION. ALLOW FOR 1"
THICK GYPCRETE IN BASE BID.

2 FINISH SPECIFICATIONS

NTS

FLOOR:	BY OWNER
STRIPING:	BY OWNER
WALLS:	
UPPER:	BENJAMIN MOORE COLOR: TBD FINISH: TBD
LOWER:	BENJAMIN MOORE COLOR: STAC RED
ACCENT STRIPE:	BENJAMIN MOORE COLOR: STAC GOLD

3 GYM FINISHES

NTS

09.26.23 ADDENDUM NO.1

09.14.23 FOR BID
08.25.23 FOR PERMIT

HALLEL BUILDING
GYMNASIUM ALTERATION

175 ROUTE 340SPARKILL, NY 10976

arcari iovino

ARCHITECTS PC

REGISTERED ARCHITECT
ANTHONY IOVINO
STATE OF NEW YORK
020765

ONE KATHERINE STREET
LITTLE FERRY, NJ 07643
201 641 0650 FAX 201 641 0626
WWW.AIARCHS.COM

EDWARD ARCARI NYR020765ANTHONY IOVINO NYR023349

Omdex Incorporated
Consulting Engineers

21 Cross Avenue
Midland Park, NJ 07432-1811
(201) 444-0753 FAX (201) 444-0839

PARTIAL FINISH PLAN
AND SPECIFICATIONS

SCALE: AS NOTED
DATE: 08.25.2023
FILE: 2260/Current/A.10 Finishes

©2023 arcari & iovino ARCHITECTS PC

A.10


1) CONTRACTOR TO COORDINATE THE EXACT ROOM NAME AND ROOM NUMBER TO BE PLACED ON EACH SIGN PRIOR TO FABRICATION

BEST SIGNAGE SYSTEMS HC 300 ADA SYSTEM WITH TACTILE CHARACTERS/SYMBOLS AND GRADE 2 BRAILLE. RESTROOM SIGNS ARE TO BE 6"X 8" AND ROOM SIGNS TO BE 8" X 6". PROVIDE 1/2" RADIUS CORNER AND MOUNT AS REQUIRED FOR ADA COMPLIANCE. VERIFY ALL ROOM DESIGNATIONS LISTED IN SCHEDULE PRIOR TO FABRICATION. NO ROOM NUMBERS WILL BE INCLUDED ON SIGNS.

EACH AREA OF REFUGE, PROVIDE SIGNAGE TO MEET REQUIREMENTS OF IBC SECTION 1007.6.4. SIGNS TO BE MOUNTED IN COMPLIANCE WITH ADA REQUIREMENTS.



2 ROOM SCHEDULE

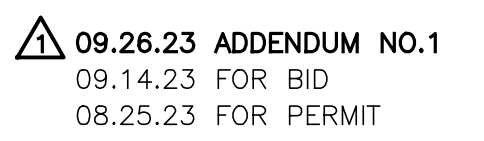

175 ROUTE 340 SPARKILL, NY 10976



21 Cross Avenue
Midland Park, NJ 07432-1811
(201) 444-0753 FAX (201) 444-0839

SCALE: AS NOTED

DATE: 08.25.2023

FILE: 2260\Current\A.11 Signage

©2023 **arcari & iovino** ARCHITECTS PC

A.11