

TOWN OF BLOOMING GROVE

LASSER PARK SENIOR CENTER CONTRACT 2: ENTRY PORCH, DECK, AND SITEWORK

AUGUST 2023

DRAWING LIST

DRAWING NO. DRAWING TITLE

GENERAL

- COVER SHEET
G1 SYMBOLS AND ABBREVIATIONS

CIVIL

C1 SITE PLAN
C2 EROSION AND SEDIMENT CONTROL PLAN
C3 DETAIL I
C4 DETAIL II
C5 EROSION AND SEDIMENT CONTROL DETAILS

ARCHITECTURAL / STRUCTURAL

A01 CODE ANALYSIS
A1 CONSTRUCTION PLAN
A2 FOUNDATION PLAN
A3 EXTERIOR ELEVATIONS
A4 SECTIONS AND DETAILS
A5 SECTIONS AND DETAILS
A6 SECTIONS AND DETAILS
A7 SECTIONS AND DETAILS
A8 FOUNDATION DETAILS
A9 SECTIONS AND DETAILS

MECHANICAL


M1 FLOOR PLAN - BASEMENT

ELECTRICAL

E1 SITE PLAN
E2 FIRST FLOOR POWER AND LIGHTING PLAN
E3 BASEMENT POWER PLAN
E4 BASEMENT LIGHTING PLAN
E5 PANELBOARD SCHEDULES AND SINGLE LINE DIAGRAM
E6 WIRING DIAGRAMS AND DETAILS

PLUMBING

P1 PLUMBING PLAN - FIRST FLOOR
P2 PLUMBING PLAN - SECOND FLOOR
P3 RISERS
P4 DETAILS
P5 DETAILS

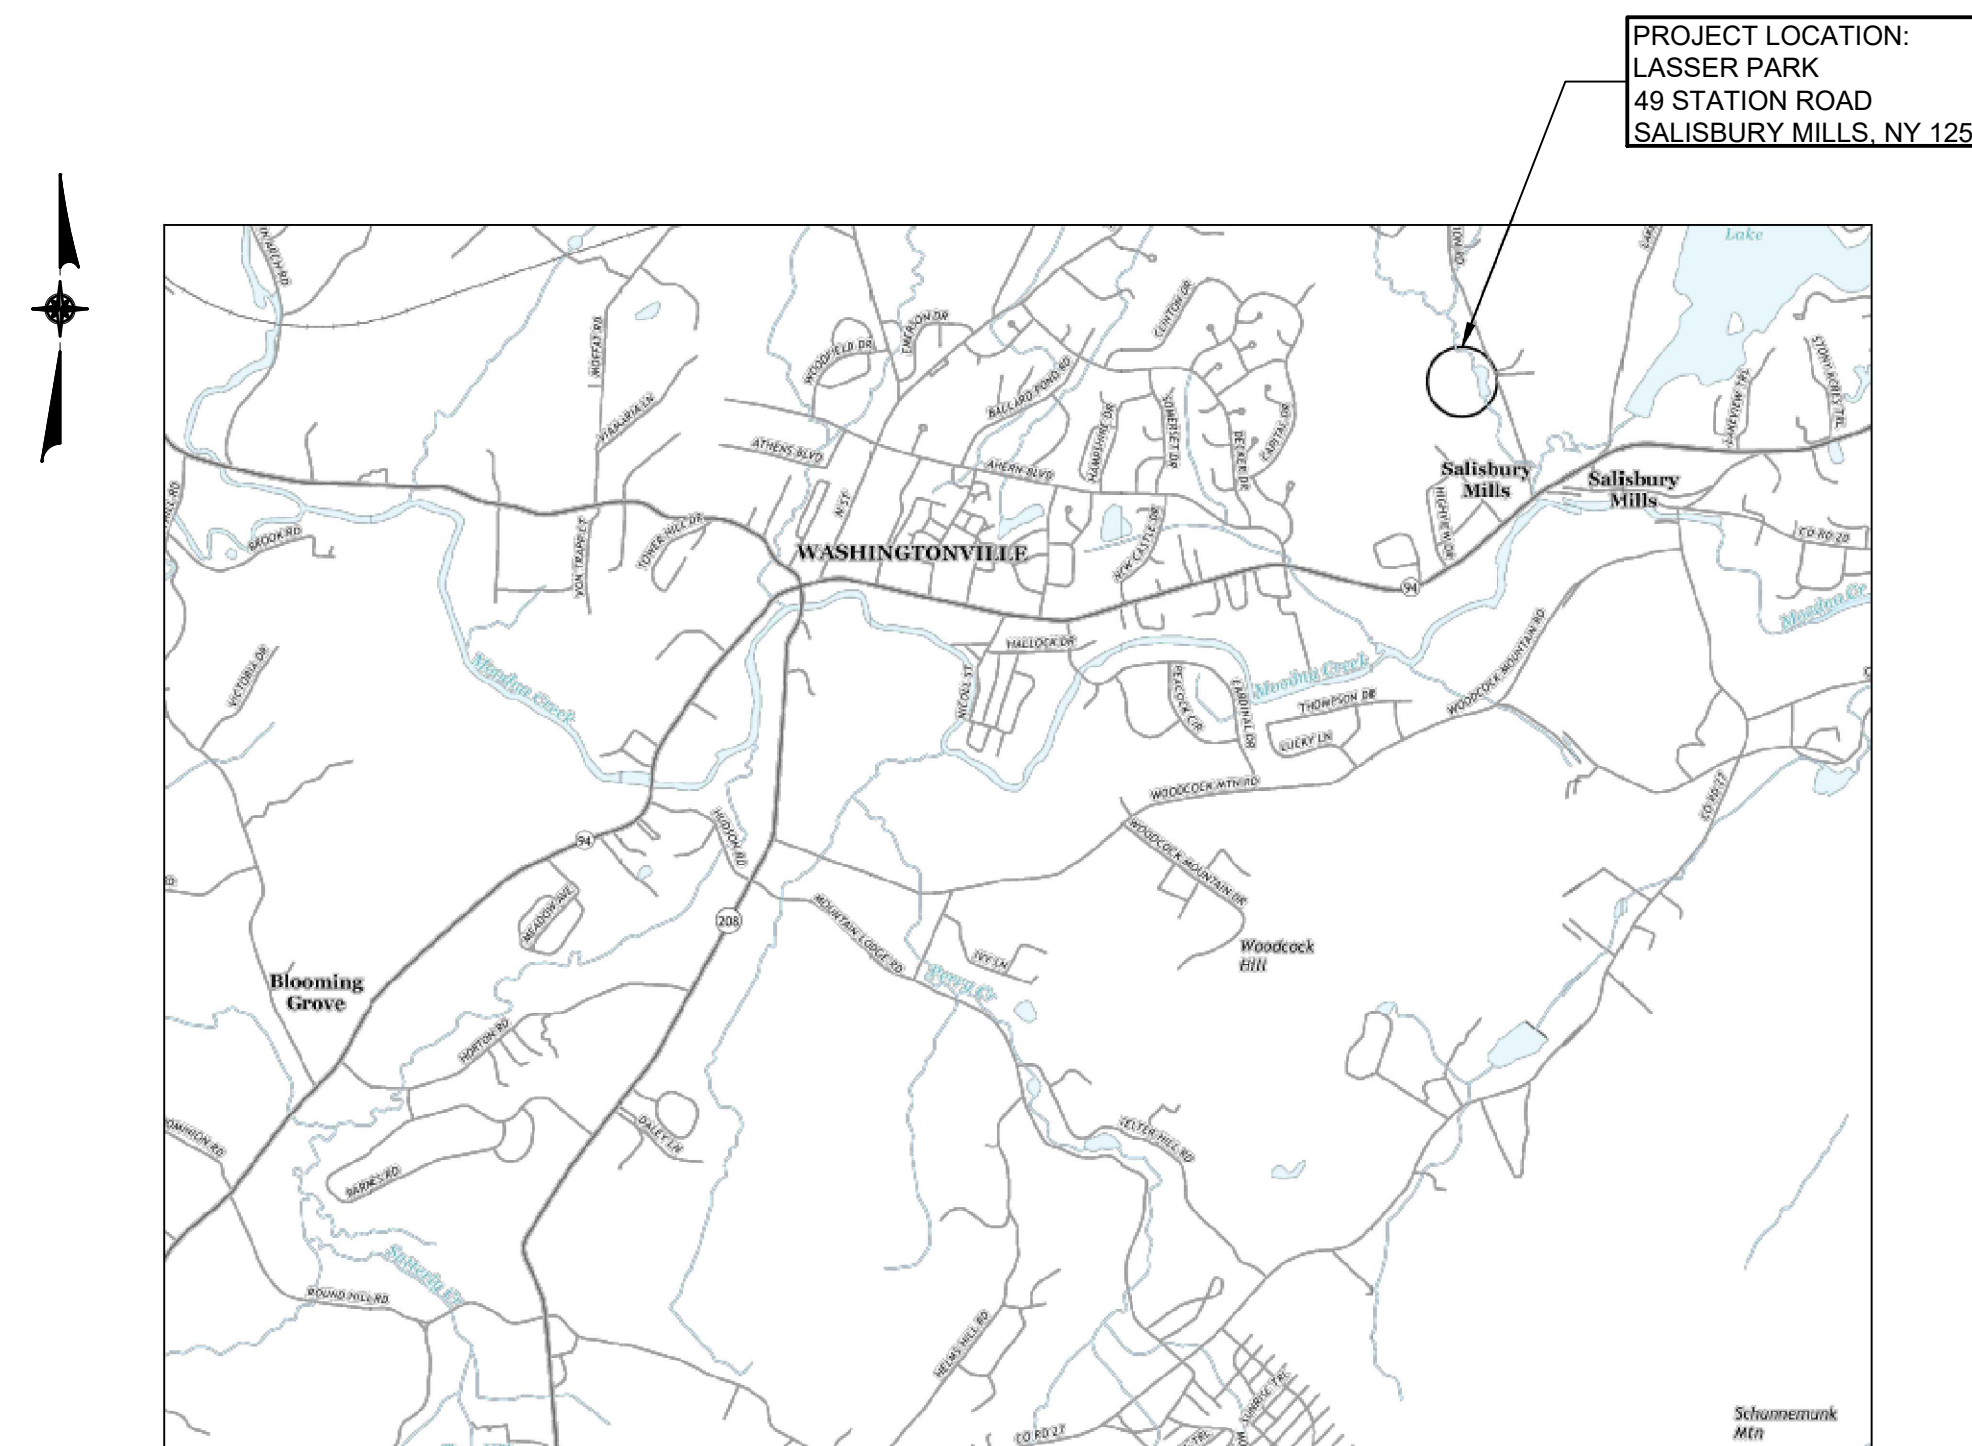

LOCATION MAP

N.T.S.