

CONSULTANTS:

MARK	DATE	DESCRIPTION

DESIGNED BY: JRM	DRAWN BY: KJE	CHECKED BY:	REVIEWED BY:
PROJECT No.: MKIV 1802	DATE: 04/21/2023	SCALE:	AS SHOWN

CLIENT

VILLAGE OF MOUNT KISCO

ADDITIONS AND ALTERATIONS TO
MUTUAL STATION



99 MAIN STREET, MOUNT KISCO,
NY 10549

CONTRACT

CONTRACT G GENERAL CONSTRUCTION

STATUS


CONSTRUCTION DOCUMENTS

SHEET TITLE

DOMESTIC WATER AND GAS FIRST FLOOR PLUMBING PLAN

DRAWING No.

P 120.01

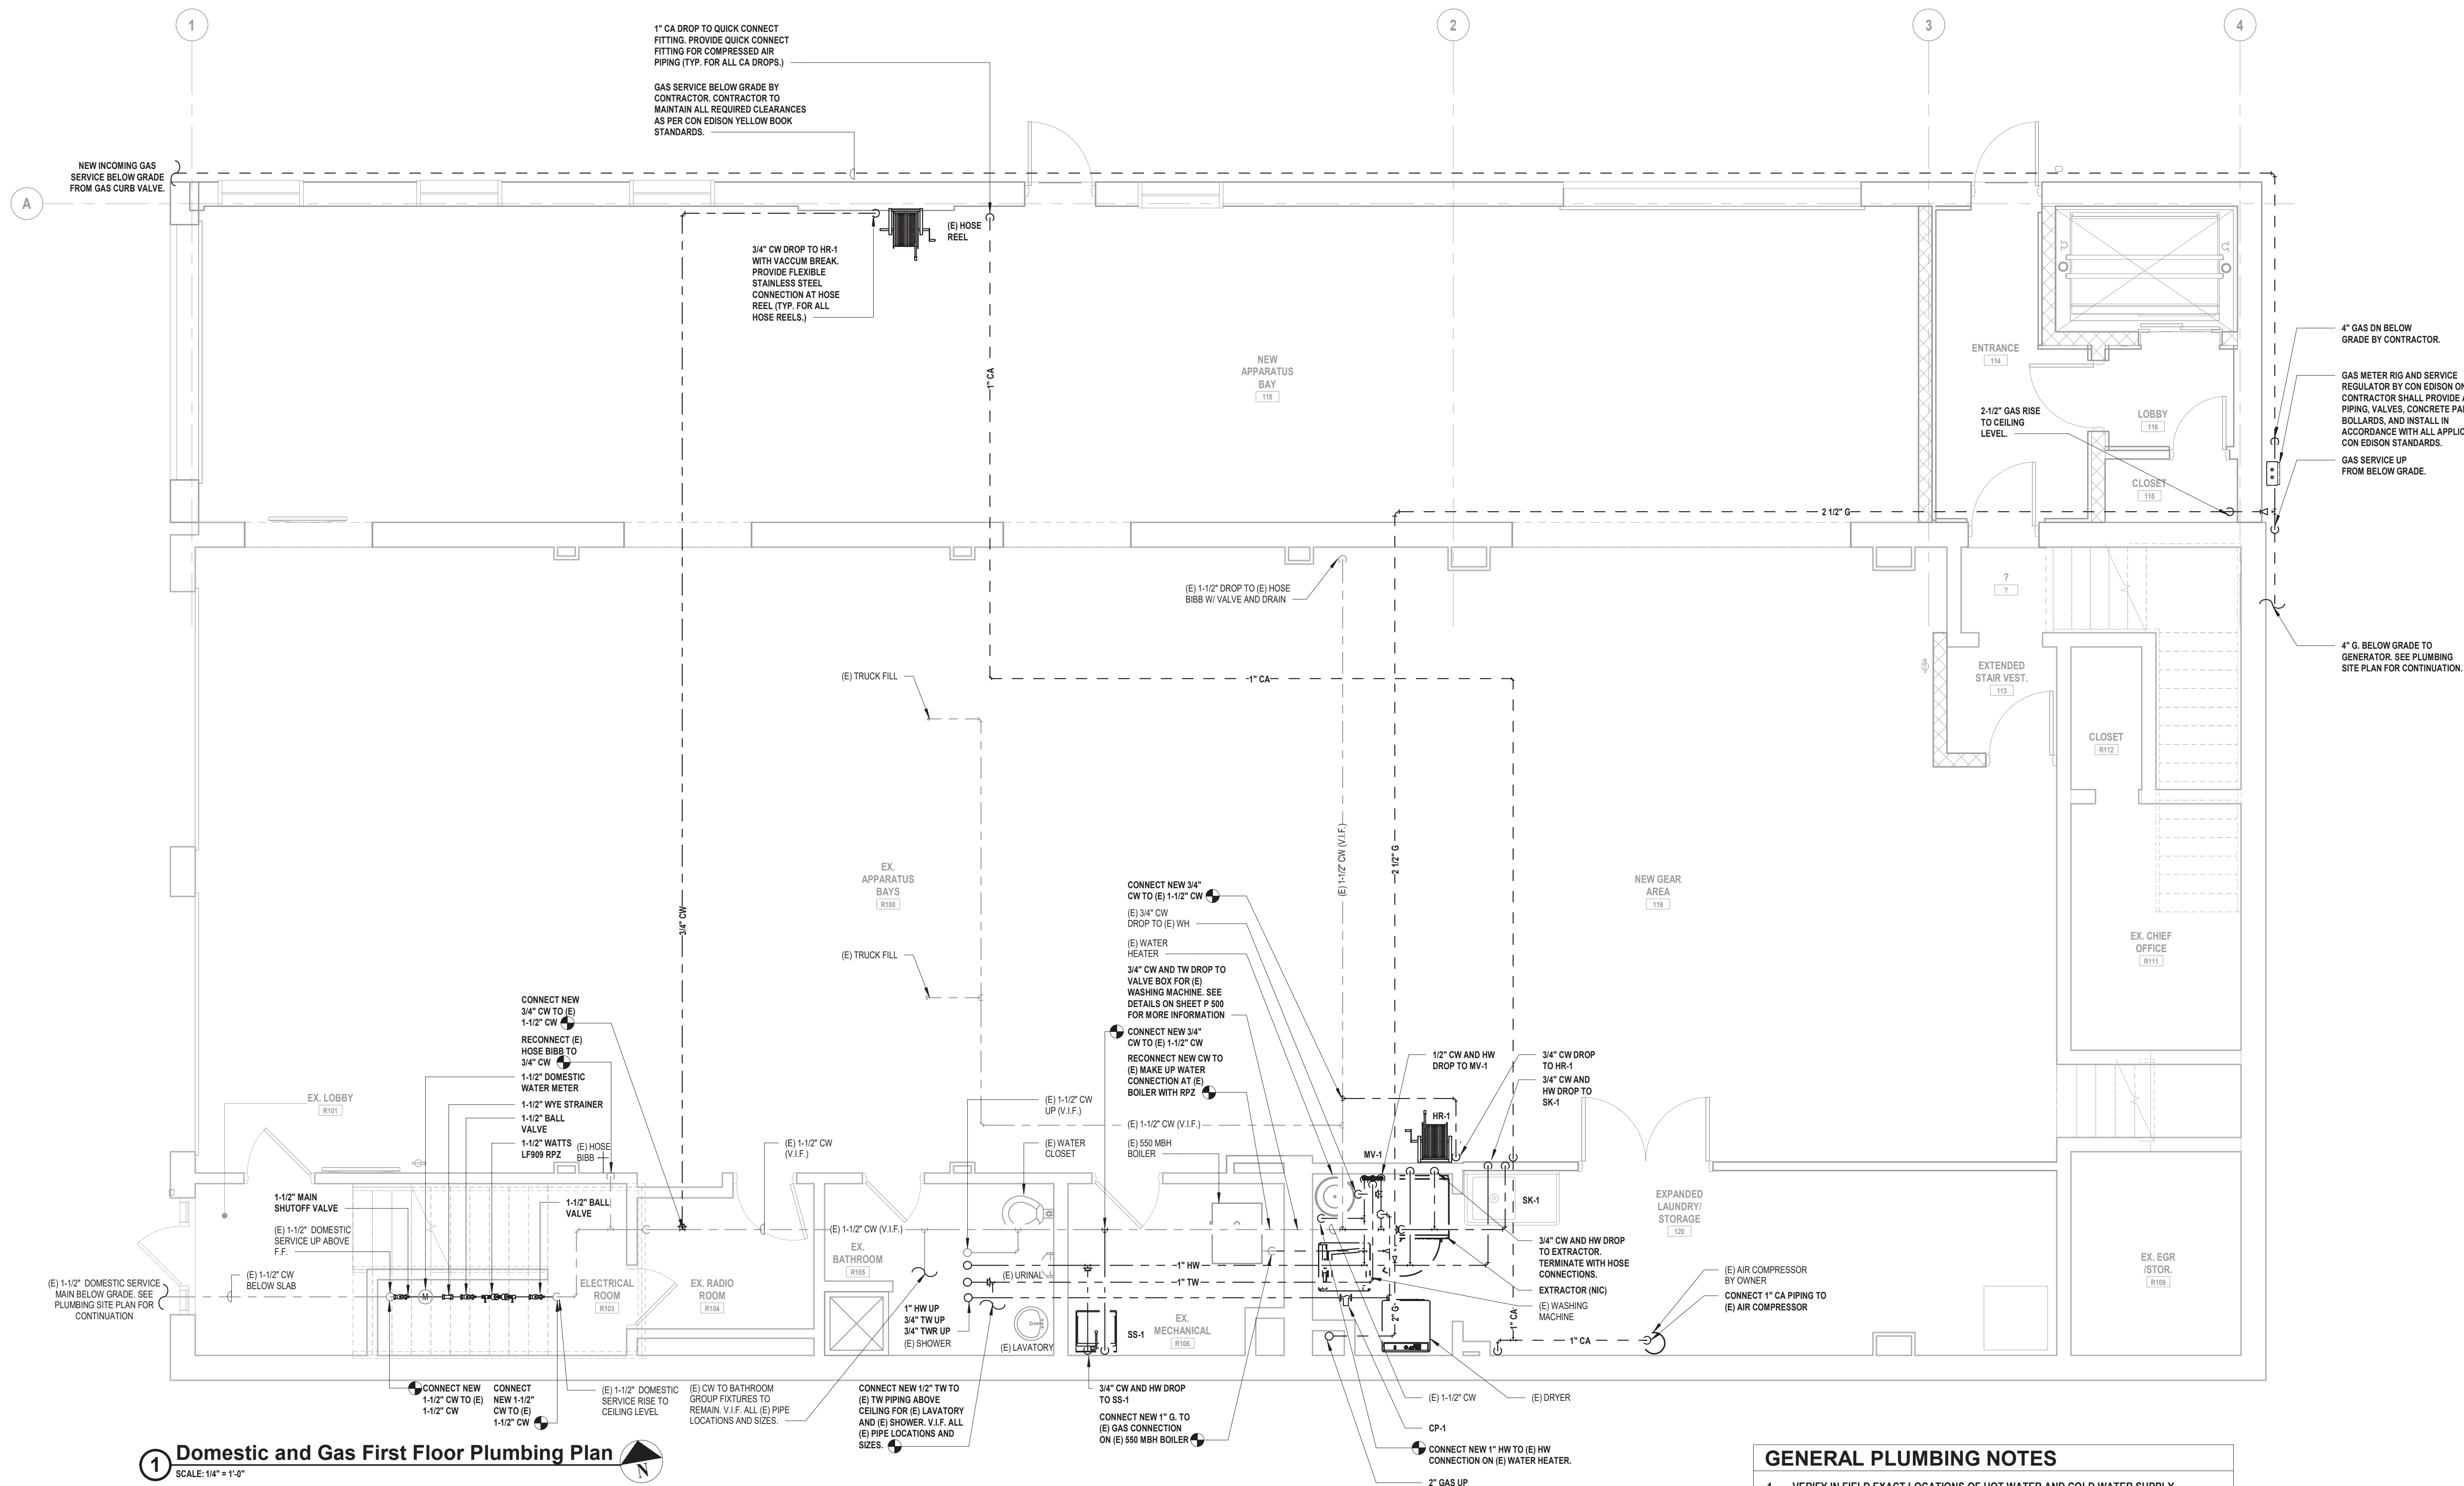

1 Domestic and Gas First Floor Plumbing Plan
SCALE: 1/4" = 1'-0"

GENERAL PLUMBING NOTES

- VERIFY IN FIELD EXACT LOCATIONS OF HOT WATER AND COLD WATER SUPPLY LINES, SANITARY, WASTE & VENT LINES. REROUTE AND MODIFY EXISTING PLUMBING LINES AS REQUIRED FOR CONNECTIONS TO NEW AND EXISTING PLUMBING FIXTURES.
- INSULATE ALL NEW WATER PIPING AND RE-INSULATE ALL EXISTING WATER PIPING WHERE INSULATION IS DAMAGED OR MISSING.
- CHASE WALLS WILL NEED TO BE OPENED TO ALLOW ACCESS TO EXISTING PIPING AND THEN REPAIRED. REFER TO ARCHITECTURAL DRAWINGS FOR MORE DETAIL.
- INSTALL NEW SHUT OFF VALVES ON ALL COLD WATER AND HOT WATER BRANCH PIPING ENTERING TOILETS.
- PROVIDE PIPE IDENTIFICATION ON ALL NEW AND EXISTING PIPING
- PROVIDE VALVE TAGS ON ALL NEW AND EXISTING VALVES.