


LEGEND	
---	EXISTING PIPING, FIXTURES, ETC. TO REMAIN
----	EXISTING PIPING, FIXTURES, ETC. TO BE REMOVED
---	NEW PIPING, FIXTURES, ETC.
---	COLD WATER PIPING
---	HOT WATER PIPING
---	HOT WATER RETURN PIPING
---	PLUMBING VENT PIPING
---	SANITARY PIPING
---	SANITARY PIPING (UNDERGROUND)
---	EXISTING SANITARY PIPING
---	EXISTING SANITARY PIPING (UNDERGROUND)
---	PUMP DISCHARGE PIPING
---	PUMP DISCHARGE PIPING (UNDERGROUND)
---	STORM PIPING
---	STORM PIPING (UNDERGROUND)
---	EXISTING STORM PIPING
---	EXISTING STORM (UNDERGROUND)
---	UNINTERRUPTIBLE GAS PIPING
---	EXISTING GAS PIPING
---	FIRE PROTECTION PIPING
---	SPRINKLER PIPING
---	SPRINKLER HEAD
---	FLOW DIRECTION WITHIN PIPE
---	CLEANOUT
---	CLEANOUT DECK PLATE
---	SHUT-OFF VALVE
---	COMBINATION BALANCING & SHUT-OFF VALVE
---	OS & Y VALVE
---	OS & Y VALVE WITH TAMPER SWITCH
---	CHECK VALVE
---	GAS SHUT OFF COCK
---	SIDEWALL SPRINKLER HEAD
---	PIPE CONNS. (BOTTOM, TOP 45 OR 90, PIPE UP)
---	PLUMBING FIXTURE IDENTIFICATION
---	BACKFLOW PREVENTER APPURTENANCE IDENTIFICATION
---	P.C. PLUMBING CONTRACTOR
---	G.C. GENERAL CONTRACTOR
---	HVAC HVAC CONTRACTOR
---	VTR VENT THRU ROOF
---	FAI FRESH AIR INTAKE
---	FD FLOOR DRAIN
---	PRV PRESSURE REDUCING VALVE
---	CIRCULATOR PUMP IDENTIFICATION
---	SUMP PUMP IDENTIFICATION
---	HOT WATER HEATER IDENTIFICATION
---	POINT OF CONNECTION
---	PART PLAN, DETAIL, SECTION NUMBER
---	DRAWING NUMBER
---	SECTION IDENTIFICATION

DISTRICT-WIDE  
CAPITAL IMPROVEMENTS  
  
NEW CONSTRUCTION  
& ATHLETIC  
UPGRADES  
  
CHAPPAQUA CENTRAL  
SCHOOL DISTRICT  
66 Roaring Brook Road  
Chappaqua, NY 10514

**KG+D ARCHITECTS, PC**  
285 MAIN STREET • MOUNT KISCO, NEW YORK 10549  
P: 914.666.5900 KGDARCHITECTS.COM

CONSTRUCTION DOCUMENTS  
  
SED Control No.  
HG: 66-10-04-06-0-015-023  
AP: 66-10-04-06-7-052-001  
CS: 66-10-04-06-7-027-002  
OB: 66-10-04-06-0-026-002  
SB: 66-10-04-06-0-036-007

**BARILE GALLAGHER & ASSOCIATES**  
CONSULTING ENGINEERS  
39 MARBLE AVE. PLEASANTVILLE, NY 10570  
914.326.6099 GENE@BGA-ENG.COM WWW.BGA-ENG.COM

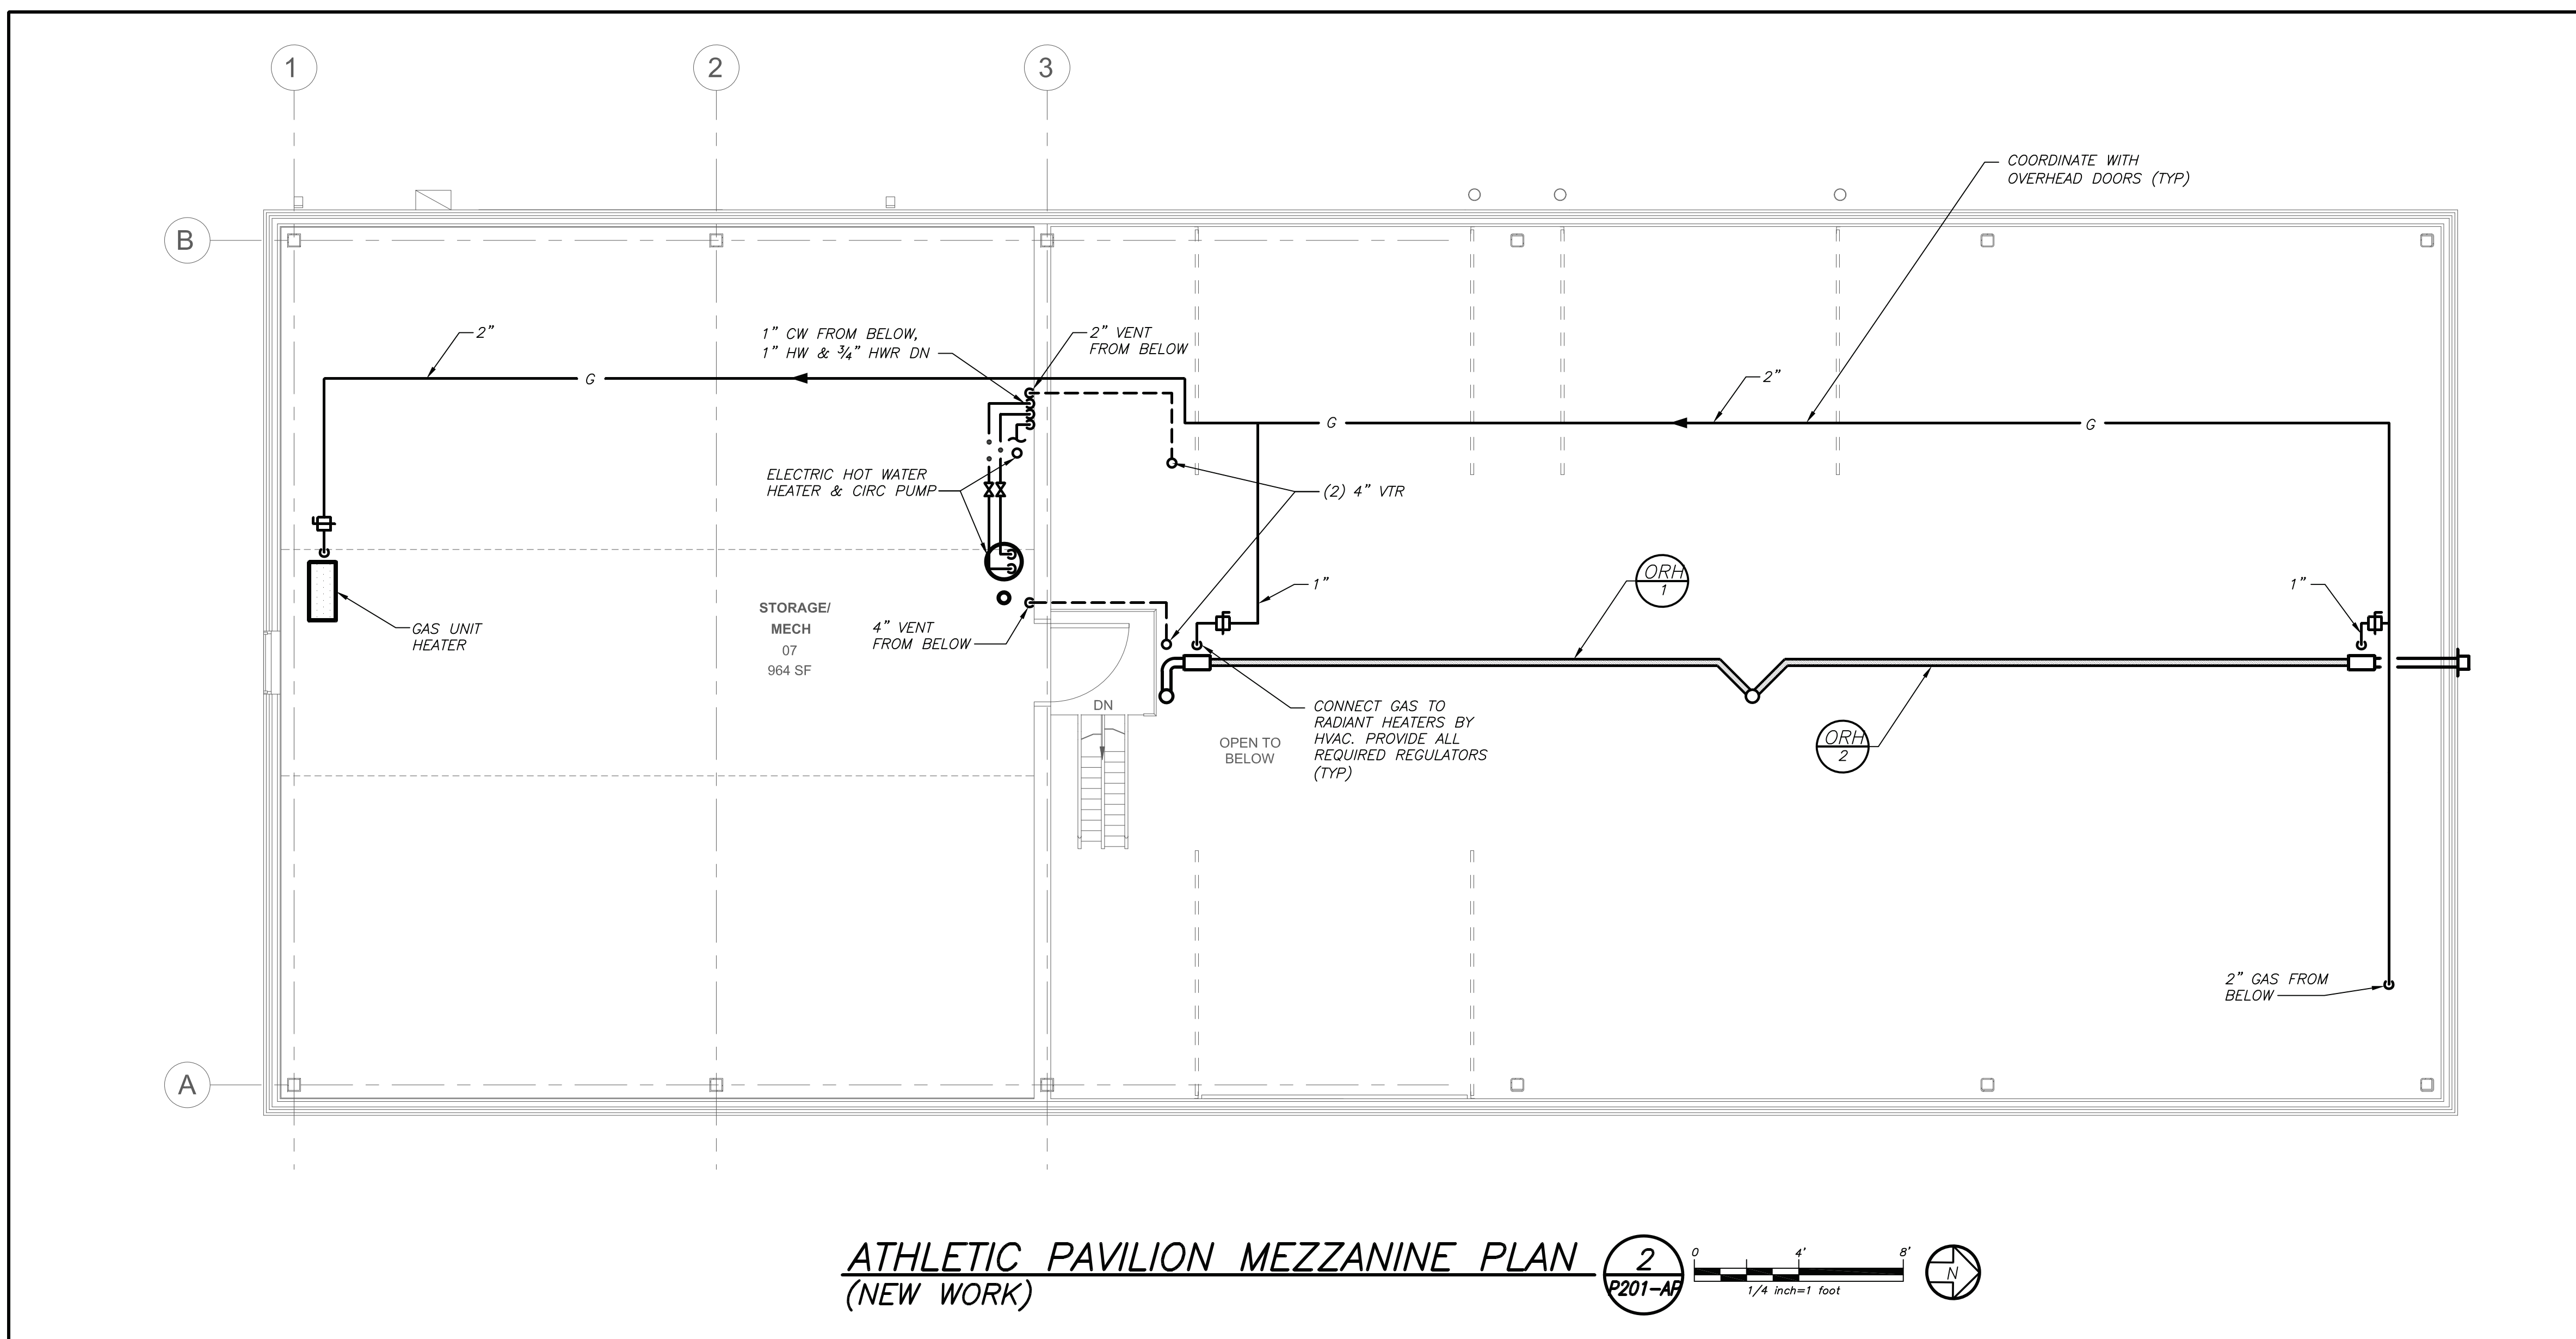

### PLUMBING FIXTURE SCHEDULE

MARK	DESCRIPTION	BRANCH SIZE			
		W	V	H	C
A1	WALL MOUNTED WATER CLOSET (FLUSH VALVE)	4"	2"	-	1"
A2	WALL MOUNTED WATER CLOSET (FLUSH VALVE) (HANDICAPPED)	4"	2"	-	1"
B1	COUNTERTOP LAVATORY (HANDICAPPED)	1-1/2"	1-1/2"	1/2"	1/2"
B2	WALL MOUNTED LAVATORY (HANDICAPPED)	1-1/2"	1-1/2"	1/2"	1/2"
B3	COUNTERTOP STAINLESS STEEL SINK (HANDICAPPED) BY GC. PC TO HOOK UP COMPLETE.	1-1/2"	1-1/2"	1/2"	1/2"
C	URINAL - WALL MOUNTED	3"	2"	-	1/2"
D	JANITOR SINK	3"	2"	3/4"	3/4"
E	WATER COOLER WITH BOTTLE FILL	2"	1-1/2"	3/4"	3/4"

### SUBMERSIBLE SEWAGE EJECTOR DETAIL