


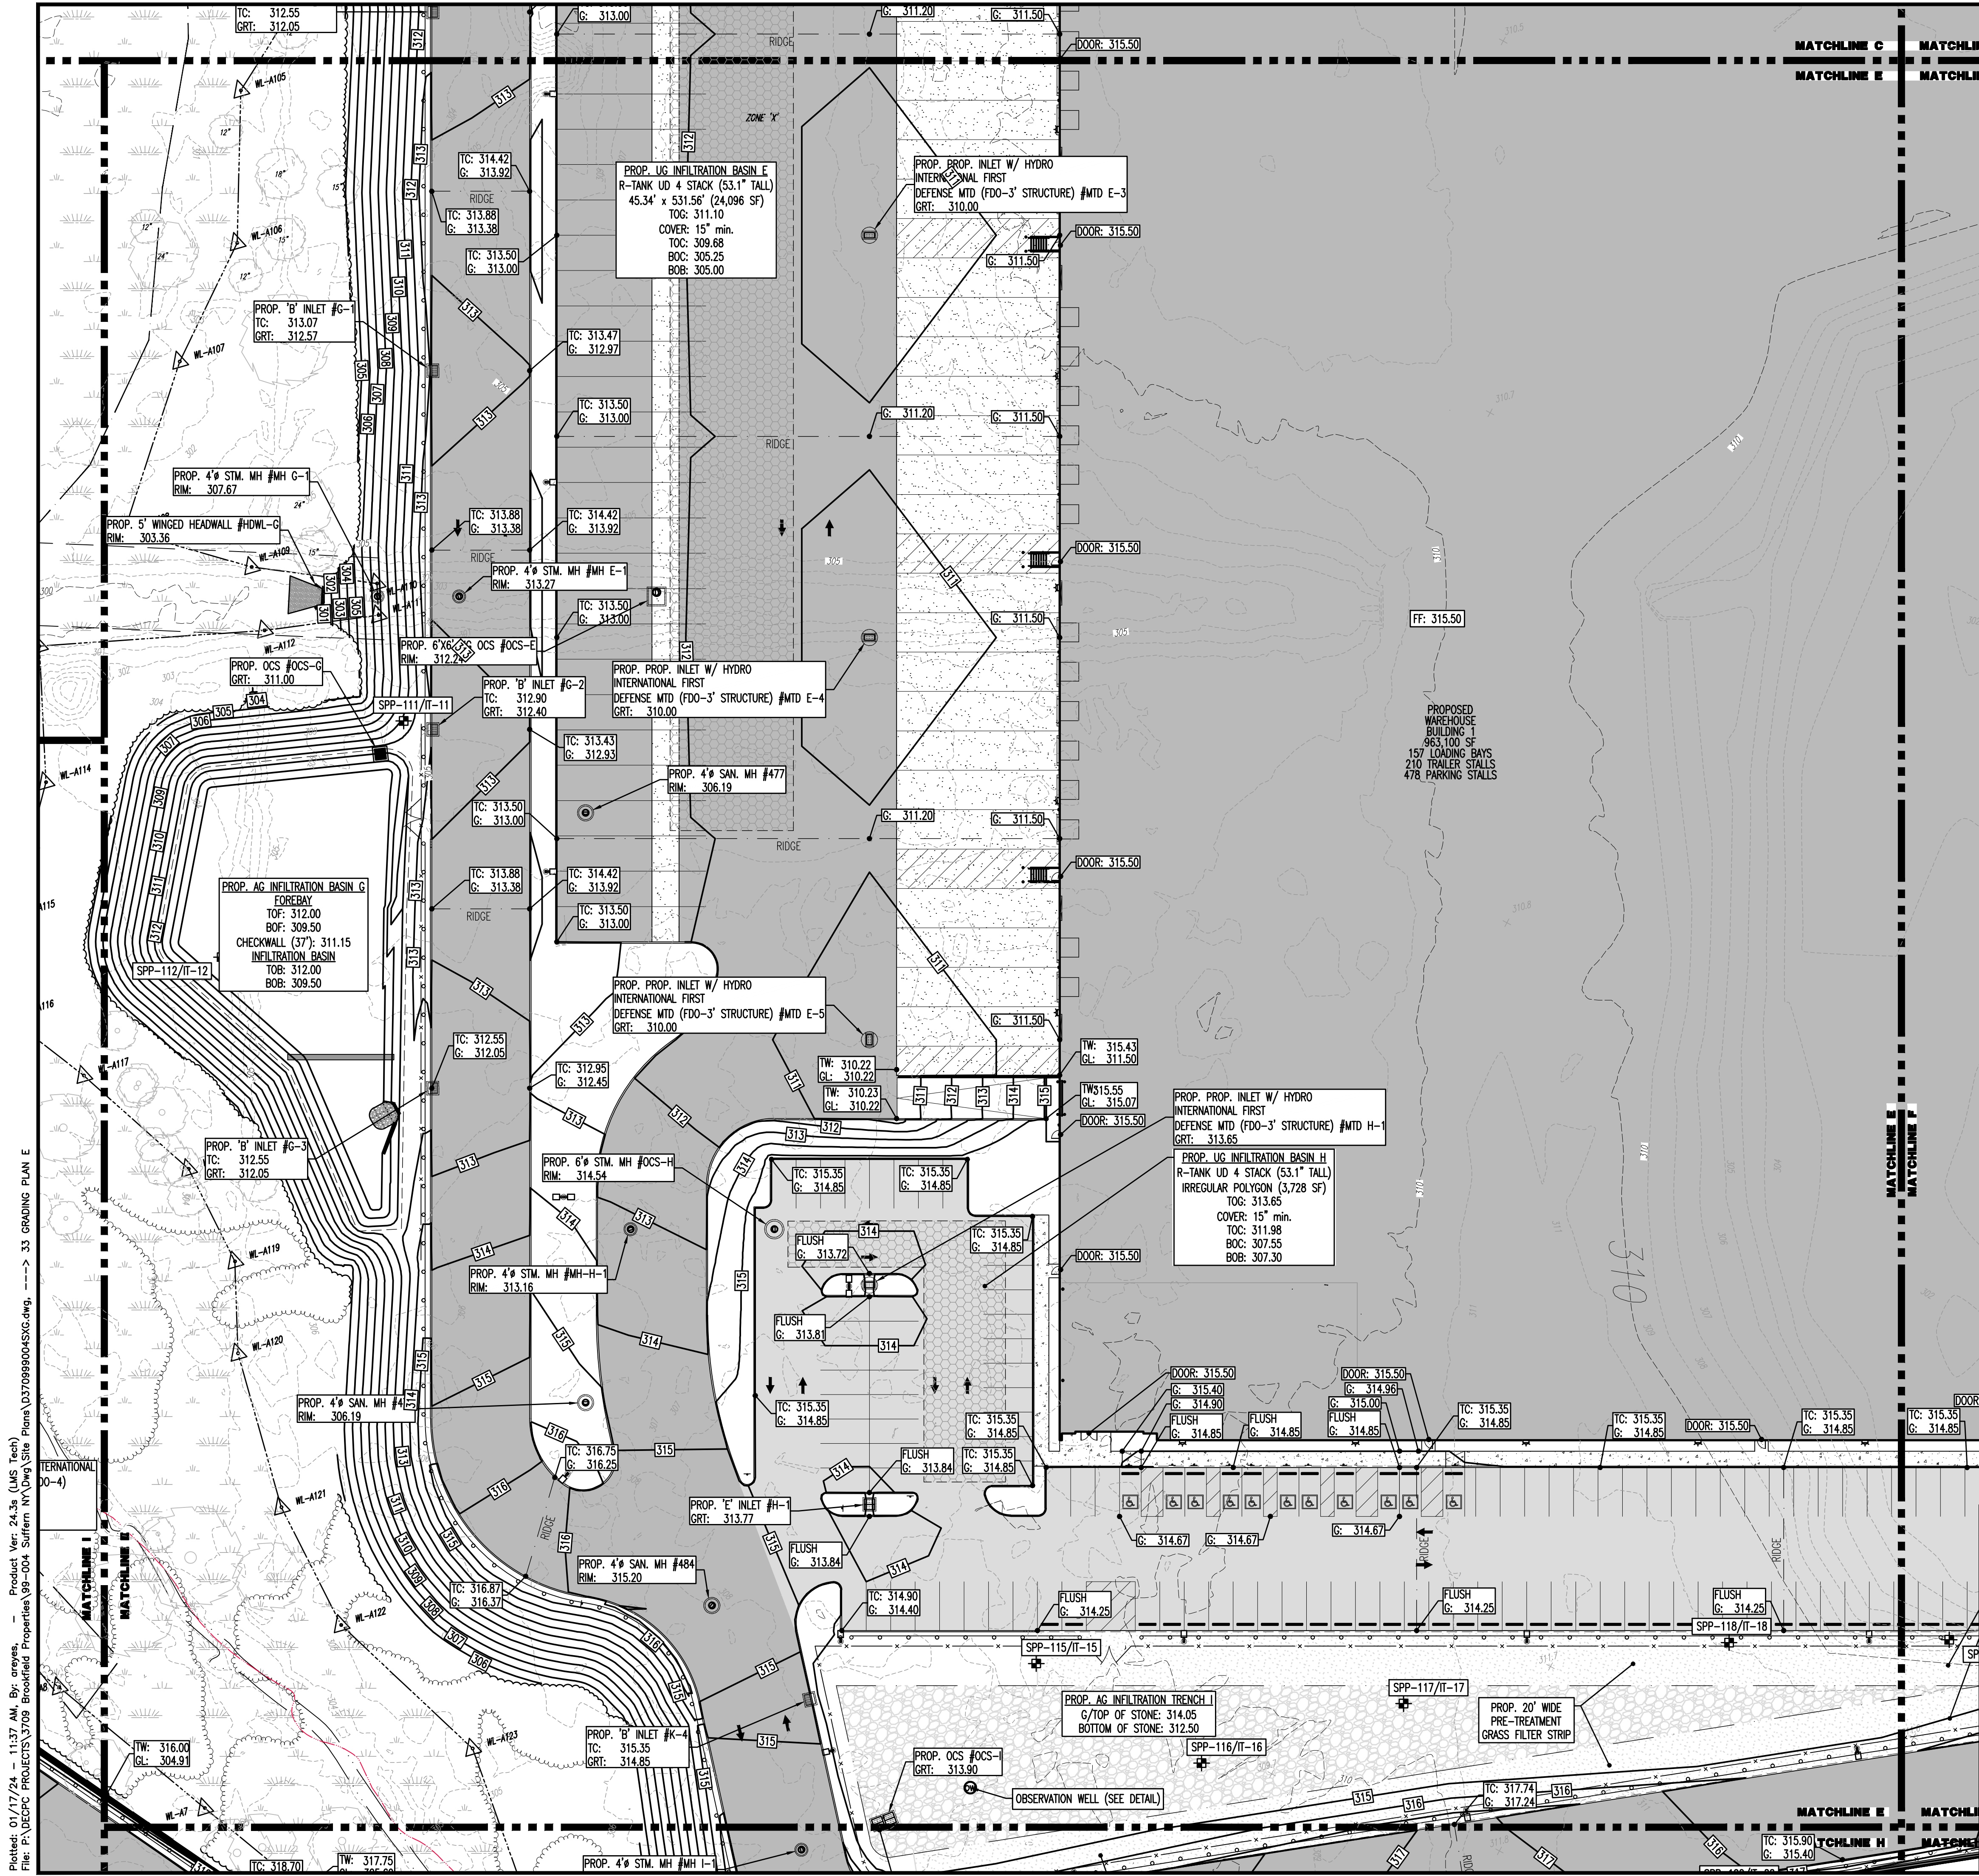

### PAVEMENT LEGEND

|          |                              |
|----------|------------------------------|
| [Symbol] | PROPOSED STANDARD PAVEMENT   |
| [Symbol] | PROPOSED HEAVY DUTY PAVEMENT |
| [Symbol] | PROPOSED STANDARD CONCRETE   |
| [Symbol] | PROPOSED HEAVY DUTY CONCRETE |

### KEY MAP

Map showing the project location within a grid of sections A through J.

### GRADING/UTILITY GRAPHIC LEGEND

|          |                                                                                                                                |
|----------|--------------------------------------------------------------------------------------------------------------------------------|
| [Symbol] | PROPERTY LINE (PARCEL IN QUESTION)                                                                                             |
| [Symbol] | OFF-SITE PROPERTY LINES                                                                                                        |
| [Symbol] | EXIST. CABLE LINE                                                                                                              |
| [Symbol] | EXIST. ELECTRIC LINE                                                                                                           |
| [Symbol] | EXIST. FIBER OPTIC LINE                                                                                                        |
| [Symbol] | EXIST. GAS LINE                                                                                                                |
| [Symbol] | EXIST. OVERHEAD WIRES                                                                                                          |
| [Symbol] | EXIST. TELEPHONE LINE                                                                                                          |
| [Symbol] | EXIST. UNDERGROUND ELEC./TELE. SERVICE (NO. & SIZE OF CONDUITS NOT DEFINED)                                                    |
| [Symbol] | EXIST. WATER LINE                                                                                                              |
| [Symbol] | EXIST. SANITARY SEWER LINE                                                                                                     |
| [Symbol] | EXIST. STORM DRAIN LINE                                                                                                        |
| [Symbol] | EXIST. MINOR CONTOUR & ELEVATION                                                                                               |
| [Symbol] | EXIST. MAJOR CONTOUR & ELEVATION                                                                                               |
| [Symbol] | EXIST. MONITORING WELL                                                                                                         |
| [Symbol] | APPROX. TEST PIT LOCATION                                                                                                      |
| [Symbol] | EXIST. SPOT ELEVATIONS                                                                                                         |
| [Symbol] | EXIST. GUTTER ELEV.                                                                                                            |
| [Symbol] | EXIST. TOP OF CURB ELEV.                                                                                                       |
| [Symbol] | EXIST. FINISH FLOOR ELEV.                                                                                                      |
| [Symbol] | EXIST. GARAGE FLOOR ELEV.                                                                                                      |
| [Symbol] | EXIST. FIRE HYDRANT                                                                                                            |
| [Symbol] | EXIST. WATER VALVE                                                                                                             |
| [Symbol] | EXIST. GAS VALVE                                                                                                               |
| [Symbol] | EXIST. GAS METER                                                                                                               |
| [Symbol] | EXIST. ELECTRIC METER                                                                                                          |
| [Symbol] | EXIST. ELECTRIC BOX                                                                                                            |
| [Symbol] | EXIST. CLEAN OUT                                                                                                               |
| [Symbol] | EXIST. WELL                                                                                                                    |
| [Symbol] | EXIST. WATER SHUT OFF VALVE                                                                                                    |
| [Symbol] | EXIST. TELEPHONE BOX                                                                                                           |
| [Symbol] | EXIST. CABLE TV BOX                                                                                                            |
| [Symbol] | EXIST. UTILITY POLE                                                                                                            |
| [Symbol] | EXIST. GUY WIRE                                                                                                                |
| [Symbol] | EXIST. LIGHT POLE                                                                                                              |
| [Symbol] | EXIST. BUILDING LIGHT                                                                                                          |
| [Symbol] | EXIST. SHOE BOX LIGHT                                                                                                          |
| [Symbol] | EXIST. COBRA LIGHT POLE                                                                                                        |
| [Symbol] | EXIST. TRAFFIC SIGNAL POLE                                                                                                     |
| [Symbol] | EXIST. MANHOLE                                                                                                                 |
| [Symbol] | EXIST. "A" INLET                                                                                                               |
| [Symbol] | EXIST. "B" INLET                                                                                                               |
| [Symbol] | EXIST. "E" INLET                                                                                                               |
| [Symbol] | EXIST. YARD INLET                                                                                                              |
| [Symbol] | EXIST. FLARED END SECTION                                                                                                      |
| [Symbol] | EXIST. HEADWALL                                                                                                                |
| [Symbol] | PROP. CABLE LINE                                                                                                               |
| [Symbol] | PROP. ELECTRIC LINE                                                                                                            |
| [Symbol] | PROP. FIBER OPTIC LINE                                                                                                         |
| [Symbol] | PROP. GAS LINE                                                                                                                 |
| [Symbol] | PROP. OVERHEAD WIRES                                                                                                           |
| [Symbol] | PROP. TELEPHONE LINE                                                                                                           |
| [Symbol] | PROP. UNDERGROUND ELEC./TELE. SERVICE (NO. & SIZE OF CONDUITS NOT DEFINED)                                                     |
| [Symbol] | PROP. WATER LINE                                                                                                               |
| [Symbol] | PROP. SANITARY SEWER LINE                                                                                                      |
| [Symbol] | PROP. STORM DRAIN LINE                                                                                                         |
| [Symbol] | PROP. FINISH GRADE CONTOUR & ELEVATION                                                                                         |
| [Symbol] | PROP. PARAPET, TOP OF WALL ELEV.                                                                                               |
| [Symbol] | PROP. GRADE SPOT ELEV.                                                                                                         |
| [Symbol] | PROP. TOP OF CURB & FINISHED GRADE ELEV.                                                                                       |
| [Symbol] | PROP. FINISHED FLOOR ELEV.                                                                                                     |
| [Symbol] | PROP. TOP OF WALL & FINISHED GRADE @ LOW SIDE OF WALL (ACTUAL BOTTOM OF WALL FOOTING TO BE ESTABLISHED BY WALL DESIGNER)       |
| [Symbol] | PROP. TOP OF EXTENDED CURB, (SH) FINISHED GRADE @ HIGH SIDE OF EXTENDED CURB & (GL) FINISHED GRADE @ LOW SIDE OF EXTENDED CURB |
| [Symbol] | PROP. DIRECTION OF DRAINAGE FLOW ARROW                                                                                         |
| [Symbol] | PROP. WATER VALVE                                                                                                              |
| [Symbol] | PROP. GAS VALVE                                                                                                                |
| [Symbol] | PROP. STORM CLEANOUT                                                                                                           |
| [Symbol] | PROP. SANITARY CLEANOUT                                                                                                        |
| [Symbol] | PROP. AREA LIGHT                                                                                                               |
| [Symbol] | PROP. OUTLET CONTROL STRUCTURE                                                                                                 |
| [Symbol] | PROP. DRAINAGE MANHOLE                                                                                                         |
| [Symbol] | PROP. SANITARY SEWER MANHOLE                                                                                                   |
| [Symbol] | PROP. "A" INLET                                                                                                                |
| [Symbol] | PROP. "B" INLET                                                                                                                |
| [Symbol] | PROP. "E" INLET                                                                                                                |
| [Symbol] | PROP. YARD INLET                                                                                                               |
| [Symbol] | PROP. FLARED END SECTION                                                                                                       |
| [Symbol] | PROP. HEADWALL                                                                                                                 |

SEE SHEET 03 OF 132 FOR GRADING PLAN NOTES

GRAPHIC SCALE

1 INCH = 30 FT.

THIS PLAN SET IS FOR PERMITTING PURPOSES ONLY AND MAY NOT BE USED FOR CONSTRUCTION

## DYNAMIC ENGINEERING

LAND DEVELOPMENT CONSULTING • PERMITTING • GEOTECHNICAL • ENVIRONMENTAL • SURVEY • PLANNING & ZONING

1954 Main Street  
Lake Como, NJ 07719  
T: 732.974.0198  
F: 732.974.3521  
www.dynamiceng.com

Lake Como, New Jersey T: 732.974.0198 | Chester, New Jersey T: 908.879.9229 | Newark, New Jersey T: 973.753.7200 | Toms River, New Jersey T: 732.478.0000  
Allen, Texas T: 972.334.2100 | Austin, Texas T: 512.244.2044 | Houston, Texas T: 281.789.6400 | Delray Beach, Florida T: 561.921.8570  
Newtown, Pennsylvania T: 267.683.0274 | Philadelphia, Pennsylvania T: 215.253.4568 | Bethlehem, Pennsylvania T: 610.256.4400

TITLE: **GRADING PLAN E**

PROJECT: **IV2 ROCKLAND LOGISTICS, LLC  
PROPOSED INDUSTRIAL PARK AT 25 OLD MILL ROAD**  
SECTION 55.22 BLOCK 1, LOT 1; SECTION 55.37, BLOCK 1, LOT 31  
OLD MILL ROAD AND HEMION ROAD (CR 93)  
VILLAGE OF SUFFERN, ROCKLAND COUNTY, NEW YORK

DESIGNED BY: CAM  
CHECKED BY: JMS  
ZAK

DATE: 12/17/2021  
SCALE: (H) 1"=30'  
(V) 1"=10'  
SHEET No: **33**  
OF 132

**ZACHARY A. KAMM**  
PROFESSIONAL ENGINEER  
NEW YORK LICENSE NO. 107071

**JOSHUA M. SWALD**  
PROFESSIONAL ENGINEER  
NEW YORK LICENSE NO. 107639

**811**  
PROTECT YOURSELF  
ALL STATES REQUIRE NOTIFICATION OF  
CONCRETE, METALS, OR ANY SERVICE  
PREPARING TO DIG THE GROUND  
FOR STATE SPONSORED DIRECT PHONE NUMBERS VISIT:  
WWW.CALL811.COM

Rev. # 5