



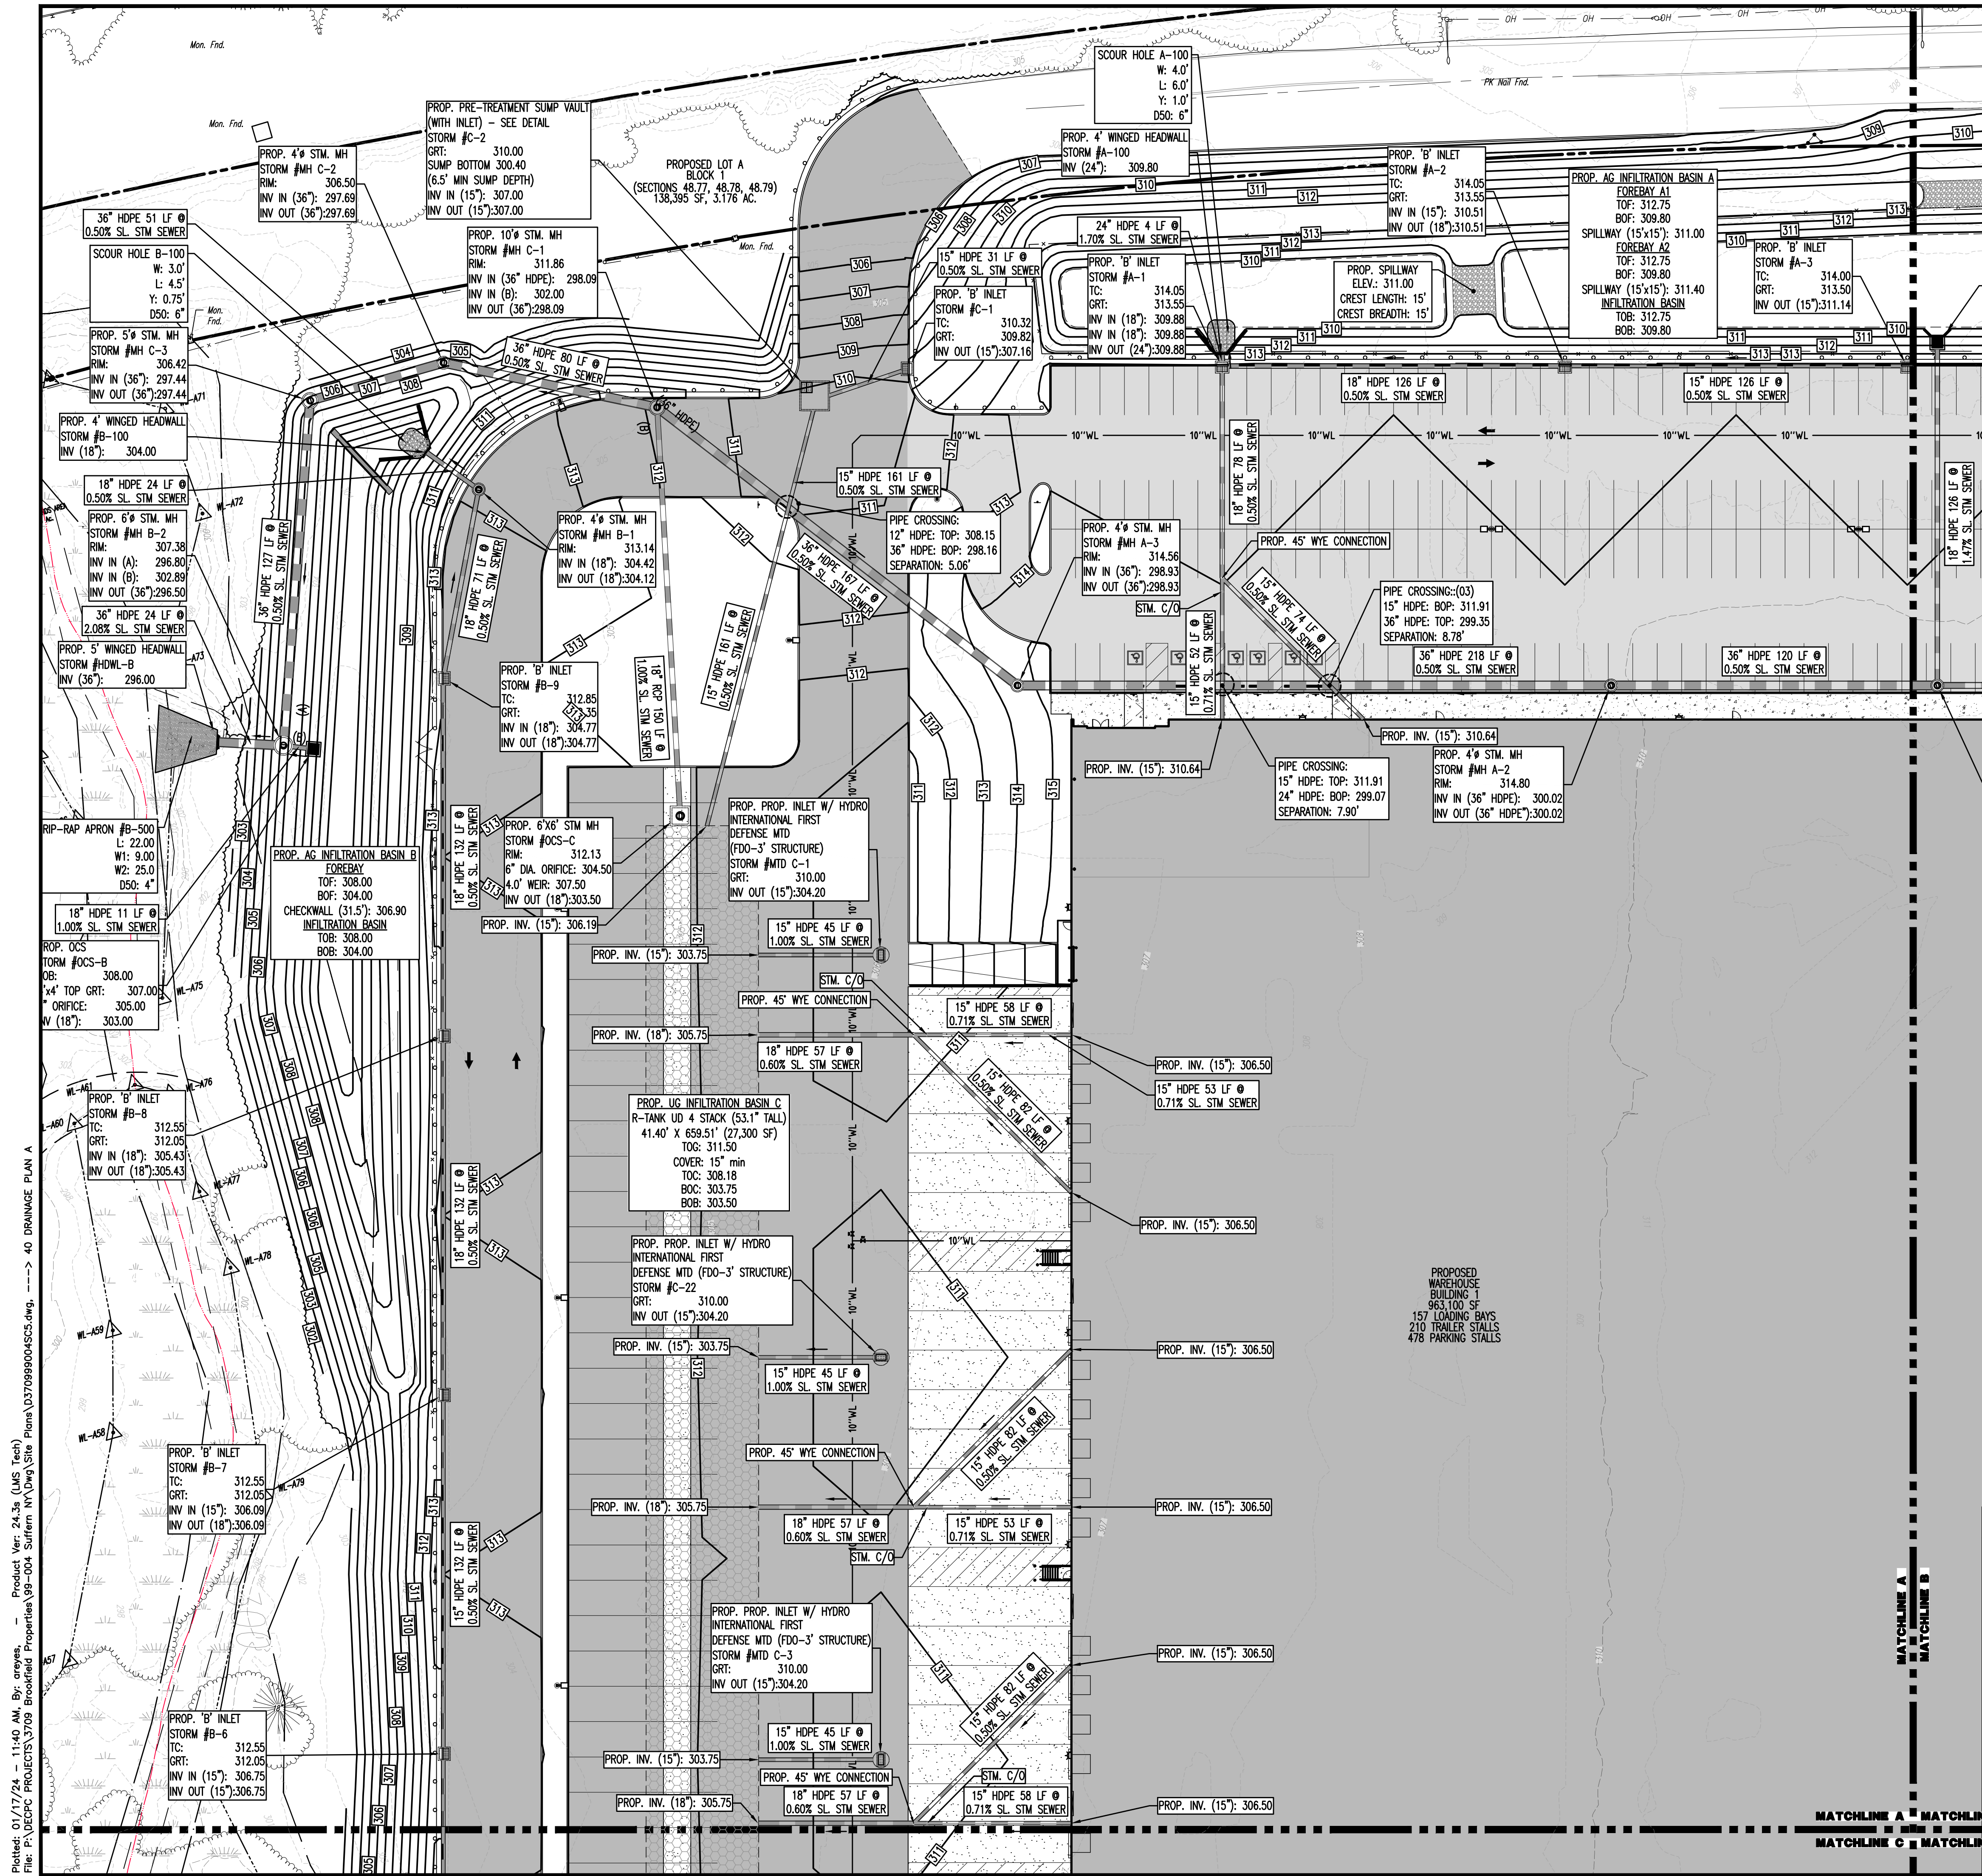

PAVEMENT LEGEND

- PROPOSED STANDARD PAVEMENT
- PROPOSED HEAVY DUTY PAVEMENT
- PROPOSED STANDARD CONCRETE
- PROPOSED HEAVY DUTY CONCRETE

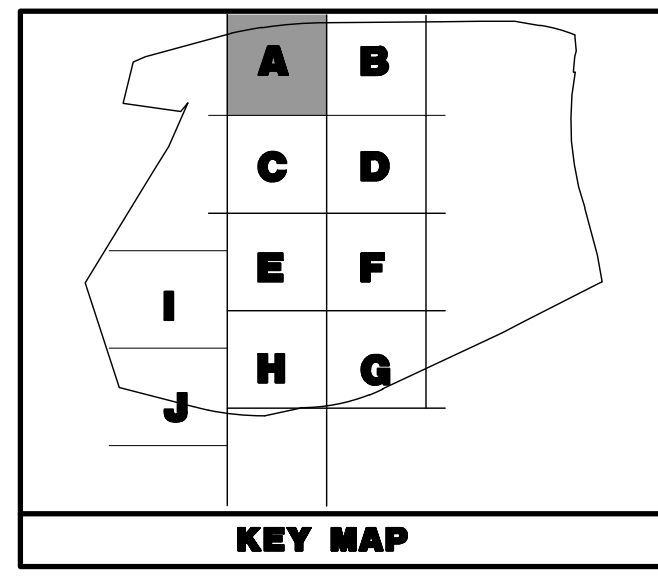

GRADING/UTILITY GRAPHIC LEGEND

PROPERTY LINE (PARCEL IN QUESTION)
OFF-SITE PROPERTY LINES


EXIST. CABLE LINE
EXIST. ELECTRIC LINE
EXIST. FIBER OPTIC LINE
EXIST. GAS LINE
EXIST. OVERHEAD WIRES
EXIST. TELEPHONE LINE
EXIST. UNDERGROUND ELEC./TELE. SERVICE (NO. & SIZE OF CONDUITS NOT DEFINED)
EXIST. WATER LINE
EXIST. SANITARY SEWER LINE
EXIST. STORM DRAIN LINE
EXIST. MINOR CONTOUR & ELEVATION
EXIST. MAJOR CONTOUR & ELEVATION
EXIST. MONITORING WELL

APPROX. TEST PIT LOCATION
EXIST. SPOT ELEVATIONS
EXIST. GUTTER ELEV.
EXIST. TOP OF CURB ELEV.
EXIST. FINISH FLOOR ELEV.
EXIST. GARAGE FLOOR ELEV.
EXIST. FIRE HYDRANT
EXIST. WATER VALVE
EXIST. GAS VALVE
EXIST. GAS METER
EXIST. ELECTRIC METER
EXIST. ELECTRIC BOX
EXIST. CLEAN OUT
EXIST. WELL
EXIST. WATER SHUT OFF VALVE
EXIST. TELEPHONE BOX
EXIST. CABLE TV BOX
EXIST. UTILITY POLE
EXIST. GUY WIRE
EXIST. LIGHT POLE
EXIST. BUILDING LIGHT
EXIST. SHOE BOX LIGHT
EXIST. COBRA LIGHT POLE
EXIST. TRAFFIC SIGNAL POLE
EXIST. MANHOLE
EXIST. "A" INLET
EXIST. "B" INLET
EXIST. "C" INLET
EXIST. YARD INLET
EXIST. FLARED END SECTION
EXIST. HEADWALL

PROF. CABLE LINE
PROF. ELECTRIC LINE
PROF. FIBER OPTIC LINE
PROF. GAS LINE
PROF. OVERHEAD WIRES
PROF. TELEPHONE LINE
PROF. UNDERGROUND ELEC./TELE. SERVICE (NO. & SIZE OF CONDUITS NOT DEFINED)
PROF. WATER LINE
PROF. SANITARY SEWER LINE
PROF. STORM DRAIN LINE
PROF. FINISH GRADE CONTOUR & ELEVATION

PROF. GRADE SPOT ELEV.
PROF. TOP OF CURB & FINISHED GRADE ELEV.
PROF. FINISHED FLOOR ELEV.
PROF. TOP OF WALL & FINISHED GRADE @ LOW SIDE OF WALL (ACTUAL BOTTOM OF WALL FOOTING TO BE ESTABLISHED BY WALL DESIGNER)
PROF. TOP OF EXTENDED CURB (B) FINISHED GRADE @ HIGH SIDE OF EXTENDED CURB & (C) FINISHED GRADE @ LOW SIDE OF EXTENDED CURB
PROF. DIRECTION OF DRAINAGE FLOW ARROW
PROF. WATER VALVE
PROF. GAS VALVE
PROF. STORM CLEANOUT
PROF. SANITARY CLEANOUT
PROF. AREA LIGHT
PROF. OUTLET CONTROL STRUCTURE
PROF. DRAINAGE MANHOLE
PROF. SANITARY SEWER MANHOLE
PROF. "A" INLET
PROF. "B" INLET
PROF. "C" INLET
PROF. YARD INLET
PROF. FLARED END SECTION
PROF. HEADWALL

SEE SHEET 03 OF 132 FOR DRAINAGE PLAN NOTES

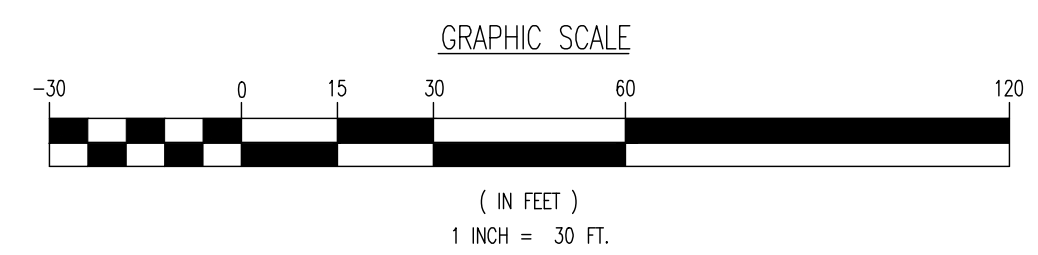

THIS PLAN SET IS FOR PERMITTING PURPOSES ONLY AND MAY NOT BE USED FOR CONSTRUCTION

DYNAMIC ENGINEERING
LAND DEVELOPMENT CONSULTING • PERMITTING • GEOTECHNICAL • ENVIRONMENTAL • SURVEY • PLANNING & ZONING

1904 Main Street
Lake Como, NJ 07719
T: 732.974.0198
F: 732.974.3521
www.dynamiceng.com

TITLE: DRAINAGE PLAN A

PROJECT: **IV2. ROCKLAND LOGISTICS, LLC**
PROPOSED INDUSTRIAL PARK AT 25 OLD MILL ROAD
SECTION 55.22 BLOCK 1, LOT 1; SECTION 55.37, BLOCK 1, LOT 31
OLD MILL ROAD AND HEMION ROAD (CR 93)
VILLAGE OF SUFFERN, ROCKLAND COUNTY, NEW YORK

JOB No: 3709-99-004
DATE: 12/17/2021
DRAWN BY: CAM
SCALE: (H) 1"=30'
(V) 1"=10'
DESIGNED BY: JMS
SHEET No: 40
CHECKED BY: JMS
ZAK
PROTECT YOURSELF
ALL STATES REQUIRE REGISTRATION OF GEOTECHNICAL ENGINEERS. IF ANY DESIGN PREPARED TO OBTAIN THE STATE'S OFFICIAL SEAL, IT MUST BE BY A REGISTERED PROFESSIONAL ENGINEER.
FOR STATE SPECIFIC DIRECT PHONE NUMBERS VISIT: WWW.CALL811.COM

PROFESSIONAL ENGINEER
NEW YORK LICENSE No. 107071

PROFESSIONAL ENGINEER
NEW YORK LICENSE No. 107071

Rev. 5

Plotted: 01/17/24 - 11:40 AM, By: areyes, Product Ver: 24.3s (LMS Tech)
File: P:\GEOPC PROJECTS\3709 Brookfield Properties\99-004 Suffern NY\DWG\Site Plans\370999004SC5.dwg, ---> 40 DRAINAGE PLAN A