



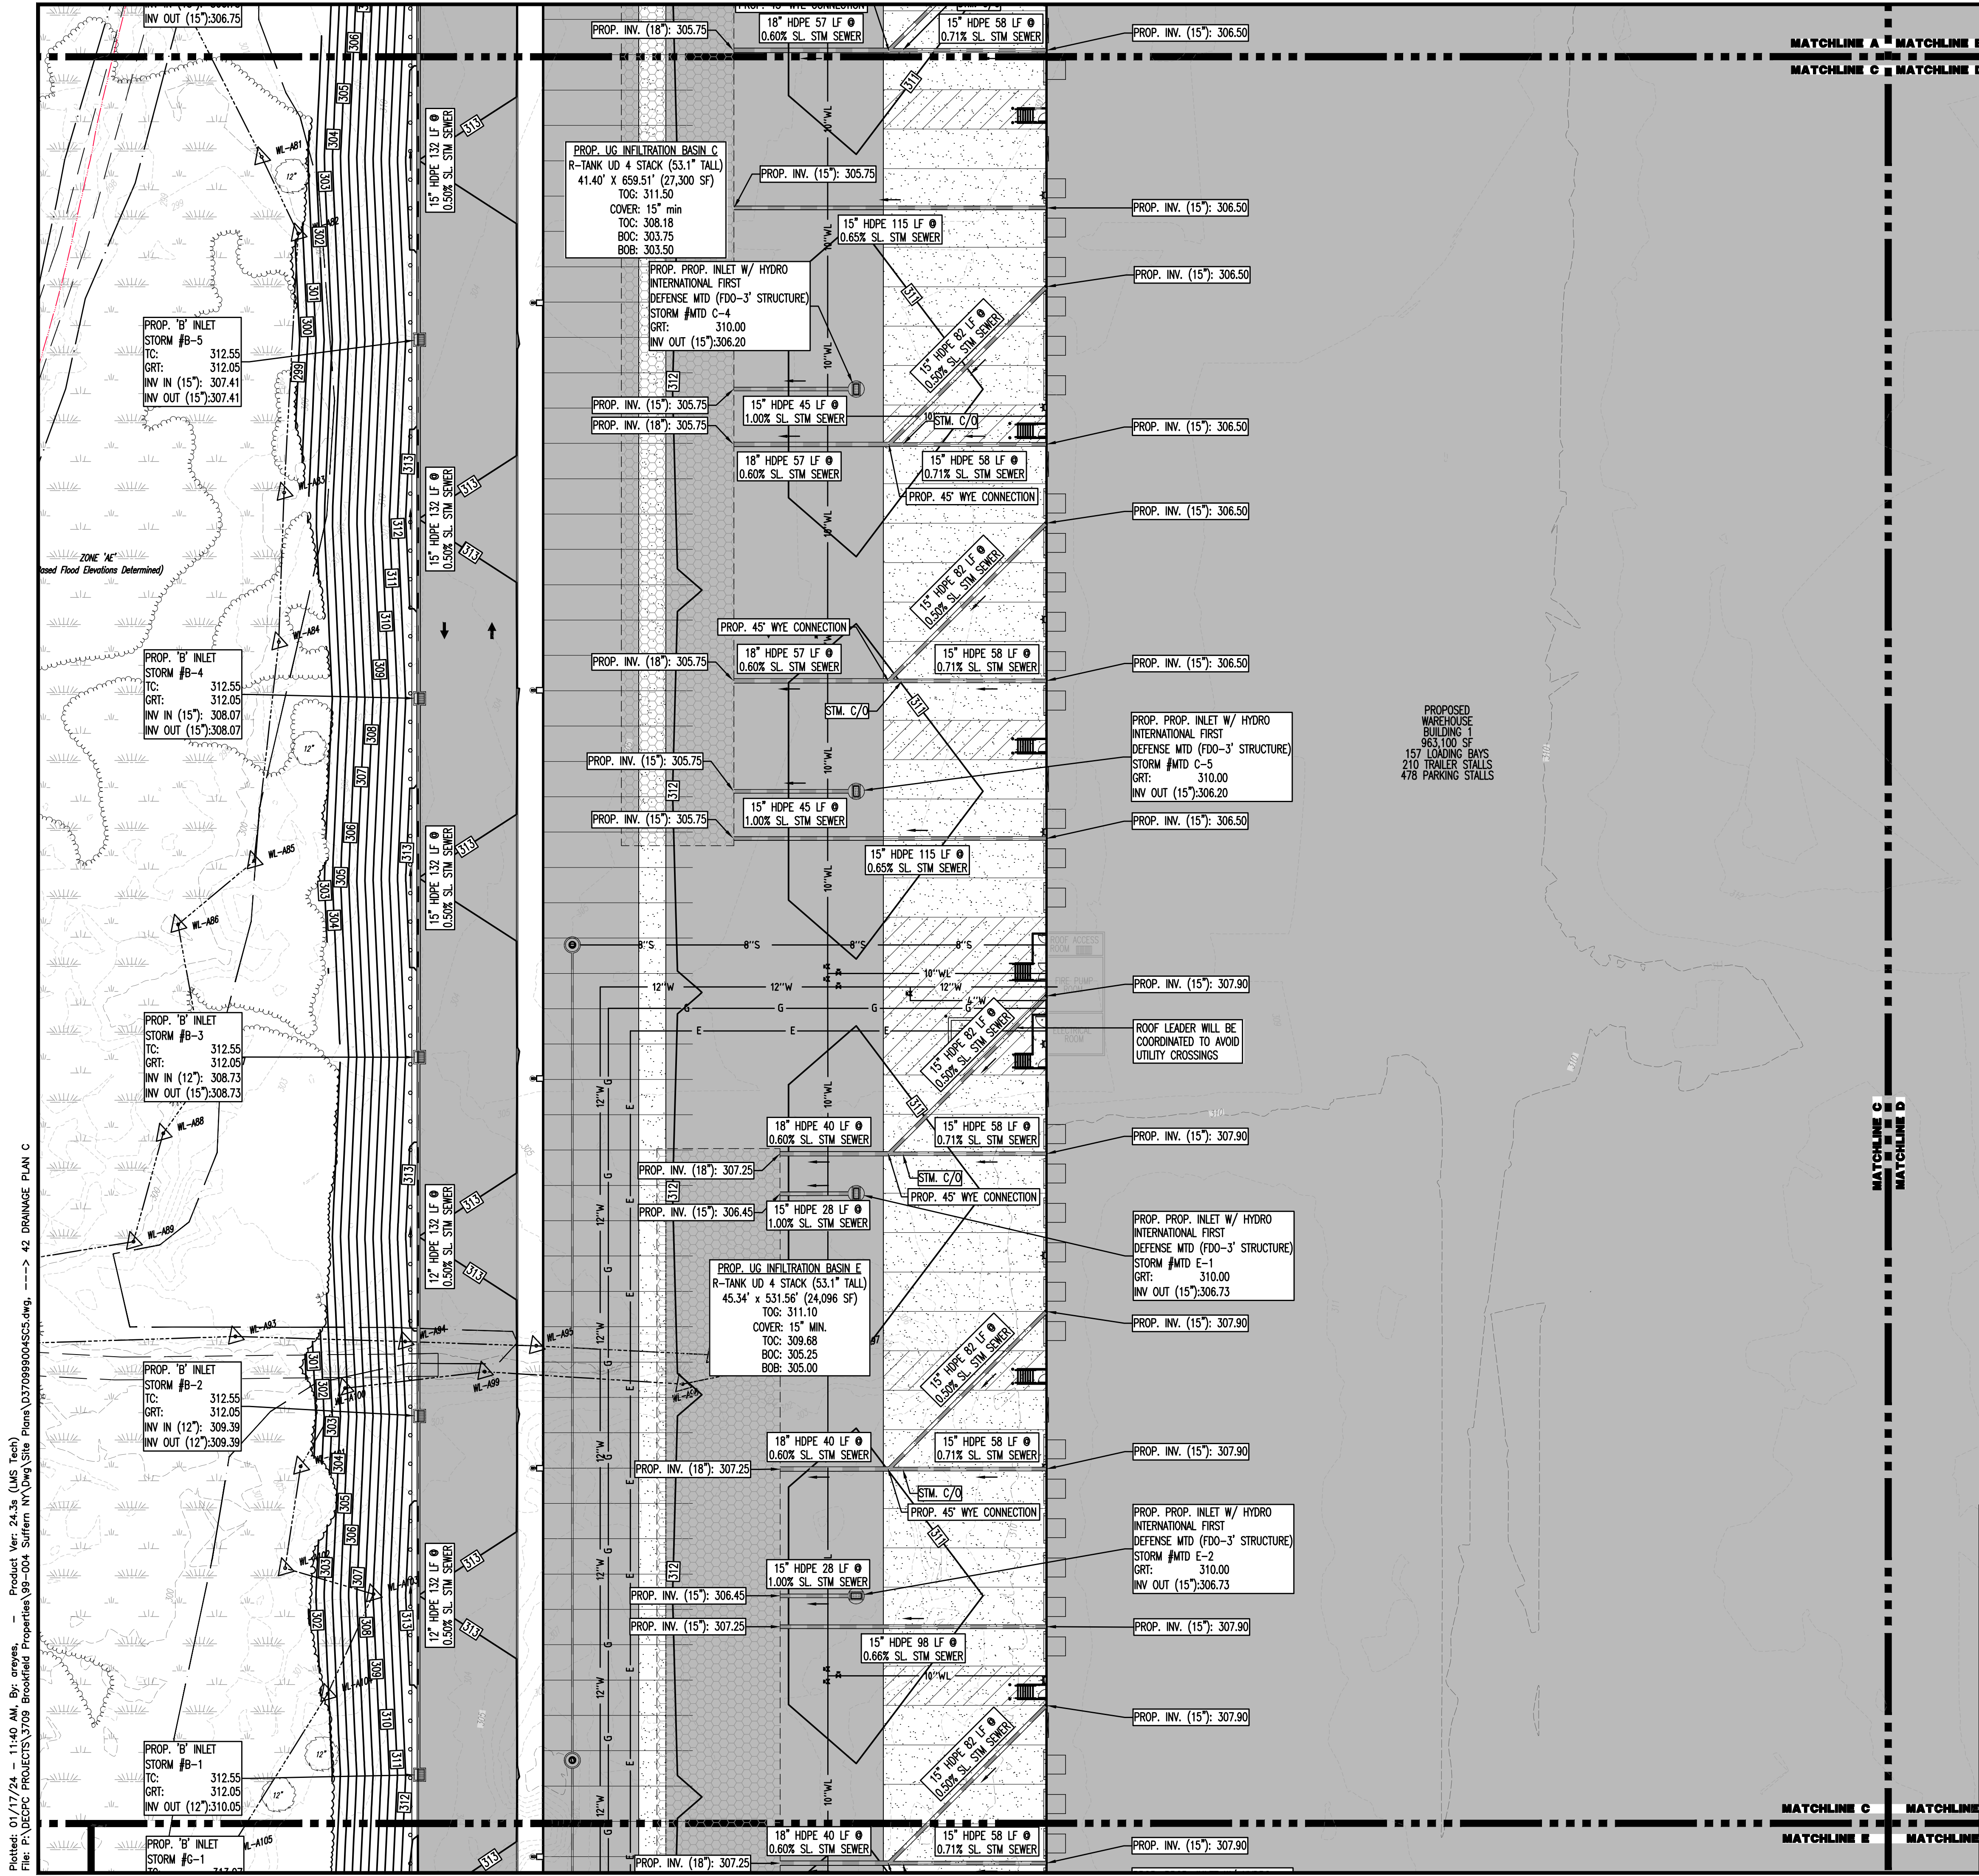

PAVEMENT LEGEND


[Symbol]	PROPOSED STANDARD PAVEMENT
[Symbol]	PROPOSED HEAVY DUTY PAVEMENT
[Symbol]	PROPOSED STANDARD CONCRETE
[Symbol]	PROPOSED HEAVY DUTY CONCRETE

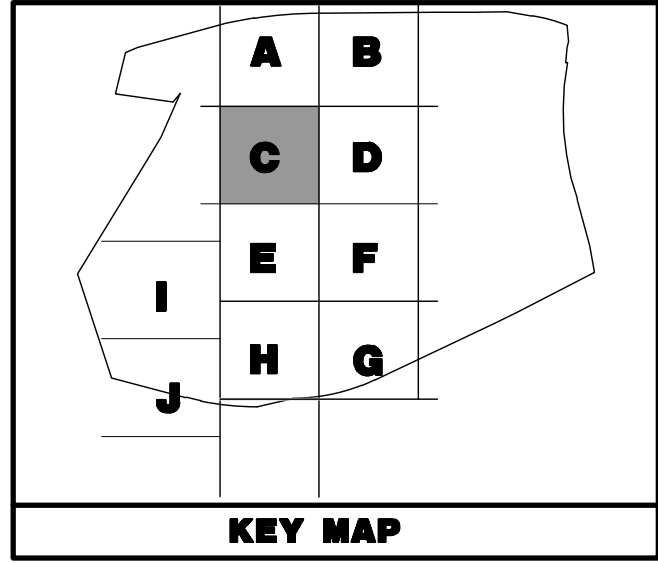

GRADING/UTILITY GRAPHIC LEGEND

[Symbol]	EXIST. CABLE LINE	[Symbol]	PROP. CABLE LINE
[Symbol]	EXIST. ELECTRIC LINE	[Symbol]	PROP. ELECTRIC LINE
[Symbol]	EXIST. FIBER OPTIC LINE	[Symbol]	PROP. FIBER OPTIC LINE
[Symbol]	EXIST. GAS LINE	[Symbol]	PROP. GAS LINE
[Symbol]	EXIST. OVERHEAD WIRES	[Symbol]	PROP. OVERHEAD WIRES
[Symbol]	EXIST. TELEPHONE LINE	[Symbol]	PROP. TELEPHONE LINE
[Symbol]	EXIST. UNDERGROUND ELEC./TELE. SERVICE (NO. & SIZE OF CONDUITS NOT DEFINED)	[Symbol]	PROP. UNDERGROUND ELEC./TELE. SERVICE (NO. & SIZE OF CONDUITS NOT DEFINED)
[Symbol]	EXIST. WATER LINE	[Symbol]	PROP. WATER LINE
[Symbol]	EXIST. SANITARY SEWER LINE	[Symbol]	PROP. SANITARY SEWER LINE
[Symbol]	EXIST. STORM DRAIN LINE	[Symbol]	PROP. STORM DRAIN LINE
[Symbol]	EXIST. MINOR CONTOUR & ELEVATION	[Symbol]	PROP. FINISH GRADE CONTOUR & ELEVATION
[Symbol]	EXIST. MAJOR CONTOUR & ELEVATION	[Symbol]	
[Symbol]	EXIST. MONITORING WELL	[Symbol]	
[Symbol]	APPROX. TEST PIT LOCATION	[Symbol]	
[Symbol]	EXIST. SPOT ELEVATIONS	[Symbol]	PROP. GRADE SPOT ELEV.
[Symbol]	EXIST. GUTTER ELEV.	[Symbol]	PROP. TOP OF CURB & FINISHED GRADE ELEV.
[Symbol]	EXIST. TOP OF CURB ELEV.	[Symbol]	PROP. FINISHED FLOOR ELEV.
[Symbol]	EXIST. FINISH FLOOR ELEV.	[Symbol]	PROP. TOP OF WALL & FINISHED GRADE @ LOW SIDE OF WALL (ACTUAL BOTTOM OF WALL FOOTING TO BE ESTABLISHED BY WALL DESIGNER)
[Symbol]	EXIST. GARAGE FLOOR ELEV.	[Symbol]	PROP. TOP OF EXTENDED CURB (9) FINISHED GRADE @ HIGH SIDE OF EXTENDED CURB & (2) FINISHED GRADE @ LOW SIDE OF EXTENDED CURB
[Symbol]	EXIST. FIRE HYDRANT	[Symbol]	
[Symbol]	EXIST. WATER VALVE	[Symbol]	PROP. DIRECTION OF DRAINAGE FLOW ARROW
[Symbol]	EXIST. GAS VALVE	[Symbol]	PROP. WATER VALVE
[Symbol]	EXIST. GAS METER	[Symbol]	PROP. GAS VALVE
[Symbol]	EXIST. ELECTRIC METER	[Symbol]	PROP. STORM CLEANOUT
[Symbol]	EXIST. ELECTRIC BOX	[Symbol]	PROP. SANITARY CLEANOUT
[Symbol]	EXIST. CLEAN OUT	[Symbol]	PROP. AREA LIGHT
[Symbol]	EXIST. WELL	[Symbol]	PROP. OUTLET CONTROL STRUCTURE
[Symbol]	EXIST. WATER SHUT OFF VALVE	[Symbol]	PROP. DRAINAGE MANHOLE
[Symbol]	EXIST. TELEPHONE BOX	[Symbol]	PROP. SANITARY SEWER MANHOLE
[Symbol]	EXIST. CABLE TV BOX	[Symbol]	PROP. "A" INLET
[Symbol]	EXIST. UTILITY POLE	[Symbol]	PROP. "B" INLET
[Symbol]	EXIST. GUY WIRE	[Symbol]	PROP. "C" INLET
[Symbol]	EXIST. LIGHT POLE	[Symbol]	PROP. YARD INLET
[Symbol]	EXIST. BUILDING LIGHT	[Symbol]	PROP. FLARED END SECTION
[Symbol]	EXIST. SHOE BOX LIGHT	[Symbol]	PROP. HEADWALL
[Symbol]	EXIST. COBRA LIGHT POLE	[Symbol]	
[Symbol]	EXIST. TRAFFIC SIGNAL POLE	[Symbol]	
[Symbol]	EXIST. MANHOLE	[Symbol]	
[Symbol]	EXIST. "A" INLET	[Symbol]	
[Symbol]	EXIST. "B" INLET	[Symbol]	
[Symbol]	EXIST. "C" INLET	[Symbol]	
[Symbol]	EXIST. YARD INLET	[Symbol]	
[Symbol]	EXIST. FLARED END SECTION	[Symbol]	
[Symbol]	EXIST. HEADWALL	[Symbol]	

SEE SHEET 03 OF 132 FOR DRAINAGE PLAN NOTES

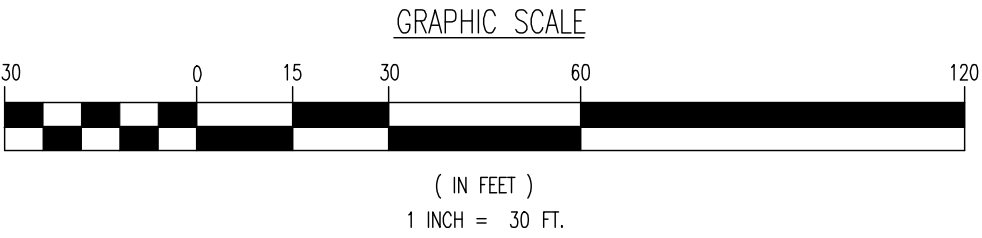

THIS PLAN SET IS FOR PERMITTING PURPOSES ONLY AND MAY NOT BE USED FOR CONSTRUCTION

DYNAMIC ENGINEERING

LAND DEVELOPMENT CONSULTING • PERMITTING • GEOTECHNICAL • ENVIRONMENTAL • SURVEY • PLANNING & ZONING

Lake Como, New Jersey 1-732-974-0198 | Chester, New Jersey 1-800-879-9229 | Newark, New Jersey 1-973-353-7200 | Toms River, New Jersey 1-732-478-0000
Allen, Texas 1-972-334-2100 | Austin, Texas 1-512-244-2044 | Houston, Texas 1-281-789-6400 | Delray Beach, Florida 1-561-921-8570
Newtown, Pennsylvania 1-282-683-0276 | Philadelphia, Pennsylvania 1-215-253-4868 | Southampton, Pennsylvania 1-610-298-4400

TITLE: **DRAINAGE PLAN C**

PROJECT: **IV2. ROCKLAND LOGISTICS, LLC
PROPOSED INDUSTRIAL PARK AT 25 OLD MILL ROAD**
SECTION 55.22 BLOCK 1, LOT 1; SECTION 55.37, BLOCK 1, LOT 31
OLD MILL ROAD AND HEMION ROAD (CR 93)
VILLAGE OF SUFFERN, ROCKLAND COUNTY, NEW YORK

JOB No: 3709-99-004
DATE: 12/17/2021
DRAWN BY: CAM
DESIGNED BY: JMS
CHECKED BY: JMS
CHECKED BY: ZAK

ZACHARY A. KAMM
PROFESSIONAL ENGINEER
NEW YORK LICENSE No. 107071

JOSHUA M. SNYDAL
PROFESSIONAL ENGINEER
NEW YORK LICENSE No. 61639

811
PROTECT YOURSELF
ALL STATES REQUIRE NOTIFICATION OF
UNDERGROUND UTILITIES. IF ANY UTILITY
PREPARED TO DIGGING THE SERVICE
OFFICE NUMBER IS 800-368-5848
FOR STATE SPECIFIC DIRECT PHONE NUMBERS VISIT:
WWW.CALL811.COM

42
OF 132
Rev. # 5