



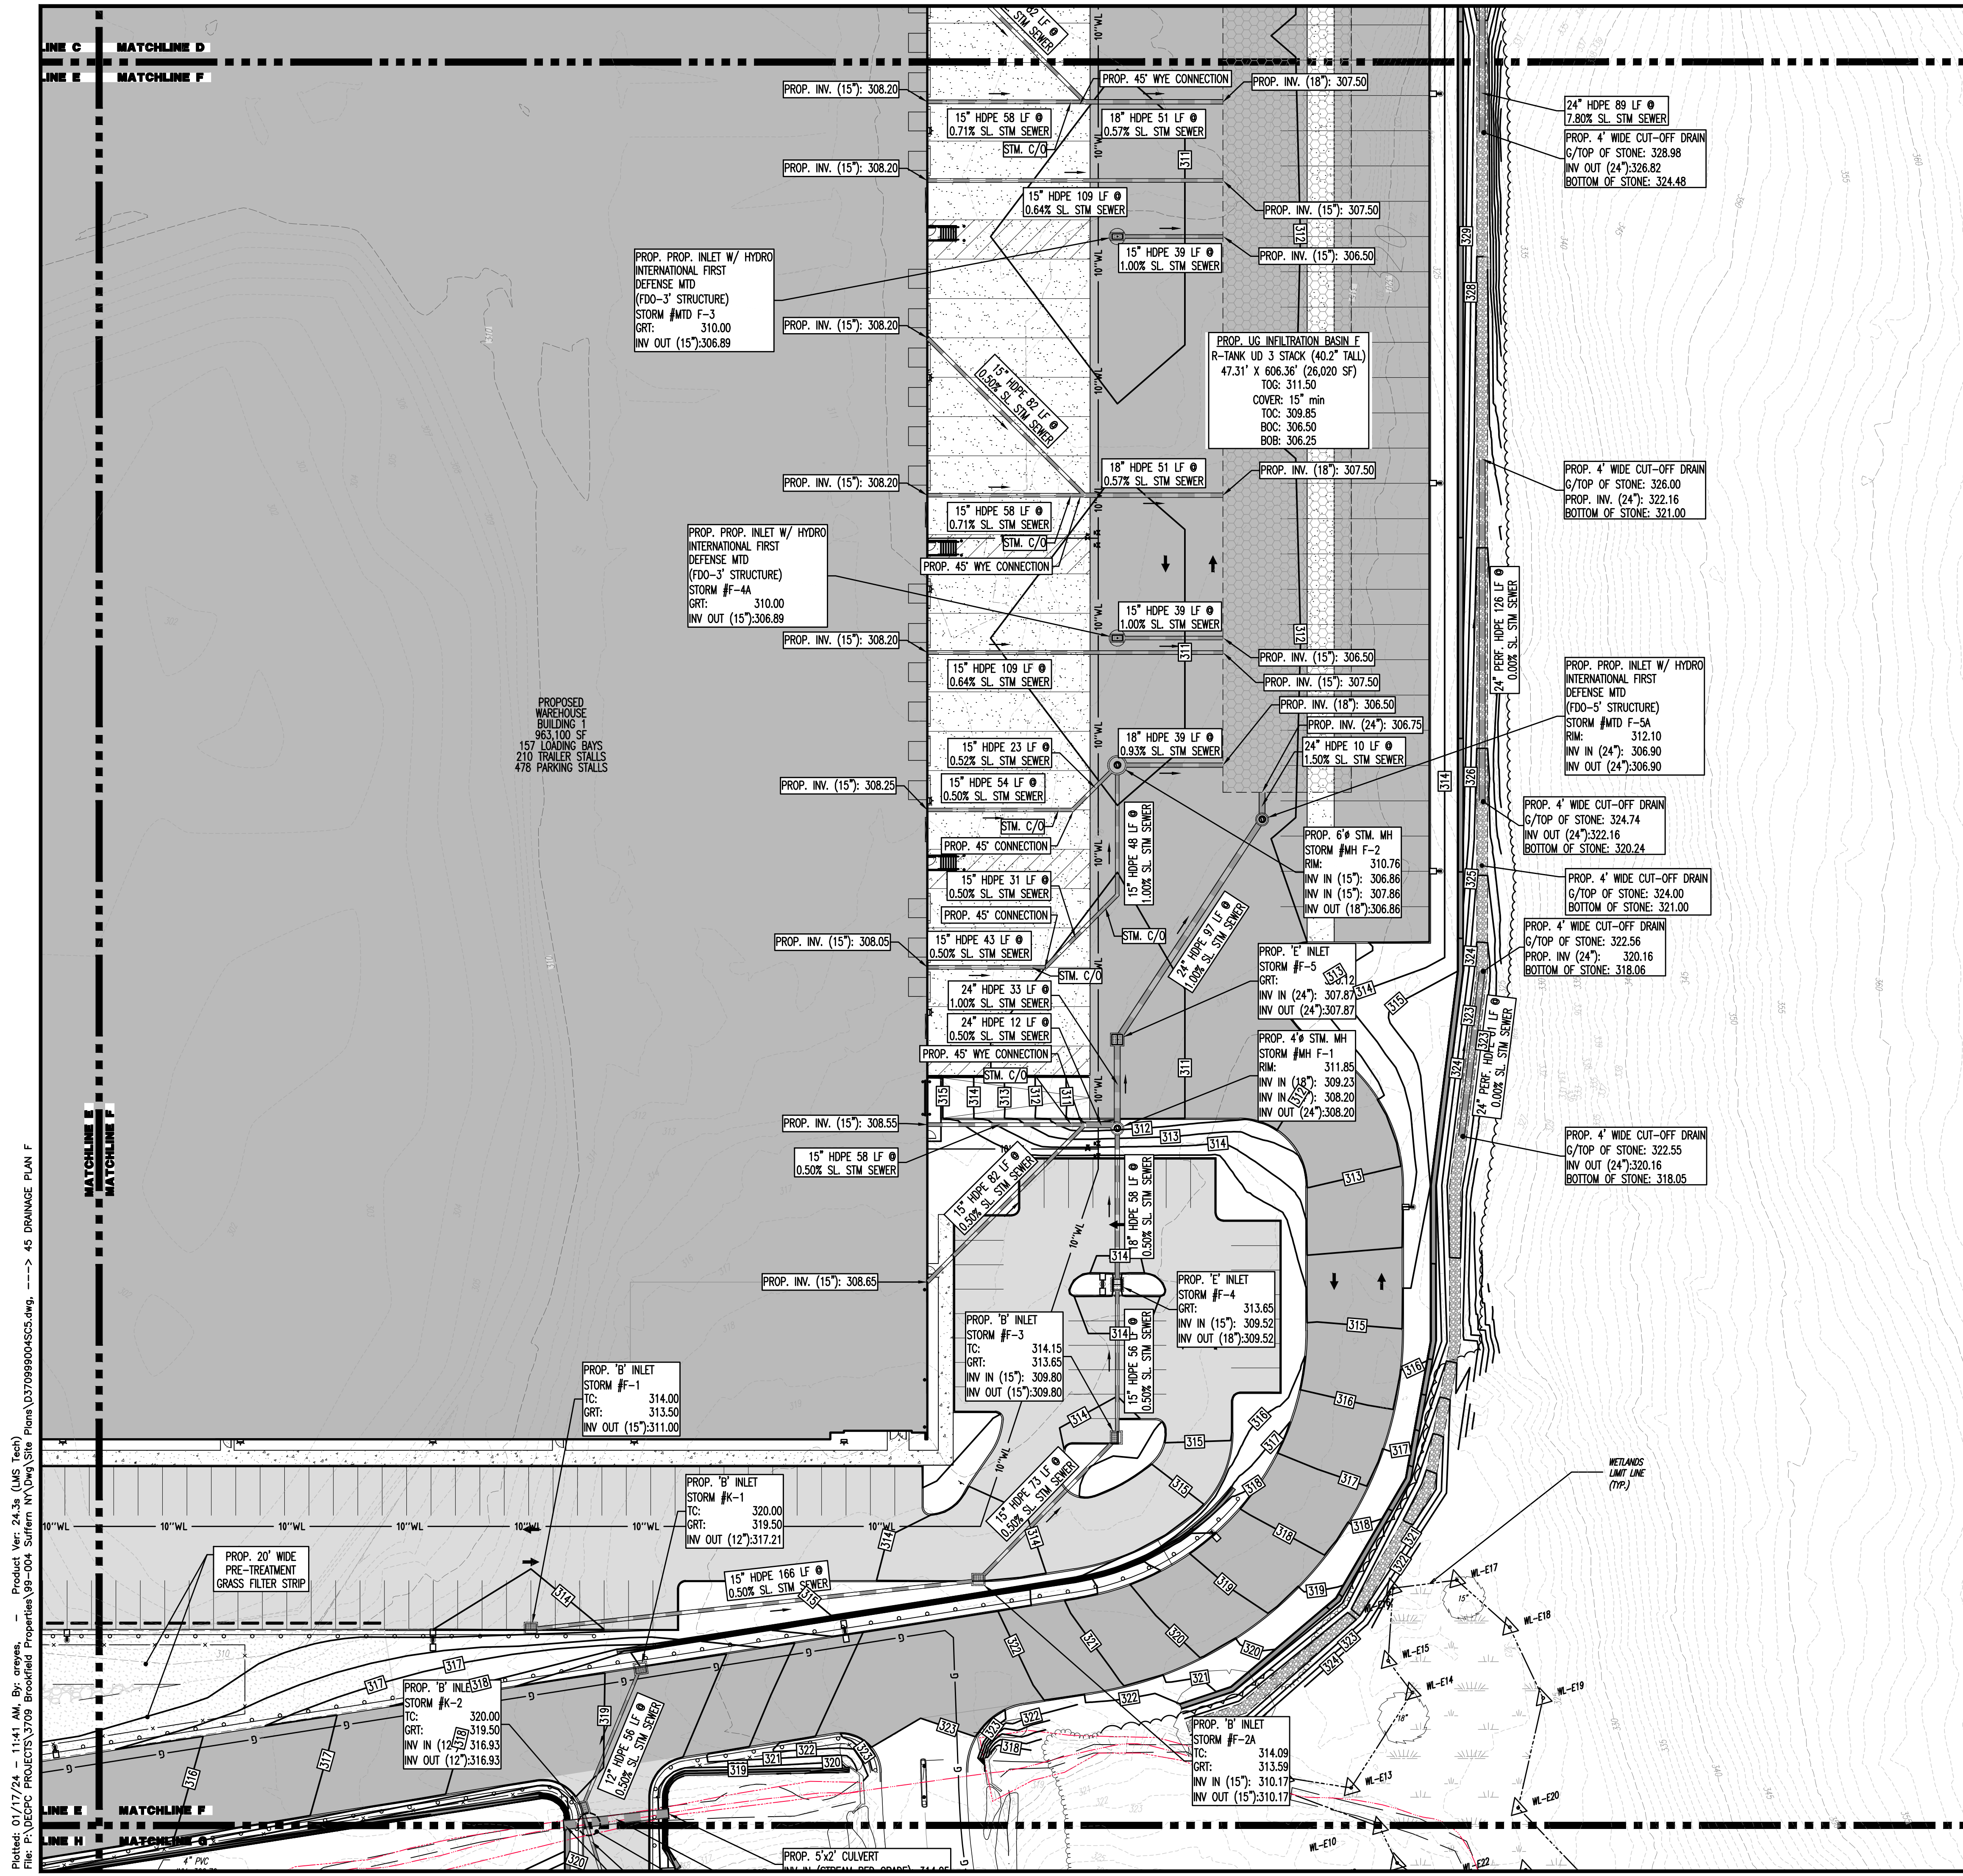

PAVEMENT LEGEND


[Pattern]	PROPOSED STANDARD PAVEMENT
[Pattern]	PROPOSED HEAVY DUTY PAVEMENT
[Pattern]	PROPOSED STANDARD CONCRETE
[Pattern]	PROPOSED HEAVY DUTY CONCRETE

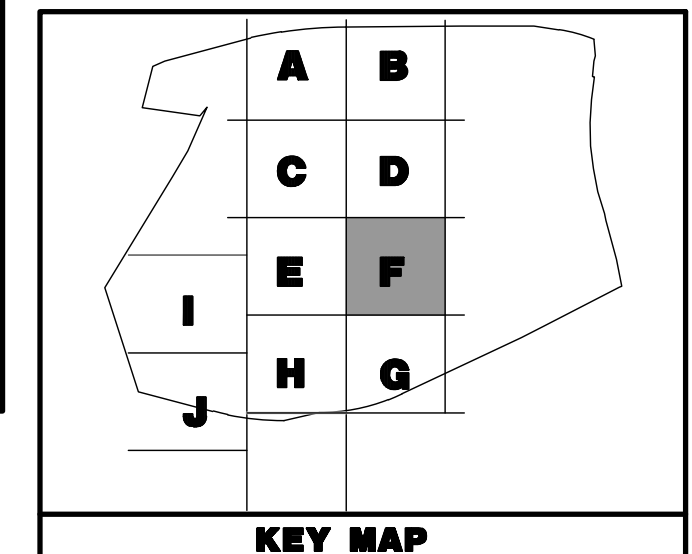

GRADING/UTILITY GRAPHIC LEGEND

[Symbol]	EXIST. CABLE LINE	[Symbol]	PROP. CABLE LINE
[Symbol]	EXIST. ELECTRIC LINE	[Symbol]	PROP. ELECTRIC LINE
[Symbol]	EXIST. FIBER OPTIC LINE	[Symbol]	PROP. FIBER OPTIC LINE
[Symbol]	EXIST. GAS LINE	[Symbol]	PROP. GAS LINE
[Symbol]	EXIST. OVERHEAD WIRES	[Symbol]	PROP. OVERHEAD WIRES
[Symbol]	EXIST. TELEPHONE LINE	[Symbol]	PROP. TELEPHONE LINE
[Symbol]	EXIST. UNDERGROUND ELEC./TELE. SERVICE (NO. & SIZE OF CONDUITS NOT DEFINED)	[Symbol]	PROP. UNDERGROUND ELEC./TELE. SERVICE (NO. & SIZE OF CONDUITS NOT DEFINED)
[Symbol]	EXIST. WATER LINE	[Symbol]	PROP. WATER LINE
[Symbol]	EXIST. SANITARY SEWER LINE	[Symbol]	PROP. SANITARY SEWER LINE
[Symbol]	EXIST. STORM DRAIN LINE	[Symbol]	PROP. STORM DRAIN LINE
[Symbol]	EXIST. MINOR CONTOUR & ELEVATION	[Symbol]	PROP. FINISH GRADE CONTOUR & ELEVATION
[Symbol]	EXIST. MAJOR CONTOUR & ELEVATION	[Symbol]	PROP. FINISH GRADE CONTOUR & ELEVATION
[Symbol]	EXIST. MONITORING WELL	[Symbol]	PROP. GRADE SPOT ELEV.
[Symbol]	APPROX. TEST PIT LOCATION	[Symbol]	PROP. TOP OF CURB & FINISHED GRADE ELEV.
[Symbol]	EXIST. SPOT ELEVATIONS	[Symbol]	PROP. FINISHED FLOOR ELEV.
[Symbol]	EXIST. GUTTER ELEV.	[Symbol]	PROP. TOP OF WALL & FINISHED GRADE @ LOW SIDE OF WALL (ACTUAL BOTTOM OF WALL FOOTING TO BE ESTABLISHED BY WALL DESIGNER)
[Symbol]	EXIST. TOP OF CURB ELEV.	[Symbol]	PROP. TOP OF EXTENDED CURB (Q1) FINISHED GRADE @ HIGH SIDE OF EXTENDED CURB & (Q2) FINISHED GRADE @ LOW SIDE OF EXTENDED CURB
[Symbol]	EXIST. FINISH FLOOR ELEV.	[Symbol]	PROP. DIRECTION OF DRAINAGE FLOW ARROW
[Symbol]	EXIST. GARAGE FLOOR ELEV.	[Symbol]	PROP. WATER VALVE
[Symbol]	EXIST. FIRE HYDRANT	[Symbol]	PROP. GAS VALVE
[Symbol]	EXIST. WATER VALVE	[Symbol]	PROP. STORM CLEANOUT
[Symbol]	EXIST. GAS VALVE	[Symbol]	PROP. SANITARY CLEANOUT
[Symbol]	EXIST. GAS METER	[Symbol]	PROP. AREA LIGHT
[Symbol]	EXIST. ELECTRIC METER	[Symbol]	PROP. OUTLET CONTROL STRUCTURE
[Symbol]	EXIST. ELECTRIC BOX	[Symbol]	PROP. DRAINAGE MANHOLE
[Symbol]	EXIST. CLEAN OUT	[Symbol]	PROP. SANITARY SEWER MANHOLE
[Symbol]	EXIST. WELL	[Symbol]	PROP. 'A' INLET
[Symbol]	EXIST. WATER SHUT OFF VALVE	[Symbol]	PROP. 'B' INLET
[Symbol]	EXIST. TELEPHONE BOX	[Symbol]	PROP. 'E' INLET
[Symbol]	EXIST. CABLE TV BOX	[Symbol]	PROP. YARD INLET
[Symbol]	EXIST. UTILITY POLE	[Symbol]	PROP. FLARED END SECTION
[Symbol]	EXIST. GUY WIRE	[Symbol]	PROP. HEADWALL
[Symbol]	EXIST. LIGHT POLE	[Symbol]	
[Symbol]	EXIST. BUILDING LIGHT	[Symbol]	
[Symbol]	EXIST. SHOE BOX LIGHT	[Symbol]	
[Symbol]	EXIST. COBRA LIGHT POLE	[Symbol]	
[Symbol]	EXIST. TRAFFIC SIGNAL POLE	[Symbol]	
[Symbol]	EXIST. MANHOLE	[Symbol]	
[Symbol]	EXIST. 'A' INLET	[Symbol]	
[Symbol]	EXIST. 'B' INLET	[Symbol]	
[Symbol]	EXIST. 'E' INLET	[Symbol]	
[Symbol]	EXIST. YARD INLET	[Symbol]	
[Symbol]	EXIST. FLARED END SECTION	[Symbol]	
[Symbol]	EXIST. HEADWALL	[Symbol]	

SEE SHEET 03 OF 132 FOR DRAINAGE PLAN NOTES

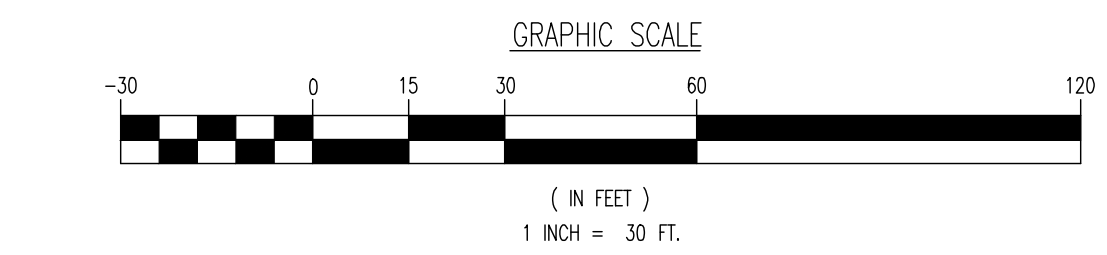

(IN FEET)
1 INCH = 30 FT.

THIS PLAN SET IS FOR PERMITTING PURPOSES ONLY AND MAY NOT BE USED FOR CONSTRUCTION

DYNAMIC ENGINEERING
LAND DEVELOPMENT CONSULTING • PERMITTING • GEOTECHNICAL • ENVIRONMENTAL • SURVEY • PLANNING & ZONING

1954 Main Street
Lake Como, NJ 07719
T: 732.974.0198
F: 732.974.3521
www.dynamiceng.com

PROJECT: **IV2. ROCKLAND LOGISTICS, LLC**
PROPOSED INDUSTRIAL PARK AT 25 OLD MILL ROAD
SECTION 55.22 BLOCK 1, LOT 1; SECTION 55.37, BLOCK 1, LOT 31
OLD MILL ROAD AND HEMION ROAD (CR 93)
VILLAGE OF SUFFERN, ROCKLAND COUNTY, NEW YORK

TITLE: **DRAINAGE PLAN F**

DESIGNED BY: JMS
CHECKED BY: JMS
ZAK

DATE: 12/17/2021
SCALE: (H) 1"=30'
(V) 1"=10'

SHEET No: **45**
OF 132

Rev. # 5

PROFESSIONAL ENGINEER
NEW YORK LICENSE No. 107071

PROFESSIONAL ENGINEER
NEW YORK LICENSE No. 107071

PROFESSIONAL ENGINEER
NEW YORK LICENSE No. 107071

PROTECT YOURSELF
ALL STATES REQUIRE REGISTRATION OF CONTRACTS, AGREEMENTS, OR ANY OTHER INSTRUMENTS TO BE USED IN THE STATE OF NEW YORK.
FOR STATE SPECIFIC DIRECT PHONE NUMBERS VISIT: WWW.CALL811.COM

Plotted: 01/17/24 - 11:41 AM, By: areyes, Product Ver: 24.3s (LMS Tech)
File: P:\DEPC PROJECTS\3709 Brookfield Projects\370909004SC5.dwg, ---> 45 DRAINAGE PLAN F