


Plotted: 01/17/24 - 11:43 AM, By: areyes, - Product Ver: 24.3s (JMS Tech)
File: P:\VEPC PROJECTS\3709 Brookfield Properties\99-004 Suffern NY\DWG\Site Plans\370909004SU5.dwg, ----> 52 UTILITY PLAN B

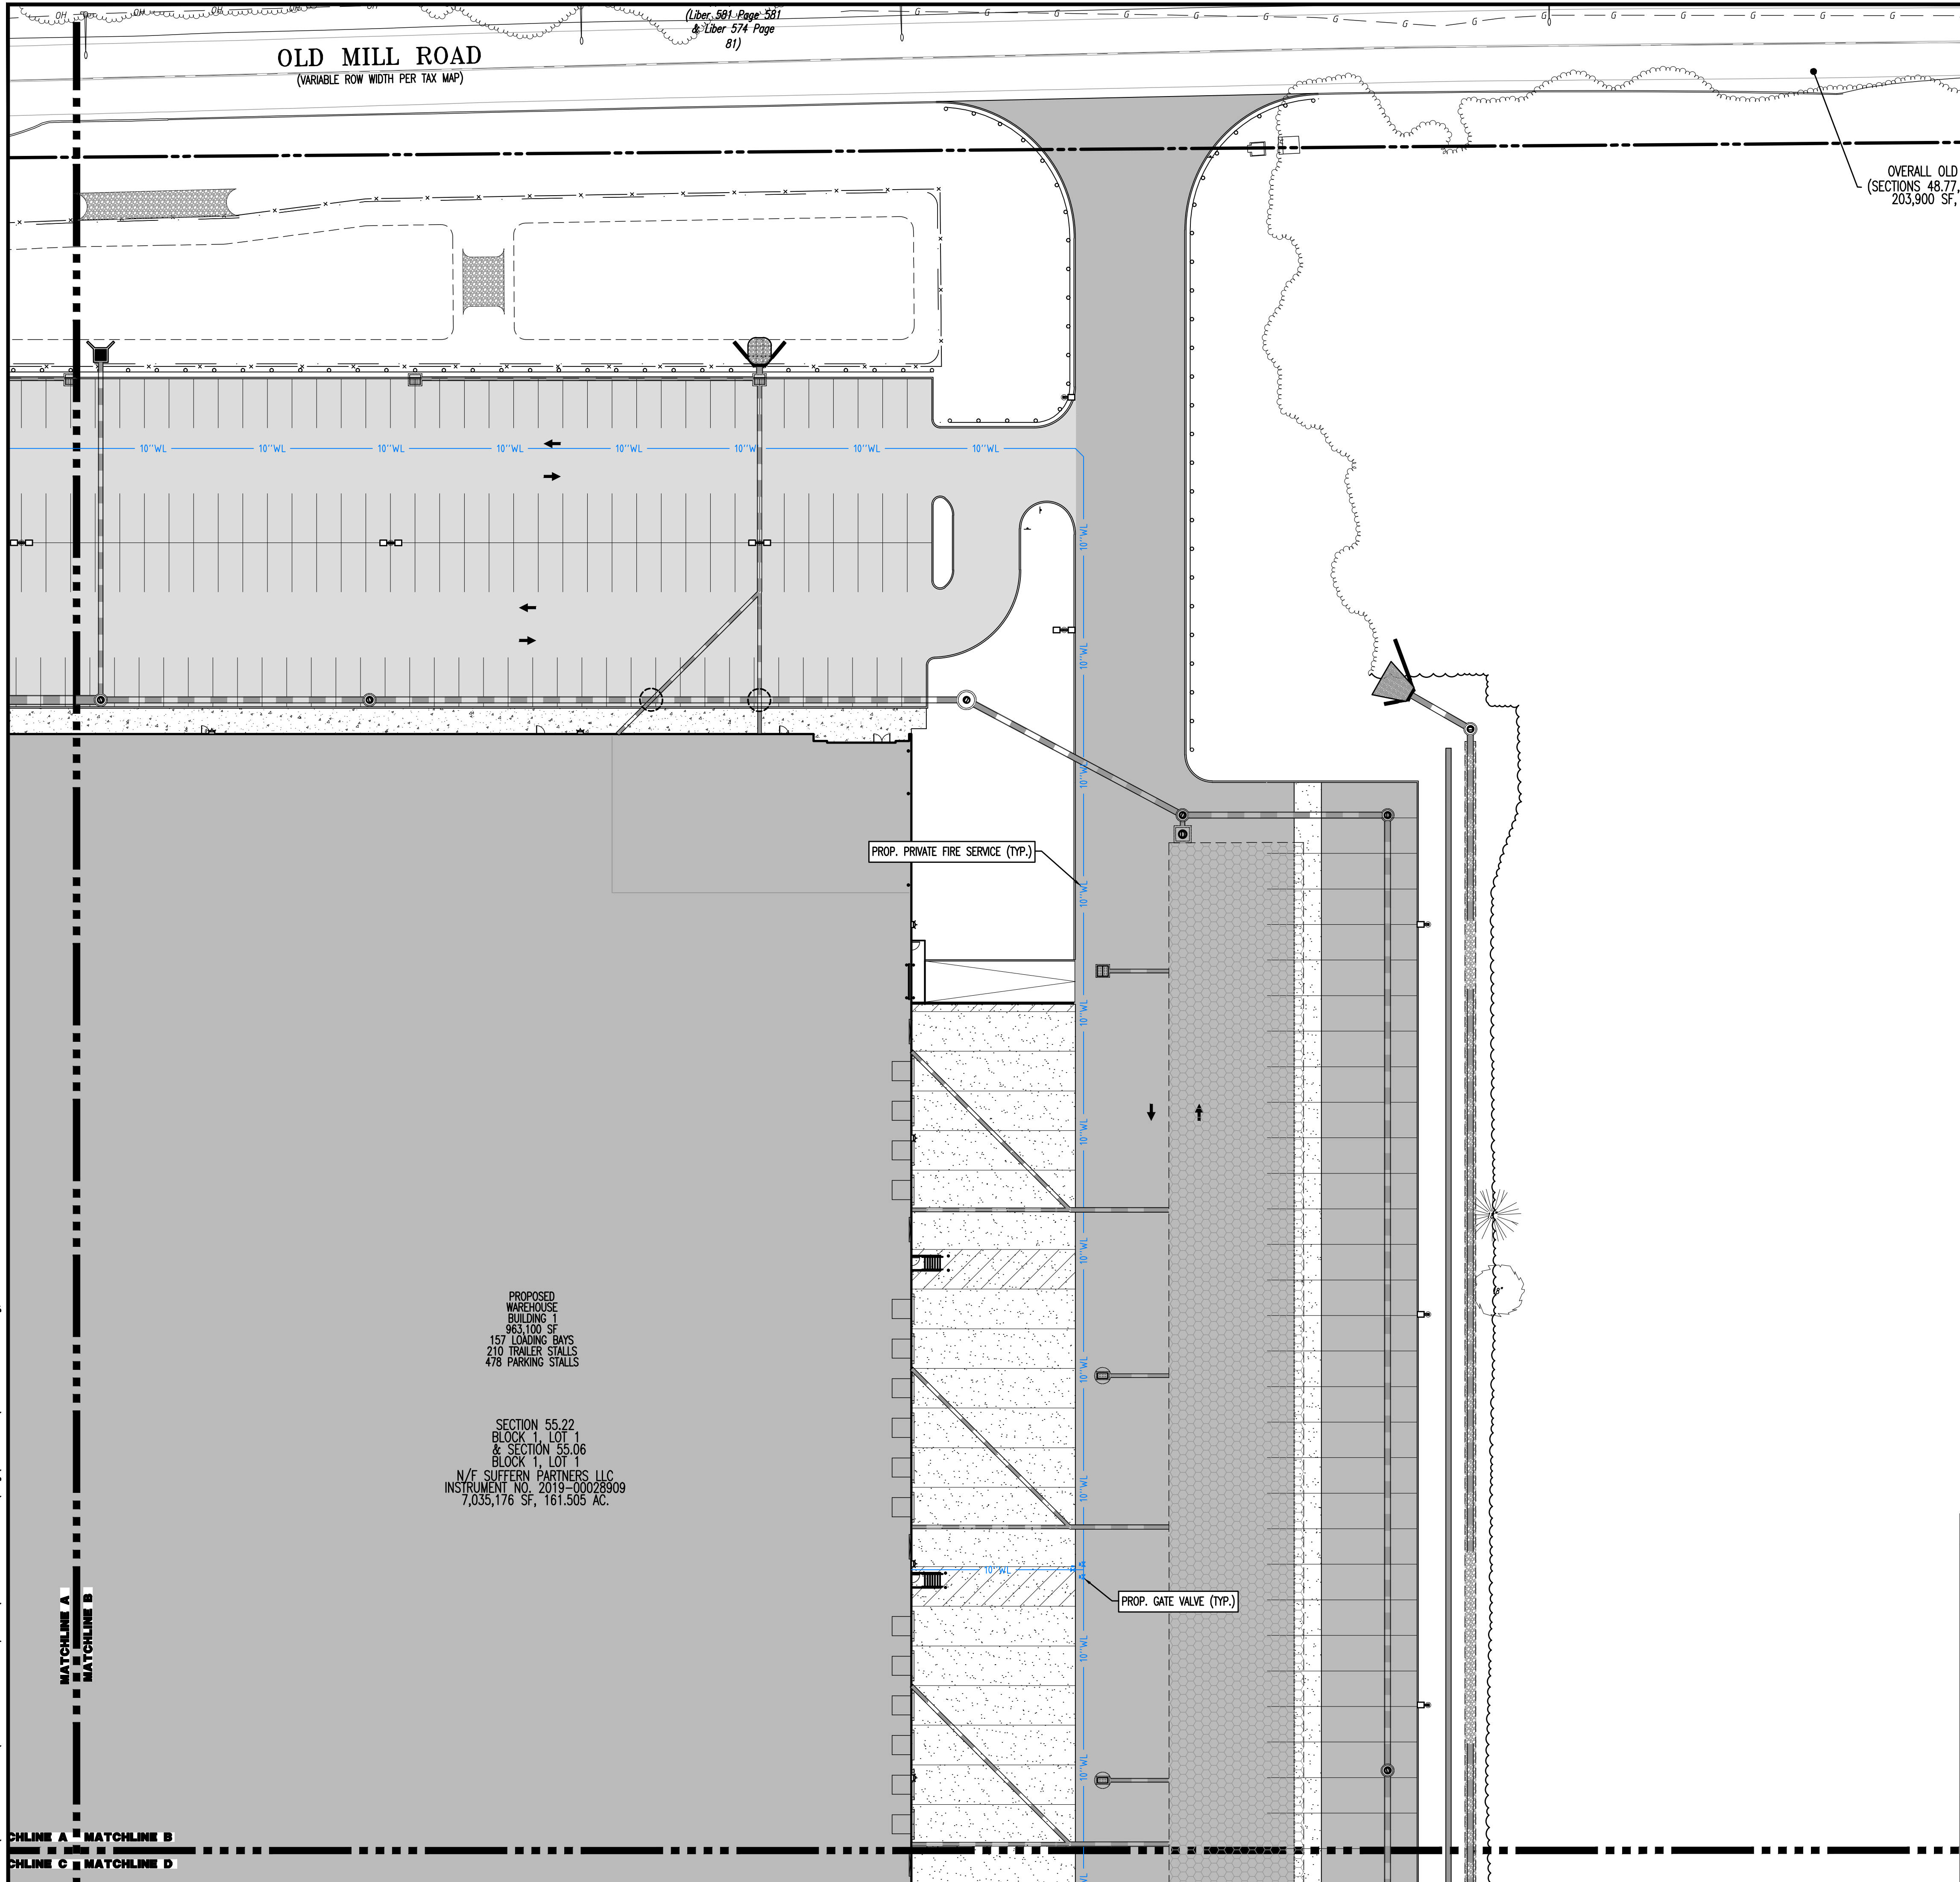


PAVEMENT LEGEND

[Symbol]	PROPOSED STANDARD PAVEMENT
[Symbol]	PROPOSED HEAVY DUTY PAVEMENT
[Symbol]	PROPOSED STANDARD CONCRETE
[Symbol]	PROPOSED HEAVY DUTY CONCRETE

KEY MAP


A	B
C	D
E	F
I	H
J	G

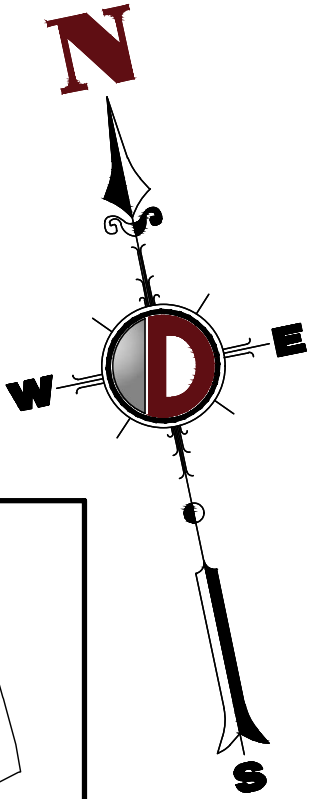

GRADING/UTILITY GRAPHIC LEGEND

[Symbol]	EXIST. CABLE LINE	[Symbol]	PROP. CABLE LINE
[Symbol]	EXIST. ELECTRIC LINE	[Symbol]	PROP. ELECTRIC LINE
[Symbol]	EXIST. FIBER OPTIC LINE	[Symbol]	PROP. FIBER OPTIC LINE
[Symbol]	EXIST. GAS LINE	[Symbol]	PROP. GAS LINE
[Symbol]	EXIST. OVERHEAD WIRES	[Symbol]	PROP. OVERHEAD WIRES
[Symbol]	EXIST. TELEPHONE LINE	[Symbol]	PROP. TELEPHONE LINE
[Symbol]	EXIST. UNDERGROUND ELEC./TELE. SERVICE (NO. & SIZE OF CONDUITS NOT DEFINED)	[Symbol]	PROP. UNDERGROUND ELEC./TELE. SERVICE (NO. & SIZE OF CONDUITS NOT DEFINED)
[Symbol]	EXIST. WATER LINE	[Symbol]	PROP. WATER LINE
[Symbol]	EXIST. SANITARY SEWER LINE	[Symbol]	PROP. SANITARY SEWER LINE
[Symbol]	EXIST. STORM DRAIN LINE	[Symbol]	PROP. STORM DRAIN LINE
[Symbol]	EXIST. MINOR CONTOUR & ELEVATION	[Symbol]	PROP. FINISH GRADE CONTOUR & ELEVATION
[Symbol]	EXIST. MAJOR CONTOUR & ELEVATION		
[Symbol]	EXIST. MONITORING WELL		
[Symbol]	APPROX. TEST PIT LOCATION		
[Symbol]	EXIST. SPOT ELEVATIONS	[Symbol]	PROP. GRADE SPOT ELEV.
[Symbol]	EXIST. GUTTER ELEV.	[Symbol]	PROP. TOP OF CURB & FINISHED GRADE ELEV.
[Symbol]	EXIST. TOP OF CURB ELEV.	[Symbol]	PROP. FINISHED FLOOR ELEV.
[Symbol]	EXIST. FINISH FLOOR ELEV.	[Symbol]	PROP. TOP OF WALL & FINISHED GRADE @ LOW SIDE OF WALL (ACTUAL BOTTOM OF WALL FOOTING TO BE ESTABLISHED BY WALL DESIGNER)
[Symbol]	EXIST. GARAGE FLOOR ELEV.	[Symbol]	PROP. TOP OF EXTENDED CURB (Q1) FINISHED GRADE @ HIGH SIDE OF EXTENDED CURB & (Q2) FINISHED GRADE @ LOW SIDE OF EXTENDED CURB
[Symbol]	EXIST. FIRE HYDRANT	[Symbol]	PROP. DIRECTION OF DRAINAGE FLOW ARROW
[Symbol]	EXIST. WATER VALVE	[Symbol]	PROP. WATER VALVE
[Symbol]	EXIST. GAS METER	[Symbol]	PROP. GAS VALVE
[Symbol]	EXIST. ELECTRIC METER	[Symbol]	PROP. STORM CLEANOUT
[Symbol]	EXIST. ELECTRIC BOX	[Symbol]	PROP. SANITARY CLEANOUT
[Symbol]	EXIST. CLEAN OUT	[Symbol]	PROP. AREA LIGHT
[Symbol]	EXIST. WELL	[Symbol]	PROP. OUTLET CONTROL STRUCTURE
[Symbol]	EXIST. WATER SHUT OFF VALVE	[Symbol]	PROP. DRAINAGE MANHOLE
[Symbol]	EXIST. TELEPHONE BOX	[Symbol]	PROP. SANITARY SEWER MANHOLE
[Symbol]	EXIST. CABLE TV BOX	[Symbol]	PROP. "A" INLET
[Symbol]	EXIST. UTILITY POLE	[Symbol]	PROP. "B" INLET
[Symbol]	EXIST. GUY WIRE	[Symbol]	PROP. "C" INLET
[Symbol]	EXIST. LIGHT POLE	[Symbol]	PROP. YARD INLET
[Symbol]	EXIST. BUILDING LIGHT	[Symbol]	PROP. FLARED END SECTION
[Symbol]	EXIST. SHOE BOX LIGHT	[Symbol]	PROP. HEADWALL
[Symbol]	EXIST. COBRA LIGHT POLE		
[Symbol]	EXIST. TRAFFIC SIGNAL POLE		
[Symbol]	EXIST. MANHOLE		
[Symbol]	EXIST. "A" INLET		
[Symbol]	EXIST. "B" INLET		
[Symbol]	EXIST. "C" INLET		
[Symbol]	EXIST. YARD INLET		
[Symbol]	EXIST. FLARED END SECTION		
[Symbol]	EXIST. HEADWALL		

SEE SHEET 03 OF 132 FOR UTILITY PLAN NOTES

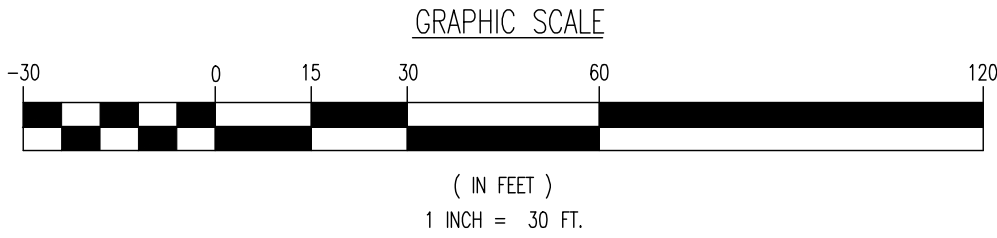

THIS PLAN SET IS FOR PERMITTING PURPOSES ONLY AND MAY NOT BE USED FOR CONSTRUCTION

DYNAMIC ENGINEERING
LAND DEVELOPMENT CONSULTING • PERMITTING • GEOTECHNICAL • ENVIRONMENTAL • SURVEY • PLANNING & ZONING

1954 Main Street
Lake Como, NJ 07719
T: 732.974.0198
F: 732.974.3521
www.dynamiceng.com

LAKE COMO, NEW JERSEY T: 732.974.0198 | CHESTER, NEW JERSEY T: 908.879.9229 | NEWARK, NEW JERSEY T: 973.755.7200 | TOMS RIVER, NEW JERSEY T: 732.478.0000
ALLEN, TEXAS T: 972.534.2100 | AUSTIN, TEXAS T: 512.244.2044 | HOUSTON, TEXAS T: 281.789.6400 | DELRAY BEACH, FLORIDA T: 561.921.8570
NEWTON, PENNSYLVANIA T: 267.683.0276 | PHILADELPHIA, PENNSYLVANIA T: 215.253.4568 | SEAFORD, PENNSYLVANIA T: 610.295.4400

TITLE: **UTILITY PLAN B**

PROJECT: **IV2. ROCKLAND LOGISTICS, LLC
PROPOSED INDUSTRIAL PARK AT 25 OLD MILL ROAD**
SECTION 55.22 BLOCK 1, LOT 1; SECTION 55.37, BLOCK 1, LOT 31
OLD MILL ROAD AND HEMION ROAD (CR 93)
VILLAGE OF SUFFERN, ROCKLAND COUNTY, NEW YORK

JOB No: 3709-99-004
DATE: 12/17/2021
DRAWN BY: CAM
SCALE: (H) 1"=30' (V)
DESIGNED BY: JMS
SHEET No:
CHECKED BY: JMS
ZAK

ZACHARY A. KAMM
PROFESSIONAL ENGINEER
NEW YORK LICENSE NO. 107071

JOSHUA M. SNYDAL
PROFESSIONAL ENGINEER
NEW YORK LICENSE NO. 61639

811
PROTECT YOURSELF
ALL STATES REQUIRE NOTIFICATION OF
CONCRETE, REBAR, OR ANY OTHER
PREPARED TO ORDER THE SERVICE
FOR STATE SPECIFIC
DIRECT PHONE NUMBERS VISIT:
WWW.CALL811.COM

Rev. # 5