


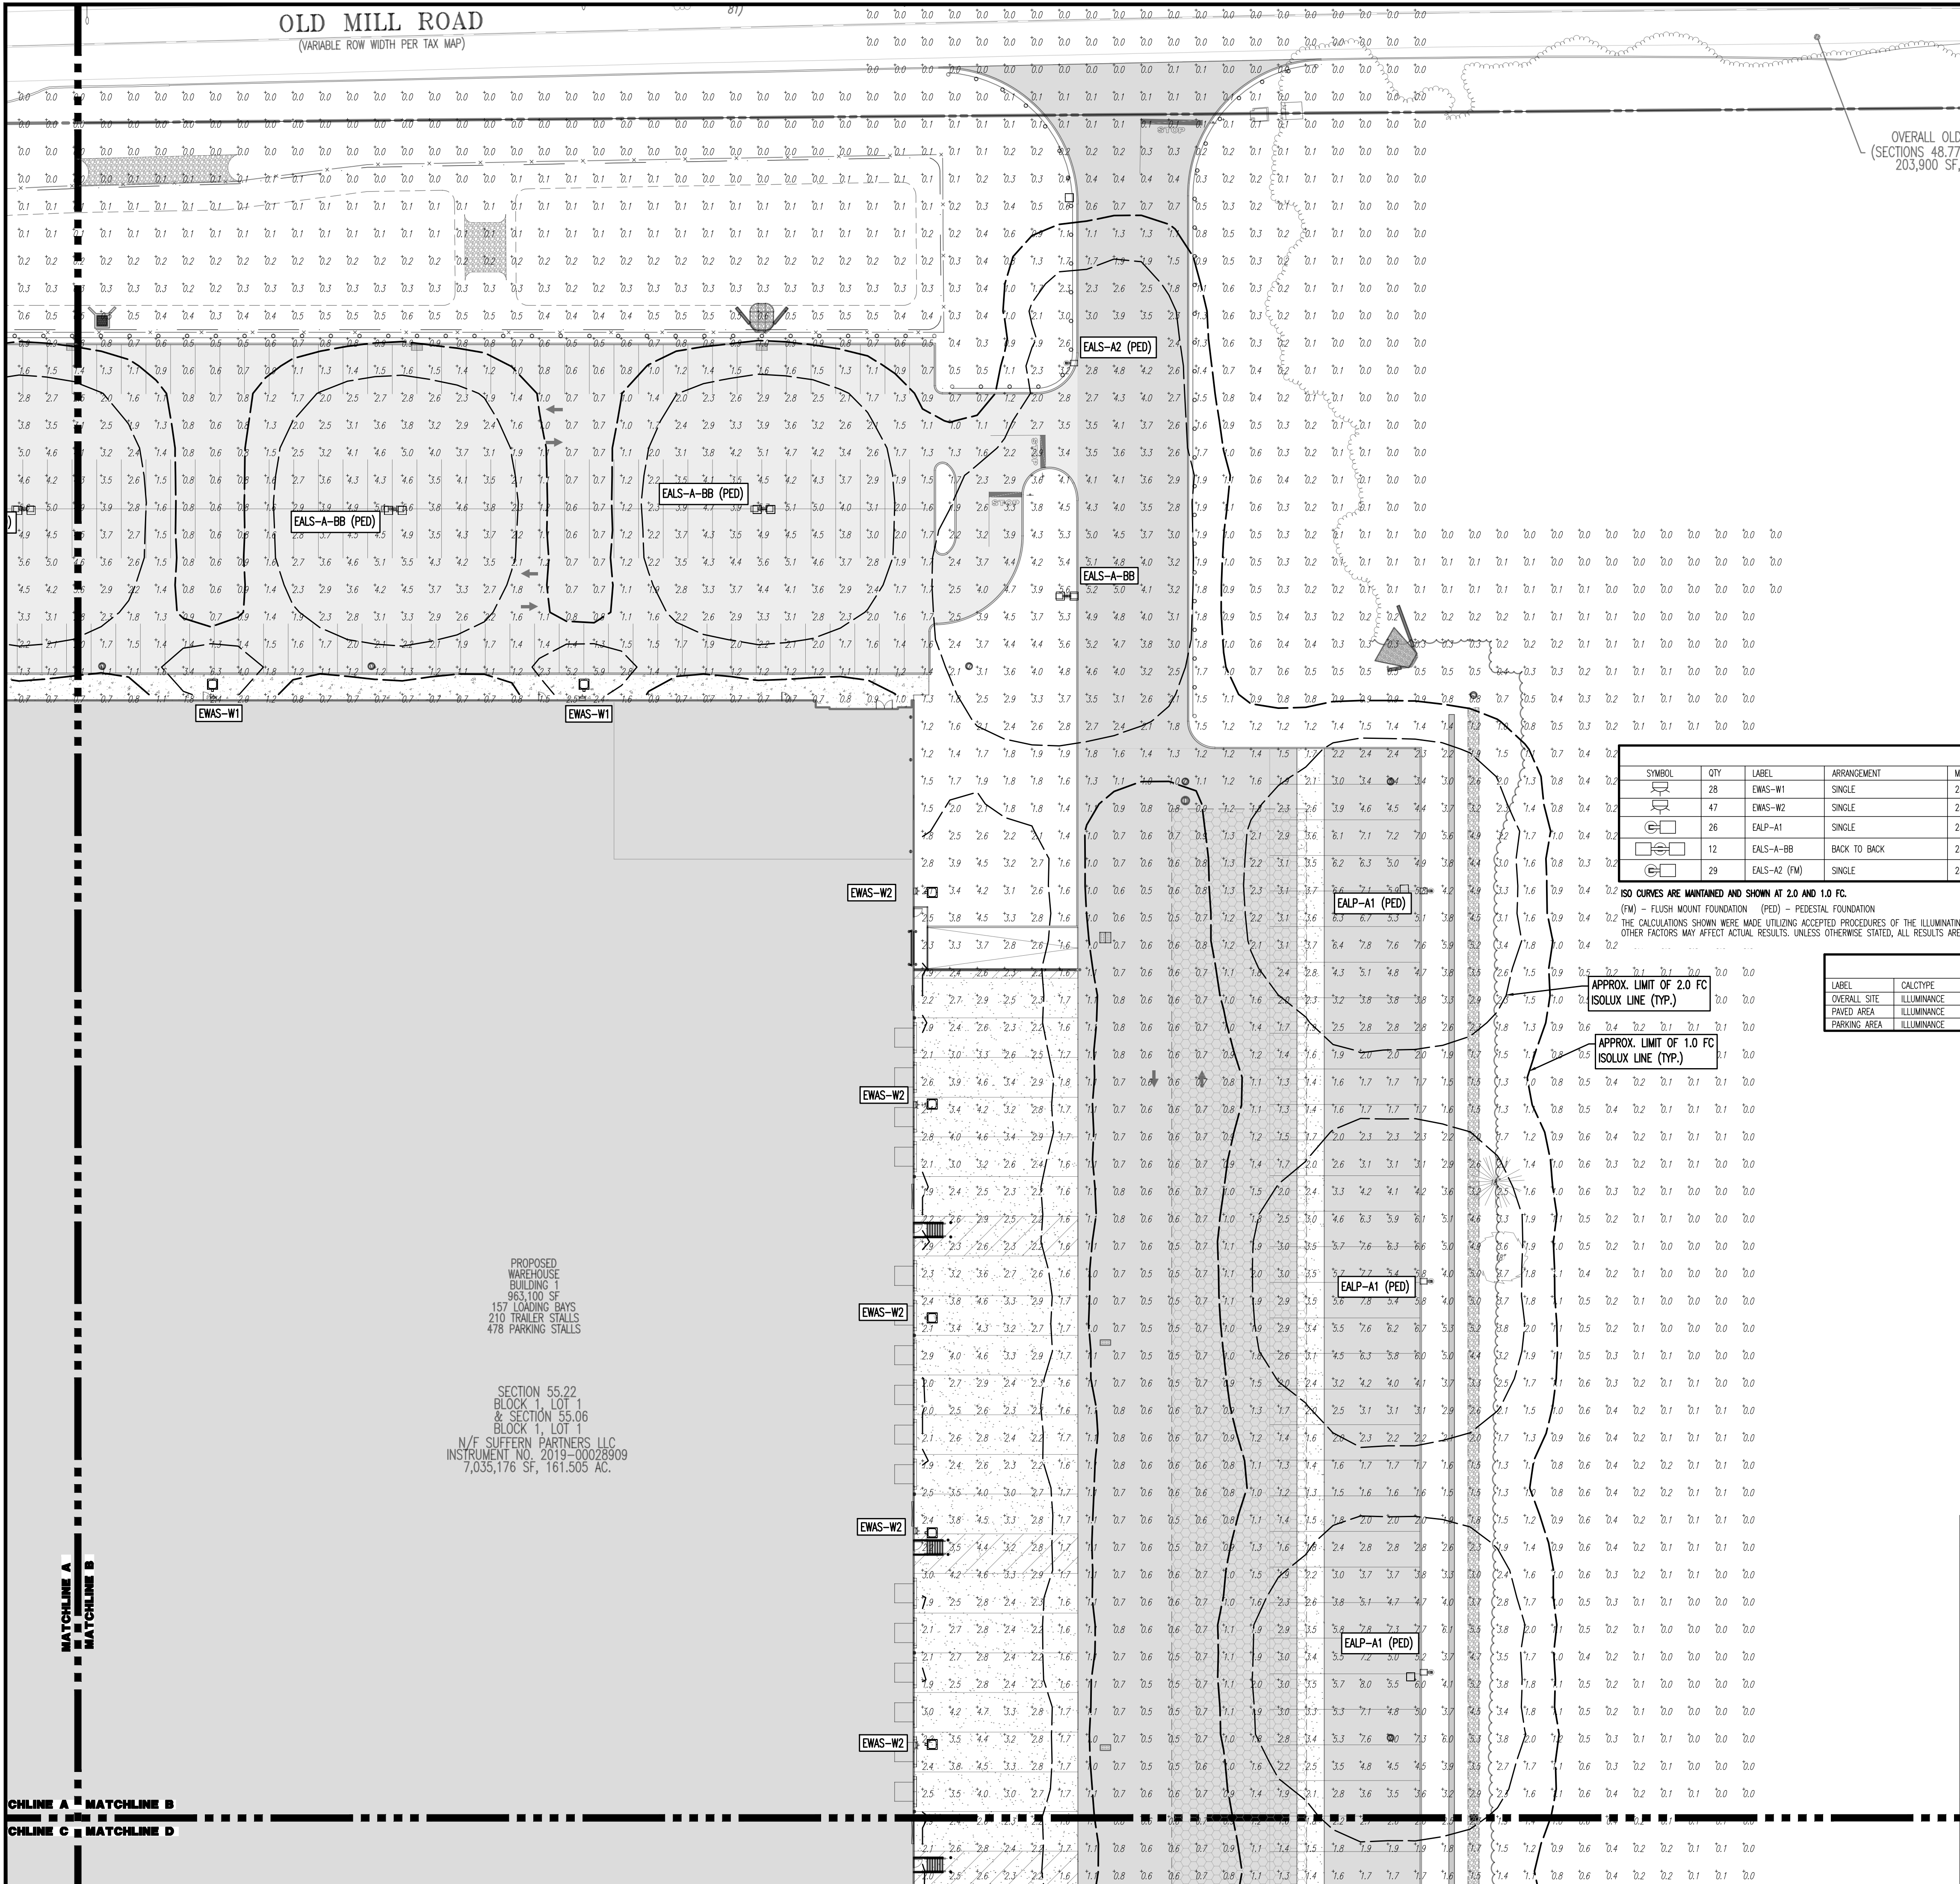


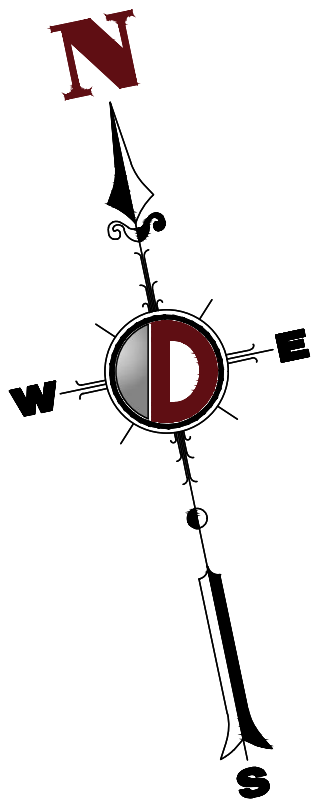

THIS PLAN TO BE UTILIZED FOR LIGHTING PURPOSES ONLY

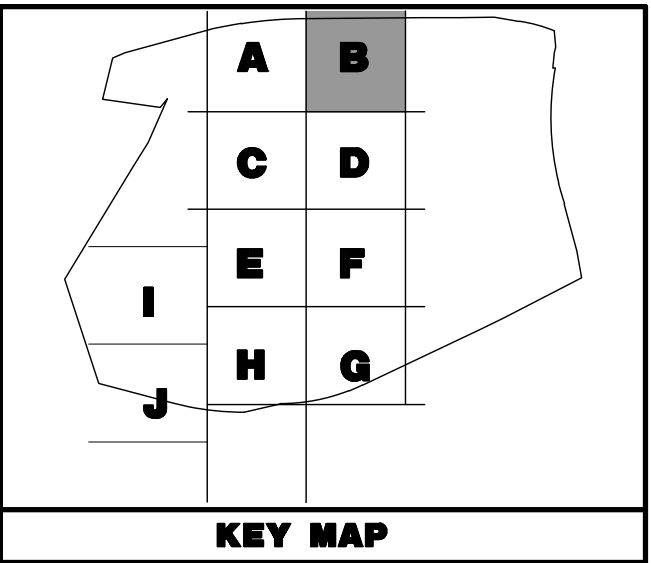

PAVEMENT LEGEND

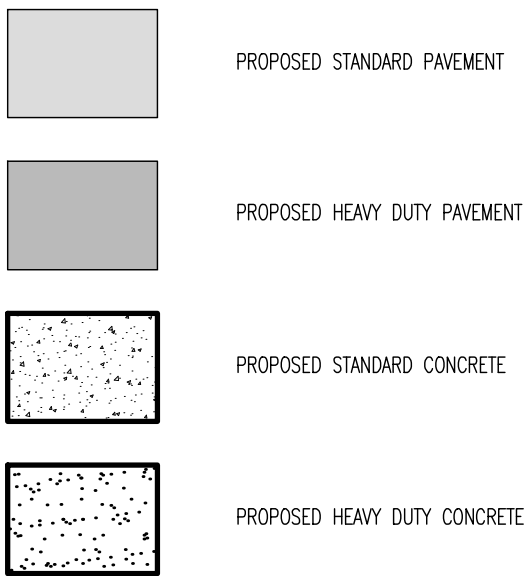


LUMINAIRE SCHEDULE

SYMBOL	QTY	LABEL	ARRANGEMENT	MOUNTING HEIGHT	DESCRIPTION	LLF	LUMINAIRE LUMENS	LUMINAIRE WATTS	COLOR TEMP	TOTAL WATTS	MANUFACTURER
	28	EWAS-W1	SINGLE	25.0 FT	EWAS01_A2M730_-----120-277V	1	2900	21	3000K	525	GE LIGHTING SOLUTIONS
	47	EWAS-W2	SINGLE	25.0 FT	EWAS01_G4M730_-----	1	16100	130	3000K	6110	GE LIGHTING SOLUTIONS
	26	EALP-A1	SINGLE	25.0 FT	EALP03_Q5H4730_-----WITH ELS-EAL-SS4-BLOCK	1	54800	570	3000K	15390	GE LIGHTING SOLUTIONS
	12	EALS-A-BB	BACK TO BACK	25.0 FT	EALS03_K4H4730_-----WITH ELS-EAL-FF4-BLOCK	1	20200	239	3000K	5736	GE LIGHTING SOLUTIONS
	29	EALS-A2 (FM)	SINGLE	25.0 FT	EALS03_K4H4730_-----WITH ELS-EAL-FF4-BLOCK	1	20200	239	3000K	6453	GE LIGHTING SOLUTIONS

CALCULATION SUMMARY

LABEL	CALCTYPE	UNITS	AVG	MAX	MIN	AVG/MIN	MAX/MIN
OVERALL SITE	ILLUMINANCE	FC	1.54	13.9	0.0	N.A.	N.A.
PAVED AREA	ILLUMINANCE	FC	2.33	13.9	0.1	23.30	139.00
PARKING AREA	ILLUMINANCE	FC	2.41	8.1	0.1	24.10	81.00

SEE SHEET 99 OF 132 FOR LIGHTING PLAN NOTES

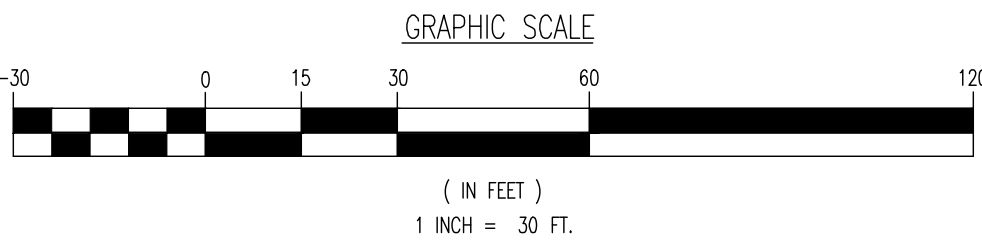

THIS PLAN SET IS FOR PERMITTING PURPOSES ONLY AND MAY NOT BE USED FOR CONSTRUCTION

DYNAMIC ENGINEERING
LAND DEVELOPMENT CONSULTING • PERMITTING • GEOTECHNICAL • ENVIRONMENTAL • SURVEY • PLANNING & ZONING

Lake Como, New Jersey 1-732-974-0198 | Chester, New Jersey 1-800-879-9229 | Newark, New Jersey 1-973-353-7200 | Toms River, New Jersey 1-732-478-0000
Allen, Texas 1-972-334-2100 | Austin, Texas 1-817-244-2044 | Houston, Texas 1-281-789-6400 | Delray Beach, Florida 1-561-921-8570
Newtown, Pennsylvania 1-287-683-0274 | Philadelphia, Pennsylvania 1-215-253-4868 | Southampton, Pennsylvania 1-610-285-4800

TITLE:

PROJECT: **IV2. ROCKLAND LOGISTICS, LLC
PROPOSED INDUSTRIAL PARK AT 25 OLD MILL ROAD**
SECTION 55.22 BLOCK 1, LOT 1; SECTION 55.37, BLOCK 1, LOT 31
OLD MILL ROAD AND HEMION ROAD (CR 93)
VILLAGE OF SUFFERN, ROCKLAND COUNTY, NEW YORK

ZACHARY A. KAMM
PROFESSIONAL ENGINEER
NEW YORK LICENSE NO. 107071

JOSHUA M. SWALD
PROFESSIONAL ENGINEER
NEW YORK LICENSE NO. 106639

811
PROTECT YOURSELF
CALL BEFORE YOU DIG
FOR STATE SPECIFIC DIRECT PHONE NUMBERS VISIT
WWW.CALL811.COM

90
OF 132
Rev. # 5

JOB No: 3709-99-004
DATE: 12/17/2021
DRAWN BY: ALPH
DESIGNED BY: JMS
CHECKED BY: JMS
CHECKED BY: ZAK

SCALE: (H) 1"=30'
(V)
SHEET No: