


Peter J Bonner

3.1

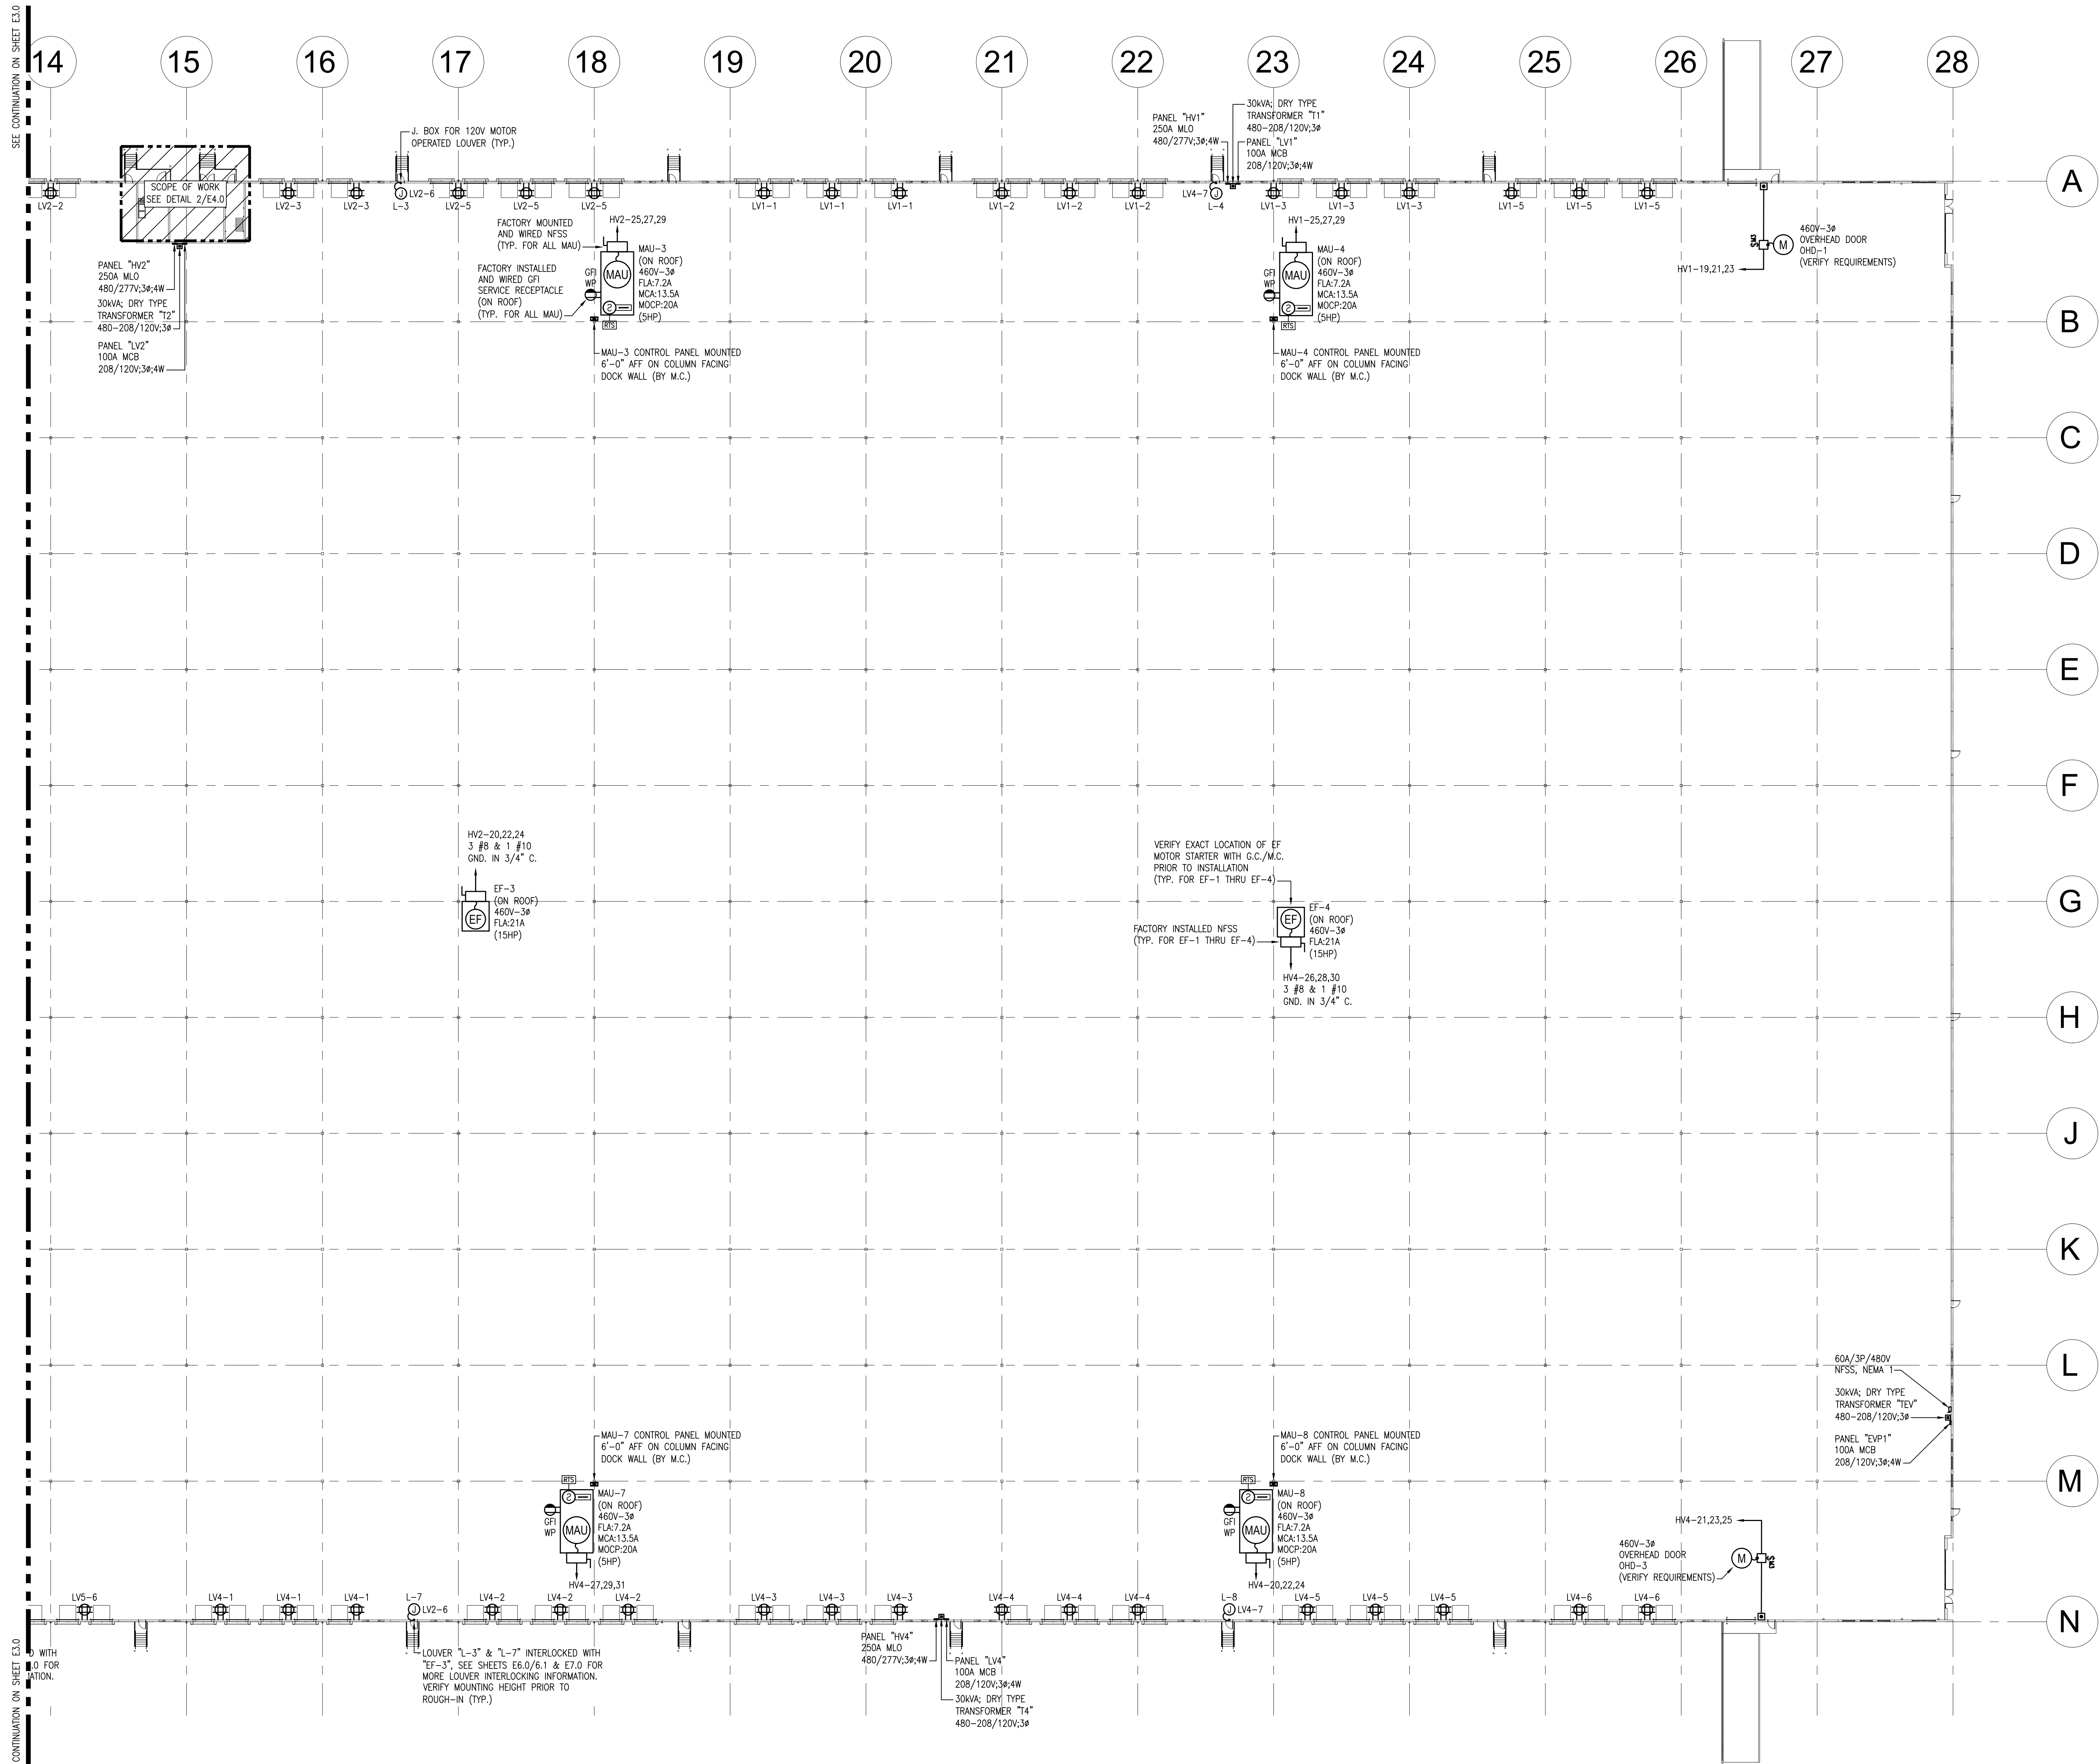

1 PARTIAL WAREHOUSE POWER PLAN
E3.1 SCALE: 1" = 30'-0"

- NOTES:
1. ALL SHOWN IS NEW & BY EC UNLESS SPECIFICALLY NOTED OTHERWISE
 2. E.C. SHALL VERIFY ALL MECHANICAL/HVAC EQUIPMENT LOCATIONS AND ELECTRICAL REQUIREMENTS WITH MECHANICAL/HVAC DRAWINGS PRIOR TO INSTALLATION.