




Peter J. Bonina

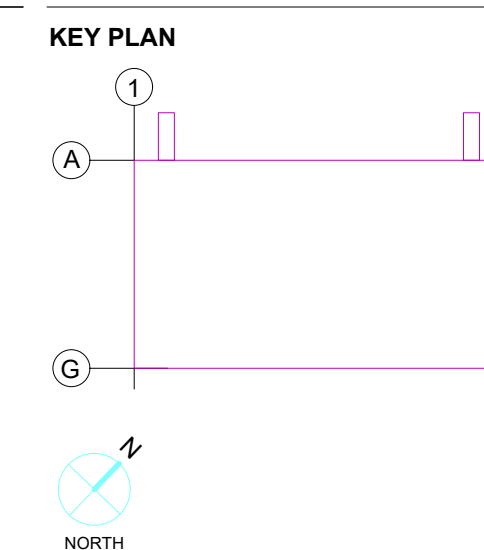

SUBMITTALS


NO.	DATE	DESCRIPTION
A	11.20.2024	ISSUE FOR REVIEW
B	02.02.2024	ISSUE FOR REVIEW
0	02.09.2024	ISSUE FOR PERMIT

PROJECT NO.
 AS397-22 | NY154

SHEET TITLE
WAREHOUSE LIGHTING PLAN

SHEET NO.

E2.0

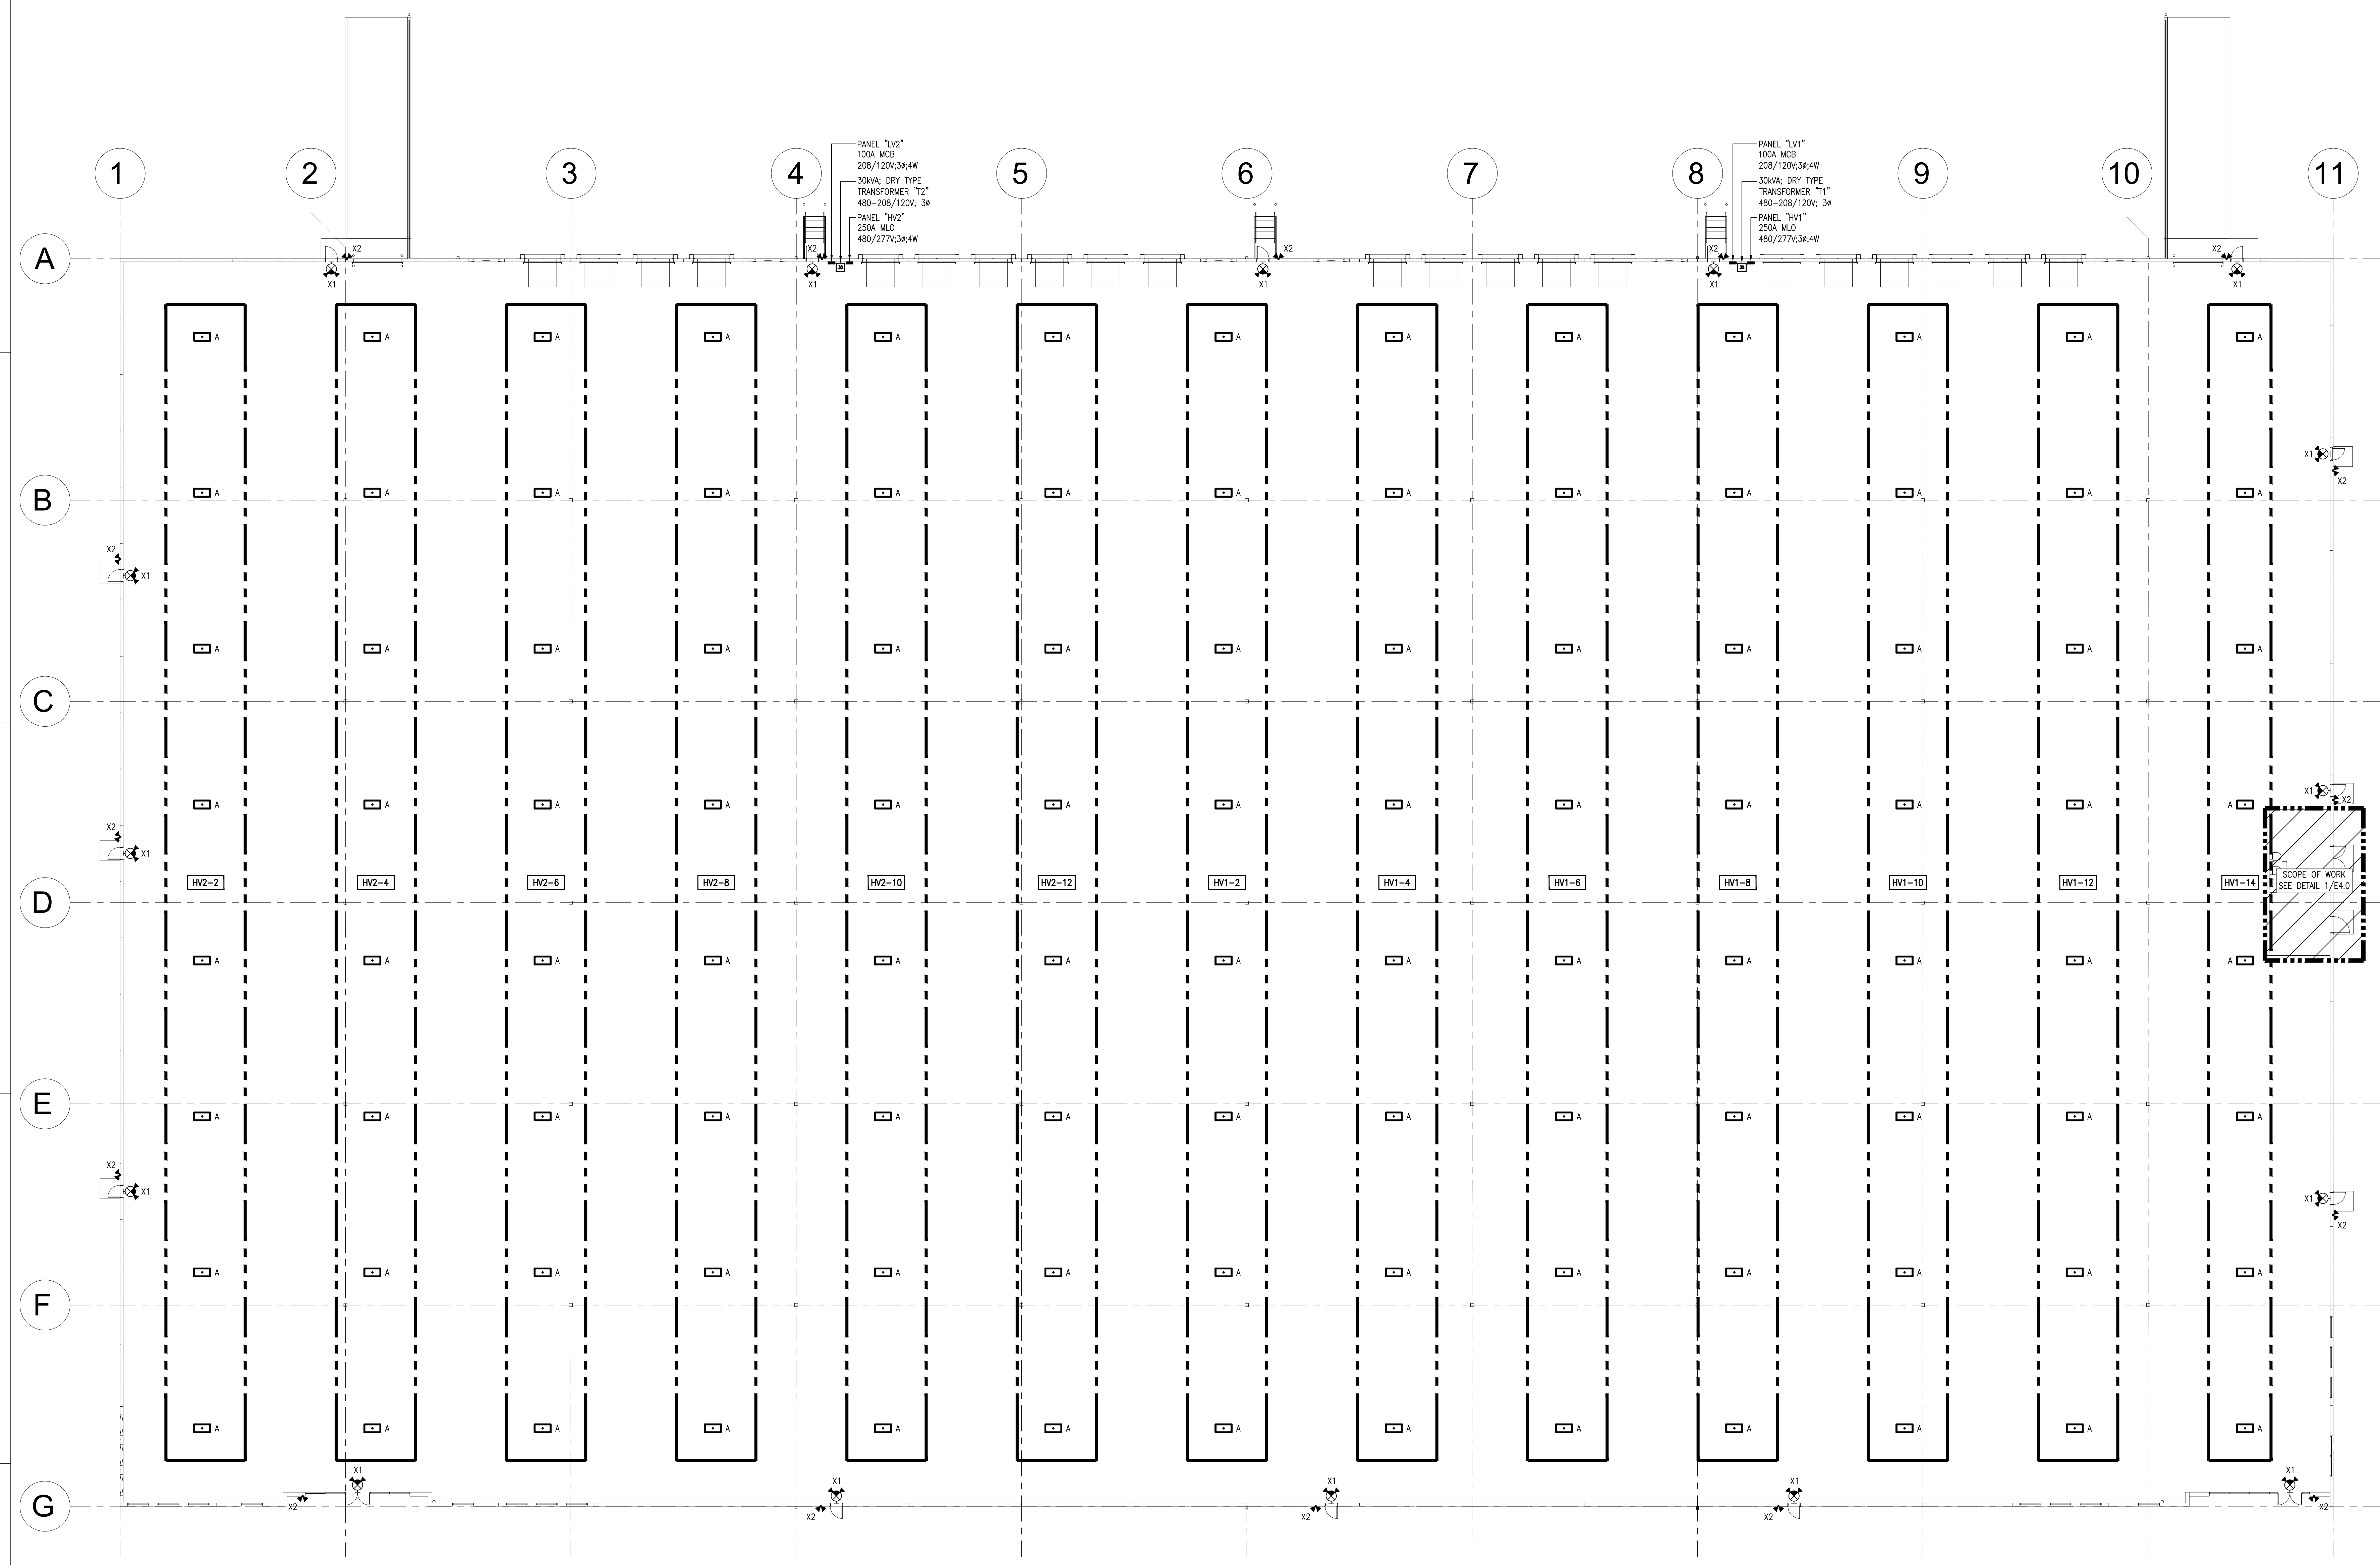

1 WAREHOUSE LIGHTING PLAN
 SCALE: 1/16" = 1'-0"

- NOTES:
- ALL SHOWN IS NEW & BY EC UNLESS SPECIFICALLY NOTED OTHERWISE
 - ALL EXIT SIGNAGE & EMERGENCY LIGHTING TO BE WIRED TO LOCAL LIGHTING CIRCUIT AND AHEAD OF ALL SWITCHING
 - ALL LIGHTING FIXTURES WITHIN THE SPECIFIED AREA SHALL BE CIRCUITED TO THE CIRCUIT NUMBER(S) INDICATED ON THIS PLAN, UNLESS NOTED OTHERWISE. SEE PANEL SCHEDULES ON DRAWING E6.0 FOR ADDITIONAL INFORMATION.

Label	Units	Avg	Max	Min	Avg/Min	Max/Min
Building 2	Fc	25.32	33.2	7.9	3.21	4.20