





Peter J. Bonni

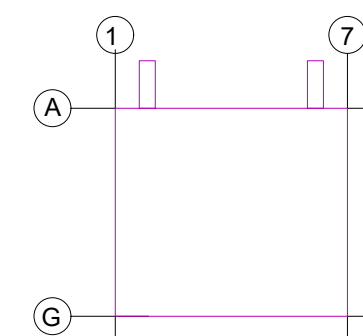

NO.	DATE	DESCRIPTION
A	11.20.2024	ISSUE FOR REVIEW
B	02.02.2024	ISSUE FOR REVIEW
0	02.09.2024	ISSUE FOR PERMIT

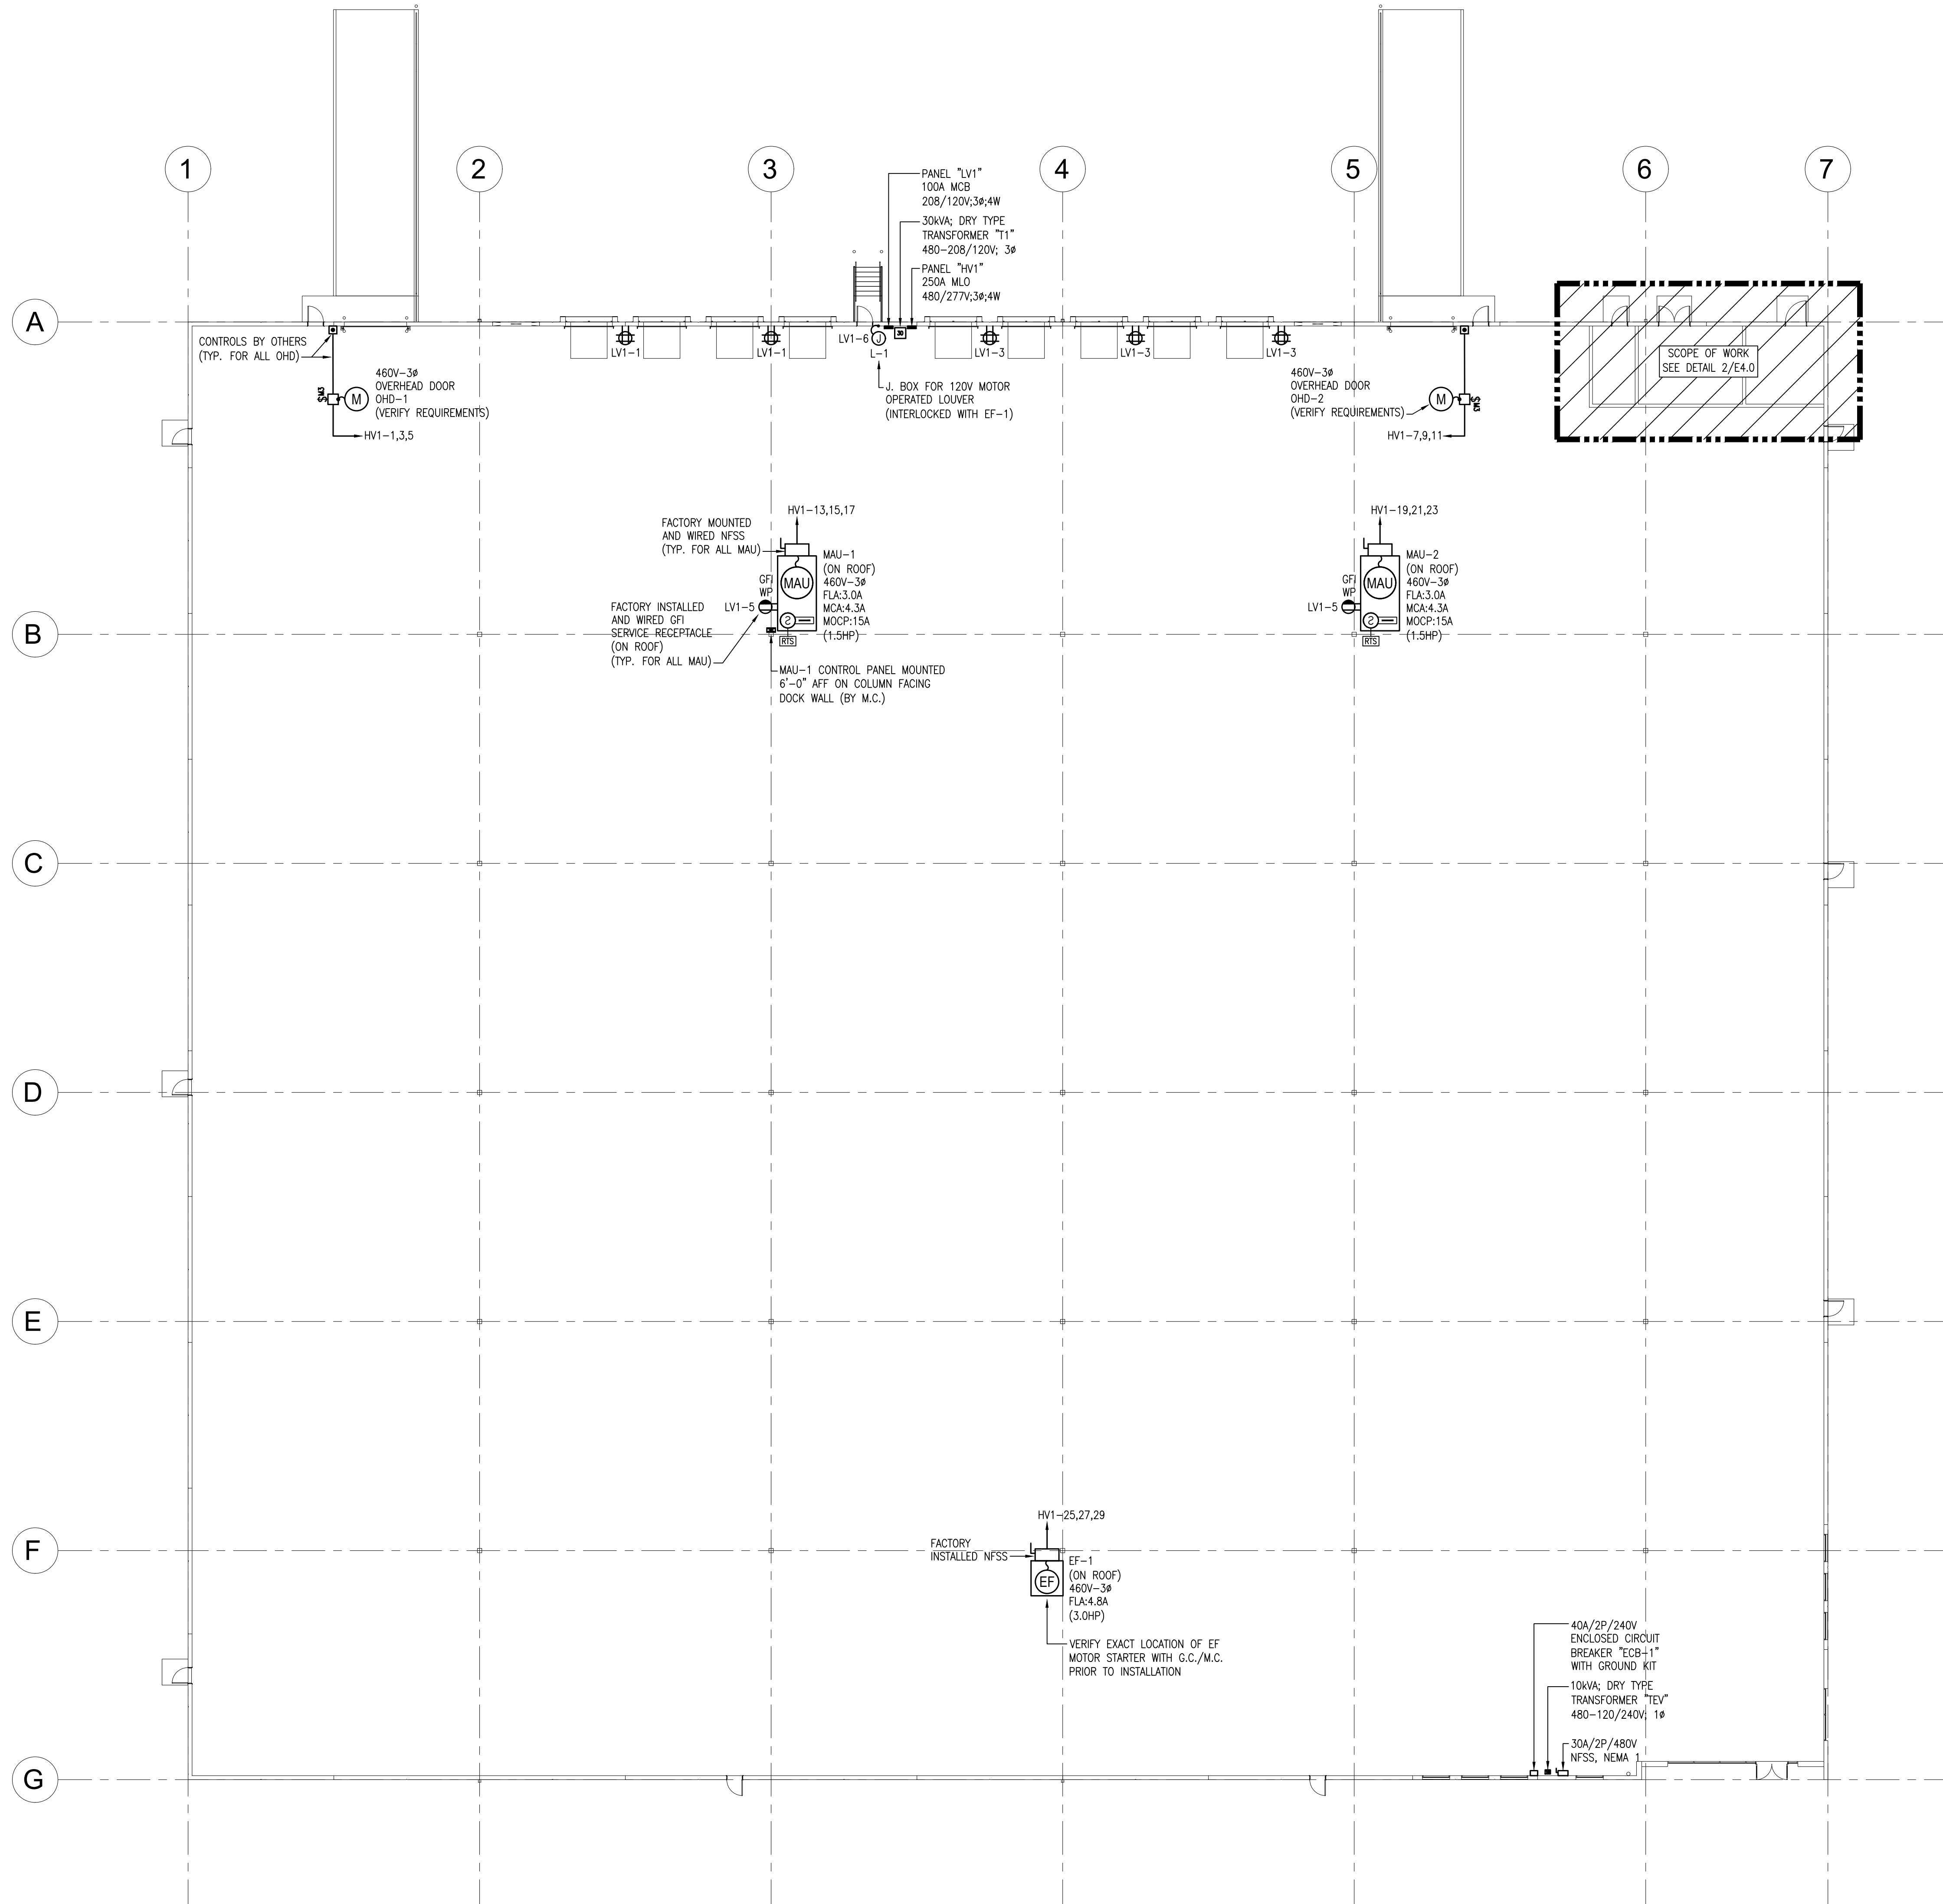

1 WAREHOUSE POWER PLAN

E3.0 SCALE: 1/16" = 1'-0"

NOTES:

- ALL SHOWN IS NEW & BY EC UNLESS SPECIFICALLY NOTED OTHERWISE.
- E.C. SHALL VERIFY ALL HVAC EQUIPMENT LOCATIONS AND ELECTRICAL REQUIREMENTS WITH APPROVED HVAC DRAWINGS PRIOR TO INSTALLATION.