


BUILDING SECTION A-A

SCALE: NTS

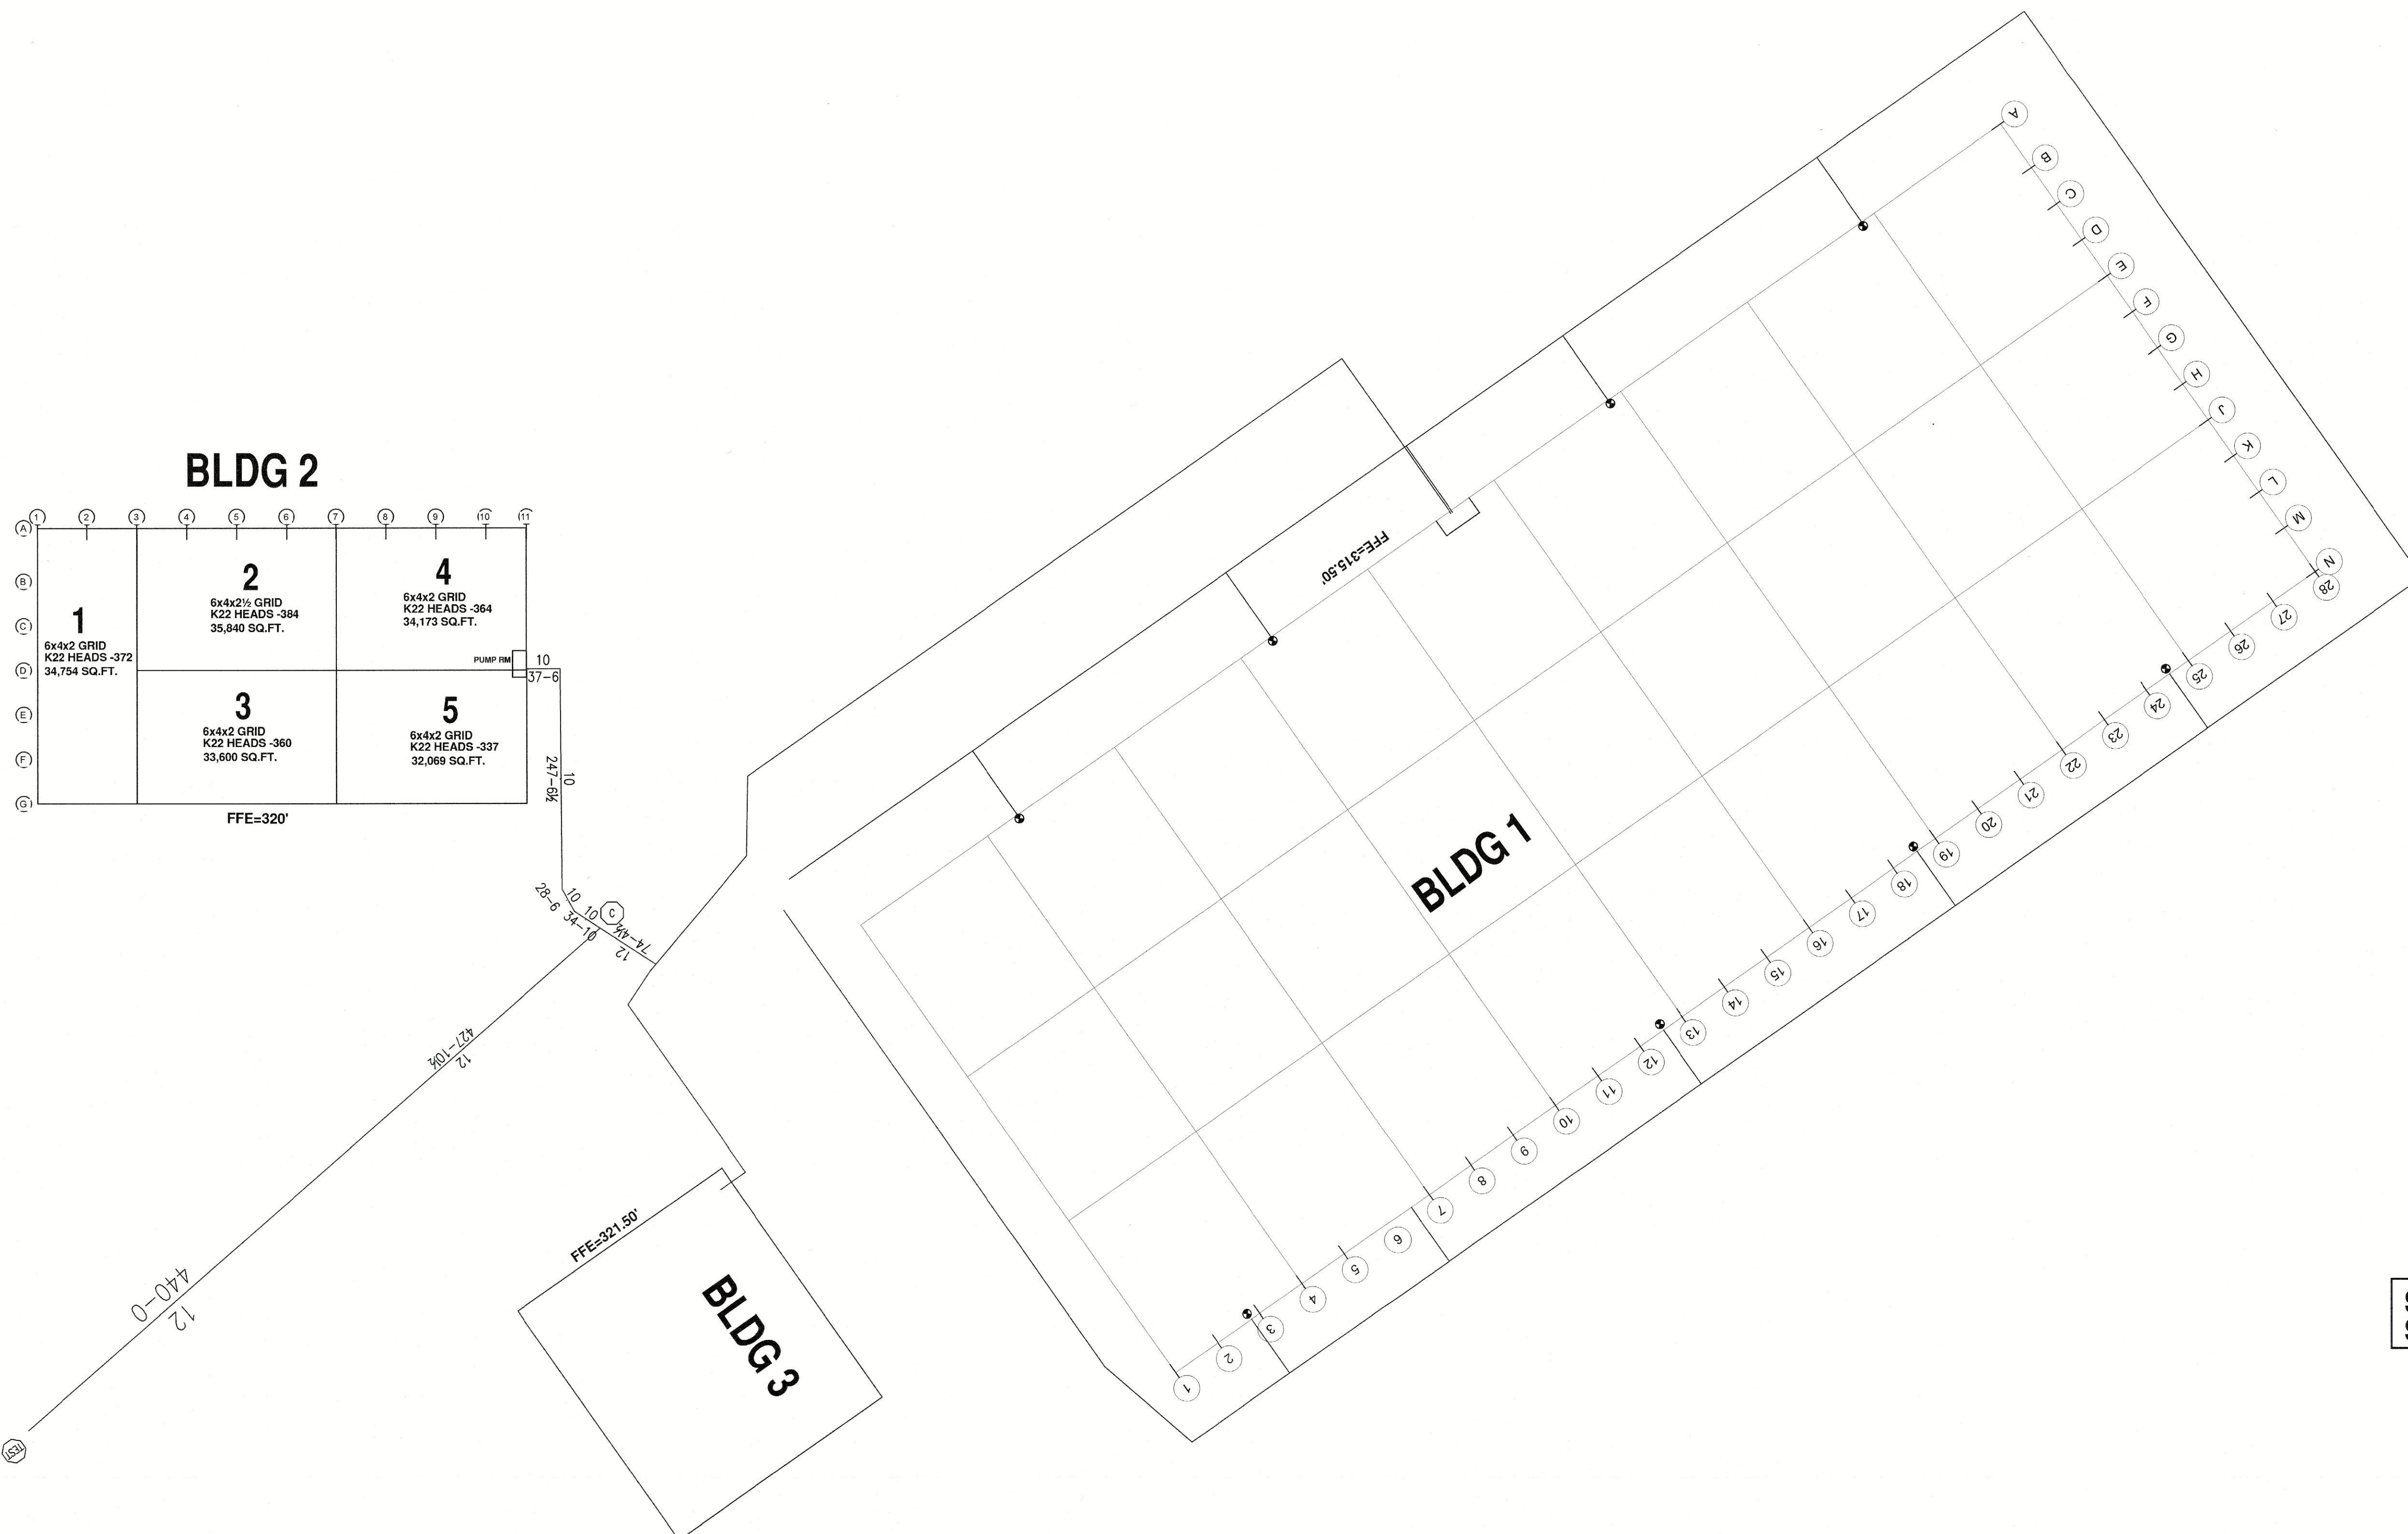

UNDERGROUND NOTES:

UNDERGROUND LOOP TO BE BLUBR C900 DR 18(C=150)
ALL UNDERGROUND PIPING & VALVES IS SHOWN FOR HYDRAULIC
REFERENCE ONLY, AND IS NOT PART OF SAC SCOPE OF WORK.
REFERENCE UNDERGROUND DRAWINGS FOR EXACT VALVE TYPES
AND THRUST BLOCK LOCATIONS.


WATER FLOW TEST	
	08.17.23
STATIC PRESSURE:	66 PSI
RESIDUAL PRESSURE:	60 PSI
FLOWING:	1061 GPM
ELEVATION:	367'
TEST BY:	MSG FIRE INC

SITE PLAN

NOT TO SCALE

HYDROSTATIC TEST TO BE CONDUCTED AT 225 PSI

STANDARD DRAWING SYMBOLS		TYPICAL HANGER ASSEMBLIES BY NUMBER		FIRE PROTECTION SPECIFICATIONS		MATERIAL SPECIFICATIONS		REVISIONS		SPRINKLER LEGEND	
D-1	1	1	1	1	1	1	1	1	1	1	1
D-2	2	2	2	2	2	2	2	2	2	2	2
D-3	3	3	3	3	3	3	3	3	3	3	3
D-100	100	100	100	100	100	100	100	100	100	100	100

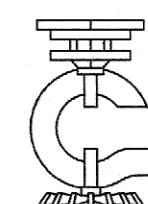

S.A. COMUNALE CO. INC.

FIRE PROTECTION CONTRACTORS

2800 NEWPARK DR. CLEVELAND, OHIO 44103 330-706-3040 FAX: 330-861-0860
CLEVELAND: 440-684-9325 COLUMBUS: 614-291-7001 CINCINNATI: 513-874-4288
PITTSBURGH: 412-334-3841 PHILADELPHIA, PA: 610-668-4888 YOUNGSTOWN: 330-858-4440
MILWAUKEE: 740-383-6789 WASHINGTON, DC: 410-768-1801 READING, PA: 610-670-3900

NY154 BROOKFIELD SUFFERN- BUILDING 2

25 OLD MILL, ROAD SUFFERN, NY 20901

SECTION VIEW AND SITE PLAN

DATE 01.11.24 SCALE 3/32" = 1'-0" DRAWN SARAH CAREW JOB NO. 51718093 DWS. NO. 2 OF 6