




1 First Floor Demolition Plan - Area C  
1/8" = 1'-0"

Keyed Notes


- 1 REMOVE LUMINAIRES, LIGHTING CONTROLS, COIL AND TAG CIRCUITRY FOR REUSE.
- 2 REMOVE THE CEILING DEVICES. PRESERVE CIRCUITRY AND STORE FOR REINSTALLATION, EXCEPT DEMOLISHED LUMINAIRES, EXITS AND OCCUPANCY SENSORS. COORDINATE ALL WORK WITH GENERAL CONTRACTOR.
- 3 DISCONNECT AND REMOVE ELECTRICAL CIRCUITRY BACK TO SOURCE, LABEL BREAKER AS SPARE AND UPDATE PANELBOARD SCHEDULE.
- 4 DISCONNECT FIRE ALARM CIRCUITS AND TAG FOR REUSE. PROTECT AND STORE FIRE ALARM PANEL FOR RE-USE.
- 5 REMOVE WALL MOUNTED DEVICES TO ACCOMMODATE CEILING REPLACEMENT. PRESERVE / STORE DEVICES AND CIRCUITRY AS NECESSARY FOR REINSTALLATION. COORDINATE ALL WORK WITH GENERAL CONTRACTOR.
- 6 REMOVE LUMINAIRES, COIL AND TAG CIRCUITRY FOR REUSE.
- 7 REMOVE AND REINSTALL CEILING DEVICES FOR MECHANICAL WORK.

General Notes

- A. REFER TO DRAWING AE100 FOR GENERAL DEMOLITION NOTES
- B. SEE SHEET G001 FOR SYMBOLS LEGEND AND ABBREVIATIONS

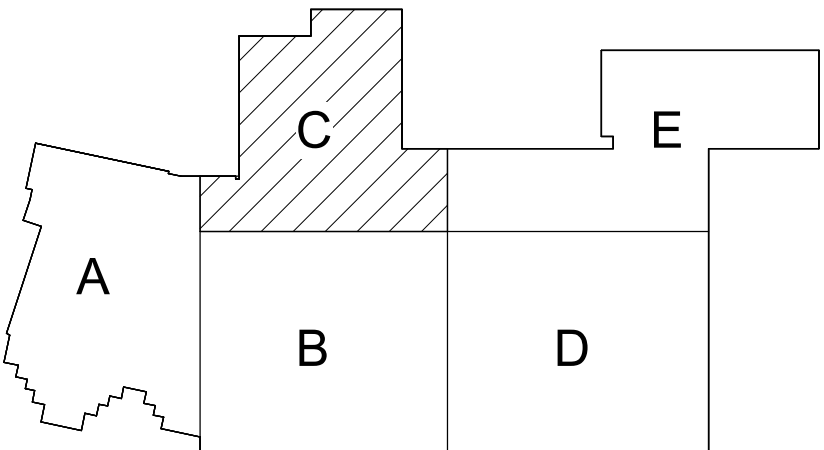


Key Plan  
N.T.S.

 

S.E.D. Control No. 62-18-01-06-0-007-019

Rev. No.: Date: Description:

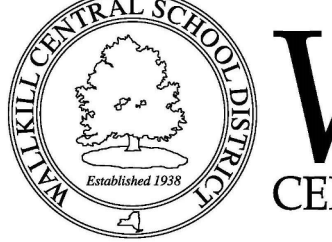


**WALLKILL**  
CENTRAL SCHOOL DISTRICT

complex world  
CLEAR SOLUTIONS

Tetra Tech Engineers, Architects  
& Landscape Architects, P.C.

**BID SET**

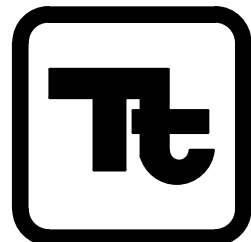

**TETRA TECH**  
ARCHITECTS & ENGINEERS

Wallkill Central School District  
Wallkill, New York

Reconstruction to:  
Wallkill Senior High School

First Floor Demolition Plan - Area C

Drawn By:  
CR/ded

Date:  
06/30/2023

Drawing Number:

Project No.:  
17597-22002

**AE101**