


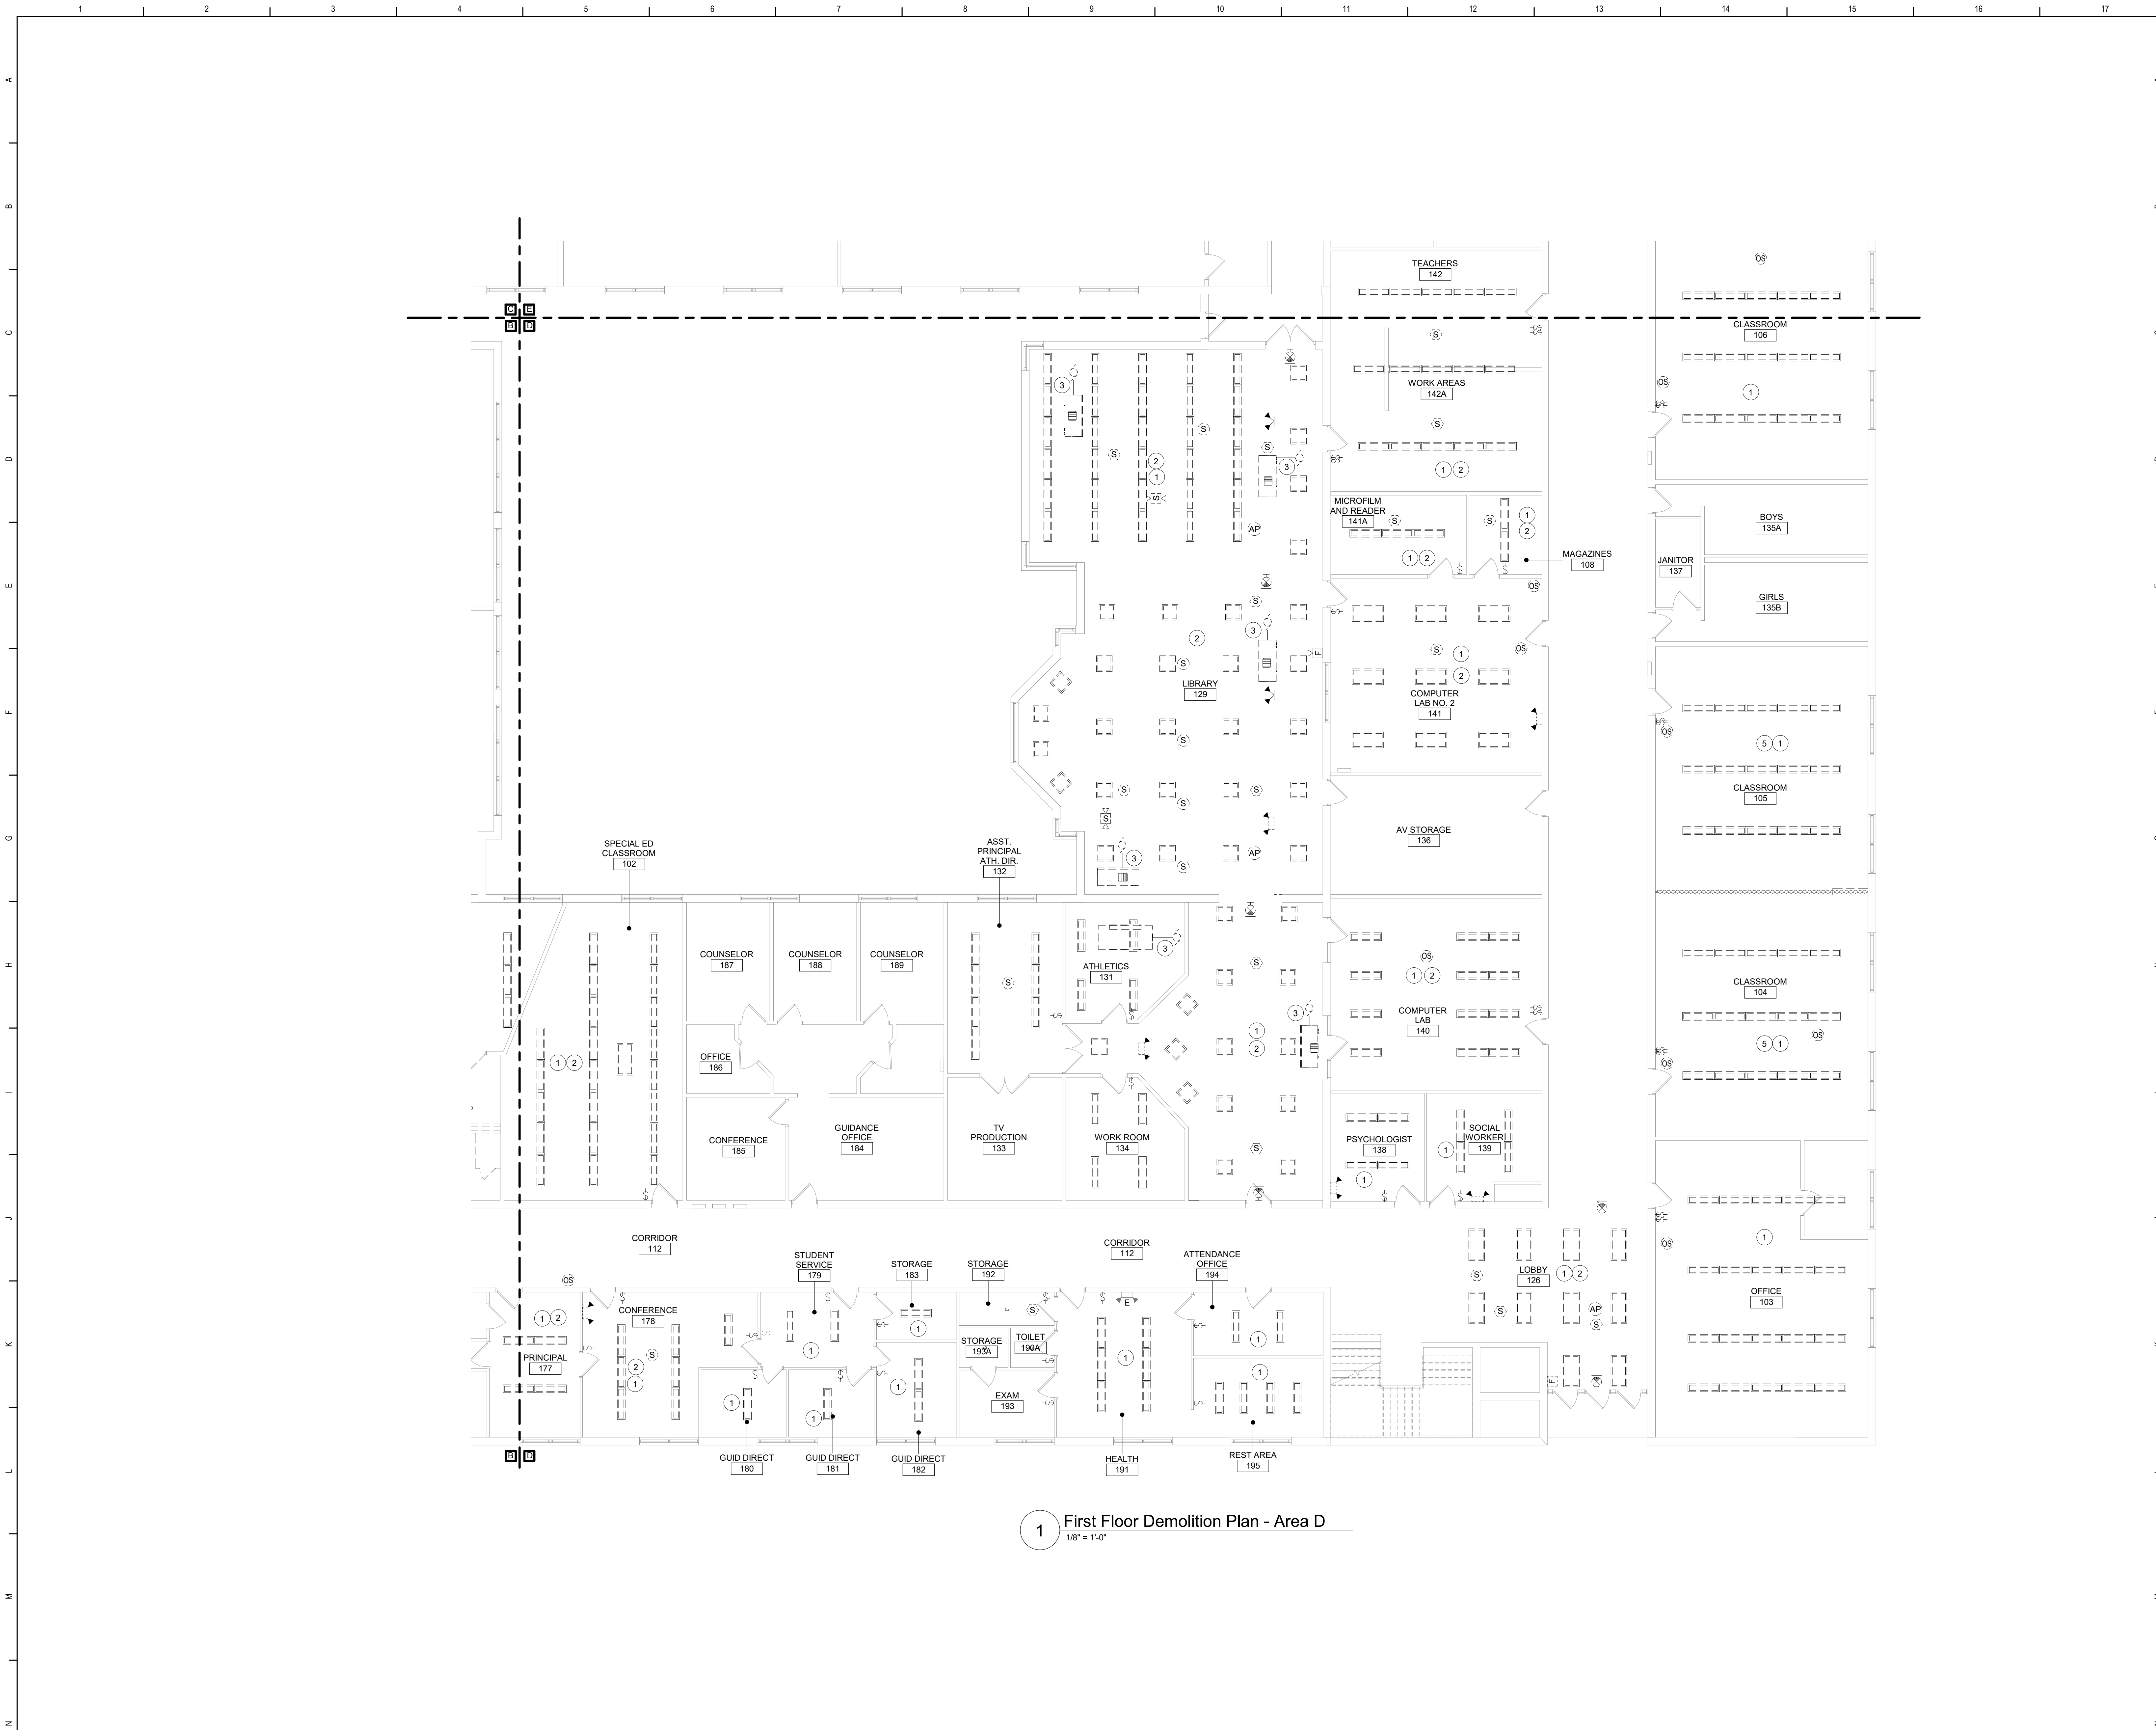


1 First Floor Demolition Plan - Area D
1/8" = 1'-0"

Keyed Notes

- 1 REMOVE LUMINAIRES, LIGHTING CONTROLS, COIL AND TAG CIRCUITRY FOR REUSE.
- 2 REMOVE THE CEILING DEVICES, PRESERVE CIRCUITRY AND STORE FOR REINSTALLATION, EXCEPT DEMOLISHED LUMINAIRES, EXITS AND OCCUPANCY SENSORS. COORDINATE ALL WORK WITH GENERAL CONTRACTOR.
- 3 DISCONNECT AND REMOVE ELECTRICAL CIRCUITRY BACK TO SOURCE, LABEL BREAKER AS SPARE AND UPDATE PANELBOARD SCHEDULE.
- 4 DISCONNECT FIRE ALARM CIRCUITS AND TAG FOR REUSE. PROTECT AND STORE FIRE ALARM PANEL FOR RE-USE.
- 5 REMOVE WALL MOUNTED DEVICES TO ACCOMMODATE CEILING REPLACEMENT, PRESERVE / STORE DEVICES AND CIRCUITRY AS NECESSARY FOR REINSTALLATION. COORDINATE ALL WORK WITH GENERAL CONTRACTOR.
- 6 REMOVE LUMINAIRES, COIL AND TAG CIRCUITRY FOR REUSE.
- 7 REMOVE AND REINSTALL CEILING DEVICES FOR MECHANICAL WORK.


General Notes

- A REFER TO DRAWING AE100 FOR GENERAL DEMOLITION NOTES.
- B SEE SHEET G001 FOR SYMBOLS LEGEND AND ABBREVIATIONS.

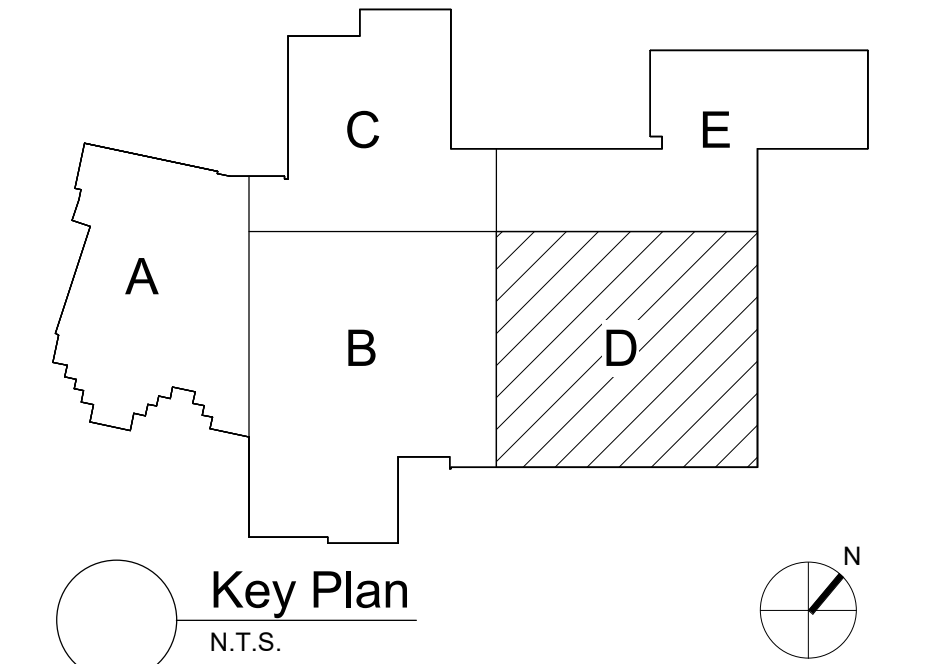

S.E.D. Control No. 62-18-01-06-0-007-019

Rev. No.	Date	Description

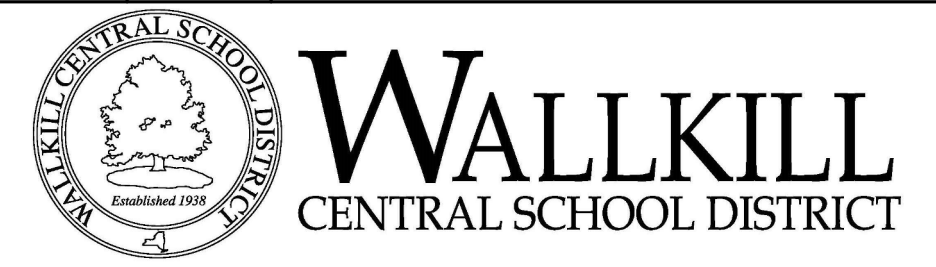

complex world
CLEAR SOLUTIONS

Tetra Tech Engineers, Architects
& Landscape Architects, P.C.

BID SET



Walkkill Central School District
Walkkill, New York

Reconstruction to:
Walkkill Senior High School

First Floor Demolition Plan - Area D

Drawn By: CR/ded	Date: 06/30/2023	Drawing Number:
Project No.: 17597-22002	AE102	