


1 Second Floor Demolition Plan - Area C  
1/8" = 1'-0"

#### Keyed Notes

- 1 REMOVE LUMINAIRES, LIGHTING CONTROLS. COIL AND TAG CIRCUITRY FOR REUSE.
- 2 REMOVE THE CEILING DEVICES - PRESERVE CIRCUITRY AND STORE FOR REINSTALLATION, EXCEPT DEMOLISHED LUMINAIRES, EXITS AND OCCUPANCY SENSORS. COORDINATE ALL WORK WITH GENERAL CONTRACTOR.
- 3 DISCONNECT AND REMOVE ELECTRICAL CIRCUITRY BACK TO SOURCE. LABEL BREAKER AS SPARE AND UPDATE PANELBOARD SCHEDULE.
- 4 DISCONNECT FIRE ALARM CIRCUITS AND TAG FOR REUSE. PROTECT AND STORE FIRE ALARM PANEL FOR RE-USE.
- 5 REMOVE WALL MOUNTED DEVICES TO ACCOMMODATE CEILING REPLACEMENT. PRESERVE / STORE DEVICES AND CIRCUITRY AS NECESSARY FOR REINSTALLATION. COORDINATE ALL WORK WITH GENERAL CONTRACTOR.
- 6 REMOVE LUMINAIRES. COIL AND TAG CIRCUITRY FOR REUSE.
- 7 REMOVE AND REINSTALL CEILING DEVICES FOR MECHANICAL WORK.

#### General Notes


- A. REFER TO DRAWING AE100 FOR GENERAL DEMOLITION NOTES
- B. SEE SHEET G001 FOR SYMBOLS LEGEND AND ABBREVIATIONS

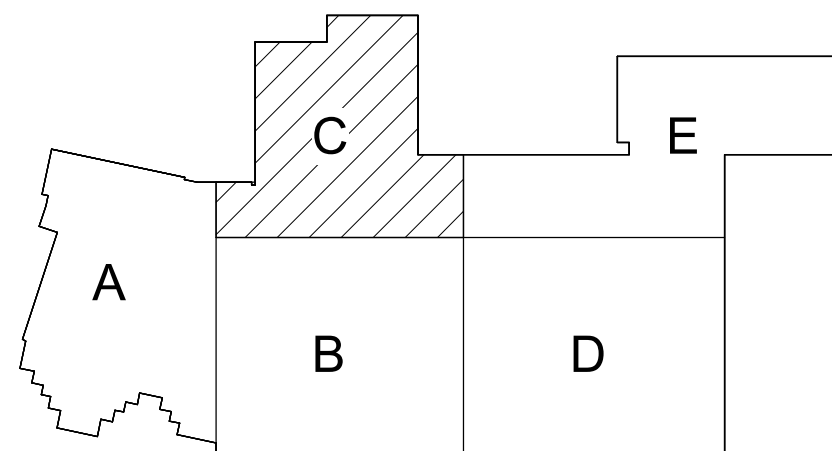

Key Plan  
N.T.S.

S.E.D. Control No. 62-18-01-06-0-007-019

Rev. No.	Date	Description

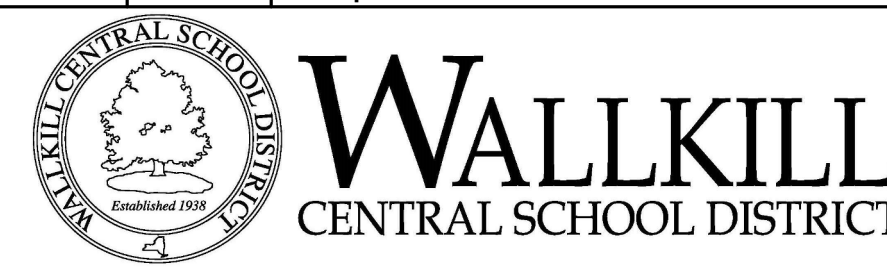

complex world CLEAR SOLUTIONS	BID SET
Tetra Tech Engineers, Architects & Landscape Architects, P.C.	



Wallkill Central School District  
Wallkill, New York

Reconstruction to:  
Wallkill Senior High School

Second Floor Demolition Plan - Area C

Drawn By: CR/ded	Date: 06/30/2023	Drawing Number:
Project No.: 17597-22002	AE104	