



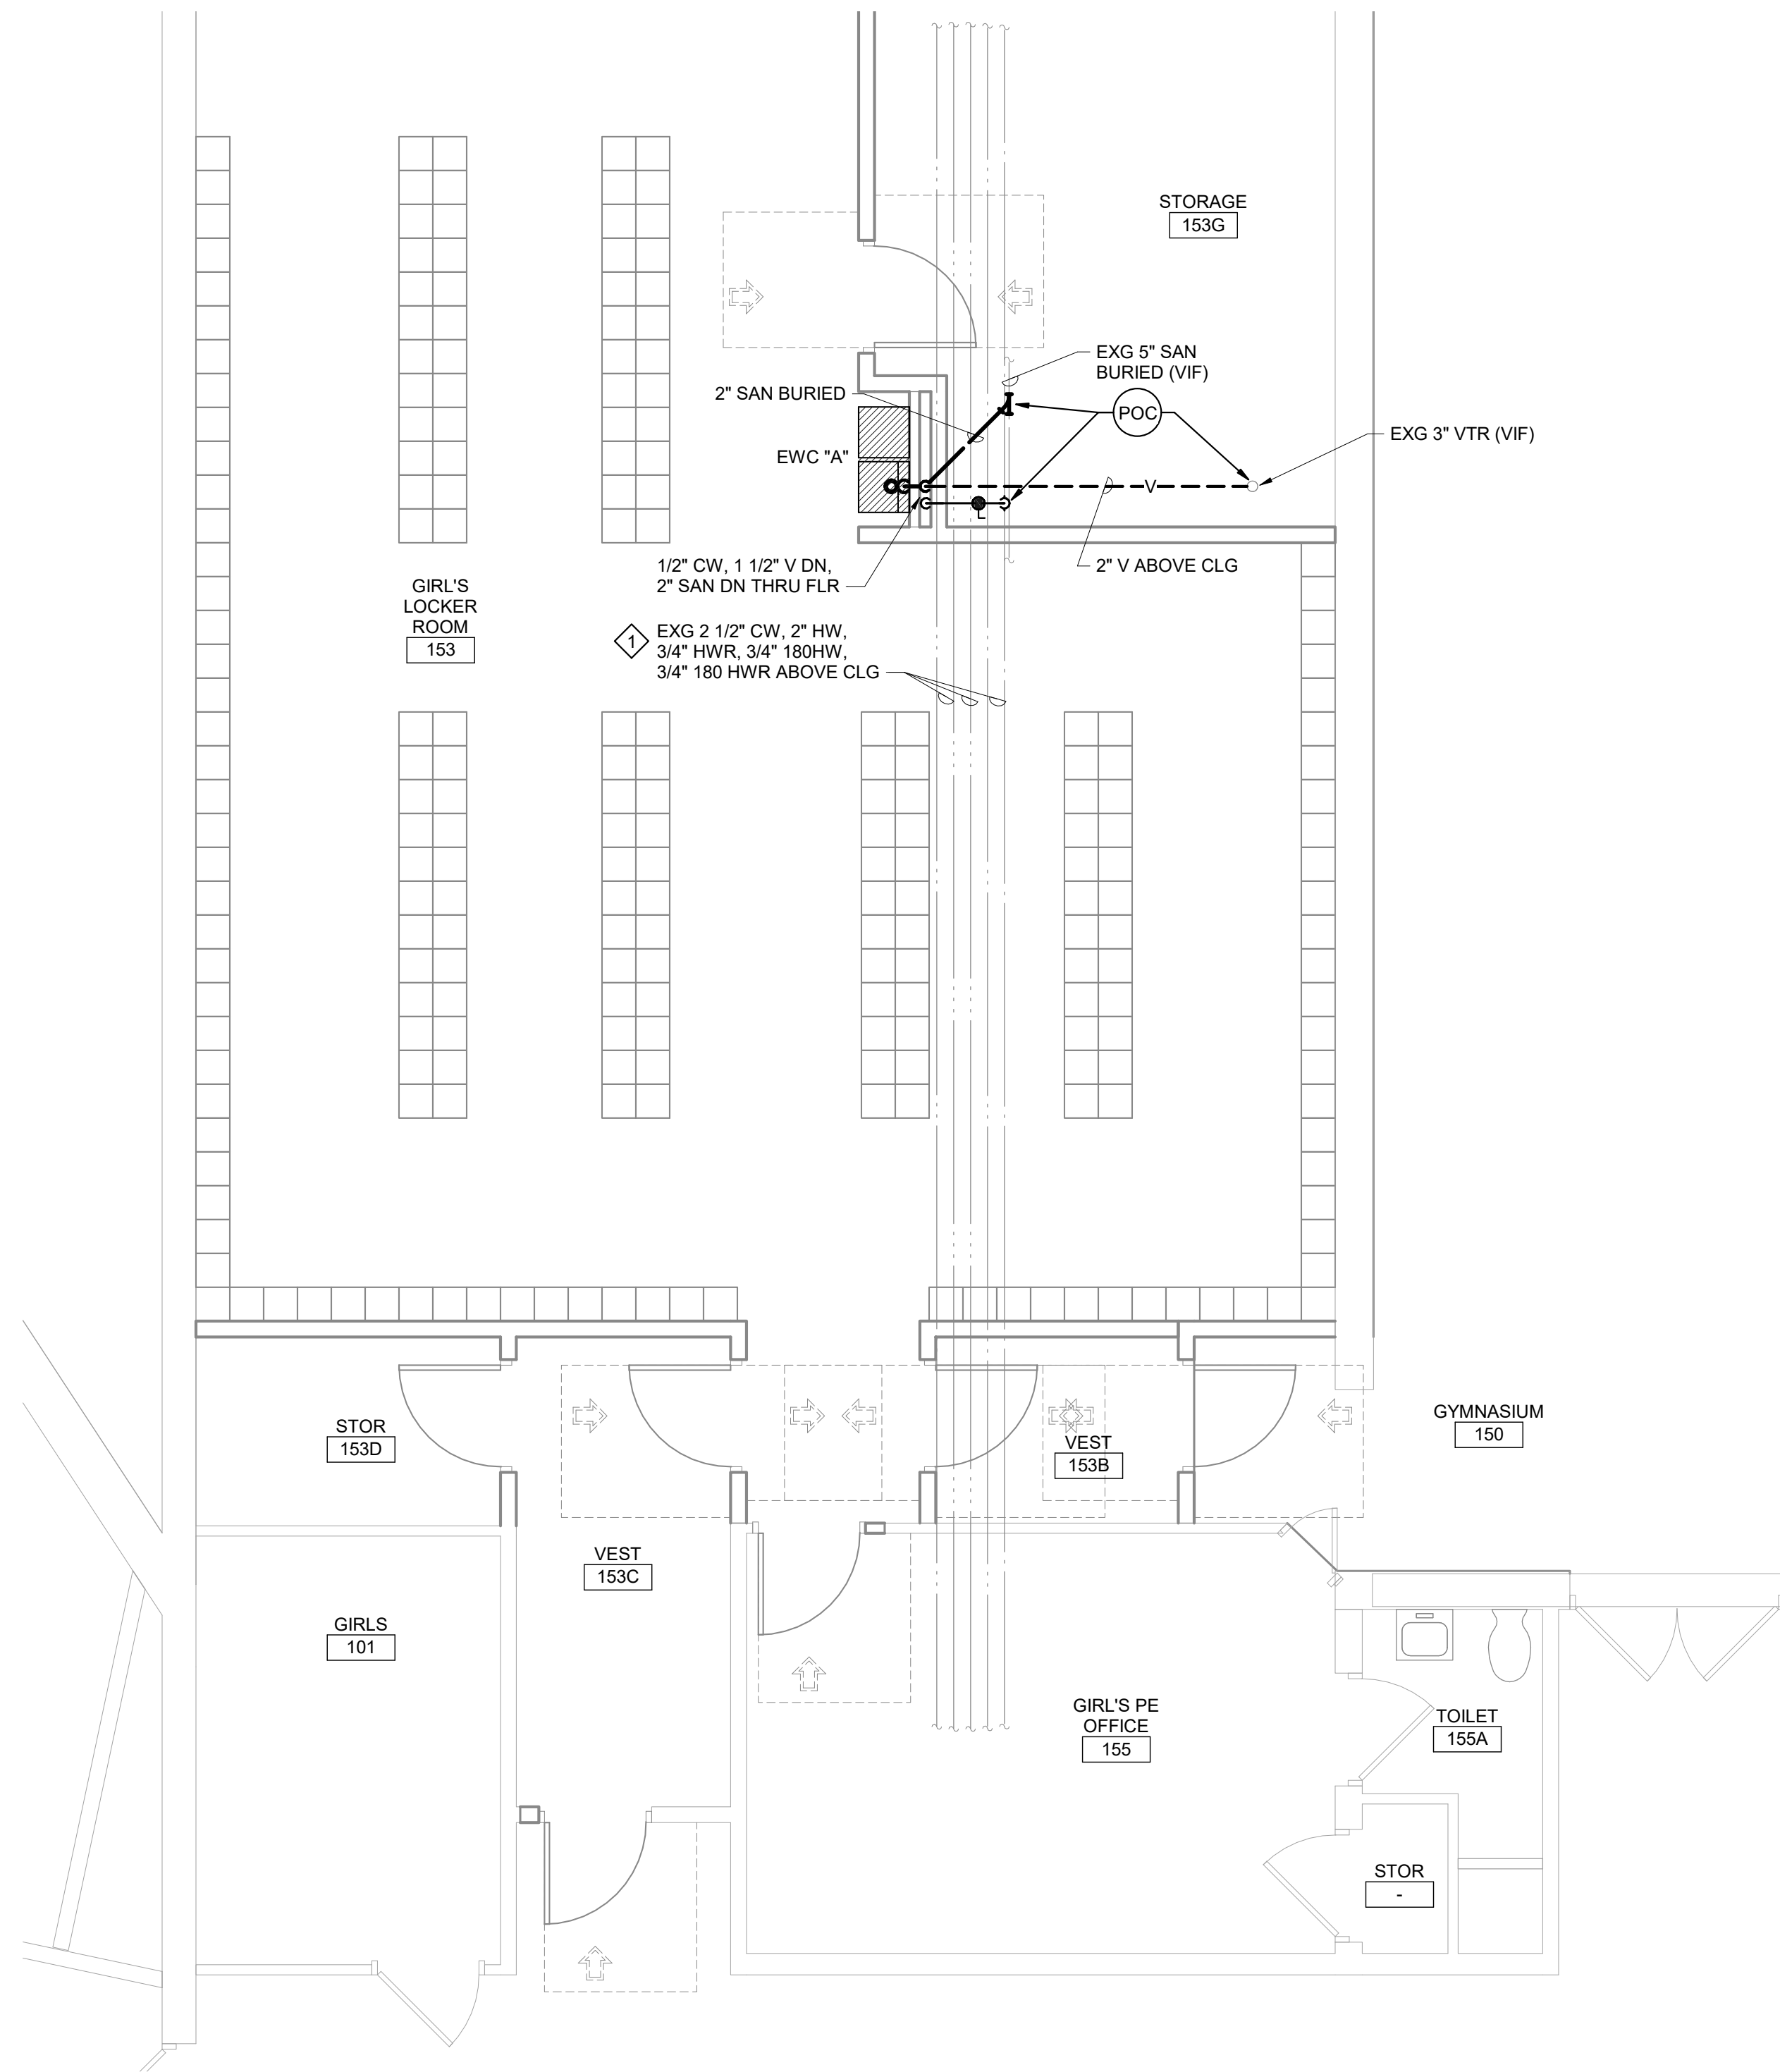

2 Girls Locker Room 153 Plan
1/4" = 1'-0"

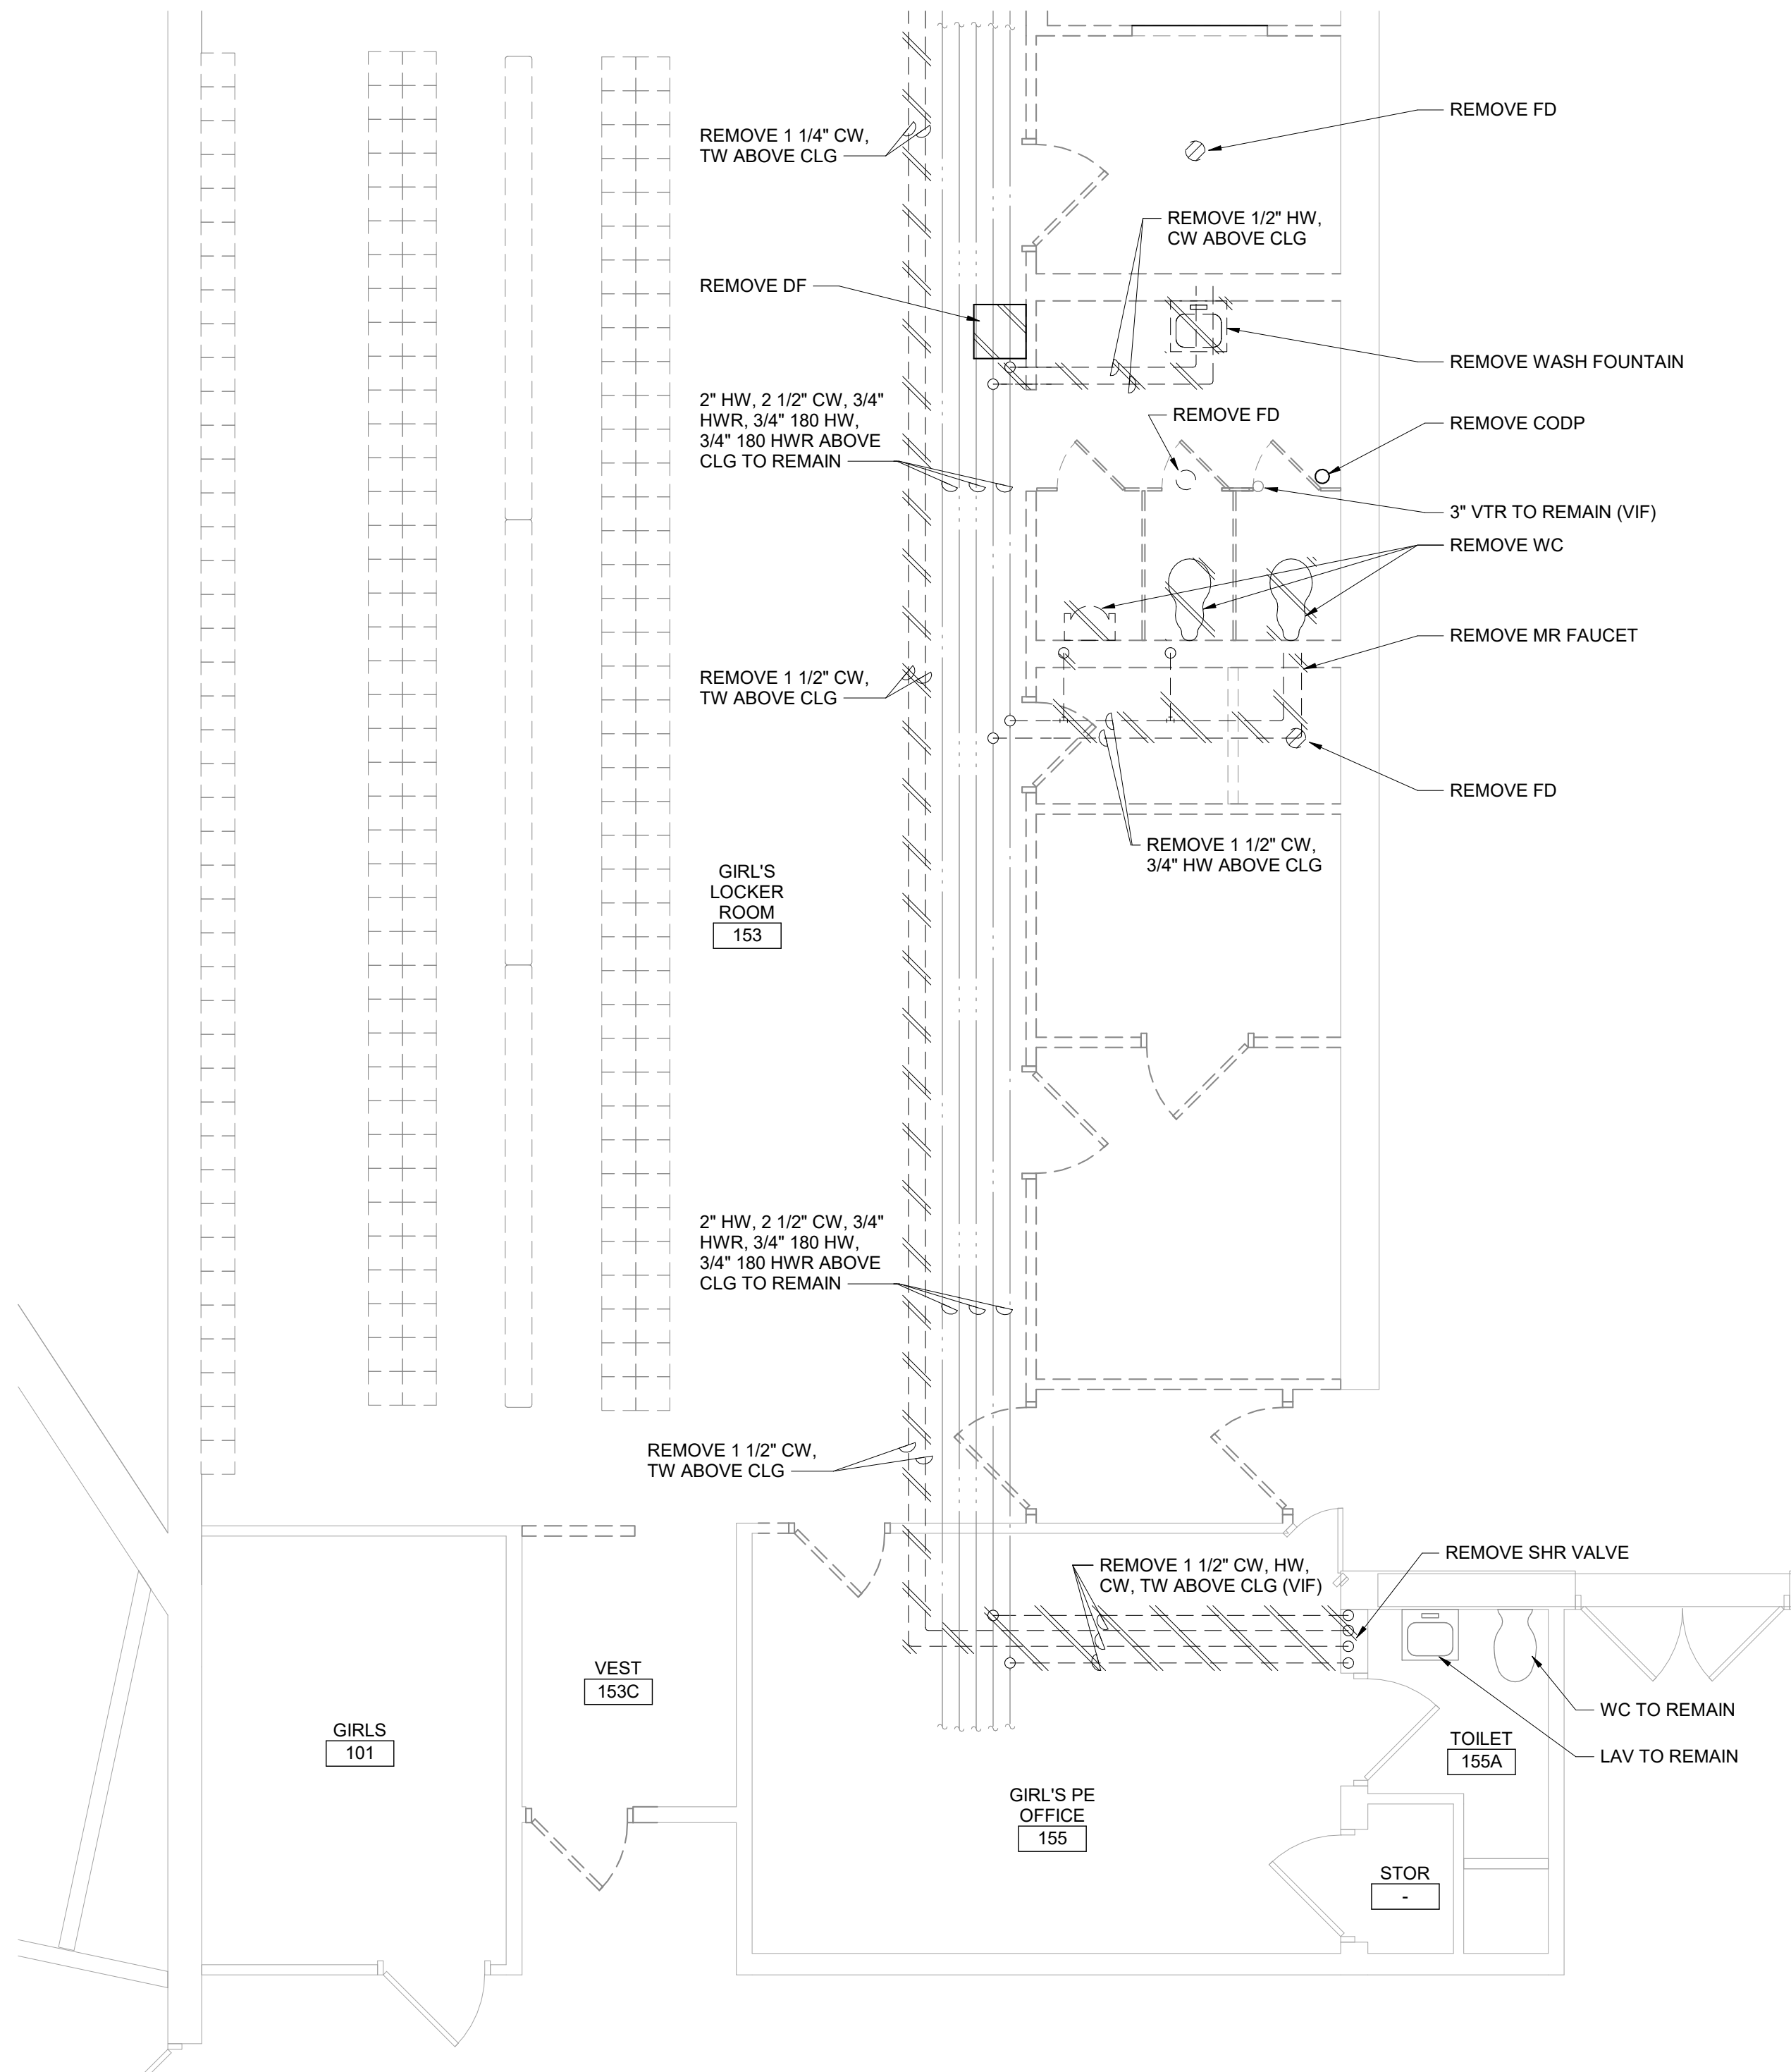


1 Girls Locker Room 153 Demolition Plan
1/4" = 1'-0"

Plan Notes

- A. REFER TO DRAWING NO. AP050 FOR GENERAL NOTES.
- B. REMOVE PLUMBING FIXTURES INDICATED, INCLUDING ASSOCIATED PIPING, FASTENERS, SUPPORTS, ETC., BACK TO POINTS OF CONCEALMENT WITHIN OR BEHIND REMAINING WALLS, BELOW FLOORS OR ABOVE CEILINGS.
- C. REMOVE ABANDONED ACCESSIBLE PIPING TO MAIN BRANCHES, STACKS OR RISERS AS REQUIRED TO ELIMINATE EXPOSED PIPING AND DEAD END PIPING RUNS LONGER THAN 1'-0". COORDINATE CONCEALMENT OF PIPING WITH FINAL CONSTRUCTION OF WALLS, FLOORS AND CEILINGS.


Plumbing Notes

- REINSULATE EXISTING DOMESTIC WATER PIPING AFTER ASBESTOS ABATEMENT. VERIFY IN FIELD EXACT SIZES, QUANTITIES AND LOCATIONS.

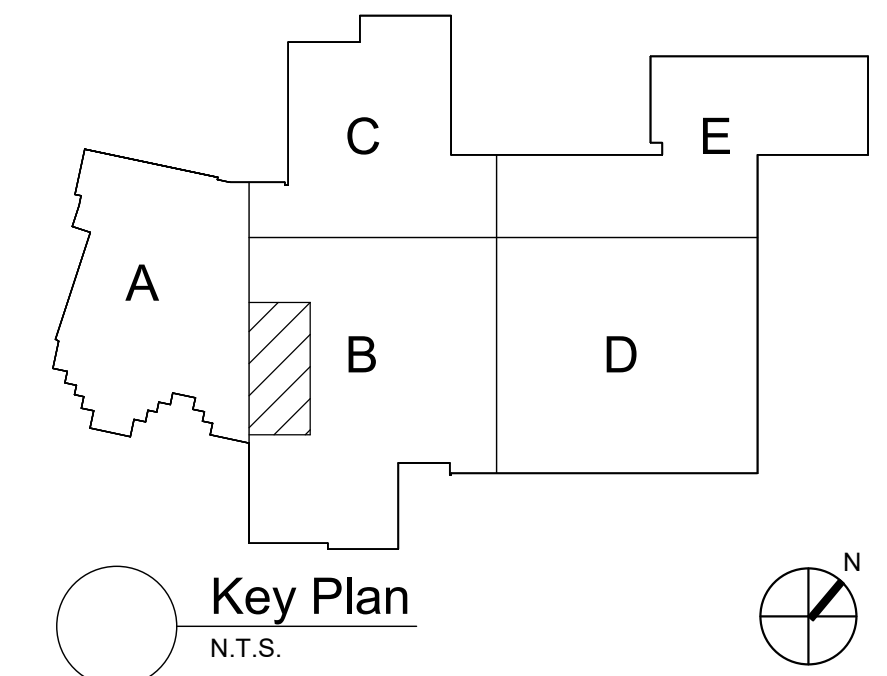

S.E.D. Control No. 62-18-01-06-0-007-019

Rev. No.:	Date:	Description:

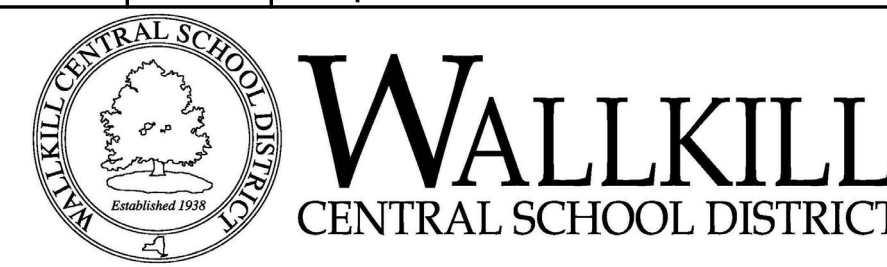

complex world | CLEAR SOLUTIONS

Tetra Tech Engineers, Architects & Landscape Architects, P.C.

BID SET



Wallkill Central School District
Wallkill, New York

Reconstruction to:
Wallkill Senior High School

Girls Locker Room 153 Plans

Drawn By: BCL	Date: 06/30/2023	Drawing Number:
Project No.: 17597-22002	AP403	