


1 Partial First Floor Power Plan - Area A
1/8" = 1'-0"

Keyed Notes:
1 RE-CONNECT STORED CEILING MOUNTED ELECTRICAL DEVICES.
MODIFY/ EXTEND CIRCUITRY AS REQUIRED


General Notes:
A. REFER TO DRAWING AE050 FOR GENERAL NOTES
B. REFER TO AE600 PANEL BOARD SCHEDULES FOR ADDITIONAL INFORMATION

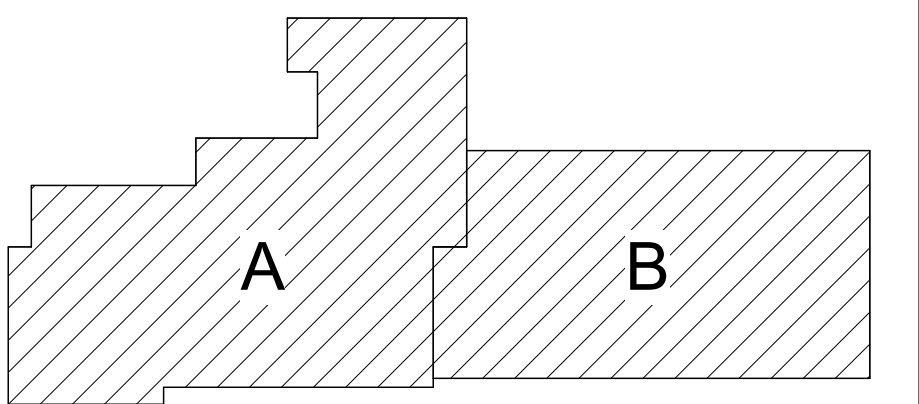

Key Plan
N.T.S.

S.E.D. Control No. 62-18-01-06-0-002-015

Rev. No.: Date: Description:

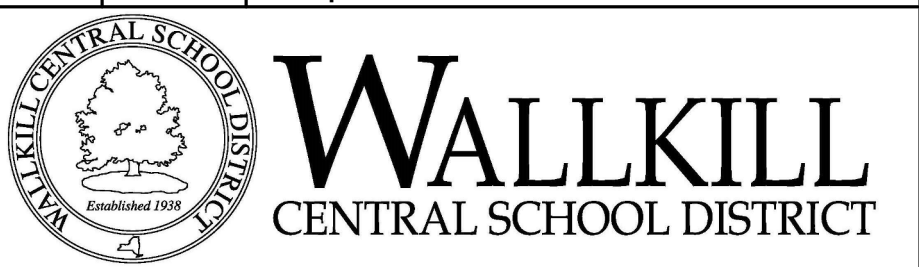

complex world
CLEAR SOLUTIONS

Tetra Tech Engineers, Architects
& Landscape Architects, P.C.



Wallkill Central School District
Wallkill, New York

Reconstruction to:
John G. Borden Middle School

Partial First Floor Power Plan - Area A

Drawn By: GLK/ded	Date: 06/30/2023	Drawing Number:
Project No.: 17597-22002		BE161