



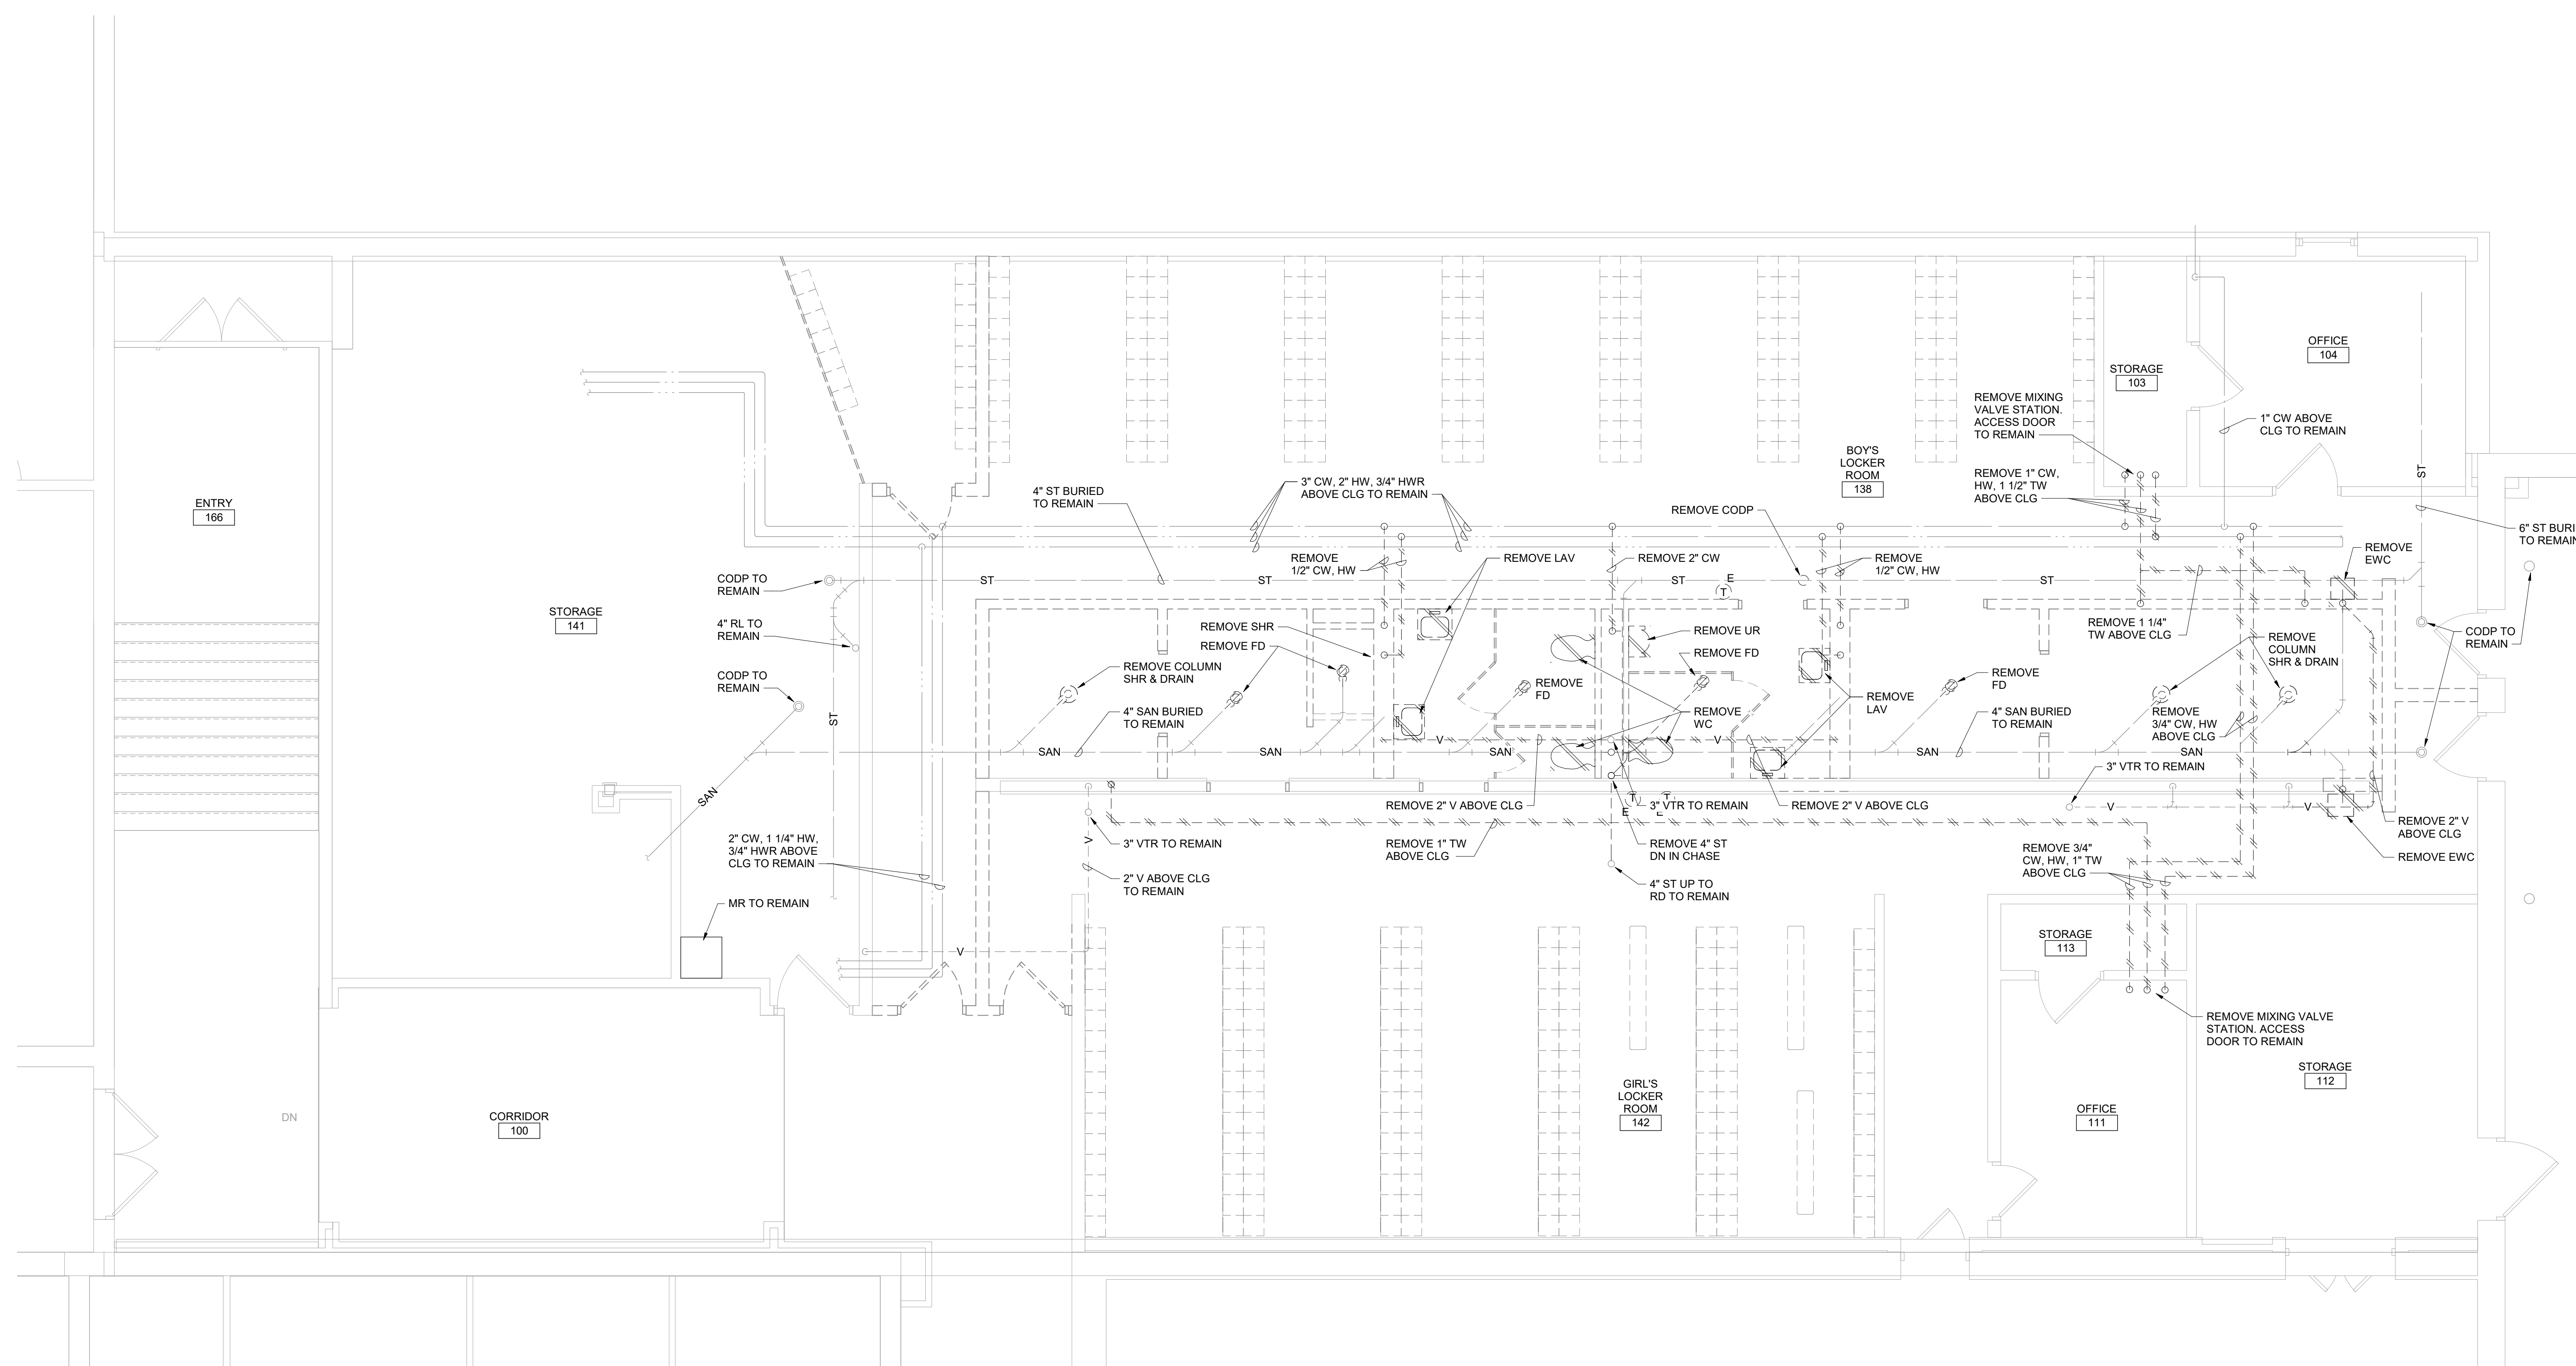

1 Enlarged Locker Rooms Demolition Plan
1/4" = 1'-0"

Plan Notes


- | | |
|----|---|
| A. | REFER TO DRAWING NO. BP050 FOR GENERAL NOTES. |
| B. | REMOVE PLUMBING FIXTURES INDICATED, INCLUDING ASSOCIATED PIPING, FASTENERS, SUPPORTS, ETC., BACK TO POINTS OF CONCEALMENT WITHIN OR BEHIND REMAINING WALLS, BELOW FLOORS OR ABOVE CEILINGS. |
| C. | REMOVE ABANDONED ACCESSIBLE PIPING TO MAIN BRANCHES, STACKS OR RISERS AS REQUIRED TO ELIMINATE EXPOSED PIPING AND DEAD END PIPING RUNS LONGER THAN 1'-0". COORDINATE CLOSURE OF PIPING WITH THE FINAL CONSTRUCTION OF WALLS, FLOORS AND CEILINGS. |

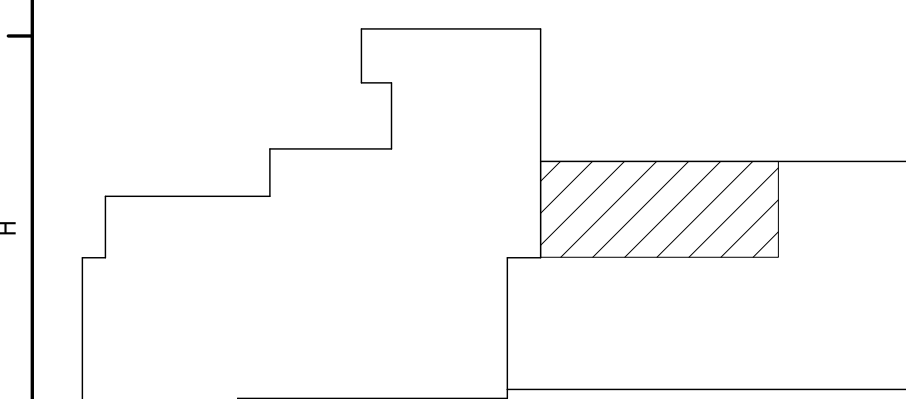

Key Plan
N.T.S.

S.E.D. Control No. 62-18-01-06-0-002-015

Rev. No.:	Date:	Description:
-----------	-------	--------------

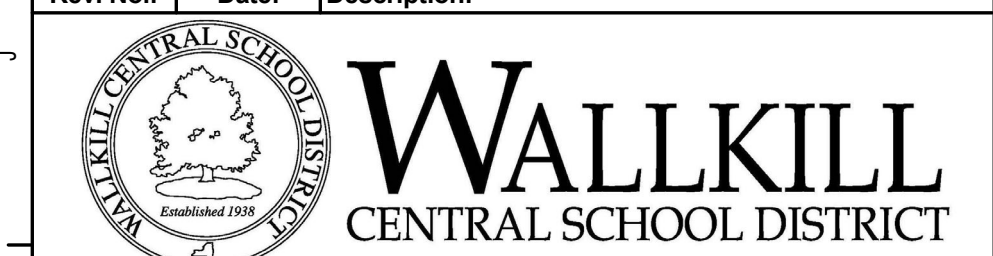

complex world | CLEAR SOLUTIONS

Tetra Tech Engineers, Architects
& Landscape Architects, P.C.



Wallkill Central School District Wallkill, New York
--

Reconstruction to: John G. Borden Middle School
--

Locker Rooms Demolition Plan

N	Drawn By: BCL	Date: 06/30/2023	Drawing Number:
	Project No.: 17597-22002		BP400

BID SET