

**COUNTY OF WESTCHESTER
NEW YORK**

**DEPARTMENT OF PUBLIC WORKS
AND TRANSPORTATION**

DIVISION OF ENGINEERING

ADDENDUM NO. 3

CONTRACT NO. 22-524

FOR

**REPLACEMENT OF HVAC SYSTEMS AND ASSOCIATED WORK
BEE-LINE CENTRAL MAINTENANCE FACILITY (DOT-CMF)
YONKERS, NEW YORK**

The attention of the bidders is directed to the following changes, additions, and/or substitutions affecting the above-referenced contract(s).

A. RE: THE DRAWINGS

ITEM A:

Delete: Sheet A-1

Insert: Attached Sheet A-1

ITEM B:

Delete: Sheet A-2











Insert: Attached Sheet A-2

ALL PROVISIONS OF THE CONTRACT NOT AFFECTED BY THE FOREGOING SHALL REMAIN IN FULL FORCE AND EFFECT.

COUNTY OF WESTCHESTER
DEPARTMENT OF PUBLIC WORKS
AND TRANSPORTATION


By: Hugh J. Greechan Jr., P.E.
Commissioner

Dated: Dec 19, 2023
WHITE PLAINS, NEW YORK

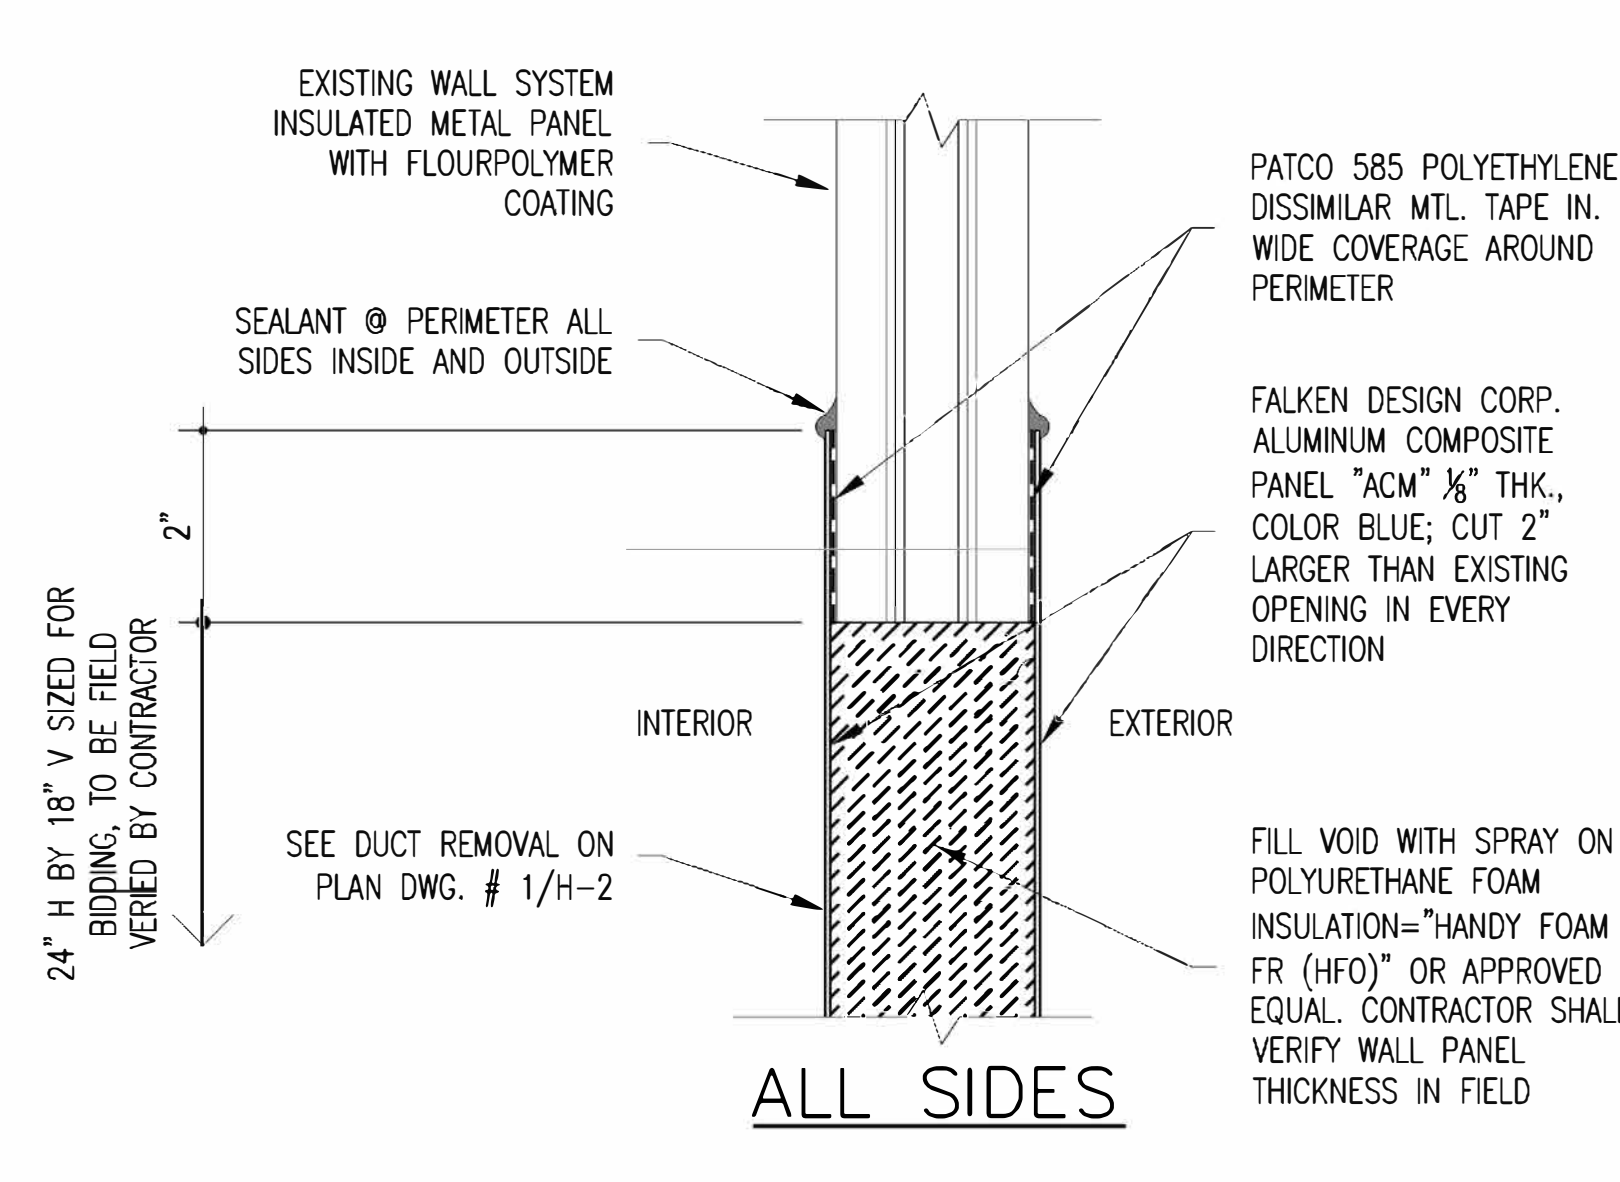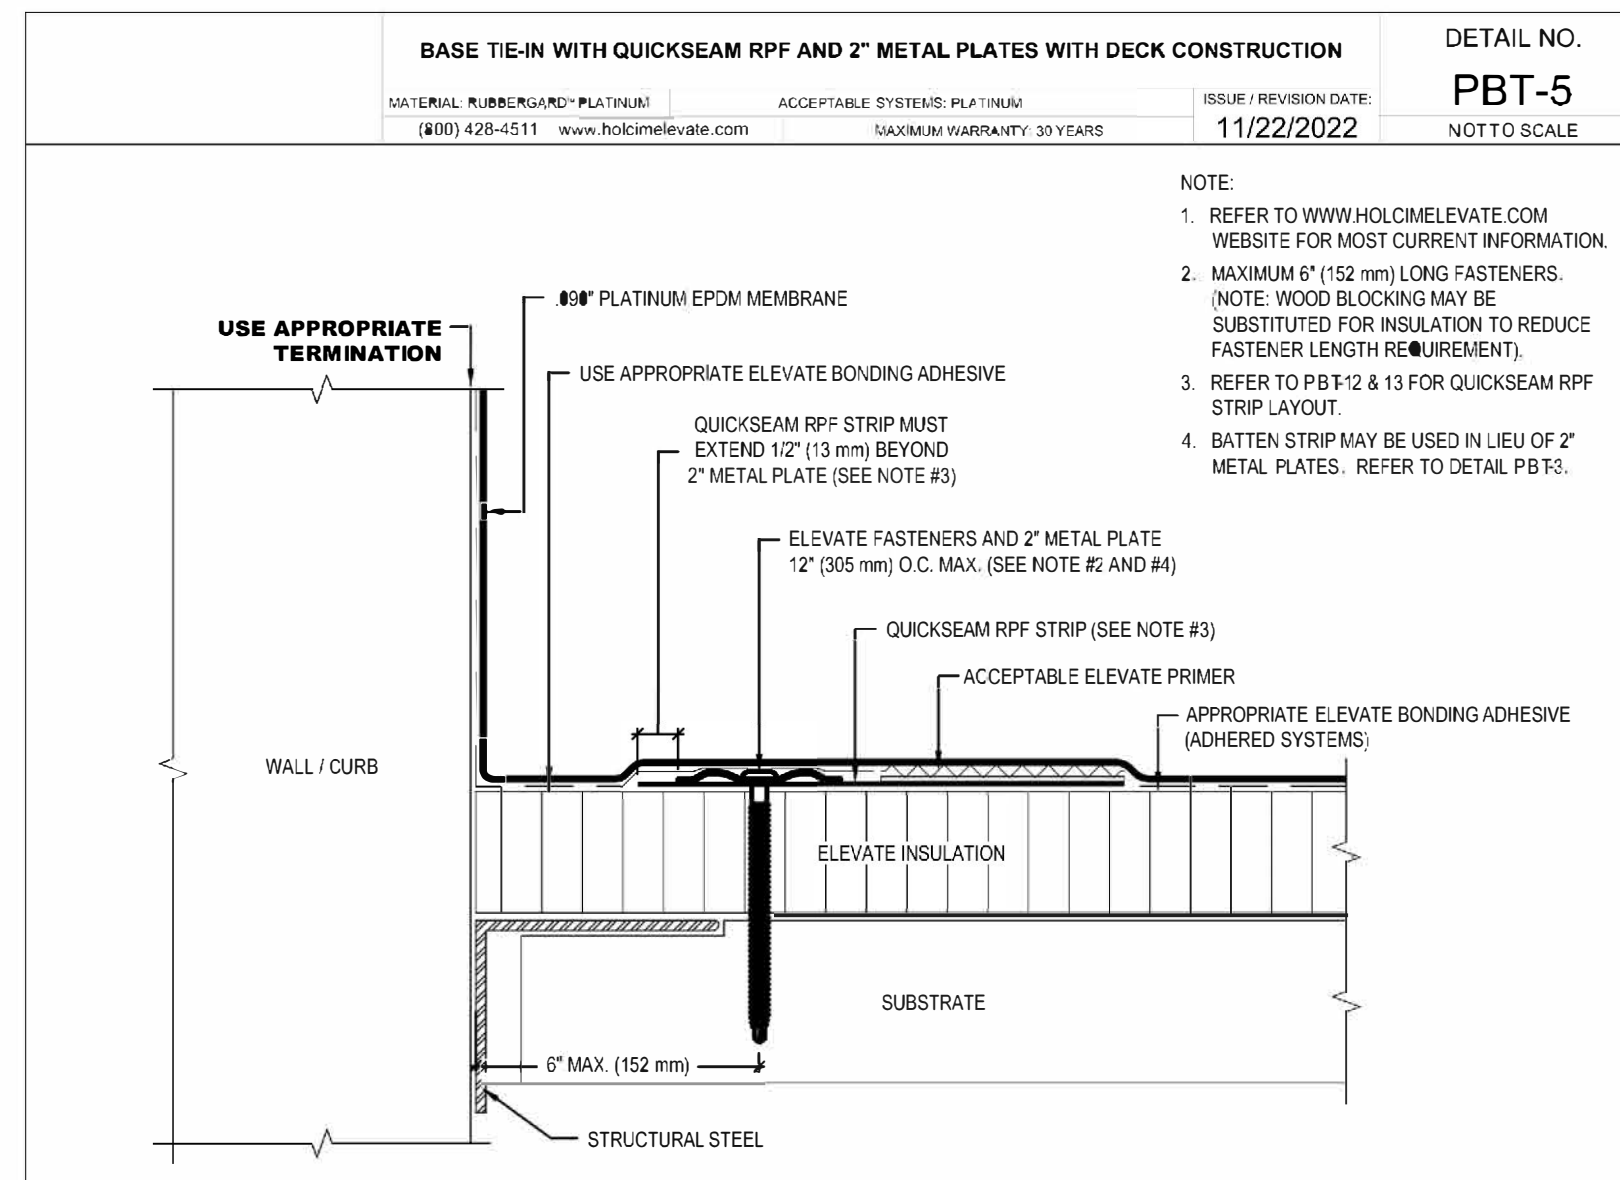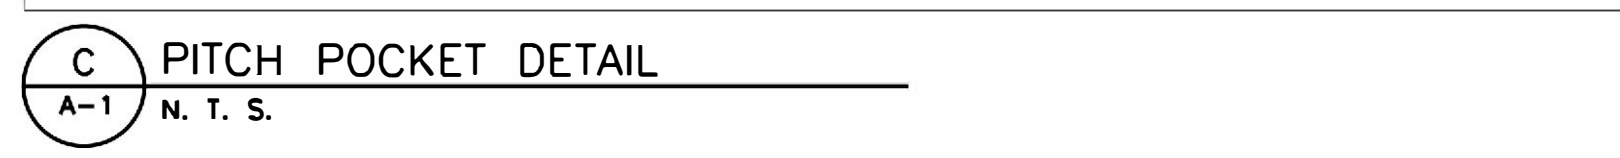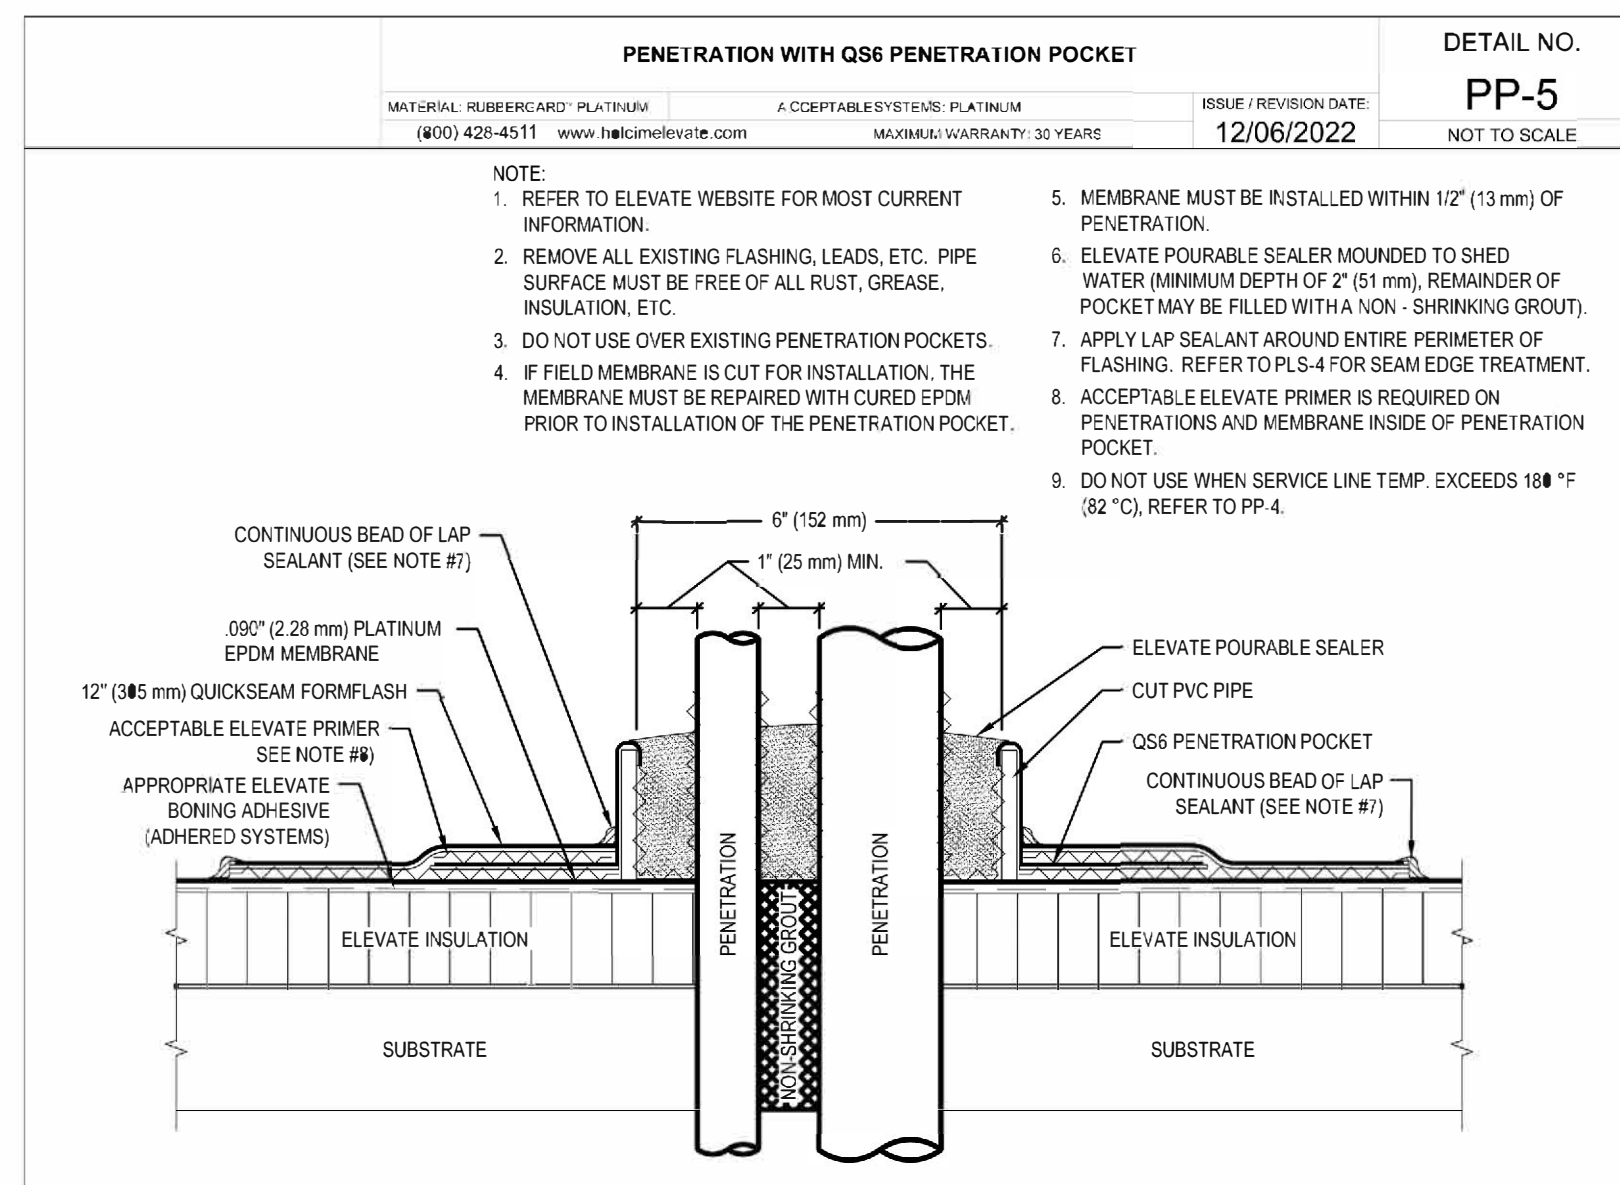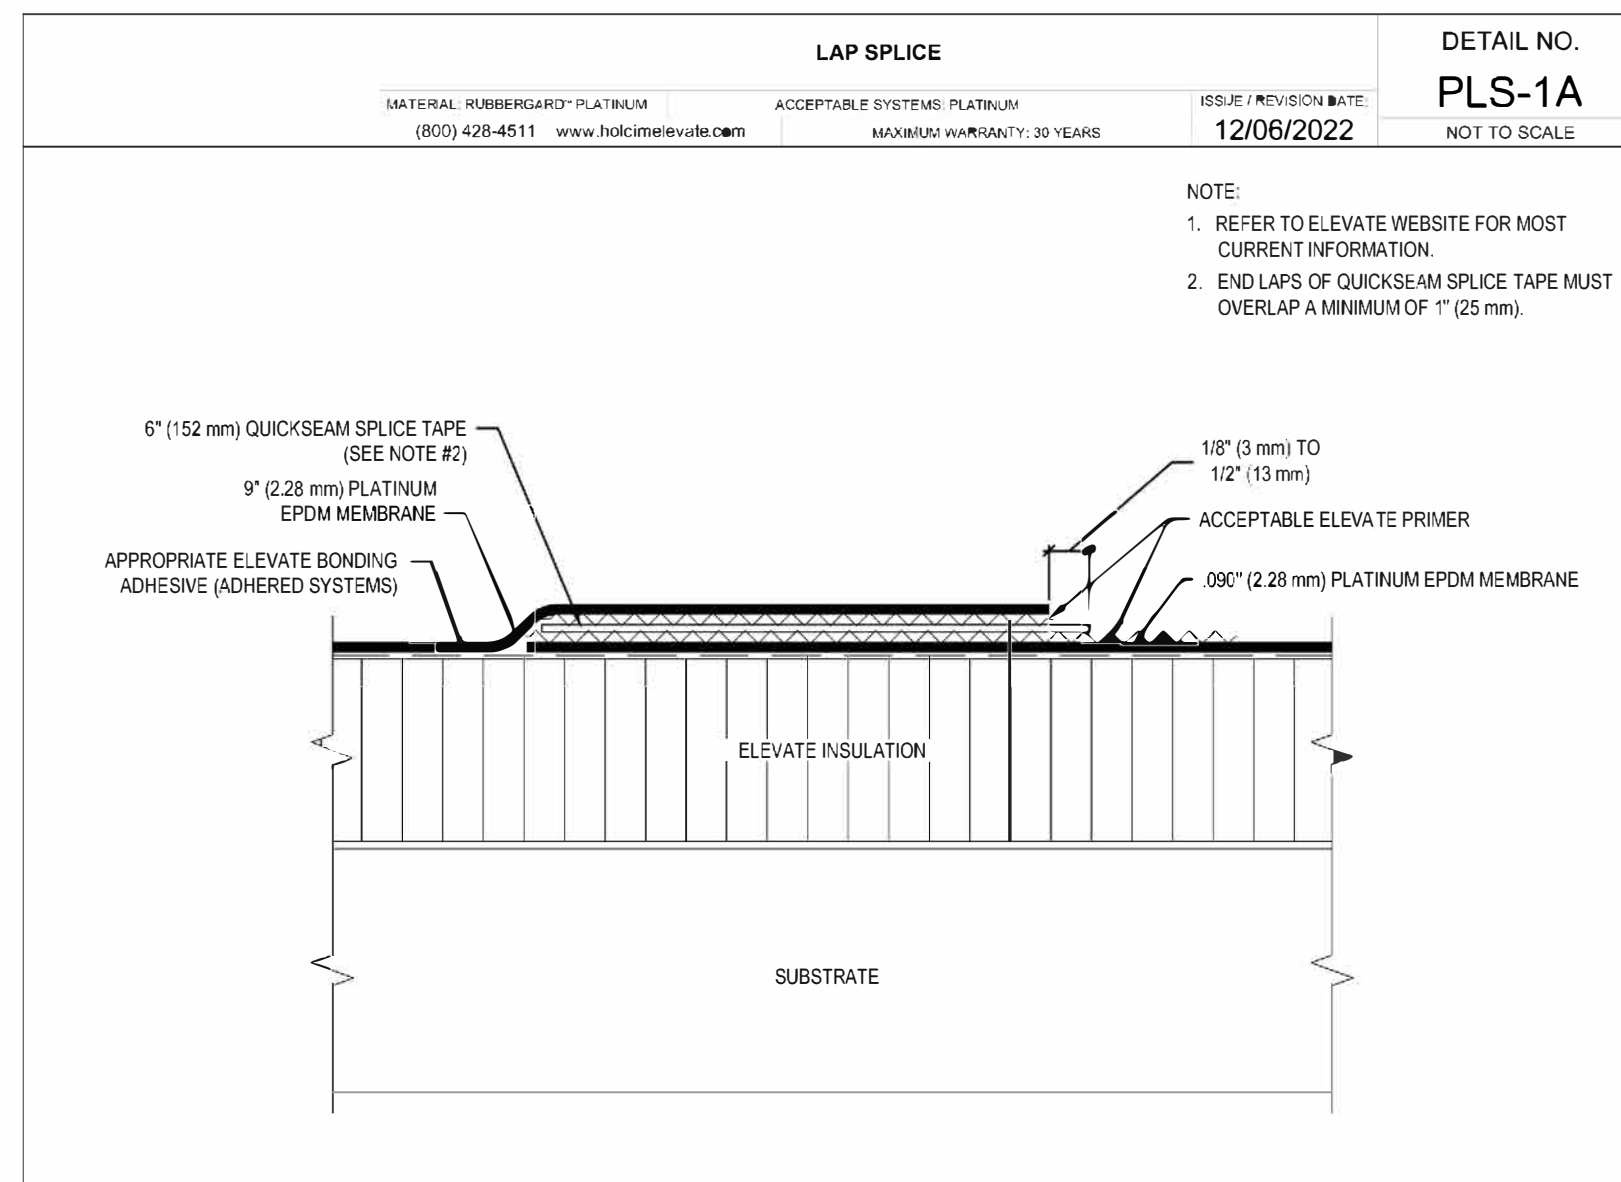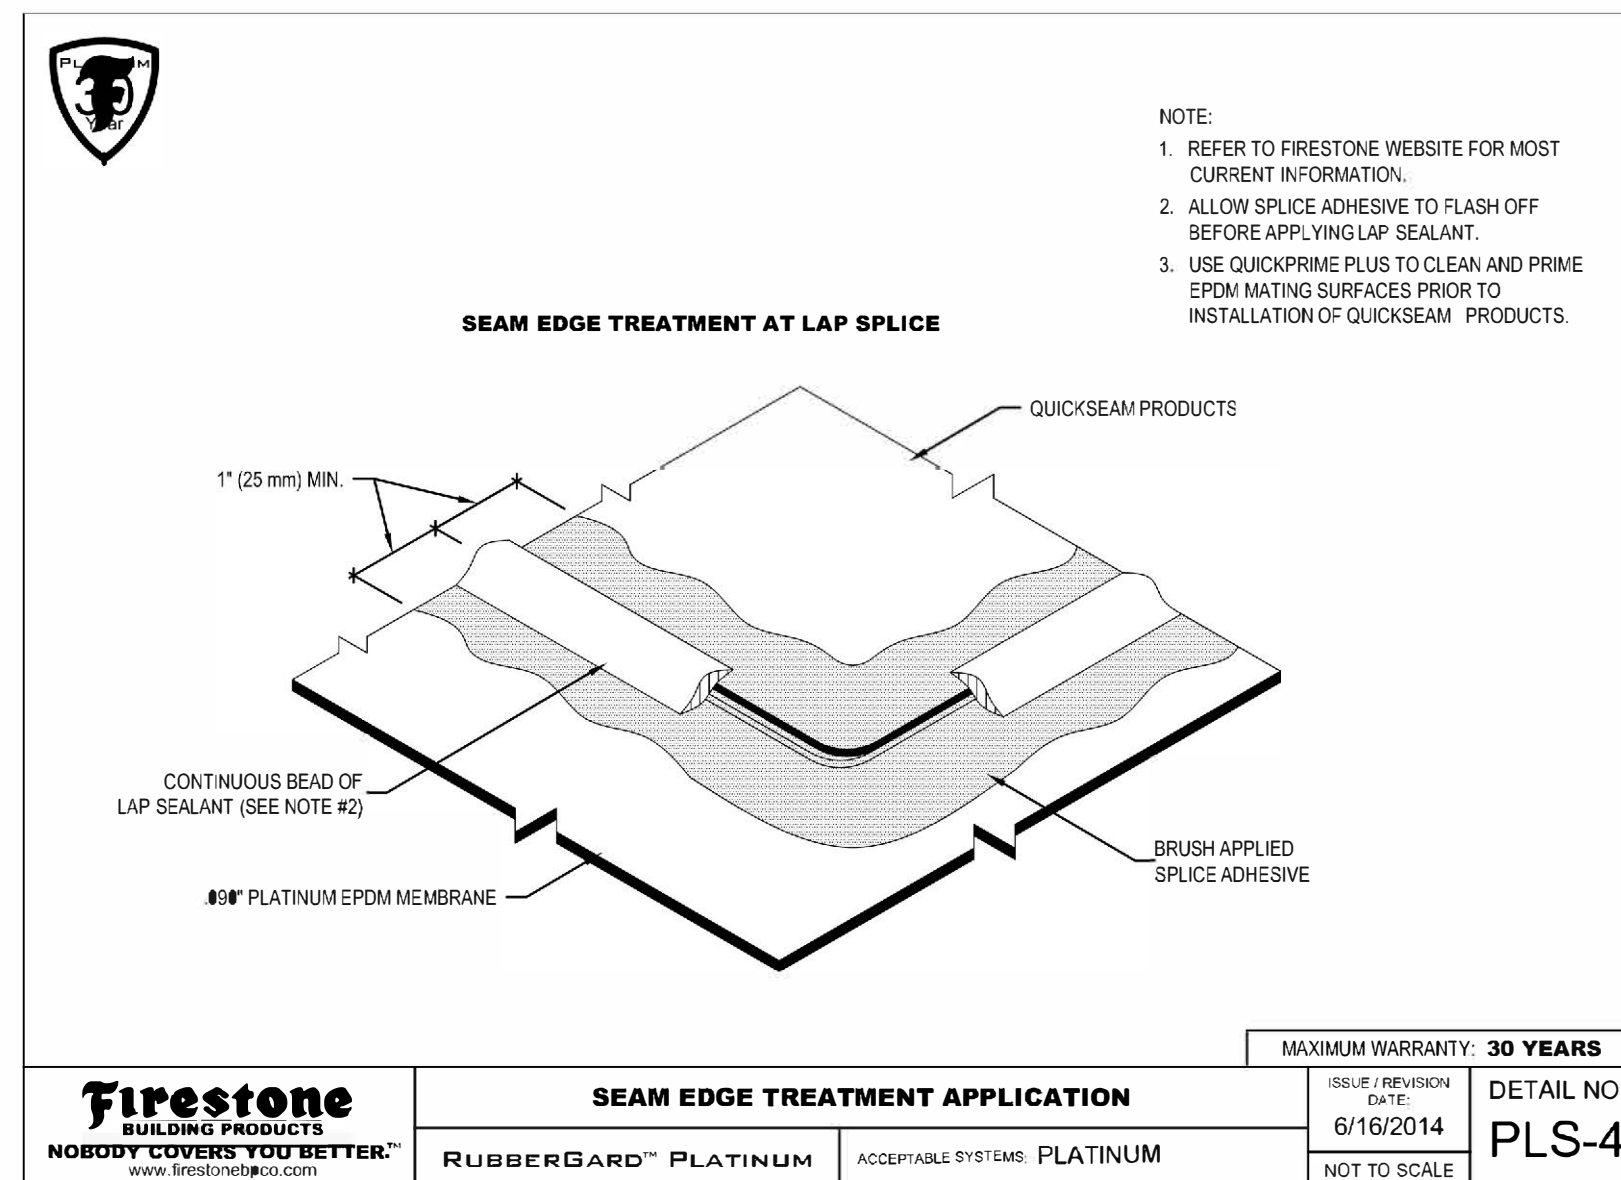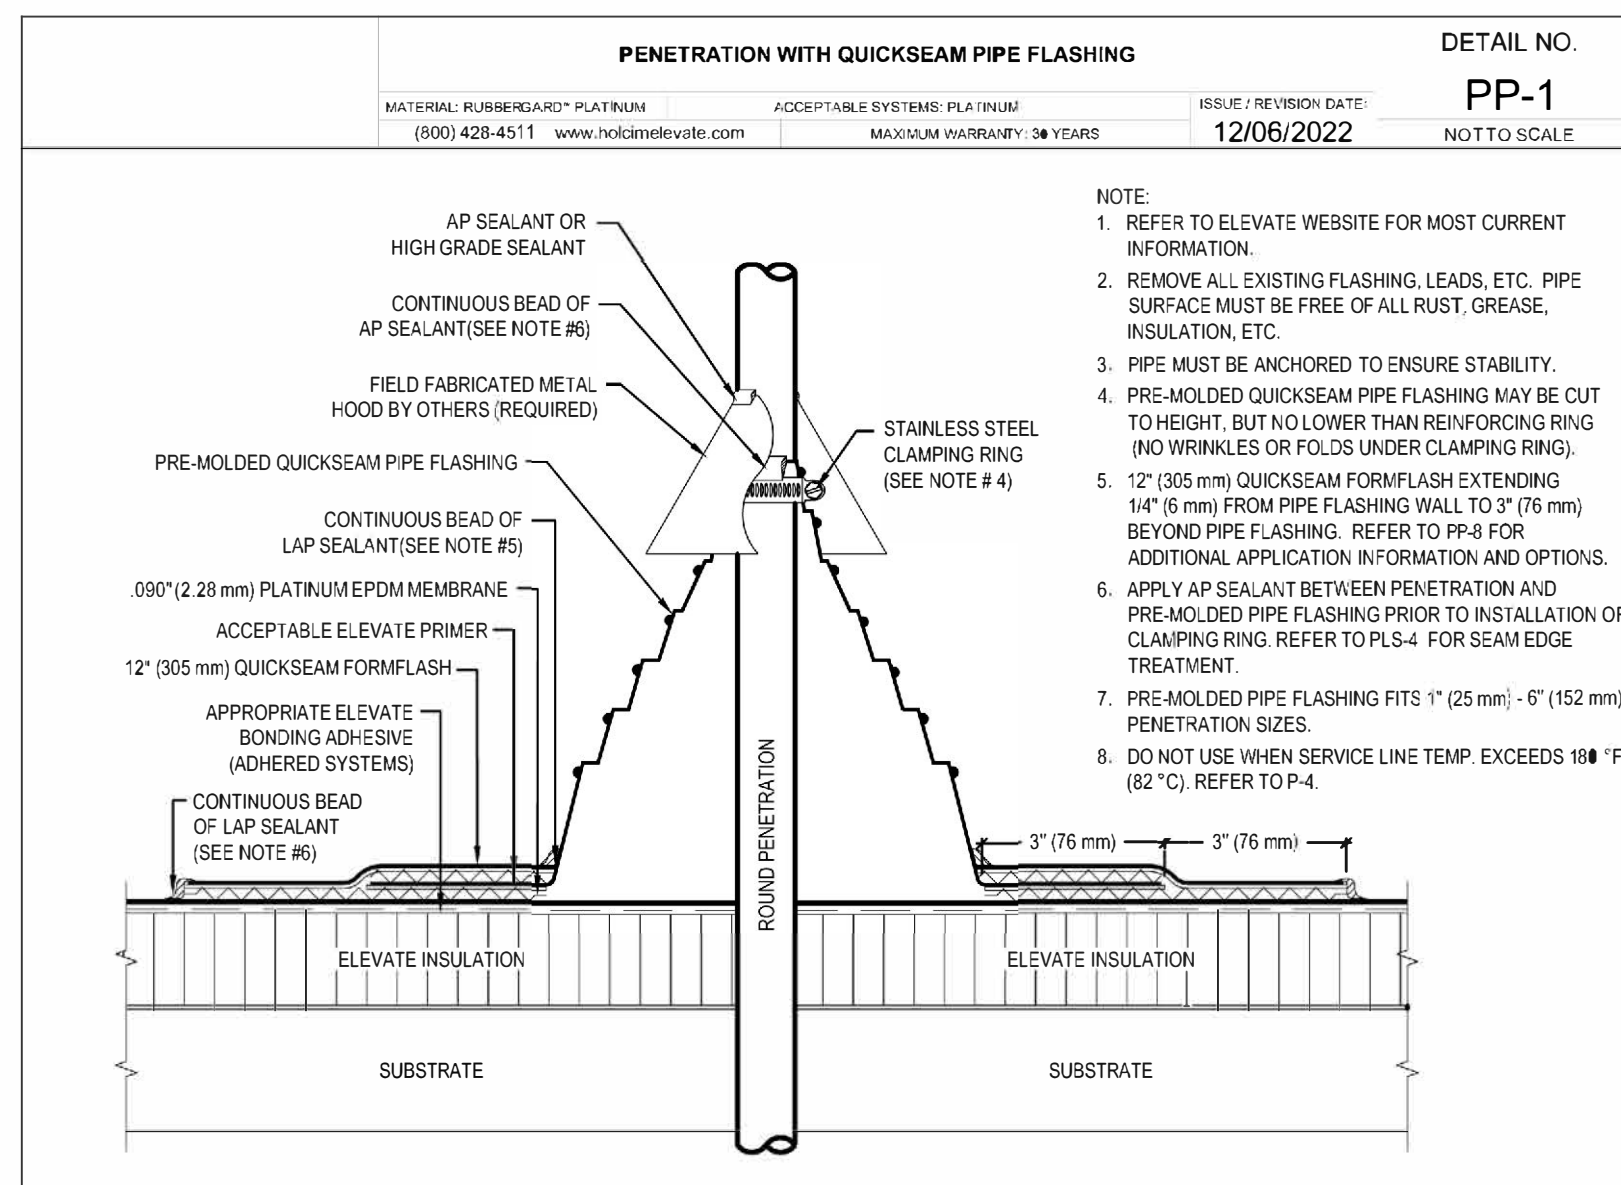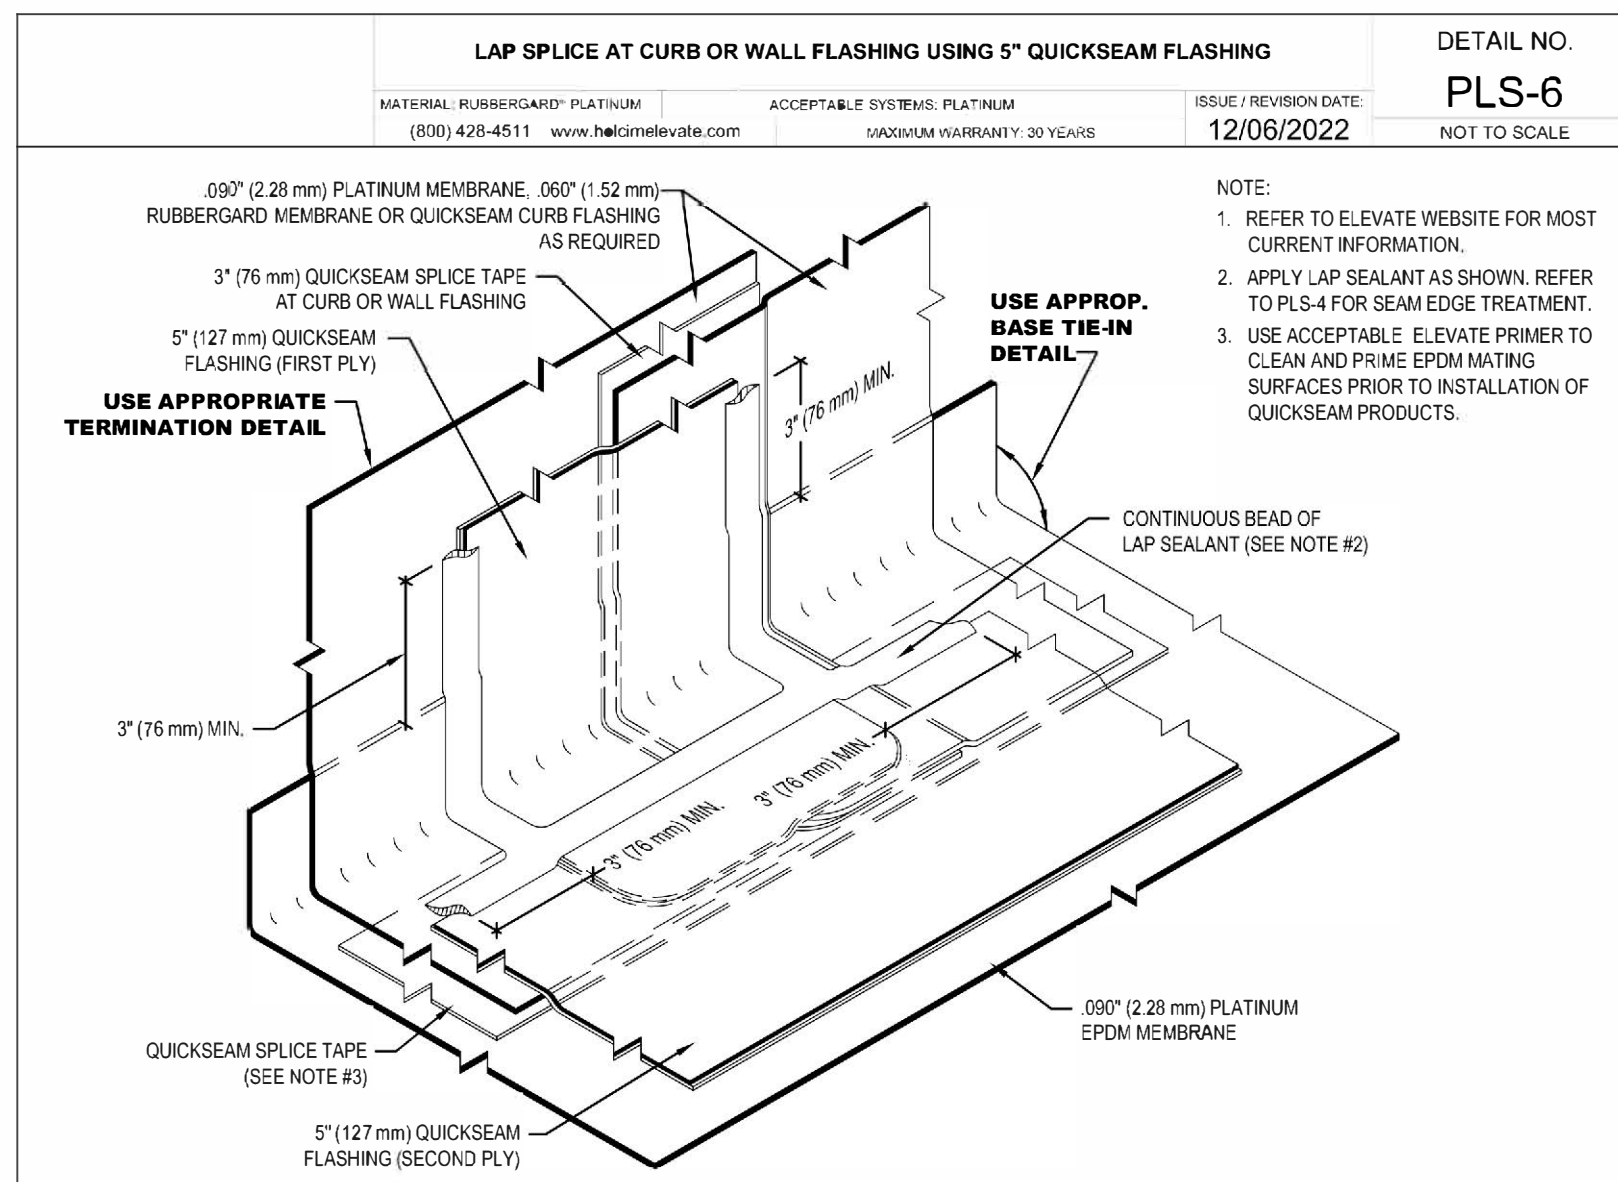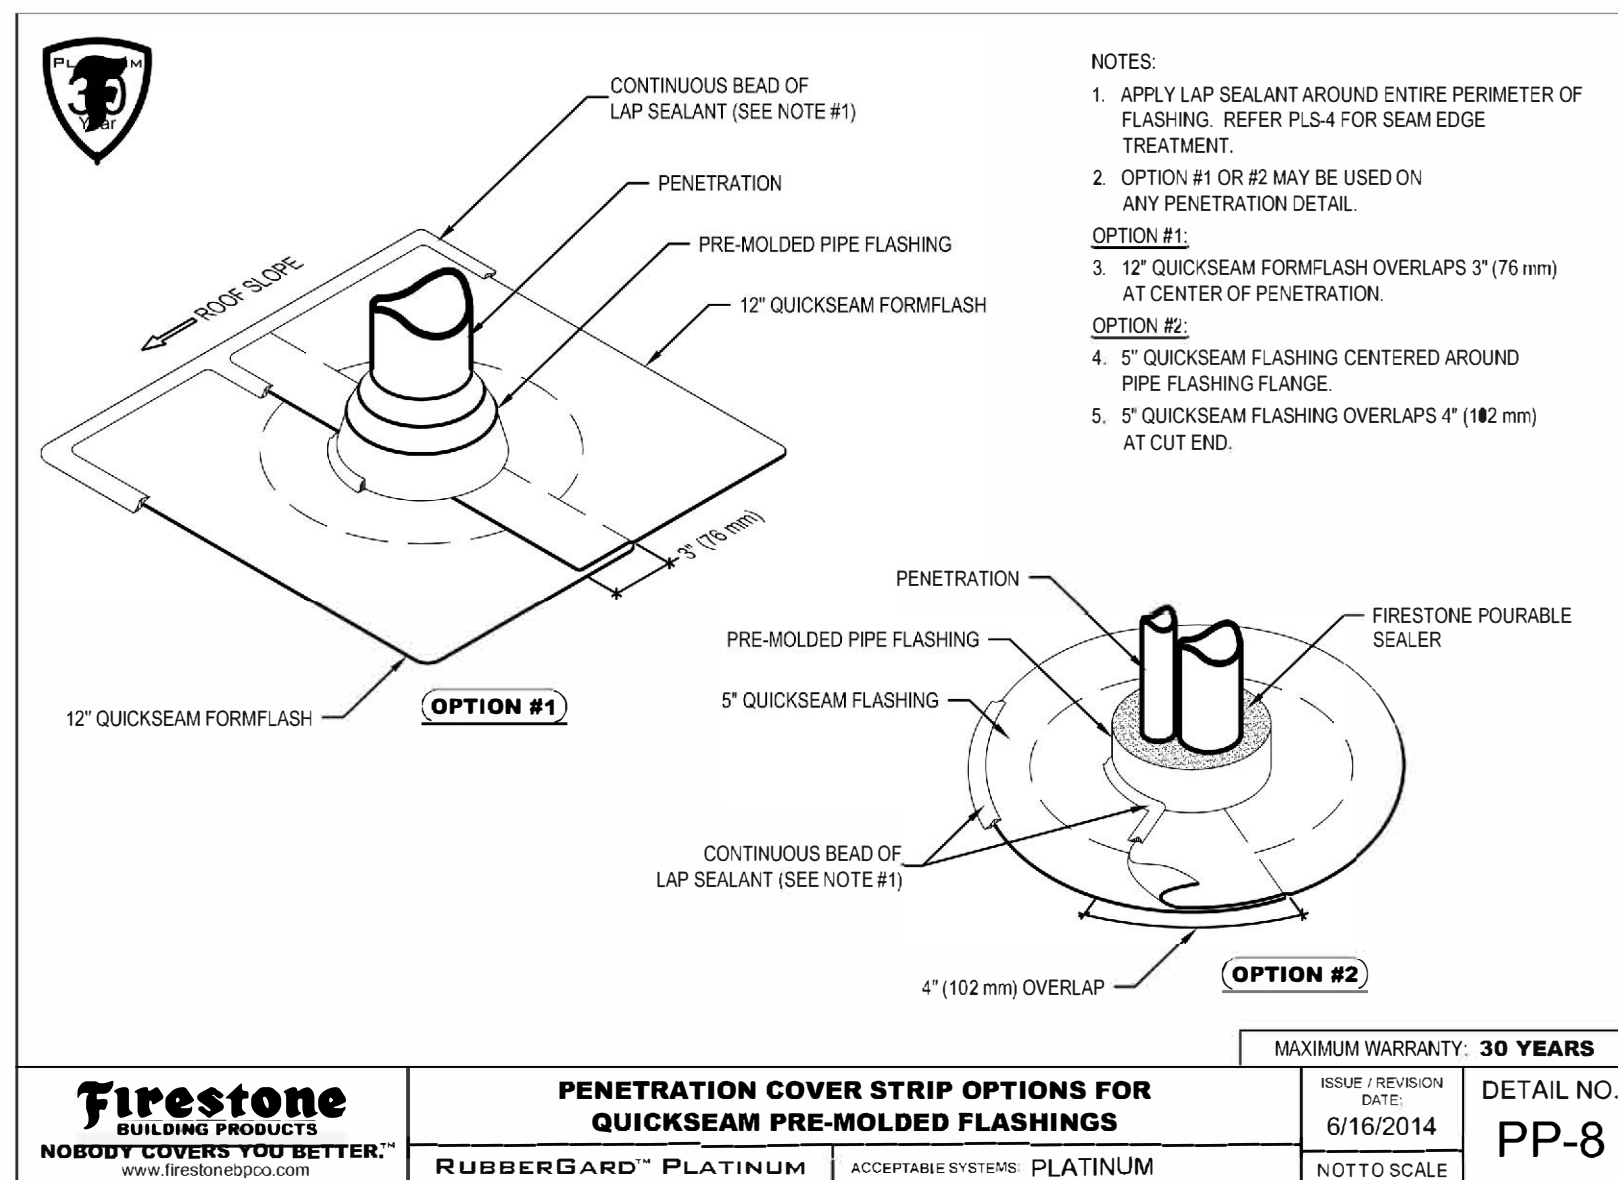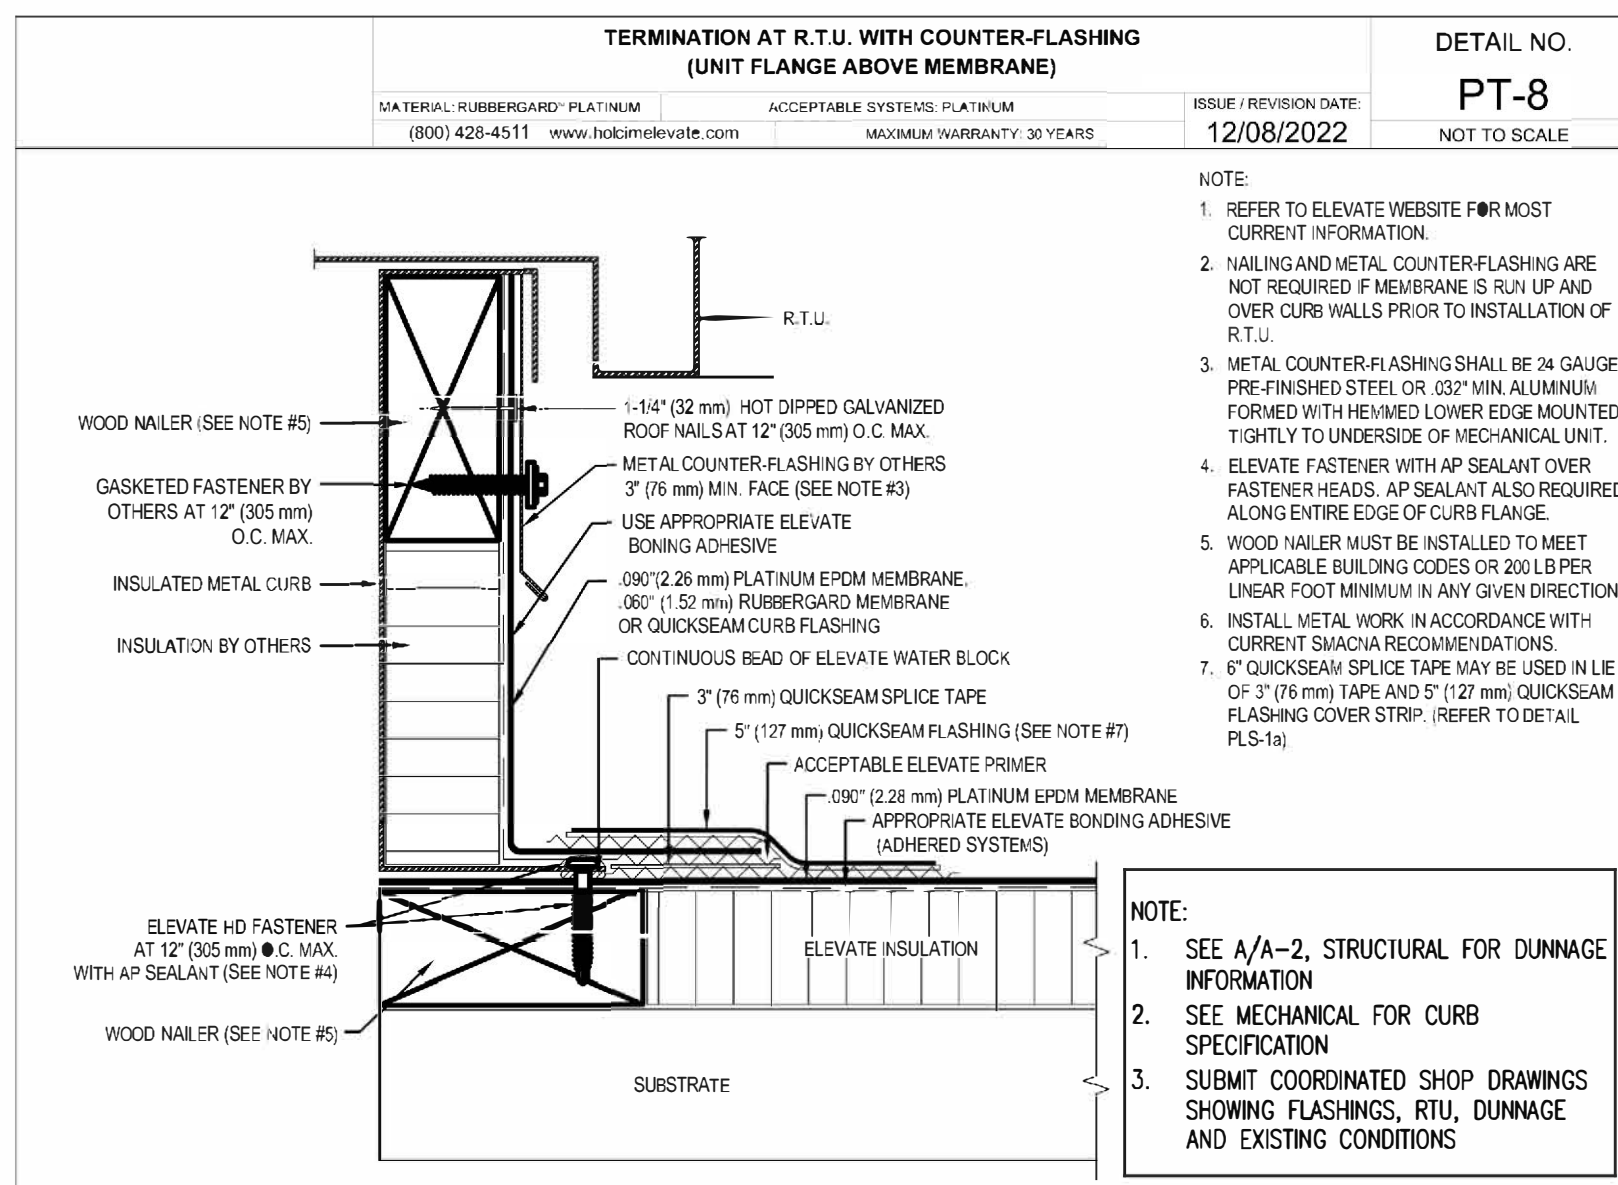


ROOFING NOTES

1. EXISTING ROOF IS UNDER FIRESTONE PLATINUM-PHW ROOFING SYSTEM LIMITED WARRANTY
2. CONTRACTOR SHALL CONTACT FIRESTONE TO FAMILIARIZE AND EXECUTE ALL WORK IN COMPLIANCE WITH FIRESTONE REQUIREMENTS TO MAINTAIN EXISTING ROOF WARRANTY
3. CONTACT FIRESTONE AT 800-836-5612, DOWNLOAD POST WARRANTY ALTERATION FORM FROM WWW.FIRESTONEFOCUS.COM WEBSITE, AND SUBMIT REQUIRED DOCUMENTS TO FIRESTONE FOR REVIEW AND APPROVAL OF COMPLETED WORK.
4. SUBMIT SHOP DRAWINGS AND PRODUCTS THAT HAVE BEEN APPROVED BY FIRESTONE
5. SUBMIT SHOP DRAWINGS THAT ARE FULLY COORDINATED BETWEEN NEW MECHANICAL EQUIPMENT, EXISTING AND NEW STRUCTURAL MEMBERS AND FLASHINGS WITH ALL PERTAINING DIMENSIONAL DATA AND INCLUDE ALL SURROUNDING EXISTING CONDITIONS
6. CREATE CRICKETS AS REQUIRED FOR POSITIVE ROOF DRAINAGE AT ALL UNITS WITH ROOF CURBS

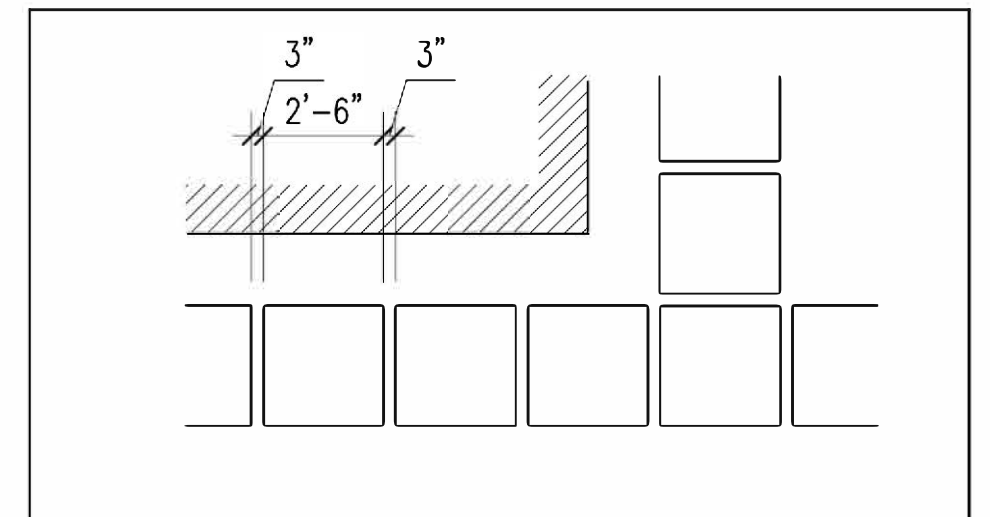

NOTES

 
1. PROVIDE 200 LINEAR FEET OF WALKWAY PATH CONSISTING OF WALKWAY PADS AROUND AND 18 INCHES AWAY FROM ALL NEW MECHANICAL EQUIPMENT AND CONNECTING TO EXISTING WALKWAY PATH.
3. ROOF WALKWAY PADS: BLACK: EPDM, 0.30 " (7.6 MM) THICK BY 30 " X 30 " (760 MM X 760 MM) WITH EPDM TAPE ADHESIVE STRIPS LAMINATED TO THE BOTTOM; QUICKSEAM™ WALKWAY PADS OR WHITE: EPDM, 0.30 " (7.6 MM) THICK BY 30 " X 30 " (760 MM X 760 MM) WITH EPDM TAPE ADHESIVE STRIPS LAMINATED TO THE BOTTOM; ECOWHITE™ QUICKSEAM™ WALKWAY PADS BY ELVATE.




	12/4/23	AG	AK	ADDENDUM # 3
REVISION NUMBER	DATE	MADE BY	APP'D BY	REVISION

RECORD DRAWING CERTIFICATION	
☐ AS BUILT — CHANGES AS NOTED ☐ AS BUILT — NO CHANGES	
CONTRACTOR	PROJECT COORDINATOR
NAME _____	NAME _____
SIGNATURE _____	SIGNATURE _____
TITLE _____ DATE _____	TITLE _____ DATE _____

WESTCHESTER COUNTY, NEW YORK DEPARTMENT OF PUBLIC WORKS AND TRANSPORTATION DIVISION OF ENGINEERING	CONTRACT NUMBER 22-524	SHEET NUMBER A-1
	SHEET NO. 2 OF 21	
REPLACEMENT OF HVAC SYSTEMS AND ASSOCIATED WORK BEE-LINE CENTRAL MAINTENANCE FACILITY (DOT-CMF) 475 SAW MILL RIVER ROAD, YONKERS, NEW YORK ROOF AND WALL PENETRATION DETAILS		
SCALE: AS NOTED DATE: 12/1/2023		REV. NO.: DPW FILE NO. 61-10-A-406

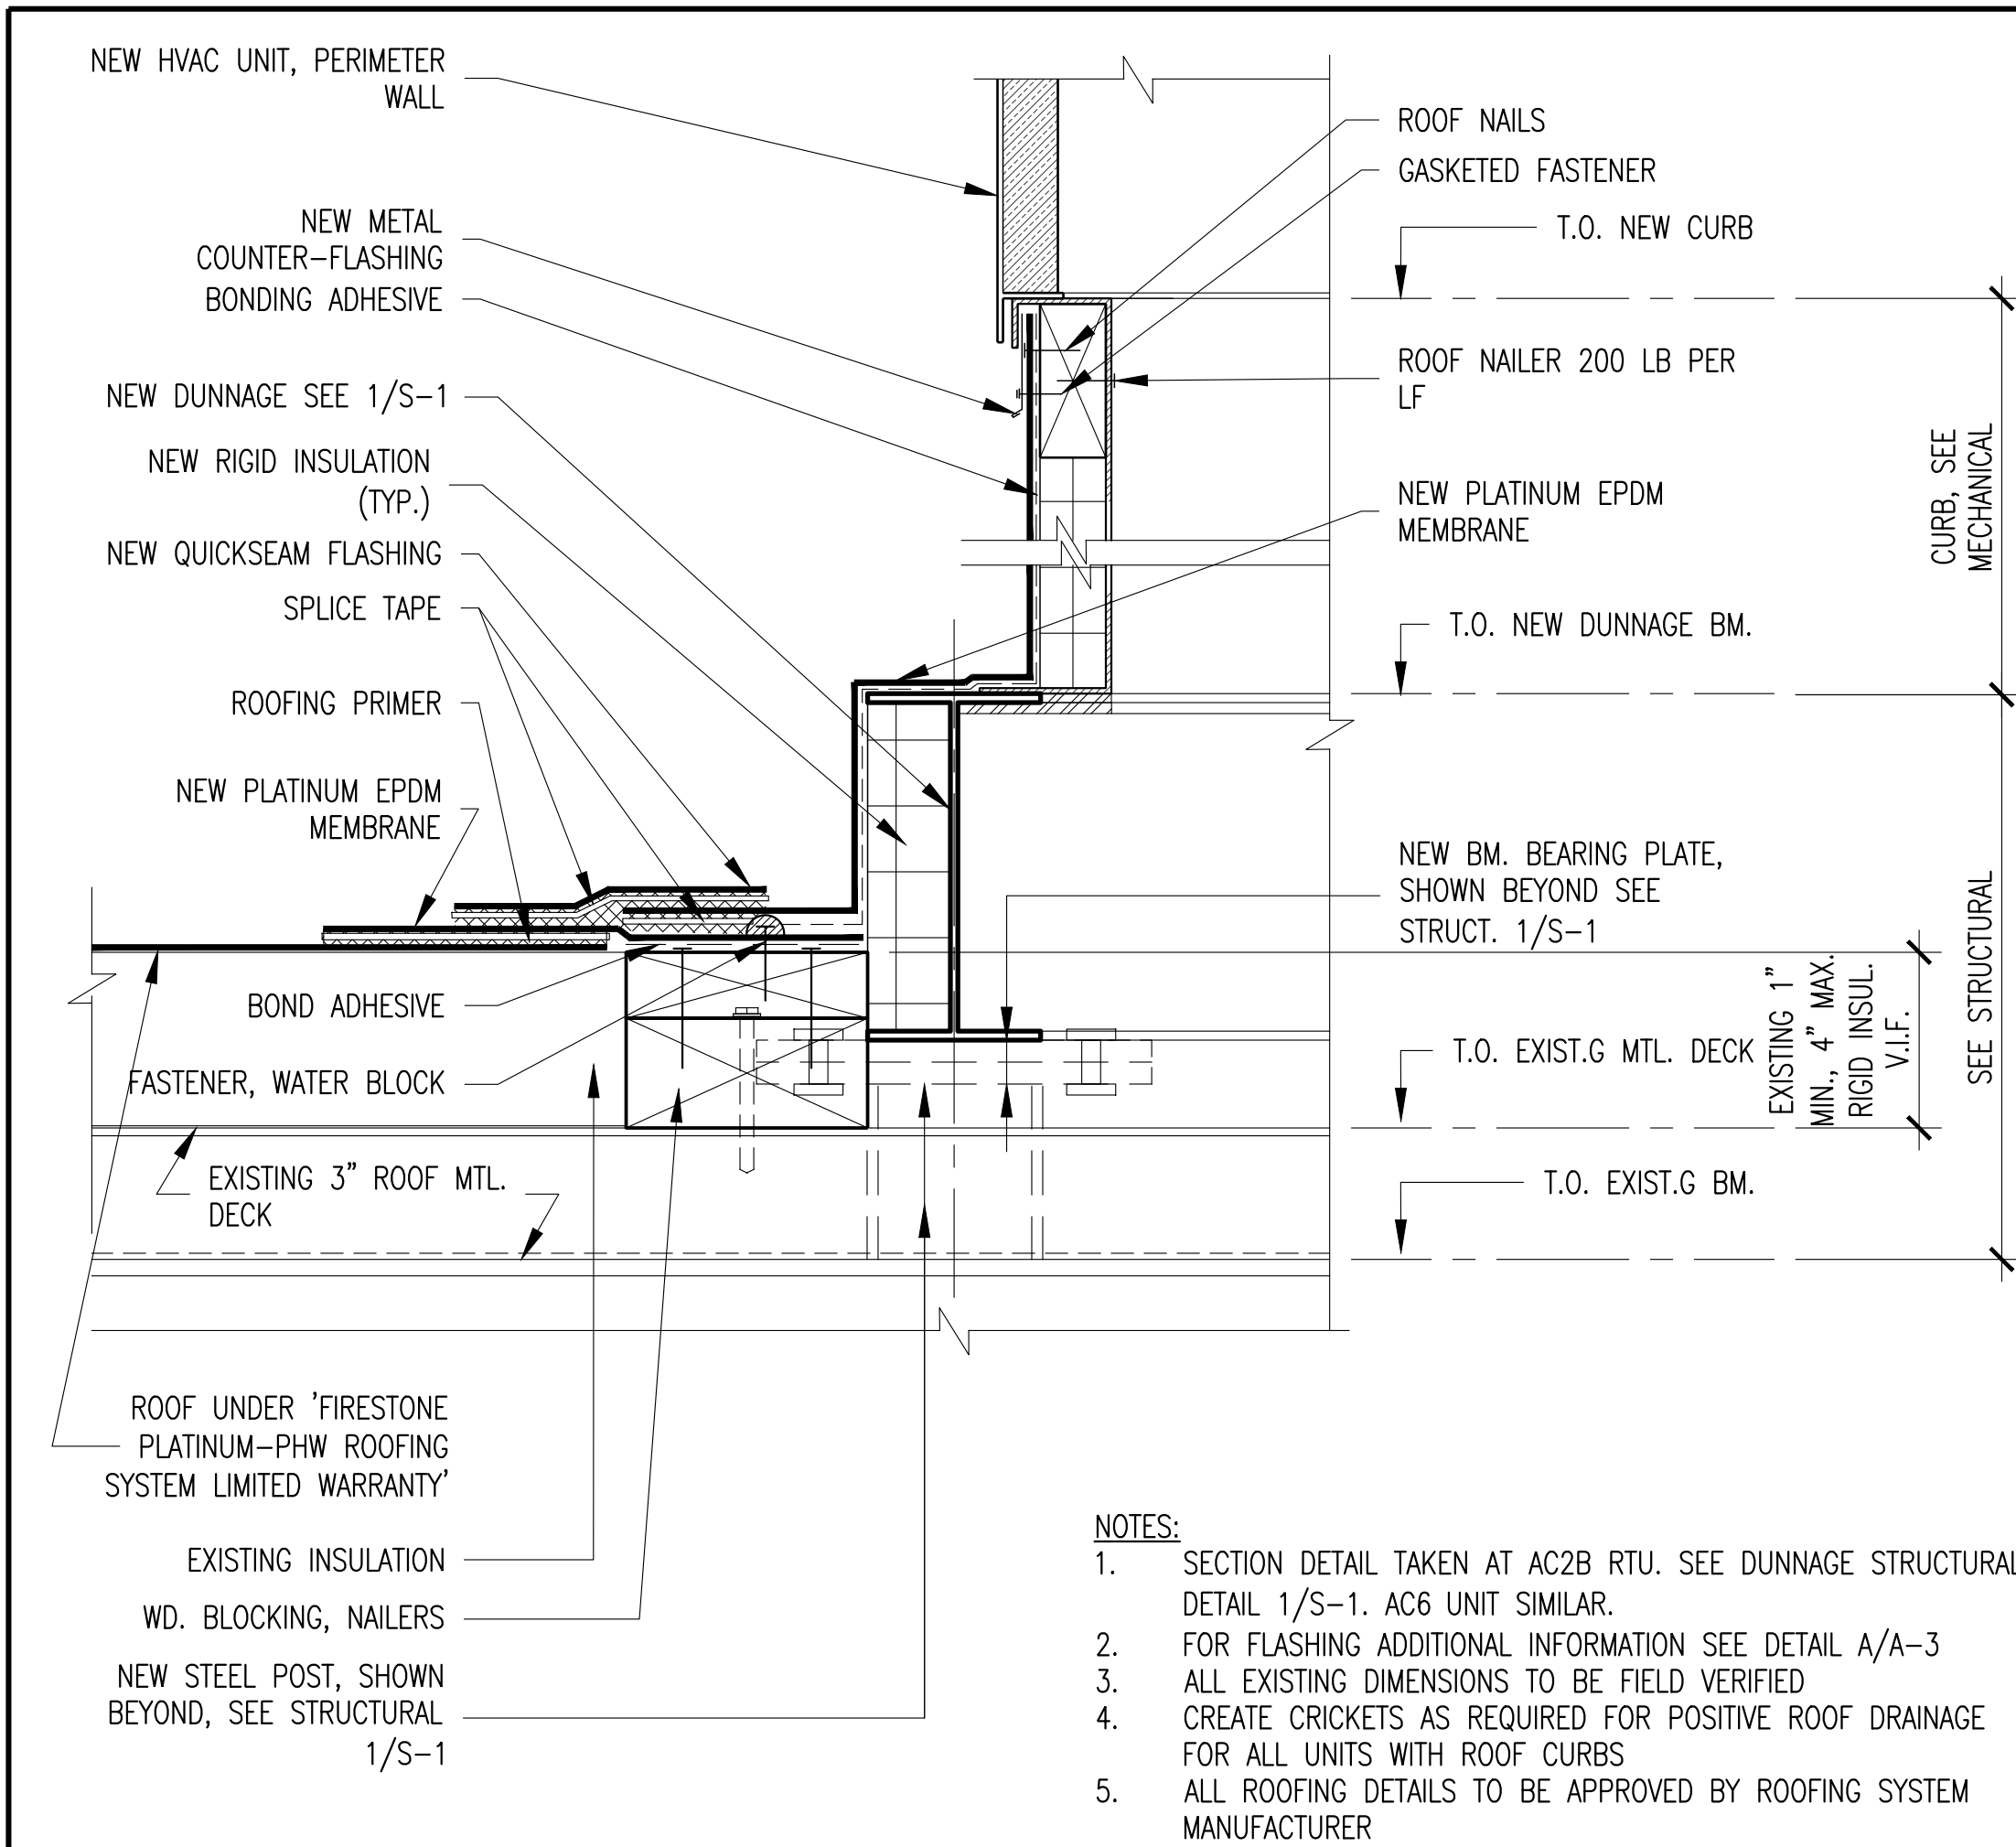

A
A-2 RTU CURB DETAIL
3"=1'-0"

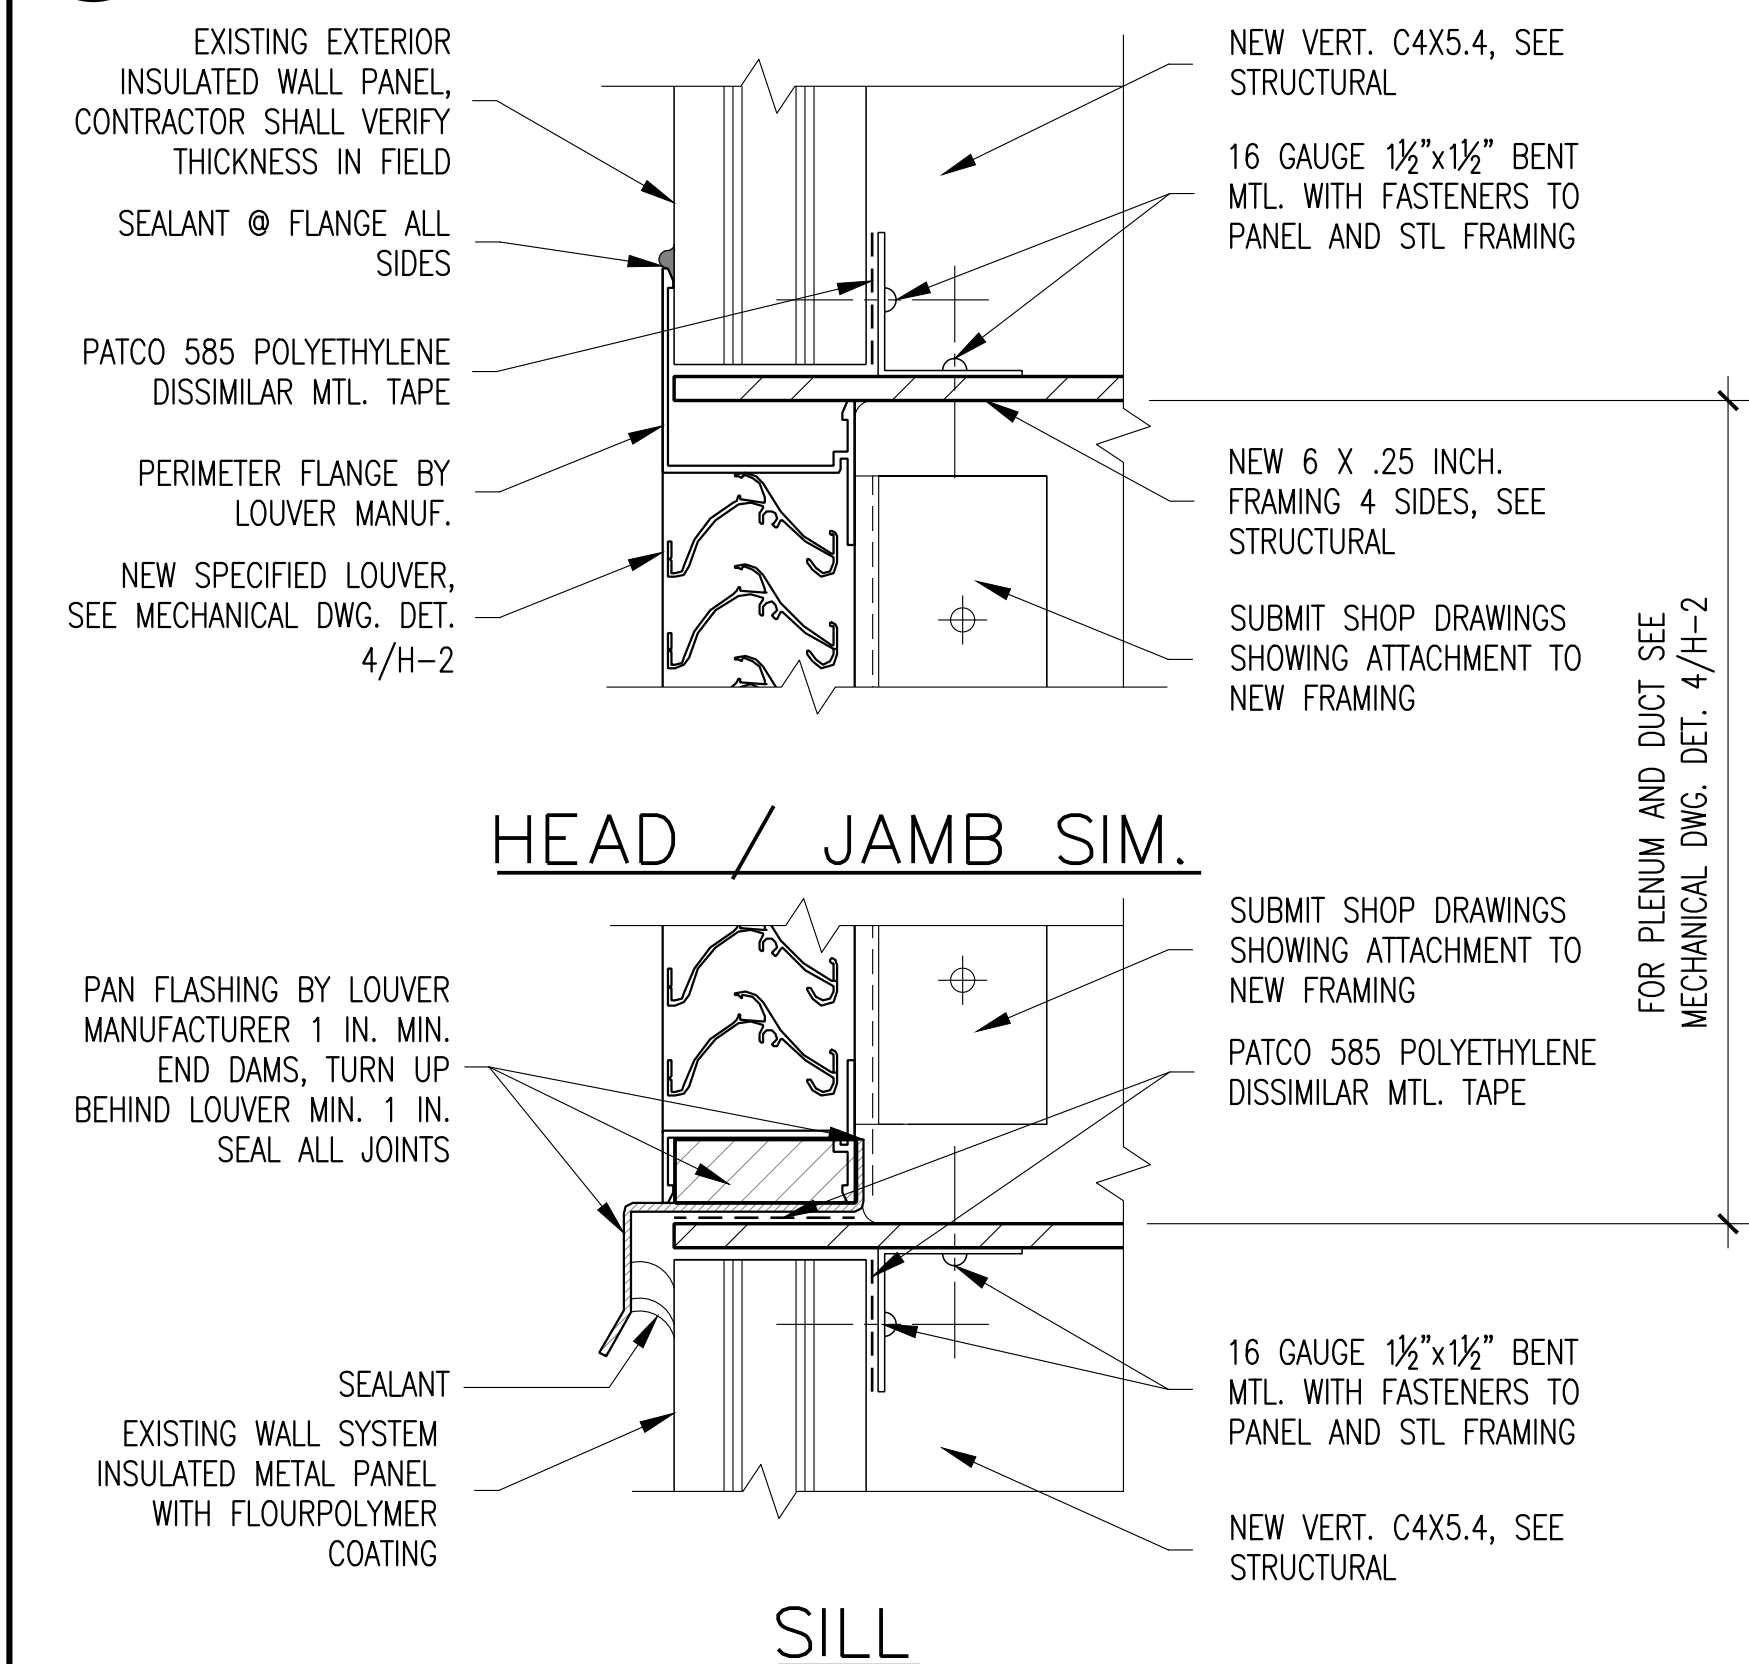


L
A-2 LOUVER DETAIL@ BOILER RM267
SCALE: 6" = 1'-0"

LEGEND


- DEMO EXISTING ACOUSTICAL CEILING TILE SYSTEM
- NEW GRID HANGING SYSTEM, 2' X 2' LAY-IN TILE AND GRID CAREFULLY LOCATED TO CENTER EXISTING SPRINKLERS IN TILE
- EXISTING SPRINKLER HEAD IN EXISTING LOCATION
- REMOVE, SALVAGE AND REINSTALL EXISTING 2' X 4' LAY-IN LIGHT FIXTURE AND HANGERS AS REQUIRED
- REMOVE, SALVAGE AND REINSTALL EXISTING SMOKE DETECTOR
- REMOVE, SALVAGE AND REINSTALL EXISTING CEILING RECESSED MOUNTED LOUDSPEAKER
- REMOVE EXISTING AIR RETURN DIFFUSER; NEW DIFFUSER; SEE MECHANICAL FOR SCOPE OF WORK AND SPECIFICATION
- REMOVE EXISTING AIR SUPPLY DIFFUSER; NEW DIFFUSER; SEE MECHANICAL FOR SCOPE OF WORK AND SPECIFICATION

2
A-2 1ST FLR. ROOF/
2ND FLR. KEY PLAN
SCALE: 1/64" = 1'-0"

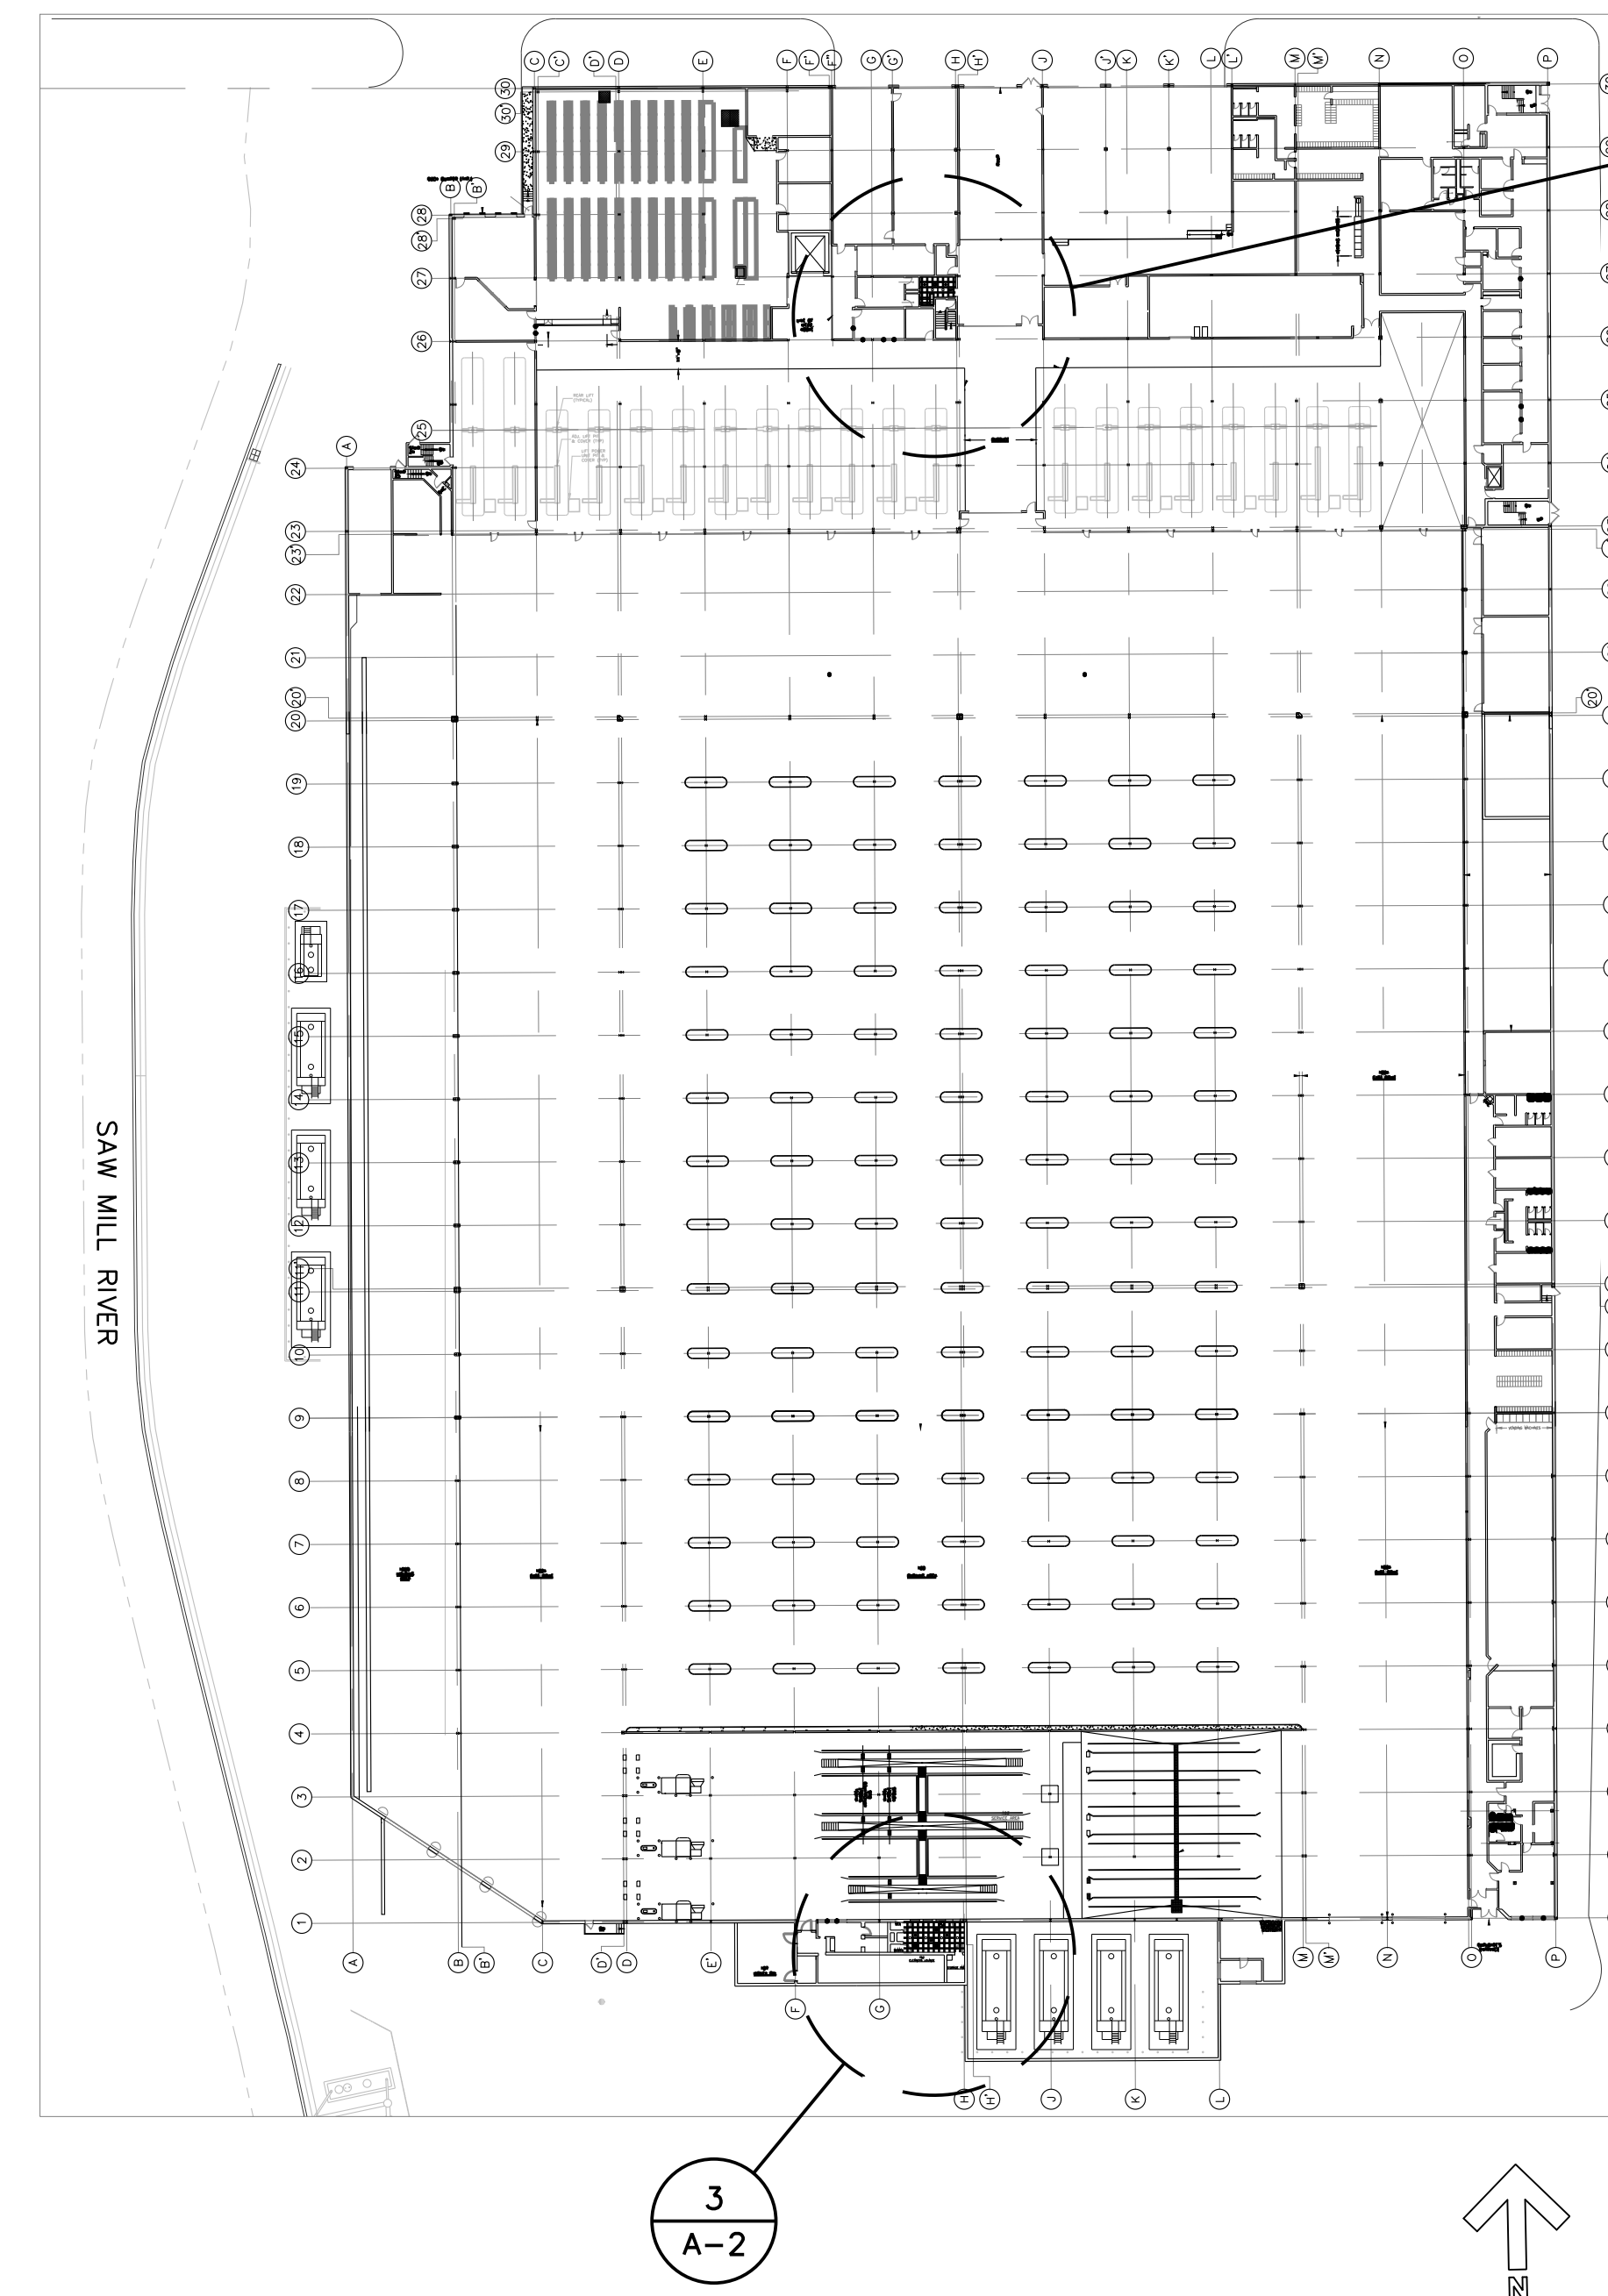


1
A-2 1ST FLR KEY PLAN
SCALE: 1/64" = 1'-0"


ADDENDUM # 3

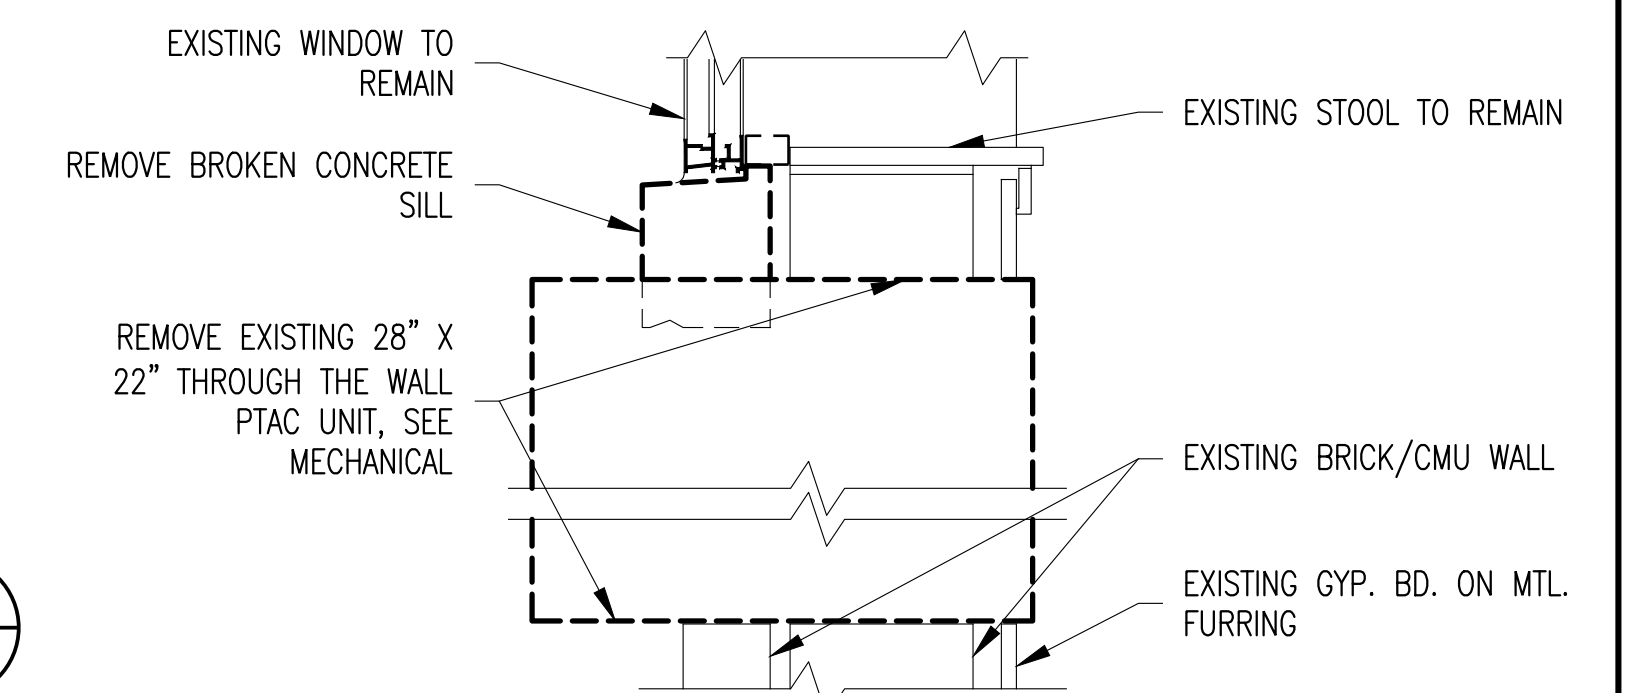


B
A-2 A/C REMOVAL DETAIL
SCALE: 1-1/2" = 1'-0"

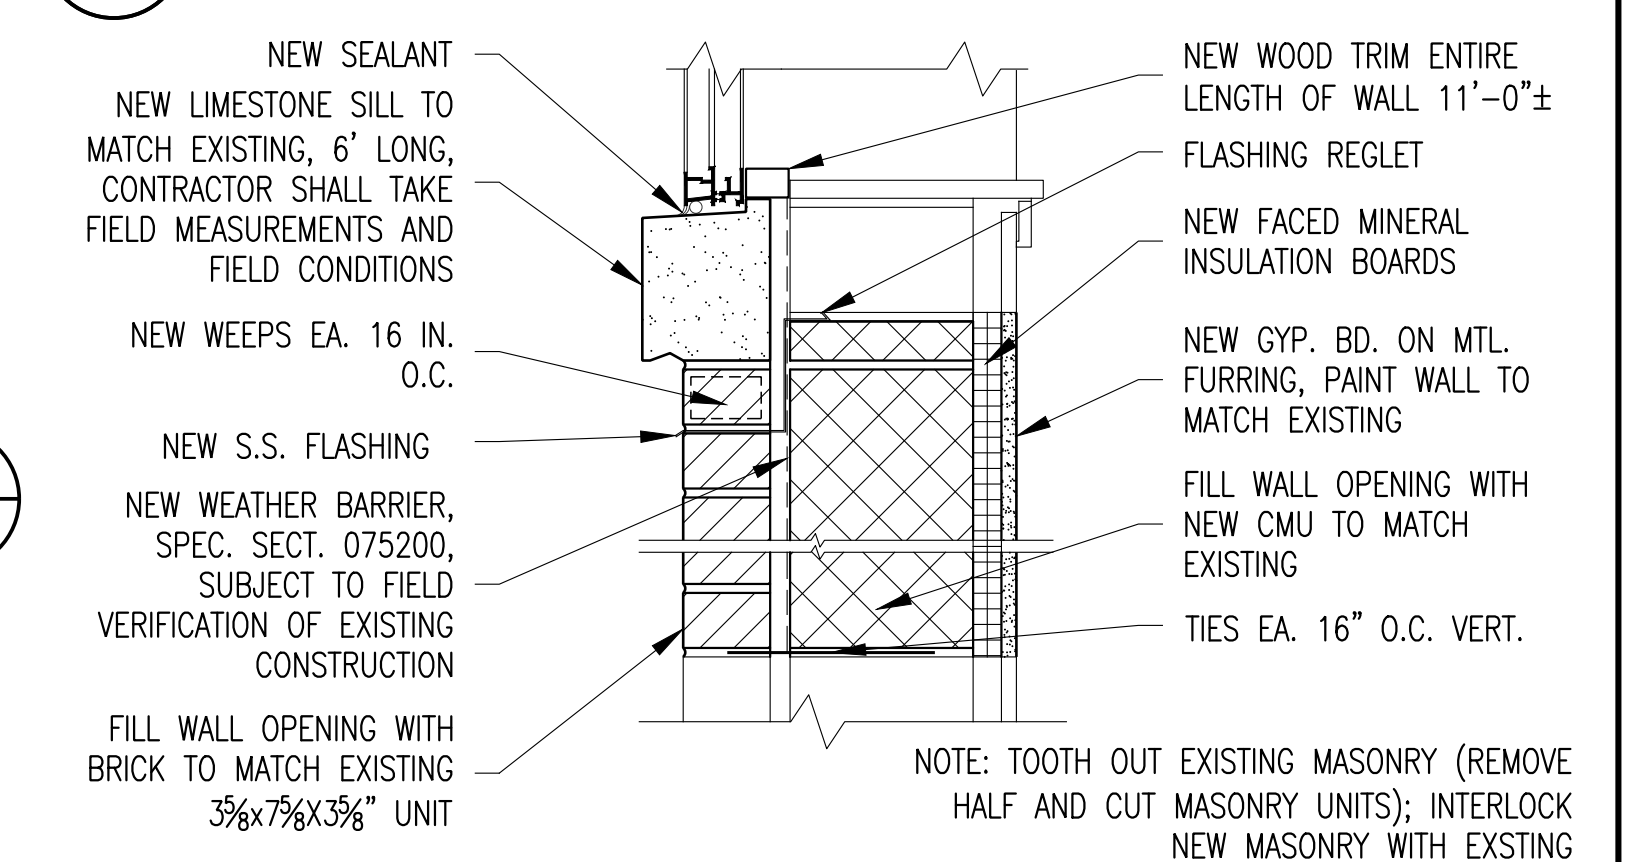

C
A-2 WALL CLOSURE DETAIL
SCALE: 1-1/2" = 1'-0"

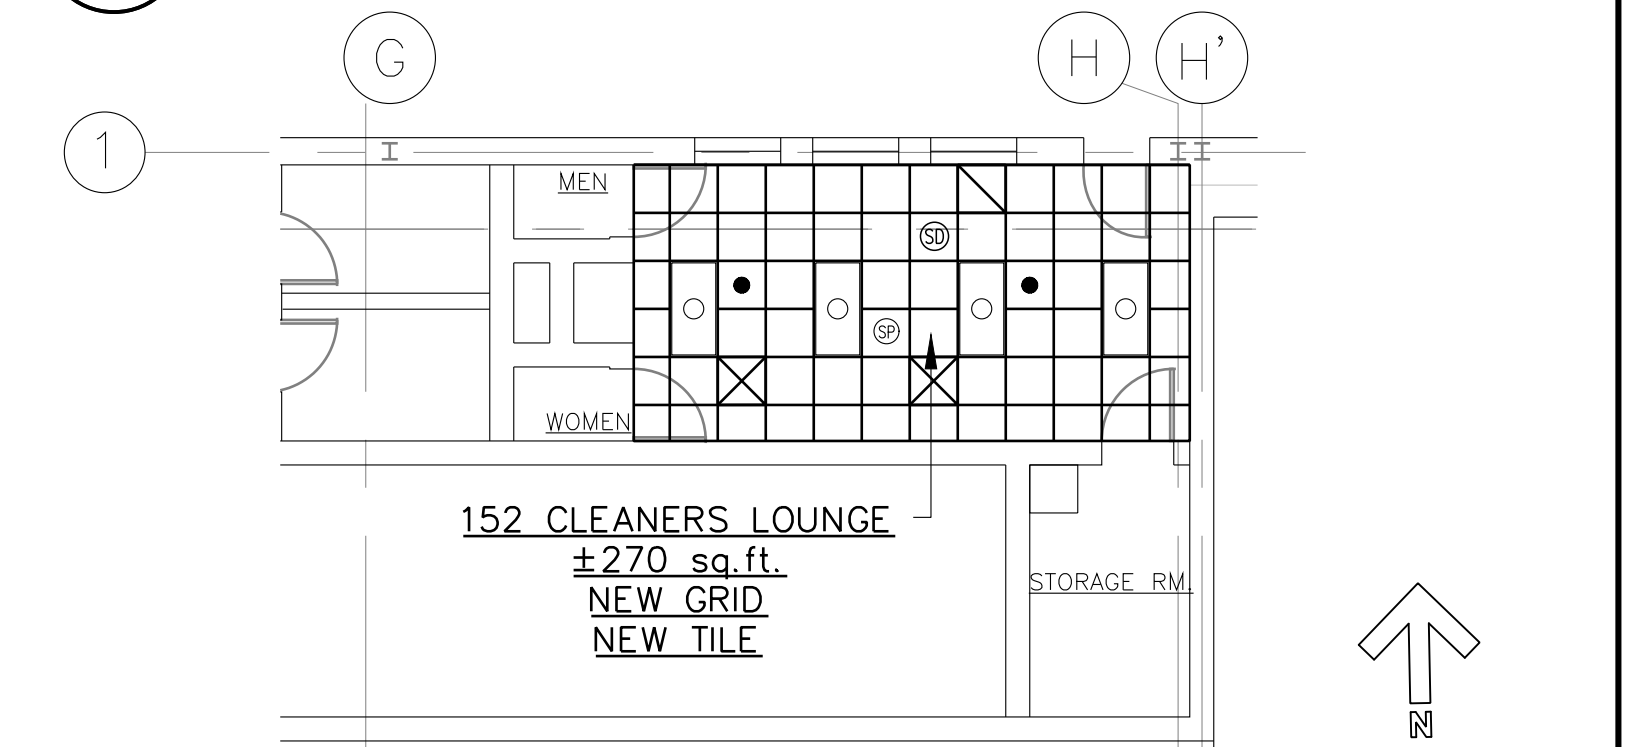

3
A-2 1ST FLR. PART REFL. CLNG. PLAN
SCALE: 1/8" = 1'-0"

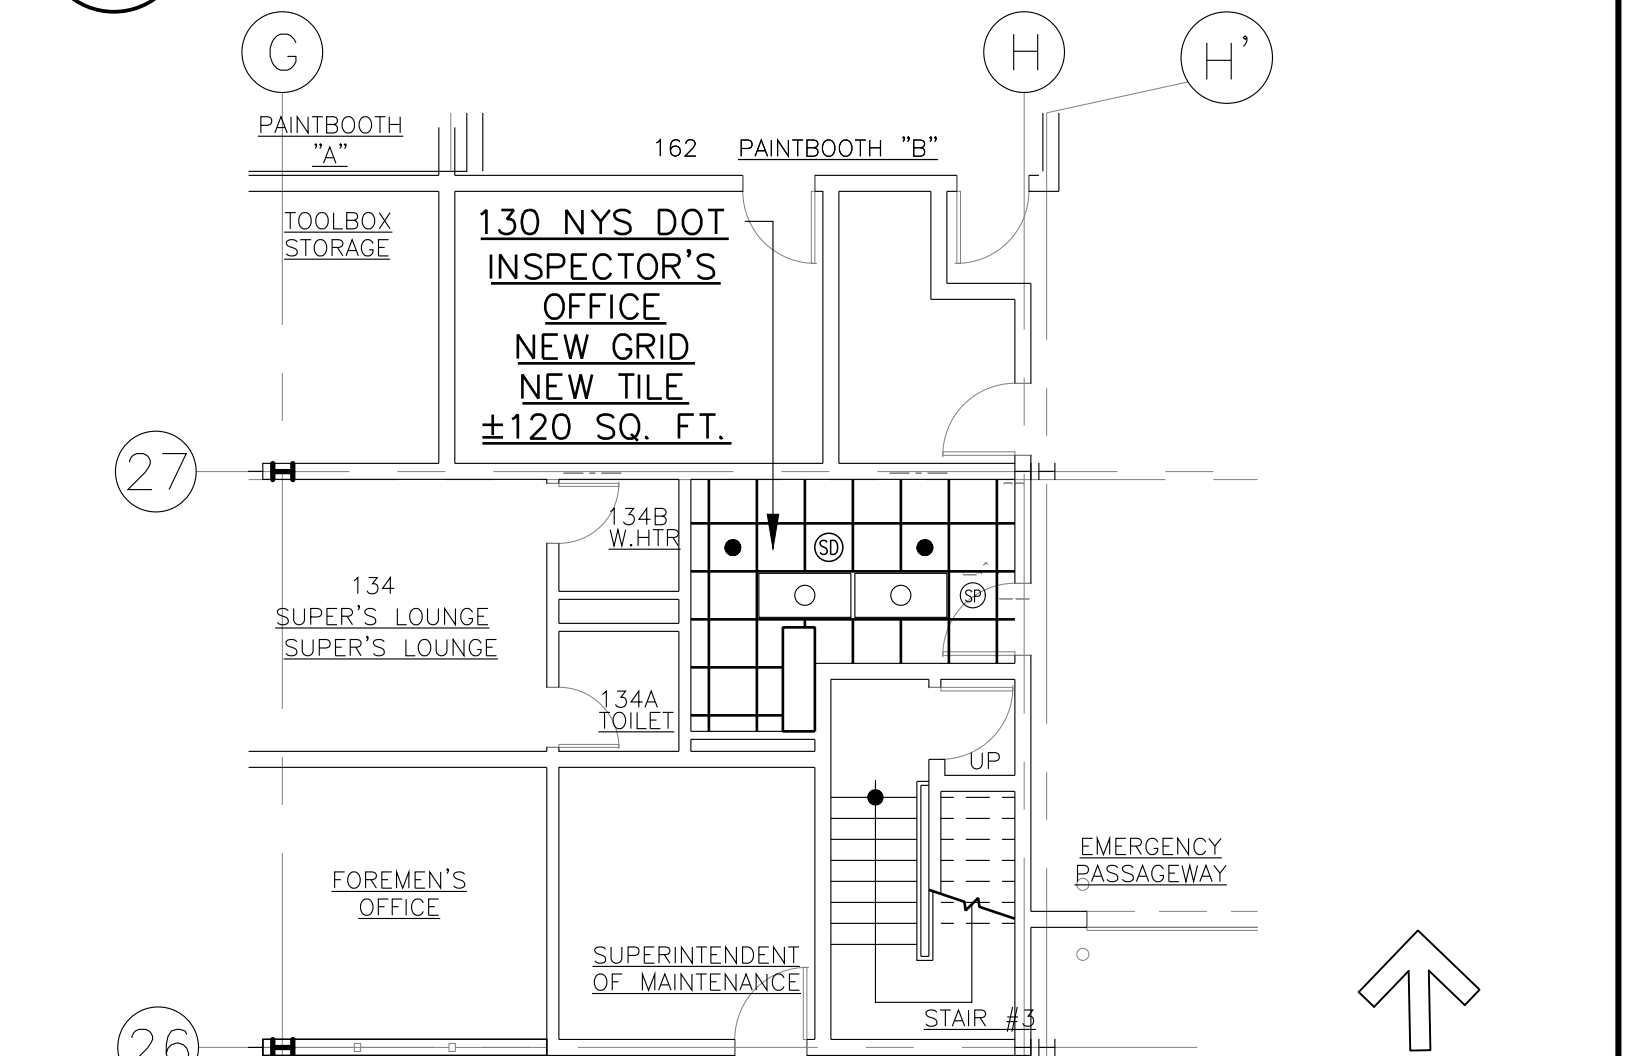

4
A-2 1ST FLR. PART REFL. CLNG. PLAN
SCALE: 1/8" = 1'-0"

IN CHARGE OF JAI PUNNOOSE, P.E.
CHECKED BY ADAM KAPLINSKI, R.A.
MADE BY ALEXIS GARCIA

	12/4/23	AG	AK	ADDENDUM # 3
REVISION NUMBER	DATE	MADE BY	APP'D BY	REVISION

RECORD DRAWING CERTIFICATION			
☐ AS BUILT - CHANGES AS NOTED			
☐ AS BUILT - NO CHANGES			
CONTRACTOR		PROJECT COORDINATOR	
NAME		NAME	
SIGNATURE		SIGNATURE	
TITLE		TITLE	

WESTCHESTER COUNTY, NEW YORK		CONTRACT NUMBER	SHEET NUMBER
DEPARTMENT OF PUBLIC WORKS AND TRANSPORTATION		22-524	A-2
DIVISION OF ENGINEERING		SHEET NO. 3 OF 21	
REPLACEMENT OF HVAC SYSTEMS AND ASSOCIATED WORK		SCALE: AS NOTED	REV. NO.
BEE-LINE CENTRAL MAINTENANCE FACILITY (DOT-CMF)		12/1/2023	
475 SAW MILL RIVER ROAD, YONKERS, NEW YORK		DPW FILE NO.	
PART REFLECTED CEILING PLANS AND DETAILS		61-10-A-407	