


F:\DE-FILES\PUBLIC\DRAWINGS\RHINEBECK (V)\22-2486 WTP-C-400 - WILLET HILL ESTATES PUMP STATION.dwg Saved: 2/21/2024 4:30:53 PM Plotted: 10/2/2024 10:15:31 AM User: Hls Broderick LastSavedBy: mofitasa

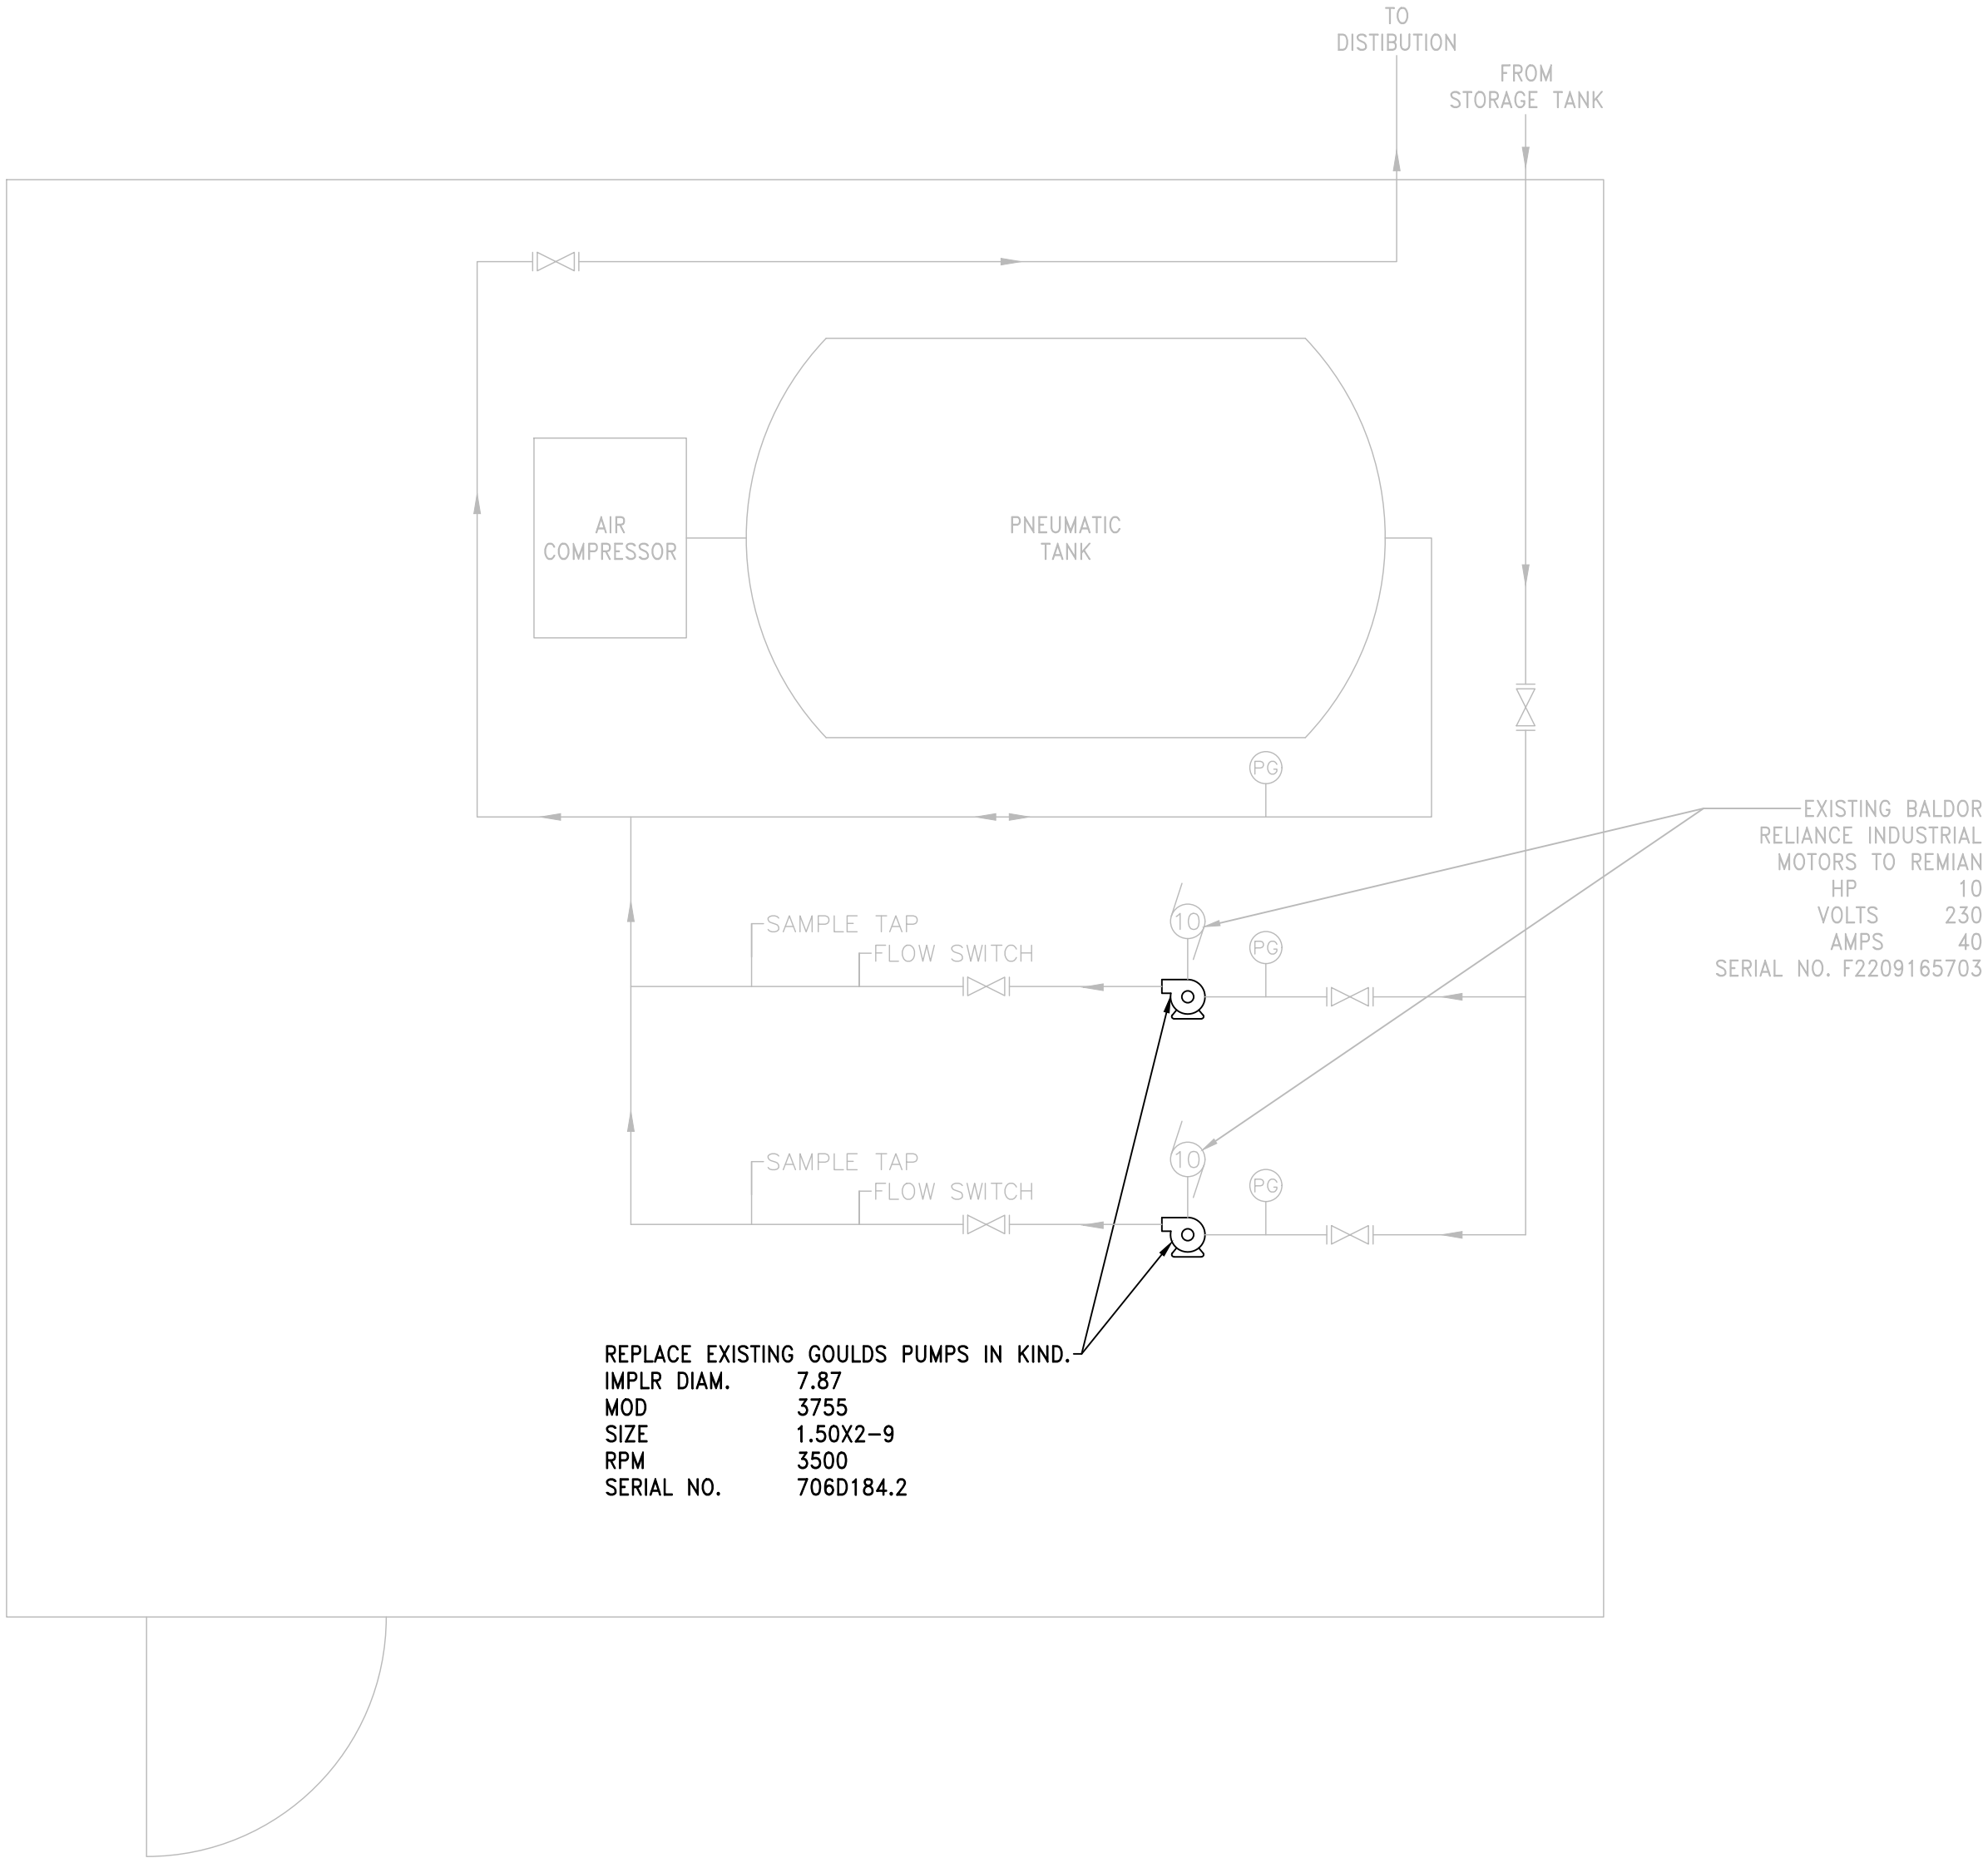

VIOLET HILL PUMP STATION FLOOR PLAN SCHEMATIC
NOT TO SCALE



SITE PLAN
SCALE: 1" = 30'

WARNING - IT IS A VIOLATION OF NEW YORK EDUCATION LAW SECTION 7209.2, FOR ANY PERSON, UNLESS HE IS ACTING UNDER THE DIRECTION OF A LICENSED PROFESSIONAL ENGINEER OR LAND SURVEYOR, TO ALTER THIS DOCUMENT IN ANY WAY. IF ALTERED THE ALTERING PERSON SHALL COMPLY WITH THE REQUIREMENTS OF NEW YORK EDUCATION LAW SECTION 7209.2.

SHEET:


C-400

RHINEBECK WTP
PLANT IMPROVEMENTS
VILLAGE OF RHINEBECK
DUTCHESS COUNTY, NEW YORK

WILLET HILL ESTATES
PUMP STATION

REVISIONS

NO.	DATE	DESCRIPTION

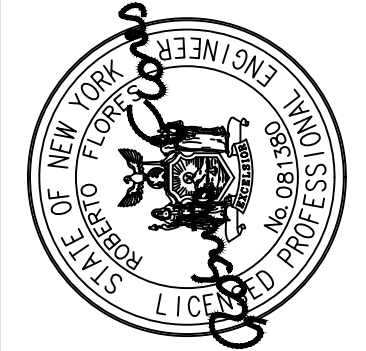

**DELAWARE
ENGINEERING, D.P.C.**
CIVIL AND ENVIRONMENTAL ENGINEERING
28 MADISON AVENUE EXTENSION, ALBANY, NY 12203 - 518.452.1290
55 SOUTH MAIN ST. ONEONTA, NY 13820 - 607.432.8073
31 NORTH MAIN STREET, LIBERTY, NY 12754 - 845.747.9862
100 WEST MAIN STREET, CATSKILL, NY 12414 - 518.452.1290
16 EAST MARKET STREET, RED HOOK, NY 12571 - 518.452.1290
548 BROADWAY, MONTECELLO, NY 12001 - 845.791.7777

DATE: 2/21/2024
DRAWN BY: KMM
SCALE: 1:40
REVIEWED BY: RF
PROJECT NO.: ----
FILE: