



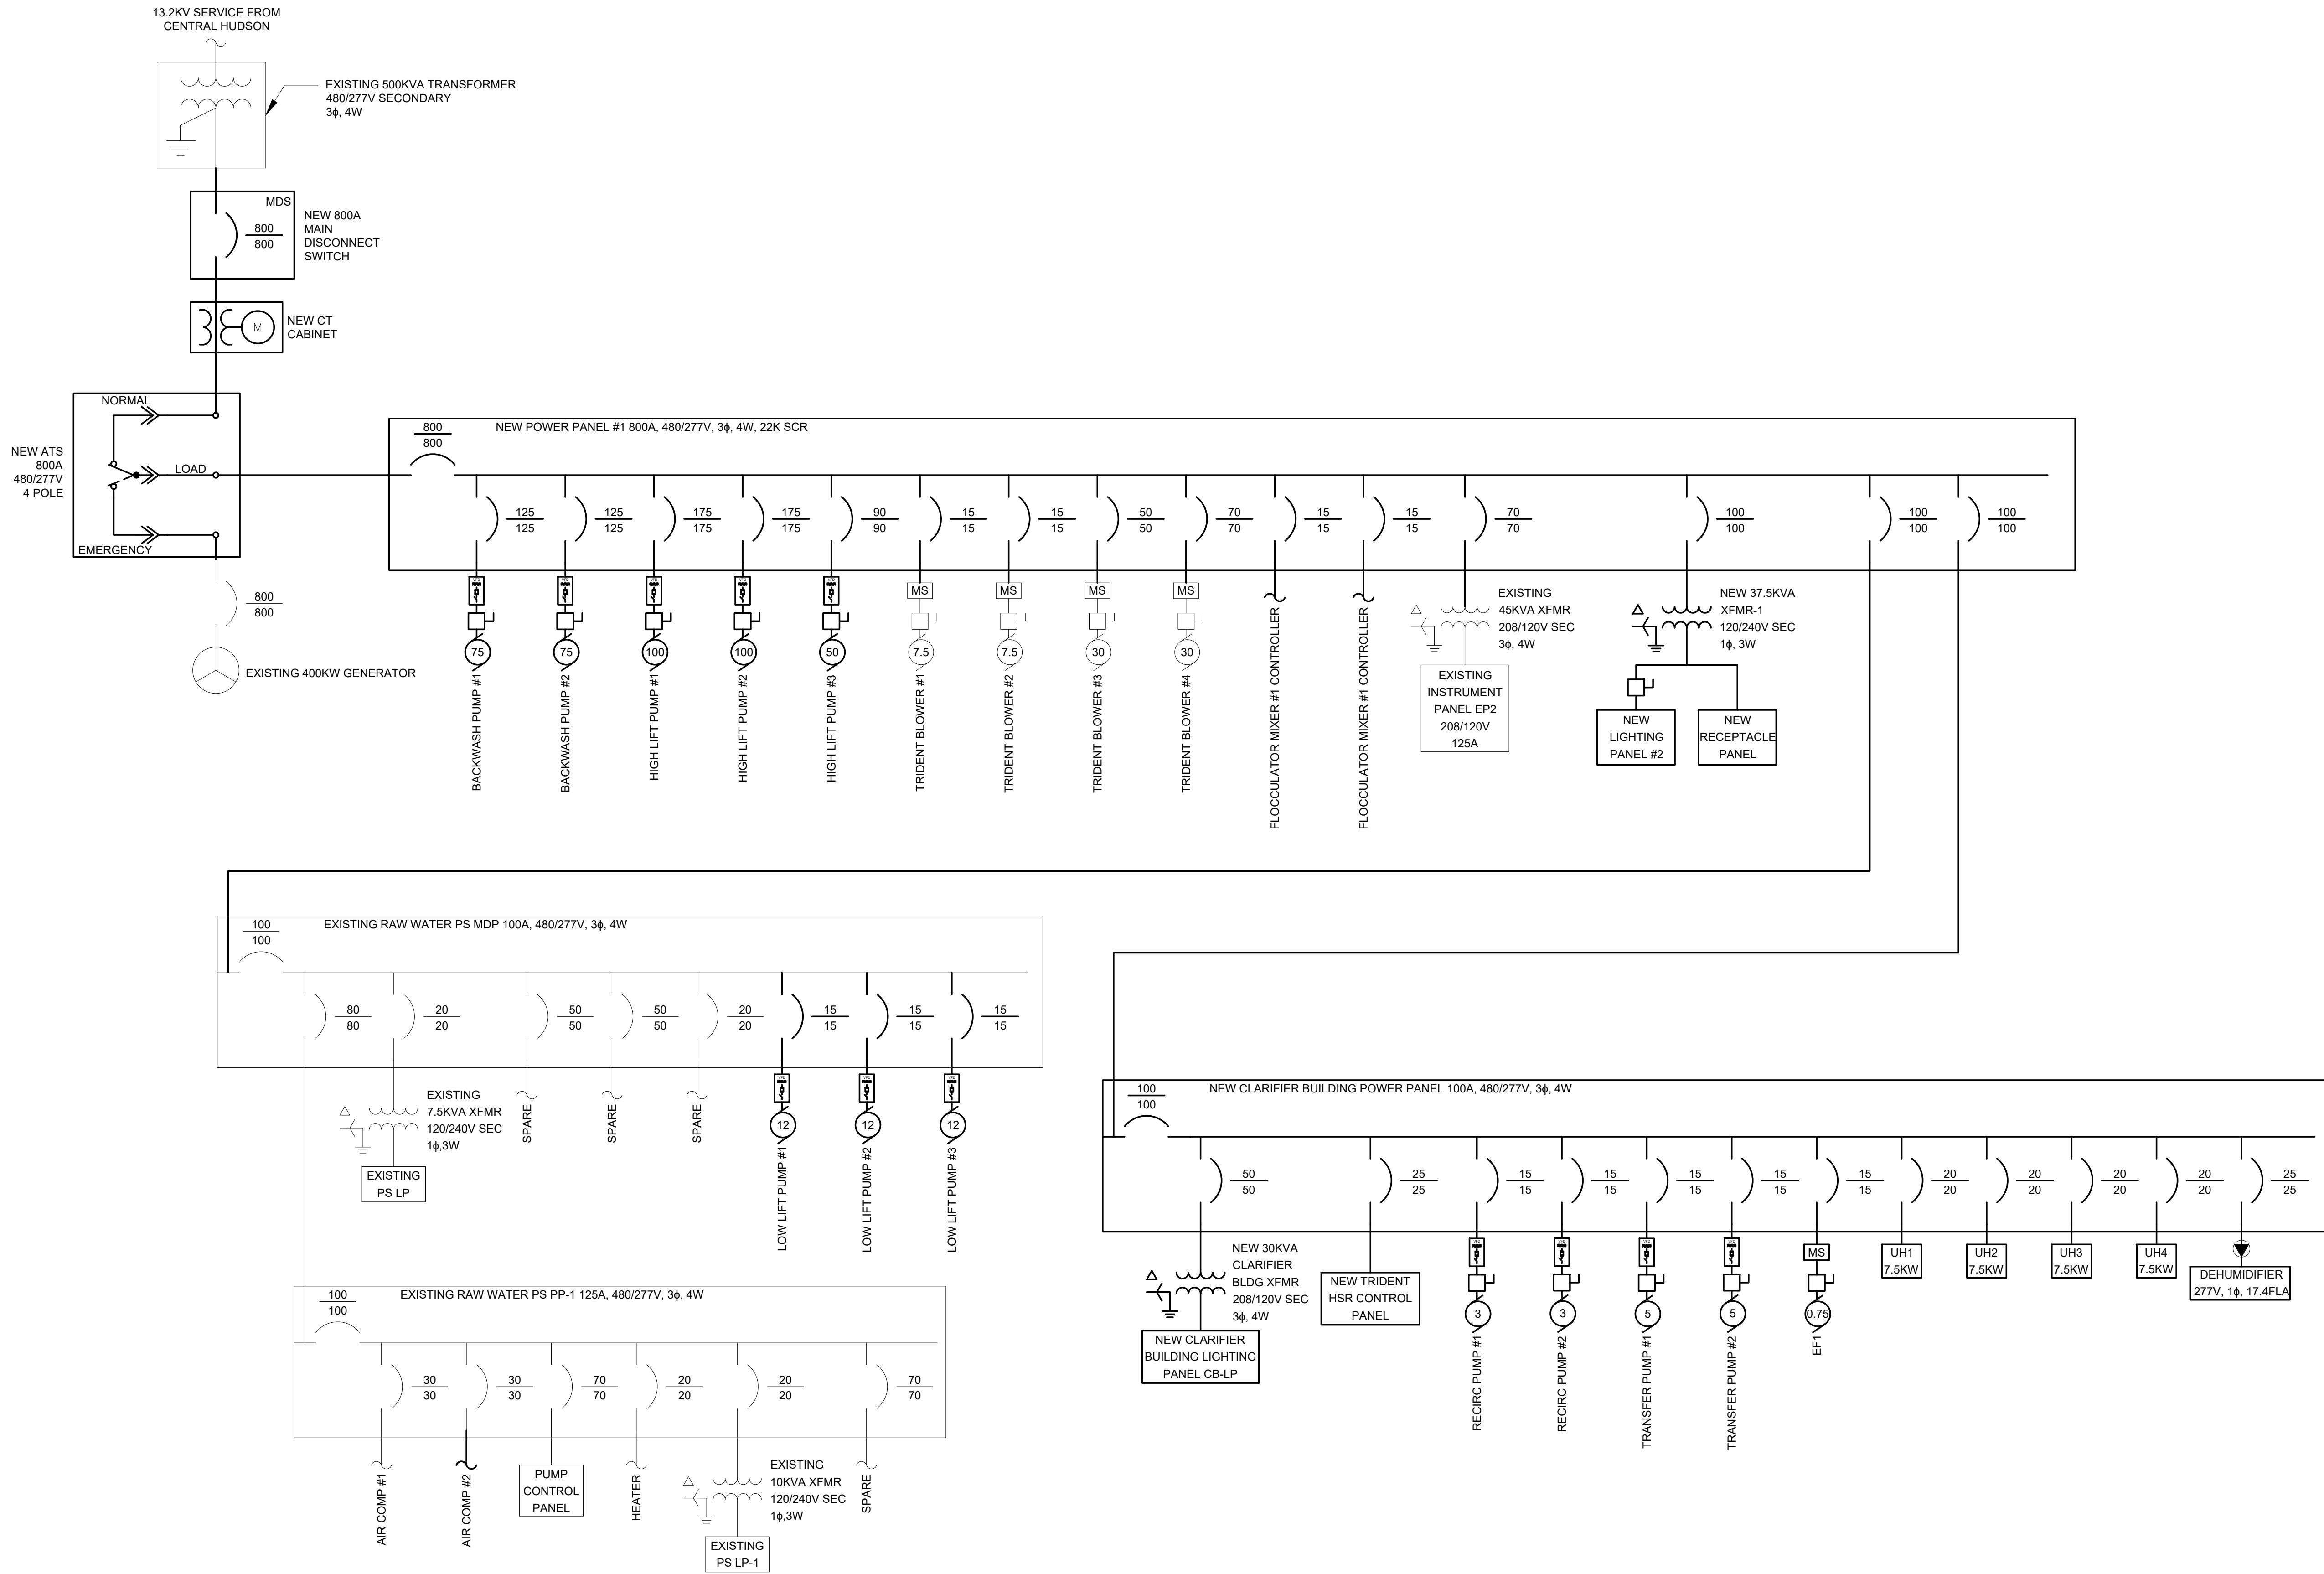

DATE: 9/30/2024
DRAWN BY: EMB
SCALE: NTS
REVIEWED BY: RF
PROJECT NO.: ----
FILE:

DELAWARE ENGINEERING, D.P.C.
CIVIL AND ENVIRONMENTAL ENGINEERING
28 MADISON AVENUE EXTENSION, ALBANY, NY 12203 - 518-452-1290
55 SOUTH MAIN ST. ONEONTA, NY 13820 - 607-432-8073
31 NORTH MAIN STREET, LIBERTY, NY 12544 - 518-747-0962
100 WEST MAIN STREET, CANTON, NY 12015 - 518-253-0000
16 EAST MARKET ST. RED HOOK, NY 12571 - 518-452-1290
548 BROADWAY, MONTICELLO, NY 12051 - 845-791-7777

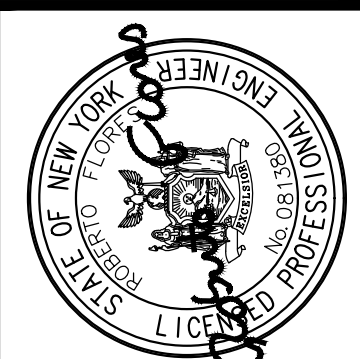

REVISIONS		DESCRIPTION
NO.	DATE	

RHINEBECK WTP
PLANT IMPROVEMENTS
VILLAGE OF RHINEBECK
DUTCHESS COUNTY, NEW YORK

ONE LINE DIAGRAM

SHEET:
E-003

WARNING - IT IS A VIOLATION OF NEW YORK EDUCATION LAW SECTION 7209.2, FOR ANY PERSON, UNLESS HE IS ACTING UNDER THE DIRECTION OF A LICENSED PROFESSIONAL ENGINEER OR LAND SURVEYOR, TO ALTER THIS DOCUMENT IN ANY WAY. IF ALTERED THE ALTERING PERSON SHALL COMPLY WITH THE REQUIREMENTS OF NEW YORK EDUCATION LAW, SECTION 7209.2.