


LEGEND:

FAIL-SAFE LED LIGHT
65W, 4', 7324 LUMEN FIXTURE
COOPER MODEL: #HVSL4-4-LD4-2STD-40-UNV- O-EDD

LUMARK CROSSTOUR WALL PACK LED LIGHT
12W, 120V, DUSK TO DAWN BUTTON PHOTOCONTROL
COOPER MODEL:
#XTOR1B-W-PC1
OR APPROVED EQUAL

EMERGENCY/EXIT FIXTURE WITH LED LIGHT
120V, POLYCARBONATE, BATTERY BACKUP,
WHITE CASE WITH RED LETTERS
OR APPROVED EQUAL

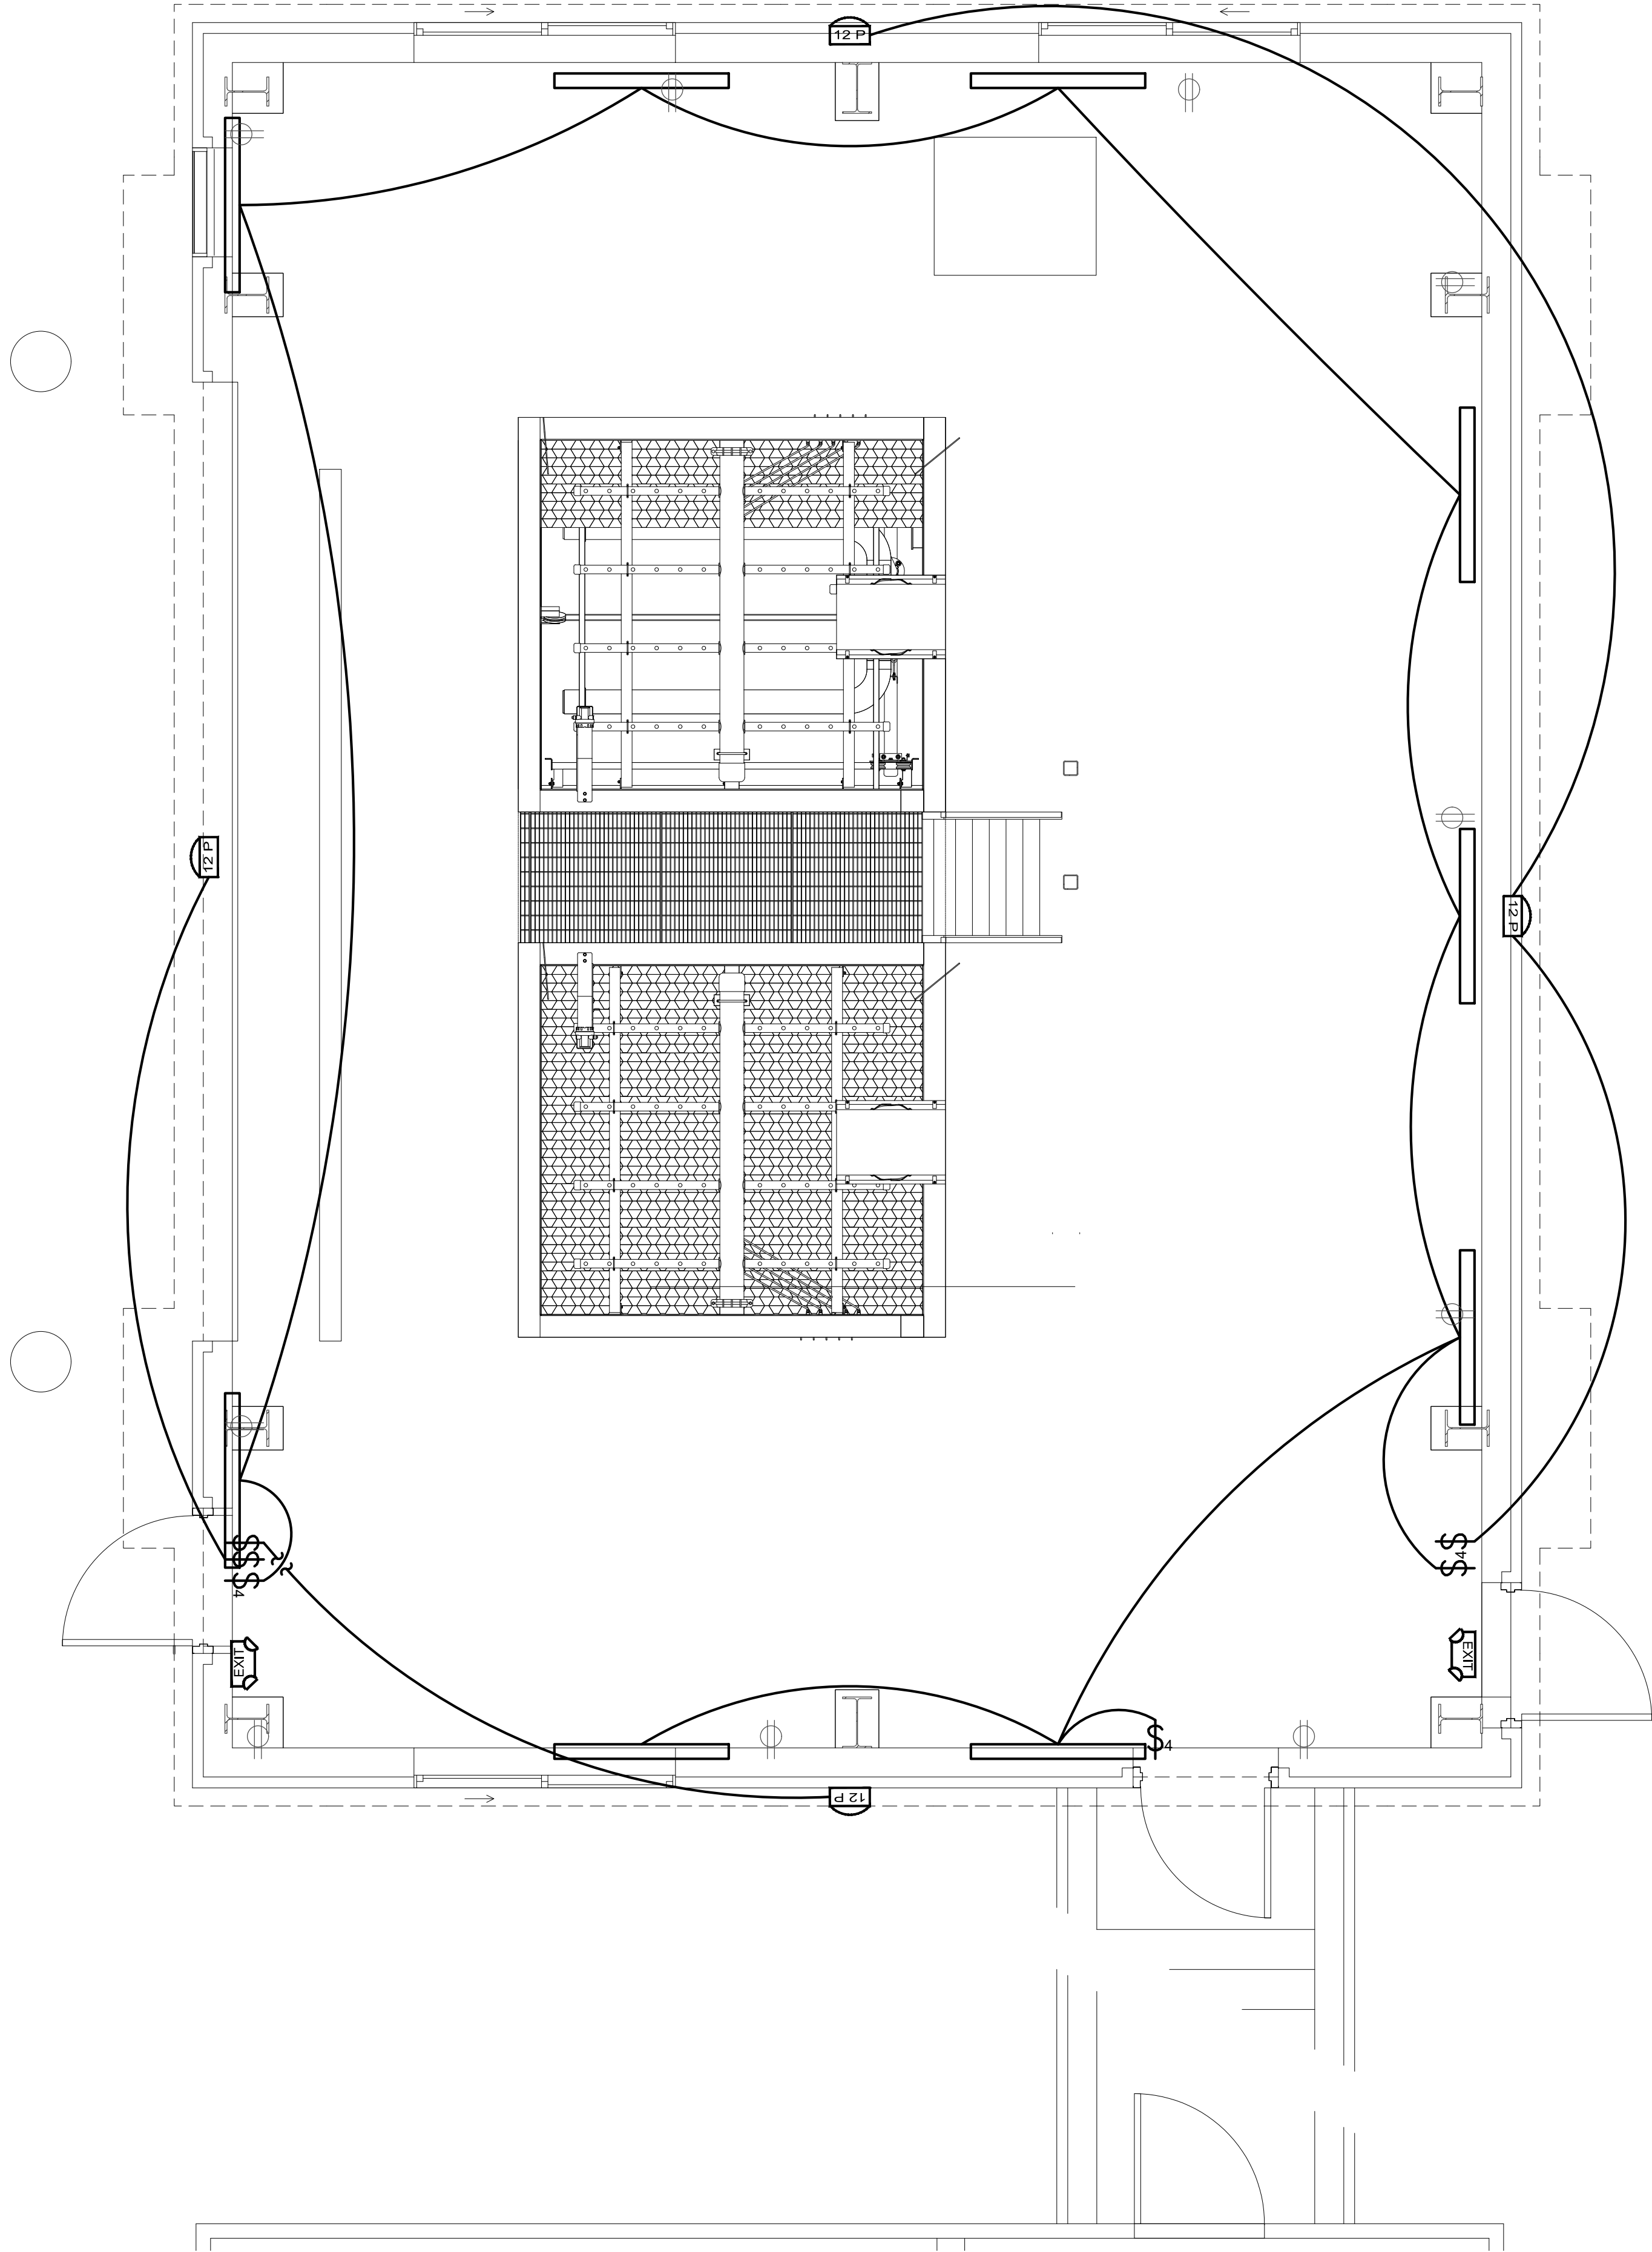

NOTES:


- INDOOR LIGHTING SHALL BE MOUNTED 12' AFF.
- WALL PACKS SHALL BE MOUNTED 14' ABOVE GRADE.

WARNING - IT IS A VIOLATION OF NEW YORK EDUCATION LAW SECTION 7209.2, FOR ANY PERSON, UNLESS HE IS ACTING UNDER THE DIRECTION OF A LICENSED PROFESSIONAL ENGINEER OR LAND SURVEYOR, TO ALTER THIS DOCUMENT IN ANY WAY. IF ALTERED THE ALTERING PERSON SHALL COMPLY WITH THE REQUIREMENTS OF NEW YORK EDUCATION LAW, SECTION 7209.2.

DATE:	9/30/2024
DRAWN BY:	EMB
SCALE:	AS SHOWN
REVIEWED BY:	RF
PROJECT NO.:	-----
FILE:	

**DELAWARE
ENGINEERING, D.P.C.**
CIVIL AND ENVIRONMENTAL ENGINEERING

28 MADISON AVENUE EXTENSION, ALBANY, NY 12203 - 518.452.1290
55 SOUTH MAIN ST. ONEONTA, NY 13820 - 607.432.8073
31 NORTH MAIN STREET, LIBERTY, NY 12544 - 845.747.9862
111 WEST MAIN STREET, CANTON, NY 12015 - 518.452.1290
16 EAST MARKET ST. RED HOOK, NY 12571 - 518.452.1290
548 BROADWAY, MONTICELLO, NY 12051 - 845.791.7777

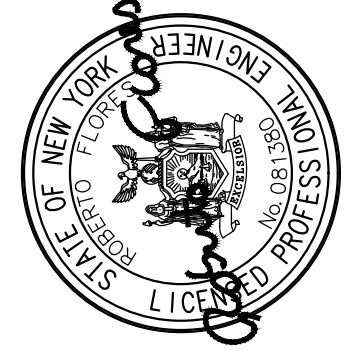

REVISIONS		DESCRIPTION
NO.	DATE	

RHINEBECK WTP
PLANT IMPROVEMENTS
VILLAGE OF RHINEBECK
DUTCHESS COUNTY, NEW YORK

NEW CLARIFIER BUILDING
LIGHTING PLAN

SHEET:
E-106