



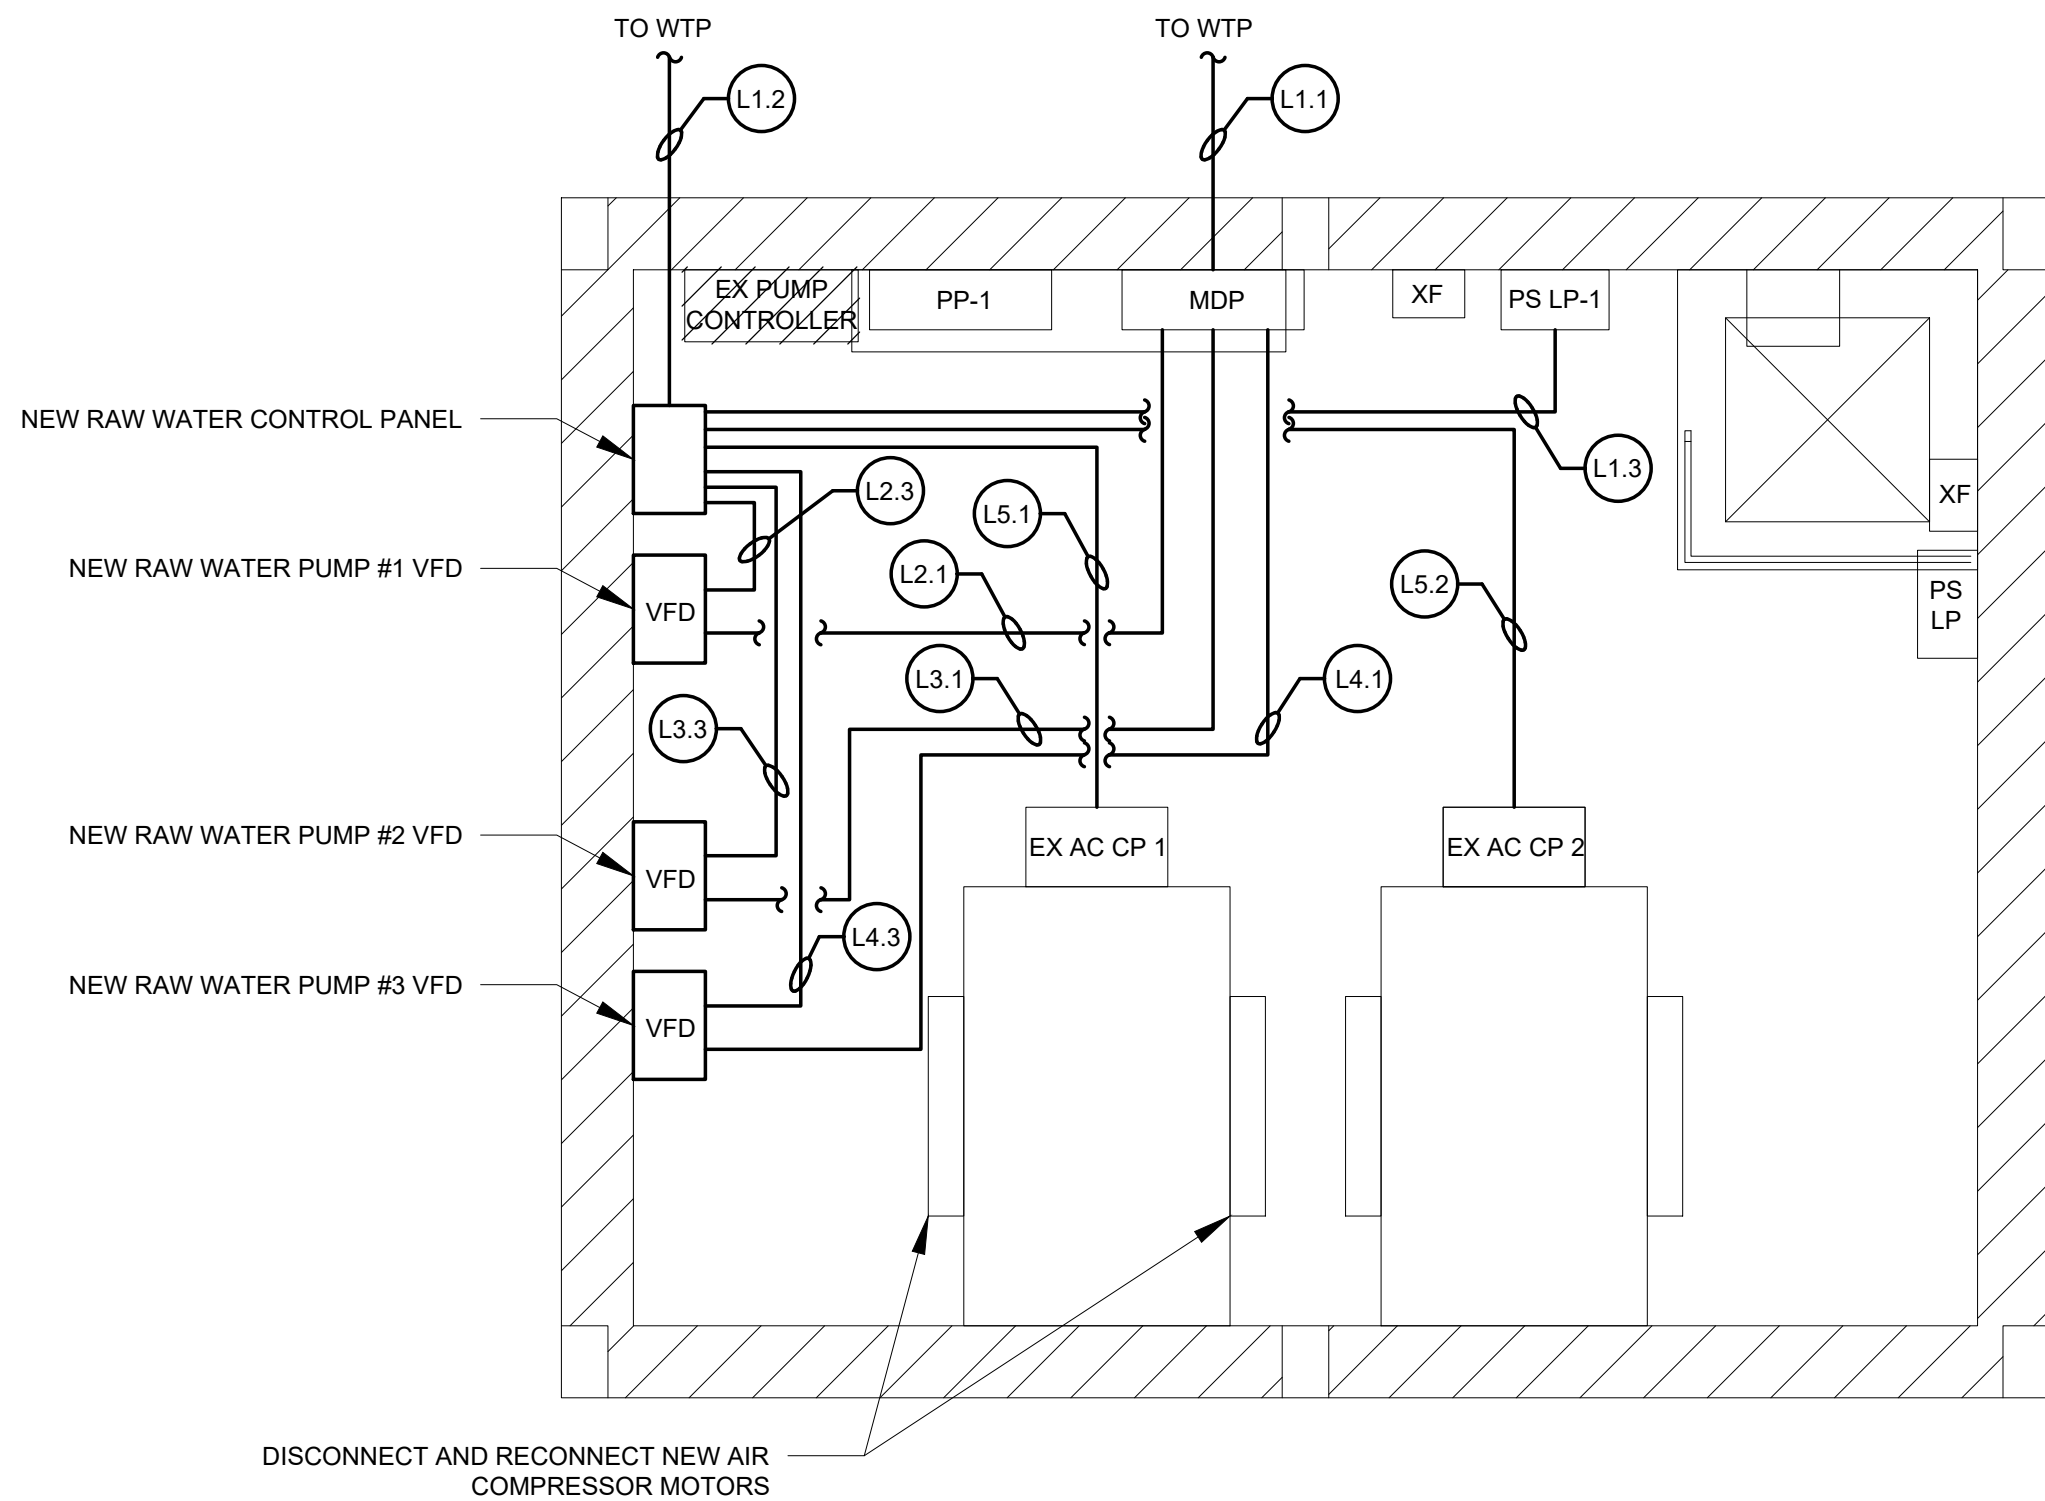


RAW WATER PUMP STATION UPPER
LEVEL ELECTRICAL PLAN
SCALE: 3/8" = 1'

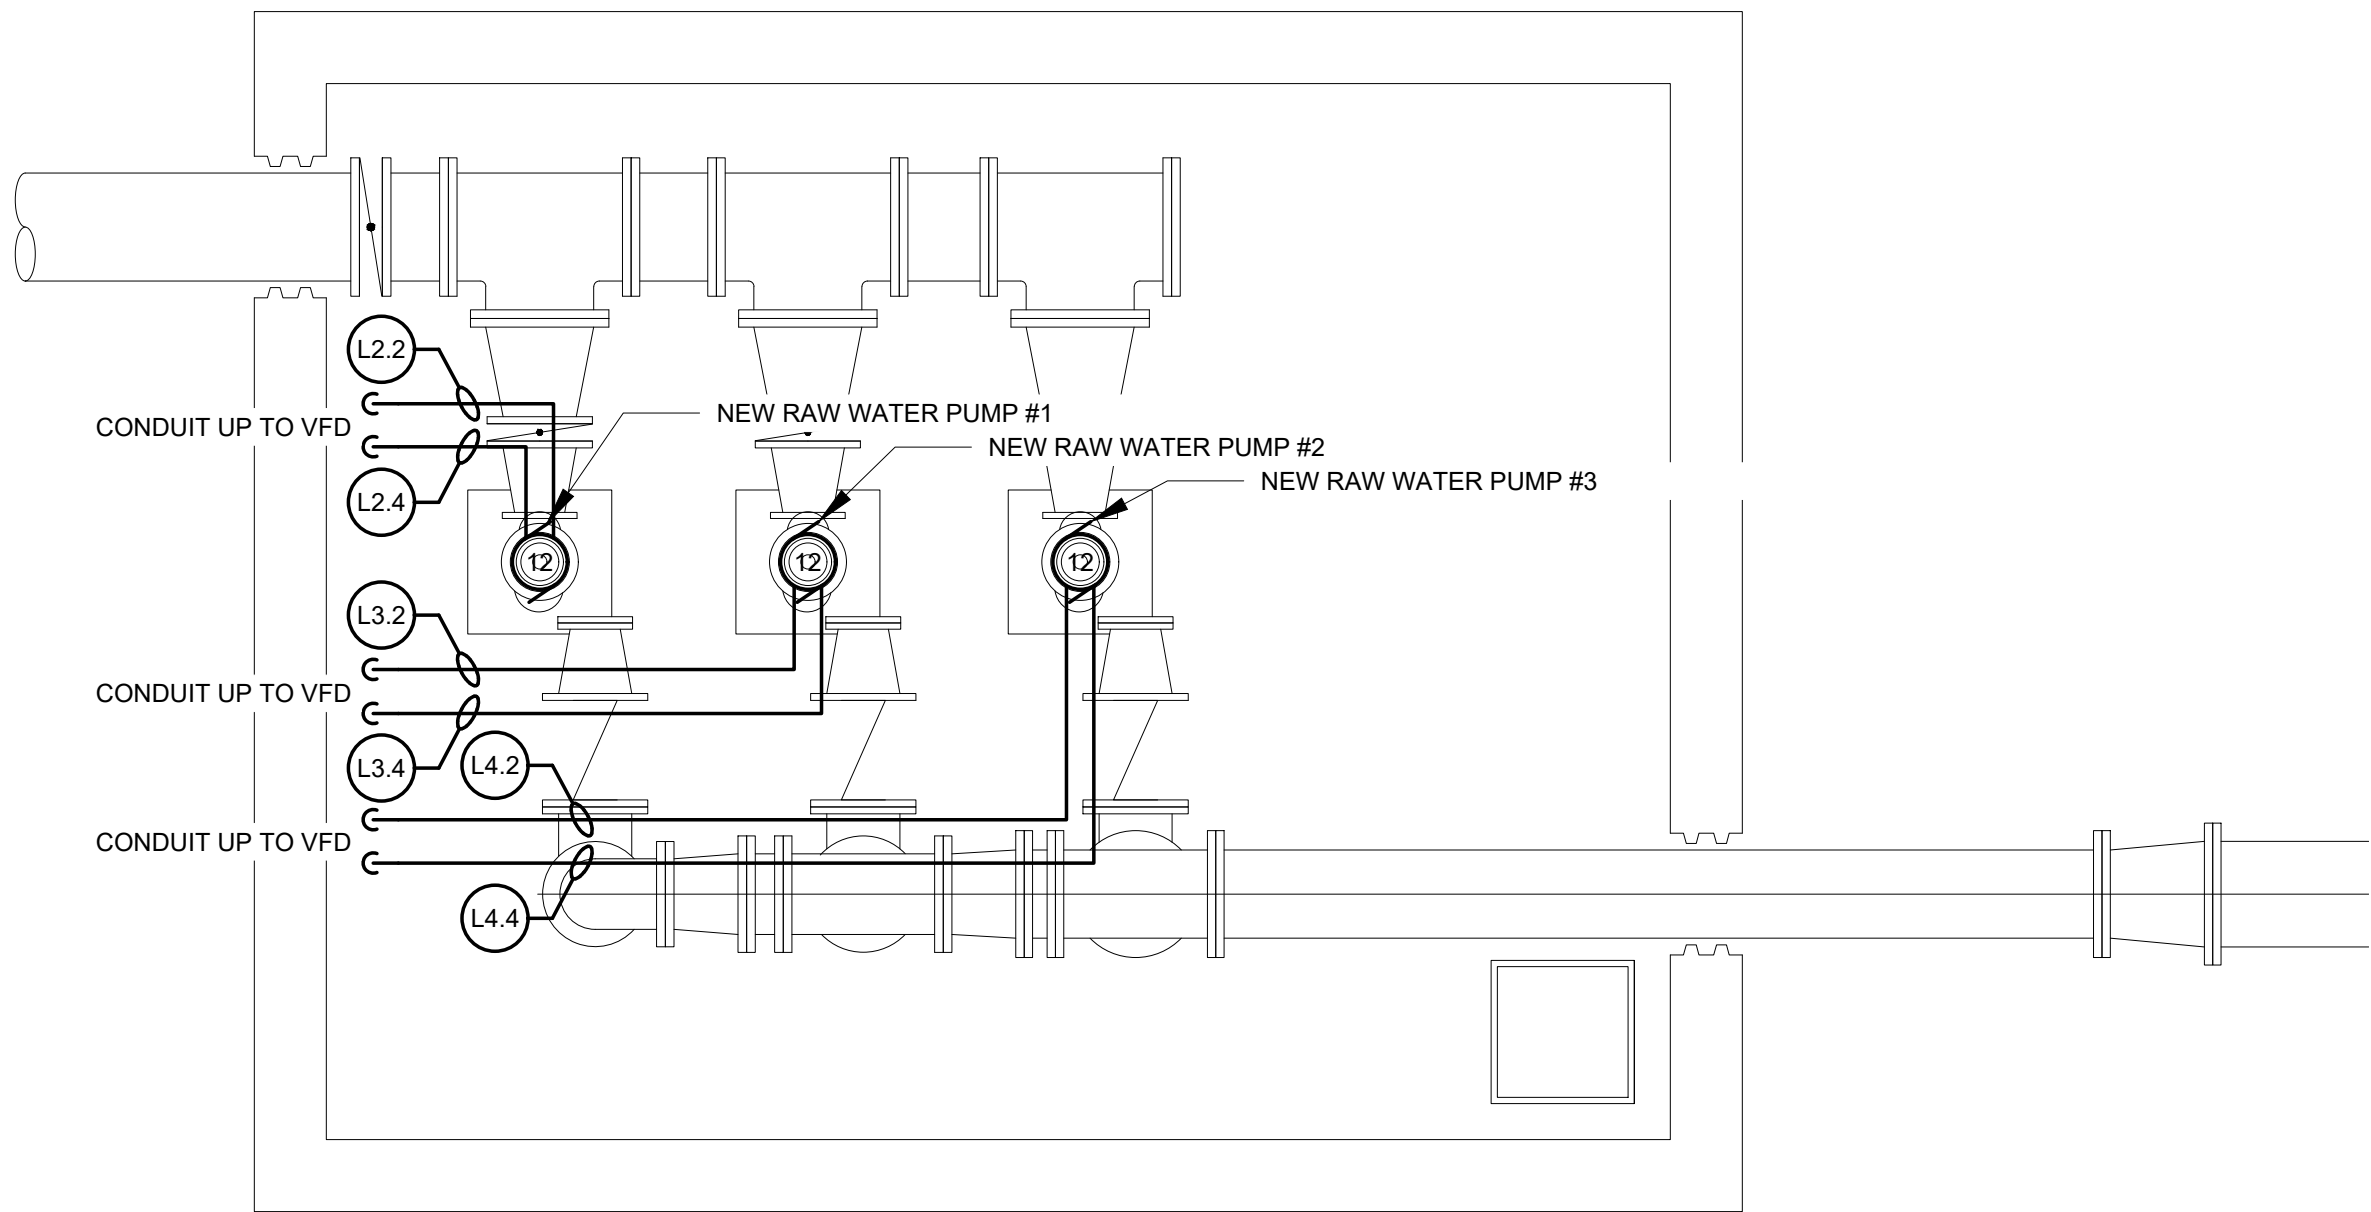

RAW WATER PUMP STATION LOWER
LEVEL ELECTRICAL PLAN
SCALE: 3/8" = 1'

NOTES:

1. NEW RAW WATER PUMP VFD ENCLOSURES SHALL INCLUDE DISCONNECTING MEANS.
2. THE ELECTRICAL CONTRACTOR SHALL DISCONNECT AND RECONNECT REPLACEMENT AIR COMPRESSOR MOTORS.

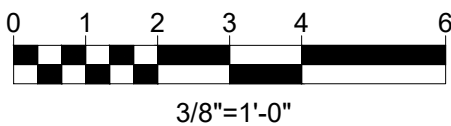


WARNING - IT IS A VIOLATION OF NEW YORK EDUCATION LAW SECTION 7209.2, FOR ANY PERSON, UNLESS HE IS ACTING UNDER THE DIRECTION OF A LICENSED PROFESSIONAL ENGINEER OR LAND SURVEYOR, TO ALTER THIS DOCUMENT IN ANY WAY. IF ALTERED THE ALTERING PERSON SHALL COMPLY WITH THE REQUIREMENTS OF NEW YORK EDUCATION LAW SECTION 7209.2.

DATE:	9/30/2024
DRAWN BY:	EMB
SCALE:	AS SHOWN
REVIEWED BY:	RF
PROJECT NO.:	----
FILE:	

**DELAWARE
ENGINEERING, D.P.C.**

CIVIL AND ENVIRONMENTAL ENGINEERING
28 MADISON AVENUE EXTENSION, ALBANY, NY 12203 - 518.452.1290
55 SOUTH MAIN ST. ONEONTA, NY 13820 - 607.432.8073
31 NORTH MAIN STREET, LIBERTY, NY 12754 - 845.747.8962
1000 STATE STREET, ALBANY, NY 12207 - 518.452.1290
16 EAST MARKET STREET, RED HOOK, NY 12571 - 518.452.1290
548 BROADWAY, MONTICELLO, NY 12701 - 845.791.7777

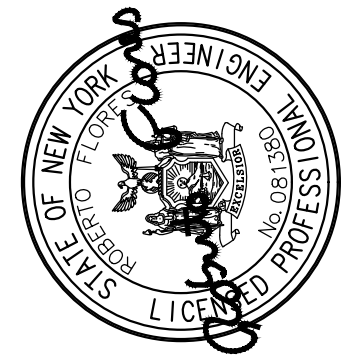

REVISIONS	
NO.	DESCRIPTION

RHINEBECK WTP
PLANT IMPROVEMENTS
VILLAGE OF RHINEBECK
DUTCHESS COUNTY, NEW YORK

RAW WATER PUMP STATION
ELECTRICAL PLAN