
 


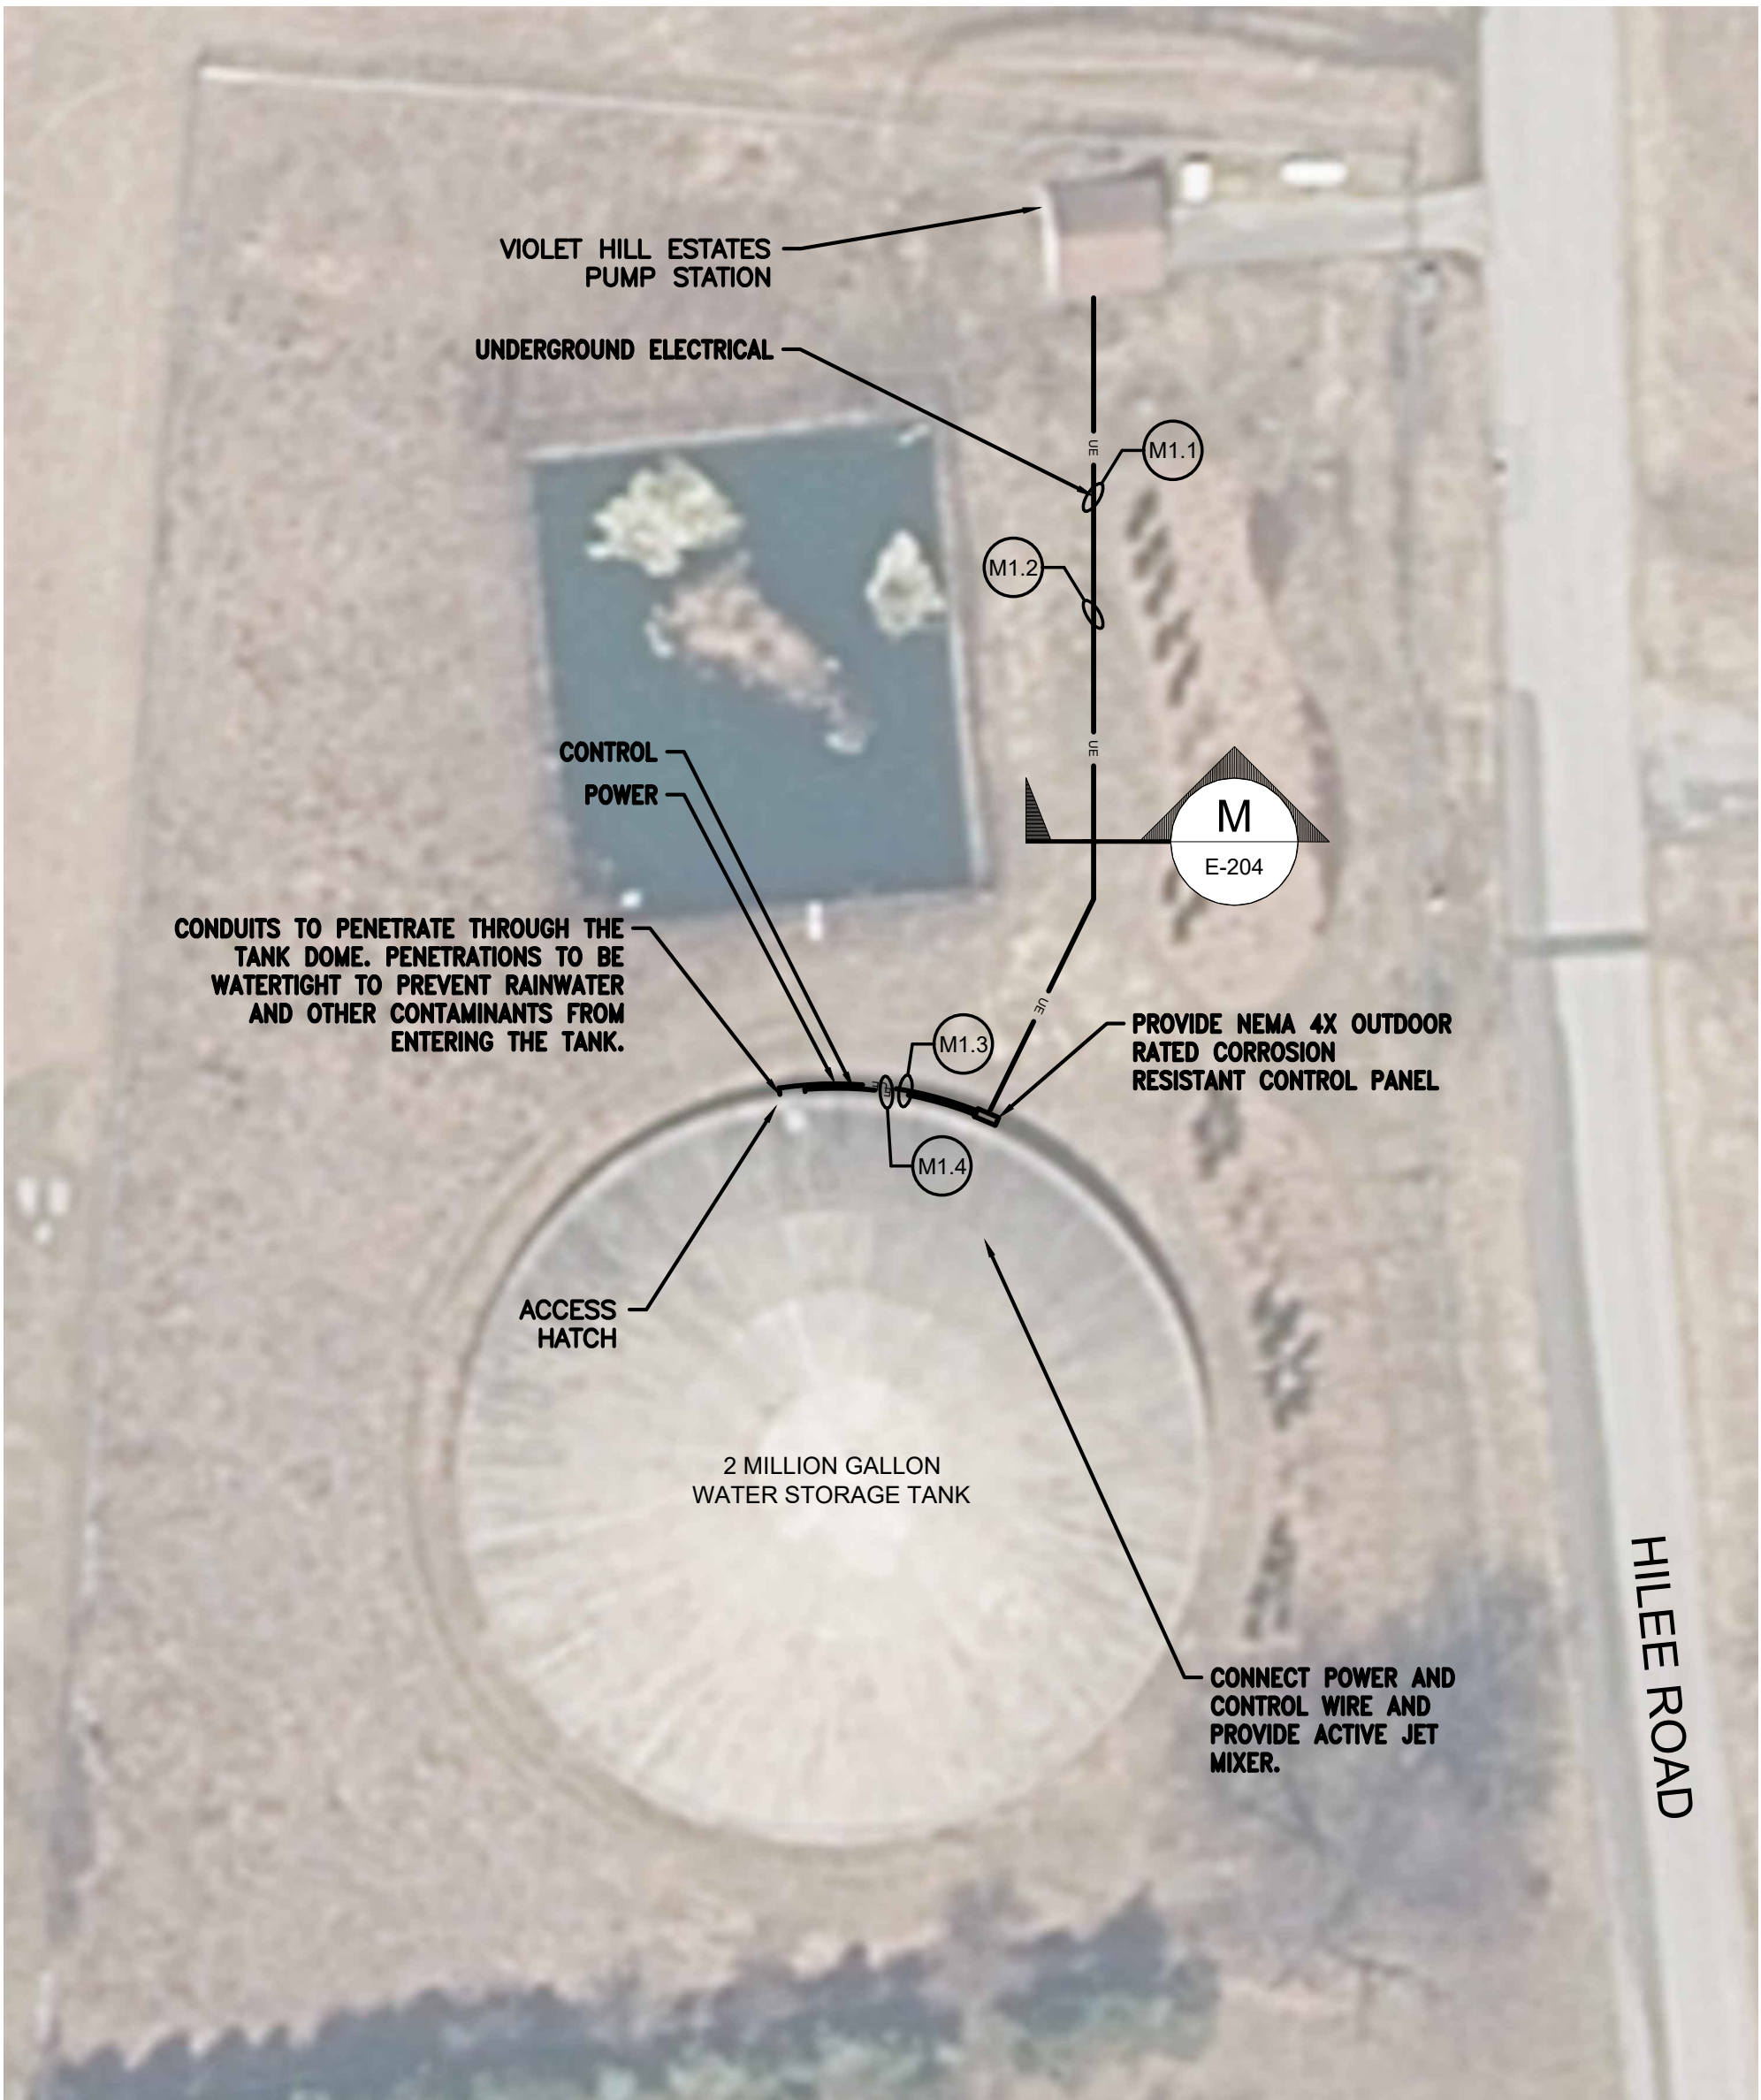

MIXER ELECTRICAL PLAN
SCALE: 1" = 30'




WARNING - IT IS A VIOLATION OF NEW YORK EDUCATION LAW SECTION 7209.2, FOR ANY PERSON, UNLESS HE IS ACTING UNDER THE DIRECTION OF A LICENSED PROFESSIONAL ENGINEER OR LAND SURVEYOR, TO ALTER THIS DOCUMENT IN ANY WAY. IF ALTERED THE ALTERING PERSON SHALL COMPLY WITH THE REQUIREMENTS OF NEW YORK EDUCATION LAW SECTION 7209.2.

DATE:	9/30/2024
DRAWN BY:	EMB
SCALE:	AS SHOWN
REVIEWED BY:	RF
PROJECT NO.:	----
FILE:	

**DELAWARE
ENGINEERING, D.P.C.**

CIVIL AND ENVIRONMENTAL ENGINEERING
28 MADISON AVENUE EXTENSION, ALBANY, NY 12203 - 518.452.1290
55 SOUTH MAIN ST. ONEONTA, NY 13820 - 607.432.8073
311 NORTH MAIN STREET, LIBERTY, NY 12544 - 845.747.8962
1100 WEST 10TH STREET, ALBANY, NY 12206 - 518.452.1290
16 EAST MARKET STREET, RED HOOK, NY 12571 - 518.452.1290
548 BROADWAY, MONTICELLO, NY 12521 - 845.791.7777

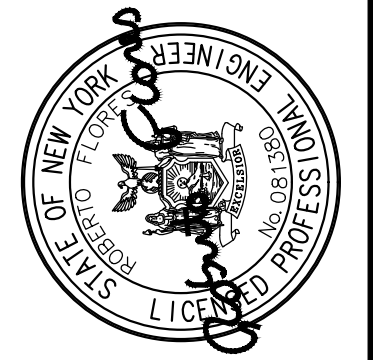

REVISIONS		DESCRIPTION
NO.	DATE	

RHINEBECK WTP
PLANT IMPROVEMENTS
VILLAGE OF RHINEBECK
DUTCHESS COUNTY, NEW YORK

WATER TANK
ELECTRICAL SITE PLAN