


File: H:\DRAWINGS\RHINEBECK (V)\22-2496 WTP\RHINEBECK\_WTP\_P&ID.DWG    Saved: 2/27/2024 3:12:20 PM    Plotted: 10/2/2024 10:21:14 AM    User: Irl Brodie LastSavedBy: brodyg

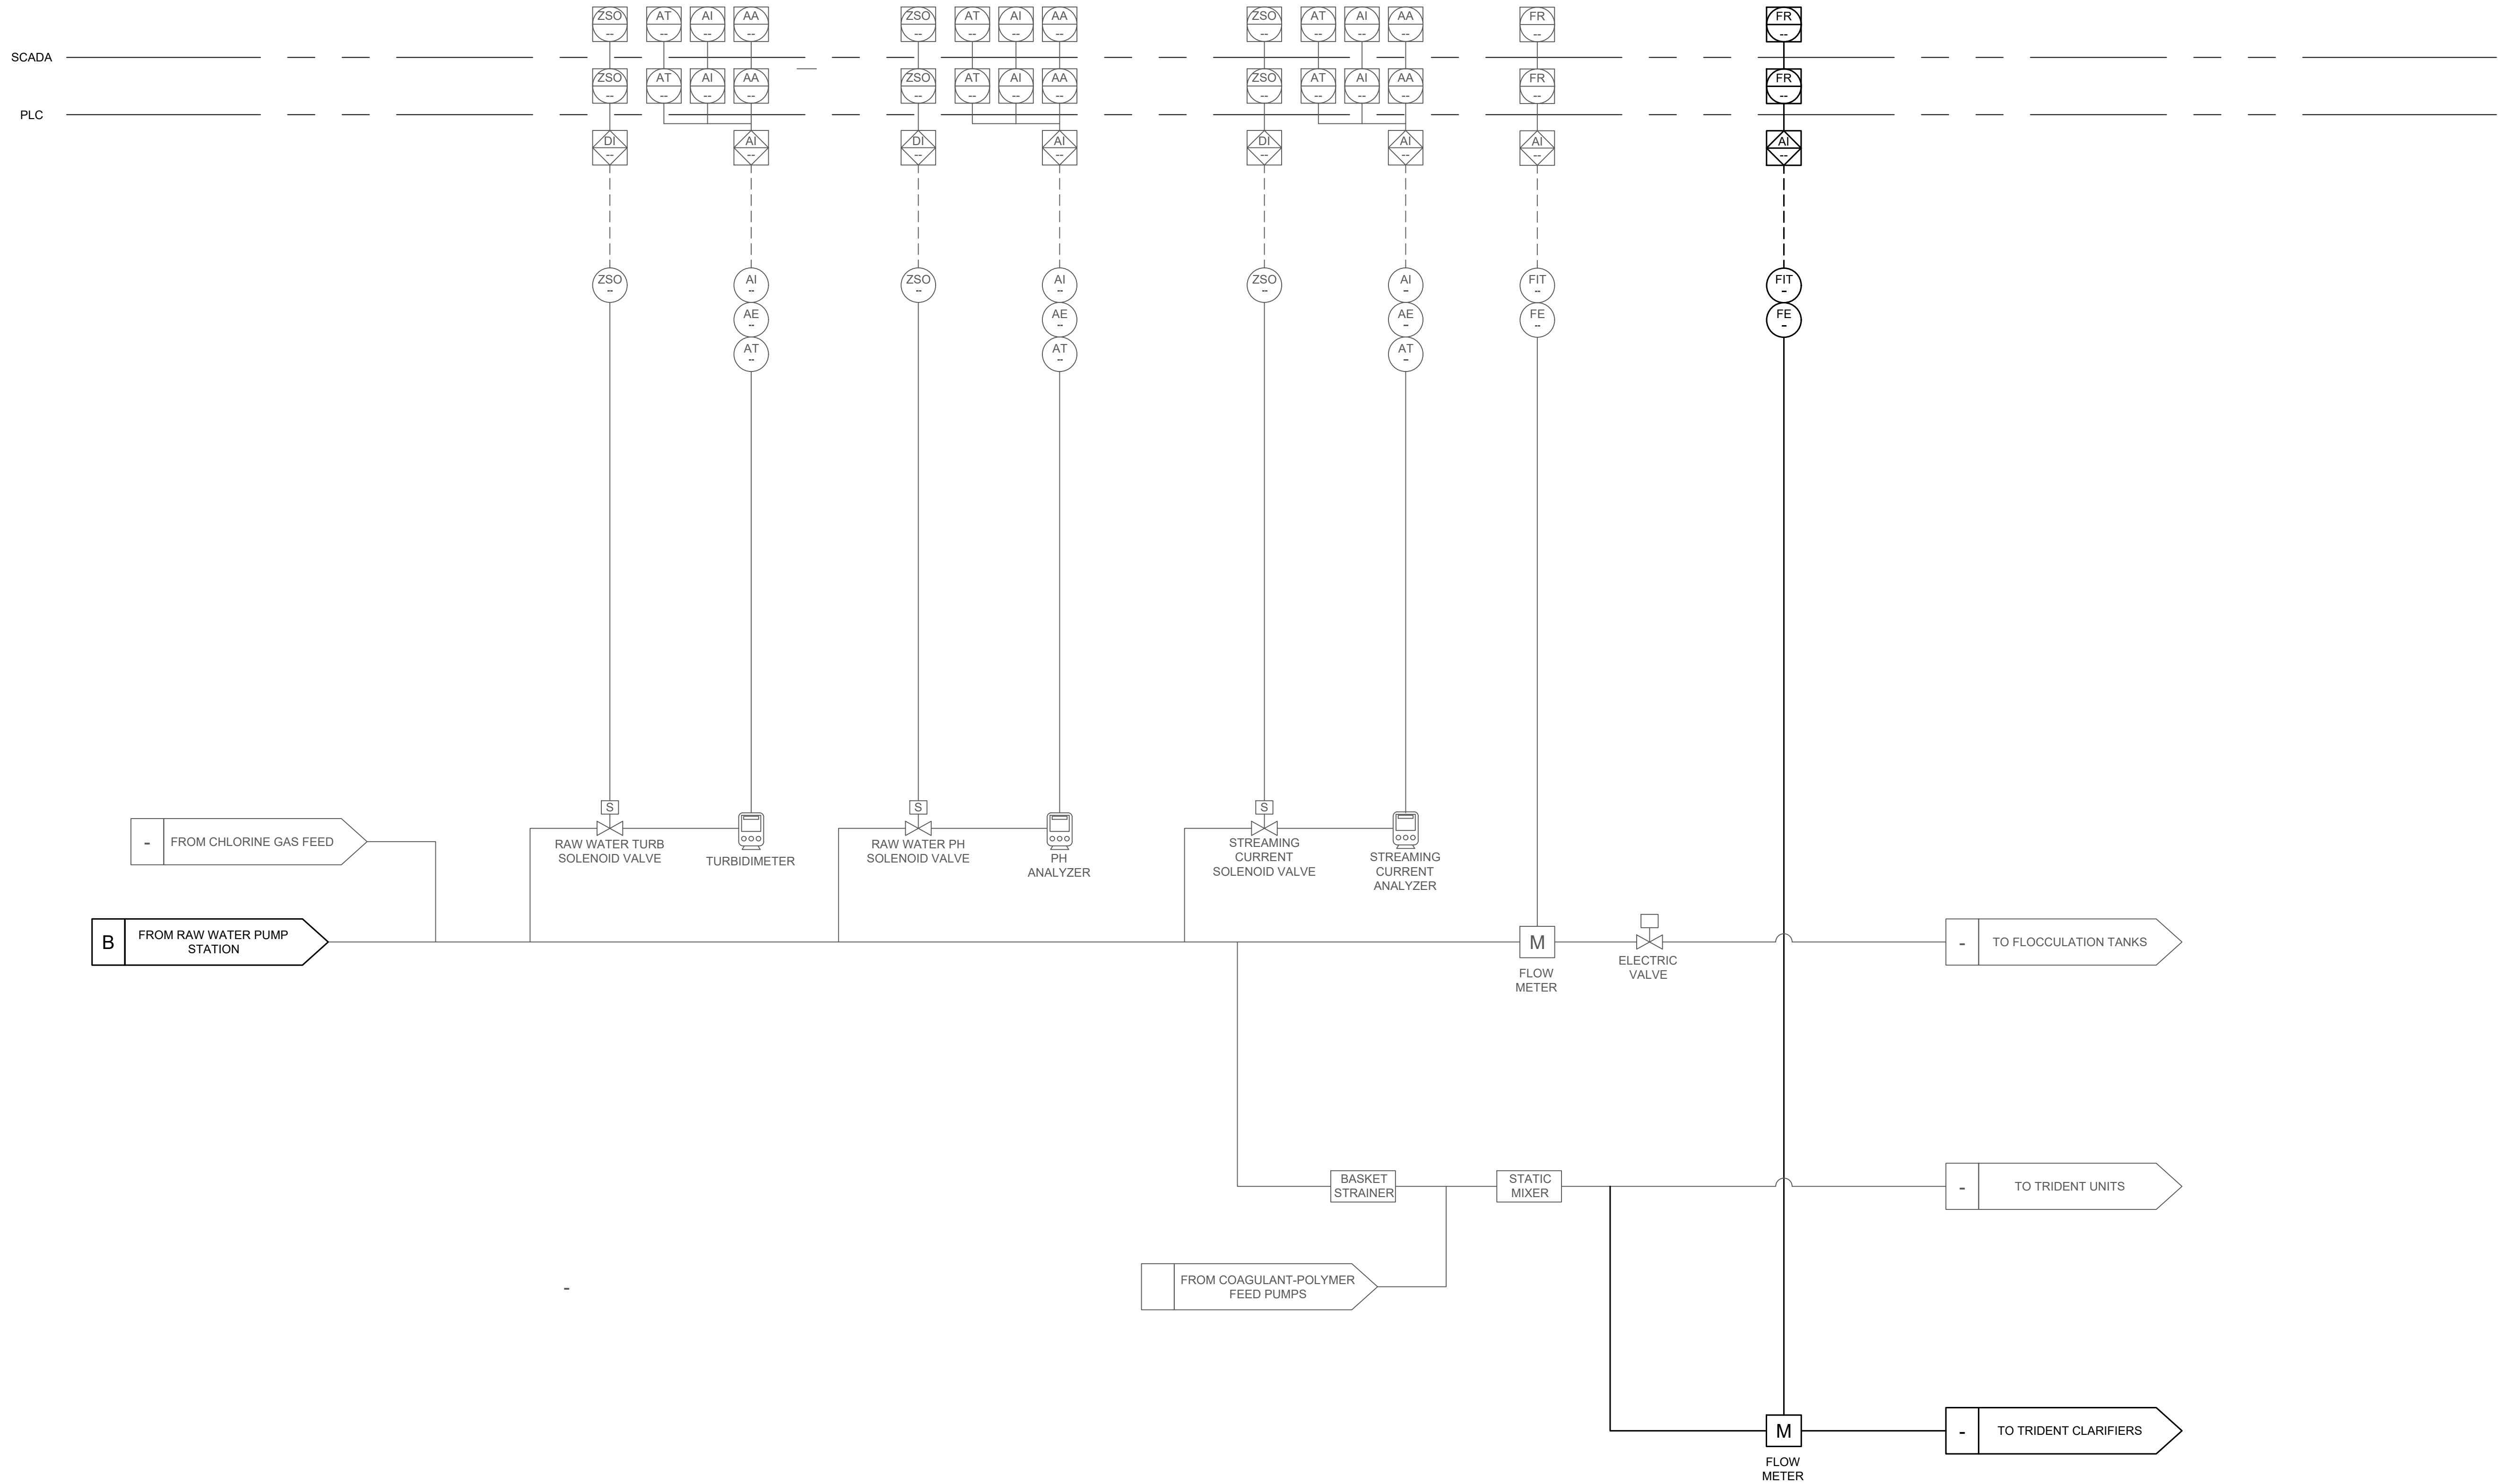


SHEET:

I-003

WATER TREATMENT  
PLANT INFLUENT  
INSTRUMENTATION

RHINEBECK WTP  
PLANT IMPROVEMENTS  
VILLAGE OF RHINEBECK  
DUTCHESS COUNTY, NEW YORK

| REVISIONS |      |
|-----------|------|
| NO.       | DATE |
|           |      |
|           |      |
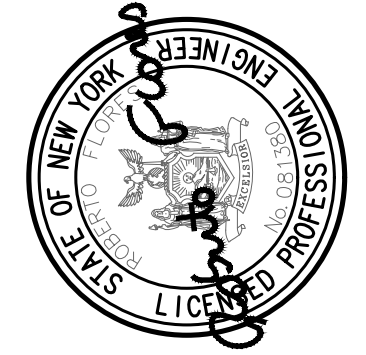



**DELAWARE  
ENGINEERING, D.P.C.**  
CIVIL AND ENVIRONMENTAL ENGINEERING

28 MADISON AVENUE EXTENSION, ALBANY, NY 12203 - 518.452.1290  
55 SOUTH MAIN ST. ONEONTA, NY 13820 - 607.432.8073  
31 NORTH MAIN STREET, LIBERTY, NY 12754 - 845.747.9862  
111 NORTH MAIN STREET, ALBANY, NY 12207 - 518.452.1290  
16 EAST MARKET STREET, RED HOOK, NY 12571 - 518.452.1290  
548 BROADWAY, MONTICELLO, NY 12521 - 845.791.7777

|              |           |
|--------------|-----------|
| DATE:        | 2/27/2024 |
| DRAWN BY:    | EMB       |
| SCALE:       | NTS       |
| REVIEWED BY: | RF        |
| PROJECT NO.: | ----      |
| FILE:        | ----      |

WARNING - IT IS A VIOLATION OF NEW YORK EDUCATION LAW SECTION 7209.2, FOR ANY PERSON, UNLESS HE IS ACTING UNDER THE DIRECTION OF A LICENSED PROFESSIONAL ENGINEER OR LAND SURVEYOR, TO ALTER THIS DOCUMENT IN ANY WAY. IF ALTERED THE ALTERING PERSON SHALL COMPLY WITH THE REQUIREMENTS OF NEW YORK EDUCATION LAW, SECTION 7209.2.